

WISCONSIN BRIDGE & IRON CO.
NORTH MILWAUKEE, WISCONSIN

CONTRACT NO. 9377 - ERECTED BY W. B. T. Co.
FOR City of Detroit -
LOCATION - Belle Isle Bridge -
DESCRIPTION - (Piers 5 & 7 B) -
DETAILS OF Towers - (Piers 5 & 7 B) -
SPECIFICATION BY Eschbacher, Murphy & Co.
SHOP PAINT - None - (See Specifications for Towers)


EXCEPT AS NOTED
MADE BY A. F. S. - OPEN HOLES
DATE 6-28-21
TRACED BY M. H. P. - DATE 6-28-21
CHECKED BY H. H. W. - DATE July 1, 21

SHEET NO. 1
SECTION

Summary of Parts			
No. Description	Marks Bill		
32 Towers	ITI		
8 Struts	ISI		
8 "	ISI		

8-STRUTS-151-2

8-STRUTS-152-2

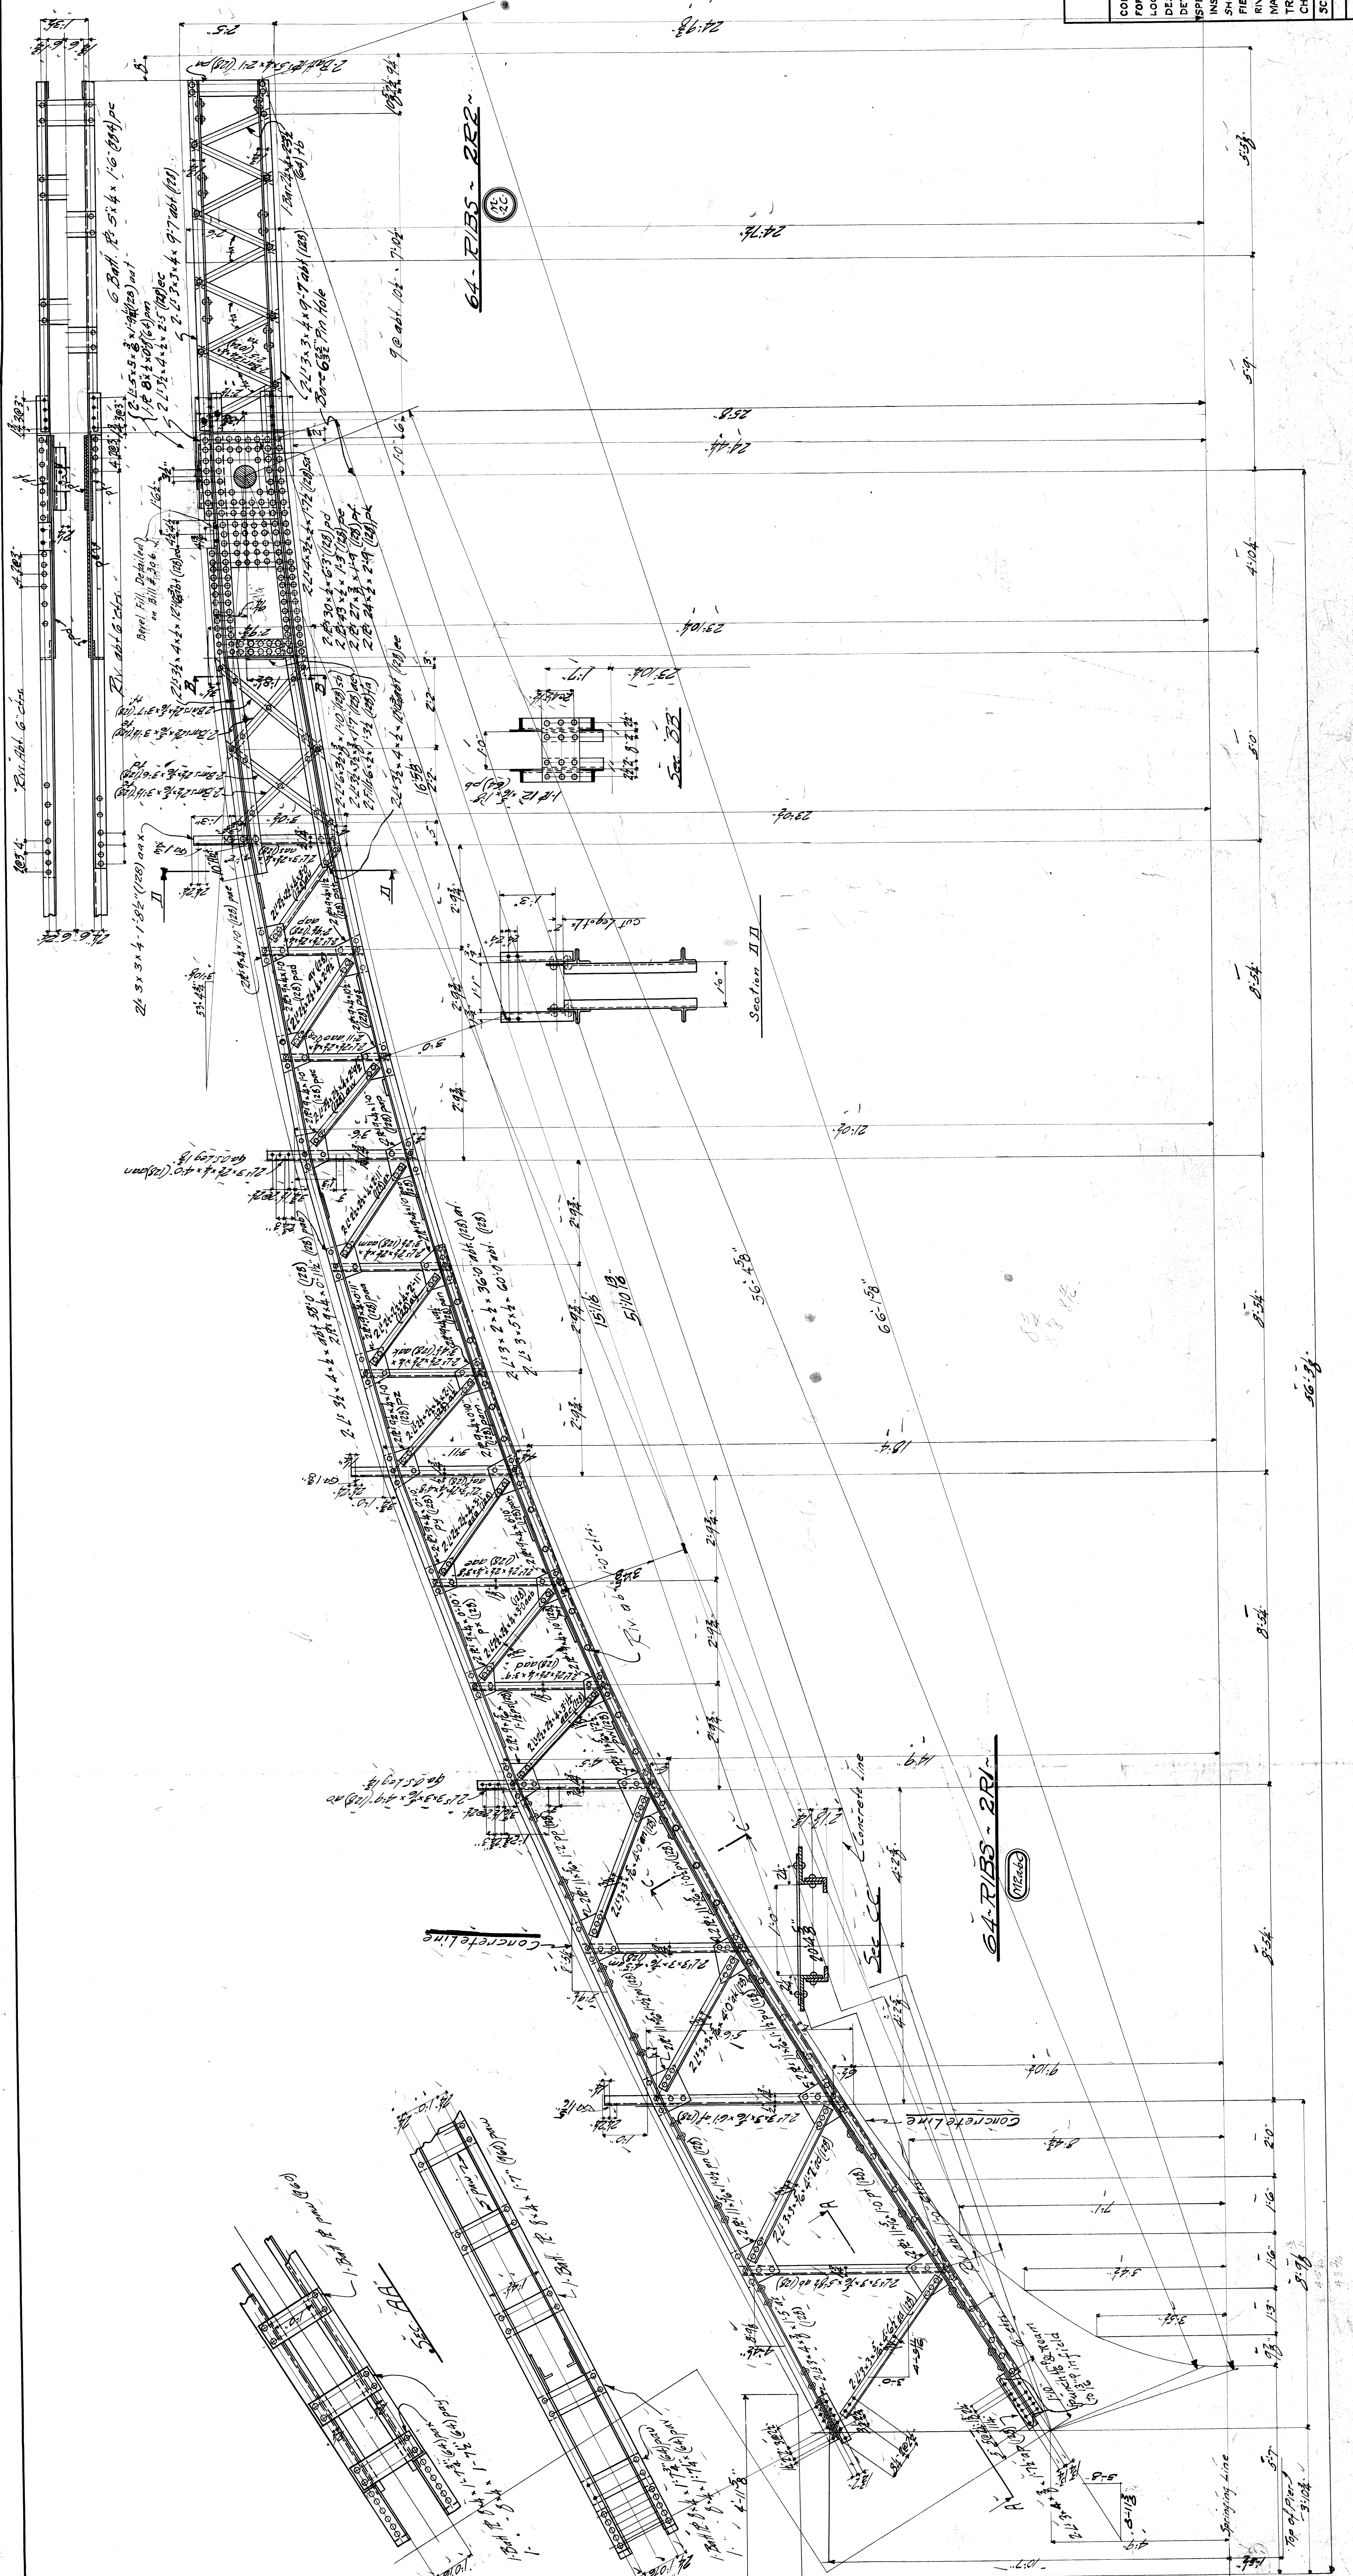



WISCONSIN BRIDGE & IRON CO.
 NORTH MILWAUKEE, WISCONSIN

CONTRACT NO. 9377 - ERECTED BY M.B.I.C.
 FOR City of Detroit Mich.
 LOCATION Detroit Mich.
 DESCRIPTION Belle Isle Bridge
 DETAILS OF Ribs
 INSPECTION BY [Signature] READING NAME

SHOP PRINT Made (see specifications)
 FIELD PAINT EXCEPT AS NOTED
 RIVETS OPEN HOLES
 MADE BY C.A.A. DATE 6-21-11
 TRACED BY Frank DATE 7-2-11
 CHECKED BY [Signature] DATE 7-2-11

SCALE 1/4" = 1'-0" SHEET NO. 22
 CONT. 9377

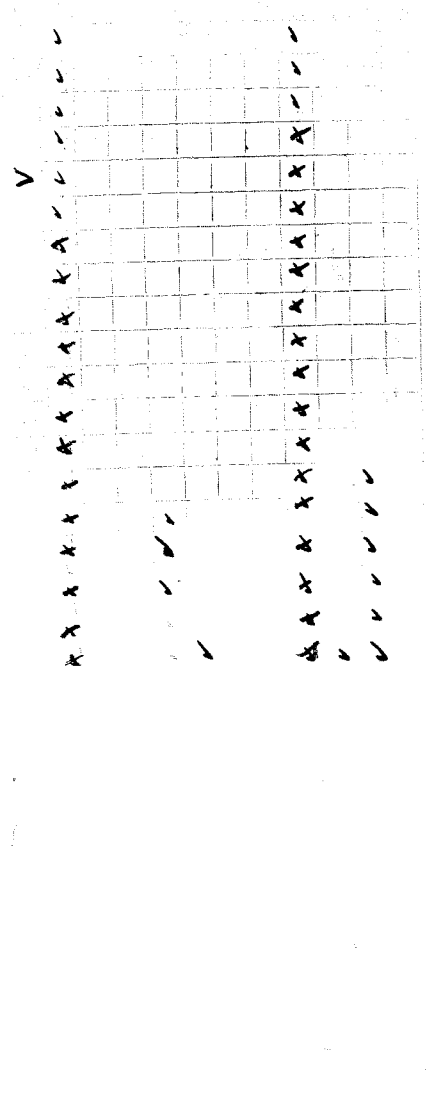

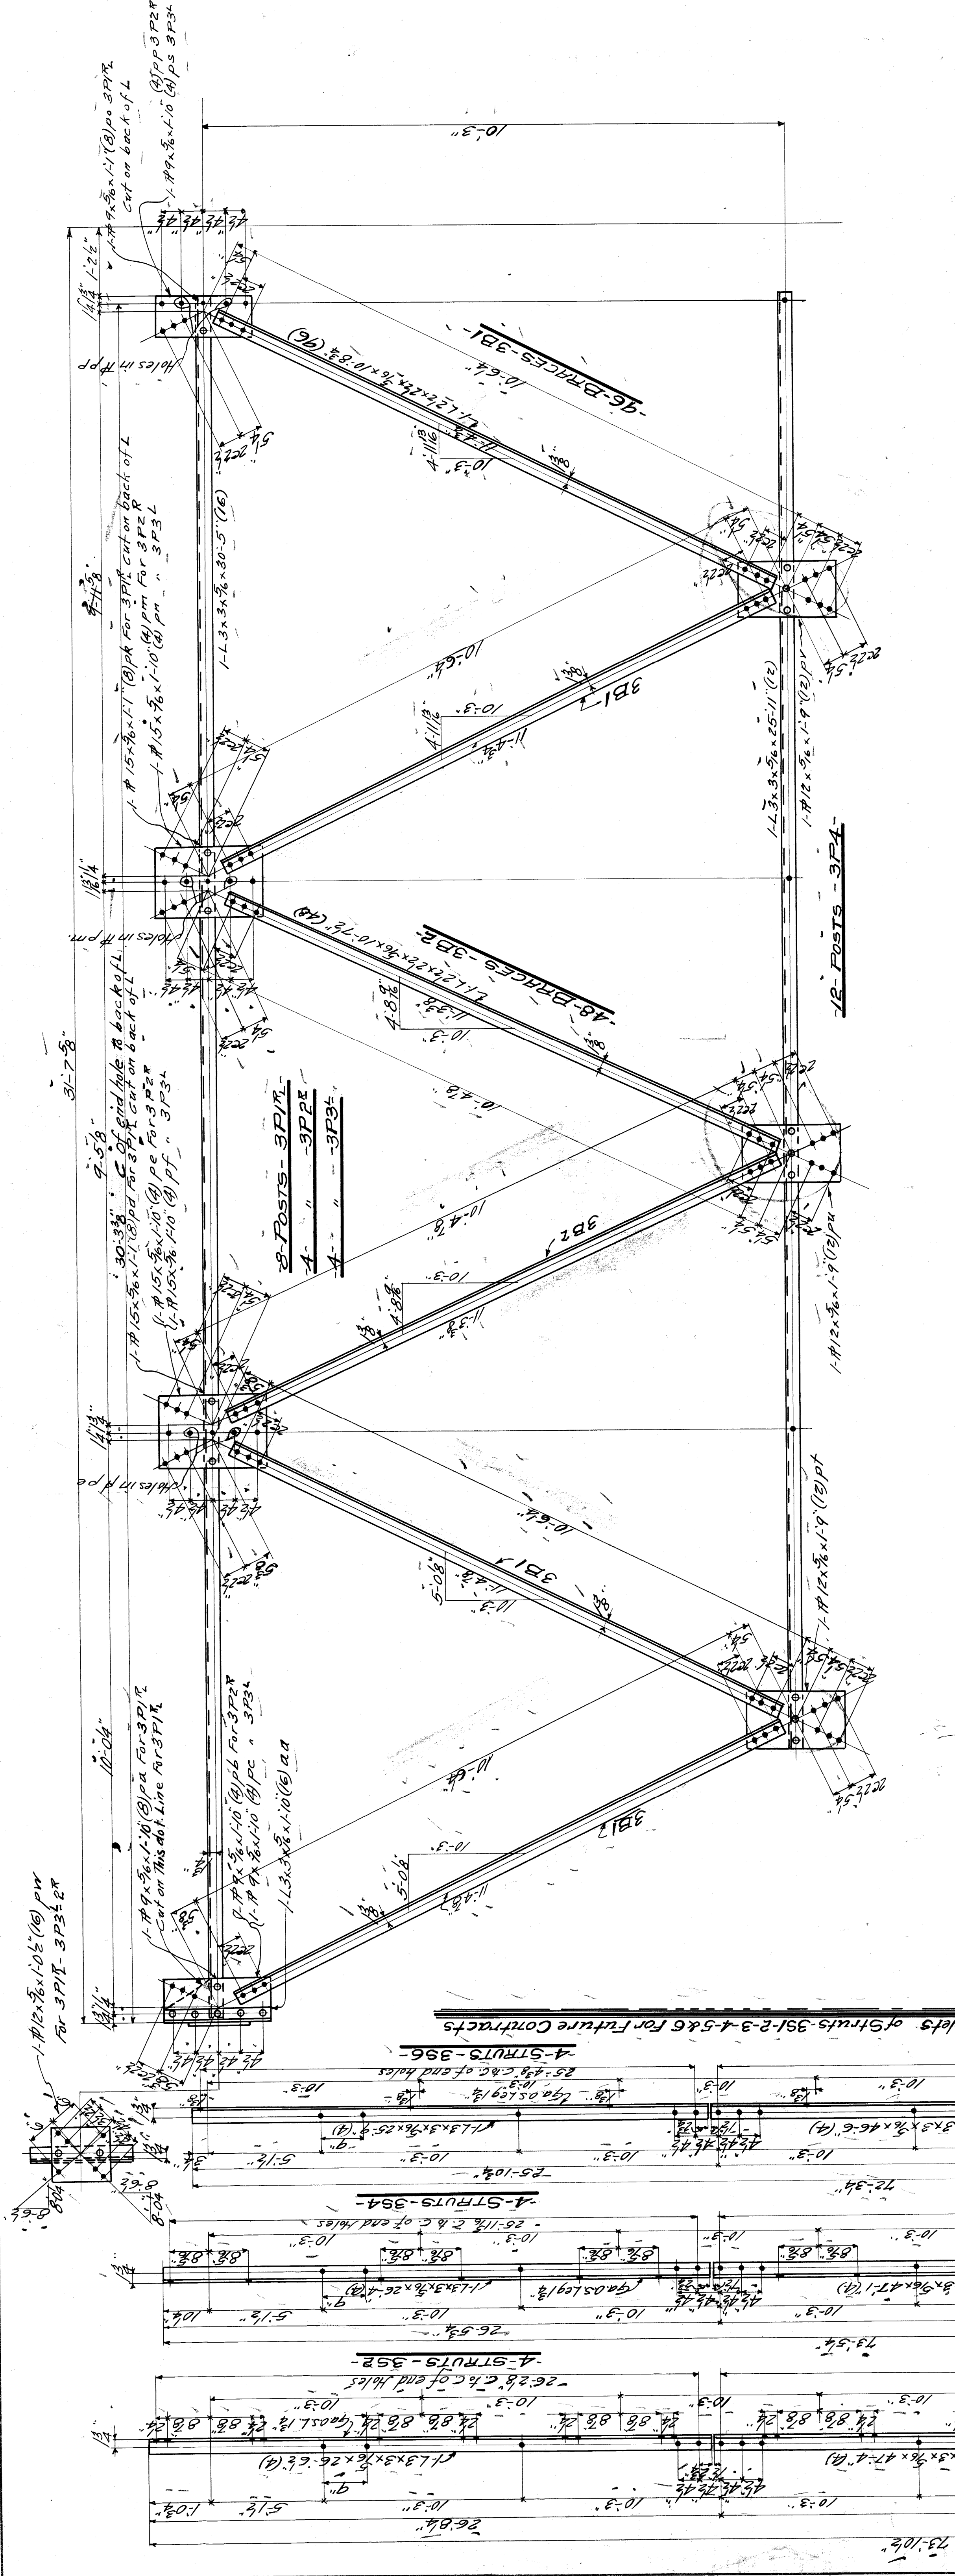

Summary of Parts

No	Description	Marks	Bill
1	STRUTS	99	36
2	"	99	36
3	"	99	36
4	"	99	36
5	"	99	36
6	"	99	36
7	"	99	36
8	"	99	36
9	"	99	36
10	"	99	36
11	"	99	36
12	"	99	36
13	"	99	36
14	"	99	36
15	"	99	36
16	"	99	36
17	"	99	36
18	"	99	36
19	"	99	36
20	"	99	36
21	"	99	36
22	"	99	36
23	"	99	36
24	"	99	36
25	"	99	36
26	"	99	36
27	"	99	36
28	"	99	36
29	"	99	36
30	"	99	36
31	"	99	36
32	"	99	36
33	"	99	36
34	"	99	36
35	"	99	36
36	"	99	36
37	"	99	36
38	"	99	36
39	"	99	36
40	"	99	36
41	"	99	36
42	"	99	36
43	"	99	36
44	"	99	36
45	"	99	36
46	"	99	36
47	"	99	36
48	"	99	36
49	"	99	36
50	"	99	36

WISCONSIN BRIDGE & IRON CO.
NORTH MILWAUKEE, WISCONSIN

CONTRACT NO. 9377
ERECTED BY
FOR *City of Detroit*
LOCATION *Detroit, Mich.*
DESCRIPTION *Belle Isle Bridge*

DETAILS OF
SPECIFICATIONS *Essels by Mayhew & Co*



INSPECTION BY
SHOP PAINT *Name* (See Specification)


FIELD PAINT " " OPEN HOLES 1/8"

MADE BY *K.A. Bates* EXCEPT AS NOTED
TRACED BY *E.R.M.* DATE *6-23-21*
CHECKED BY *M.H.C.* DATE *6-23-21*

SCALE *3/4" = 1'-0"*

SHEET NO. **3**

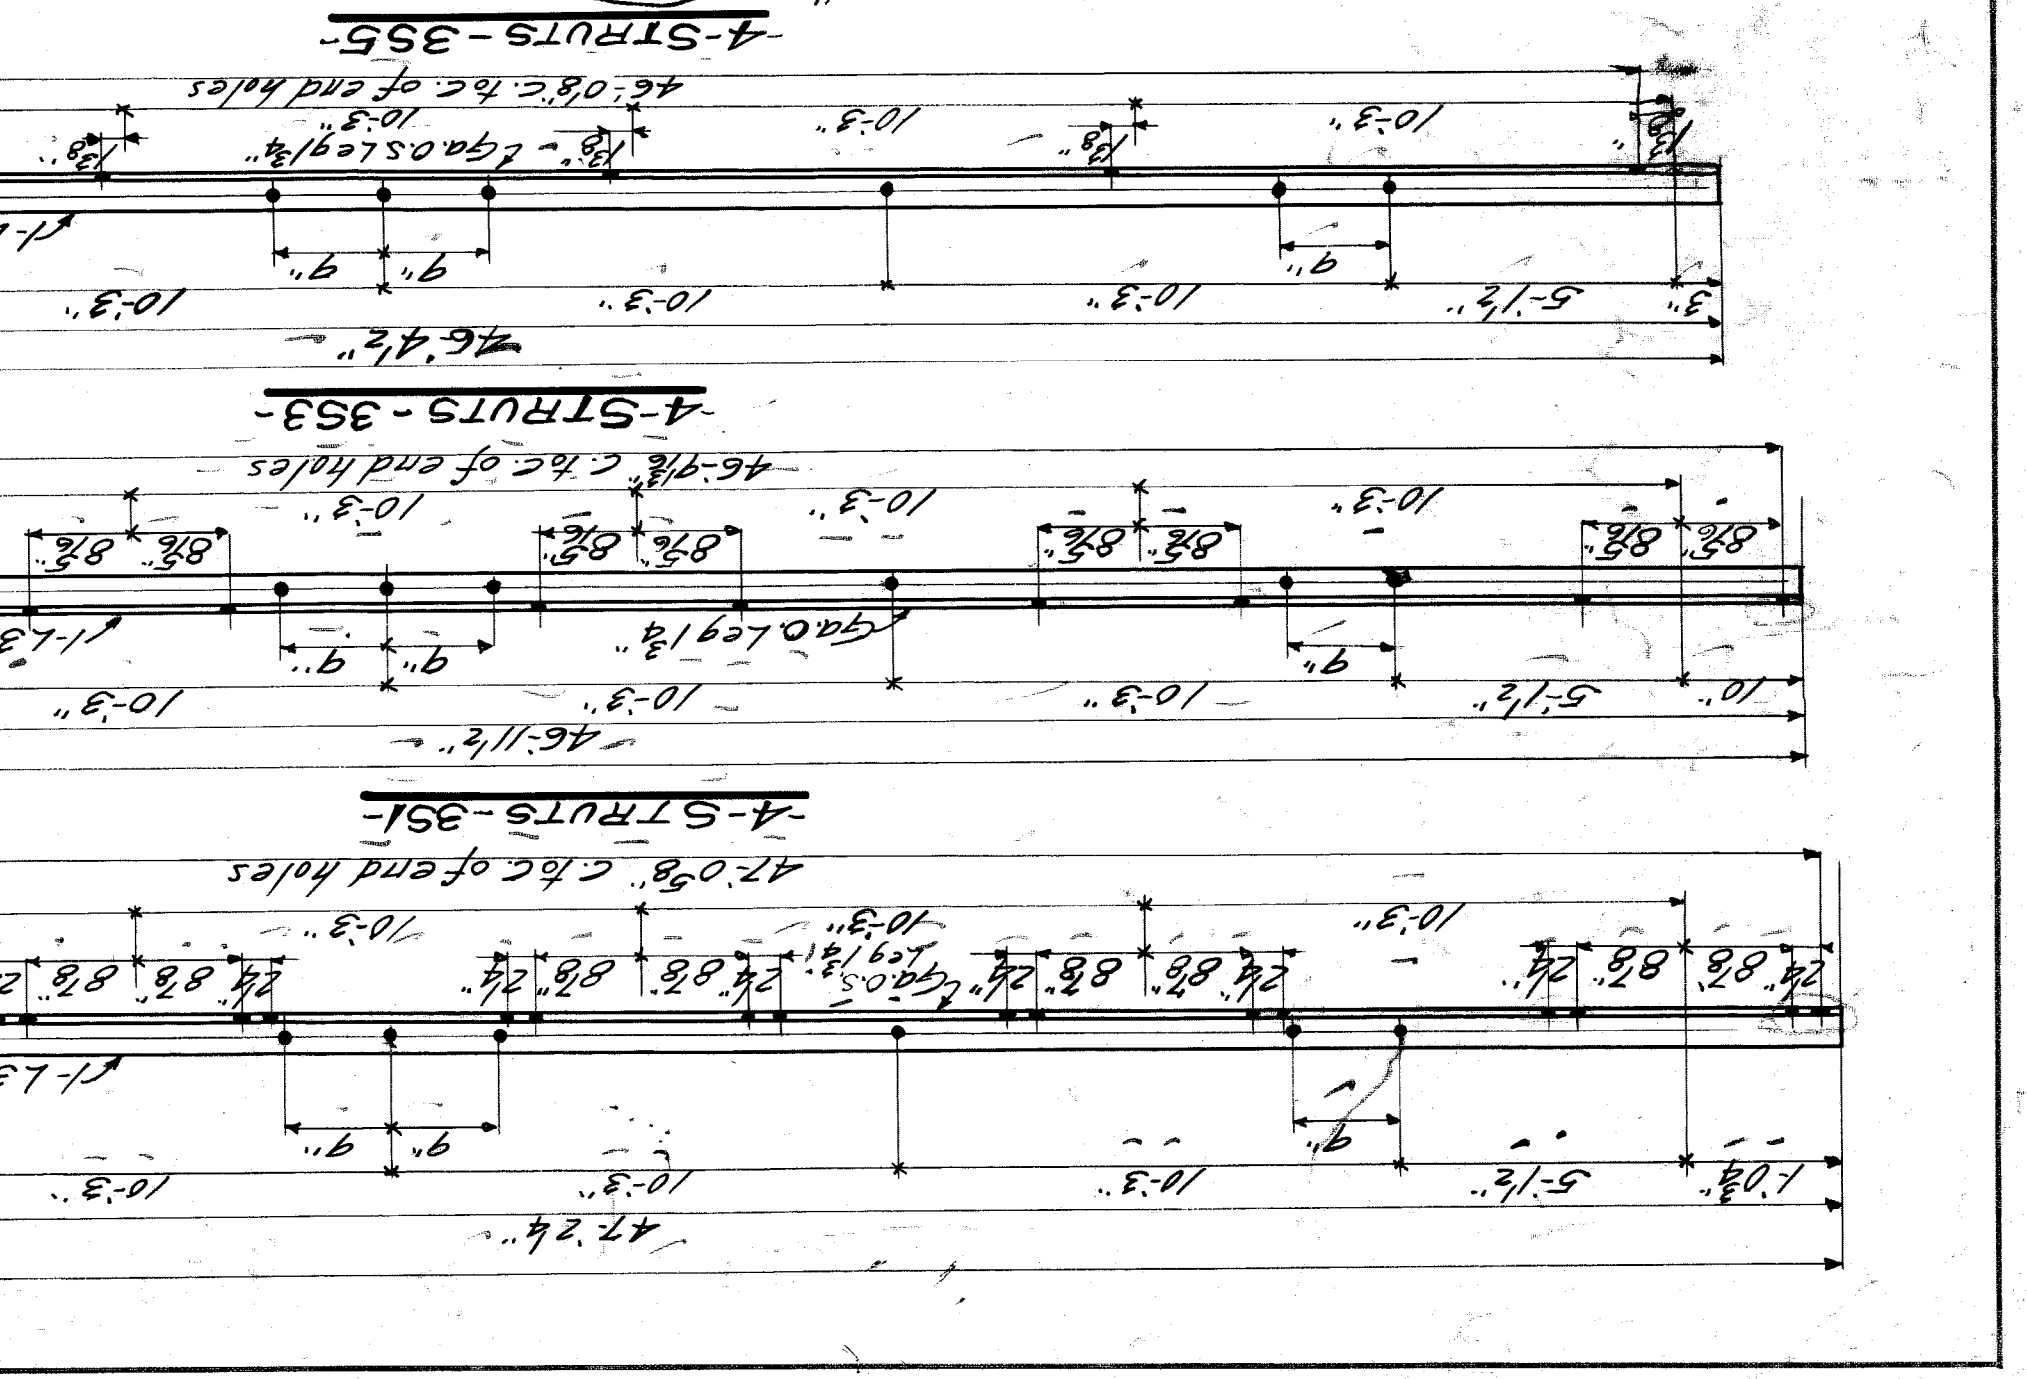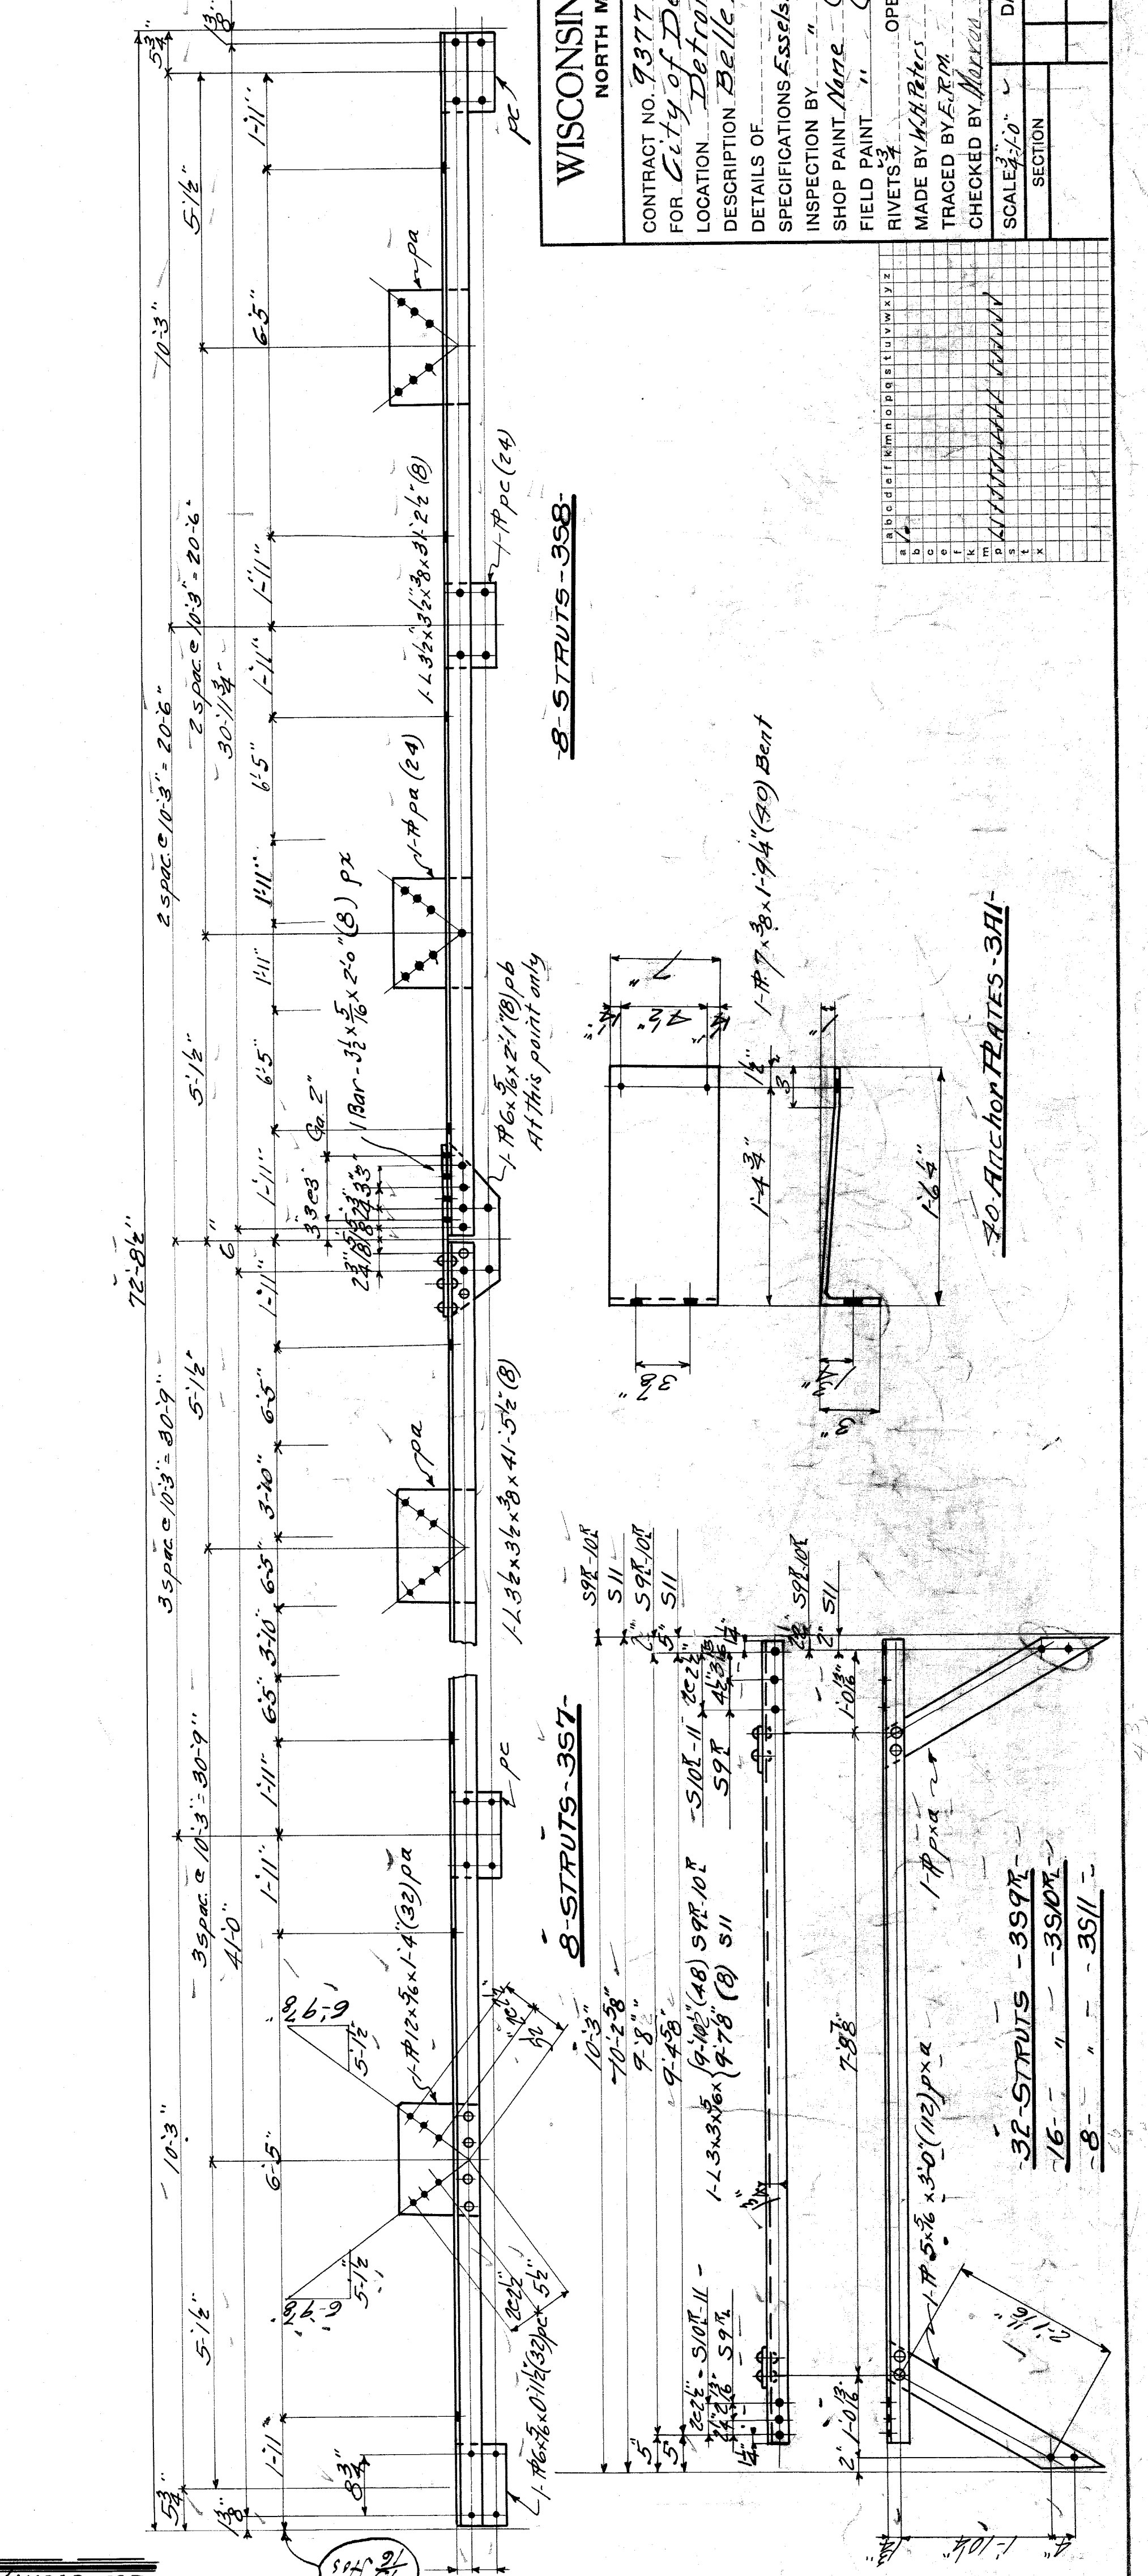

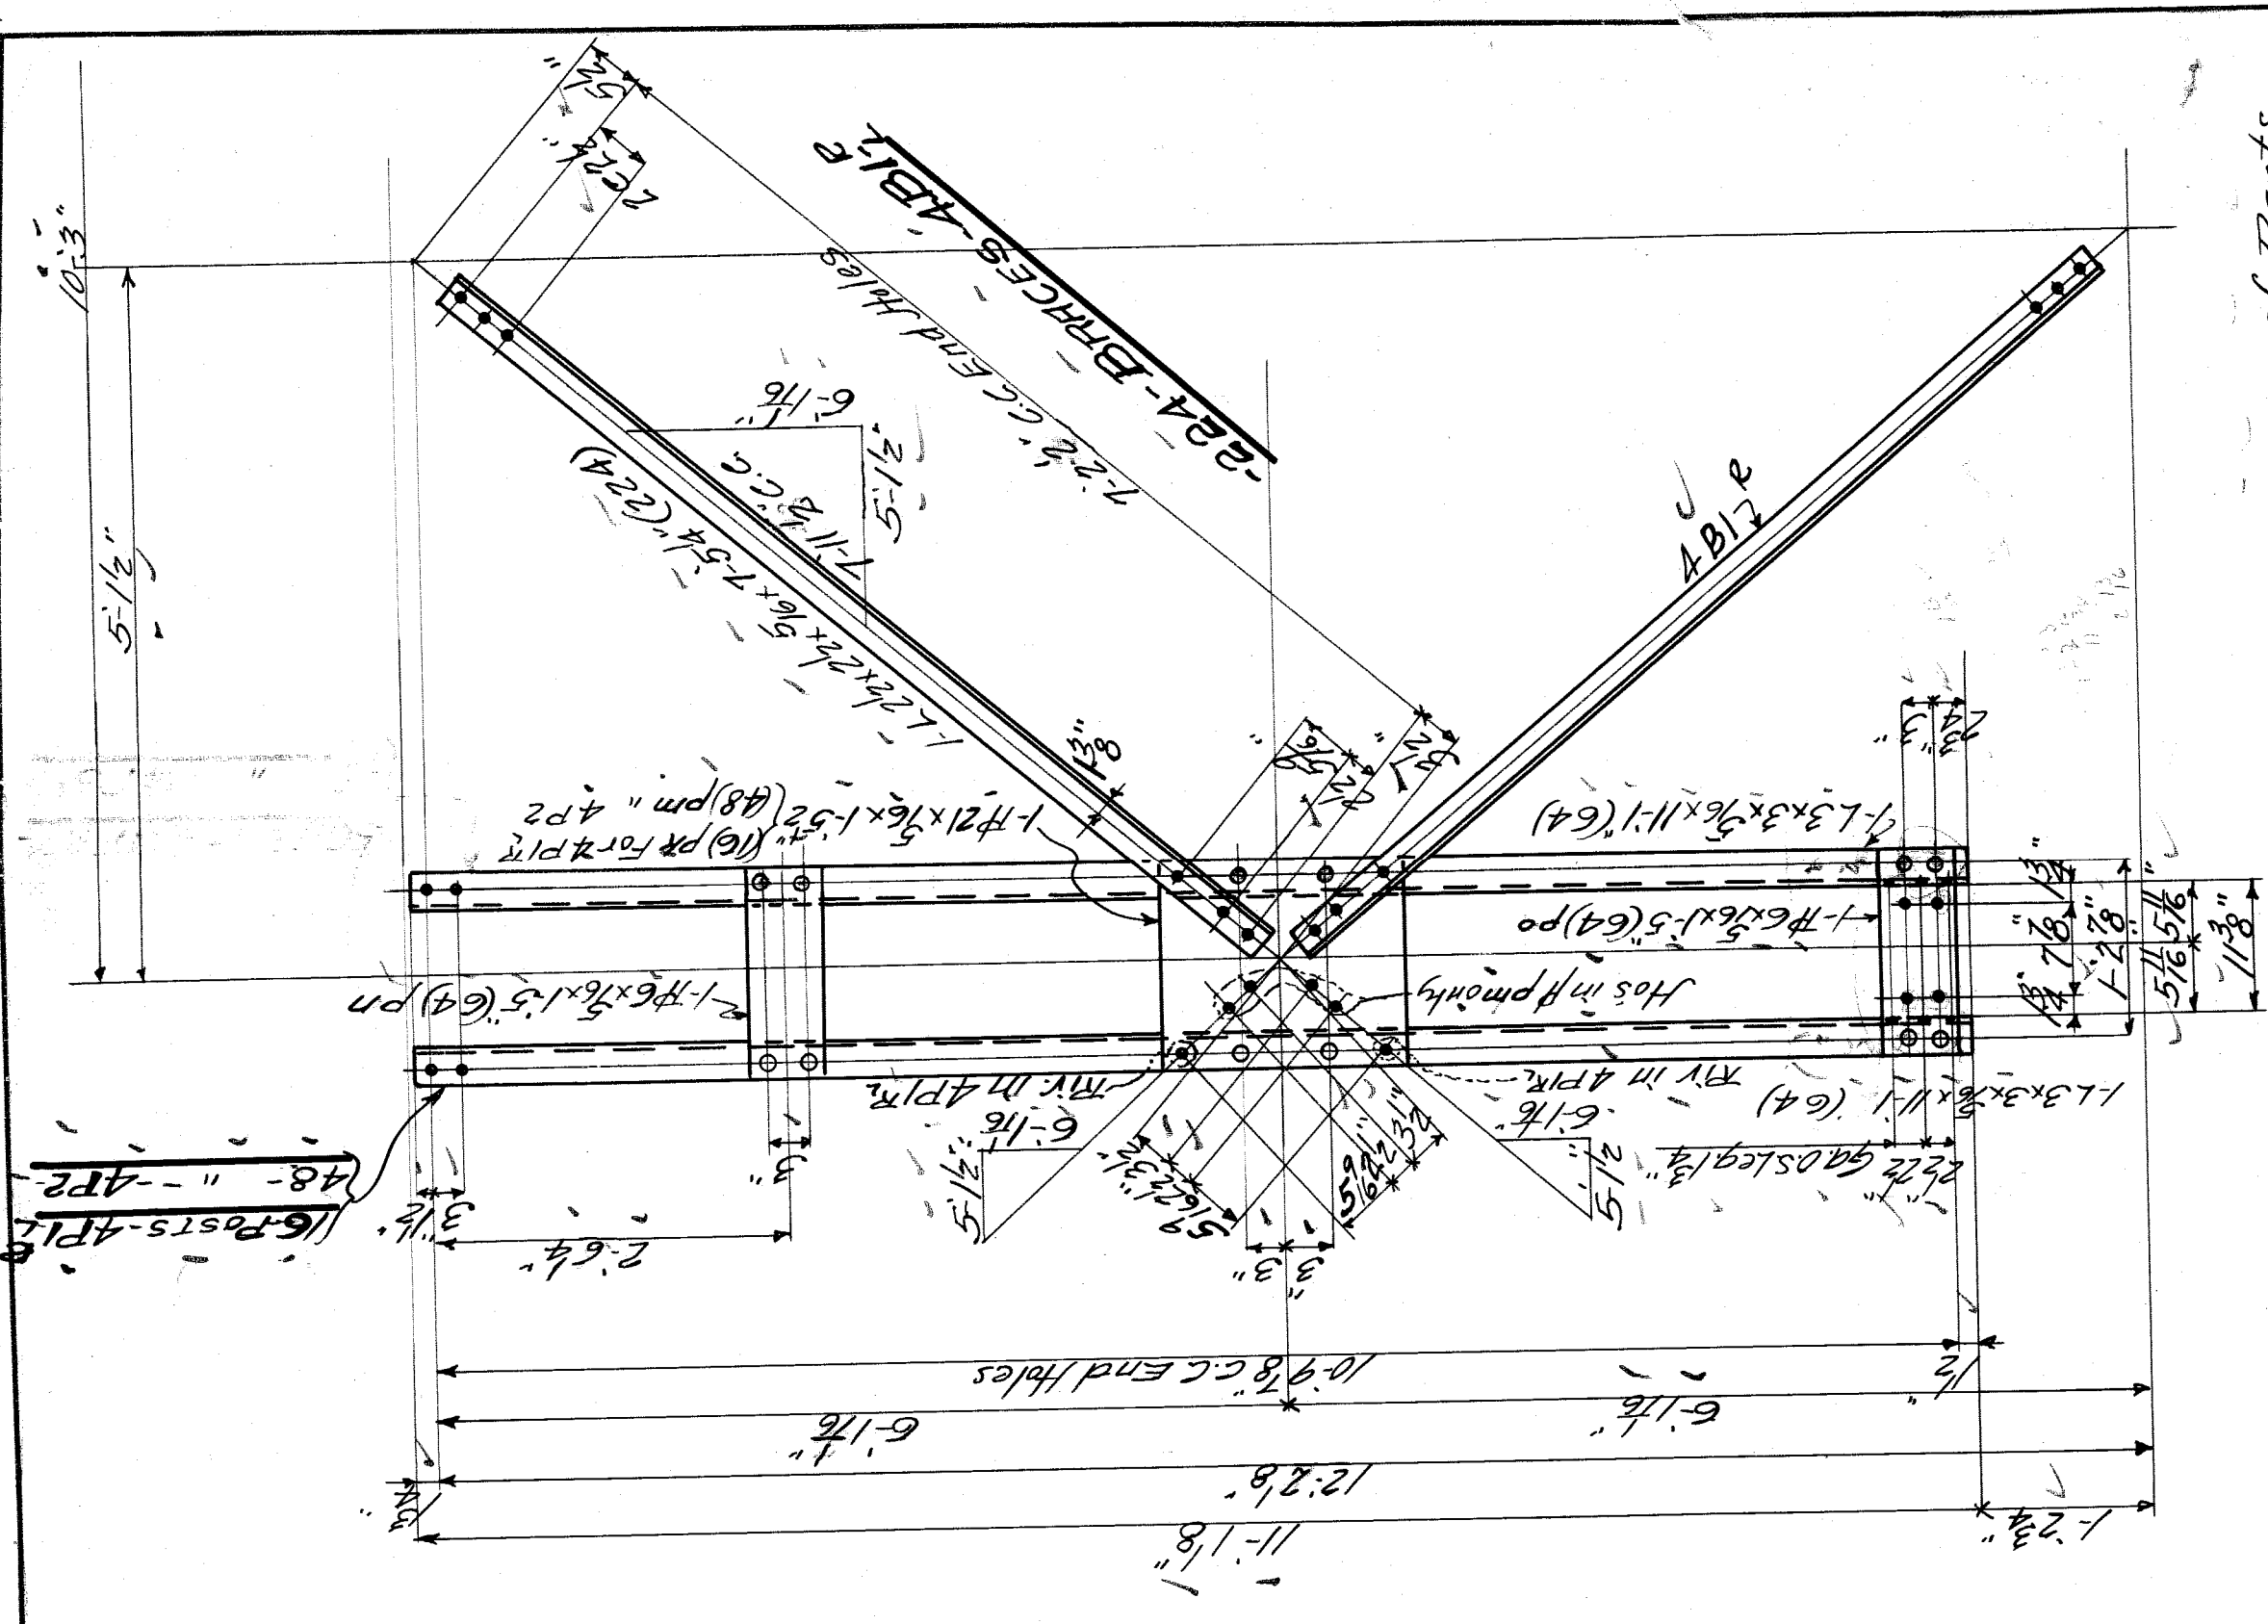

AA Description	Marks	Bill
16 Struts	451 F	40
"	452 F	"
"	453 F	"
"	454 F	"
"	455 F	"
"	456 F	"
56 Channels	4C1 F	46
16 Posts	4P1	"
48 "	4P2	"
64 "	4P4	46
64 Braces	4B1 F	46
"	4B2 F	40
"	4B7	"
"	4B8	"
"	4B9	"
"	4B10	"
"	4B11	40
"	4B12	40
"	4B13	"
"	4B14	"
"	4B15	"

WISCONSIN BRIDGE & IRON CO.
 NORTH MILWAUKEE, WISCONSIN

CONTRACT NO. 9377
 ERCTED BY
 City of Detroit
 LOCATION: Detroit, Mich.
 DESCRIPTION: Belle Isle Bridge
 Piers 5-6-7-8

DETAILS OF SPECIFICATIONS: Essels by Mappbreeming, None

INSPECTION BY: SHOP PAINT: None (see Specification)

FIELD PAINT: OPEN HOLES: 18"

RIVETS: MADE BY: G. L. & H. F. S. DATE: 6-27-21










TRACED BY: S. M. Roberts DATE: 6-30-21


CHECKED BY: M. J. P. DATE: 7-1-21

SCALE: 3/4" = 1'-0"


DATE REVISED: ON SECTION

SHEET NO. 4

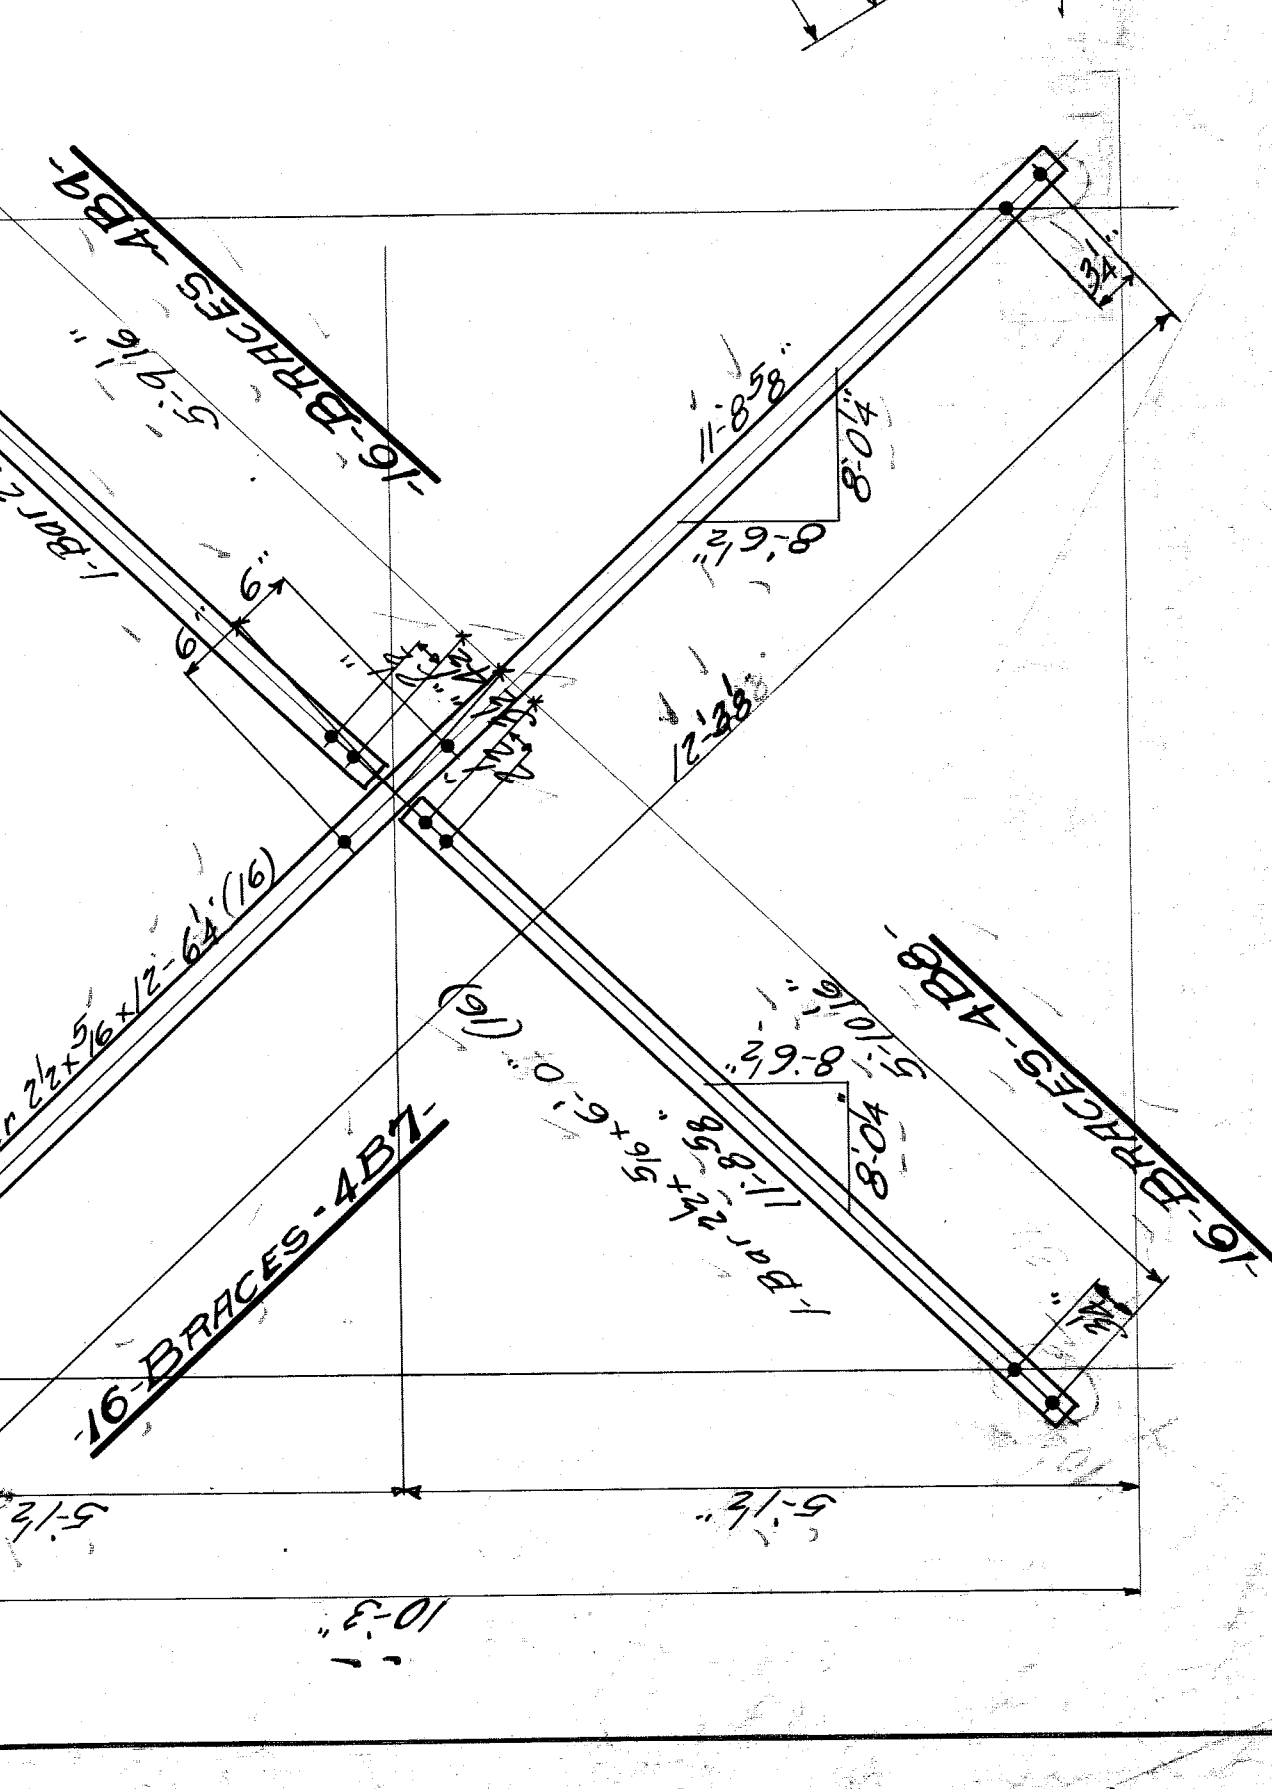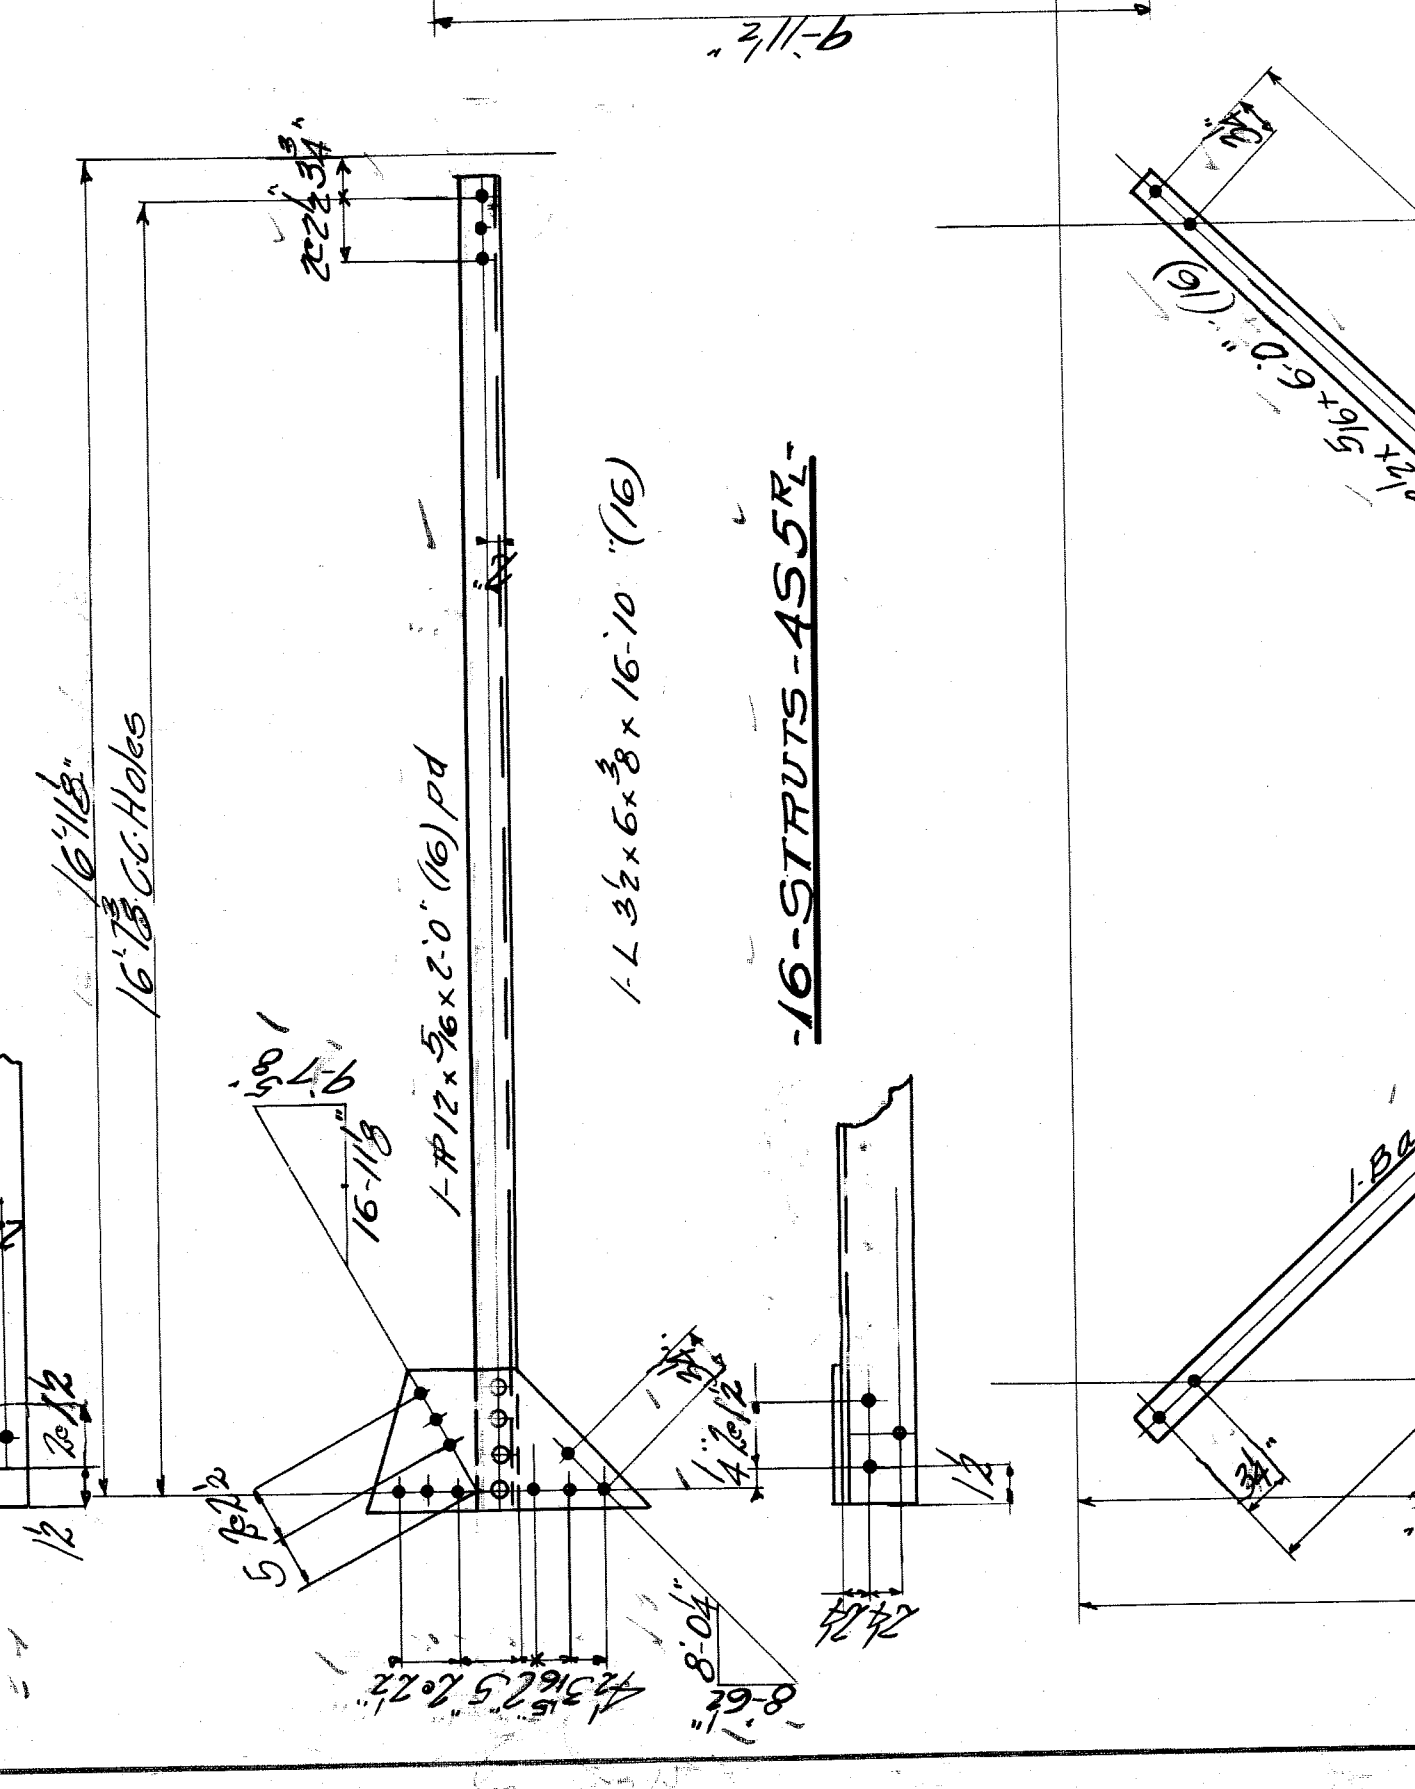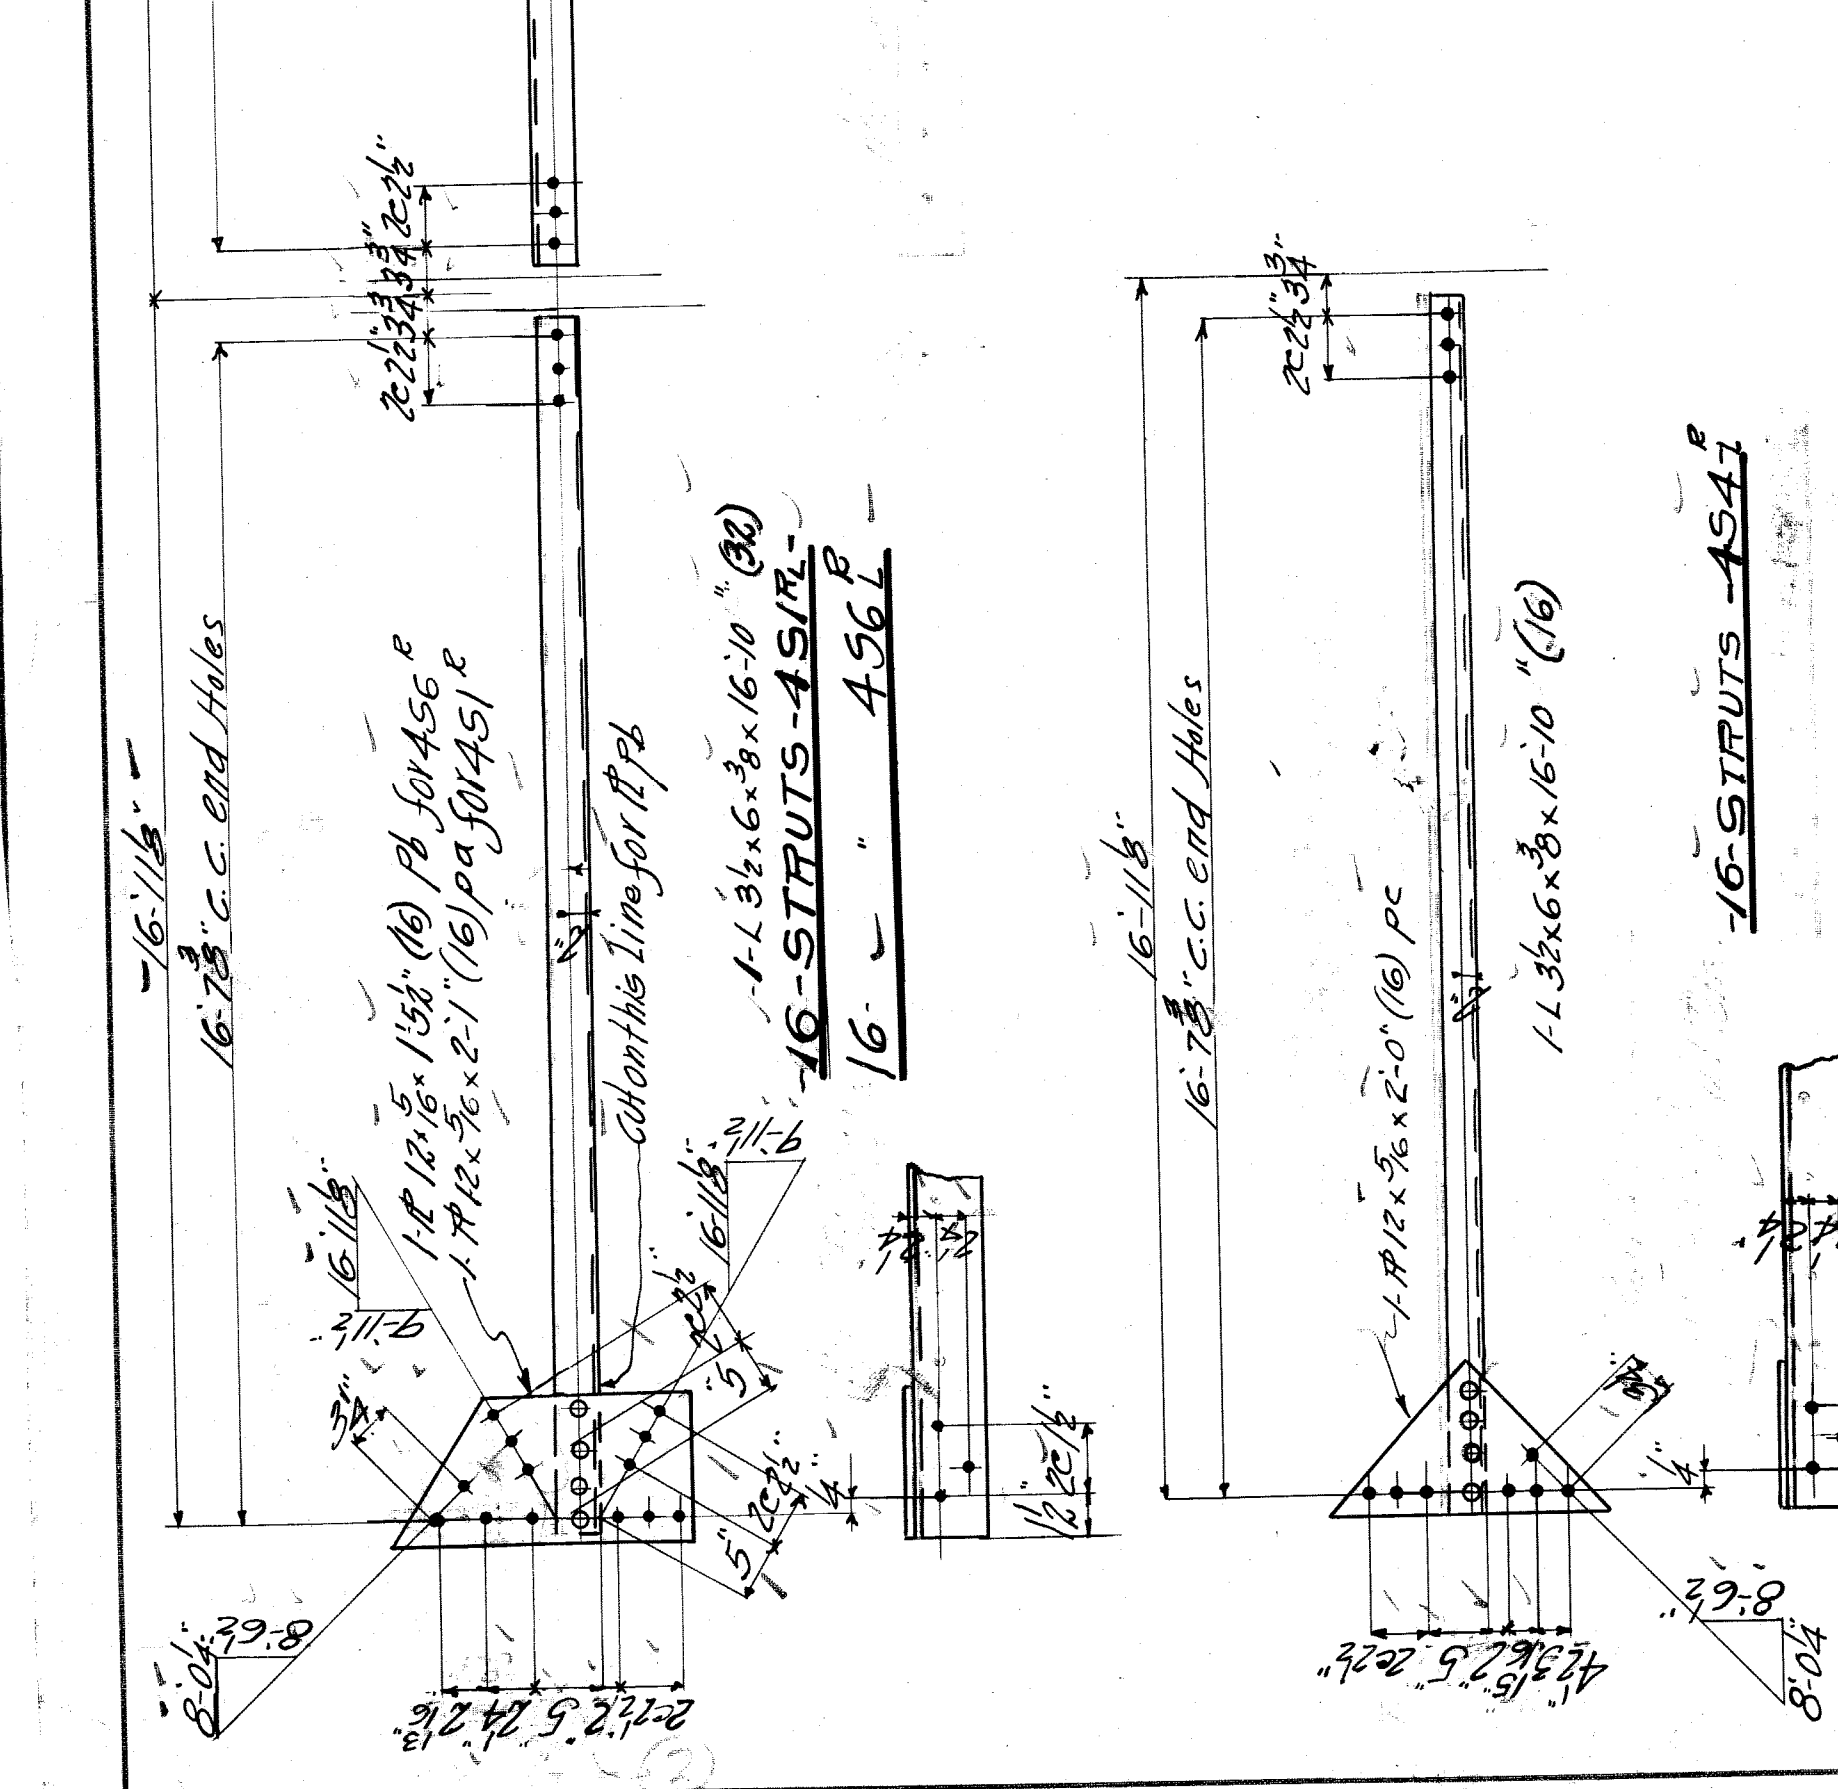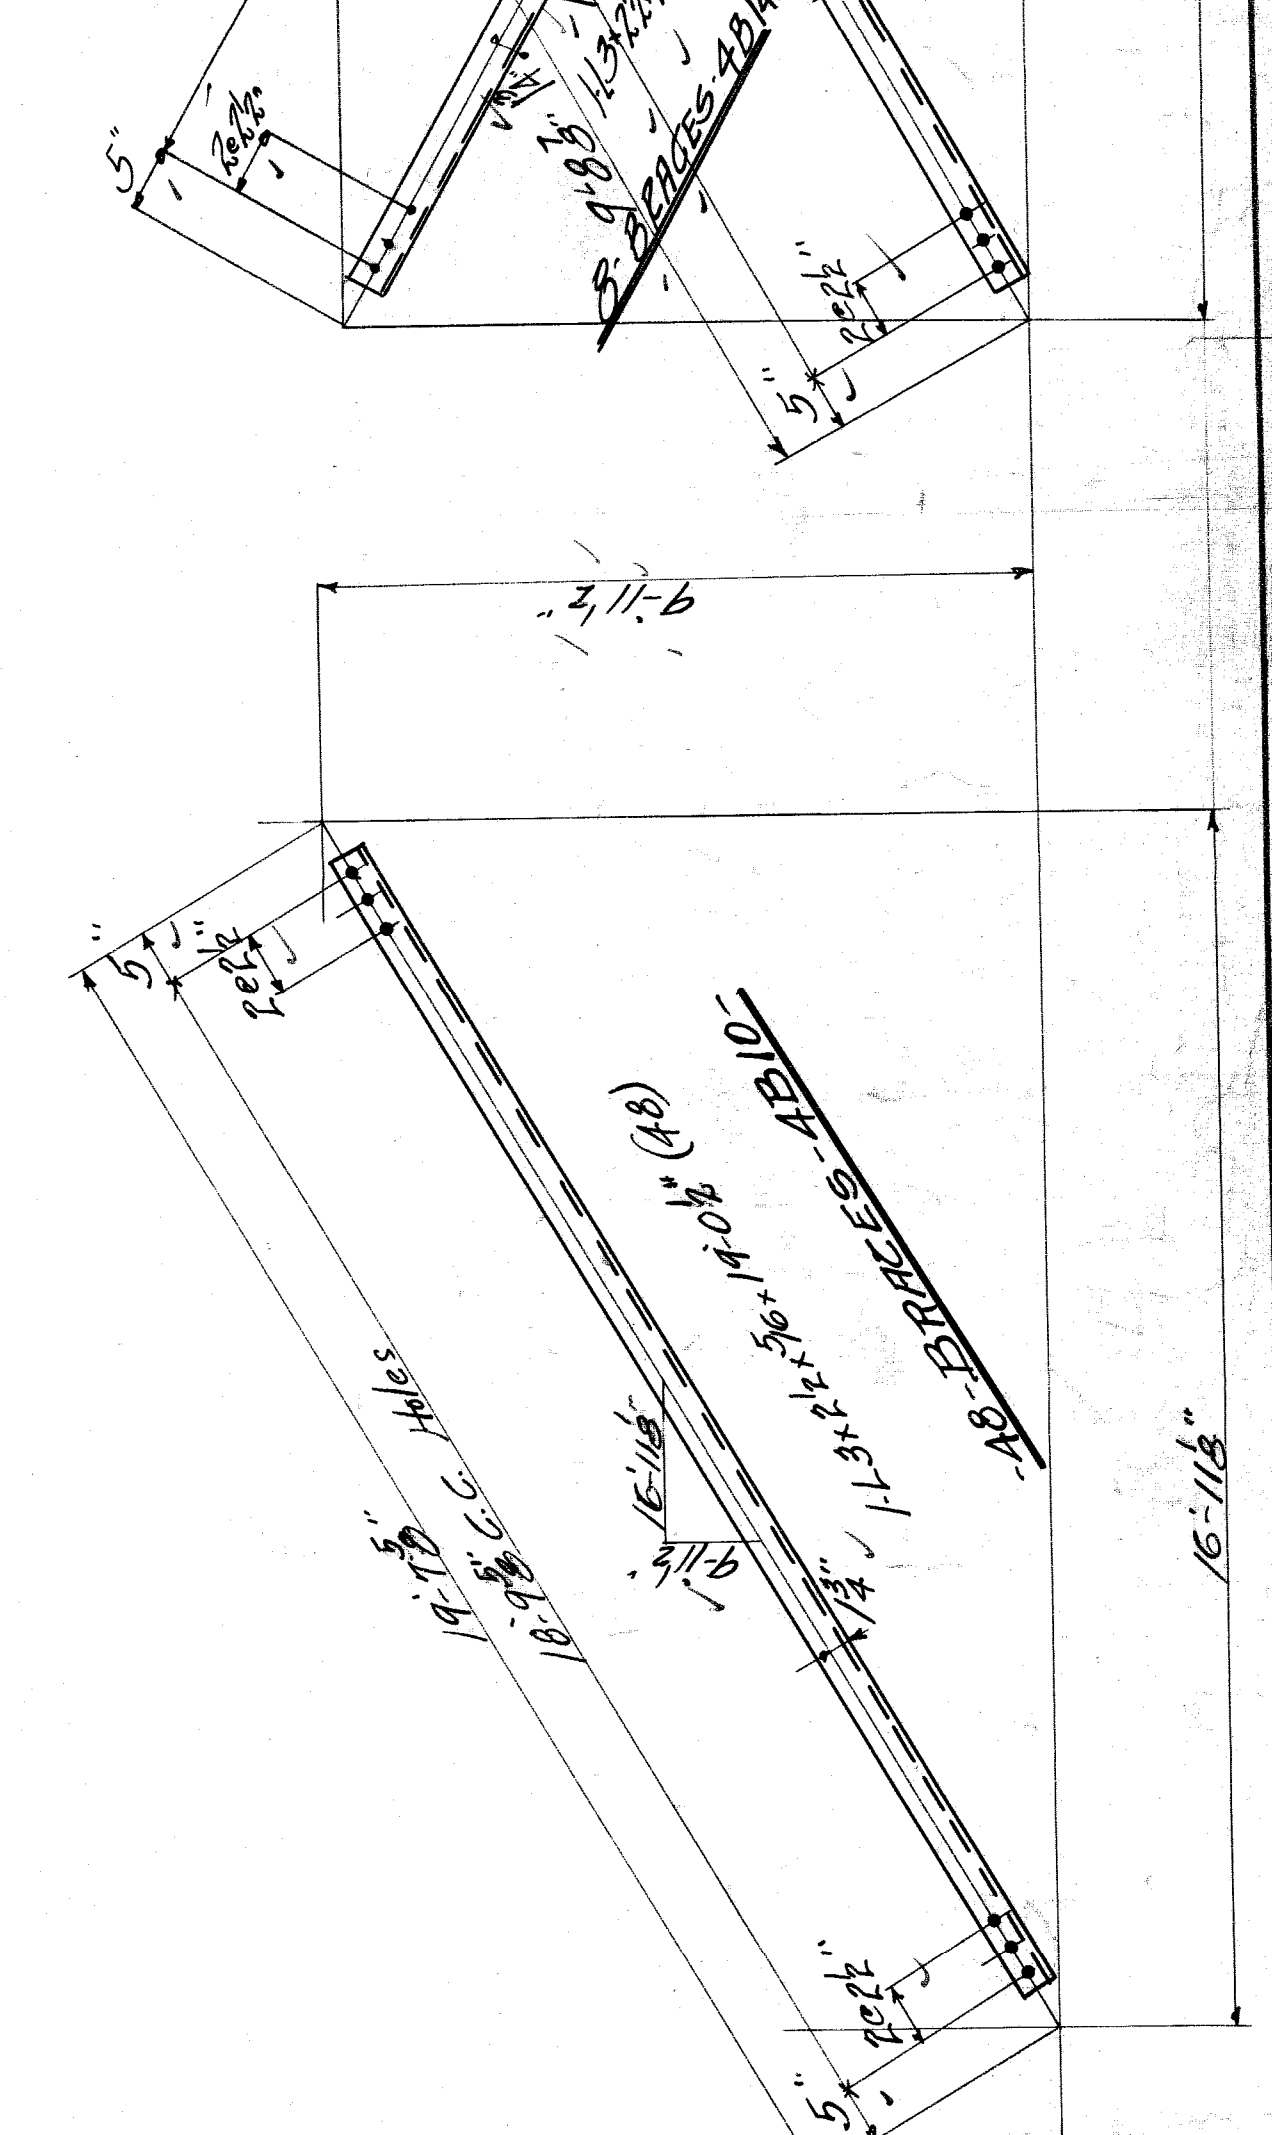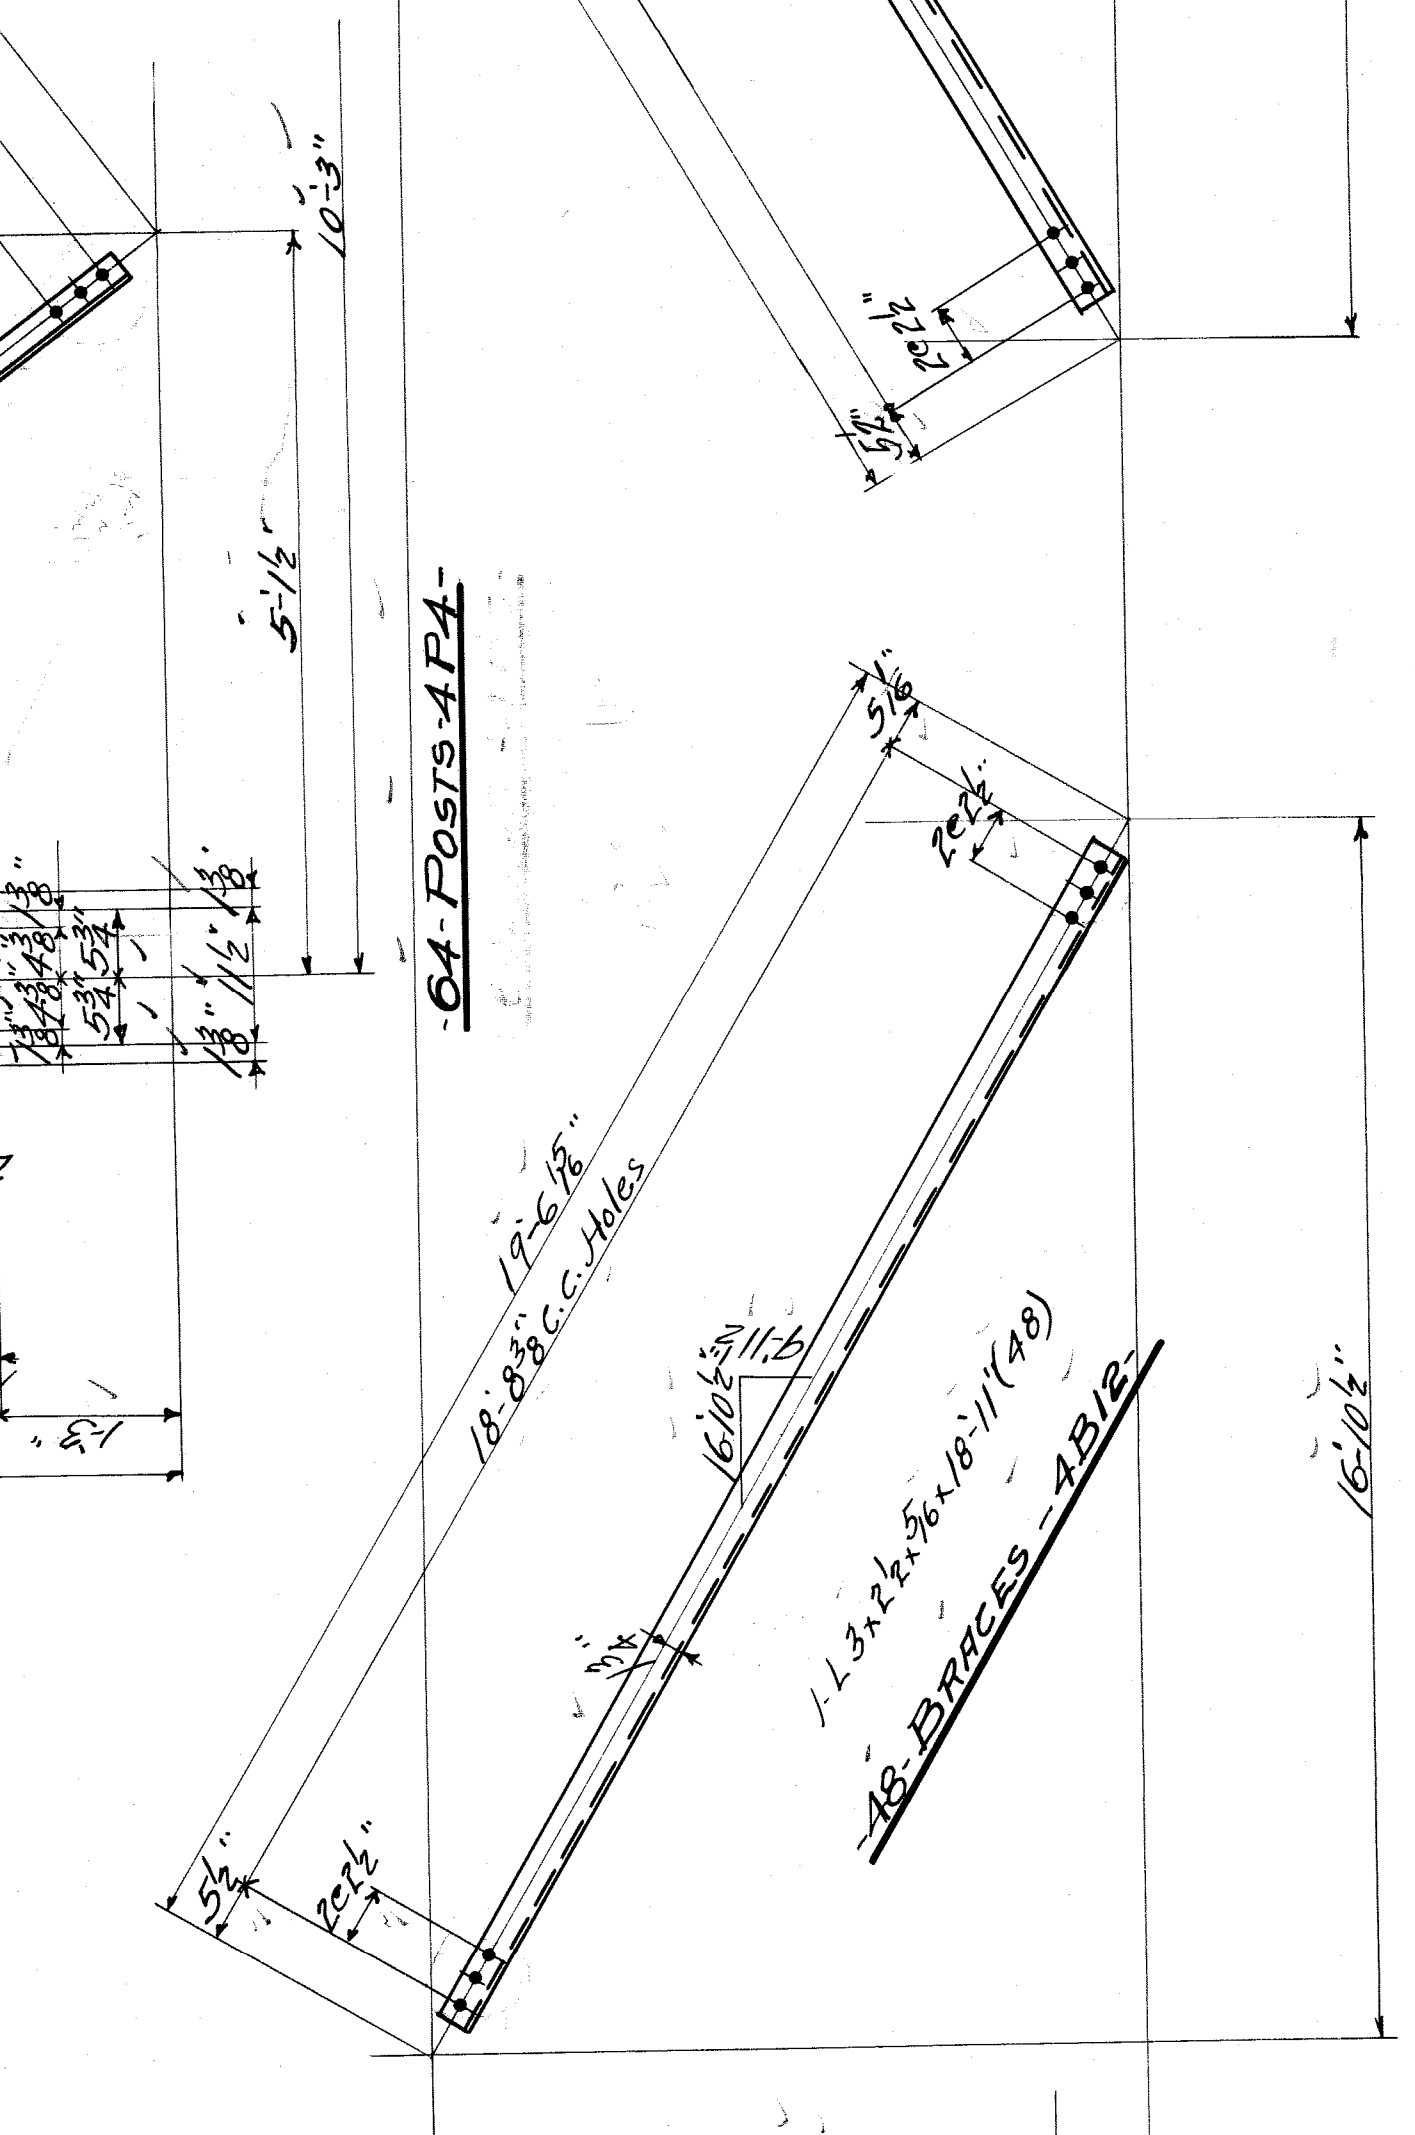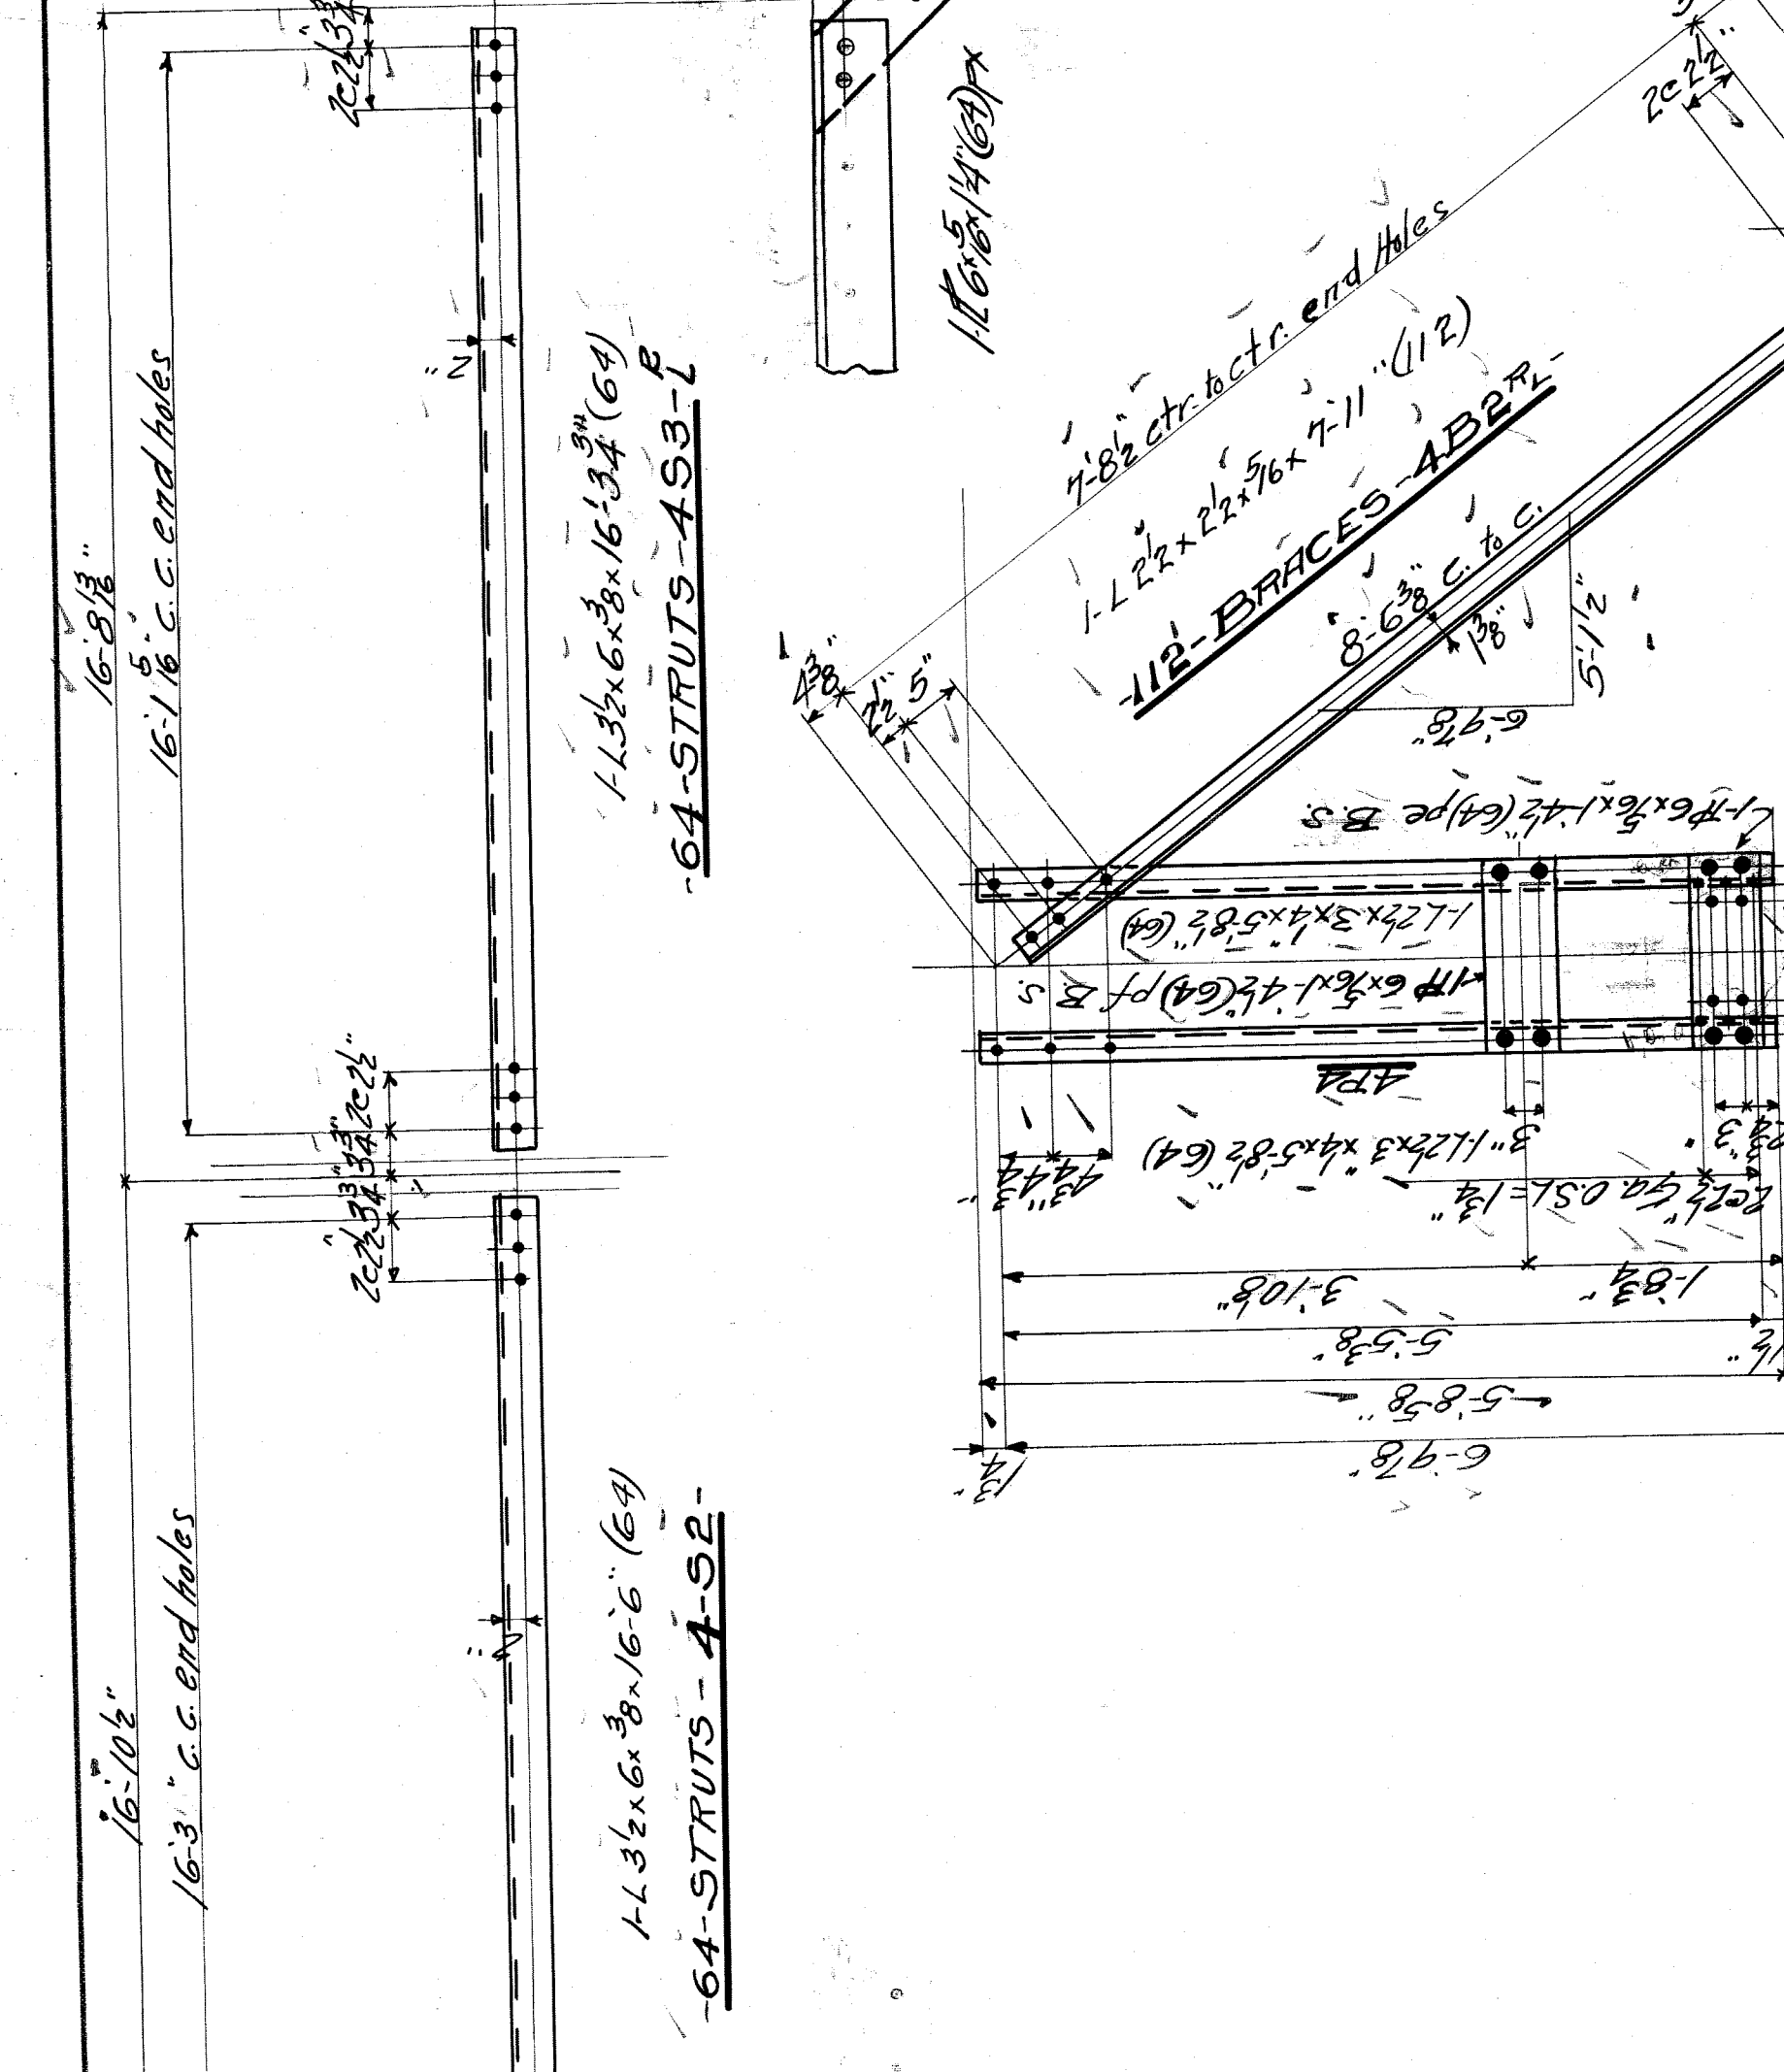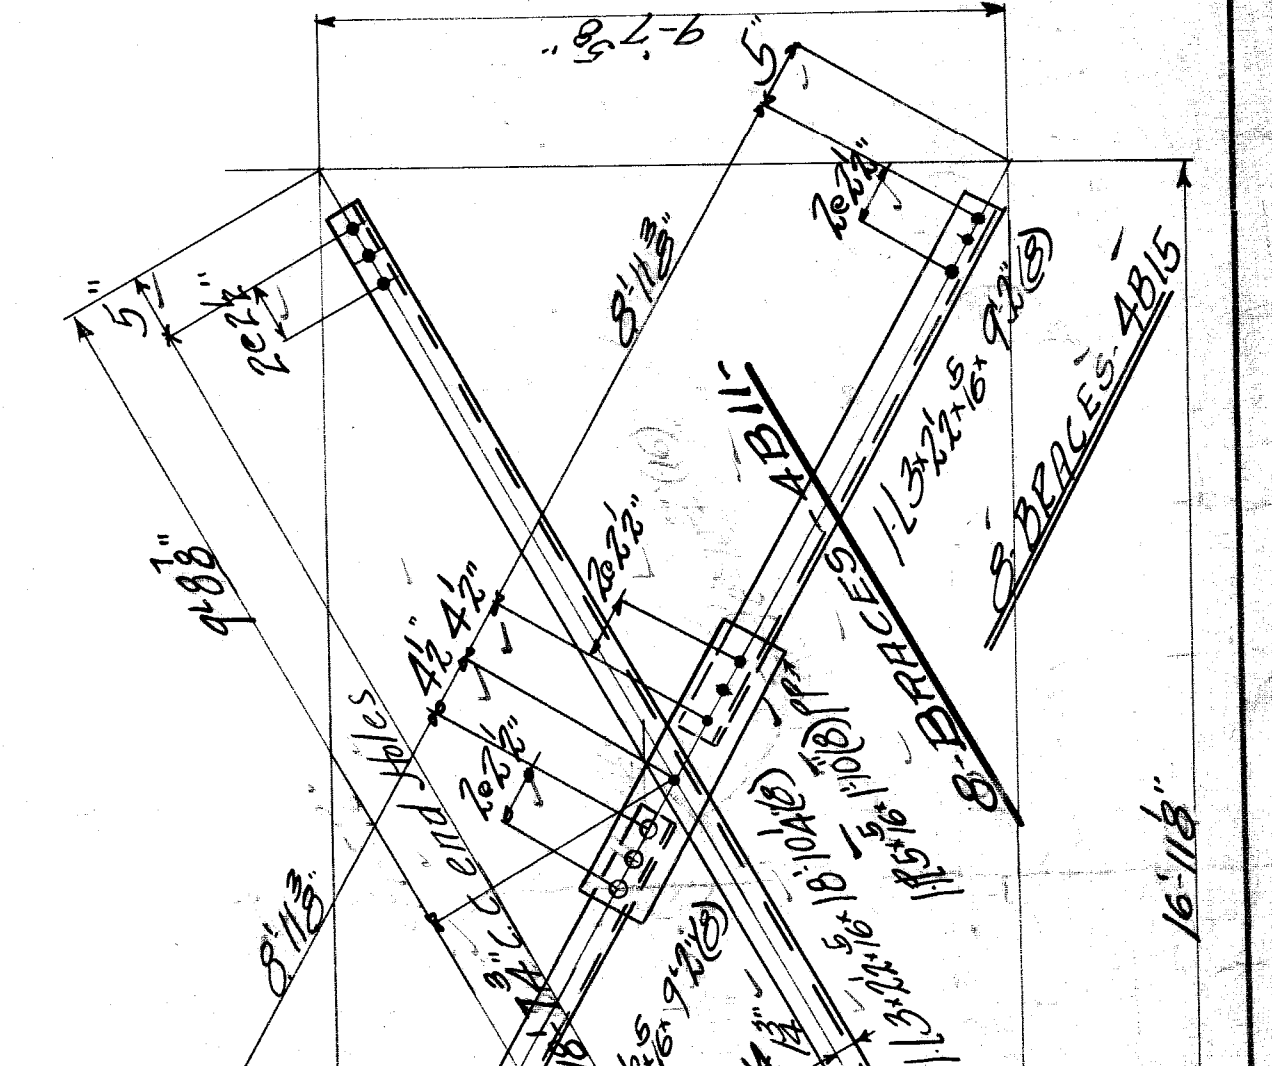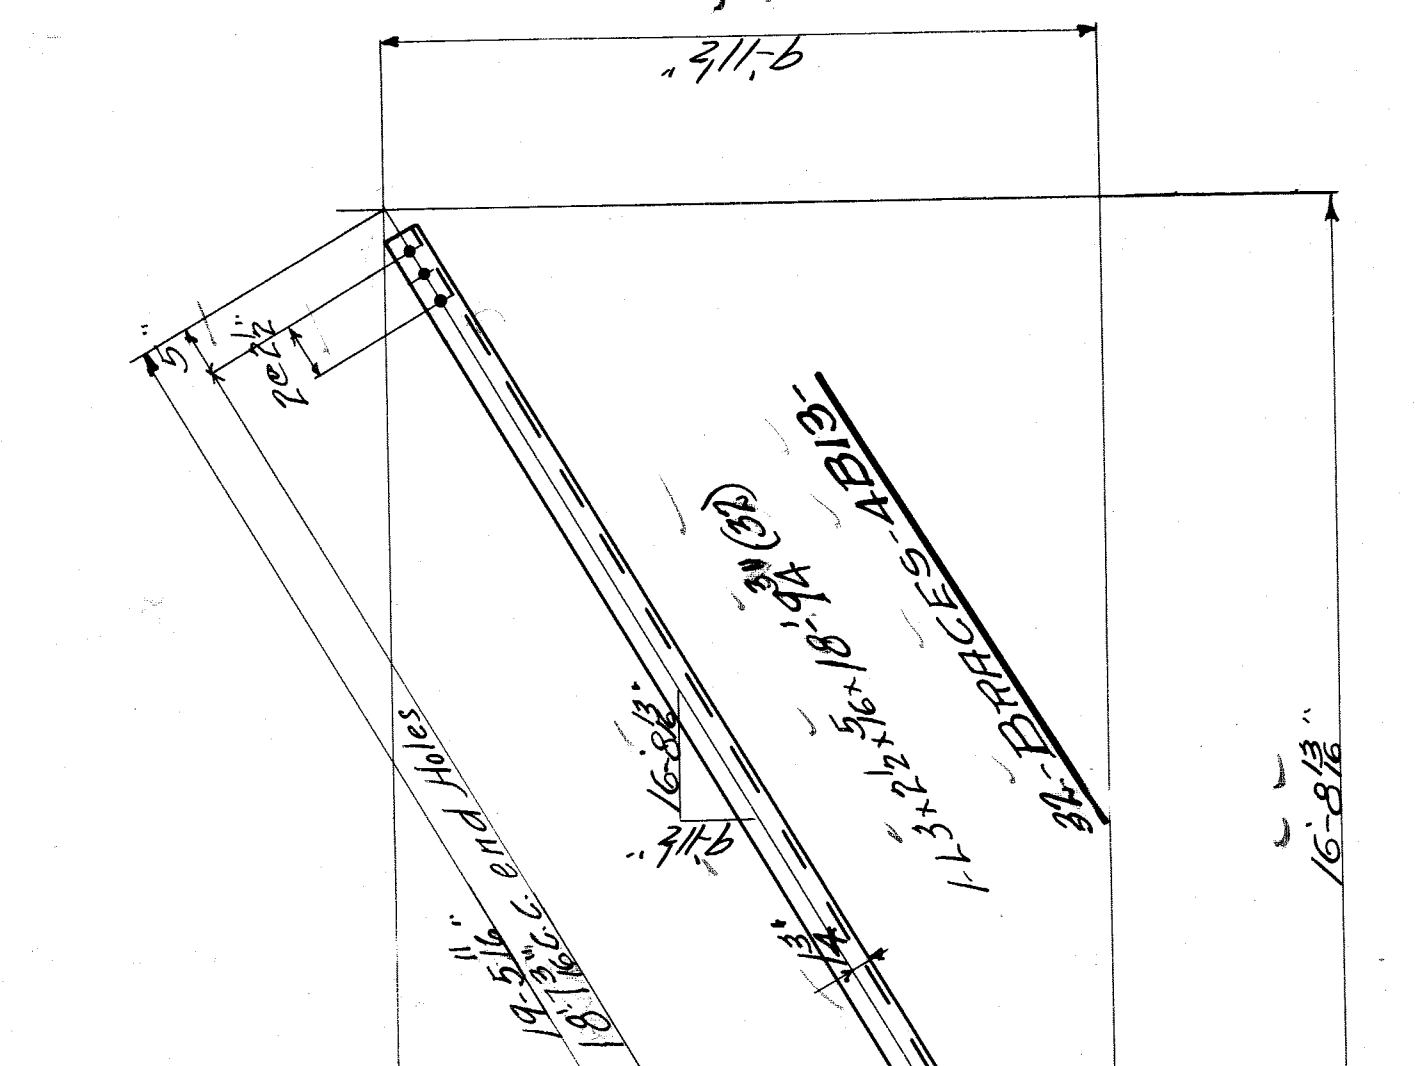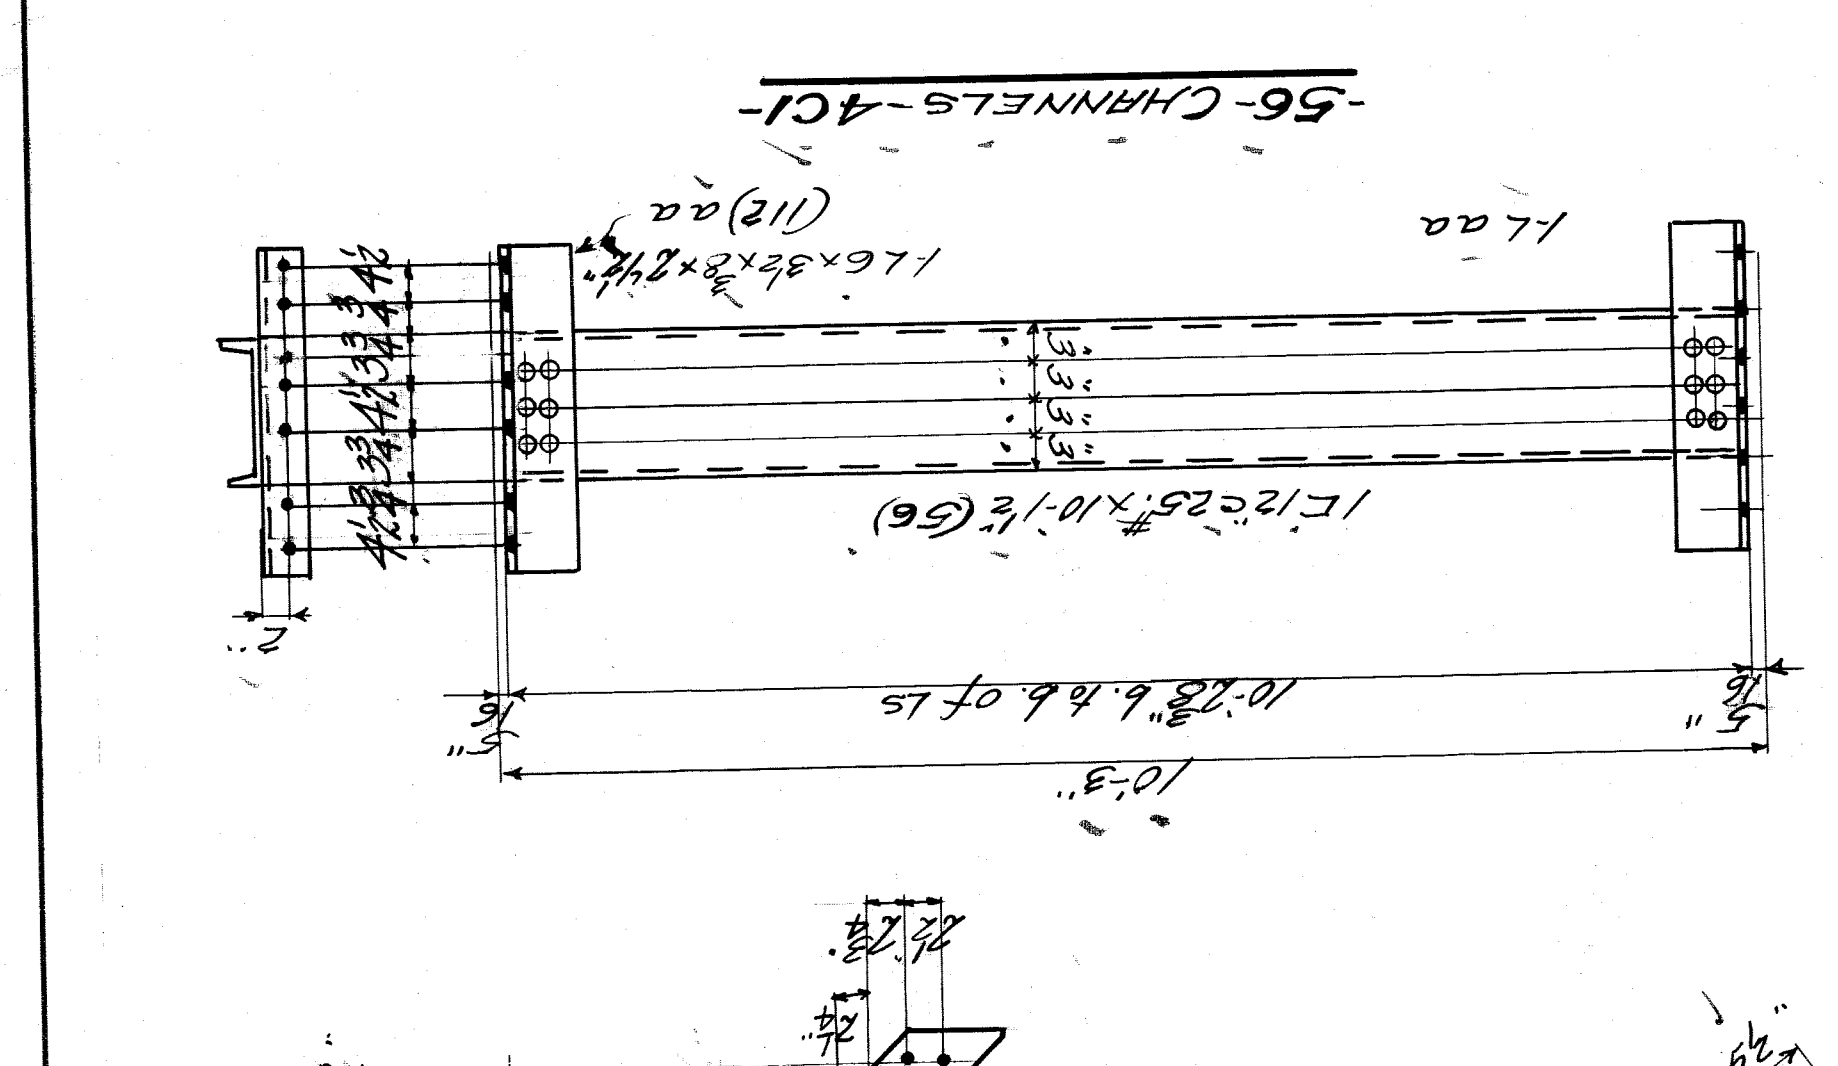


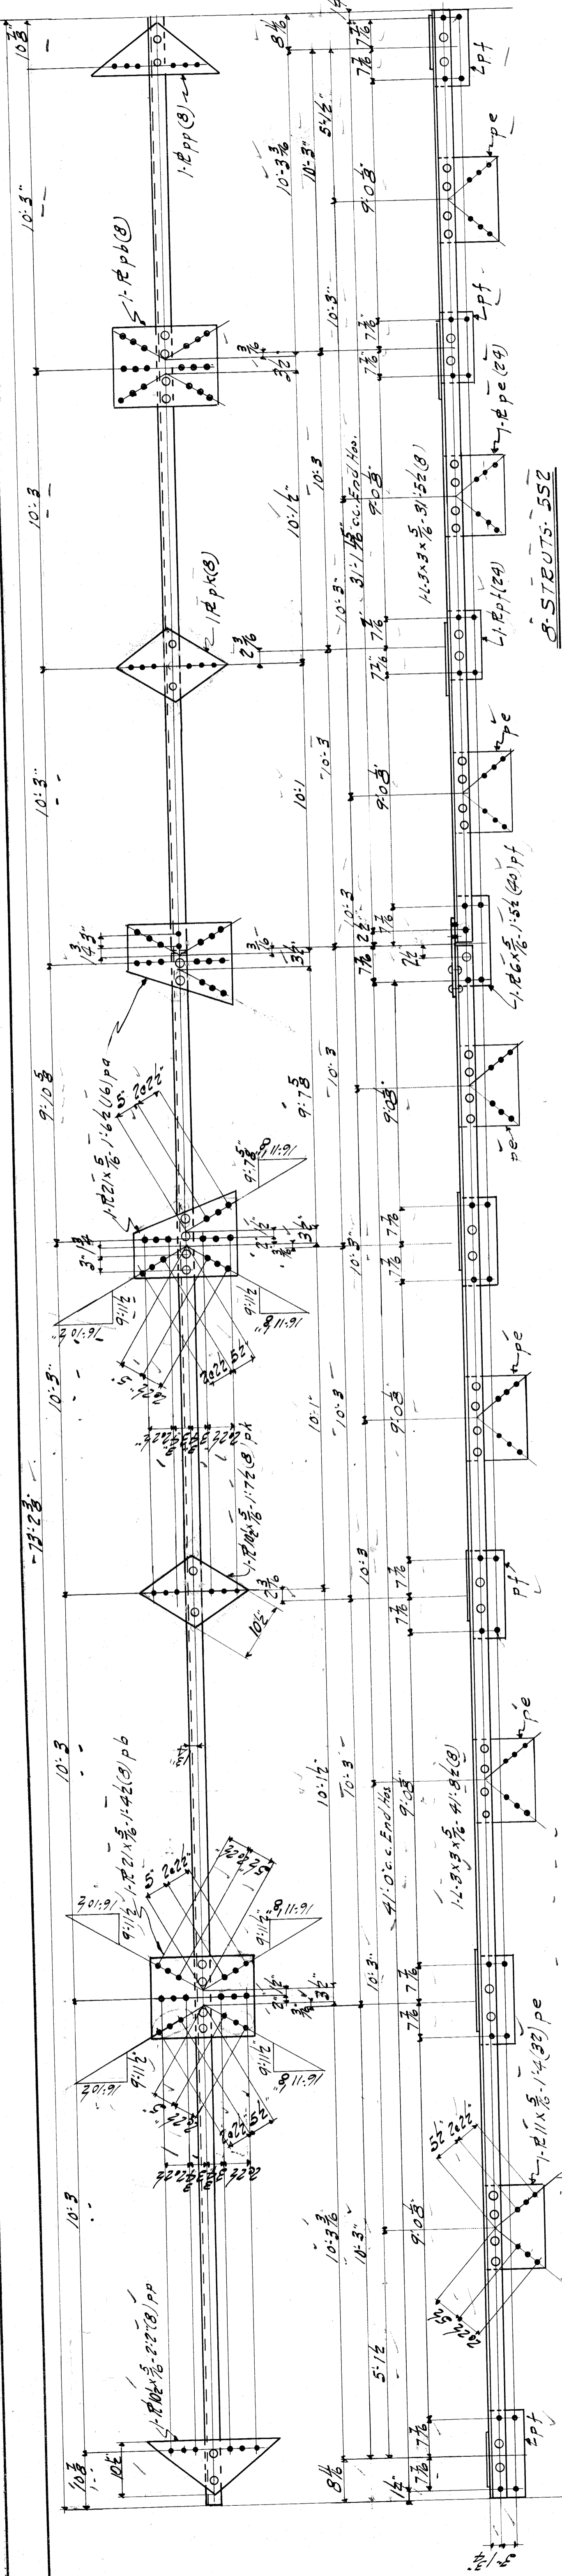

8-STRUTS-551

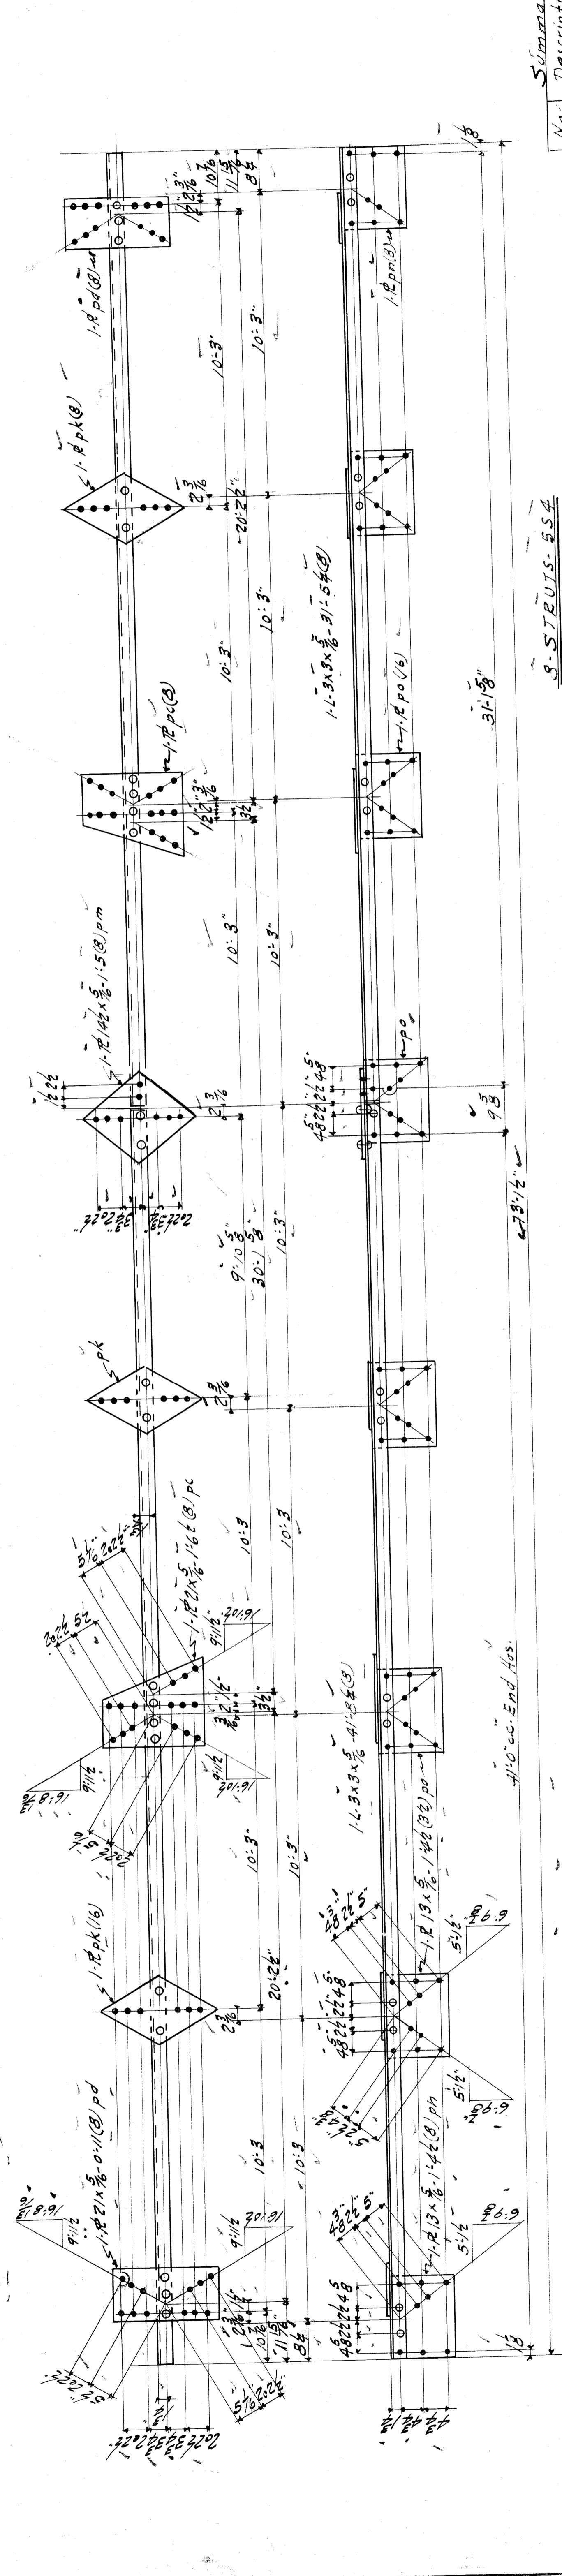

8-STRUTS-552

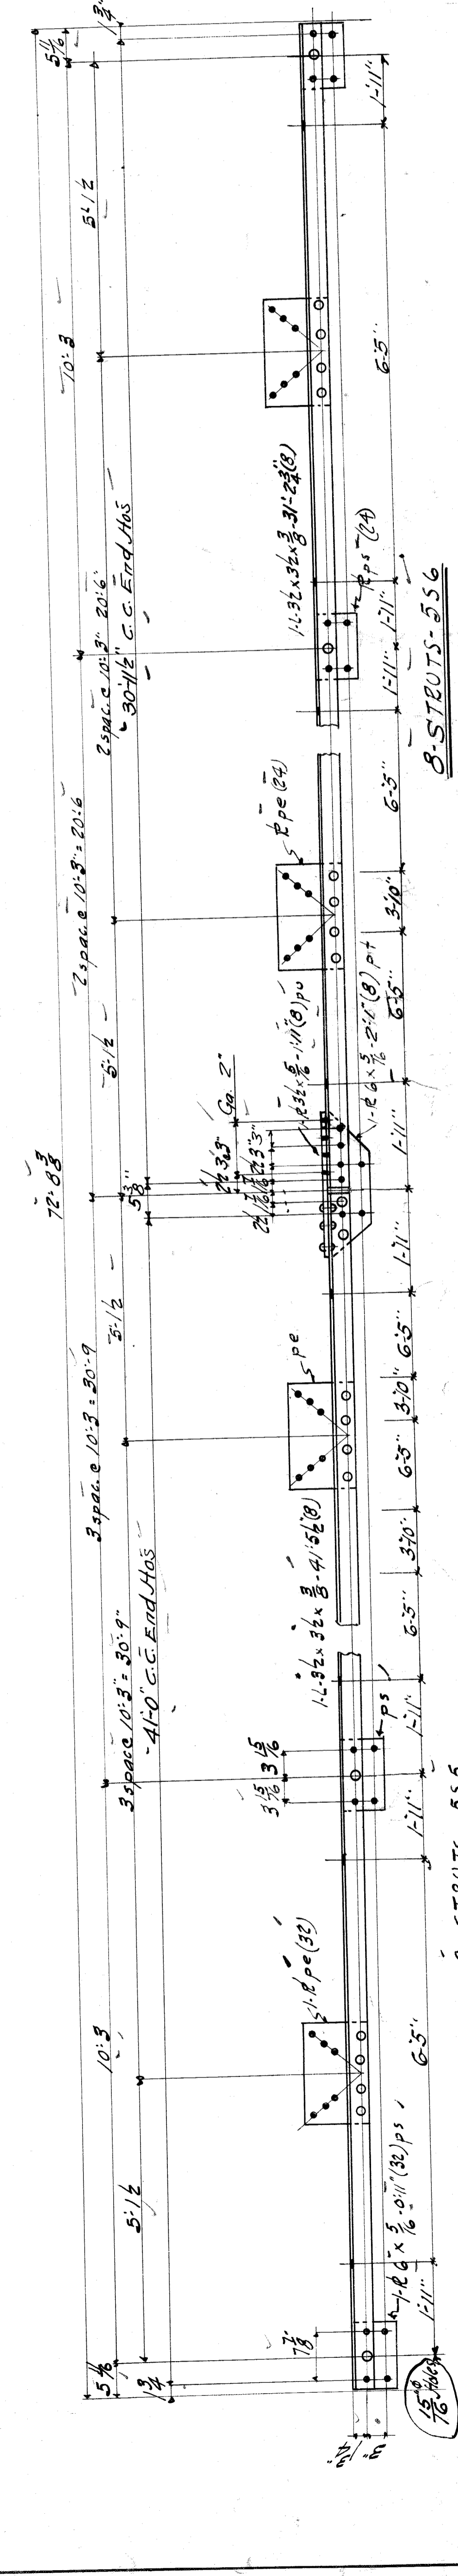


8-STRUTS-556

Summary






No.	Description	Mark	Net
8	Struts	551	50
8	"	552	"
8	"	553	"
8	"	554	56
8	"	555	"
8	"	556	"

WISCONSIN BRIDGE & IRON CO.
NORTH MILWAUKEE, WISCONSIN

ERECTED BY M.B. & I. Co.
CONTRACT NO. 9377
FOR City of Detroit
LOCATION Detroit Mich
DESCRIPTION Belle Isle Bridge
DETAILS OF Struts
SPECIFICATIONS See Ism. Murphy
INSPECTION BY Esselsky - Murphy
SHOP PAINT Name C. sec. Specification
FIELD PAINT Name C. OPEN HOLES 3/8
RIVETS 3/4
MADE BY H.P.S.
TRACED BY
CHECKED BY
SCALE 1/4" = 1'-0"
DATE REVISION
SECTION
DATE 8-27-21
DATE 8-27-21
SHEET NO. 5
9377

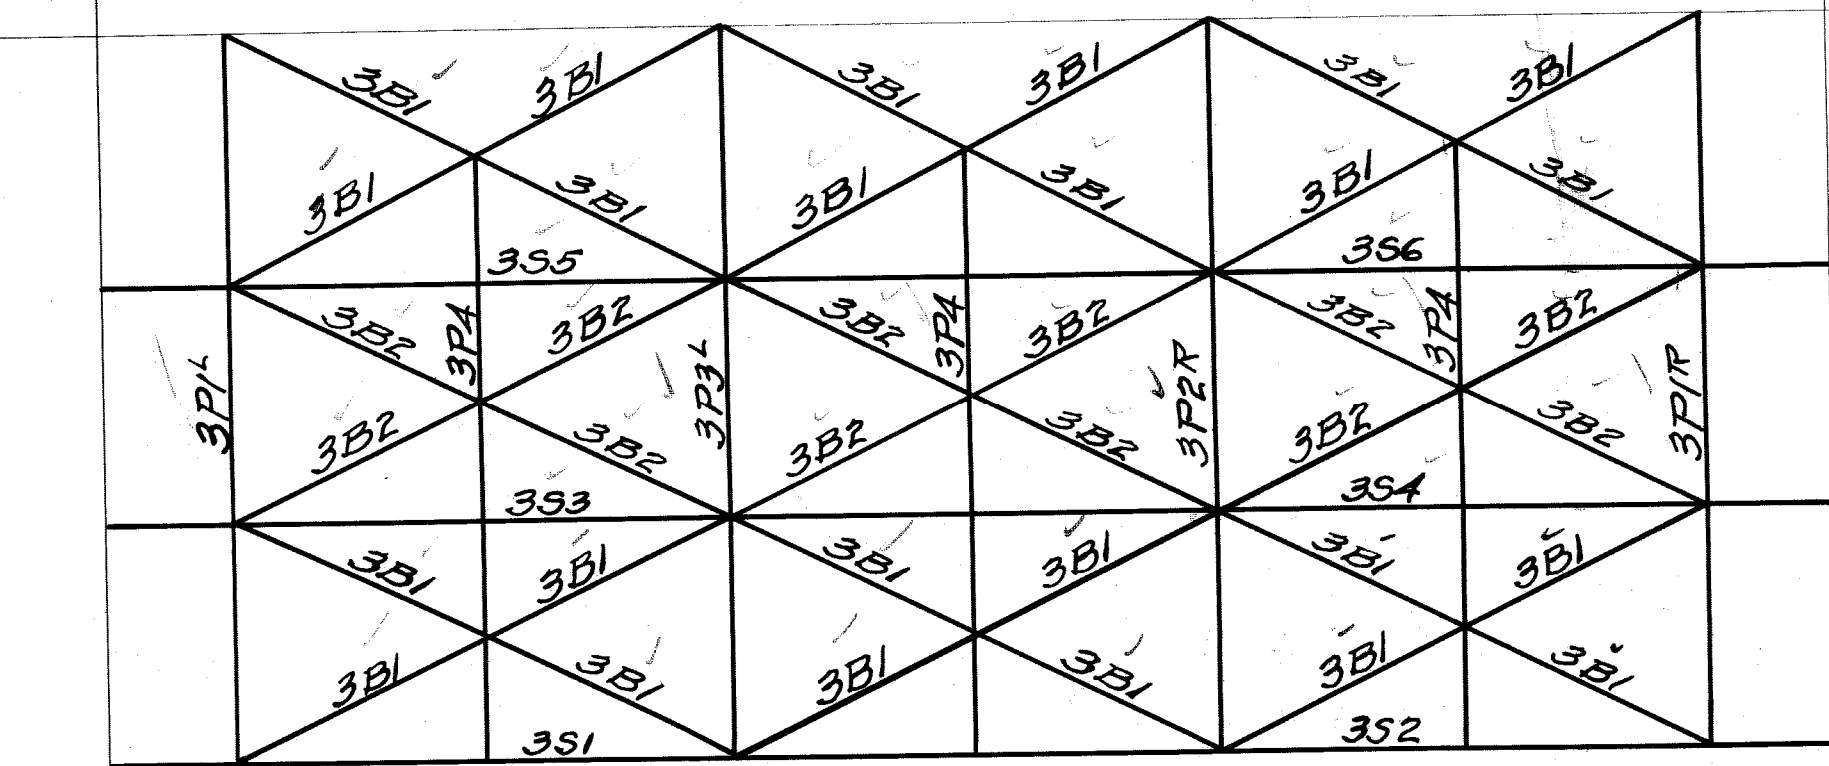

Bracing on line of Pier
SECTION "DD"

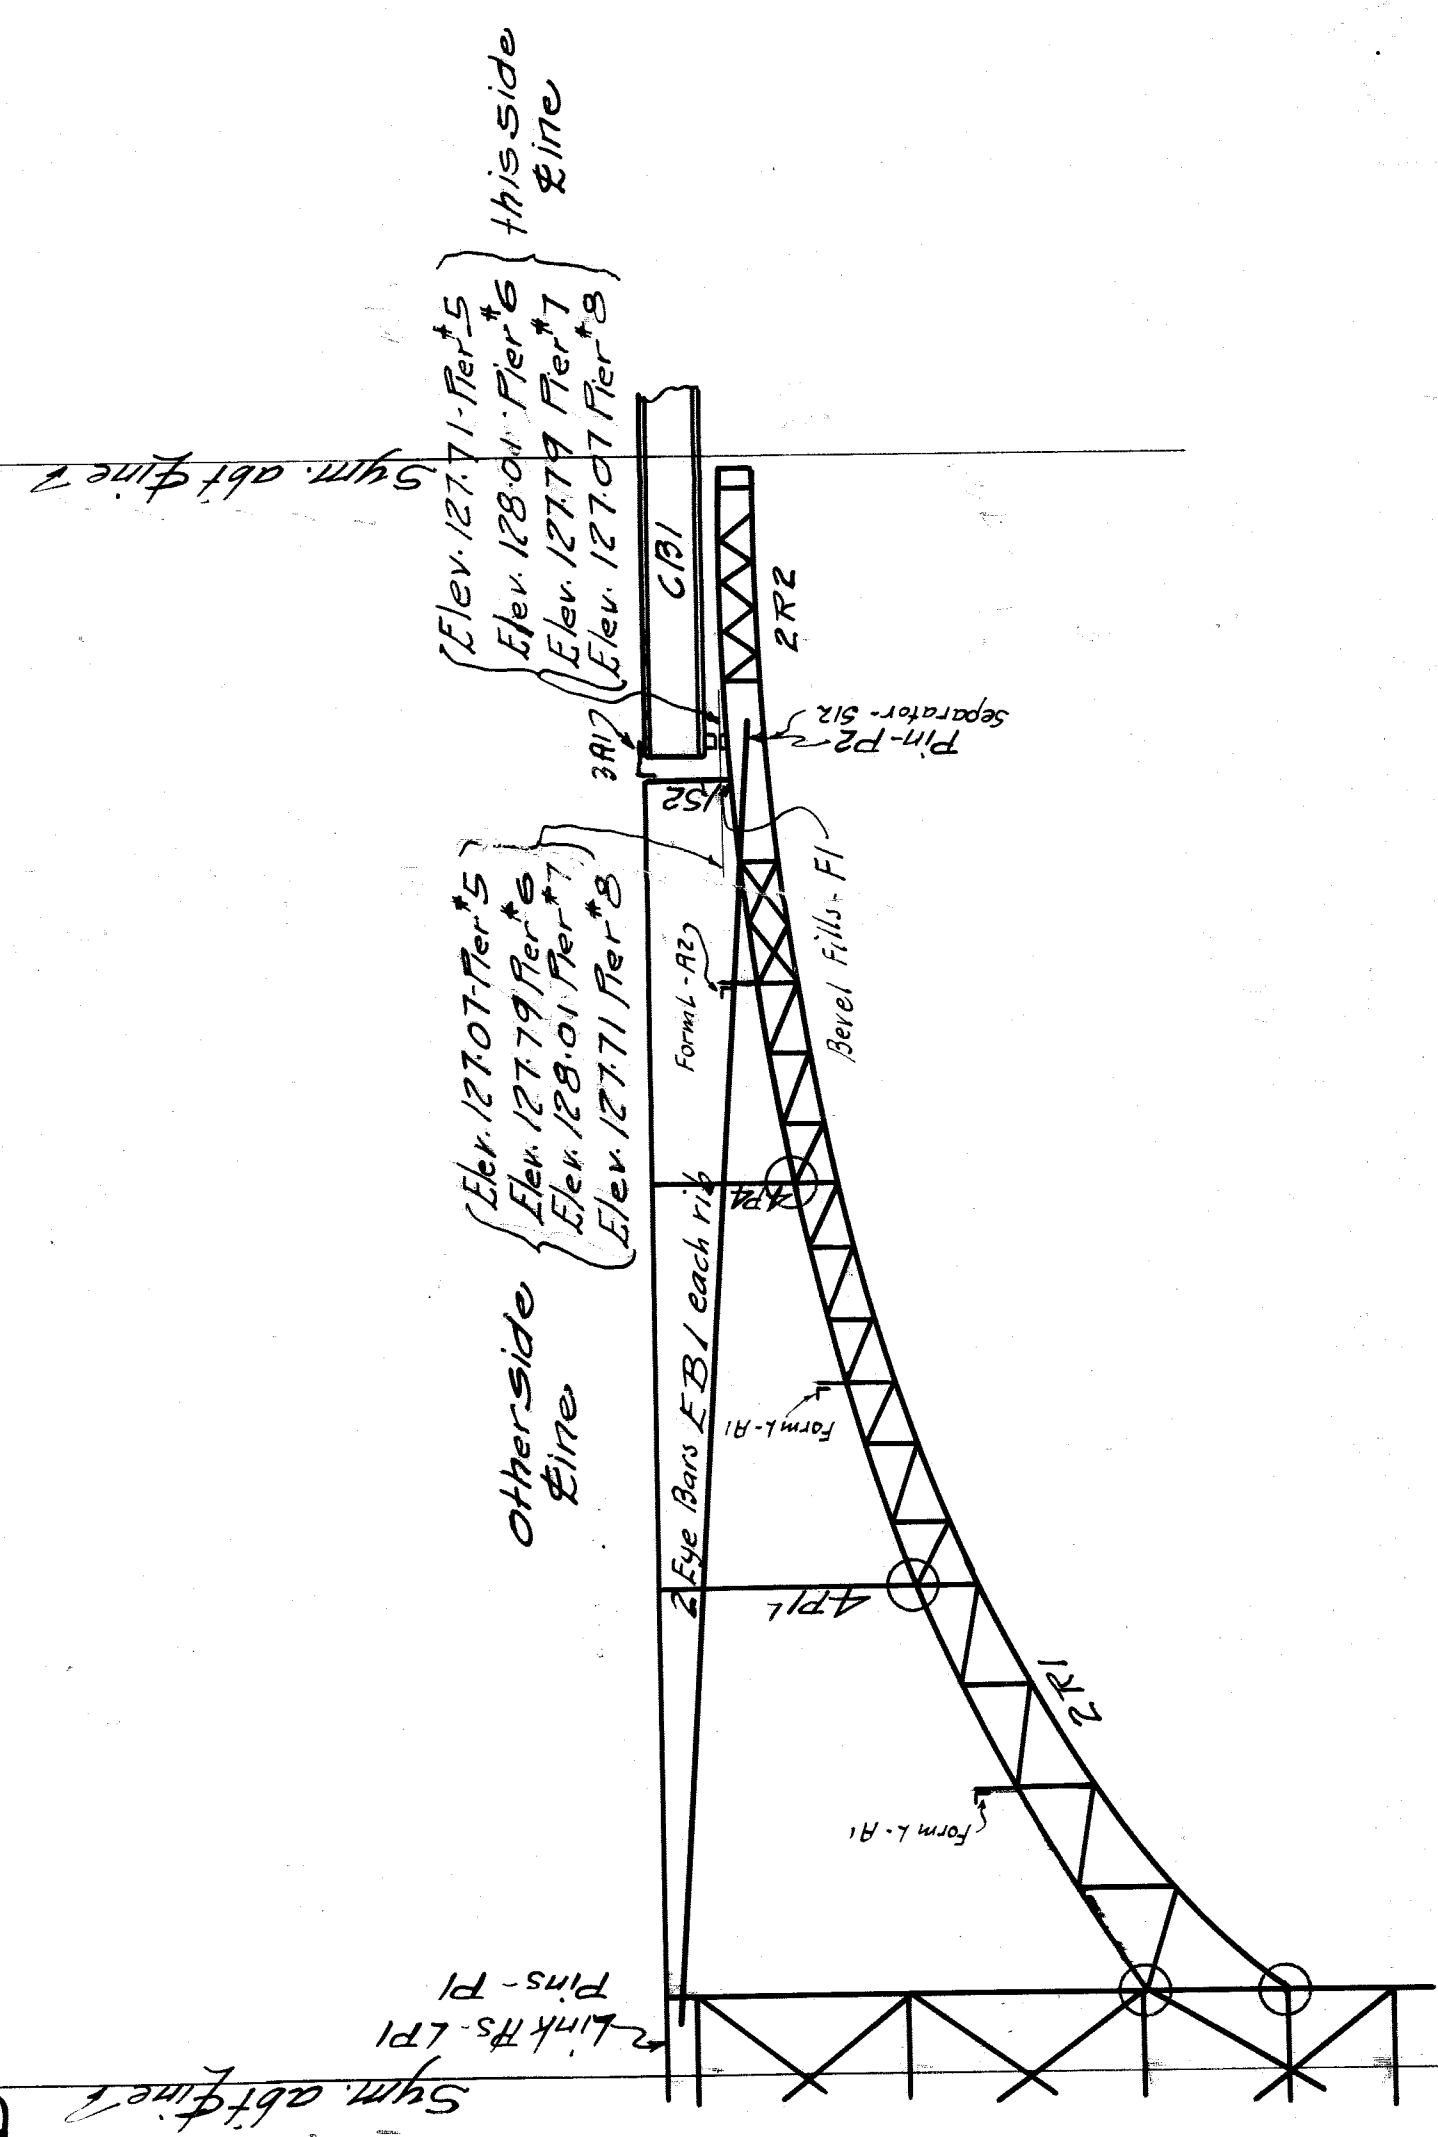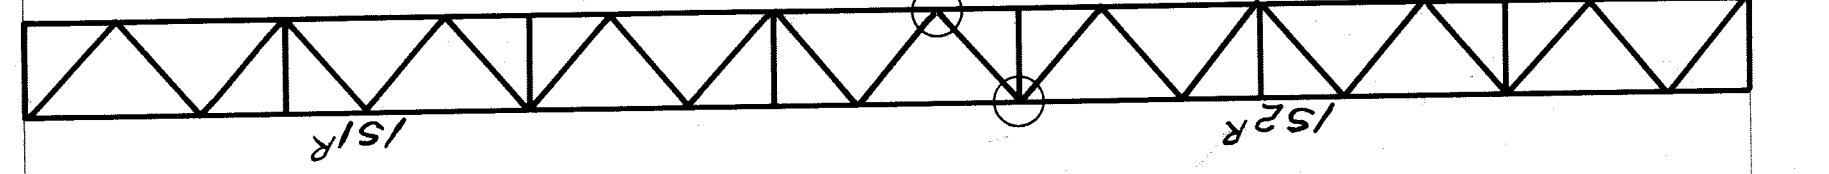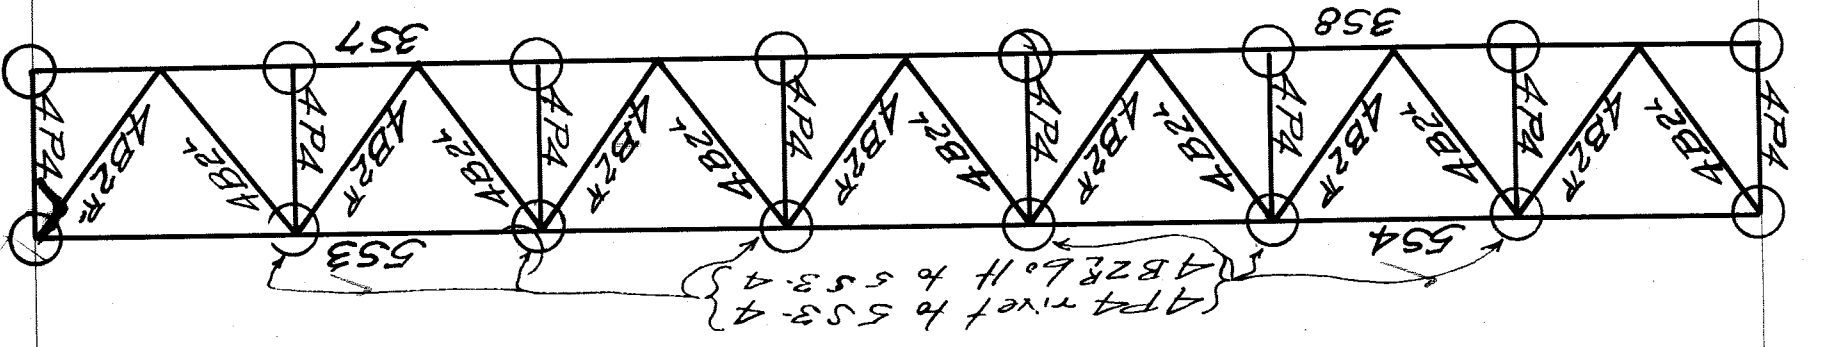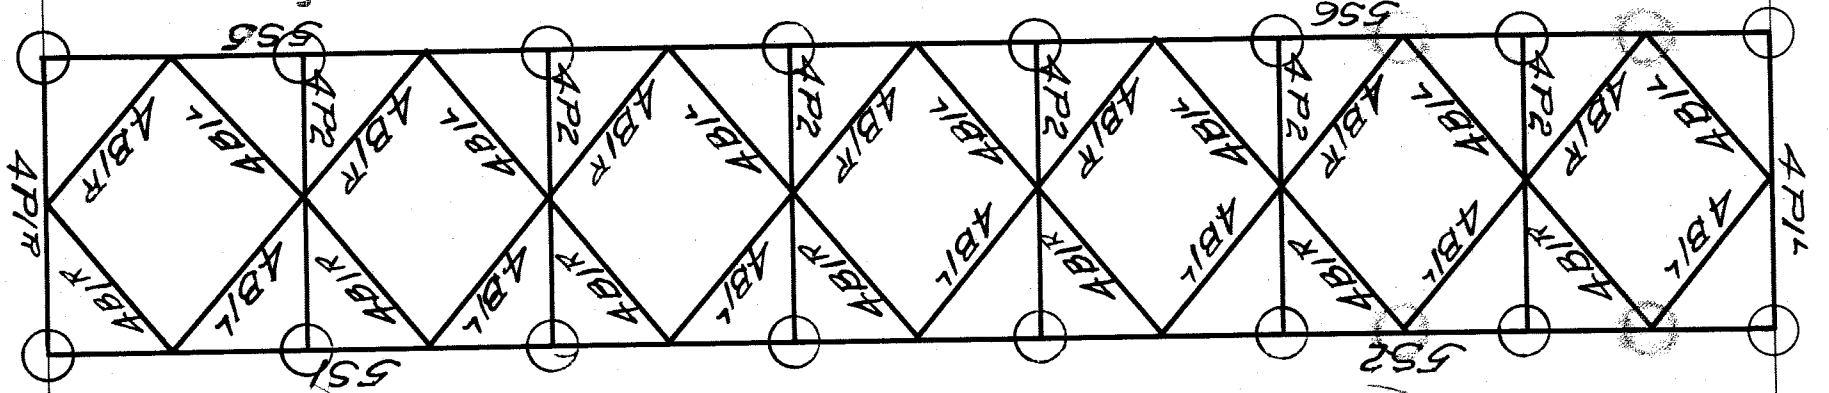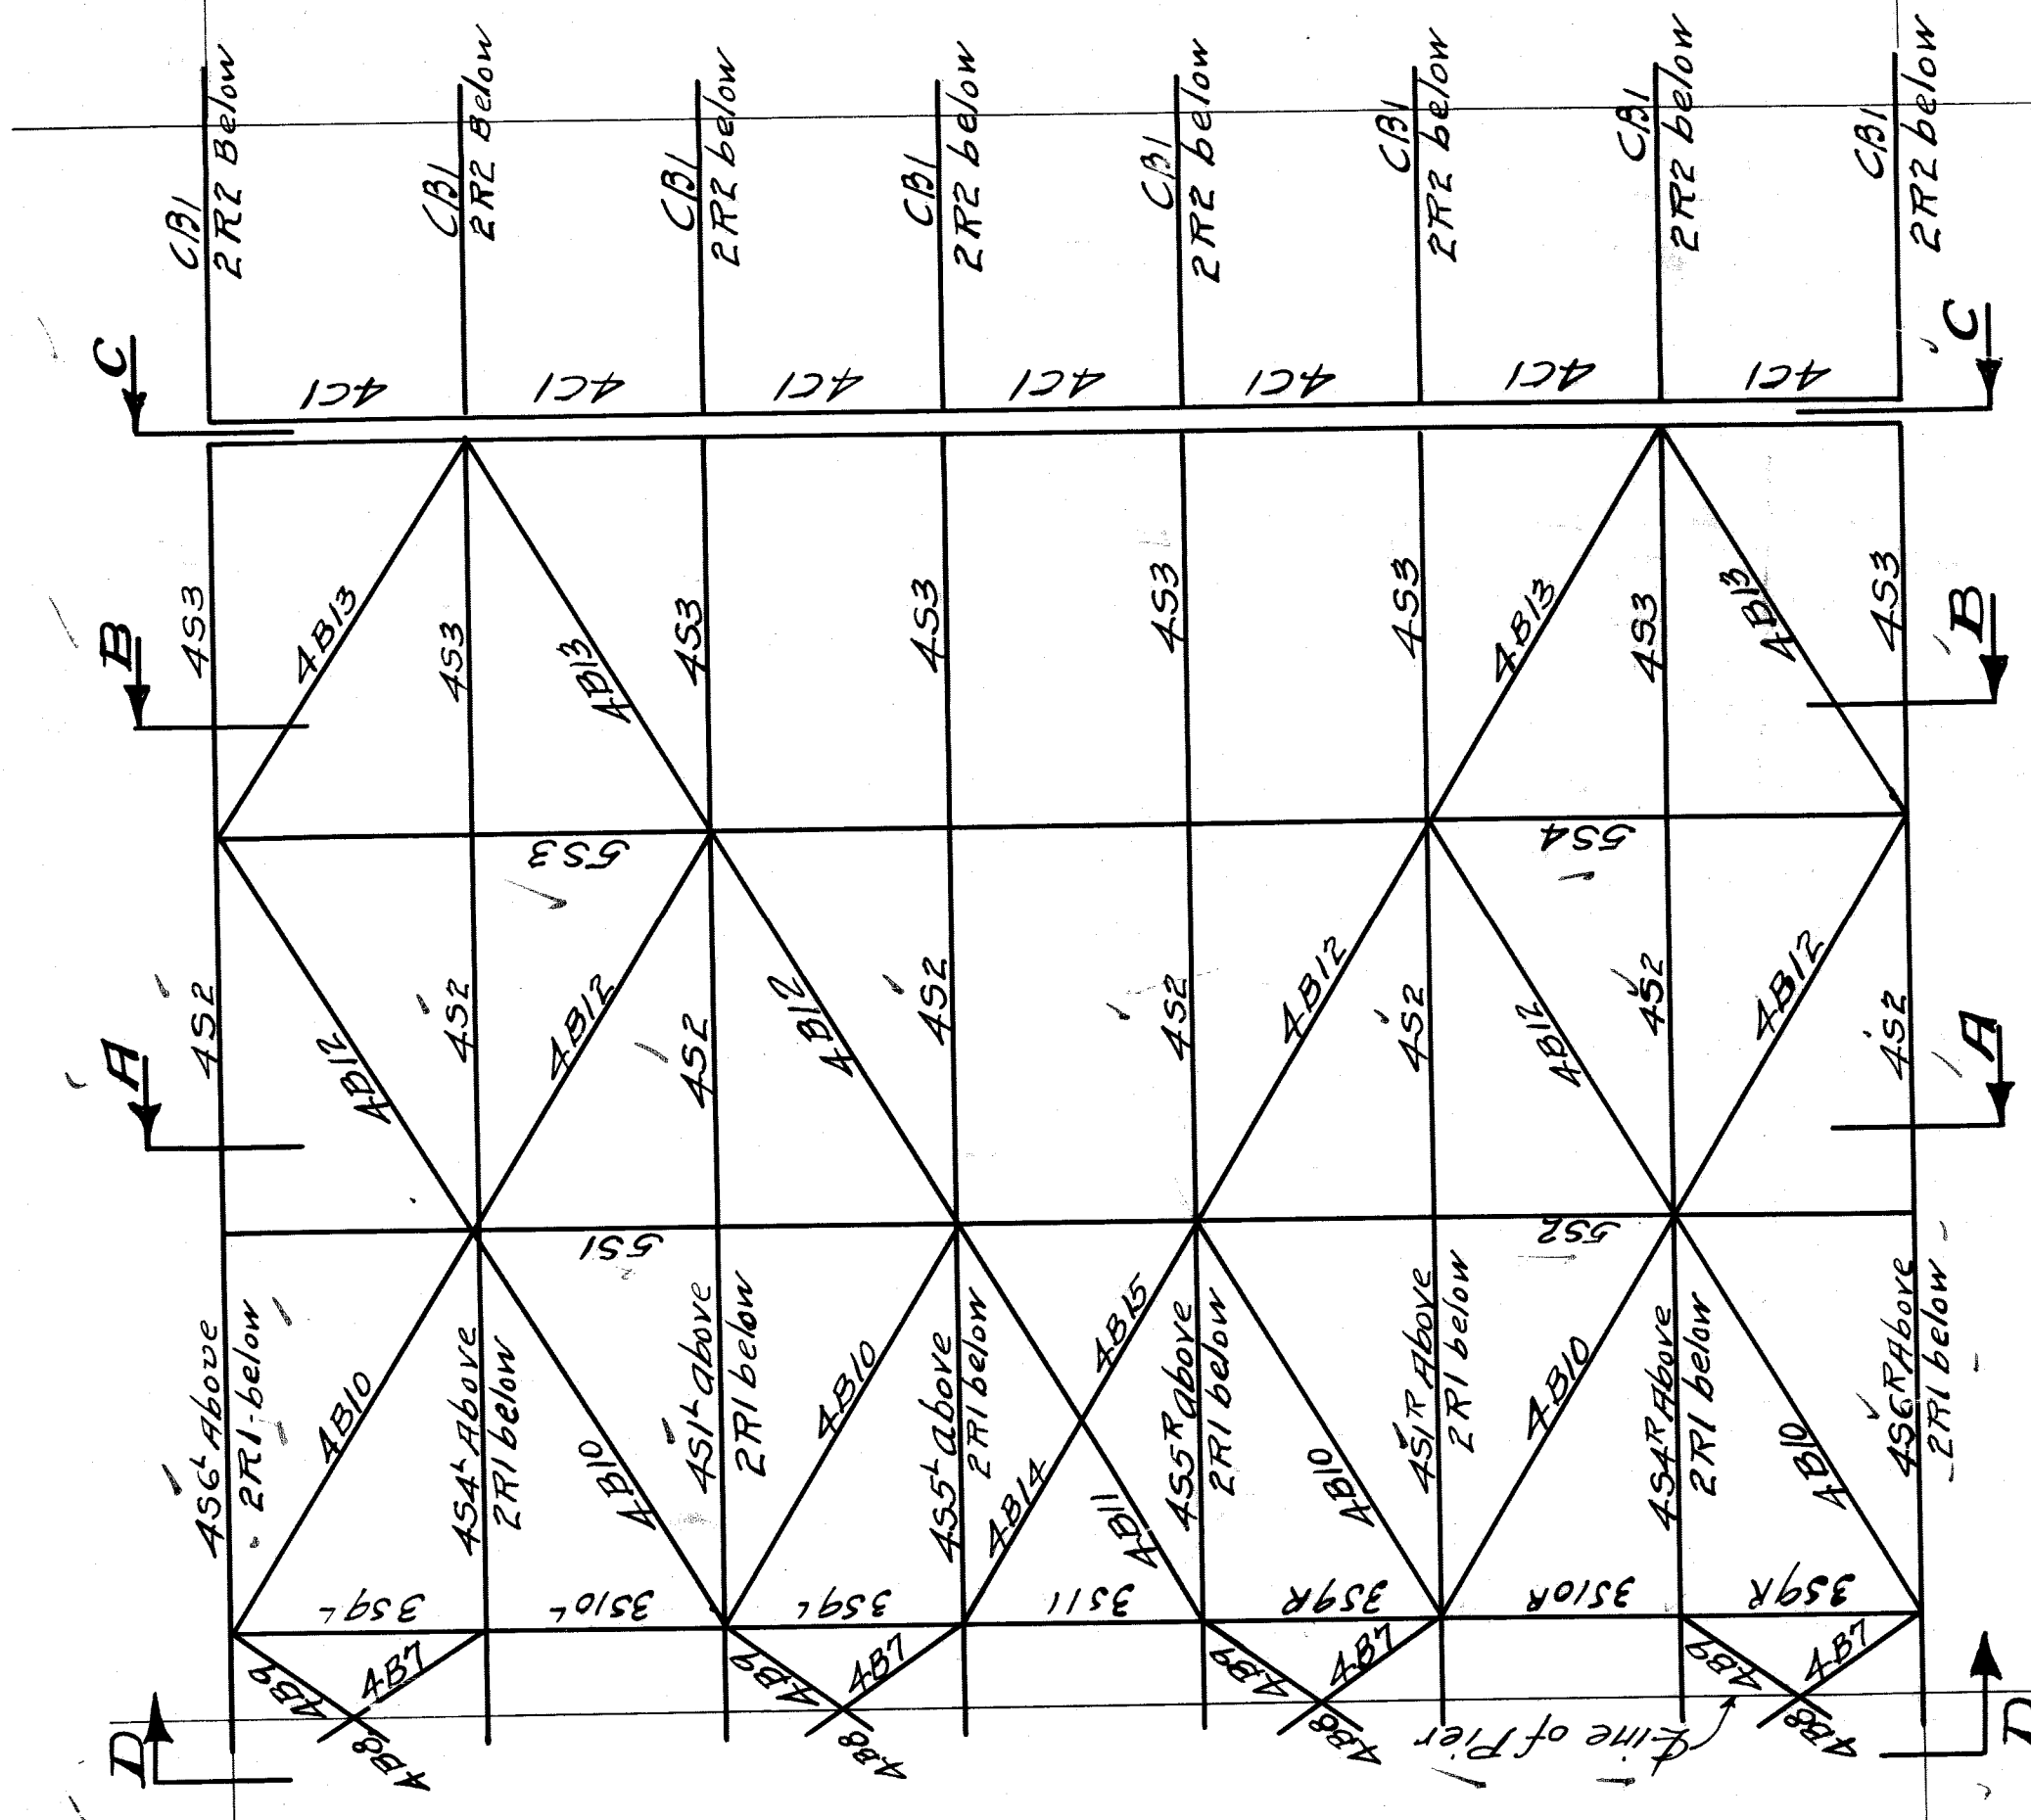

Erect for Note 1:
All points enclosed thus \bigcirc are to be riveted. All other points bolted.

WISCONSIN BRIDGE & IRON CO.
NORTH MILWAUKEE, WISCONSIN



CONTRACT NO. 9377
ERECTED BY
FOR City of Detroit
LOCATION Detroit, Mich.
DESCRIPTION Belle Isle Bridge
DETAILS OF Erect Plan (Piers 5-6-7-8)
SPECIFICATIONS 5565 by Murphy & Reming.
INSPECTION BY
SHOP PAINT
FIELD PAINT

EXCEPT AS NOTED
RIVETS
MADE BY W.H.F.
TRACED BY E.F.M.
CHECKED BY M.
DATE 7-5-21
DATE 7-6-21
DATE

SCALE 1/2" = 1'-0"
SECTION
DATE REVISED
SHEET NO. E1

9377
NO. 1
NO. 2
NO. 3
NO. 4
NO. 5
NO. 6
NO. 7
NO. 8
NO. 9
NO. 10
NO. 11
NO. 12
NO. 13
NO. 14
NO. 15
NO. 16
NO. 17
NO. 18
NO. 19
NO. 20
NO. 21
NO. 22
NO. 23
NO. 24
NO. 25
NO. 26
NO. 27
NO. 28
NO. 29
NO. 30
NO. 31
NO. 32
NO. 33
NO. 34
NO. 35
NO. 36
NO. 37
NO. 38
NO. 39
NO. 40
NO. 41
NO. 42
NO. 43
NO. 44
NO. 45
NO. 46
NO. 47
NO. 48
NO. 49
NO. 50

File 8 W 201-176

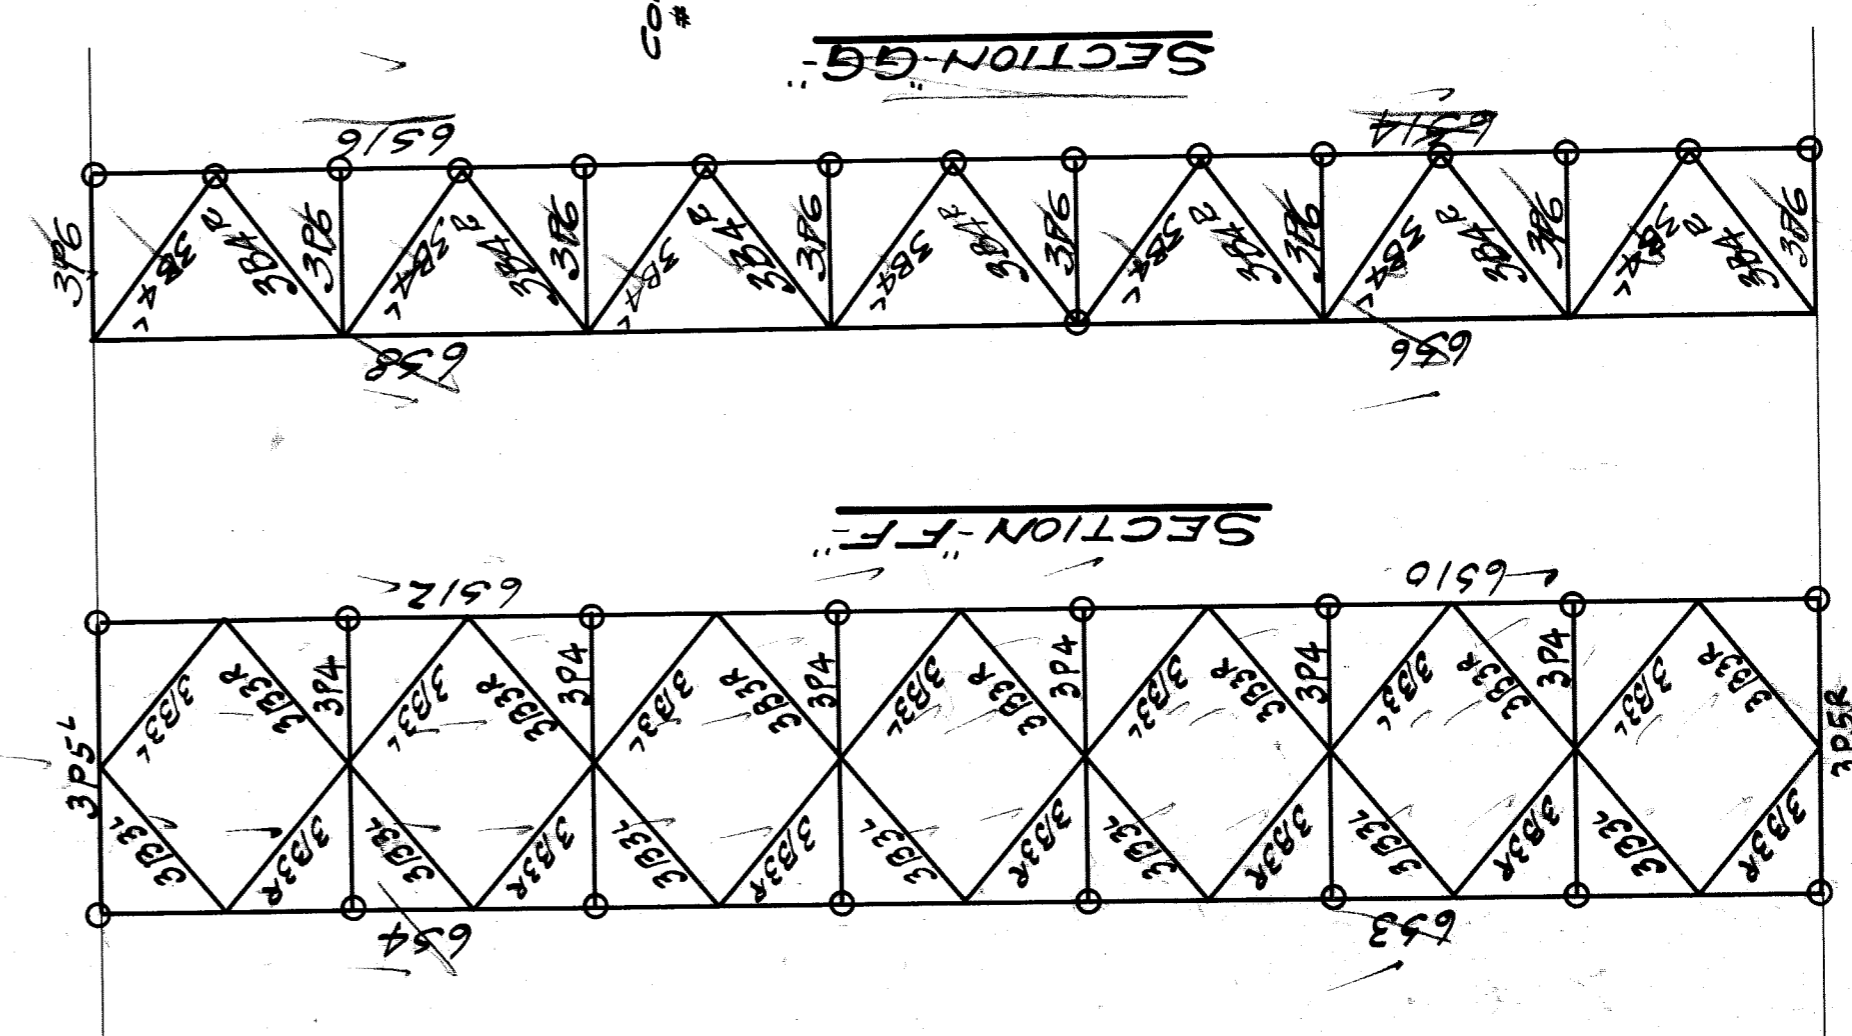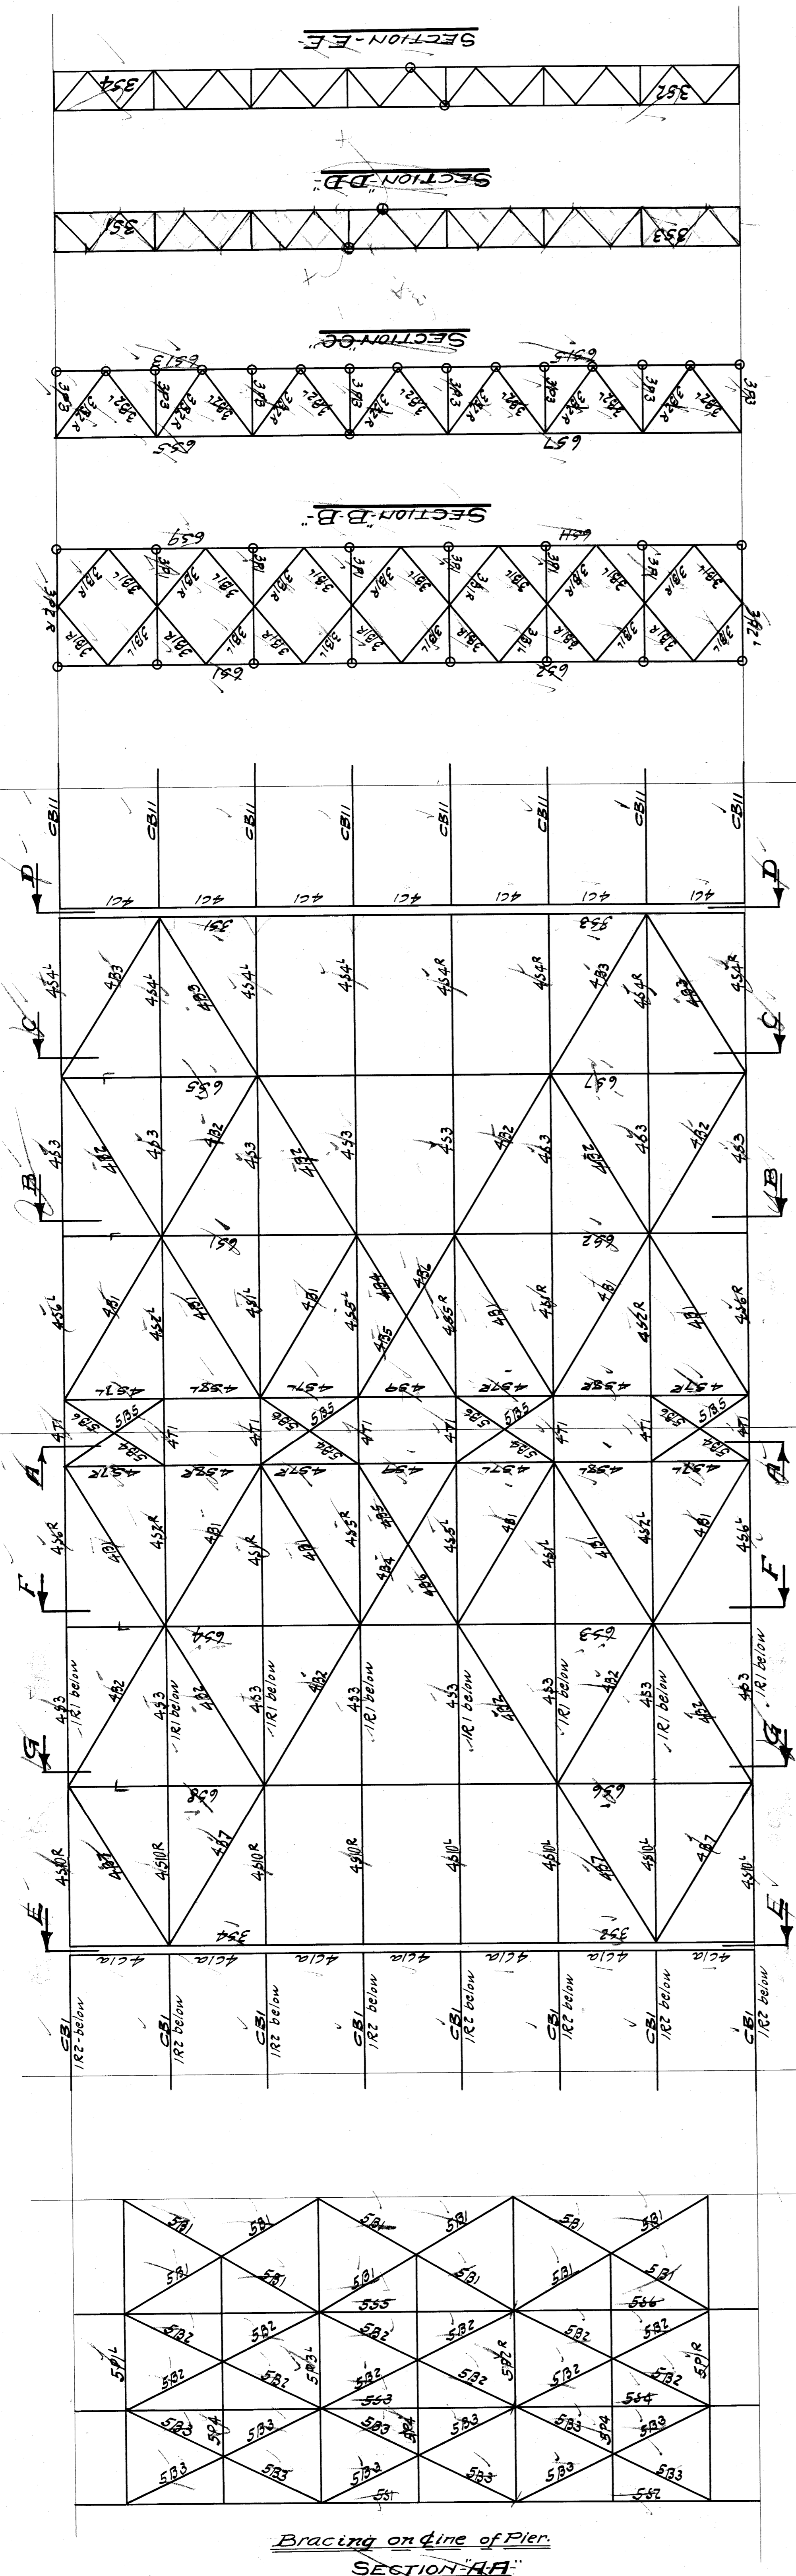

Note: -
All points encircled thus **O** to be riveted
All other points bolted

WISCONSIN BRIDGE & IRON CO.
NORTH MILWAUKEE, WISCONSIN


CONTRACT NO. 9378 ERCTED BY
FOR City of Detroit
LOCATION Detroit, Mich
DESCRIPTION Belle Isle Bridge
DETAILS OF ERECTION PLAN (Piers 4-9)
SPECIFICATIONS by Messrs. McAlpine
INSPECTION BY
SHOP PAINT
FIELD PAINT

RIVETS EXCEPT AS NOTED
MADE BY W.H.P.
TRACED BY E.H.P.M.
CHECKED BY W.H.P.
DATE 7-5-21
DATE 7-6-21
DATE 7-22-21

SHEET NO. **51**
NO. 2
NO. 10
9378

Piers 4-9
Pier #9 shown
Form L-AI - Detailed on Bill #205 - Contr. 9377

FIELD CHECKED 5-20-22 O.R.B. File B/W 201-184

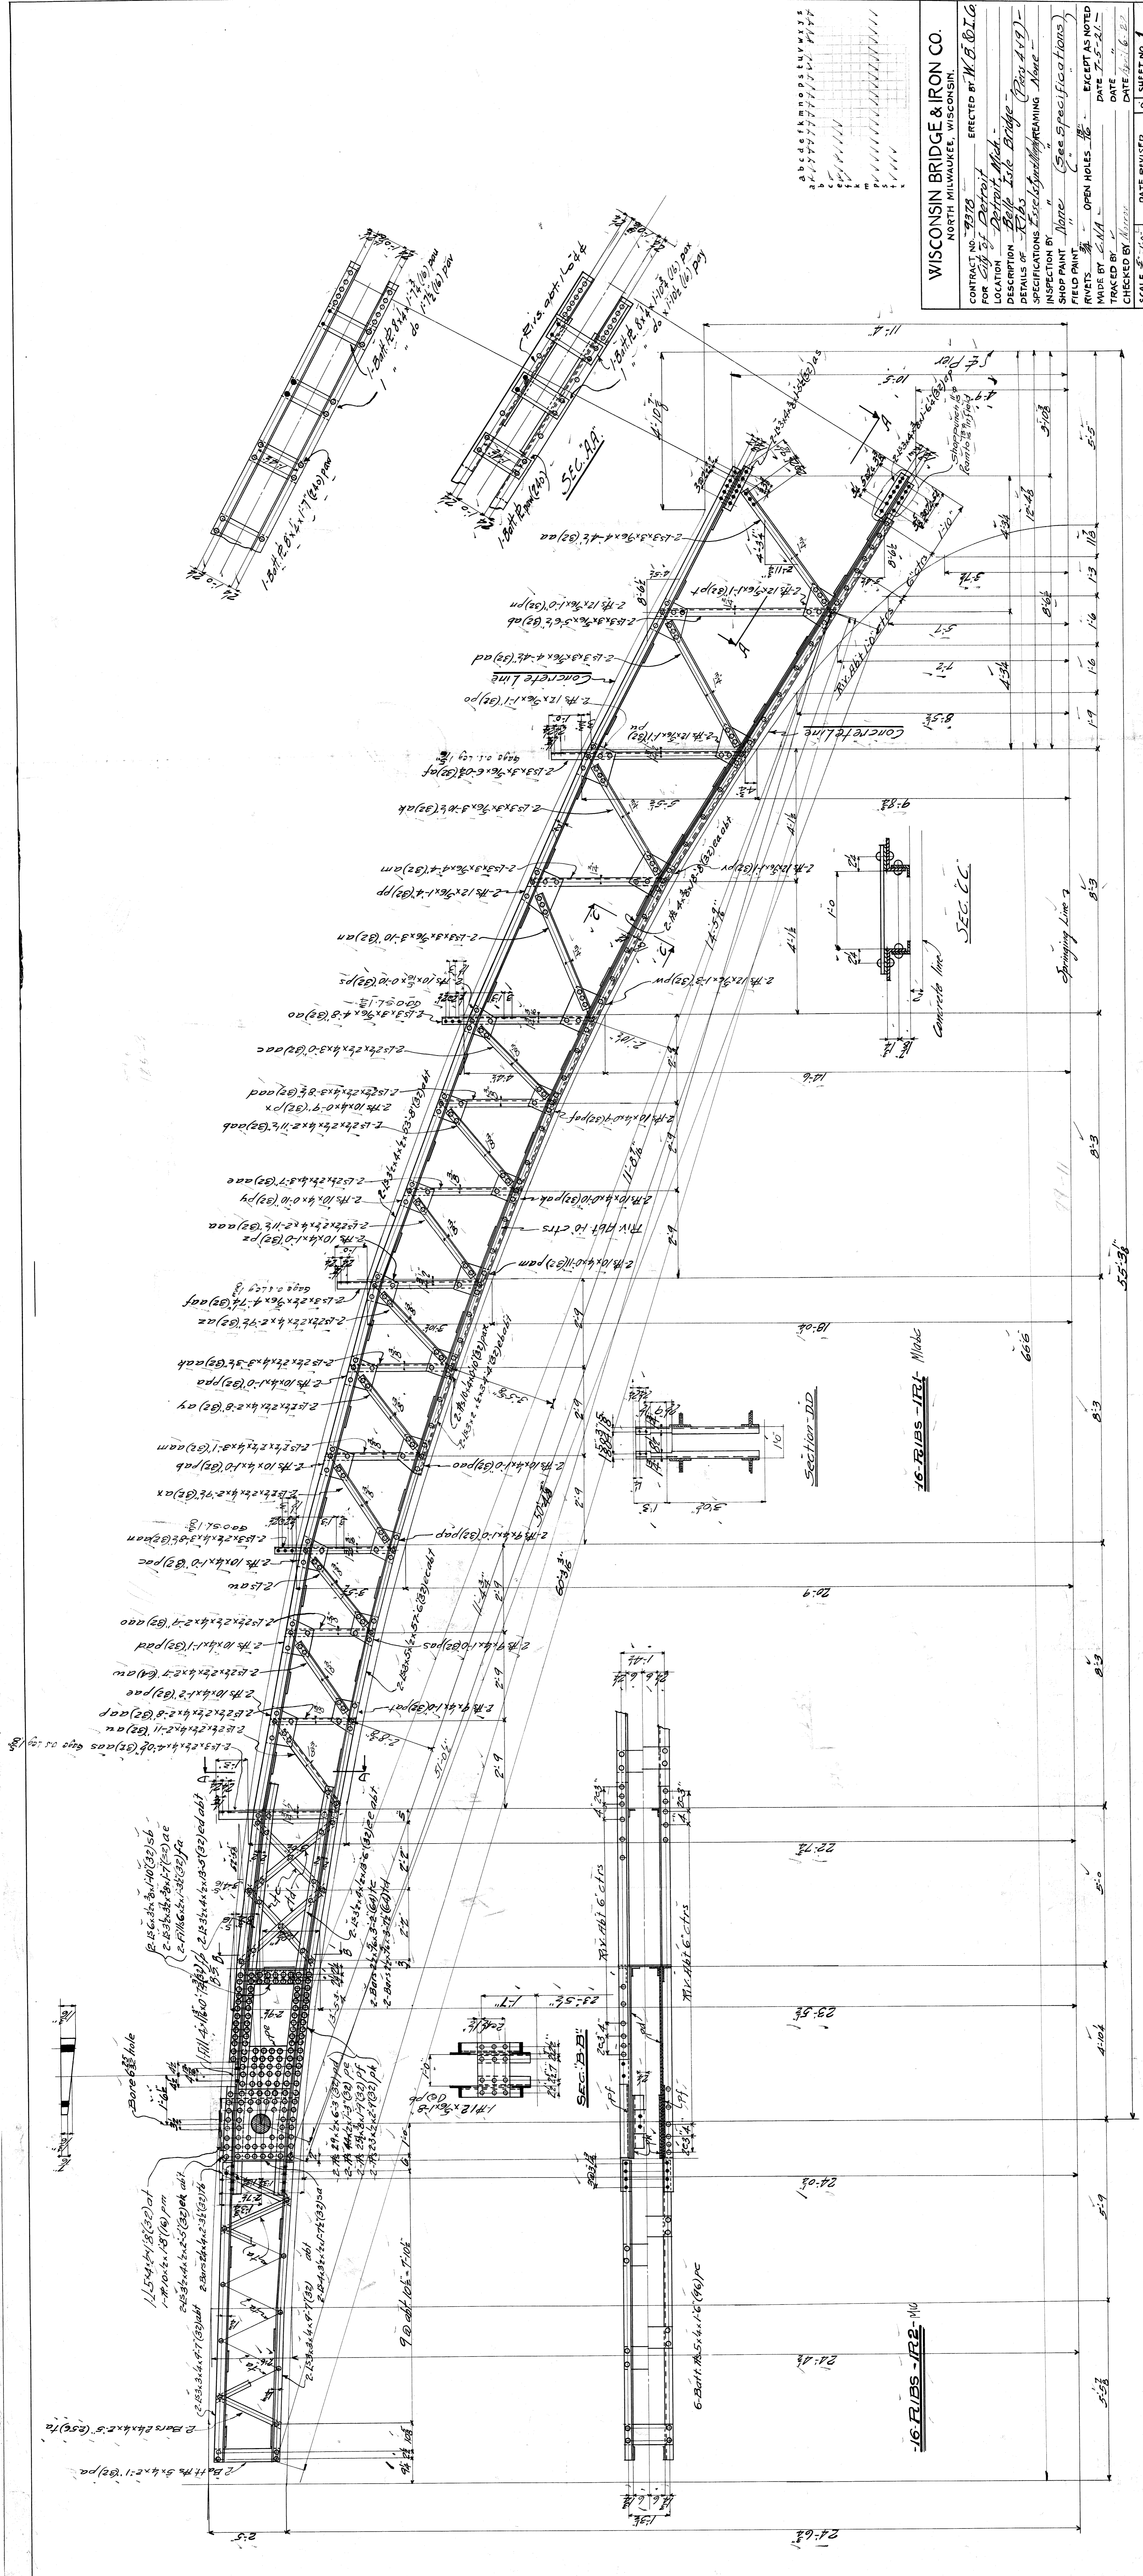

WISCONSIN BRIDGE & IRON CO.
 NORTH MILWAUKEE, WISCONSIN.

CONTRACT NO. 9378
 ERECTED BY **W.B. O.L.G.**

FOR City of Detroit
 LOCATION Detroit Mich.
 DESCRIPTION Belle Isle Bridge (R.R. 419)
 DETAILS OF Ribs See Framing Above
 INSPECTION BY None (See Specifications)
 SHOP PAINT None
 FIELD PAINT None
 MADE BY C.N.A. EXCEPT AS NOTED
 RIVETS NONE
 DATE 7-5-21
 TRACED BY None
 DATE 6-1-22
 CHECKED BY None
 DATE 6-1-22

SECTION	SCALE	DATE	REVISER	NO.
	1/8" = 1'-0"	7-5-21		

SEC. CC

SEC. DD

SEC. AA

SEC. BB

SEC. CC

SEC. DD

SEC. EE

SEC. FF

SEC. GG

SEC. HH

SEC. II

SEC. JJ

SEC. KK

SEC. LL

SEC. MM

SEC. NN

SEC. OO

SEC. PP

SEC. QQ

SEC. RR

SEC. SS

SEC. TT

SEC. UU

SEC. VV


SEC. WW

SEC. XX

SEC. YY

SEC. ZZ

SEC. AA

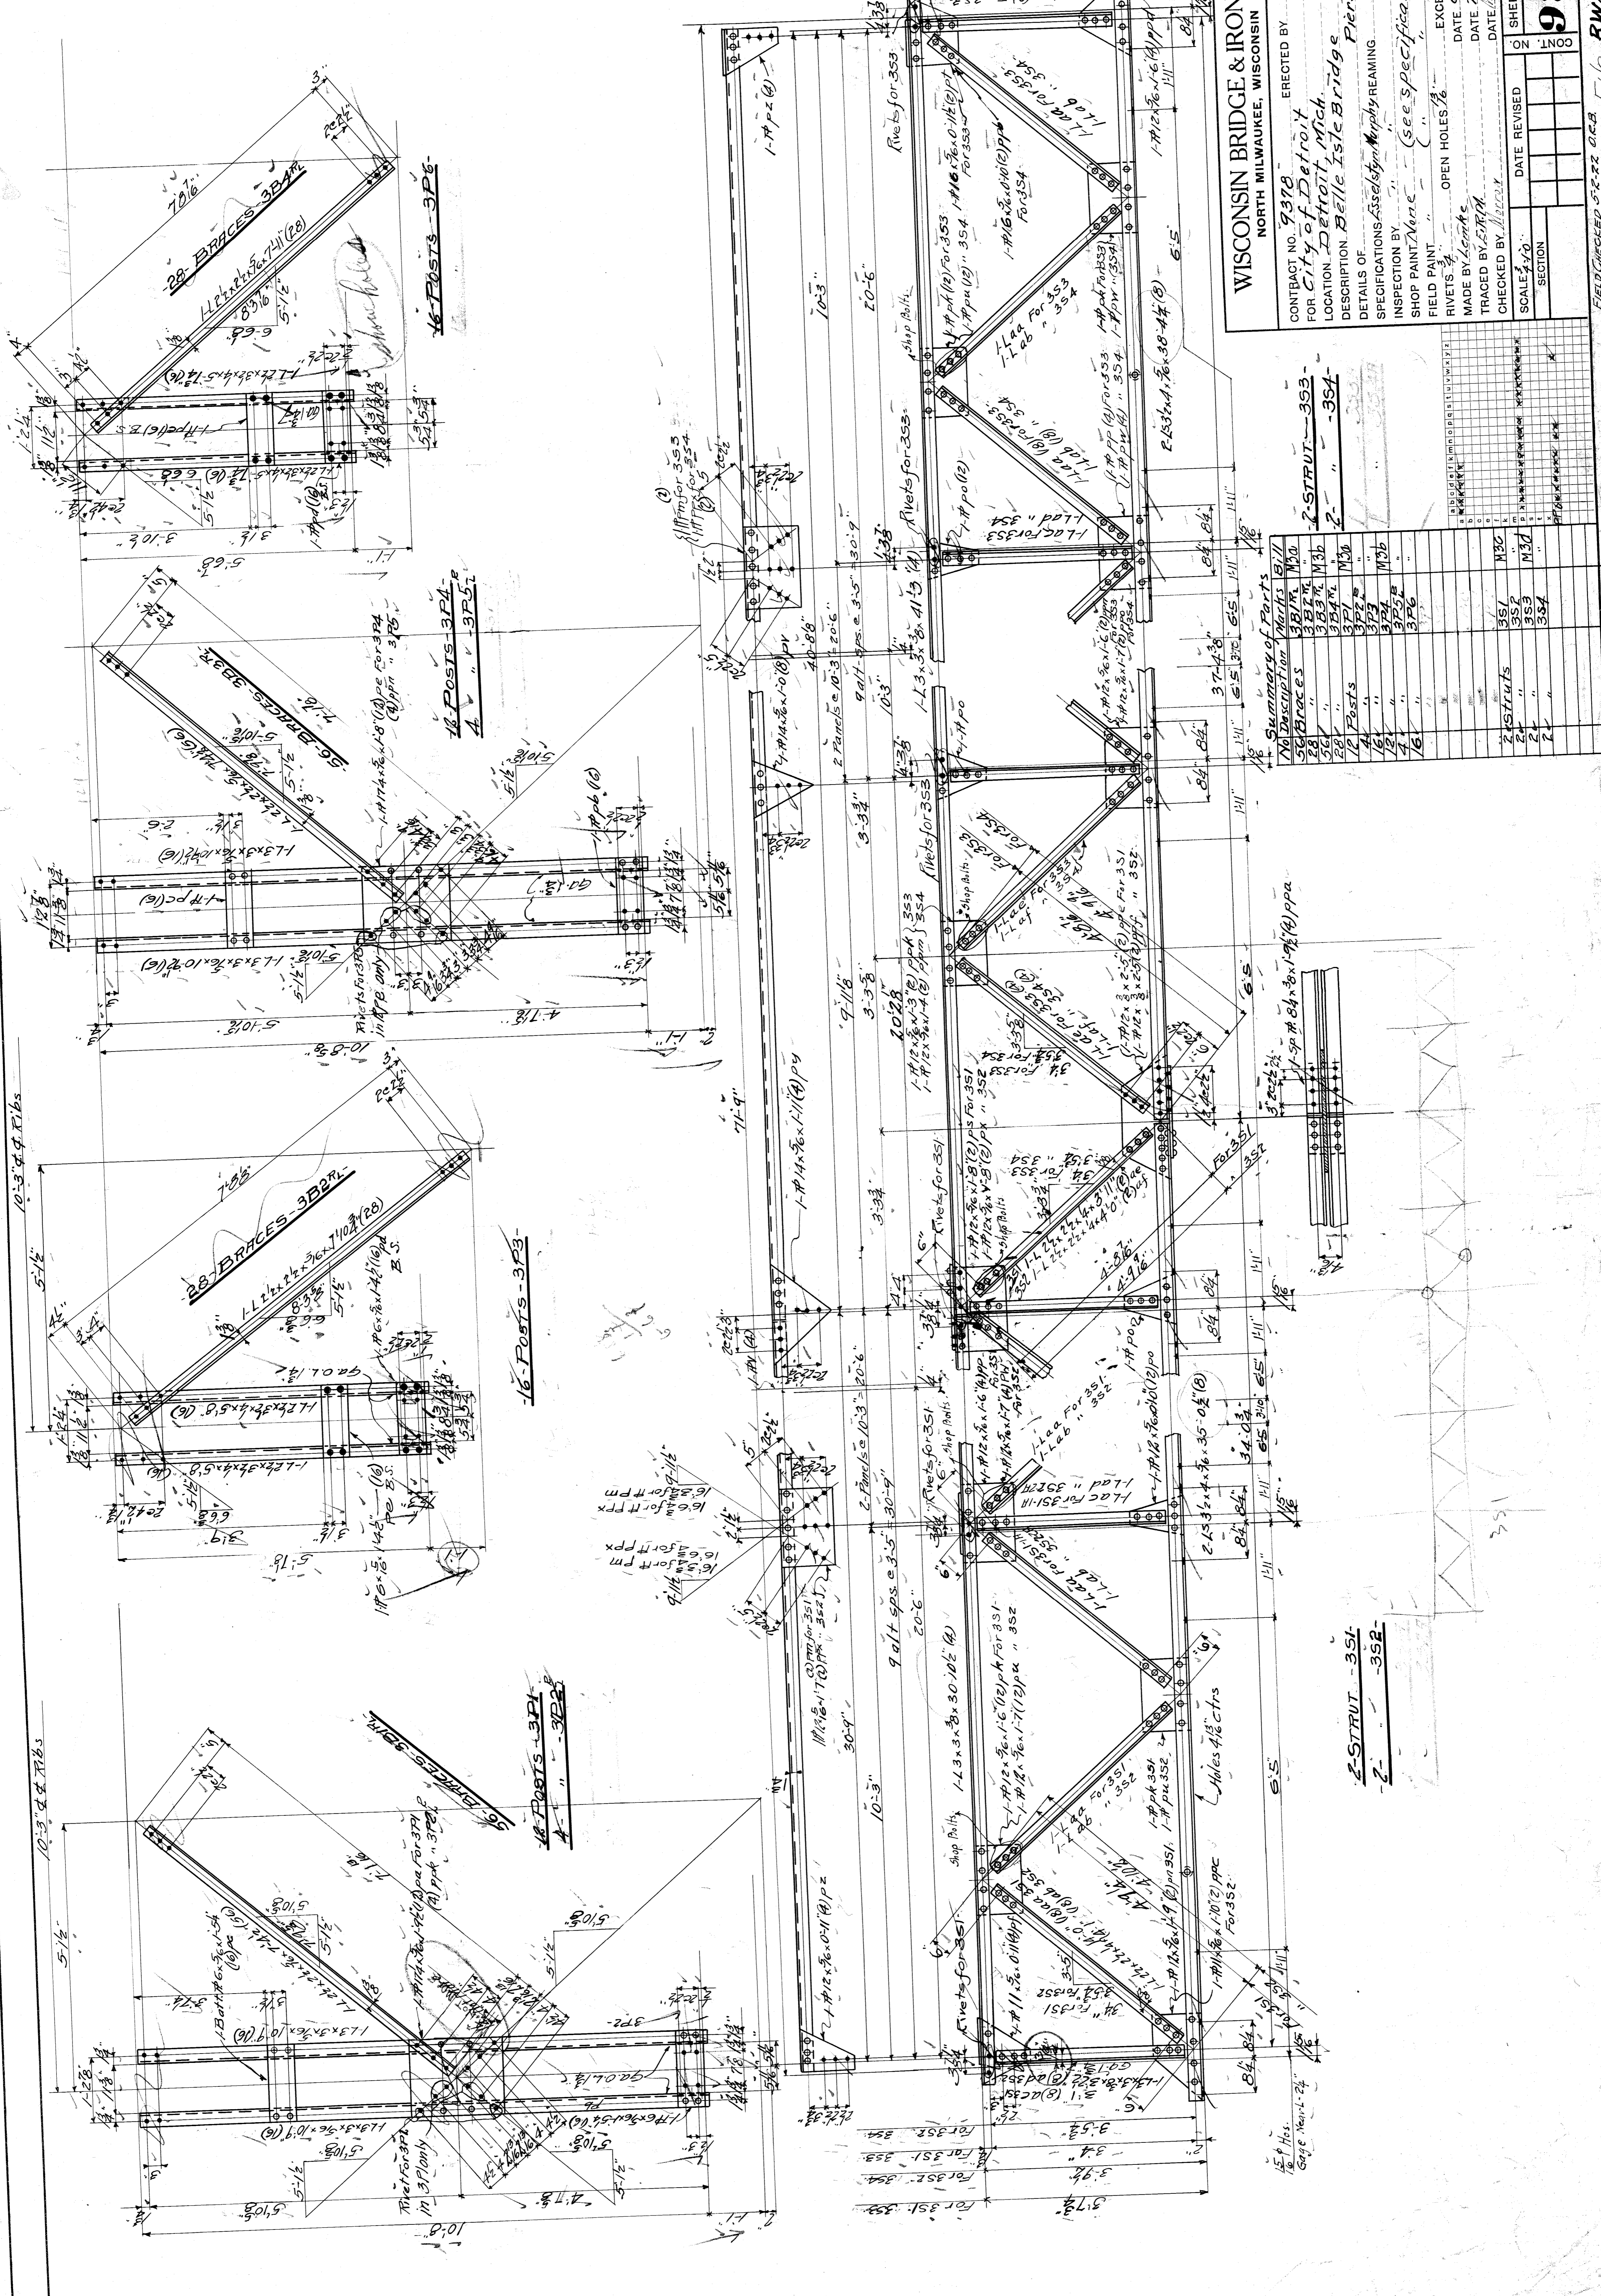

WISCONSIN BRIDGE & IRON CO.
 NORTH MILWAUKEE, WISCONSIN

ERECTED BY
City of Detroit
 LOCATION **Detroit Mich.**
 DESCRIPTION **Belle Isle Bridge Piers-4-7**

DETAILS OF
 SPECIFICATIONS **See Specification**
 INSPECTION BY
 SHOP PAINT NAME **(see Specification)**
 FIELD PAINT **OPEN HOLES**
 RIVETS **EXCEPT AS NOTED**
 MADE BY **Lucas** DATE **7-5-21**
 TRACED BY **L.M.A.** DATE **7-5-21**
 CHECKED BY **M.C.C.** DATE **7-5-21**


CONTRACT NO. **9378**
 SHEET NO. **3**
 OF **1100**

SCALE **1/2" = 1'-0"**

FIELD CHECKED **5-2-22 G.C.B.** FILE **BW201-167**

Summary of Parts

No.	Description	Mch	Bill
56	BRACES	3B2R	M30
28	"	3B3R	M30
28	"	3B4R	M30
16	POSTS	3P1	M30
16	"	3P2	M30
16	"	3P3	M30
16	"	3P4	M30
2	STRUTS	3S1	M30
2	"	3S2	M30
2	"	3S3	M30
2	"	3S4	M30

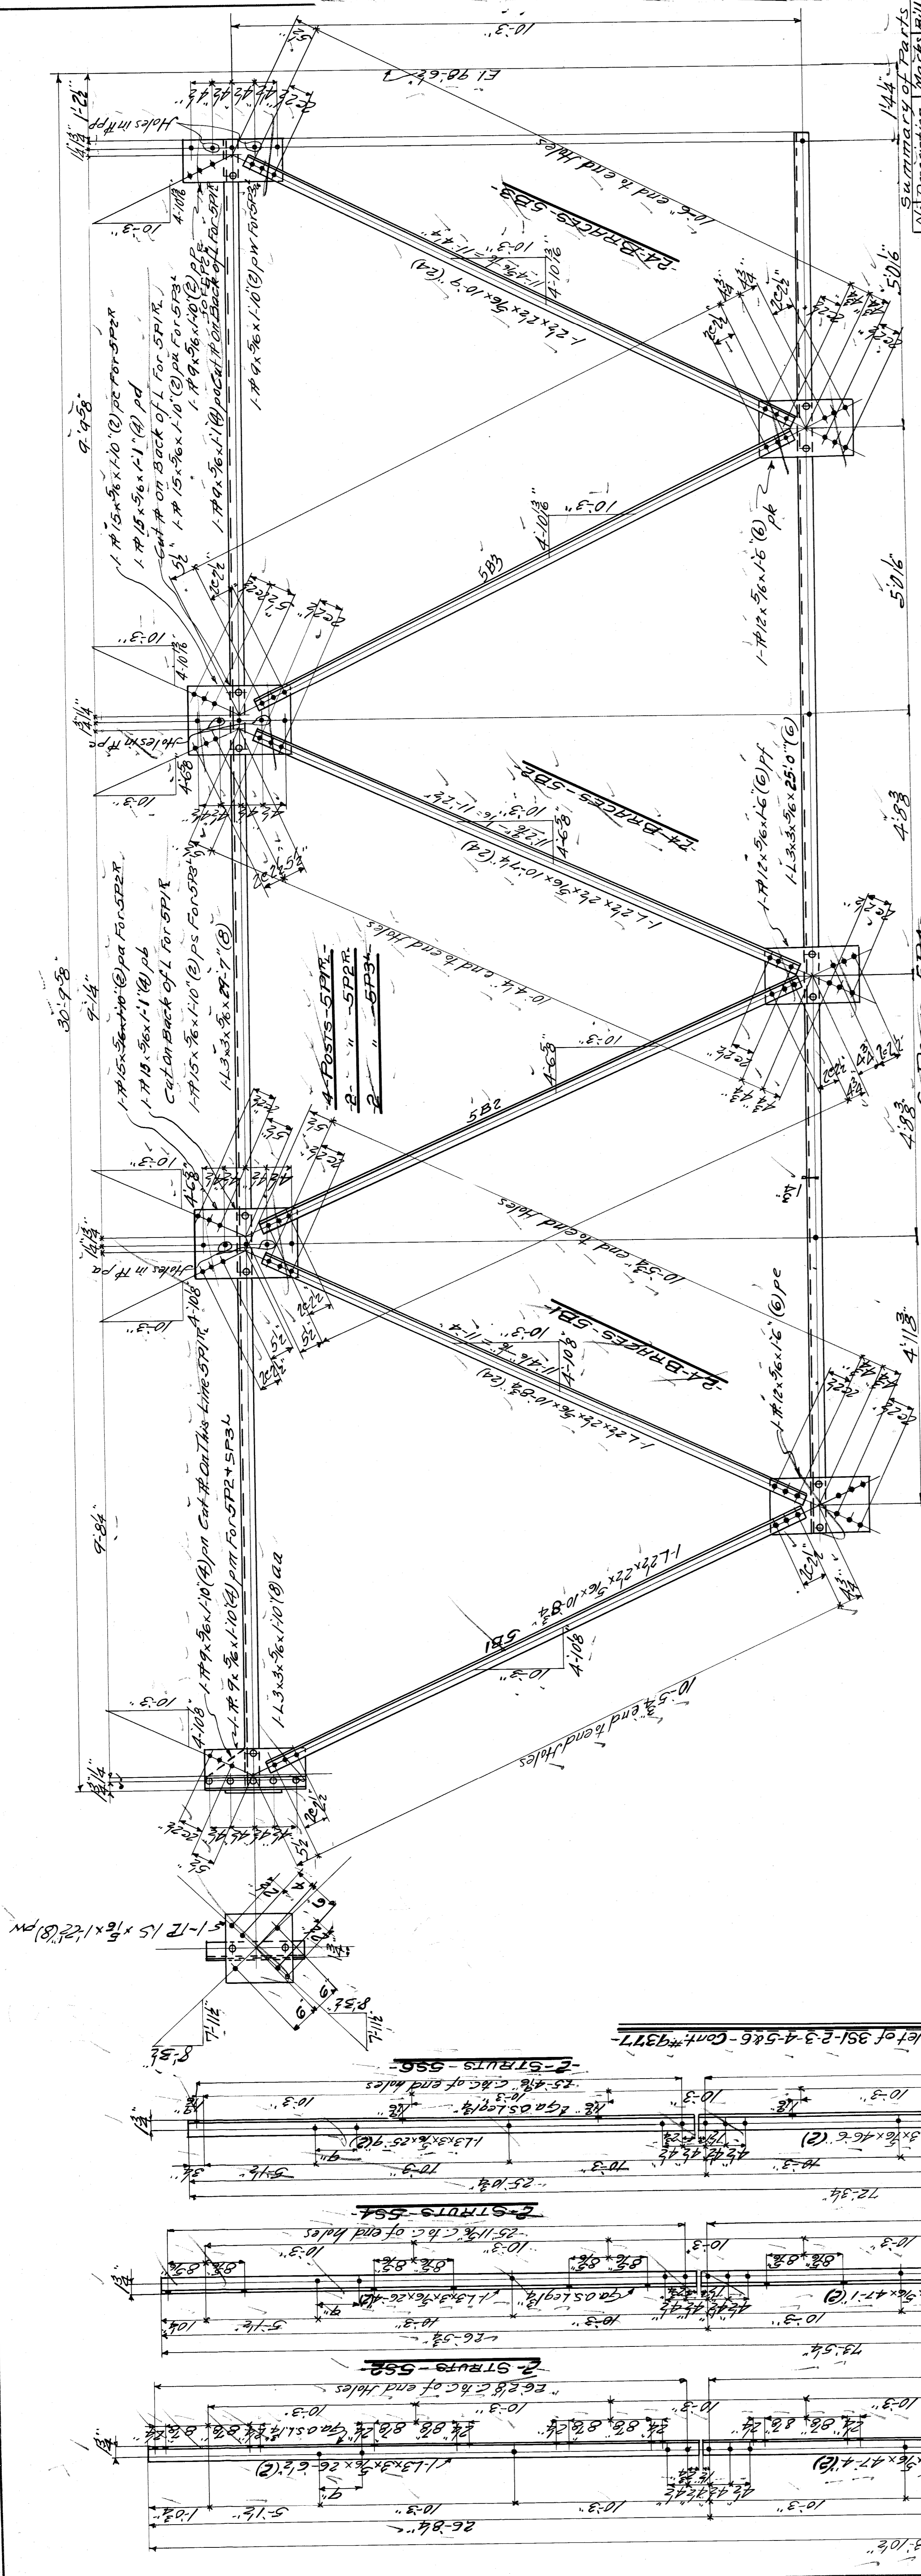

Summary of Parts Bill

No	Description	Material	Qty
1	4 Posts	SPR	4
2	"	SPR	2
3	"	SPR	2
4	2 Struts	SSI	2
5	"	SS2	2
6	"	SS3	2
7	"	SS4	2
8	"	SS5	2
9	"	SS6	2
10	24 BRACES	5B1	24
11	"	5B2	24
12	"	5B3	24
13	"	5B4	24
14	"	5B5	24
15	"	5B6	24
16	Anchor Plates	5A1	16

WISCONSIN BRIDGE & IRON CO.
 NORTH MILWAUKEE, WISCONSIN

ERECTED BY
 City of Detroit

LOCATION
 Belle Isle Bridge

DESCRIPTION
 Fiers 4-7




DETAILS OF
 SPECIFICATIONS
 INSPECTION BY
 SHOP PAINT NAME
 FIELD PAINT


EXCEPT AS NOTED
 DATE 6-26-21
 MADE BY
 TRACED BY
 CHECKED BY

SCALE 1/2" = 1'-0"

DATE REVISED

SHEET NO. 5

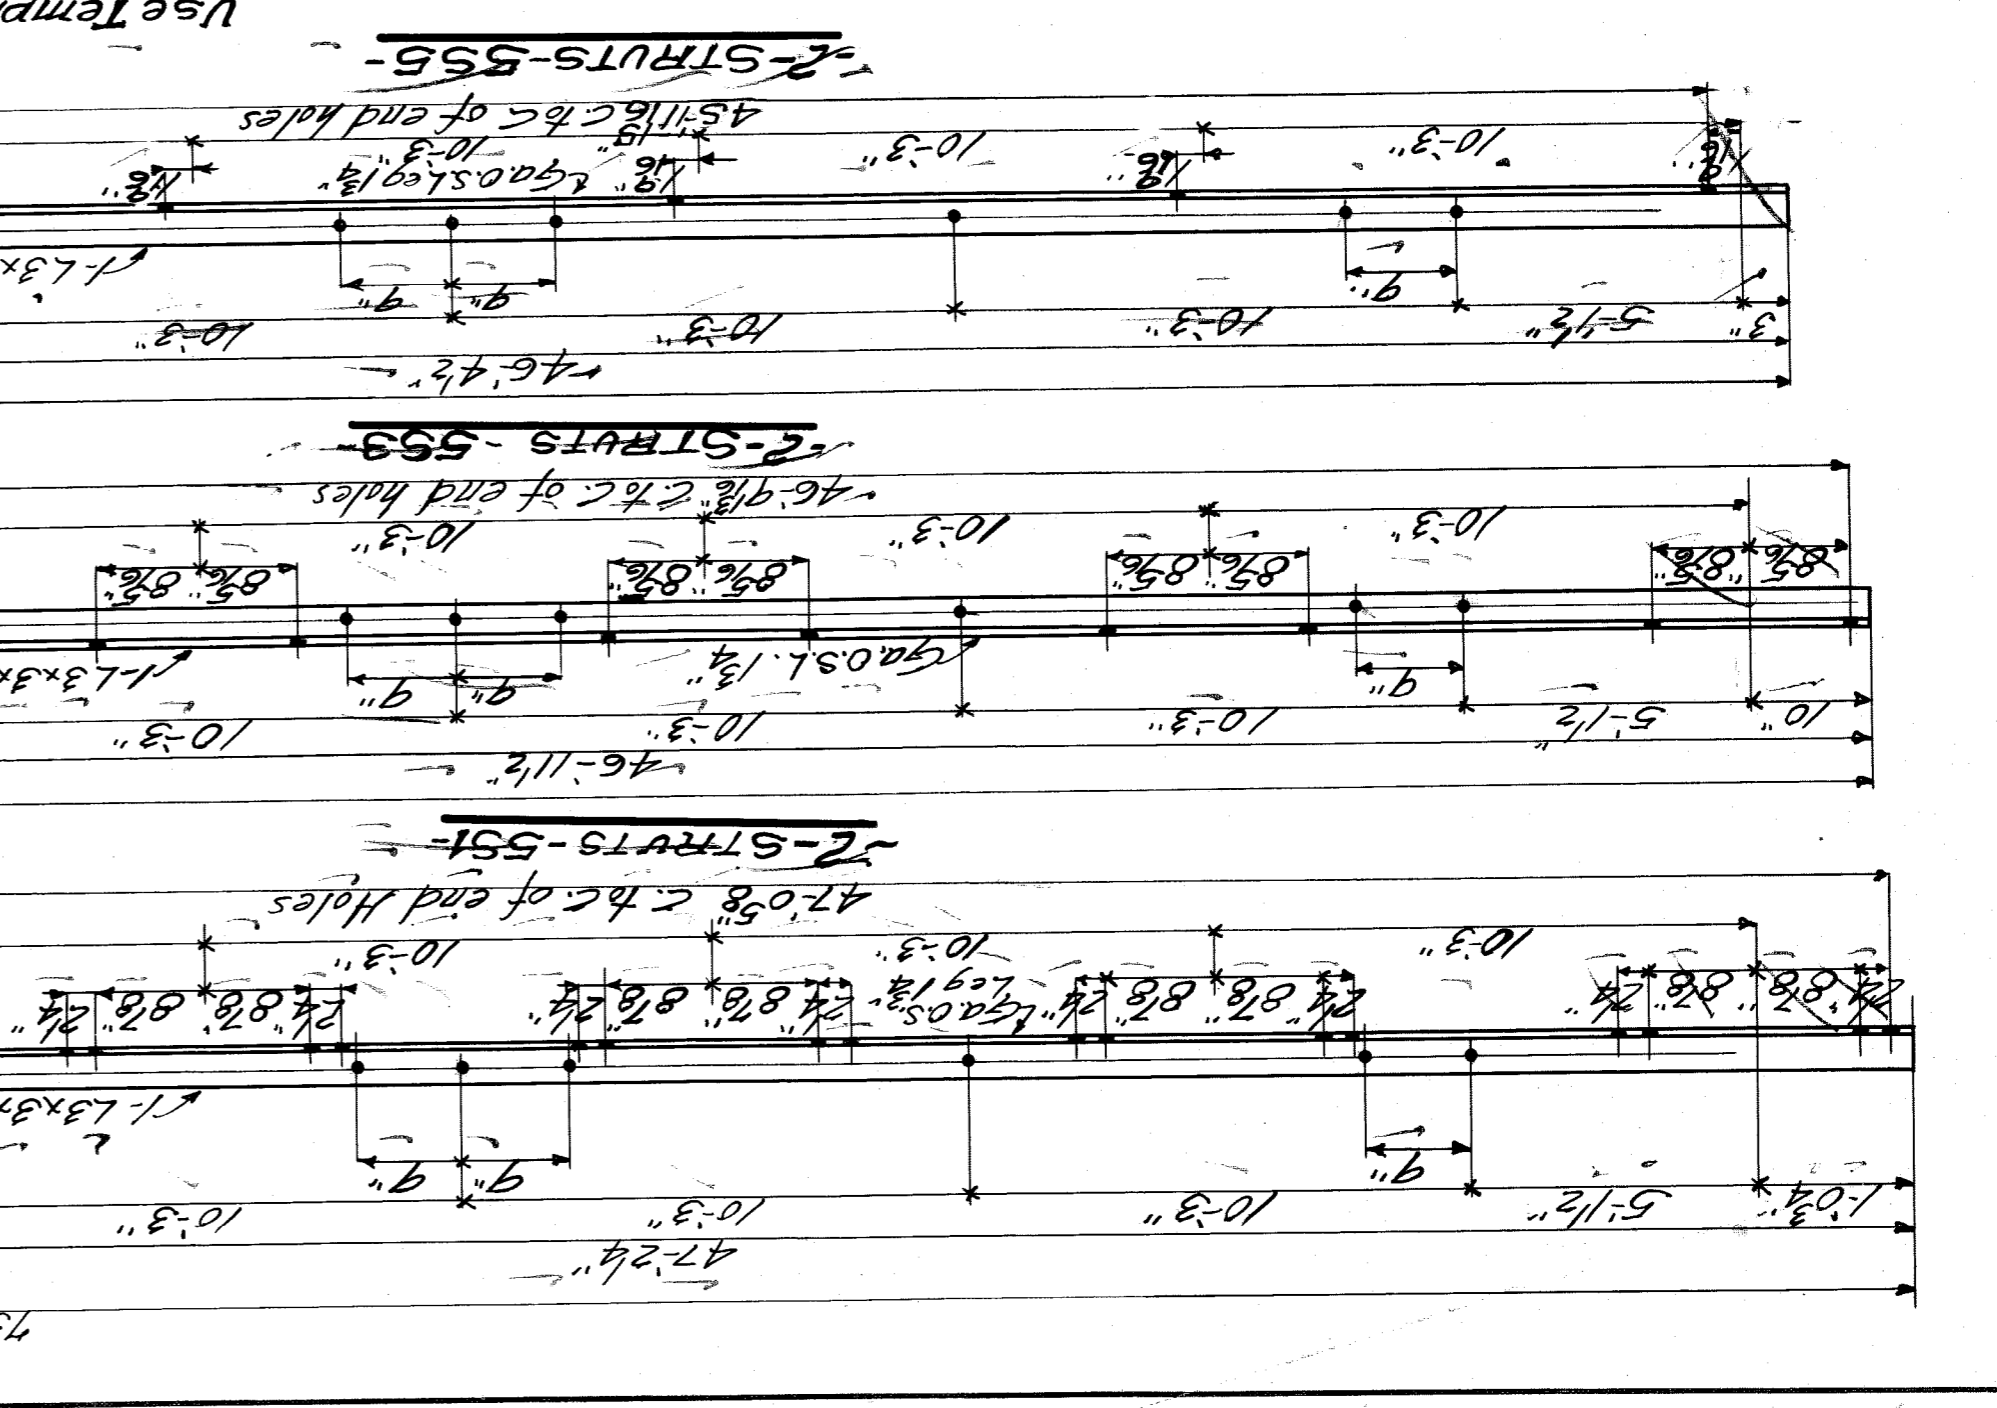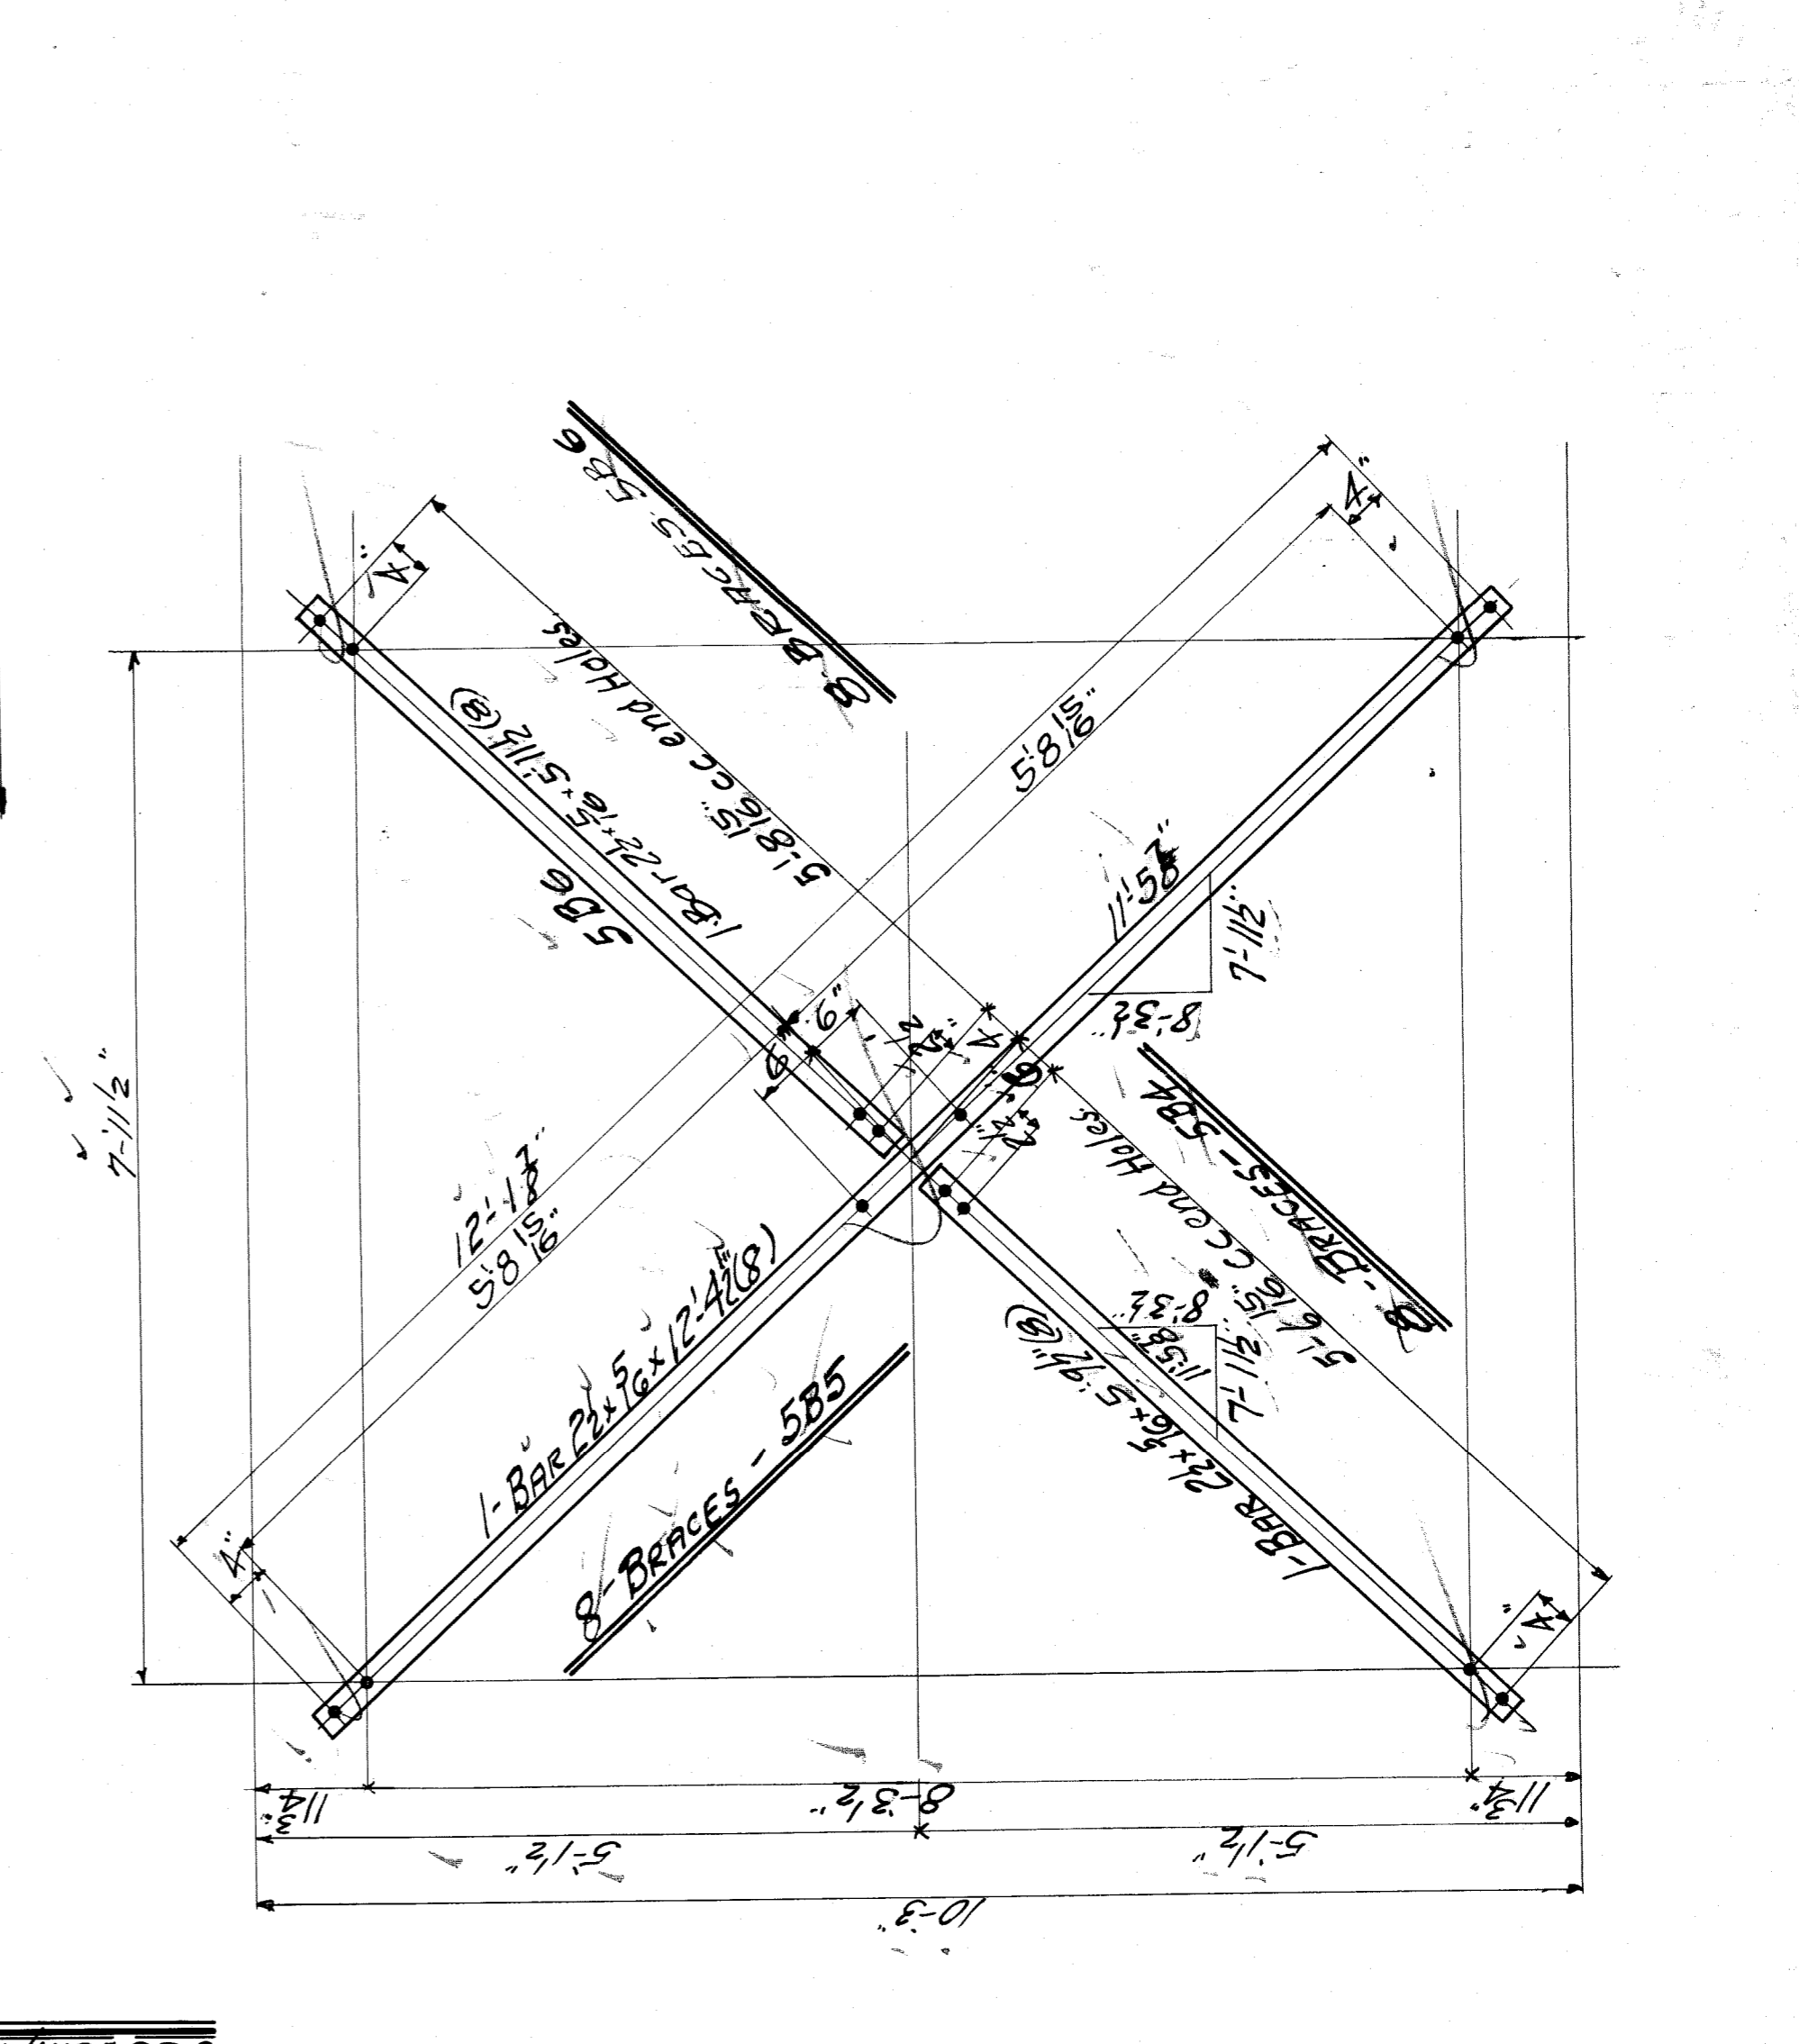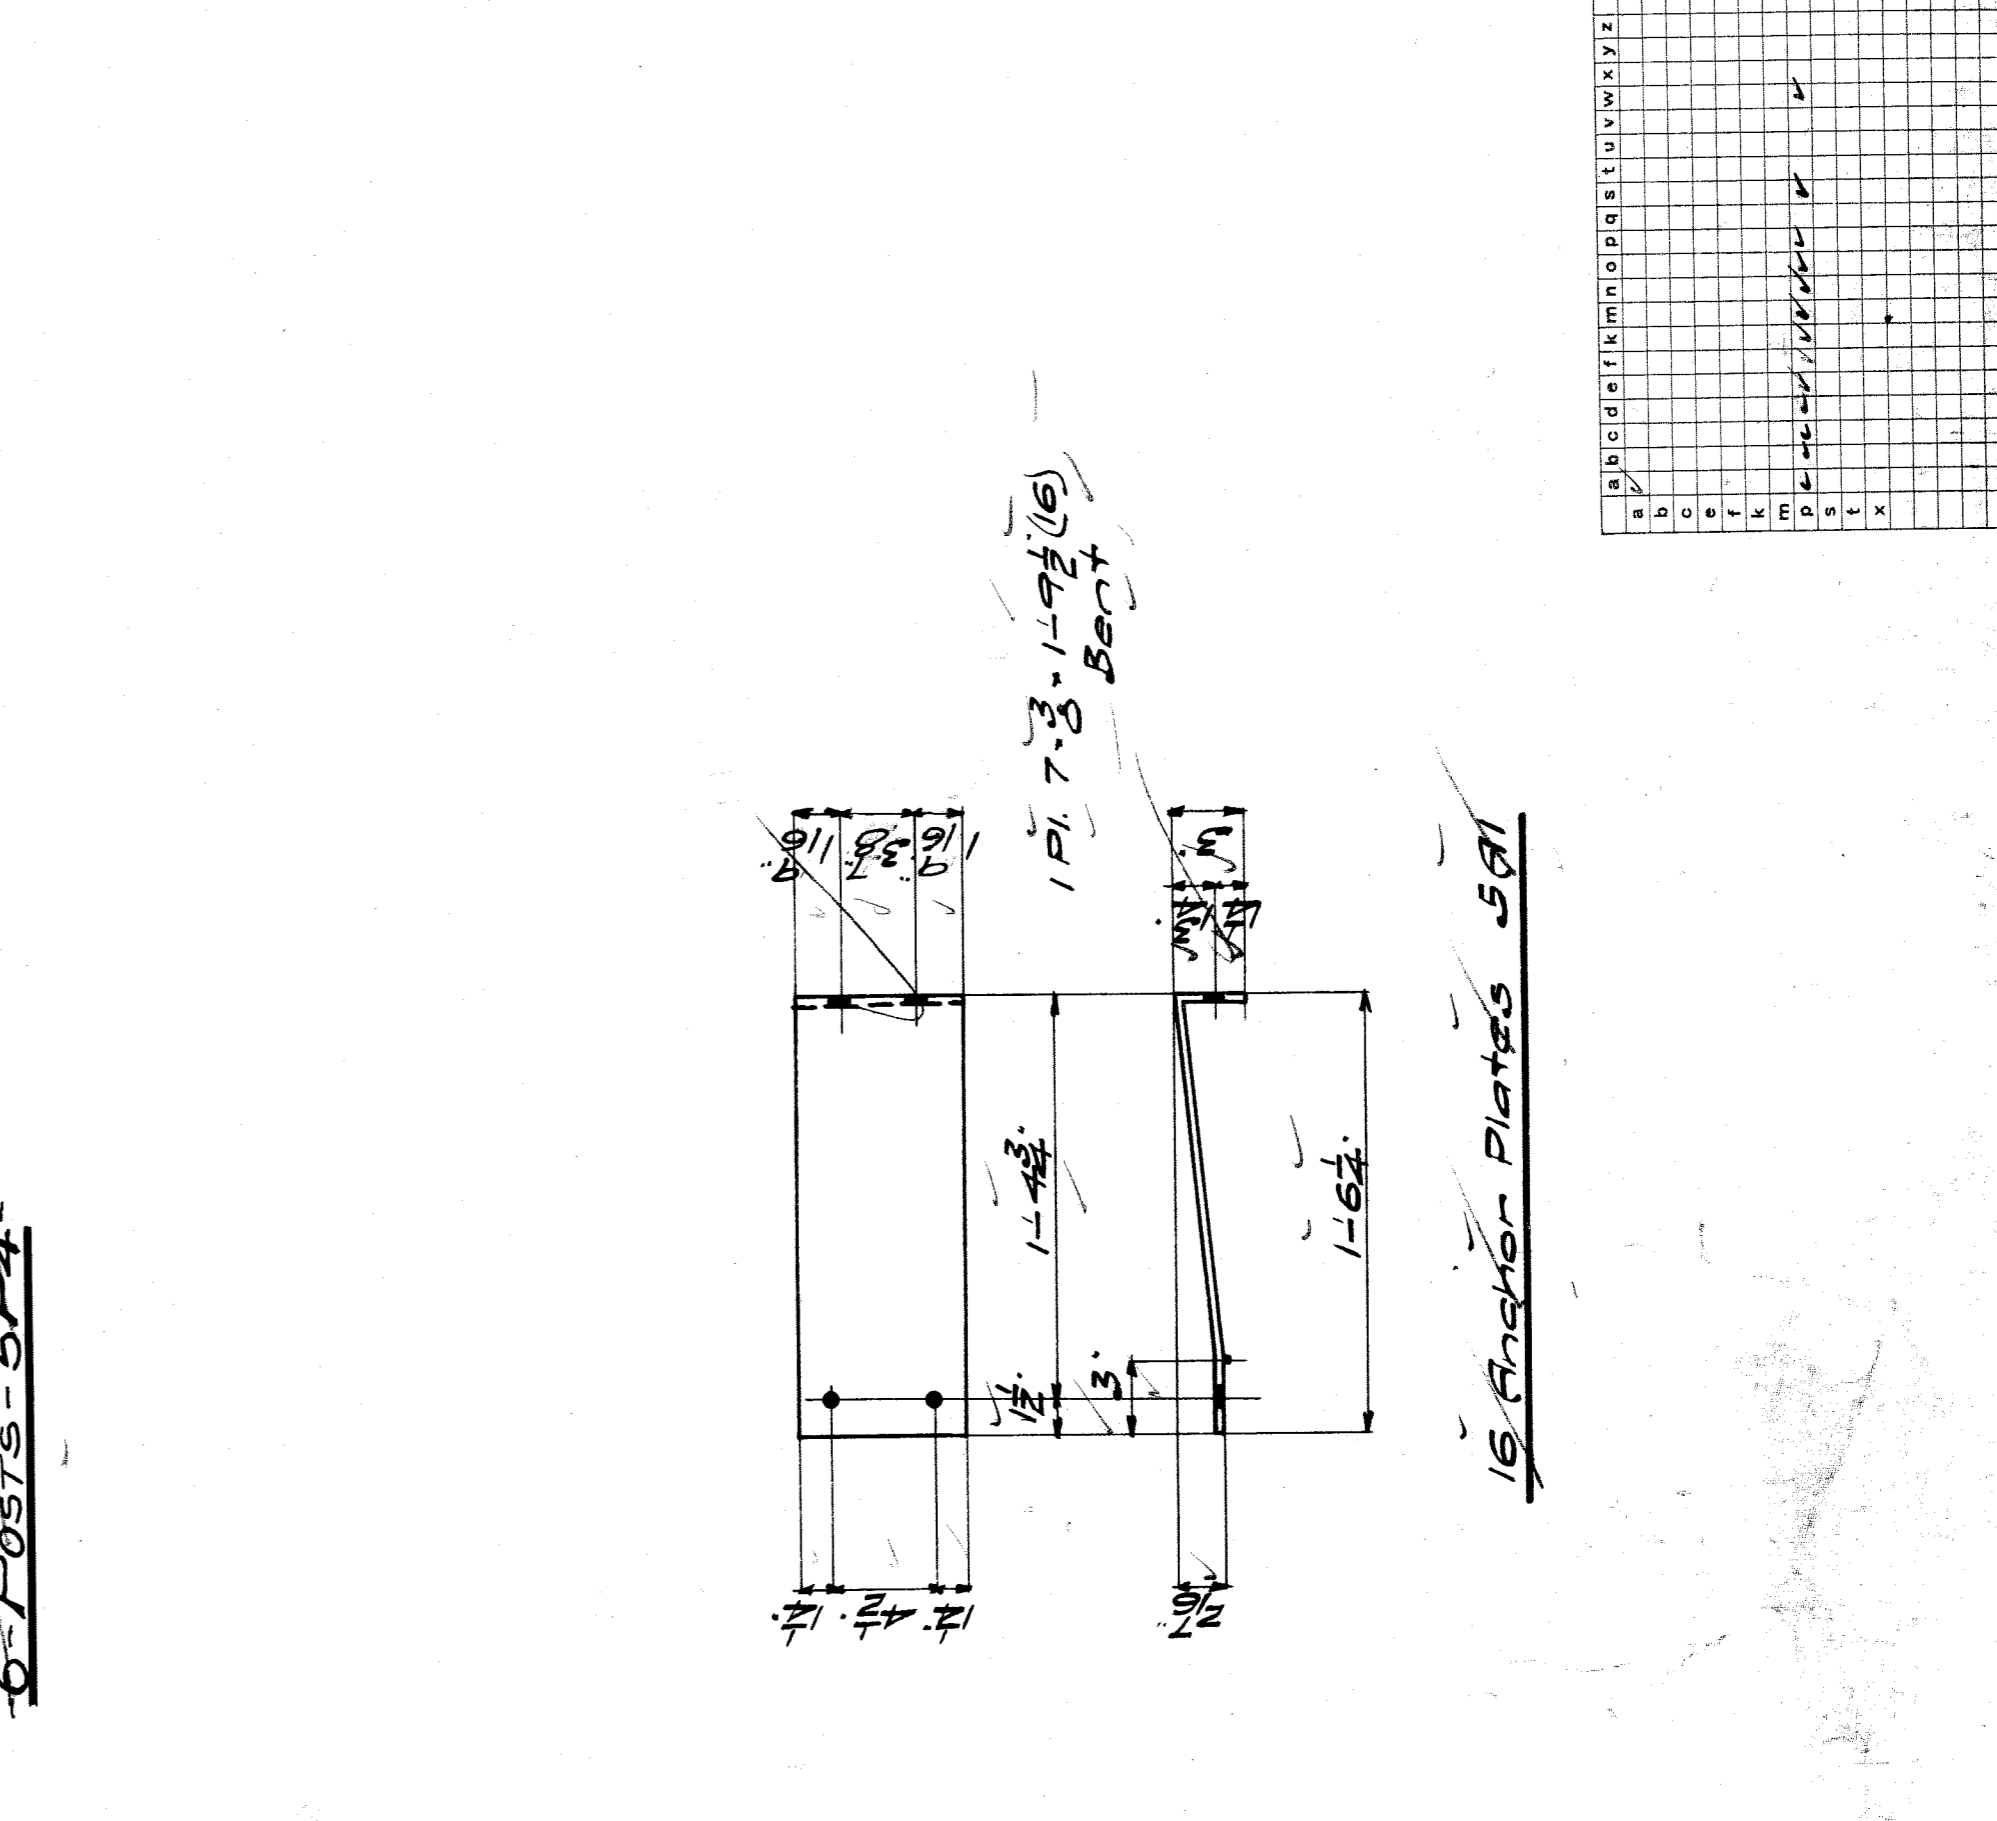

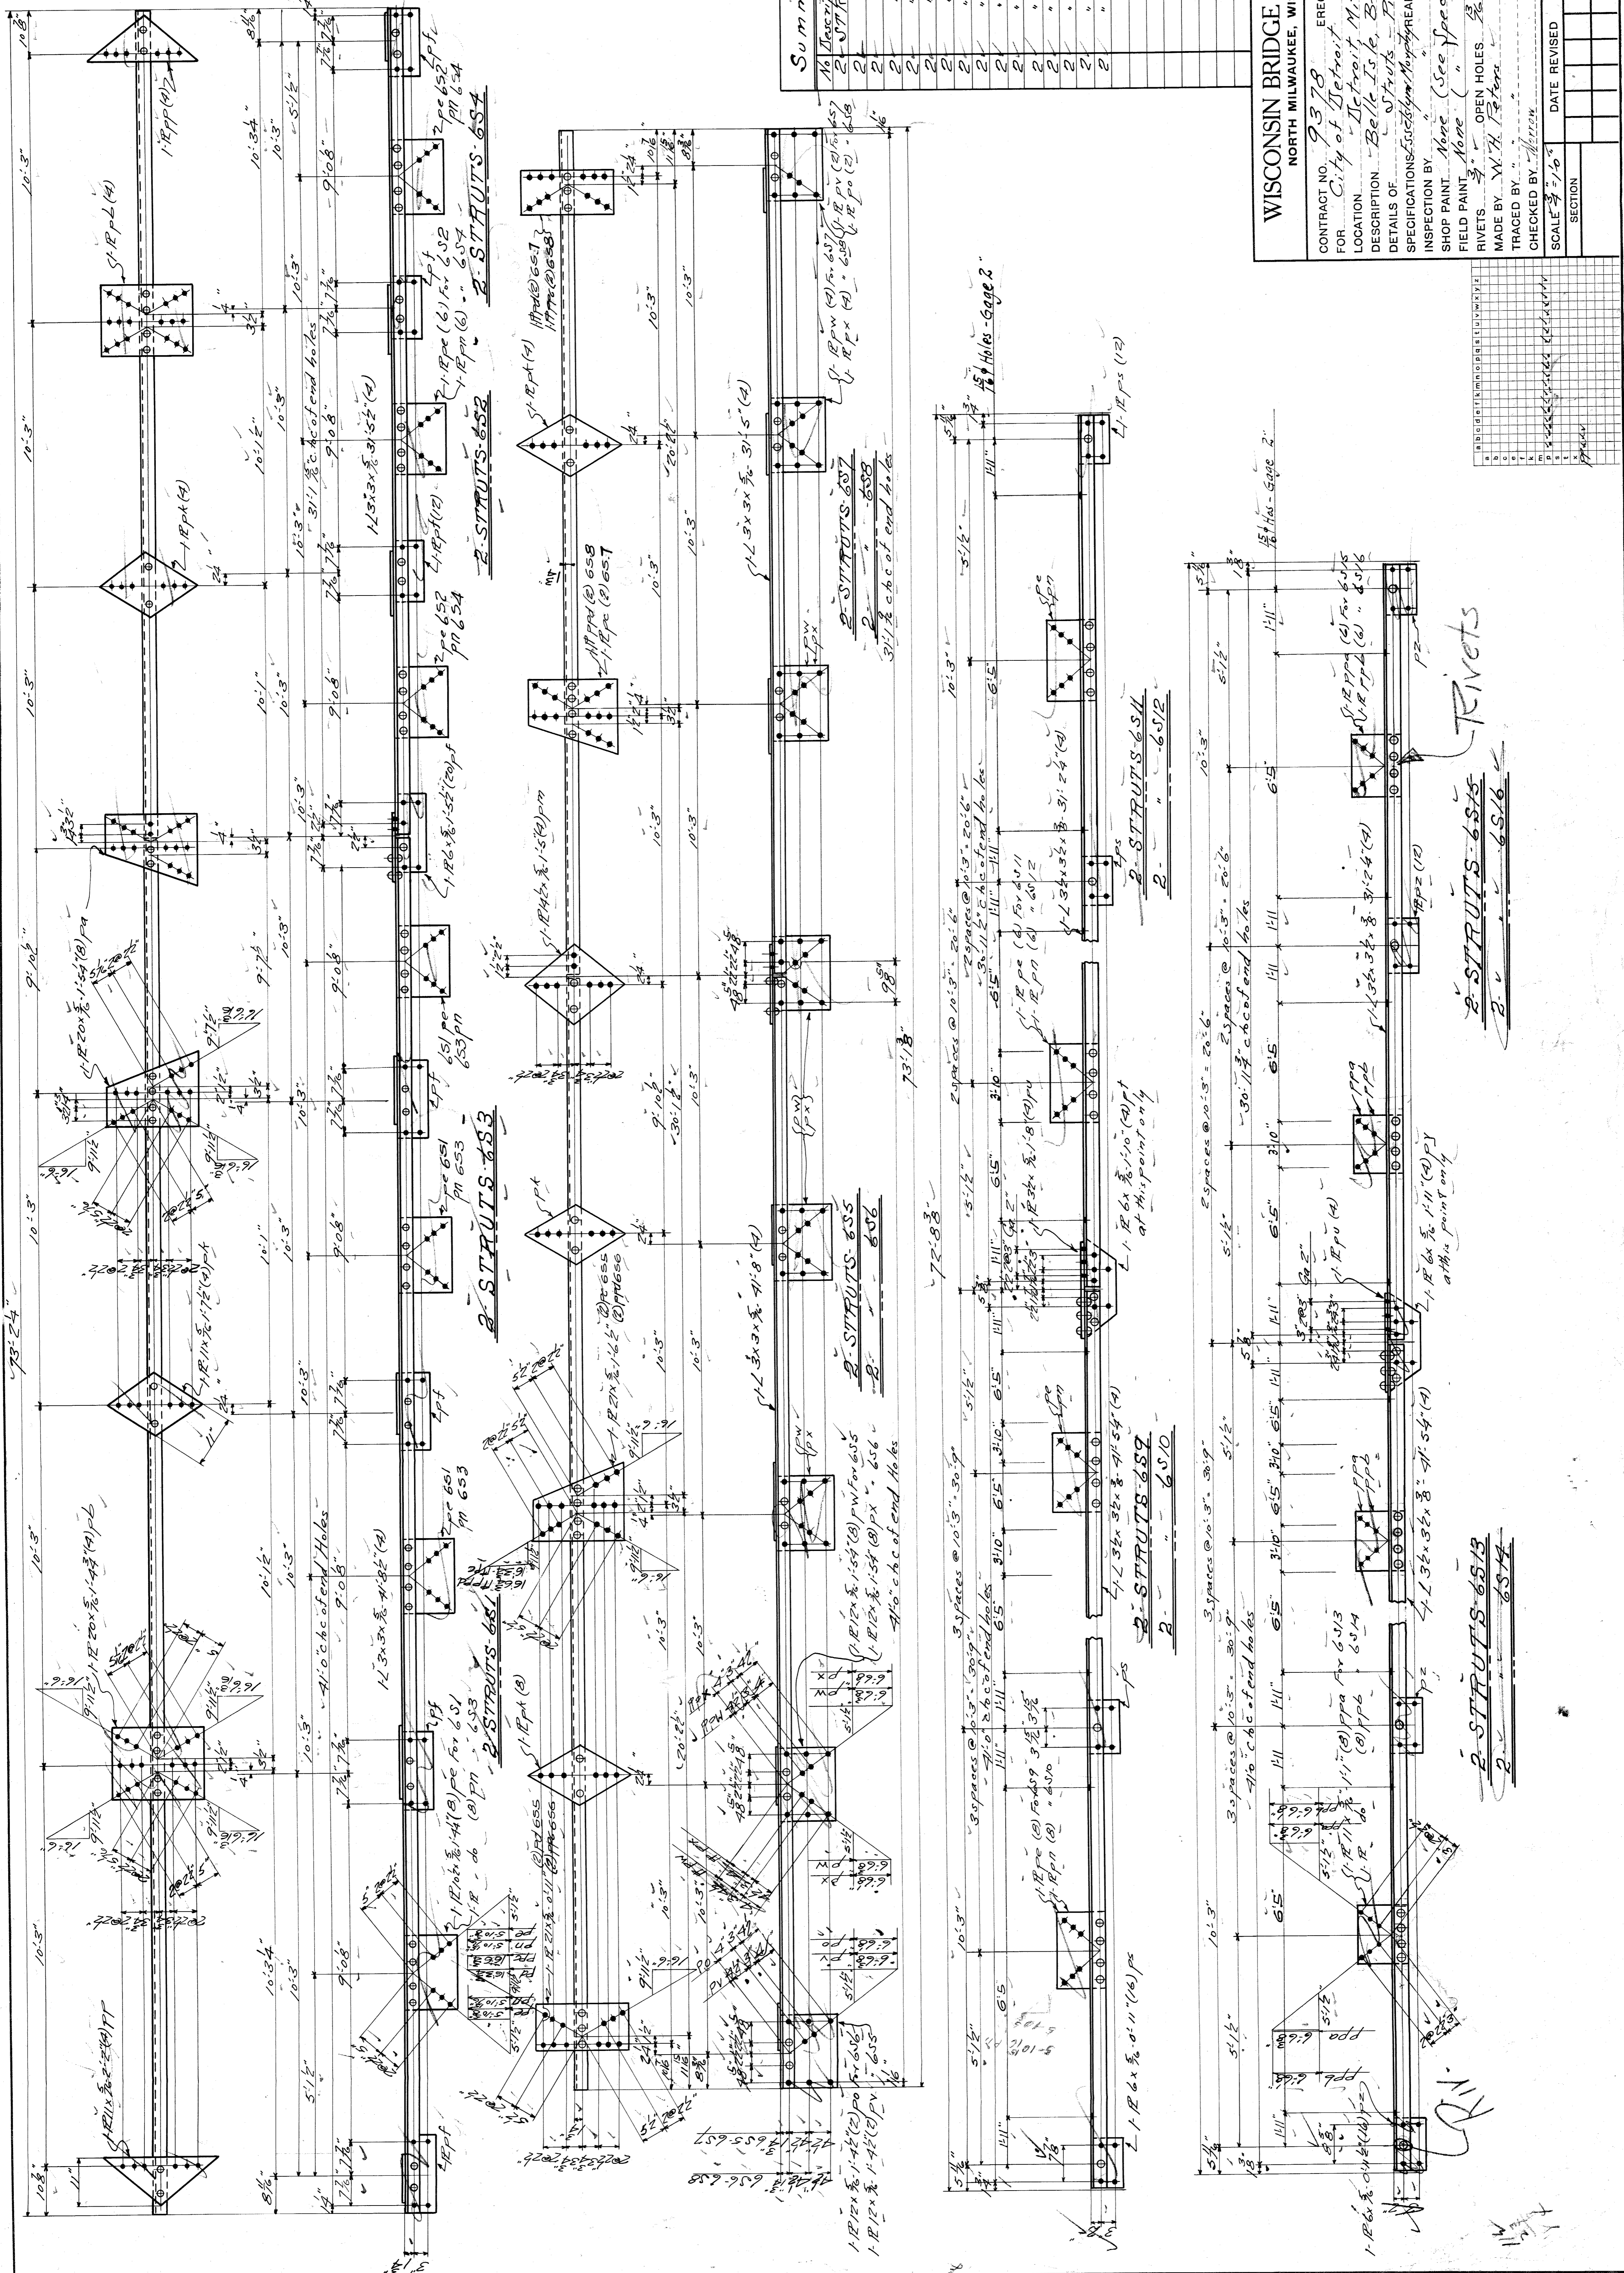

Summary of Parts

No	Description	Mat't	Qty
1	STRTS	651	1
2	"	652	1
3	"	653	1
4	"	654	1
5	"	655	1
6	"	656	1
7	"	657	1
8	"	658	1
9	"	659	1
10	"	6510	1
11	"	6511	1
12	"	6512	1
13	"	6513	1
14	"	6514	1
15	"	6515	1
16	"	6516	1

WISCONSIN BRIDGE & IRON CO.
 NORTH MILWAUKEE, WISCONSIN

CONTRACT NO. 9378
 ERECTED BY
 City of Detroit

LOCATION
 Detroit Mich

DESCRIPTION
 Belle Isle Bridge

DETAILS OF
 Struts - Deck 9-9

SPECIFICATIONS
 Customary

INSPECTION BY
 None

SHOP PAINT
 None (See Specifications)

FIELD PAINT
 None

RIVETS
 OPEN HOLES

MADE BY
 W. H. Peters

TRACED BY
 None

CHECKED BY
 None

SCALE
 1/4" = 1'-0"




DATE REVISION
 None

SECTION
 None

SHEET NO. 6
 LN00

9378

File BW201-190

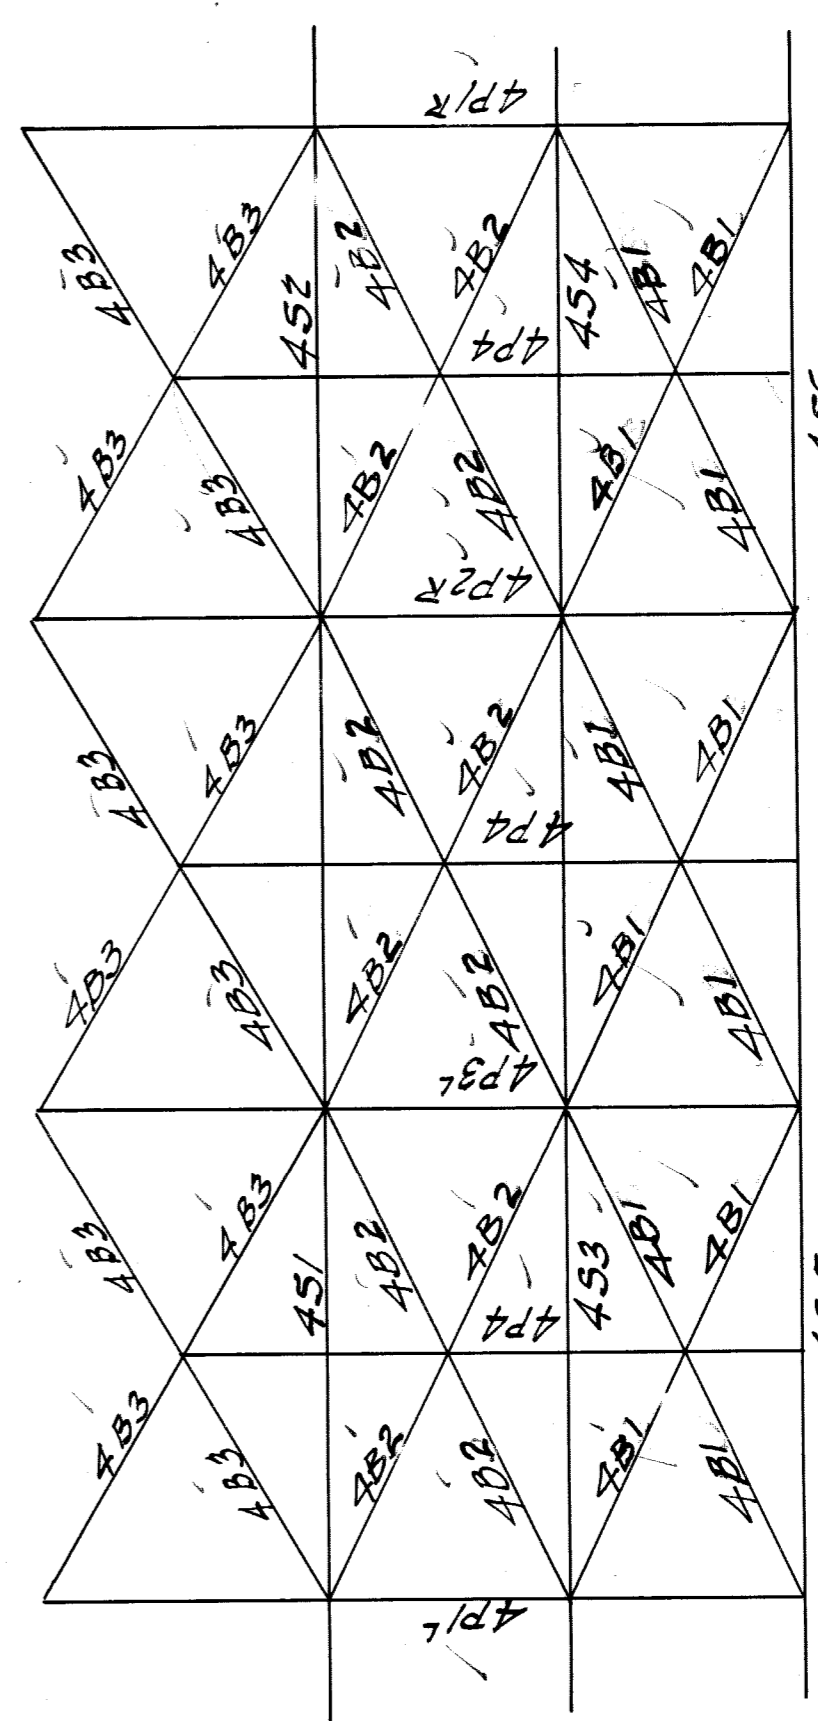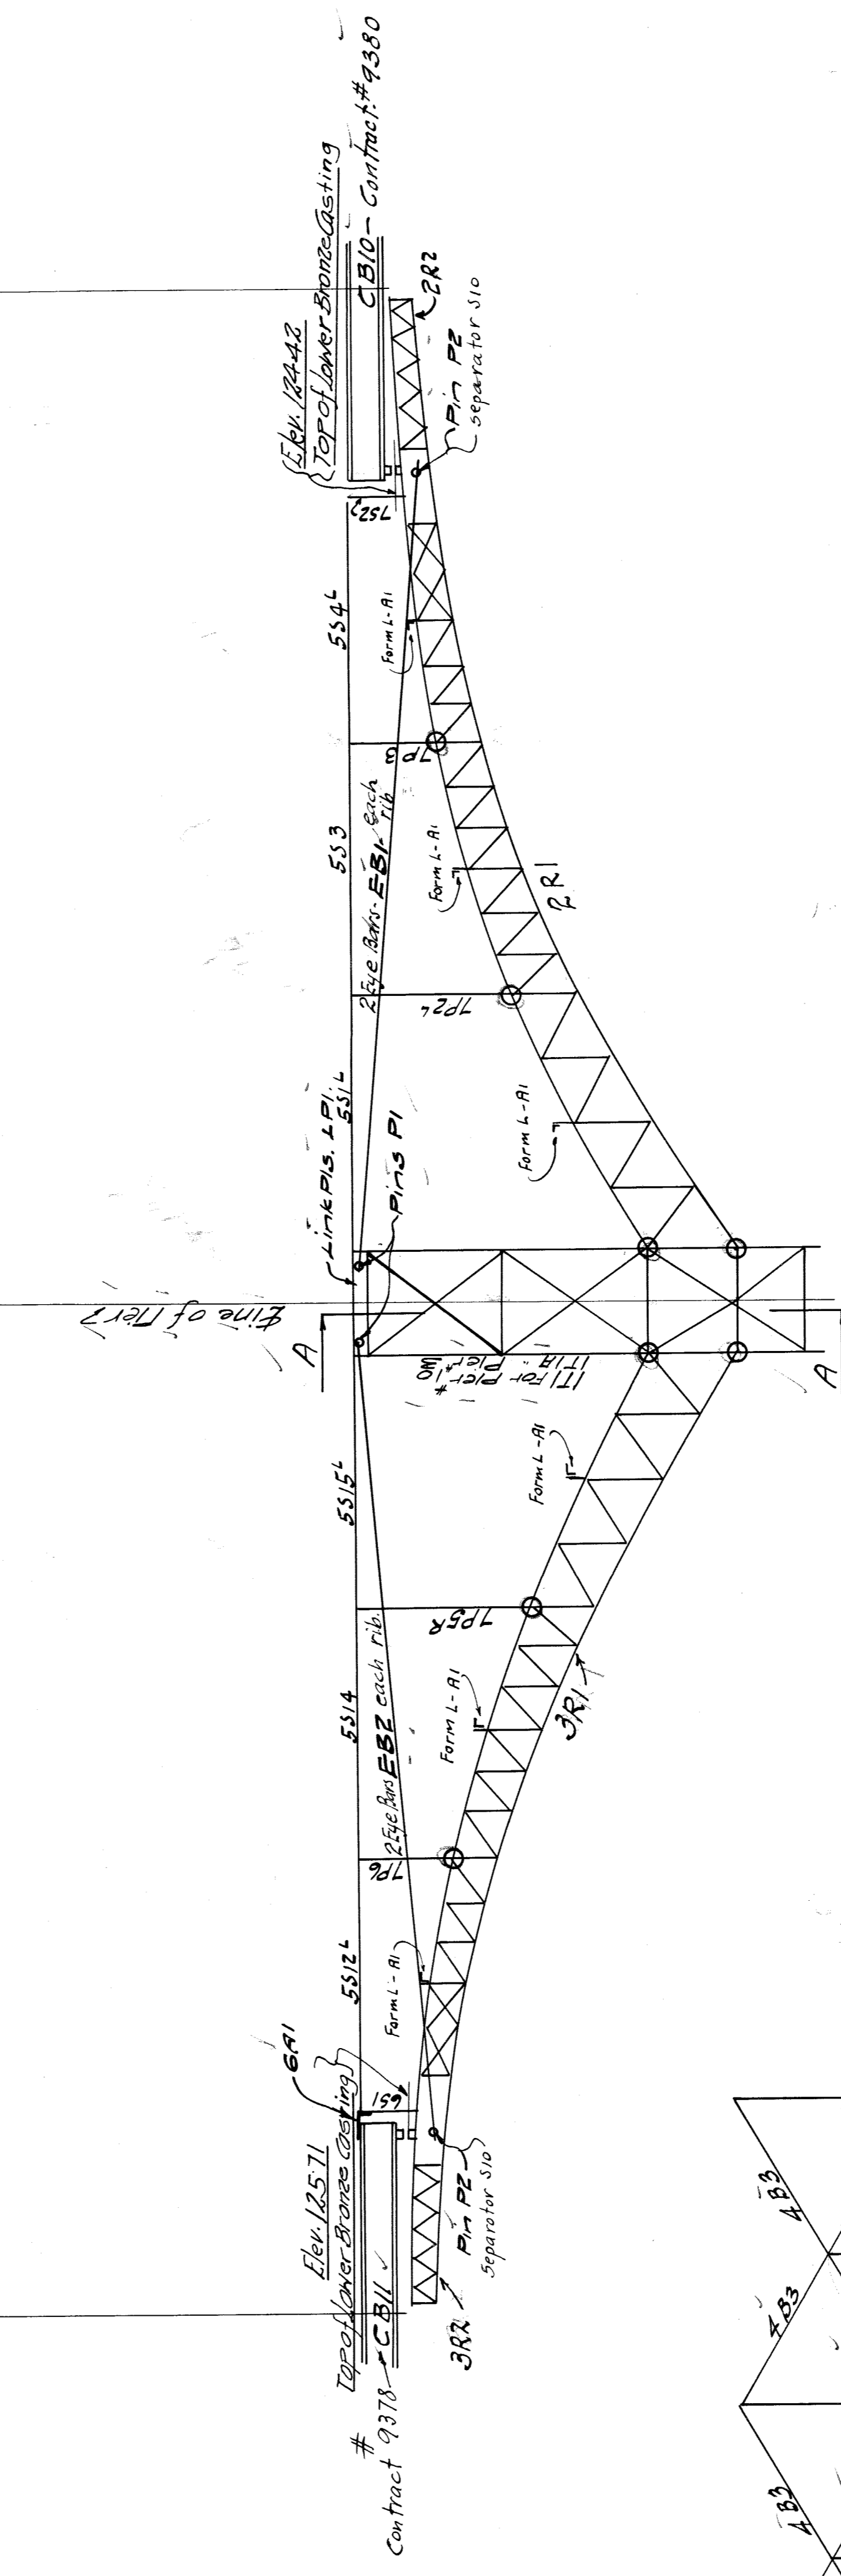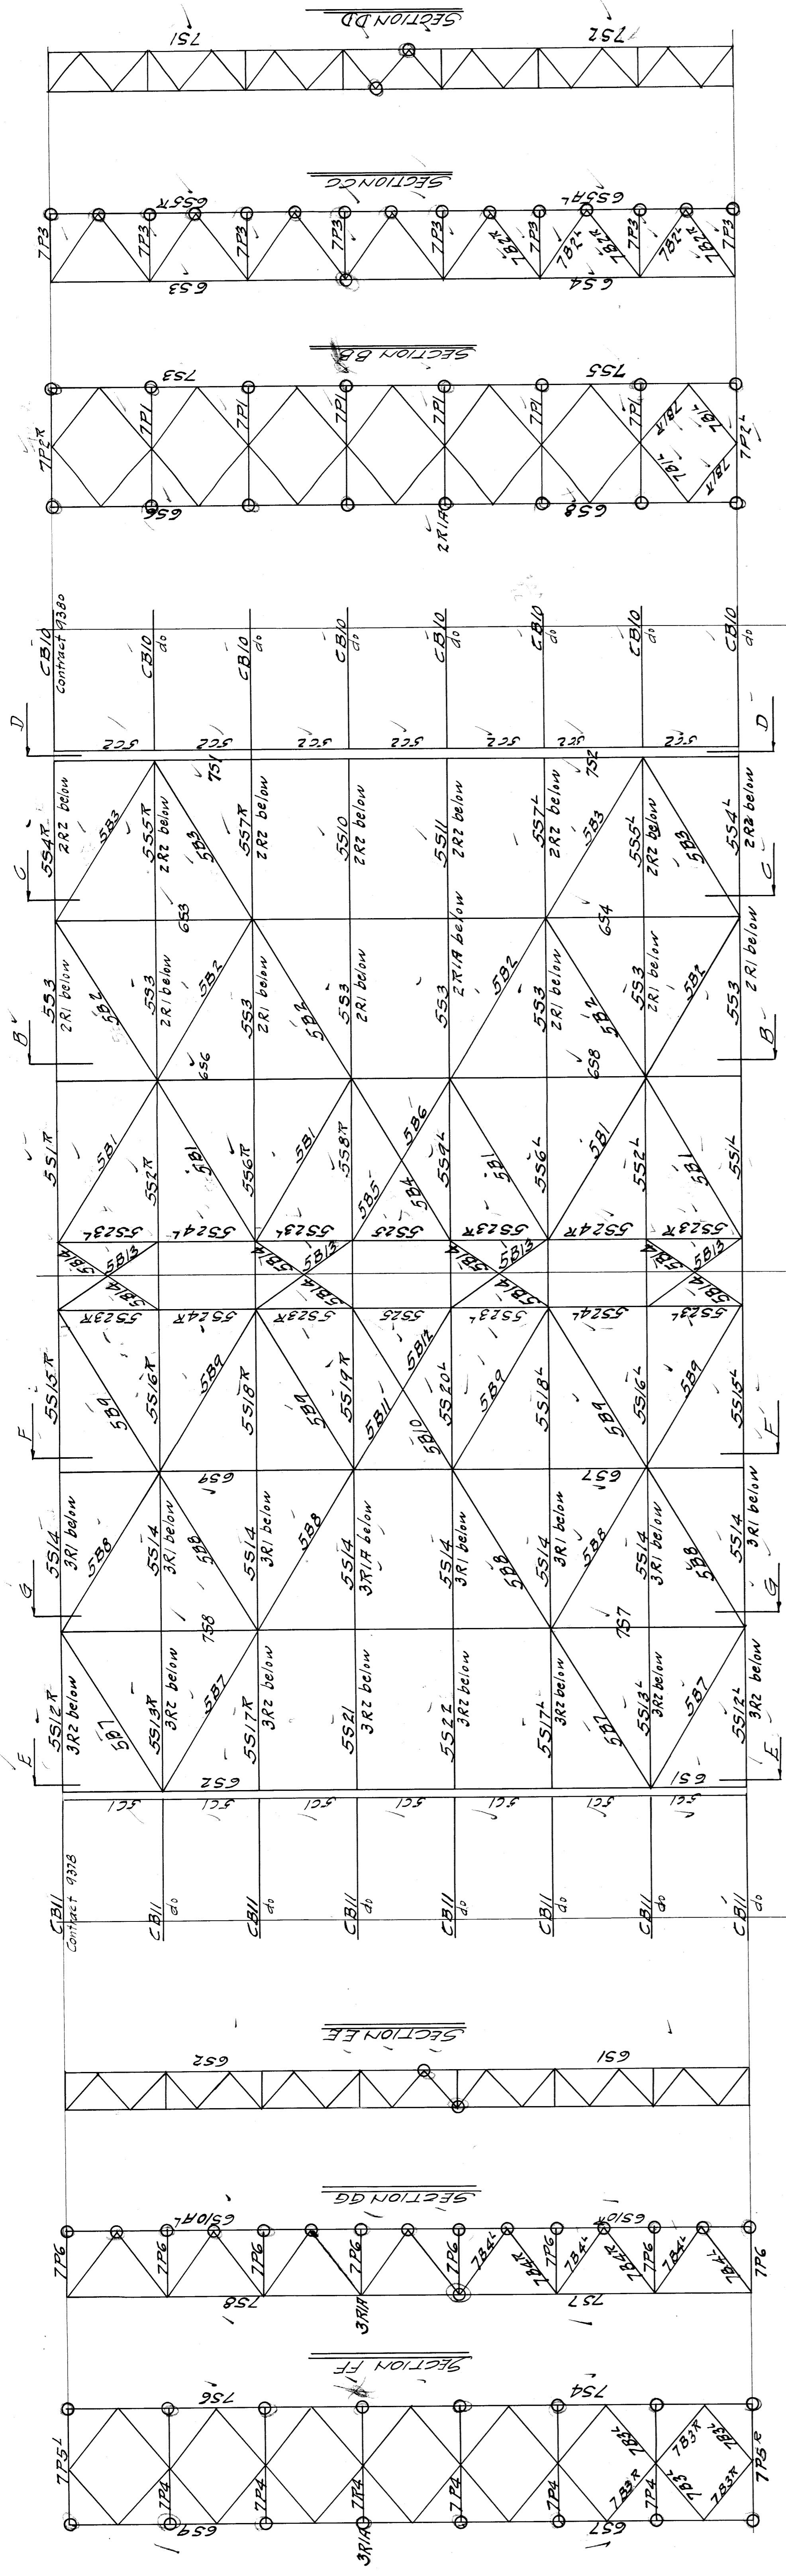

NOTE: All points encircled thus \circ to be riveted. All other points bolted.

WISCONSIN BRIDGE & IRON CO.
 NORTH MILWAUKEE, WIS.

FOR: City of Detroit
 LOCATION: Detroit, Mich.
 DESCRIPTION: Belle Isle Bridge Pier No. 10
 DETAILS OF: Section AA

SPECIFICATIONS BY: _____
 REAMING BY: _____
 INSPECTION BY: _____
 SHOP PAINT BY: _____


MADE BY: Lemke DATE: 7/21
 TRACED BY: _____ DATE: 4/22
 CHECKED BY: _____ DATE: 4/22

SCALE: 1/4" = 1'-0"
 SECTION: _____

RIVETS: _____
 OPEN HOLES: _____
 UNLESS NOTED: _____

SHEET No. E1
9379

Piers #3+10.
 Pier #10 shown.
 Form L detailed on Bill #305-Cont. 9377.

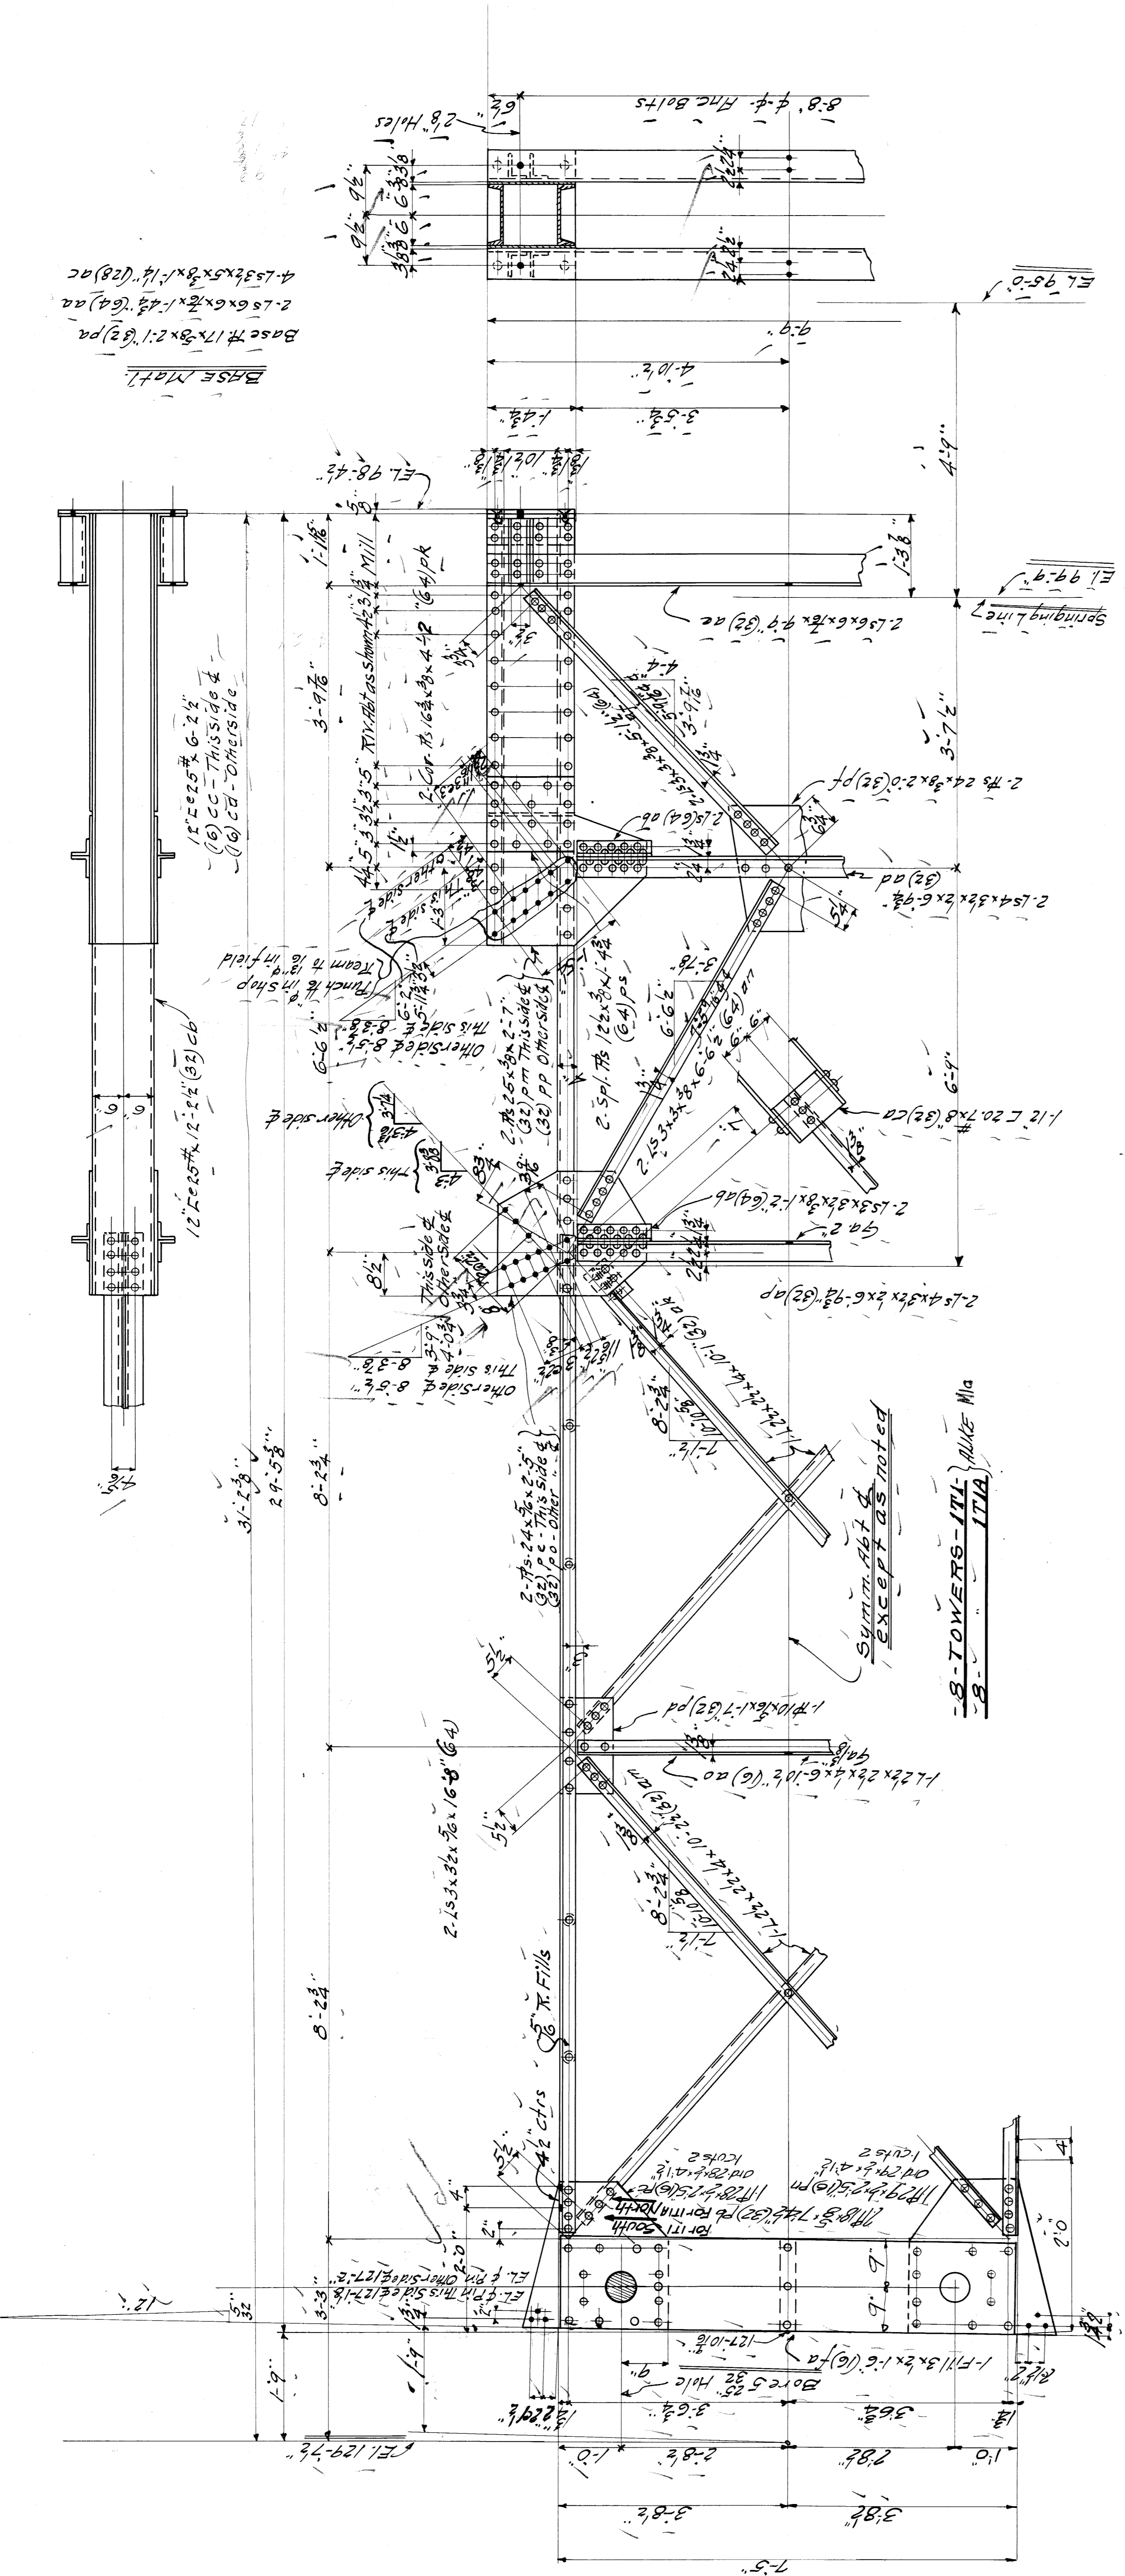


WISCONSIN BRIDGE & IRON CO.
 NORTH MILWAUKEE, WIS.
 FOR City of Detroit
 LOCATION Detroit Mich
 DESCRIPTION Belle Isle Bridge
 DETAILS OF TOWERS PLANS
 SPECIFICATIONS See Specifications
 ERECTED BY W. J. ...
 SHOP PAINT None (See Specifications)
 FIELD PAINT None
 MADE BY C. N. ... DATE 8-22-21
 TRACED BY C. N. ... DATE 1-25-21
 CHECKED BY ... DATE ...
 UNLESS NOTED
 SCALE _____
 DATE REVISED: _____
 SHEET NO. **1**
 SECTION _____
 INCHES
 FEET


F. 581 CNA 5-22
 BW 201-192

9379

WISCONSIN BRIDGE & IRON CO
NORTH MILWAUKEE WIS.

FOR CITY OF MILWAUKEE
LAWSON DESIGN OFFICE
DESIGNED BY LAWSON DESIGN OFFICE
DRAWN BY J. J. ...
CHECKED BY ...
APPROVED BY ...
DATE ...

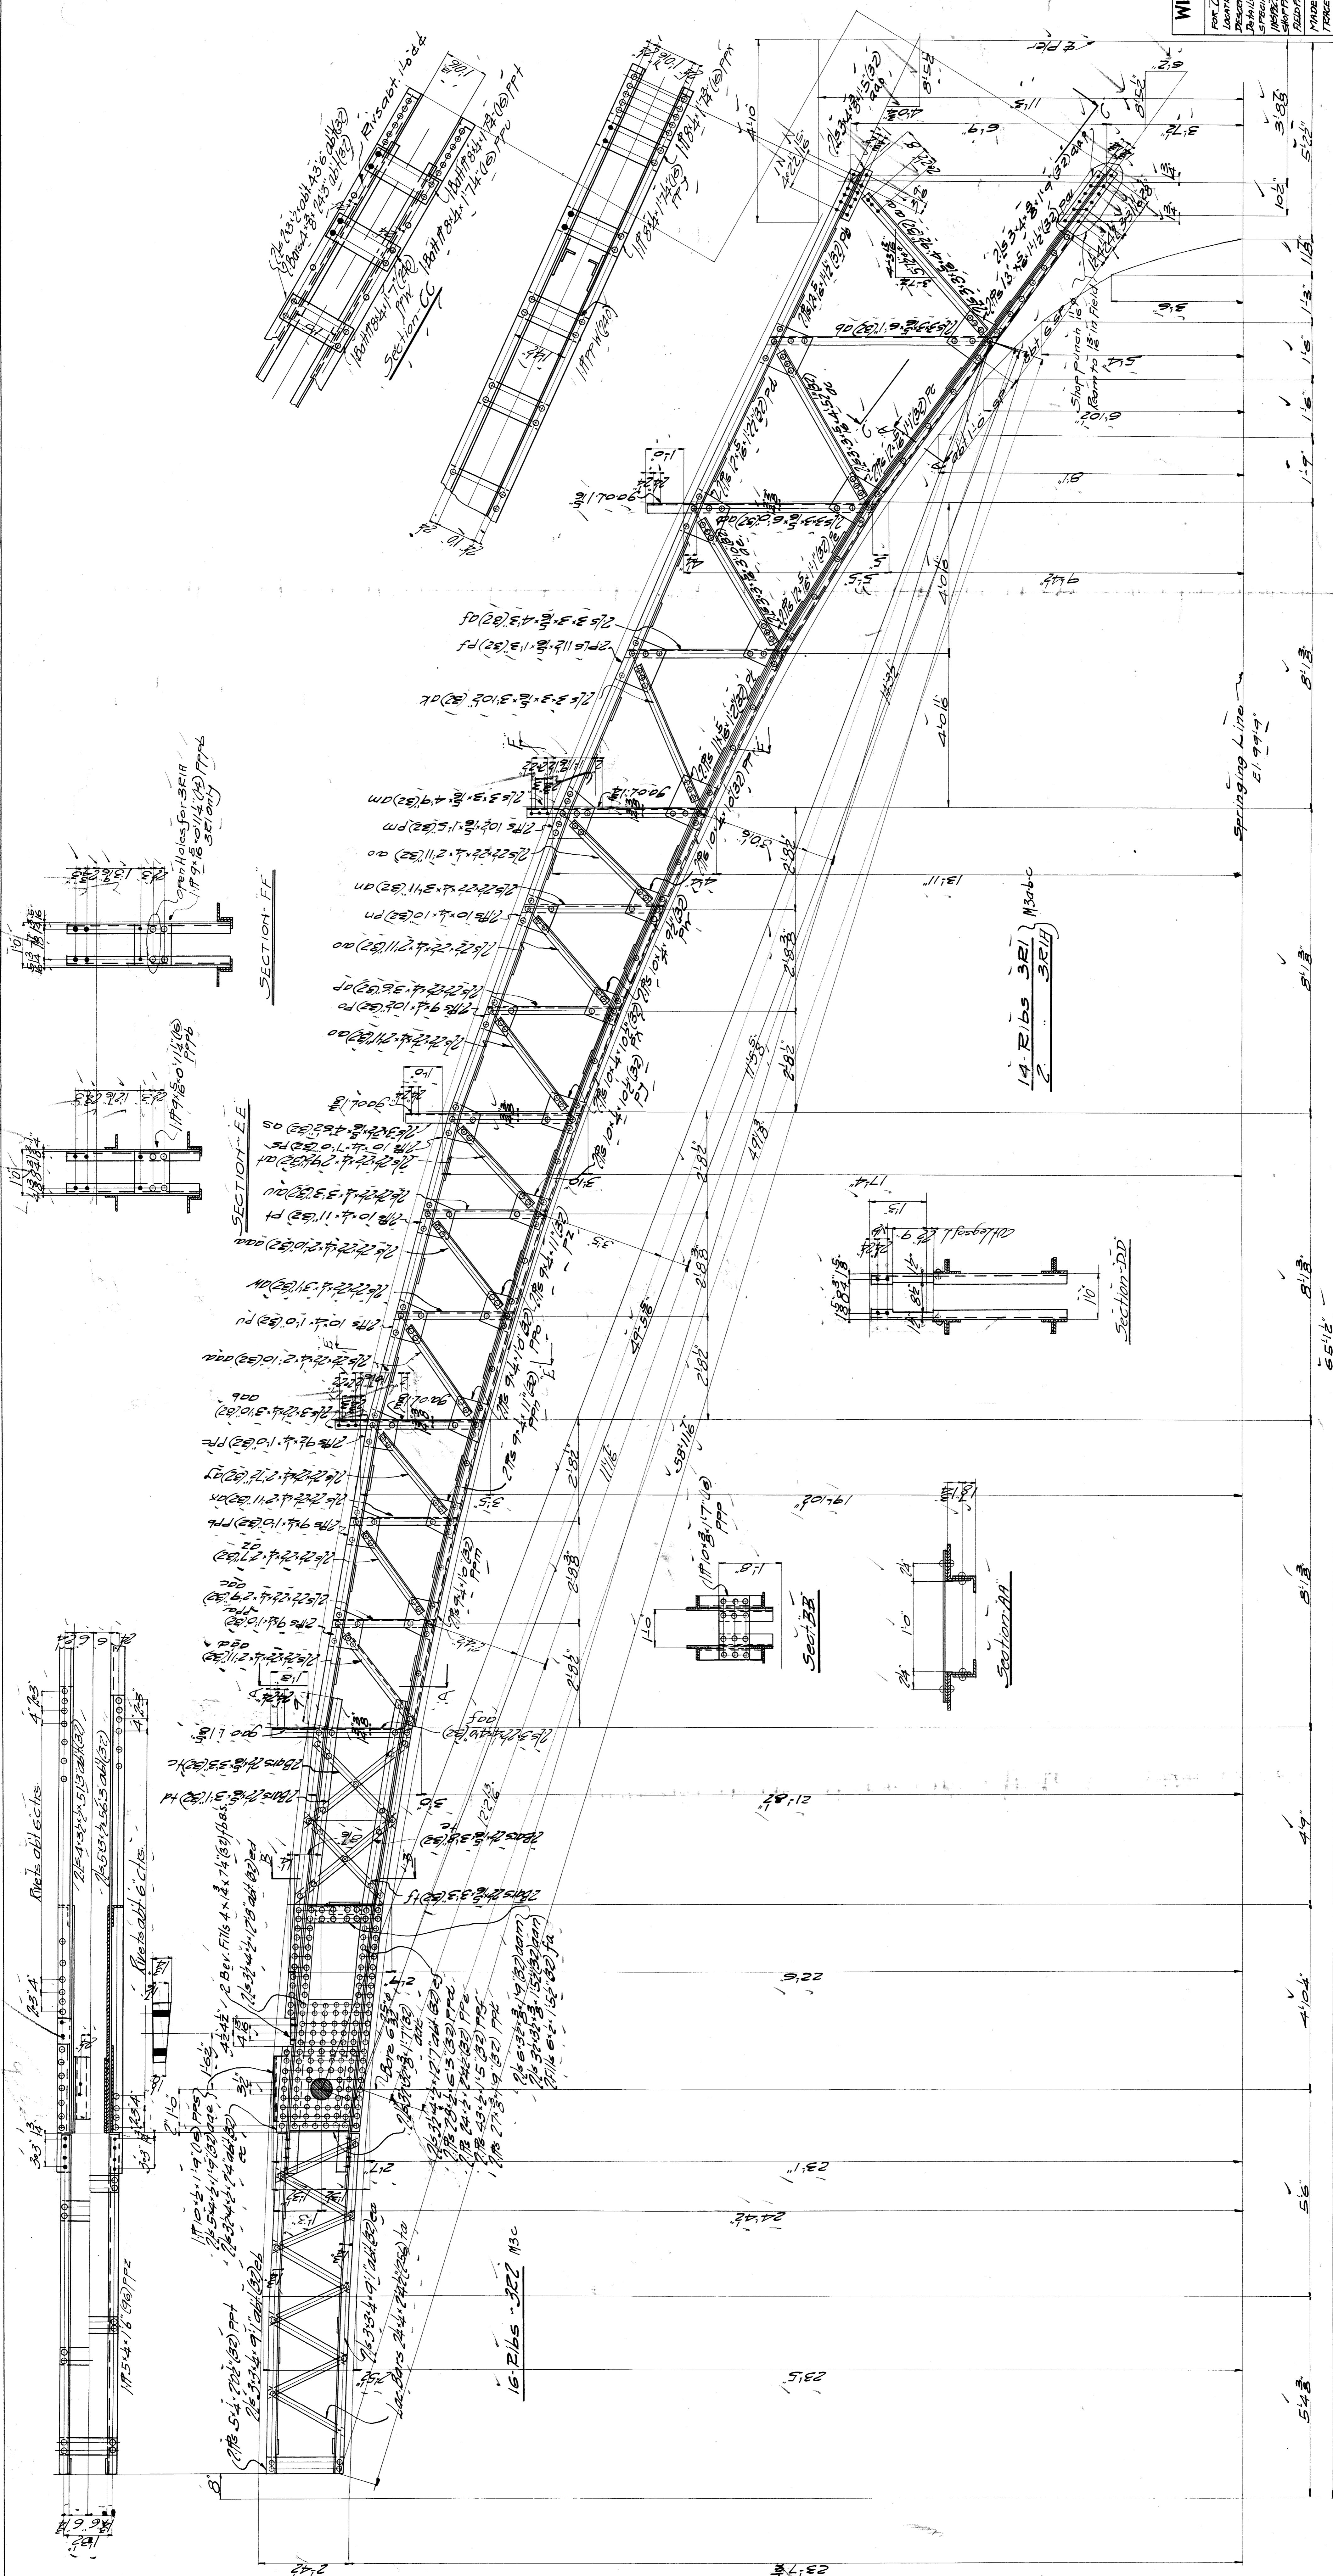

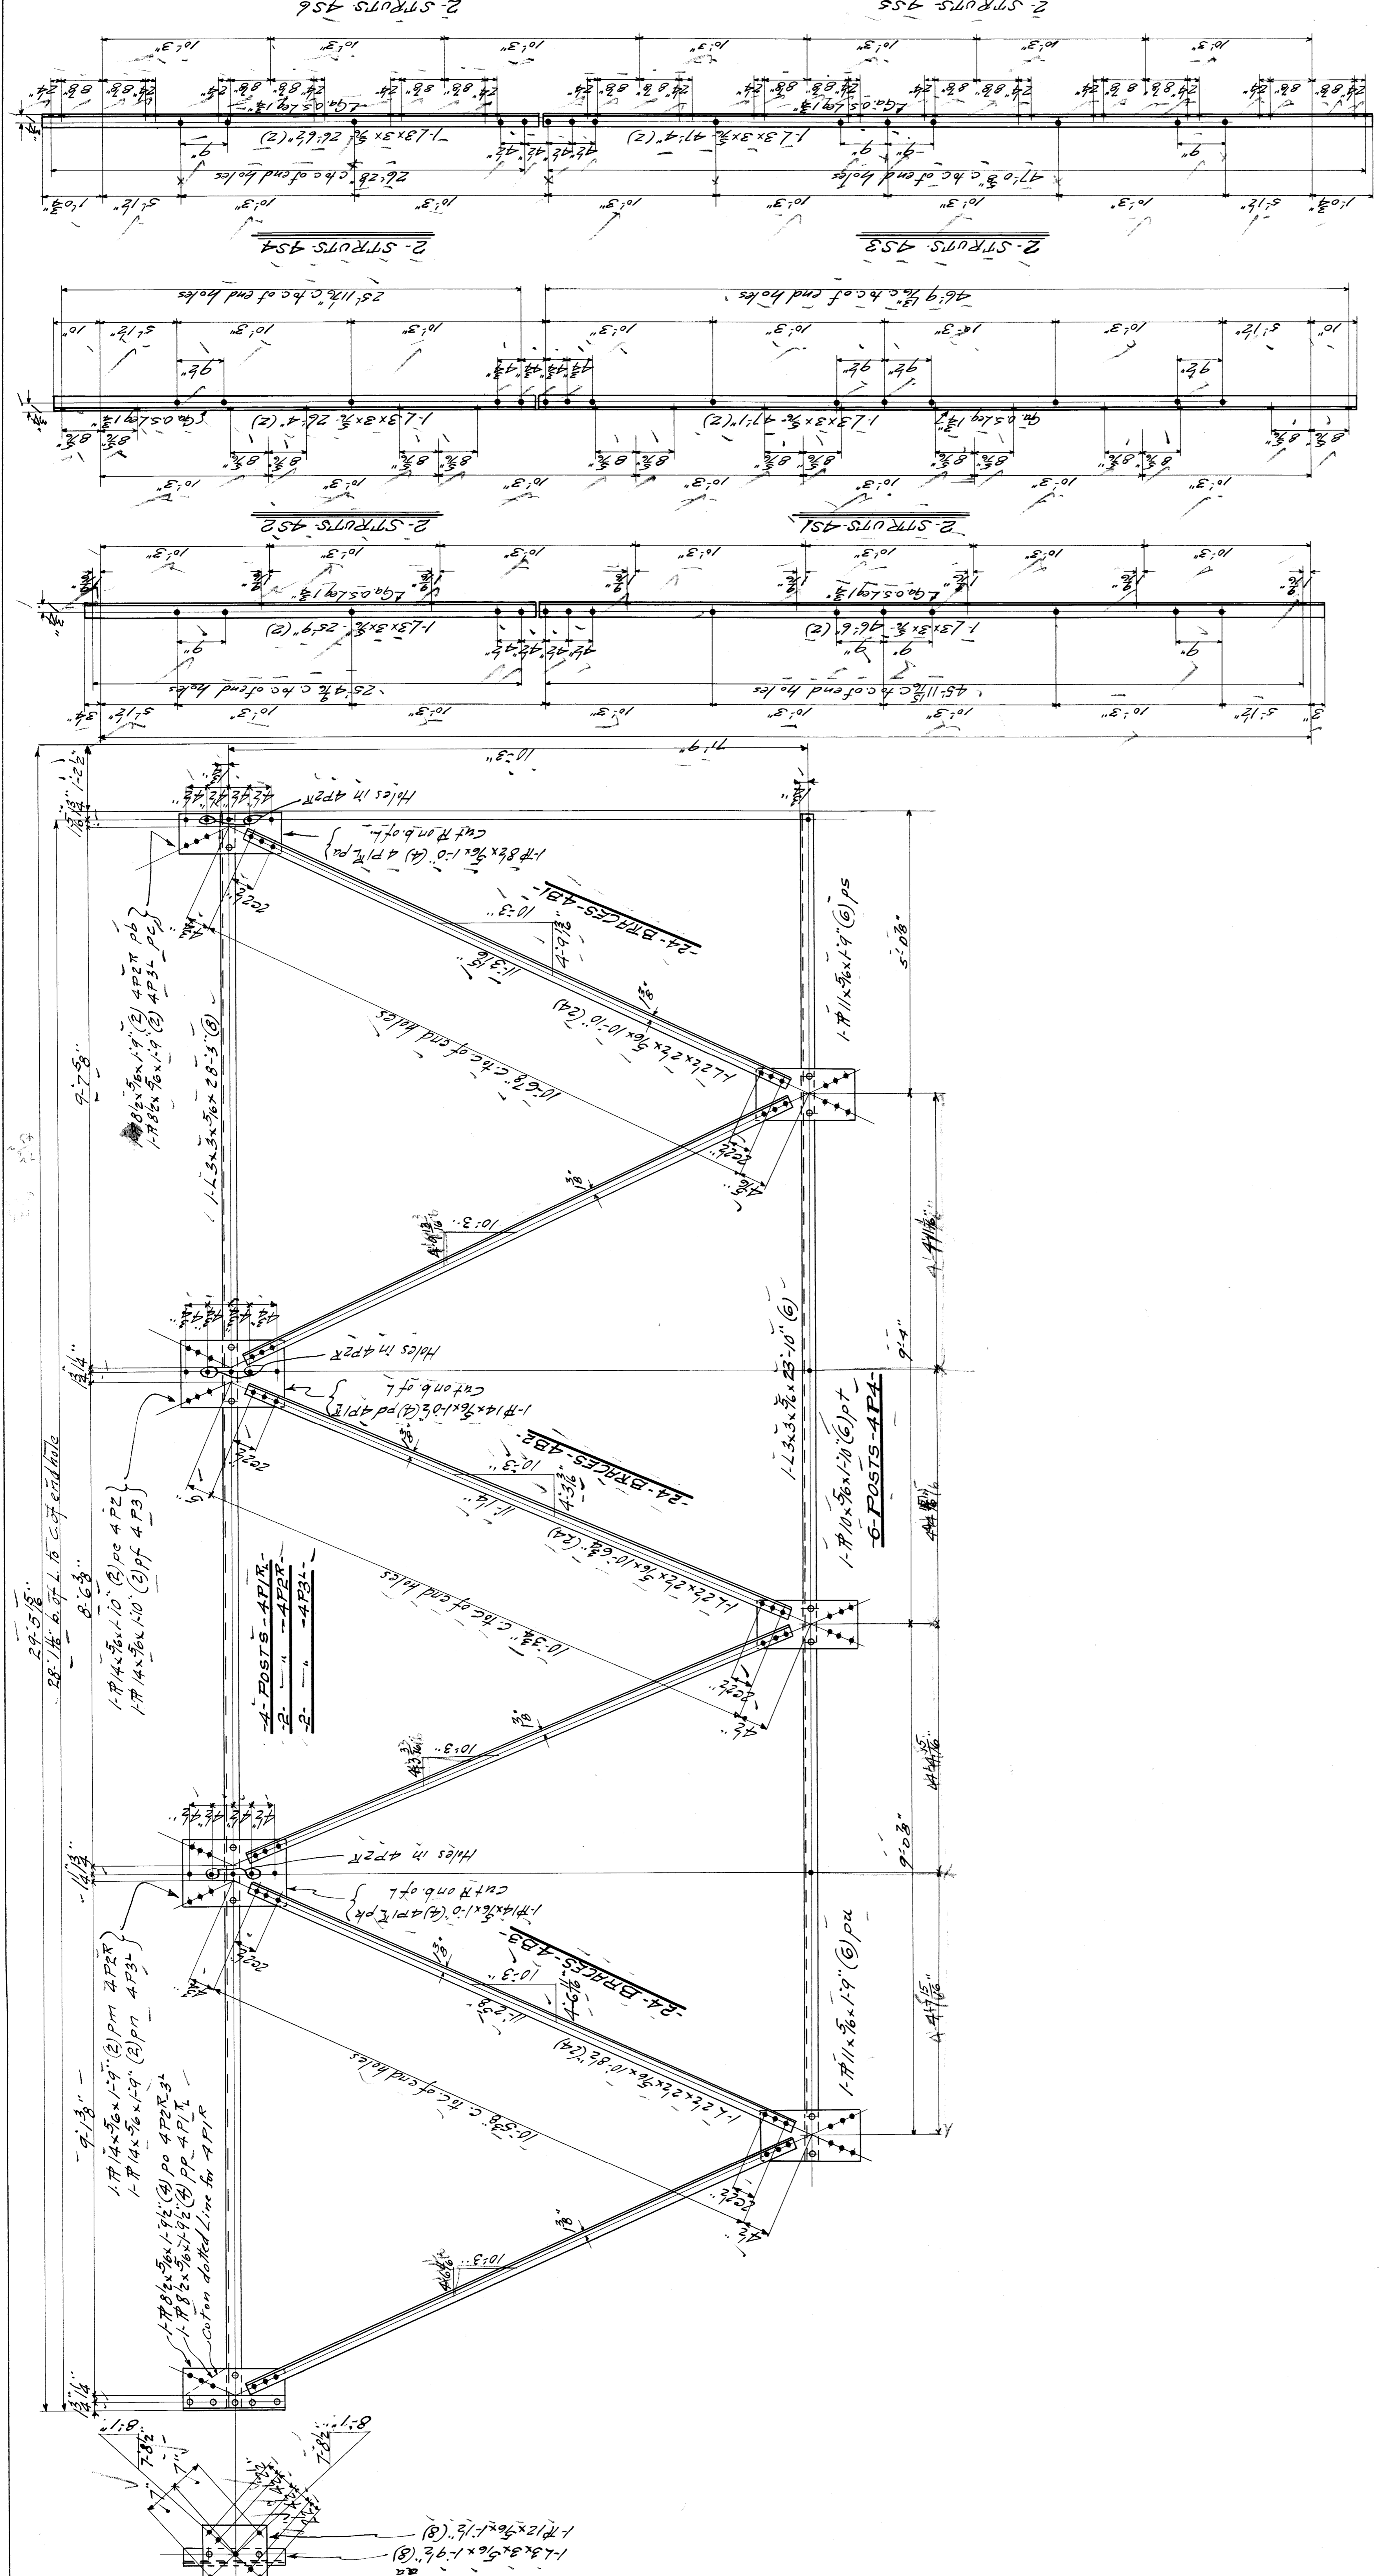

Summary

No.	Description	Mark	Mat.
1	Posts	APA	1-P 11x56x1-10 (6) pt
2		AB2	1-P 11x56x1-10 (6) pt
3		AB3	1-P 11x56x1-10 (6) pt
4		AB4	1-P 11x56x1-10 (6) pt
5		AS1	1-L 3x5x5/8x23-10 (6)
6		AS2	1-L 3x5x5/8x23-10 (6)
7		AS3	1-L 3x5x5/8x23-10 (6)
8		AS4	1-L 3x5x5/8x23-10 (6)
9		AS5	1-L 3x5x5/8x23-10 (6)
10		AS6	1-L 3x5x5/8x23-10 (6)

WISCONSIN BRIDGE & IRON CO.
NORTH MILWAUKEE, WIS.

FOR City of Detroit
LOCATION: Detroit Bridge
DESCRIPTION: Beric Isle Bridge
DETAILS OF BRACING AND STRUTS Figs 3-10
SPECIFICATIONS: Sign Interfering Metal
INSPECTED BY: (See Specifications)
SHOP PAINT: (See Specifications)

MADE BY: Date 5/16/21
TRACED BY: Date 4/30/21
CHECKED BY: Date 4/30/21
SCALE: 1/2" = 1'-0"

FIELD PAINT: (See Specifications)

RIVETS: (See Specifications)


DATE REVISED: (See Specifications)

SECTION: (See Specifications)

SHEET NO. 4

9379

F. W. C. S. N. A. 5-8-22. F. 1/2 BW 20-195

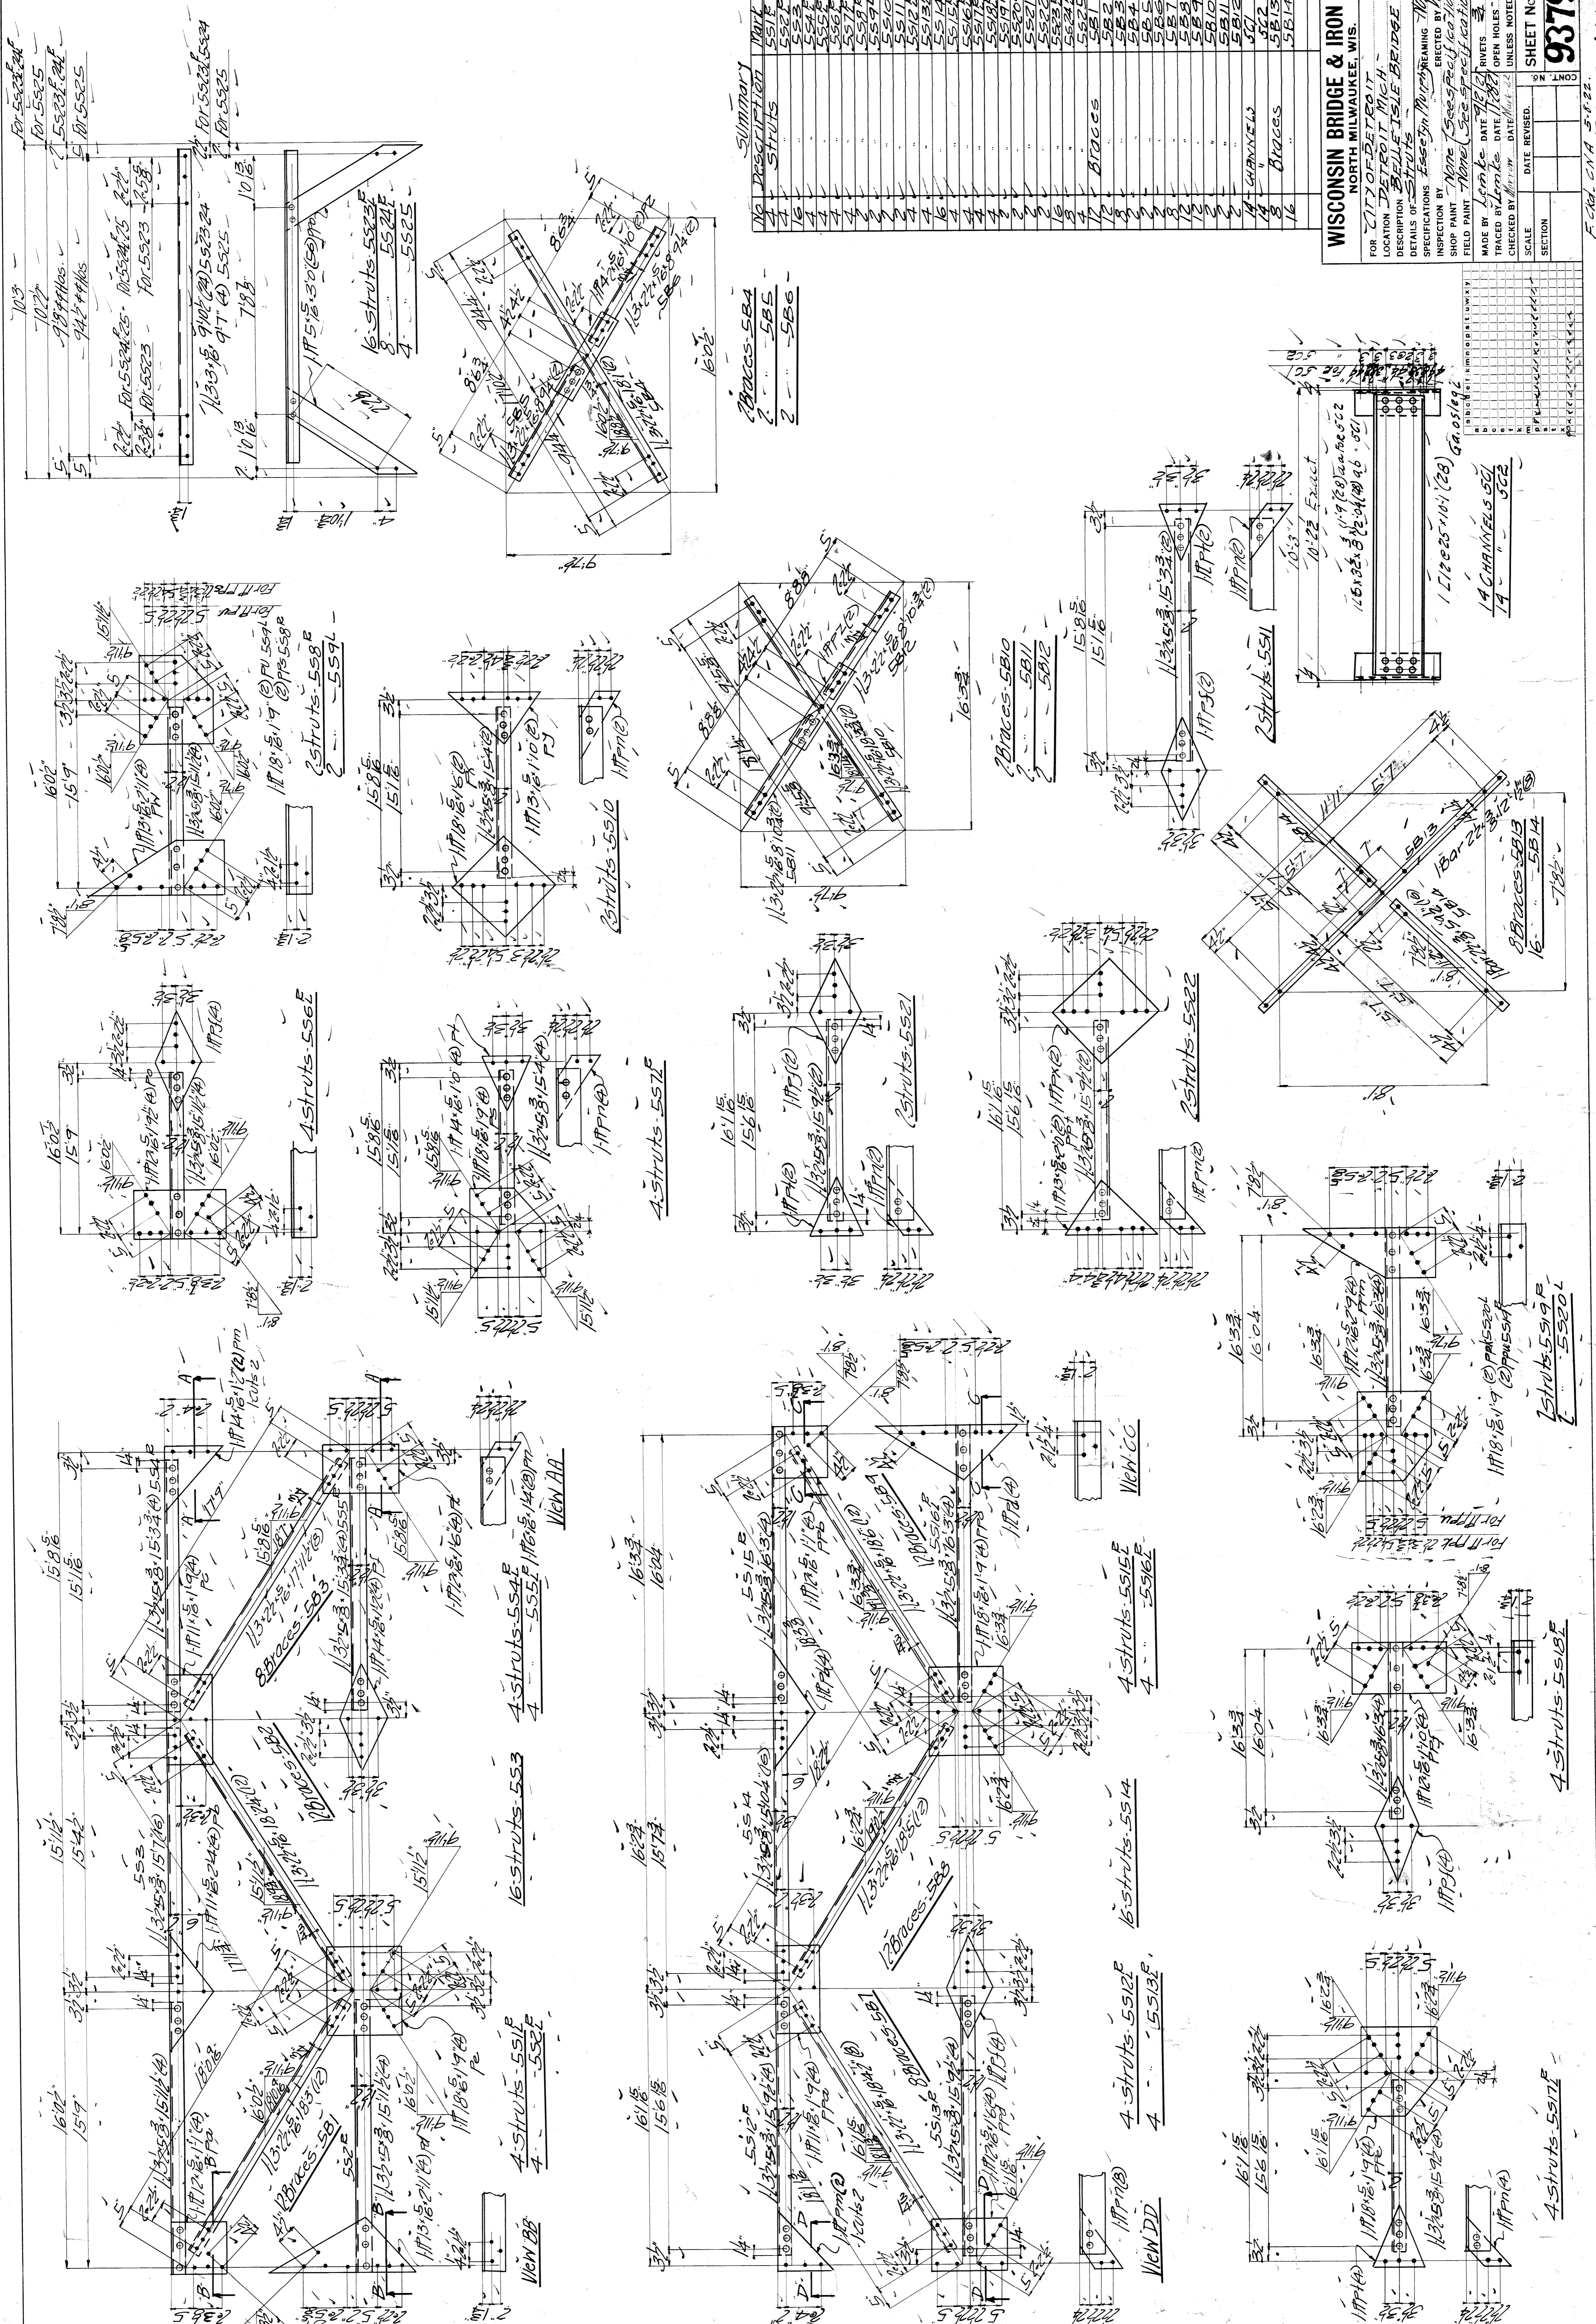





Summary
 2 Braces 5B4
 2 5B5
 2 5B6

No.	Description	Qty.
1	Struts	2
2		2
3		2
4		2
5		2
6		2
7		2
8		2
9		2
10		2
11		2
12		2
13		2
14		2
15		2
16		2

WISCONSIN BRIDGE & IRON CO.
 NORTH MILWAUKEE, WIS.

FOR CITY OF BERTHA
 LOCATION OF BRIDGE
 DESCRIPTION OF BRIDGE ISLE BRIDGE
 DETAILS OF BRIDGE
 SPECIFICATIONS
 SHOP PAINT
 FIELD PAINT
 MADE BY
 TRACED BY
 CHECKED BY
 SCALE
 SECTION

14 CHANNELS
 7 7/8
 14
 UNLESS NOTED
 SHEET NO. **9379**
 5

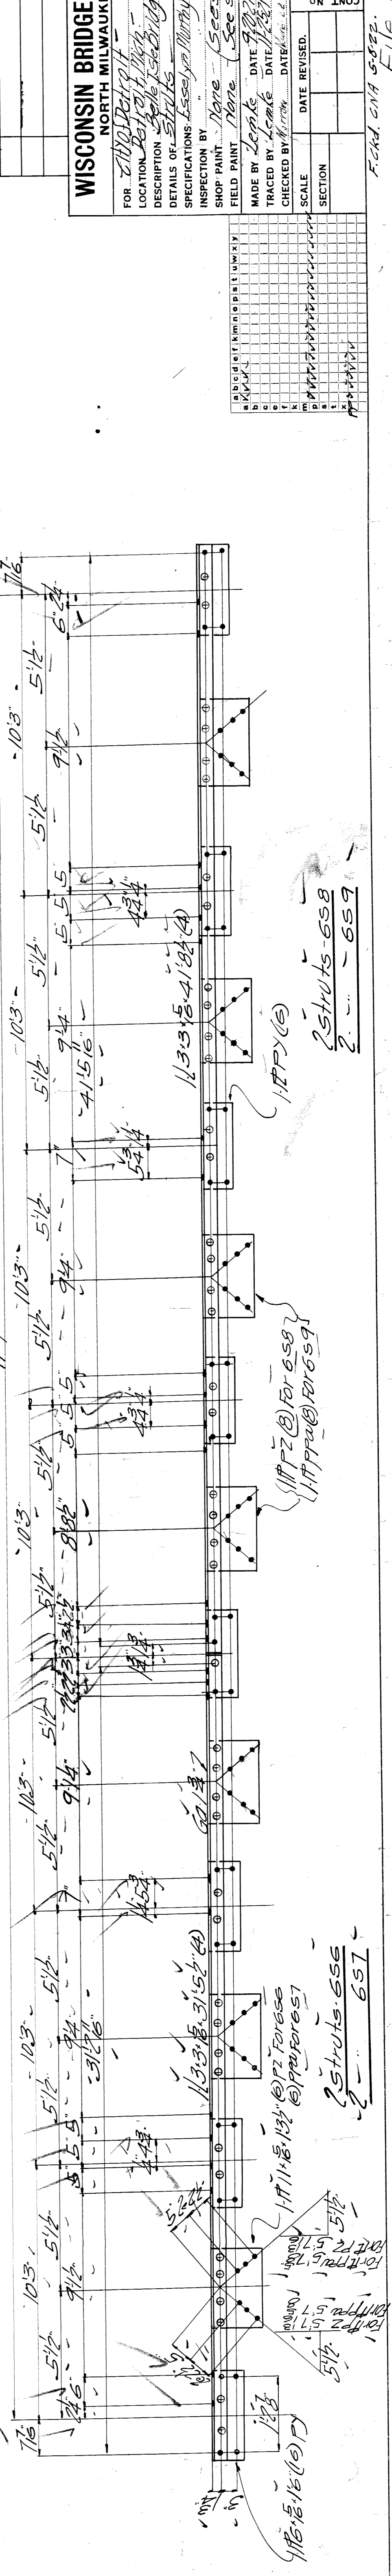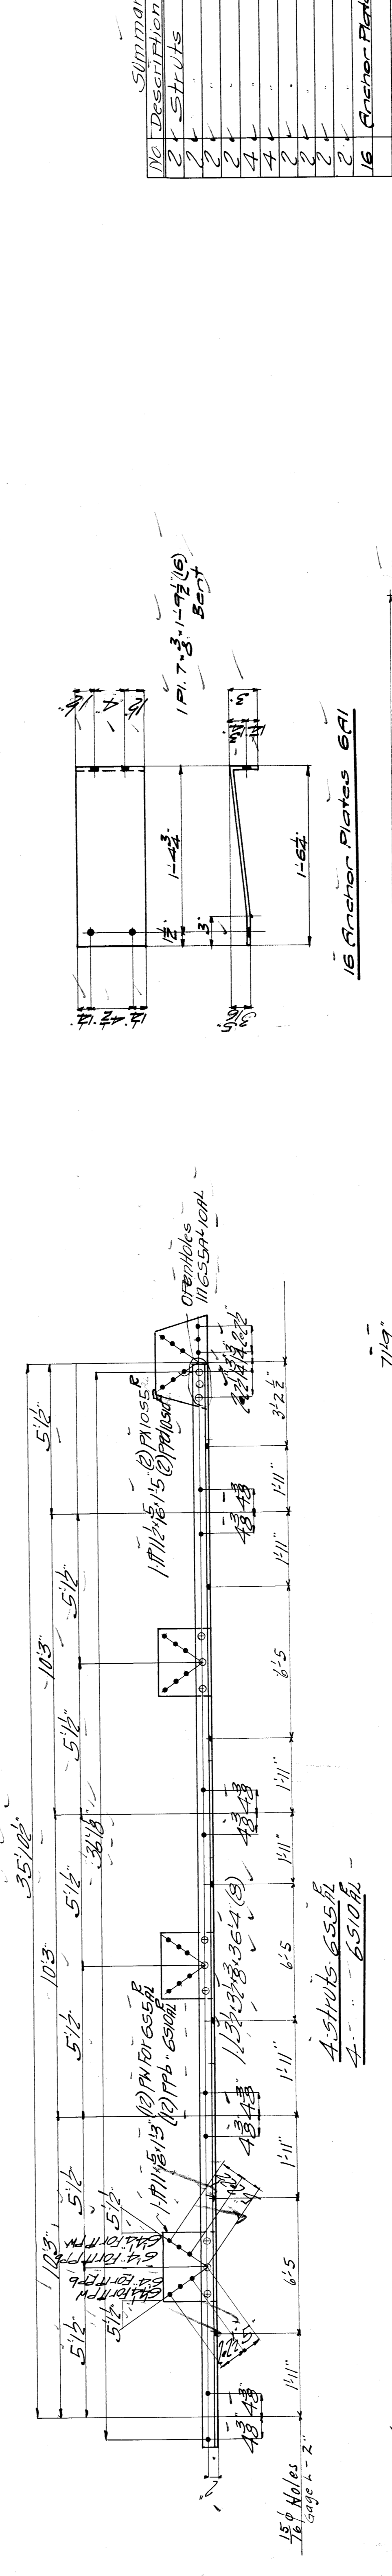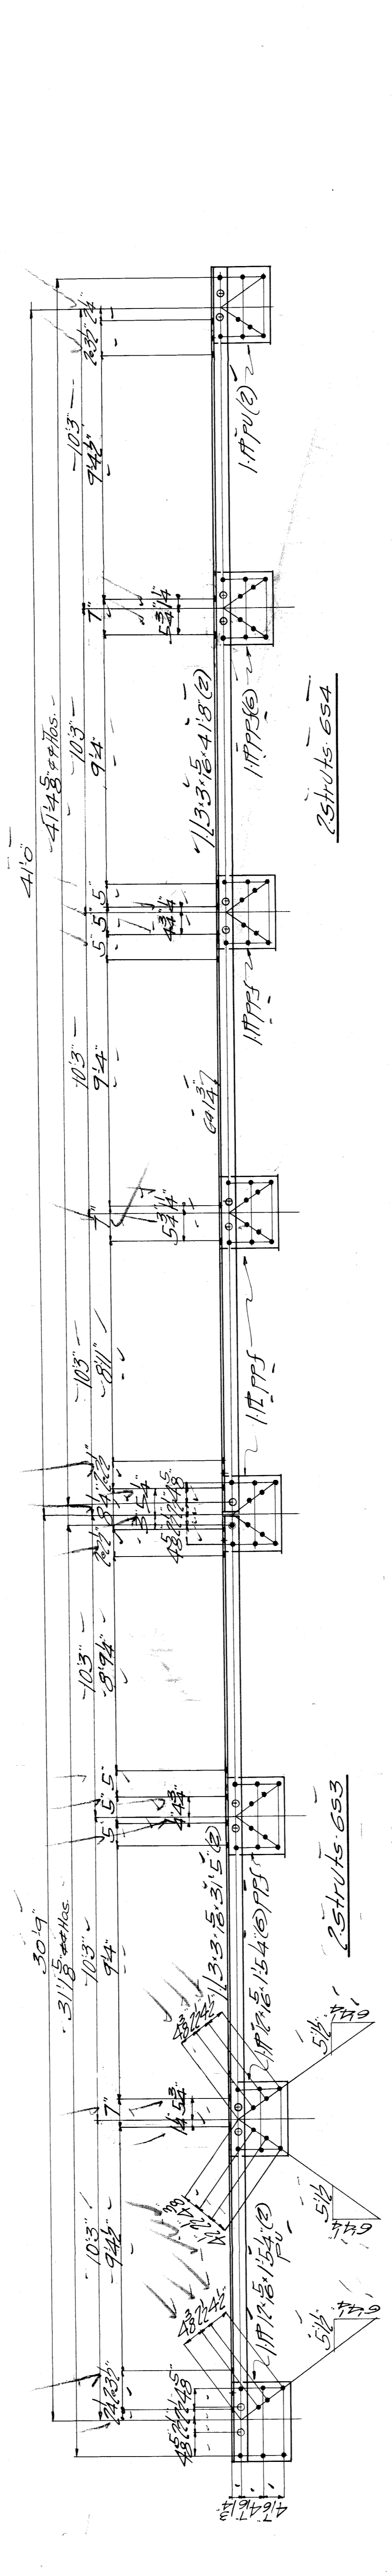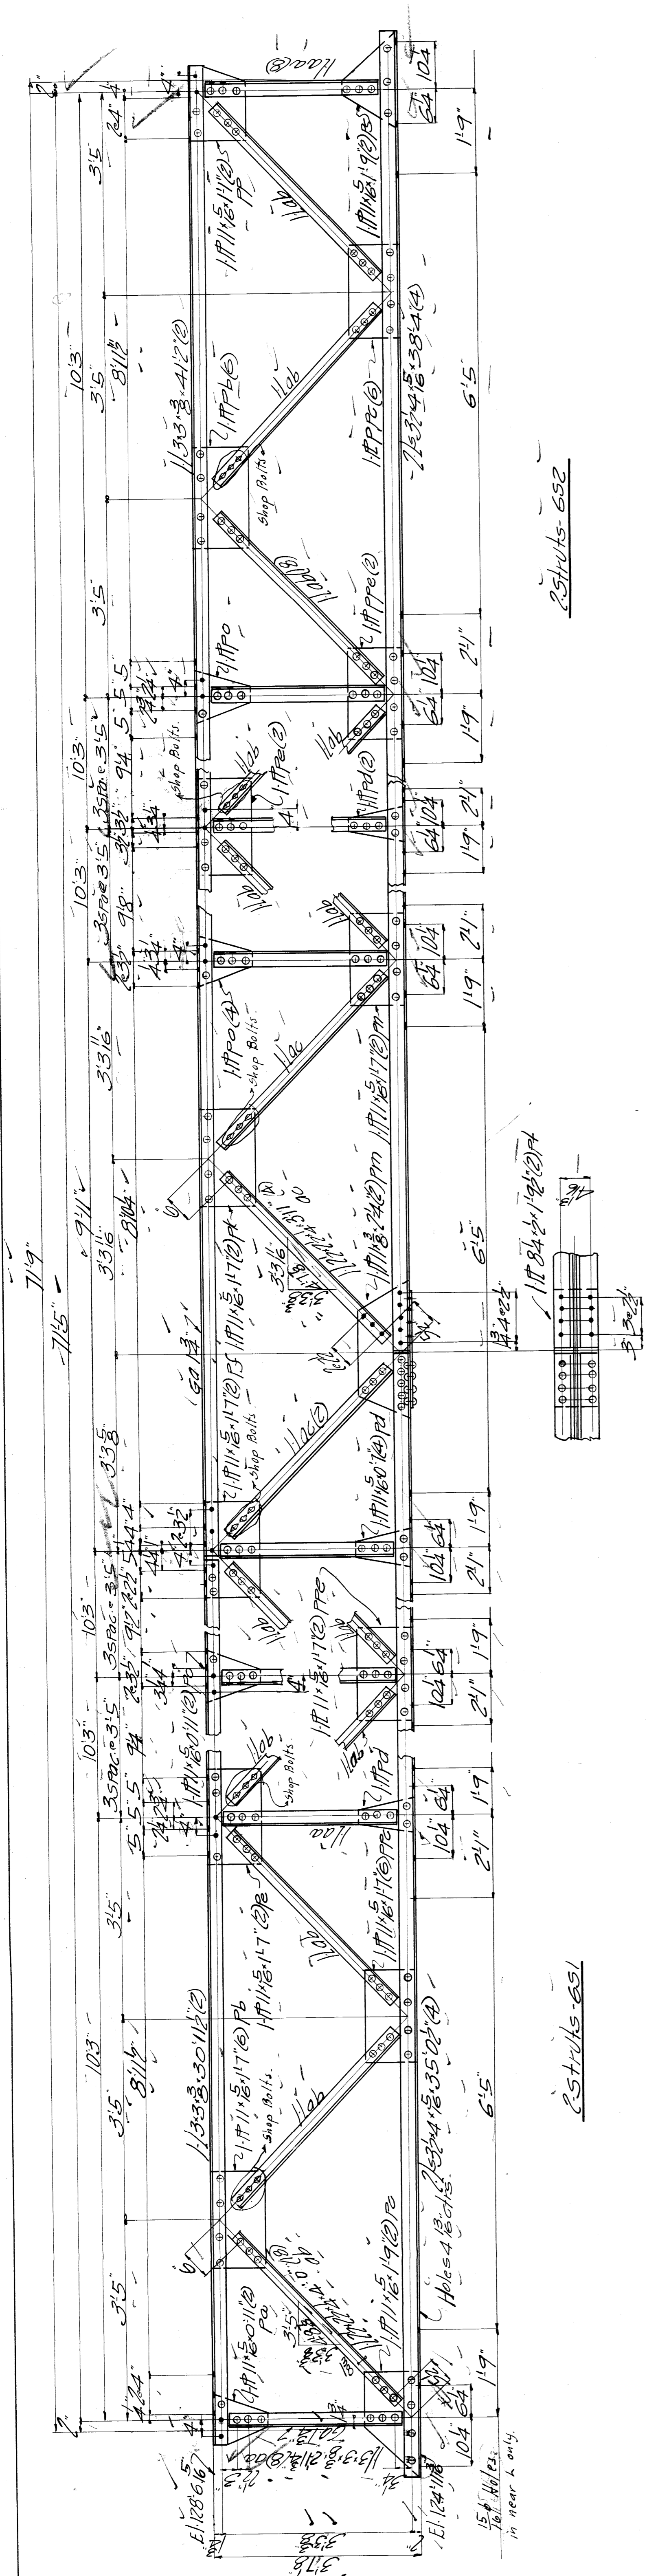

No.	Description	Part - Mat.
2	STRUTS	651 M64
2		652 M64
2		653 M66
2		654 M66
4		655A
2		656
2		657
2		658
2		659
16	Anchor Plates	6A1 M6





WISCONSIN BRIDGE & IRON CO.
NORTH MILWAUKEE, WIS.

FOR: *2100 Detroit*
LOCATION: *Bay of St. Ignace*
DESCRIPTION: *St. Ignace Bridge for 310*
DETAILS OF: *STRUTS*
SPECIFICATIONS: *See Specifications for 310*
INSPECTED BY: *Essays Murray*
REMARKS: *None*
ERECTED BY: *W.B. & I.C.*
SHOP PAINT: *None*
FIELD PAINT: *None*
MADE BY: *Leopold*
TRACED BY: *None*
CHECKED BY: *None*
SCALE: *1/4" = 1'-0"*
SECTION: *6*

DATE: *7/11/11*
DATE REVISION: *7/11/11*
DATE REVISION: *7/11/11*
DATE REVISION: *7/11/11*
DATE REVISION: *7/11/11*

SHEET No. 6
9379

FORM C-19 5-22 F-11E

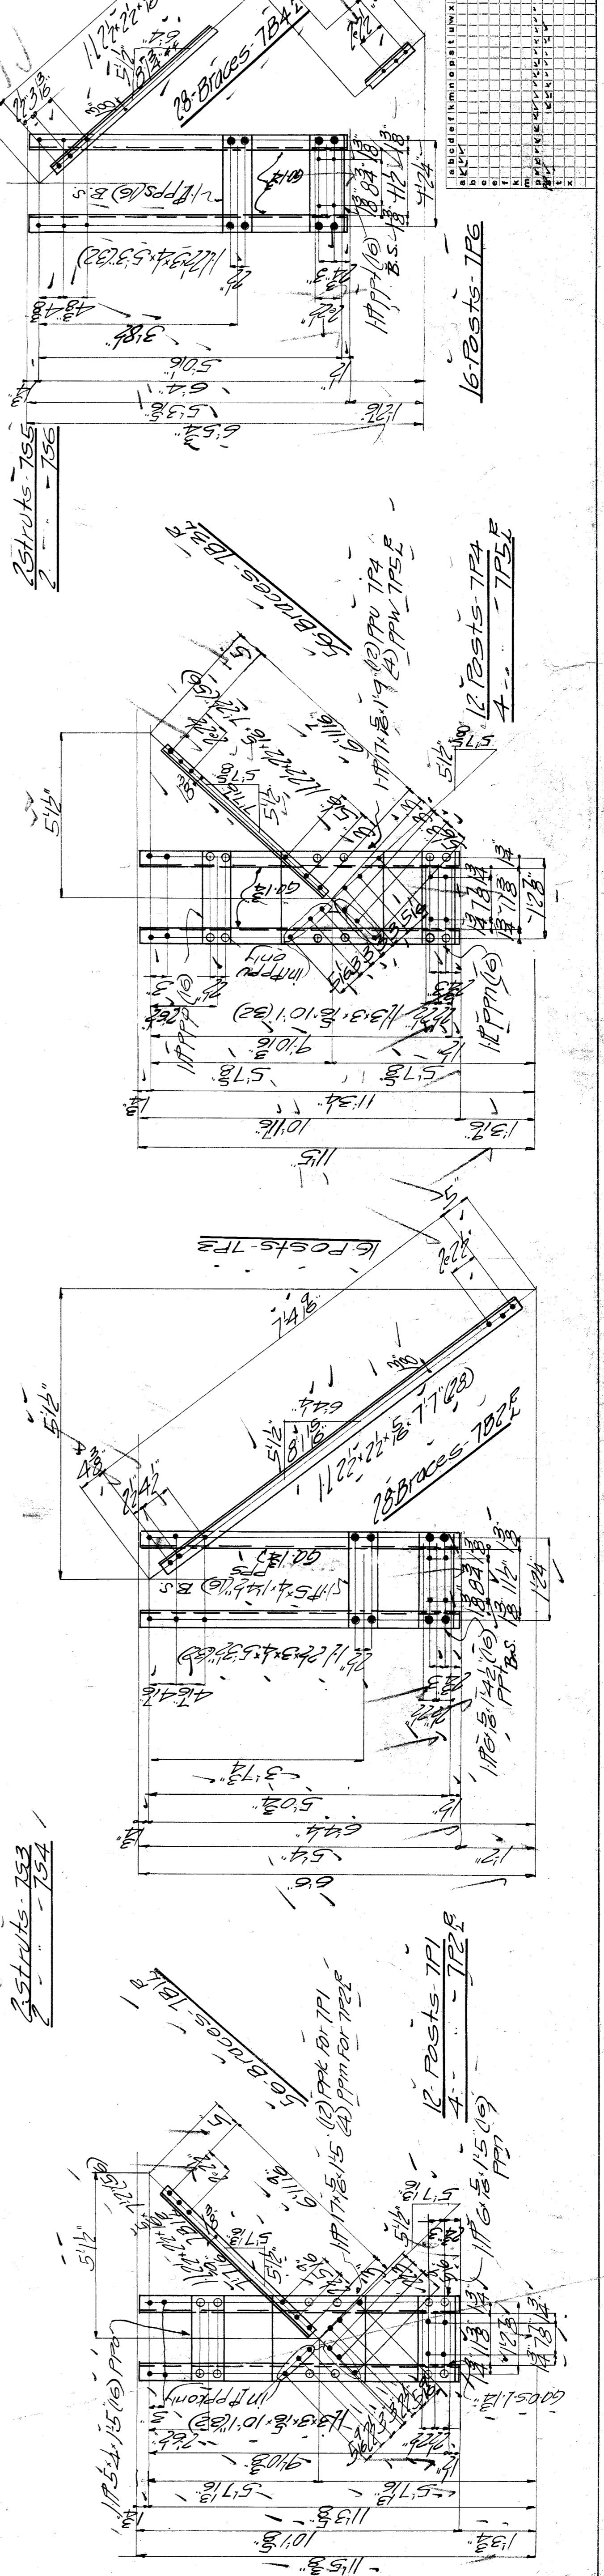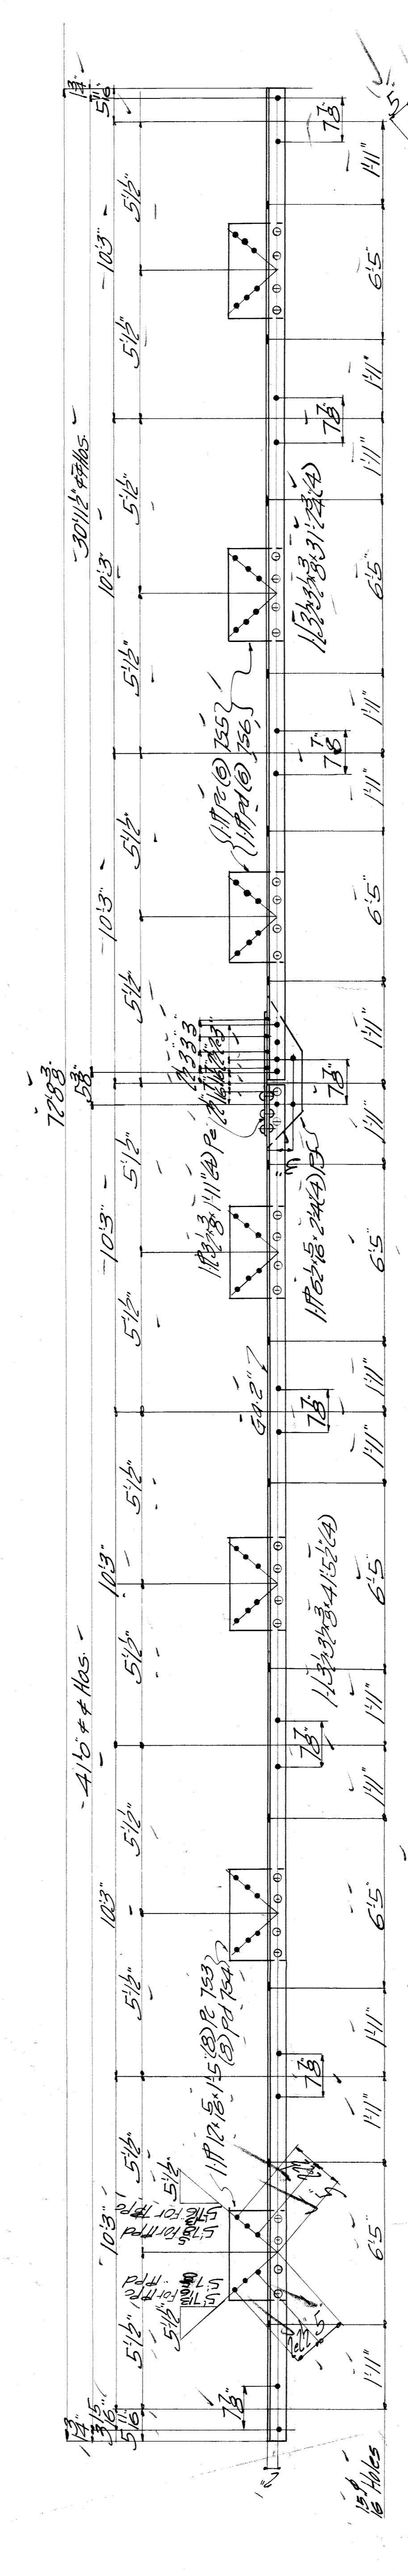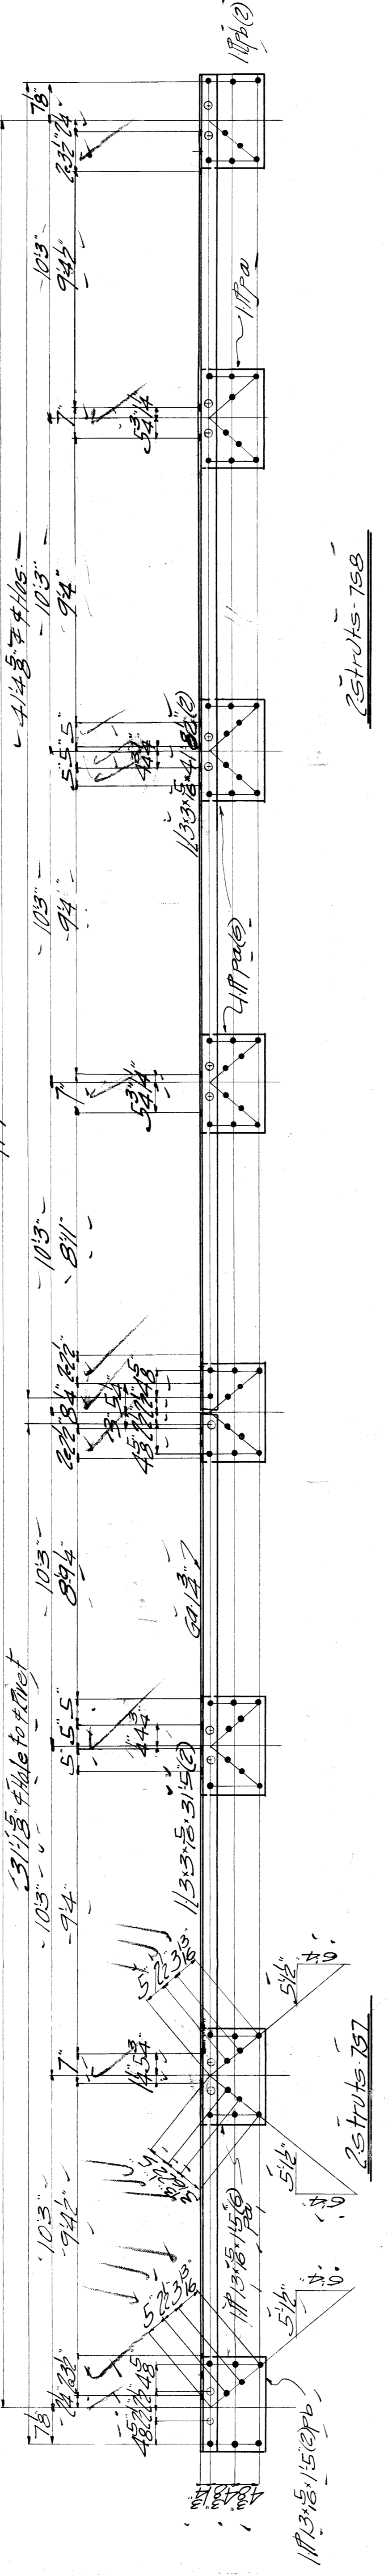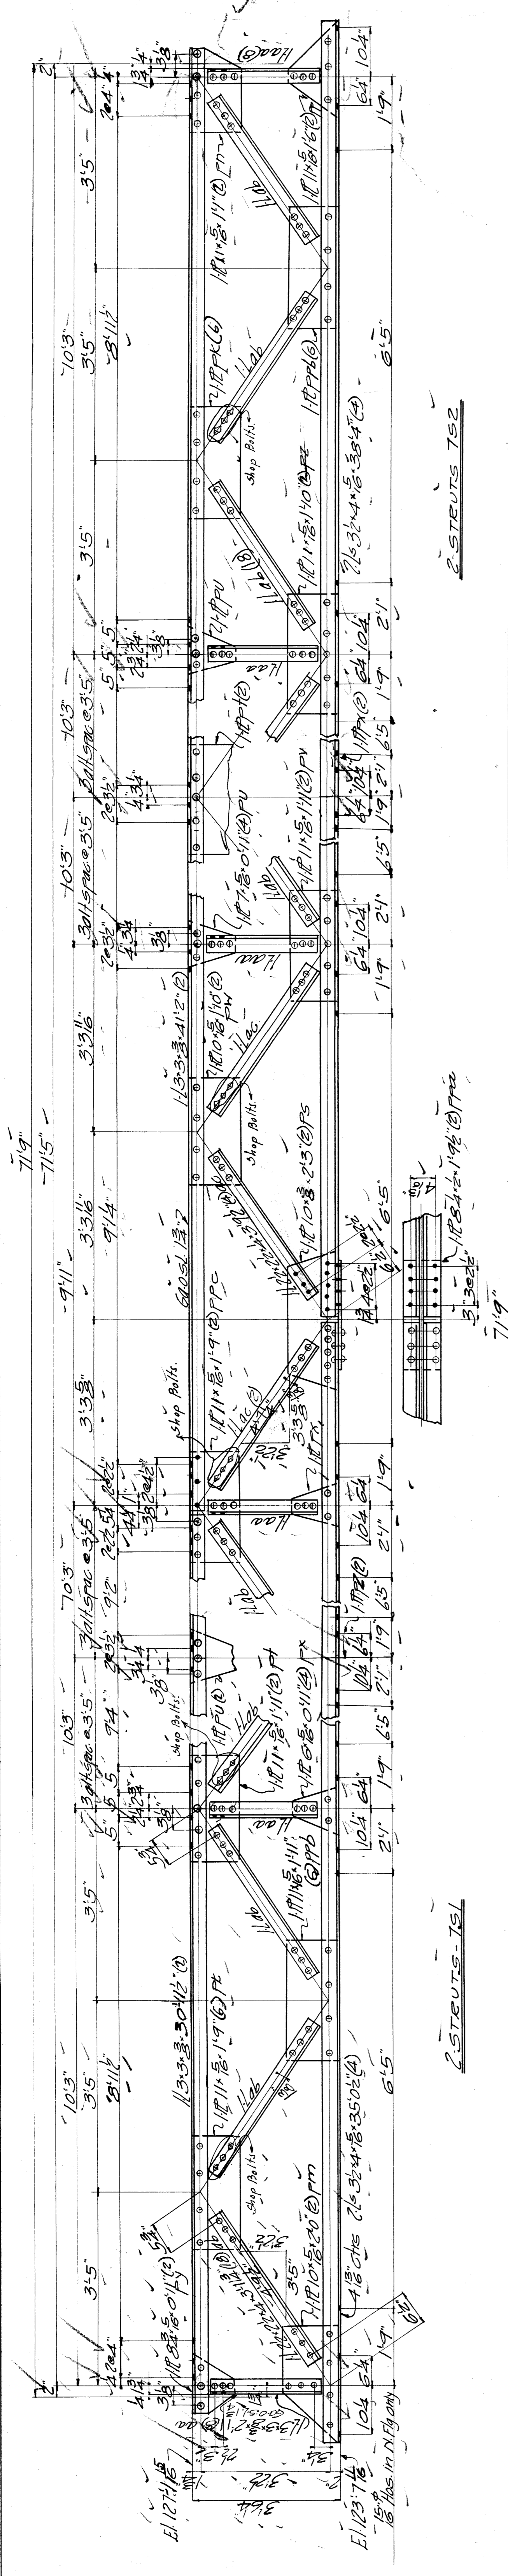

No.	Description	Markings
2	STRUTS	751 N10
2		752 N16
2		753
2		754
2		755 M10
2		756
2		757 N10
2		758
12	Posts	761 M10
4		762
12		763
4		764 M10
16		765
16		766
56	Braces	761 B M10
28		762 B
56		763 B M10
56		764 B



WISCONSIN BRIDGE & IRON CO.
NORTH MILWAUKEE, WIS.

FOR CITY OF DECATUR
LOCATION DECATUR ILLINOIS
DESCRIPTION BELLEVILLE BRIDGE, EAST
DETAILS OF STRUTS - FEBRUARY 1910
SPECIFICATIONS BRIDGE DEPARTMENT, DECATUR ILLINOIS
ERECTED BY W.B.I.C.O.
SHOP PAINT NOTE - See Specifications
FIELD PAINT NOTE - See Specifications

MADE BY LORRAINE DATE 9/25/10 RIVETS 3/8"
TRACED BY DATE 11/25/10 OPEN HOLES 1/2"
CHECKED BY DATE 11/25/10 UNLESS NOTED
SCALE SECTION


DATE REVISED: _____
SHEET No. 7
9379

Field Cont. 5-8-12 File BW 21-108

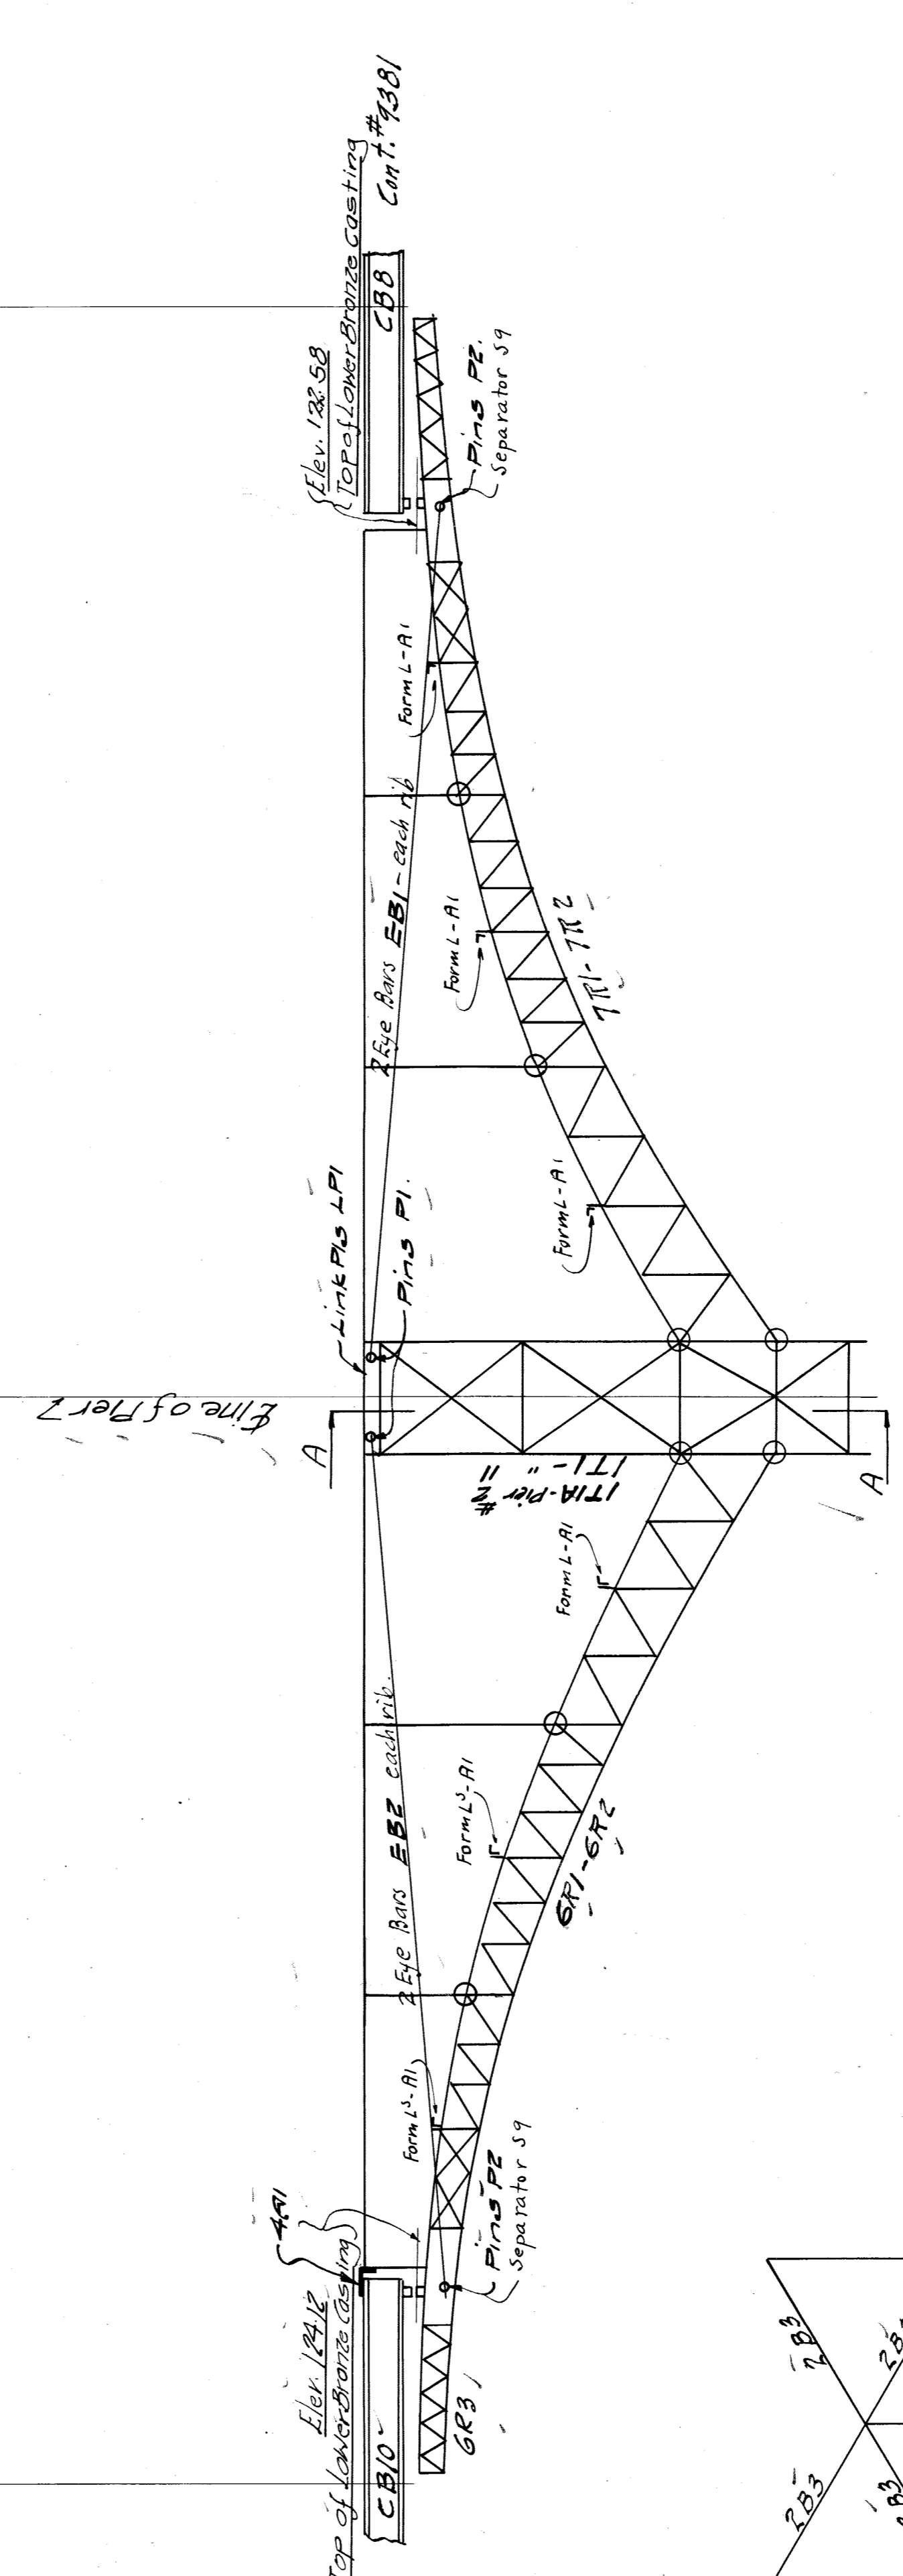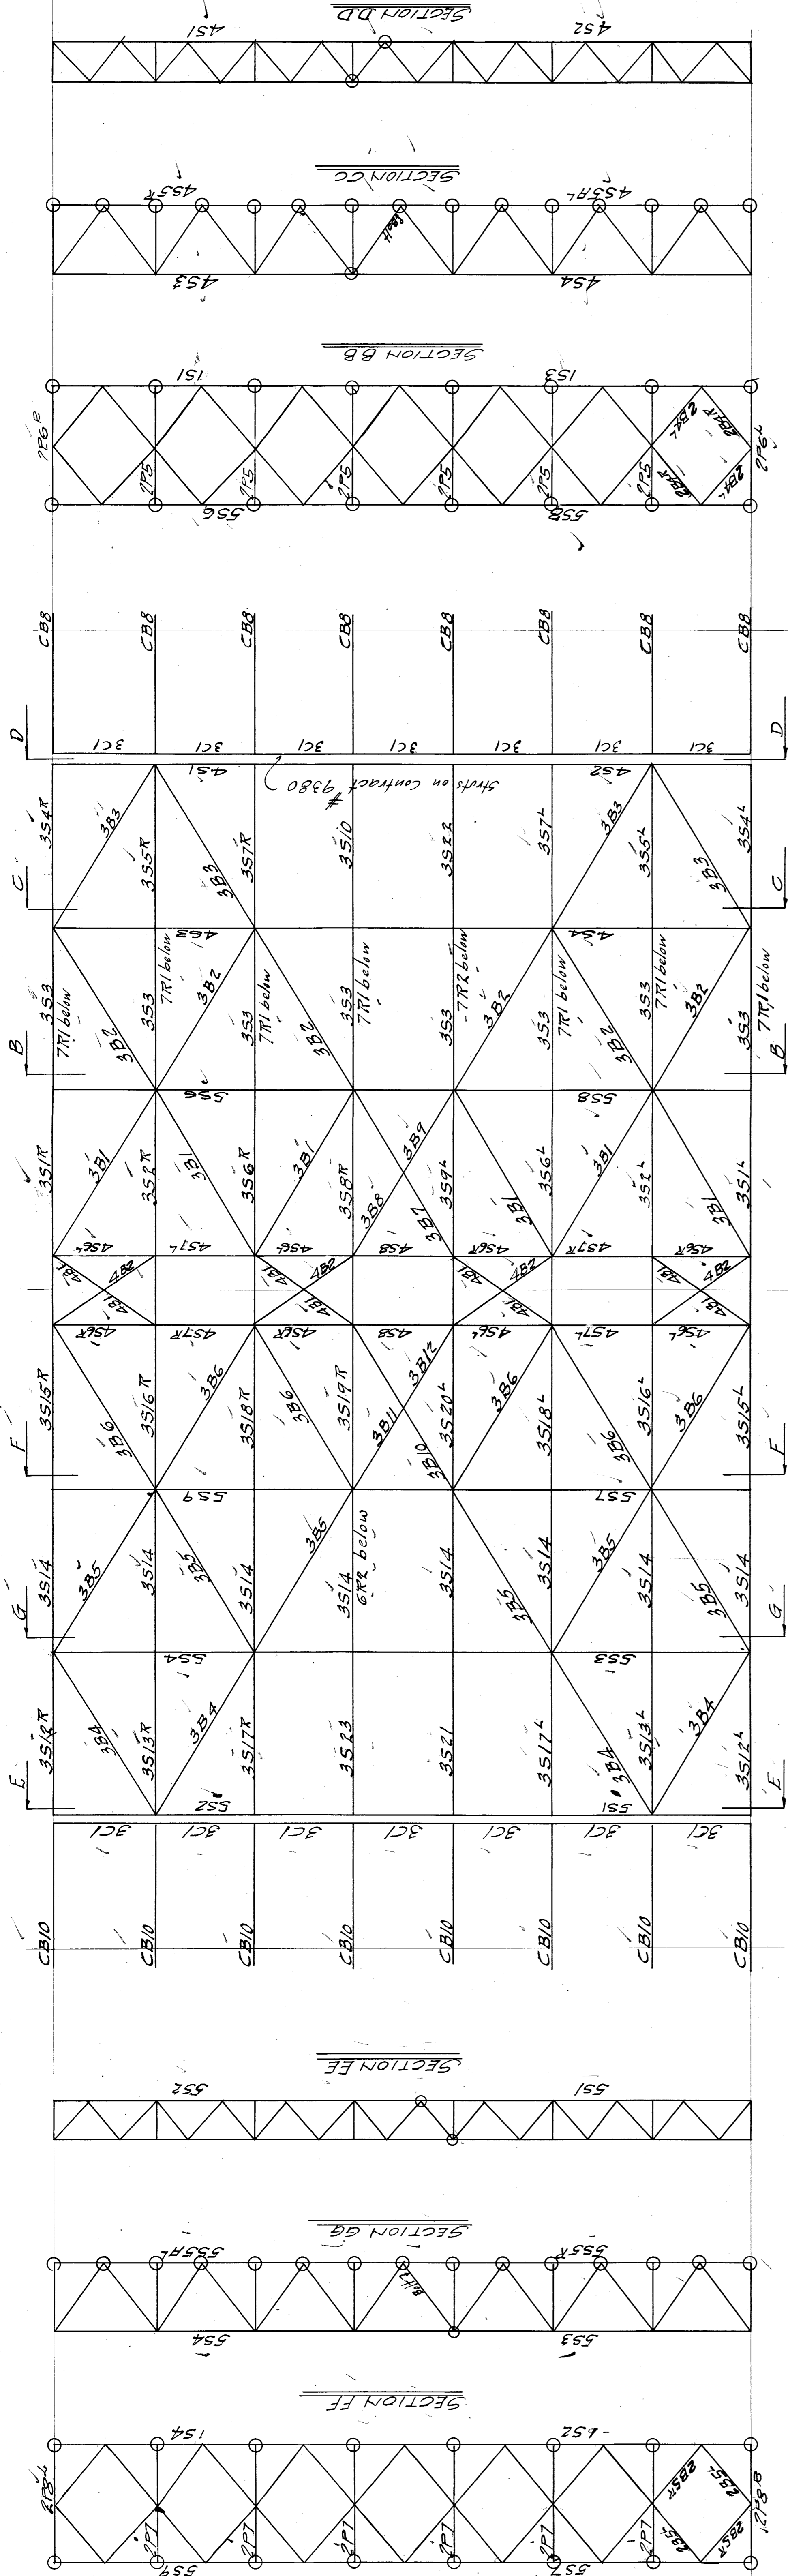

All points encircled thus O to be riveted.
 All other points bolted.

PIER #2-11-
 Pier #11 - Shown
 Pier #2 - Symm. by rotation.
 Form L1 Detailed on Bill #305-Cont #377

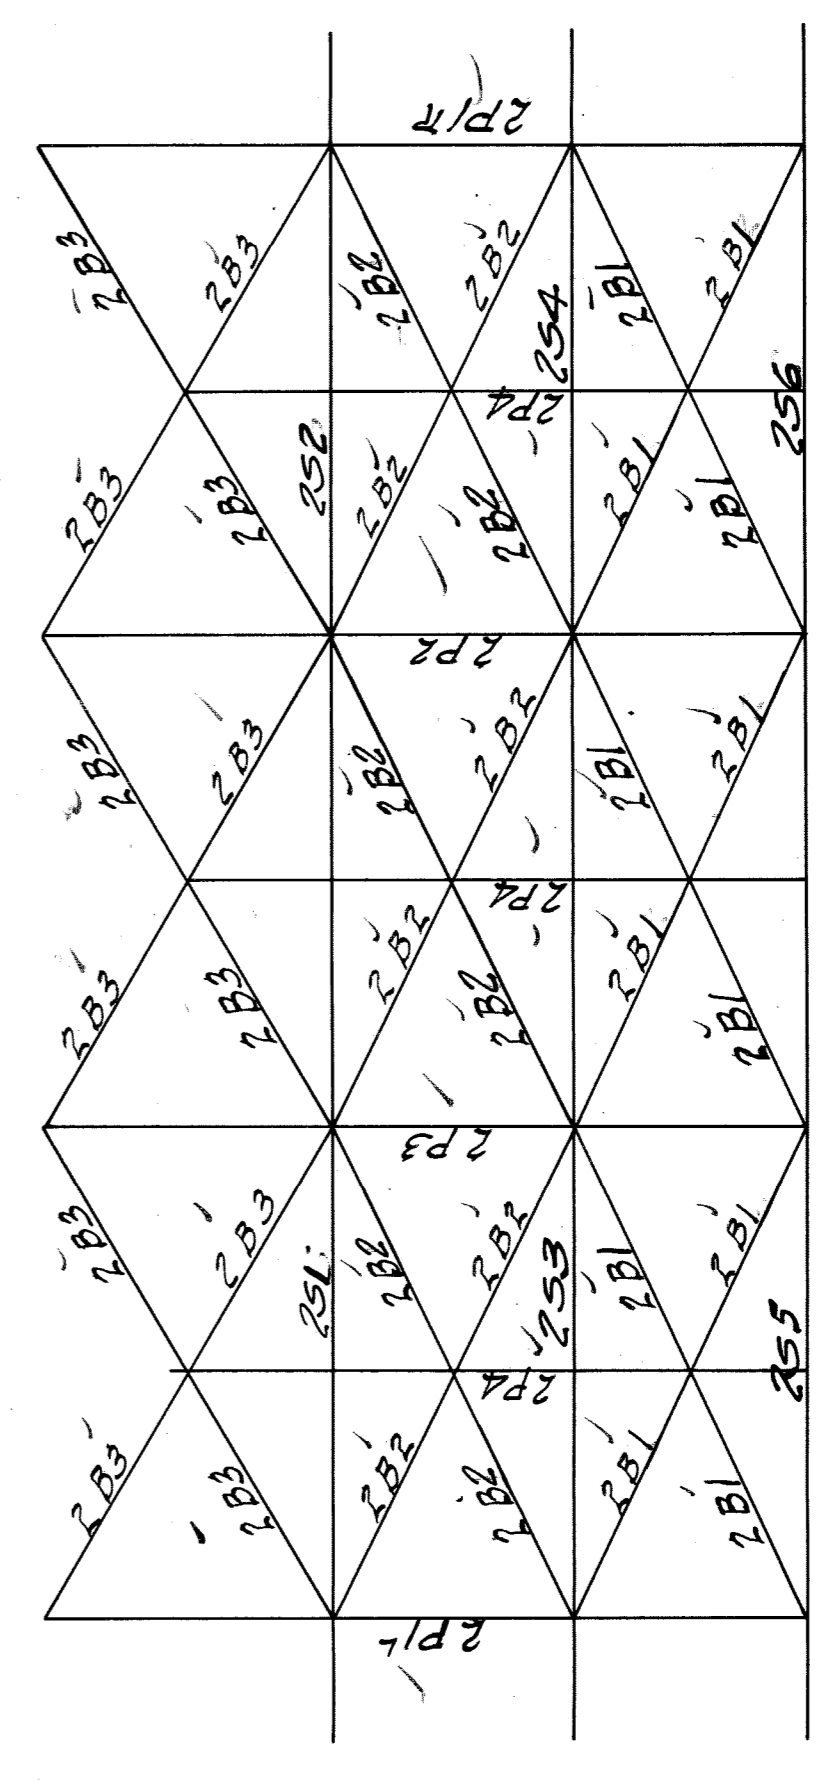

Braiding on line of Pier
 SECTION AA

WISCONSIN BRIDGE & IRON CO.
 NORTH MILWAUKEE, WIS.

FOR: CITY OF DETROIT
 LOCATION: DETROIT MI
 DESCRIPTION: BELLEVILLE BRIDGE Pier 2-11
 DETAILS OF: SECTION 11-11

SPECIFICATIONS
 REAMING
 INSPECTION BY
 SHOP PAINT

MADE BY: Lerville DATE: 7/27/12
 TRACED BY: Merson DATE: DATE
 CHECKED BY: DATE: DATE



FIELD PAINT
 MADE BY: Lerville DATE: 7/27/12
 TRACED BY: Merson DATE: DATE
 CHECKED BY: DATE: DATE

OPEN HOLES
 UNLESS NOTED

SCALE: 1/8" = 1'-0"
 SECTION: 11-11

SHEET No. E1

9380

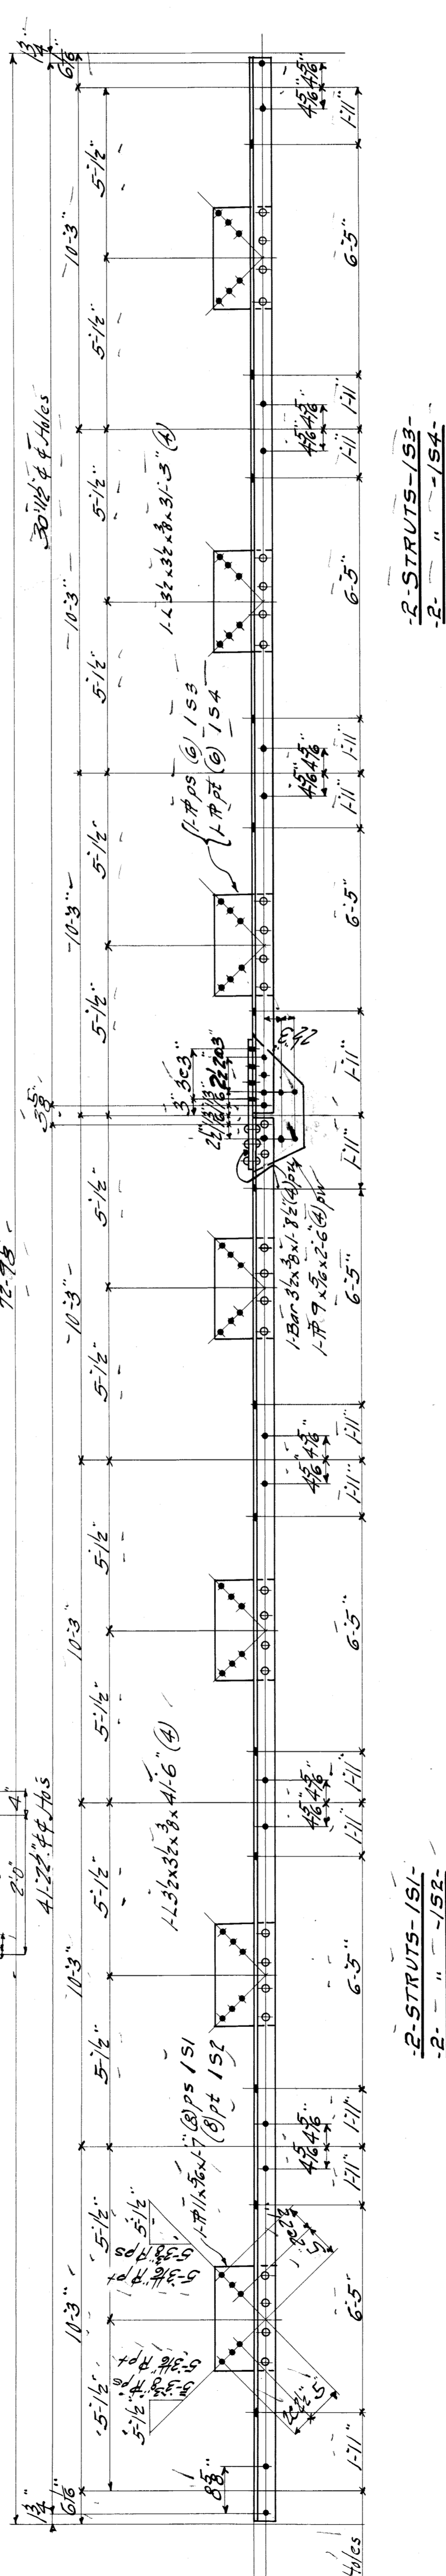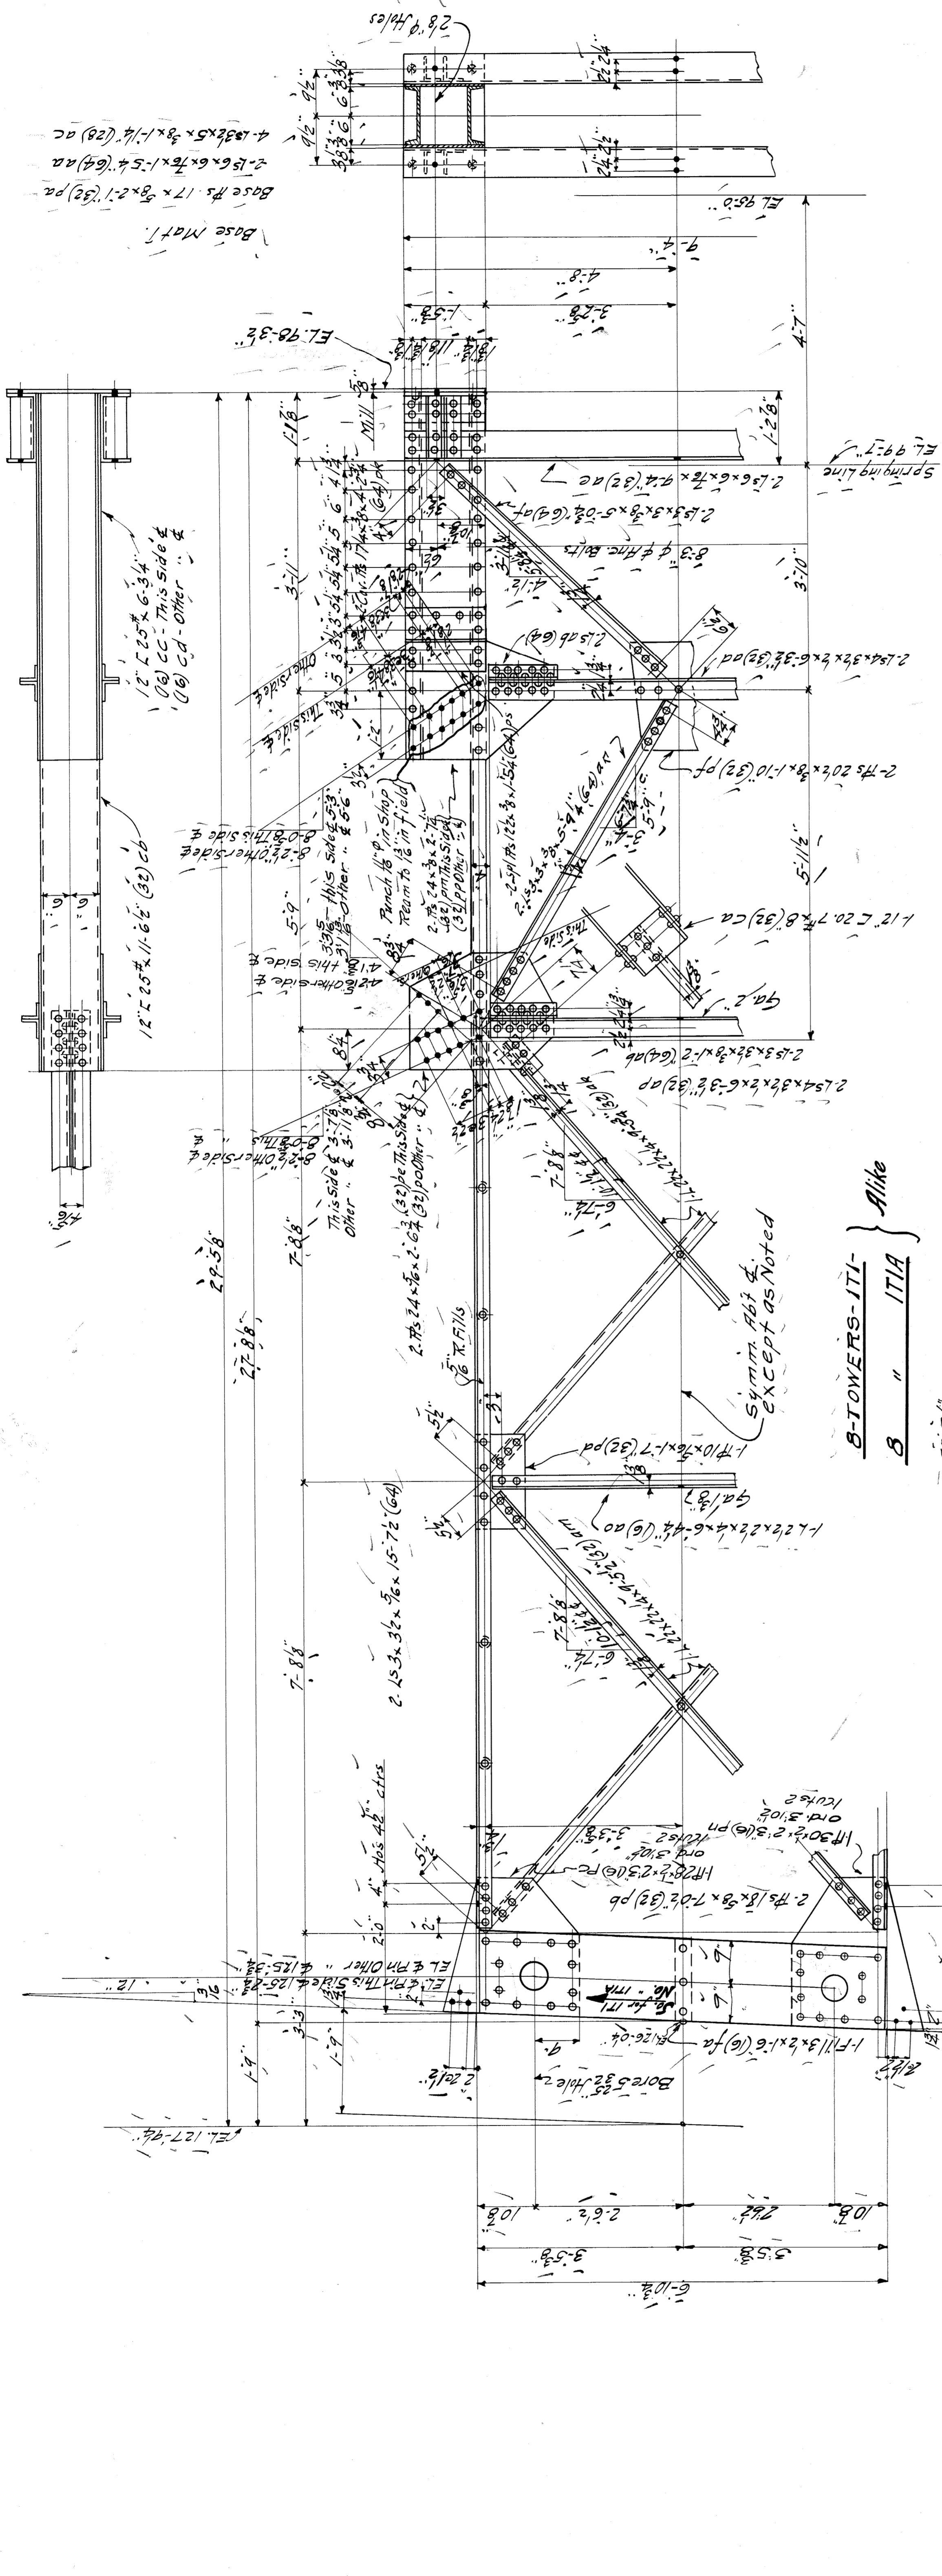

Summary of Parts





No.	Description	Quantity	Remarks
1	8 Towers	171	
2	2 Struts	151	
3	2 "	152	
4	2 "	153	
5	8 Towers	171A	

WISCONSIN BRIDGE & IRON CO.
NORTH MILWAUKEE, WIS.

FOR City of Detroit
LOCATION Detroit Mich
DESCRIPTION Belle Isle Bridge
DETAILS OF Towers & Struts
SPECIFICATIONS by the Engineering
INSPECTED BY None (See Specifications)
FIELD PAINT None
MADE BY CNA DATE 7-30-22
TRACED BY S.M.M. DATE 12-28-22 OPEN HOLES 1/8"
CHECKED BY J.M.M. DATE 1-11-23 UNLESS NOTED
SCALE DATE REVISED SHEET No. 1
SECTION

9380

F. Ed. by CNA File BW 201-200

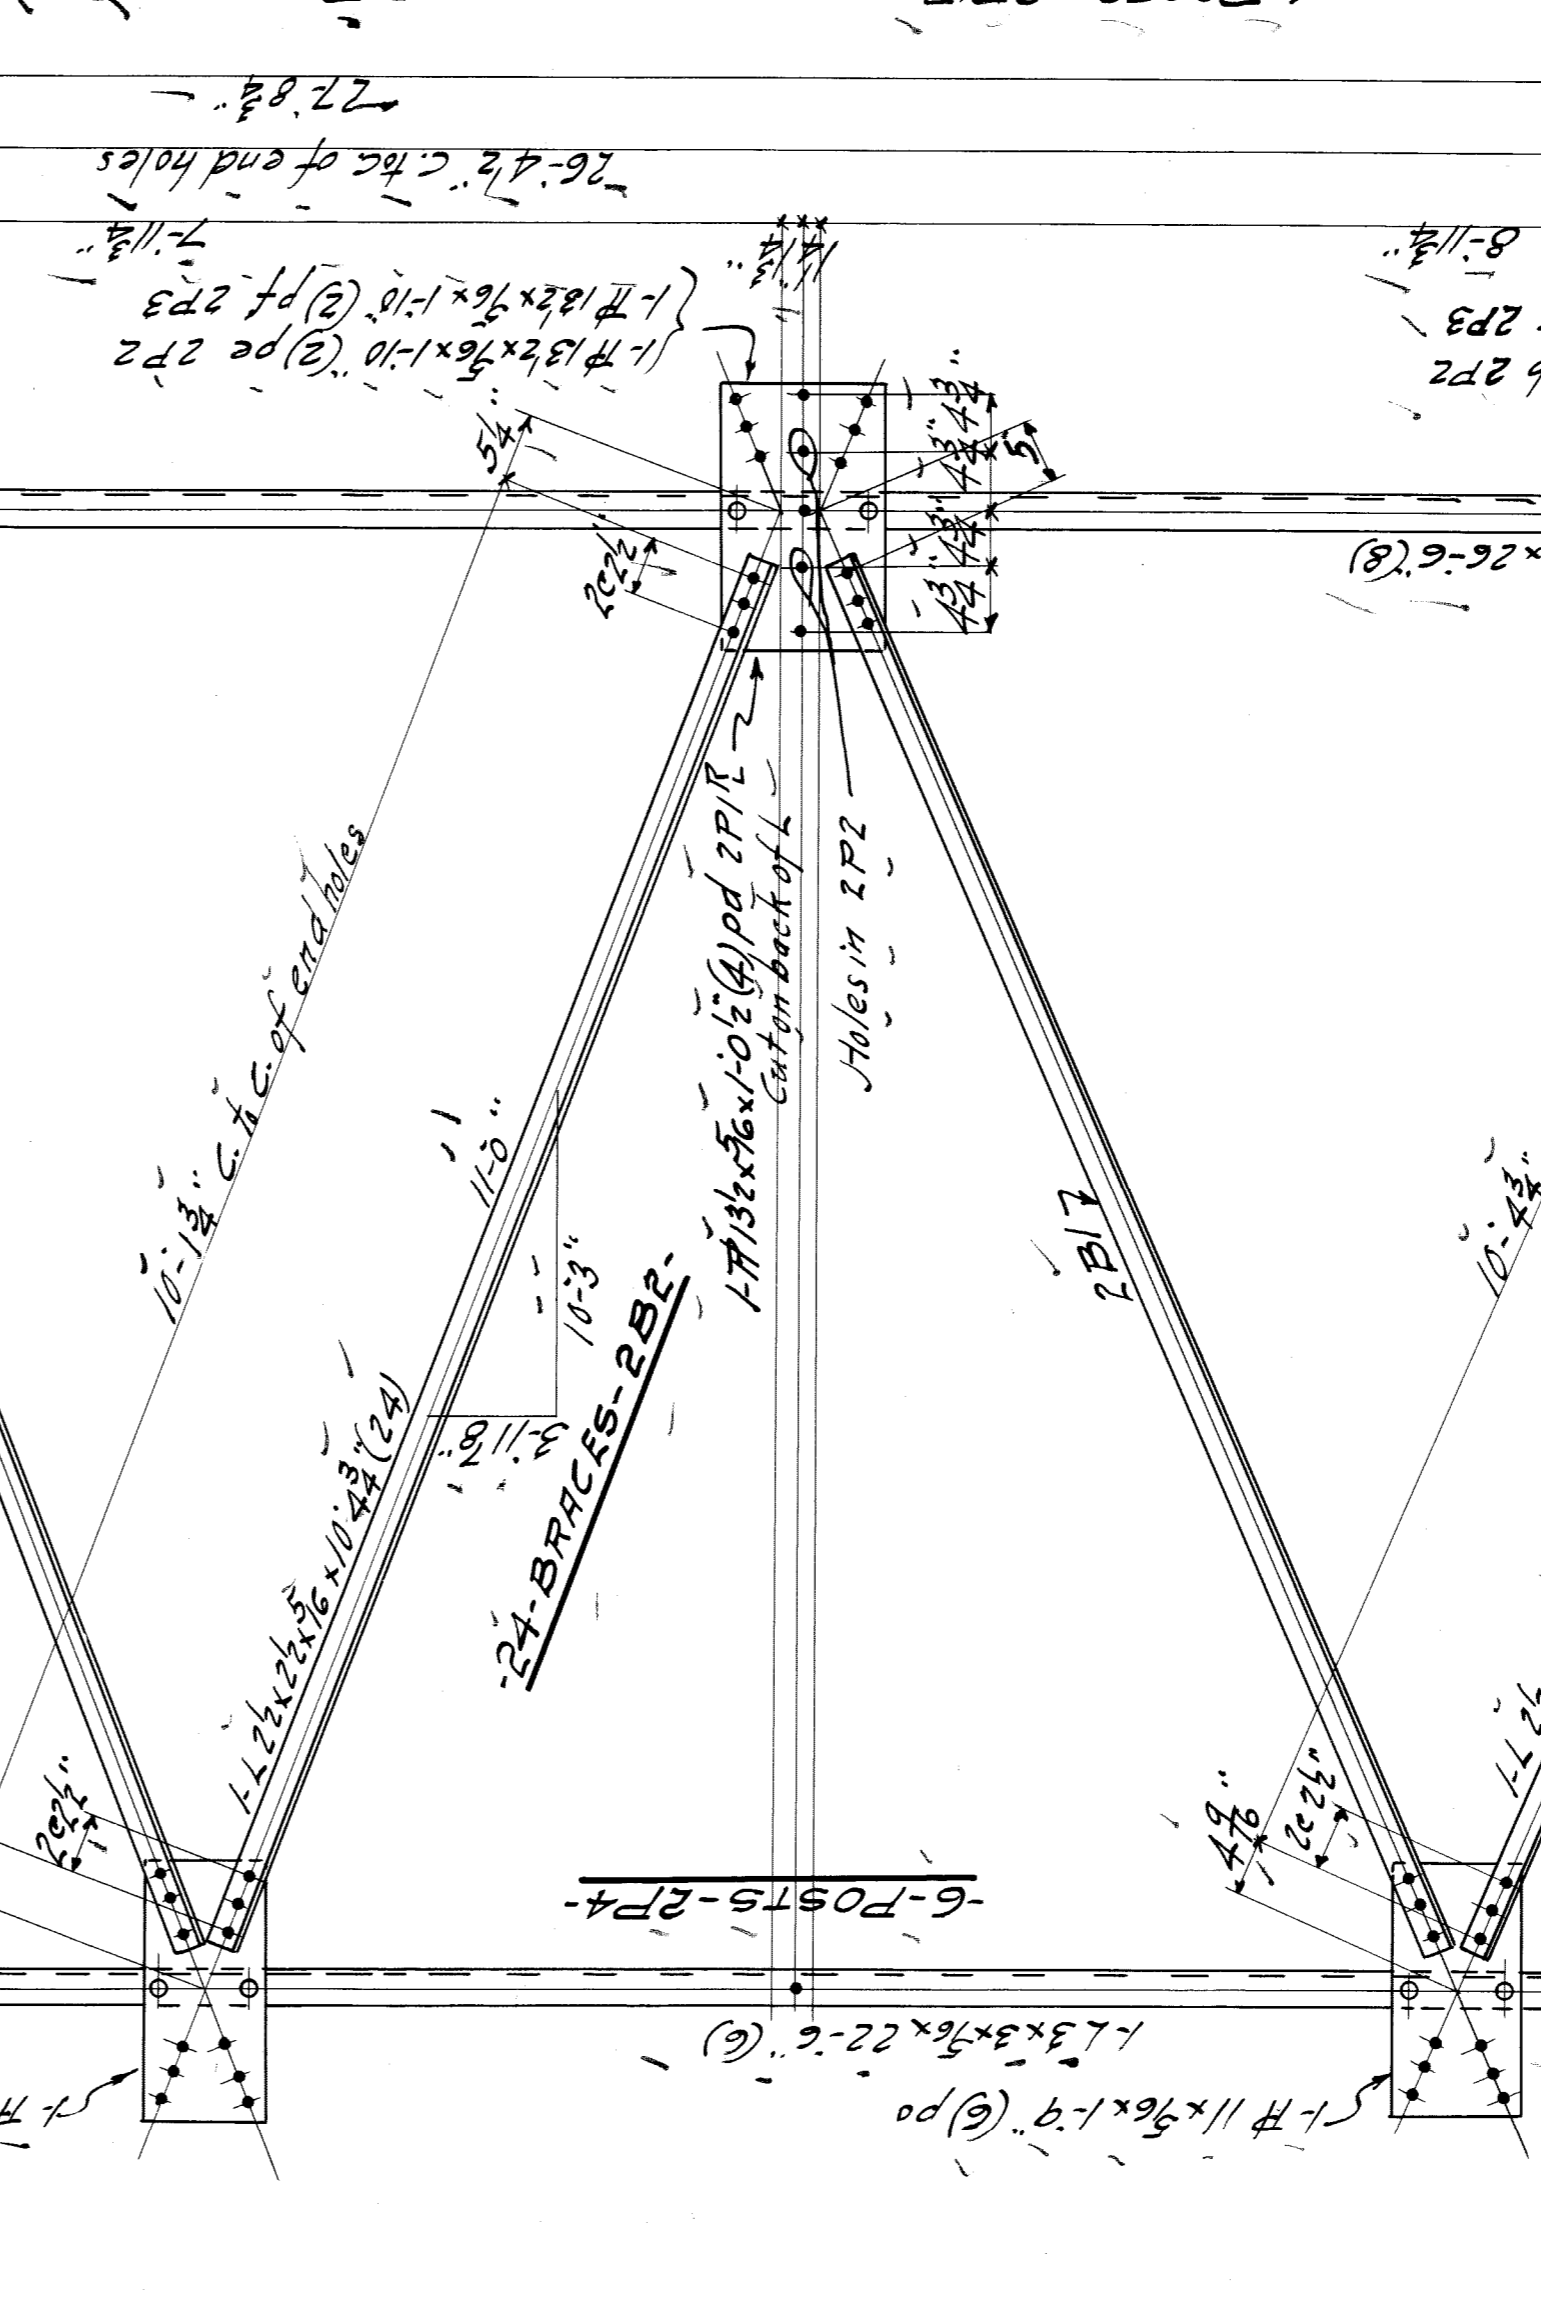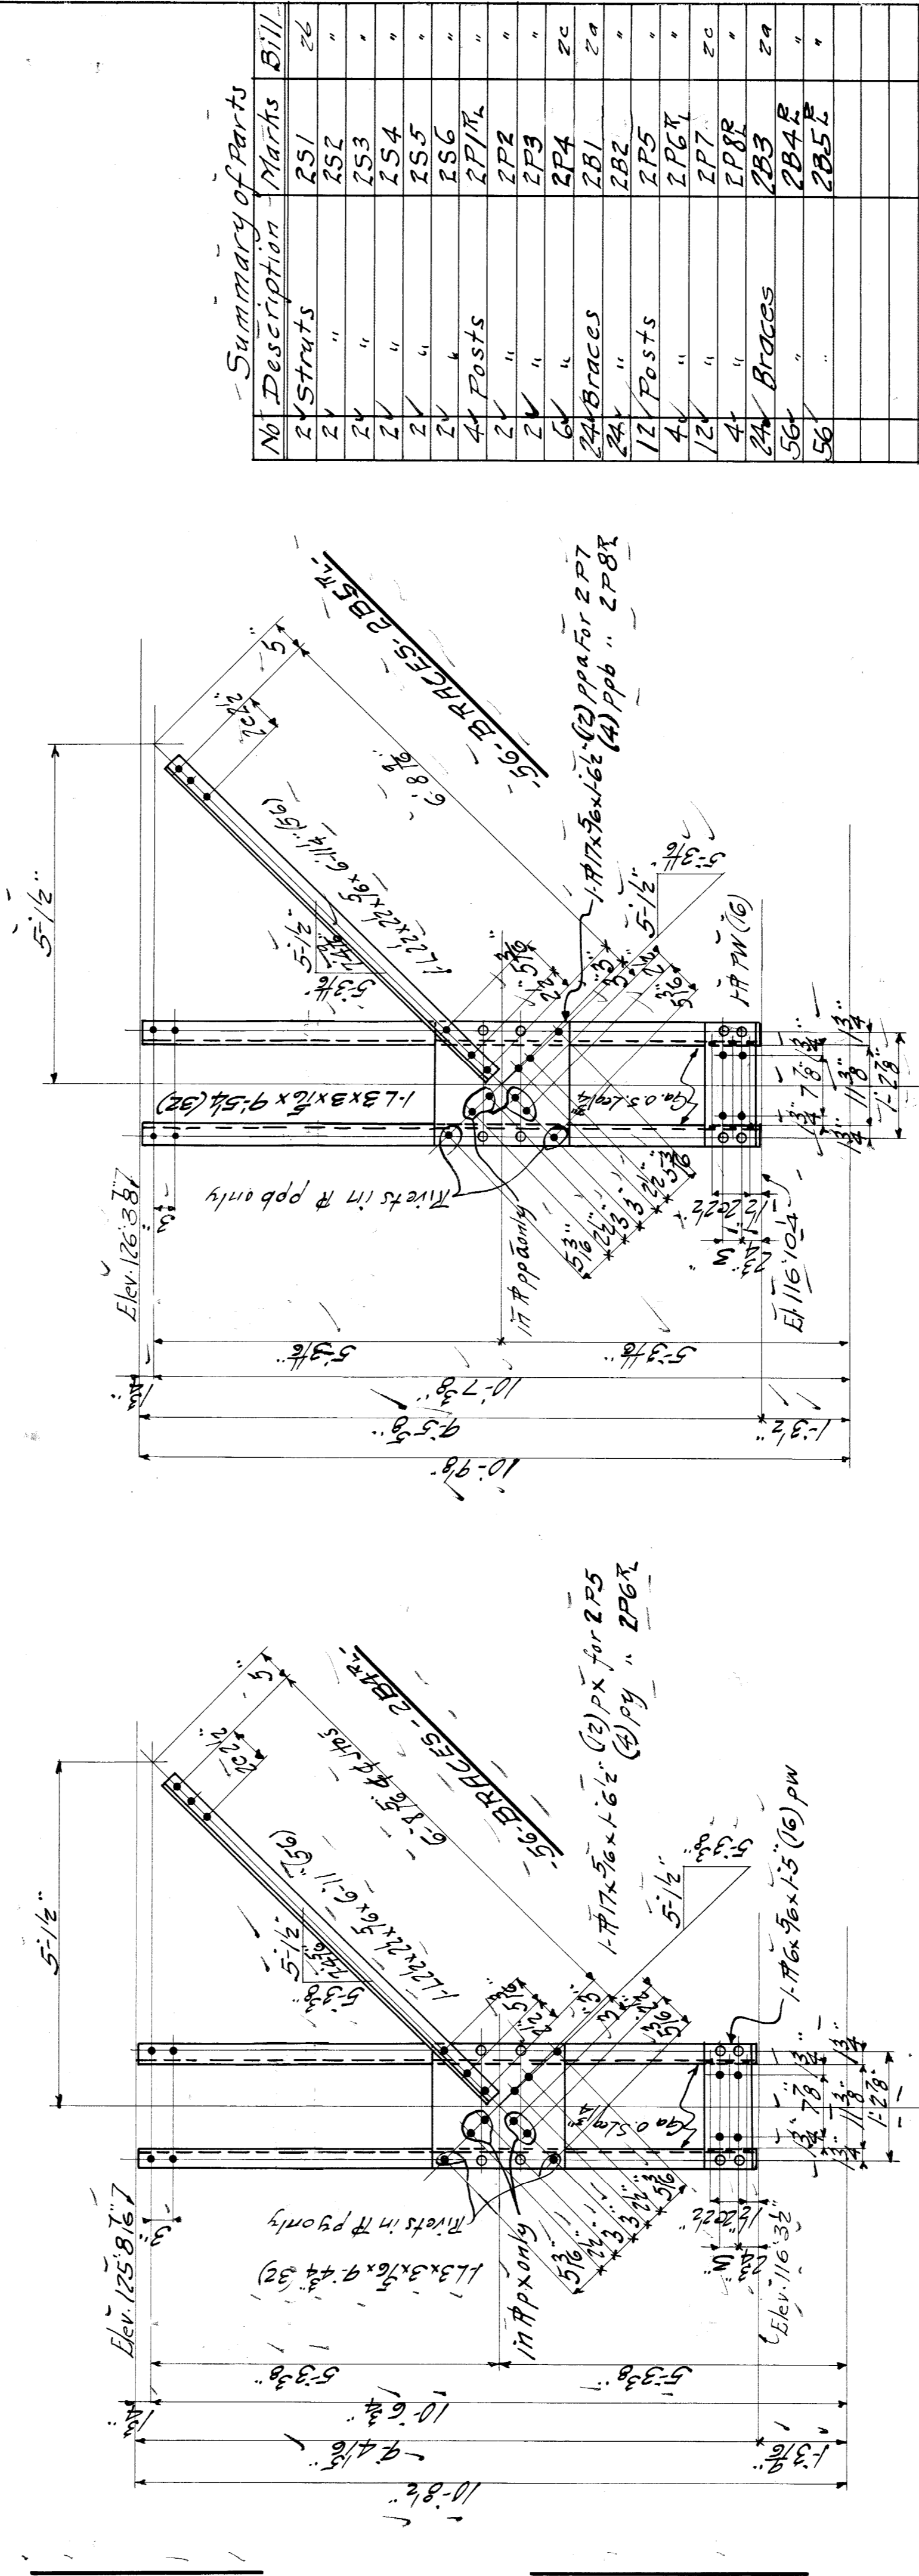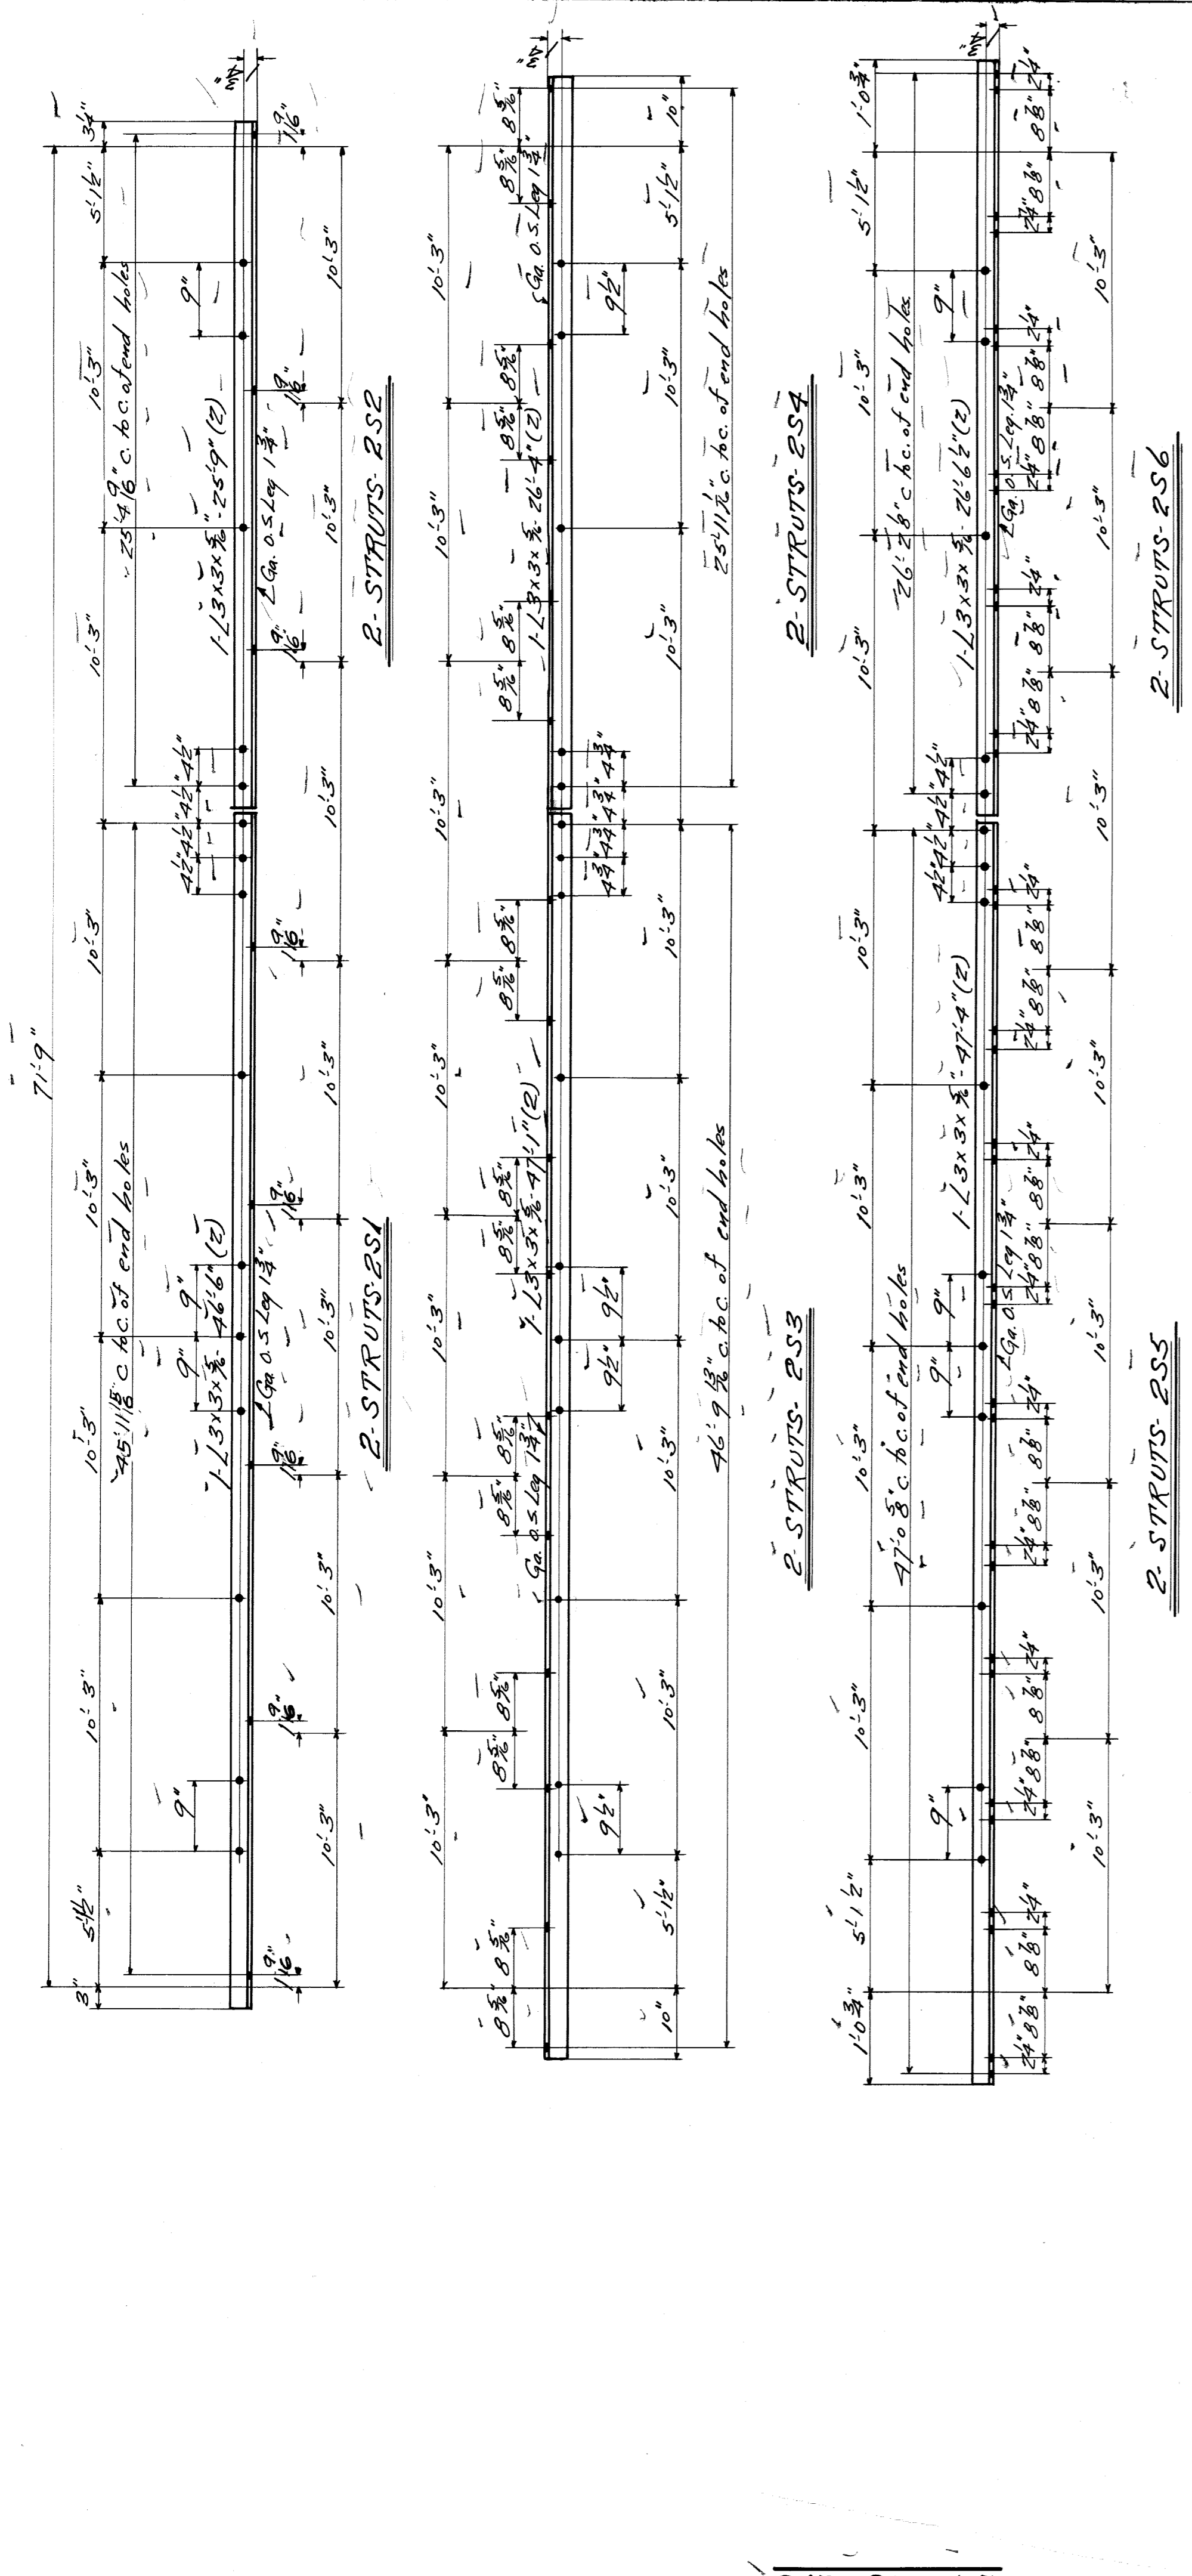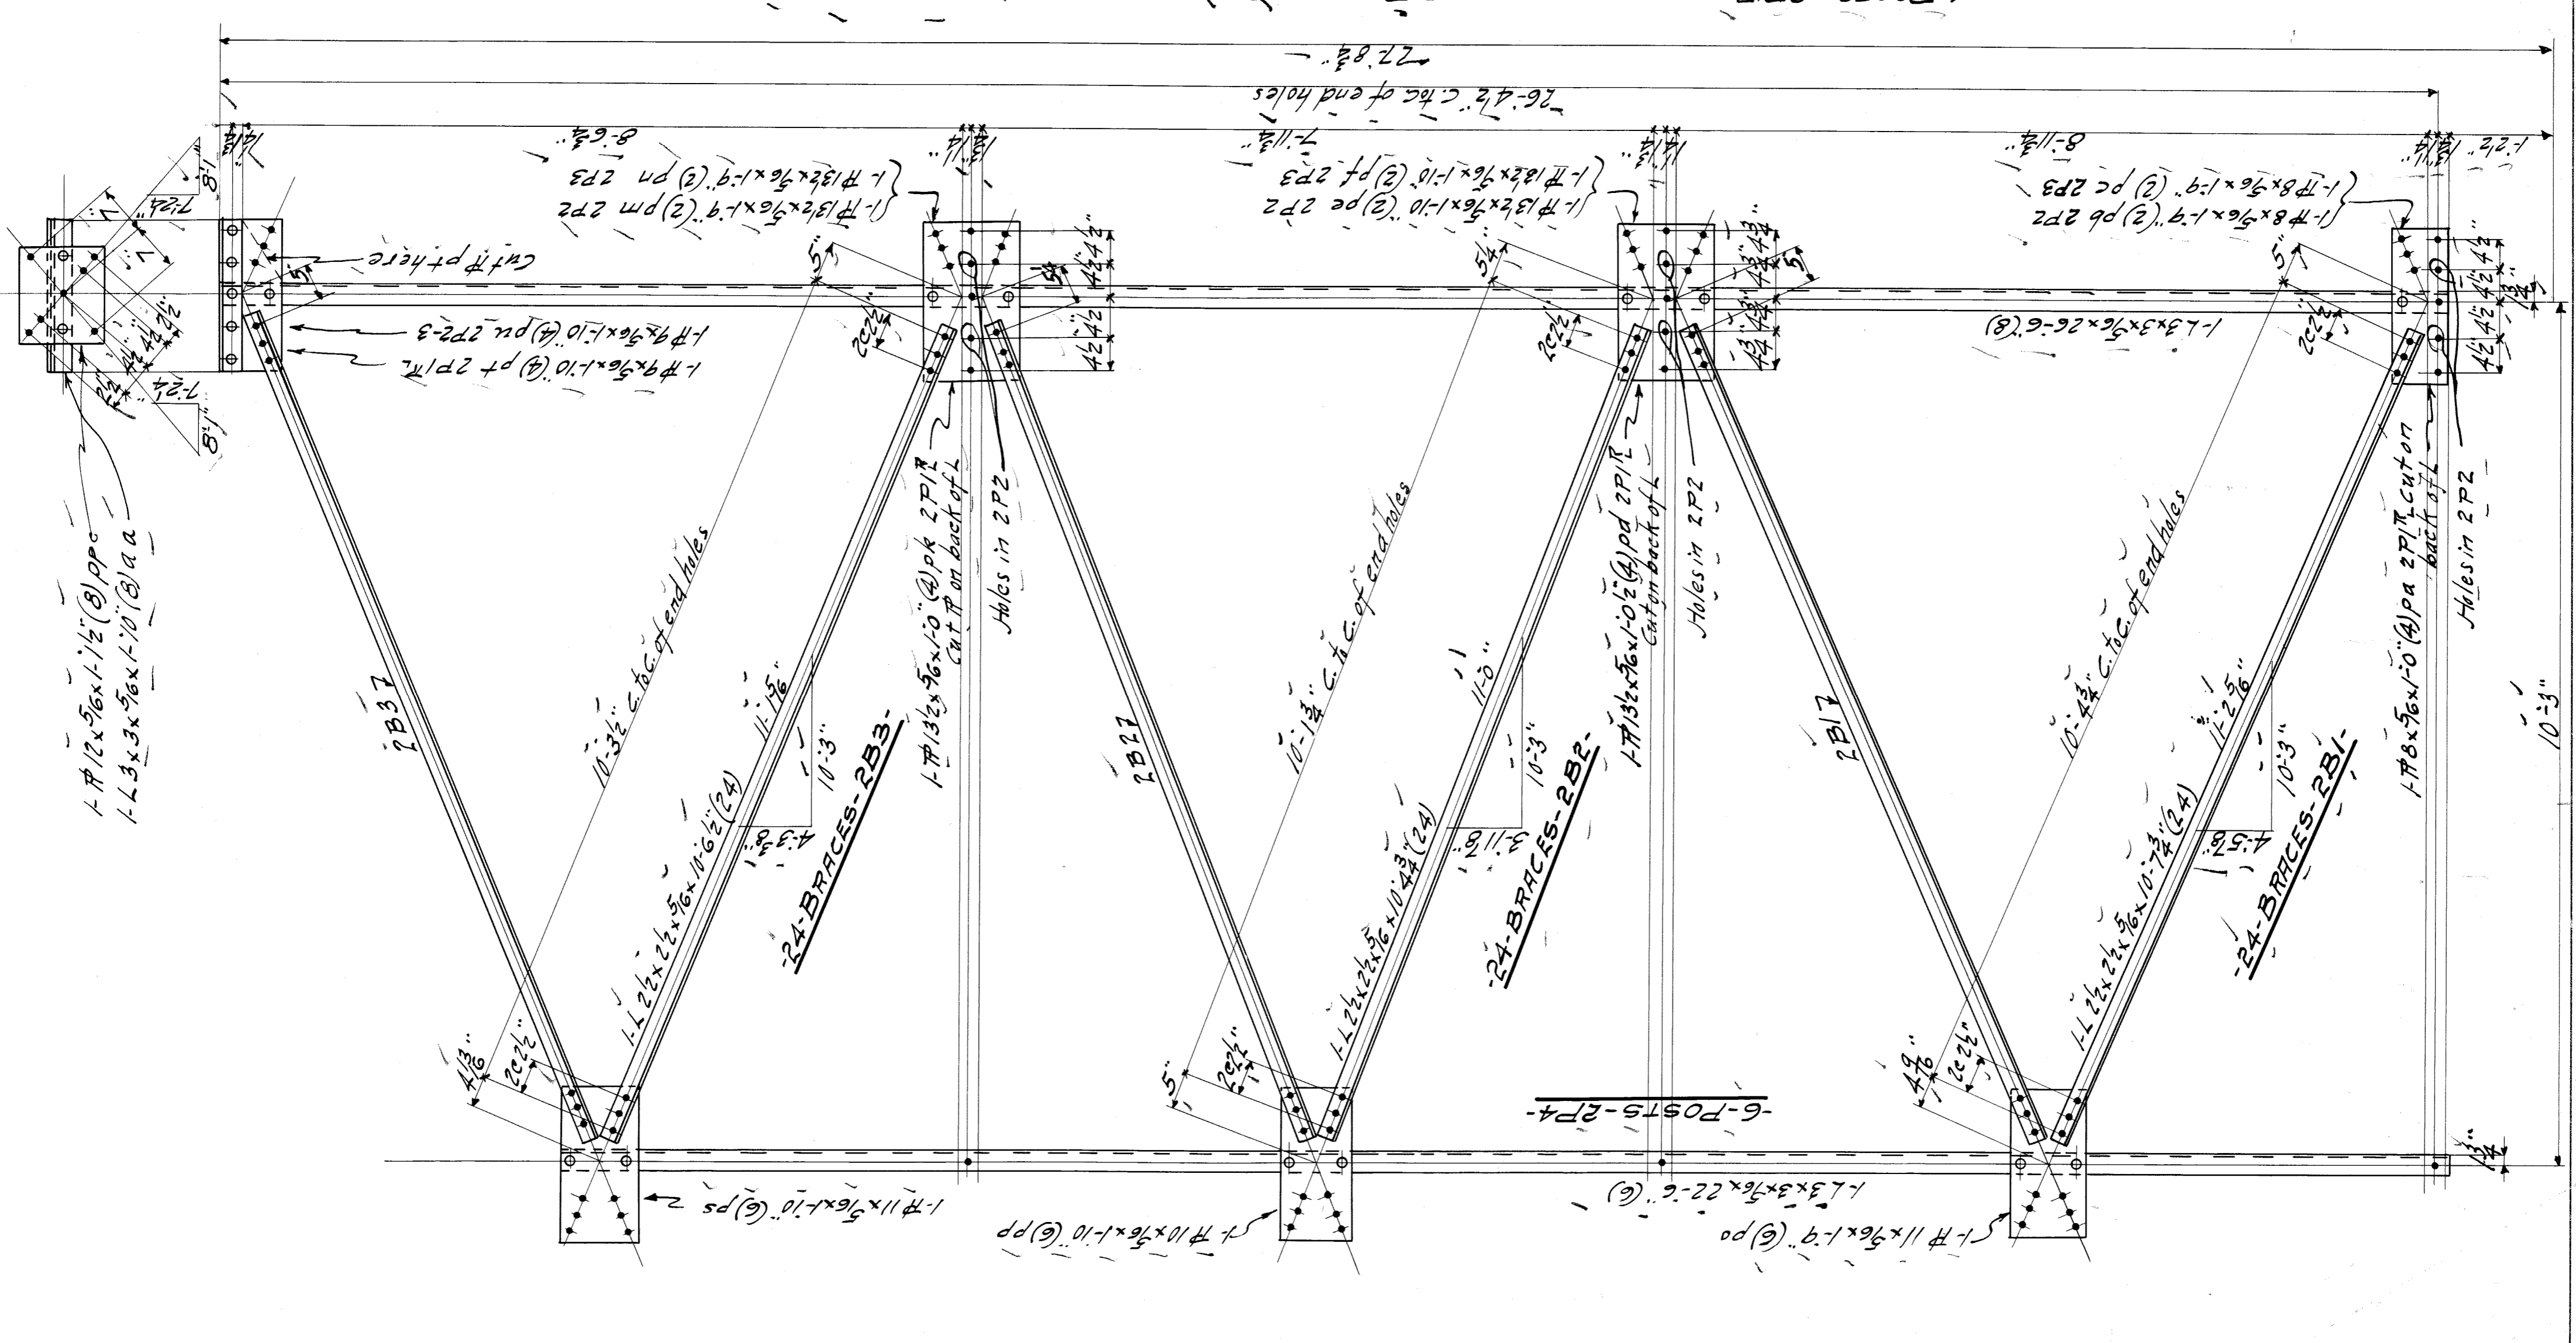


Summary of Parts

No	Description	Marks	Bill
21	21 Struts	2S1	26
22	"	2S2	"
23	"	2S3	"
24	"	2S4	"
25	"	2S5	"
26	"	2S6	"
27	4 Posts	2P1	"
28	"	2P2	"
29	"	2P3	"
30	"	2P4	"
31	24 Braces	2B1	24
32	"	2B2	"
33	"	2B3	"
34	"	2B4	"
35	"	2B5	"
36	"	2B6	"
37	"	2B7	"
38	"	2B8	"
39	"	2B9	"
40	"	2B10	"

WISCONSIN BRIDGE & IRON CO.
NORTH MILWAUKEE, WIS.


FOR CITY of Detroit
LOCATION Detroit, Mich
DESCRIPTION Belle Isle Bridge
DETAILS OF BRIDGE STRUTS - Piers 2-11
SPECIFICATIONS Design Murphy, REAMING
INSPECTED BY
SHOP PAINT None (See Specifications)
FIELD PAINT
MADE BY M. P. DATES 8/17/21 RIVETS 3/8"
TRACED BY S. P. DATES 8/22/21 OPEN HOLES 1/2"
CHECKED BY M. P. DATES 8/22/21 UNLESS NOTED
SCALE DATE REVISED. SHEET NO. **2**
SECTION

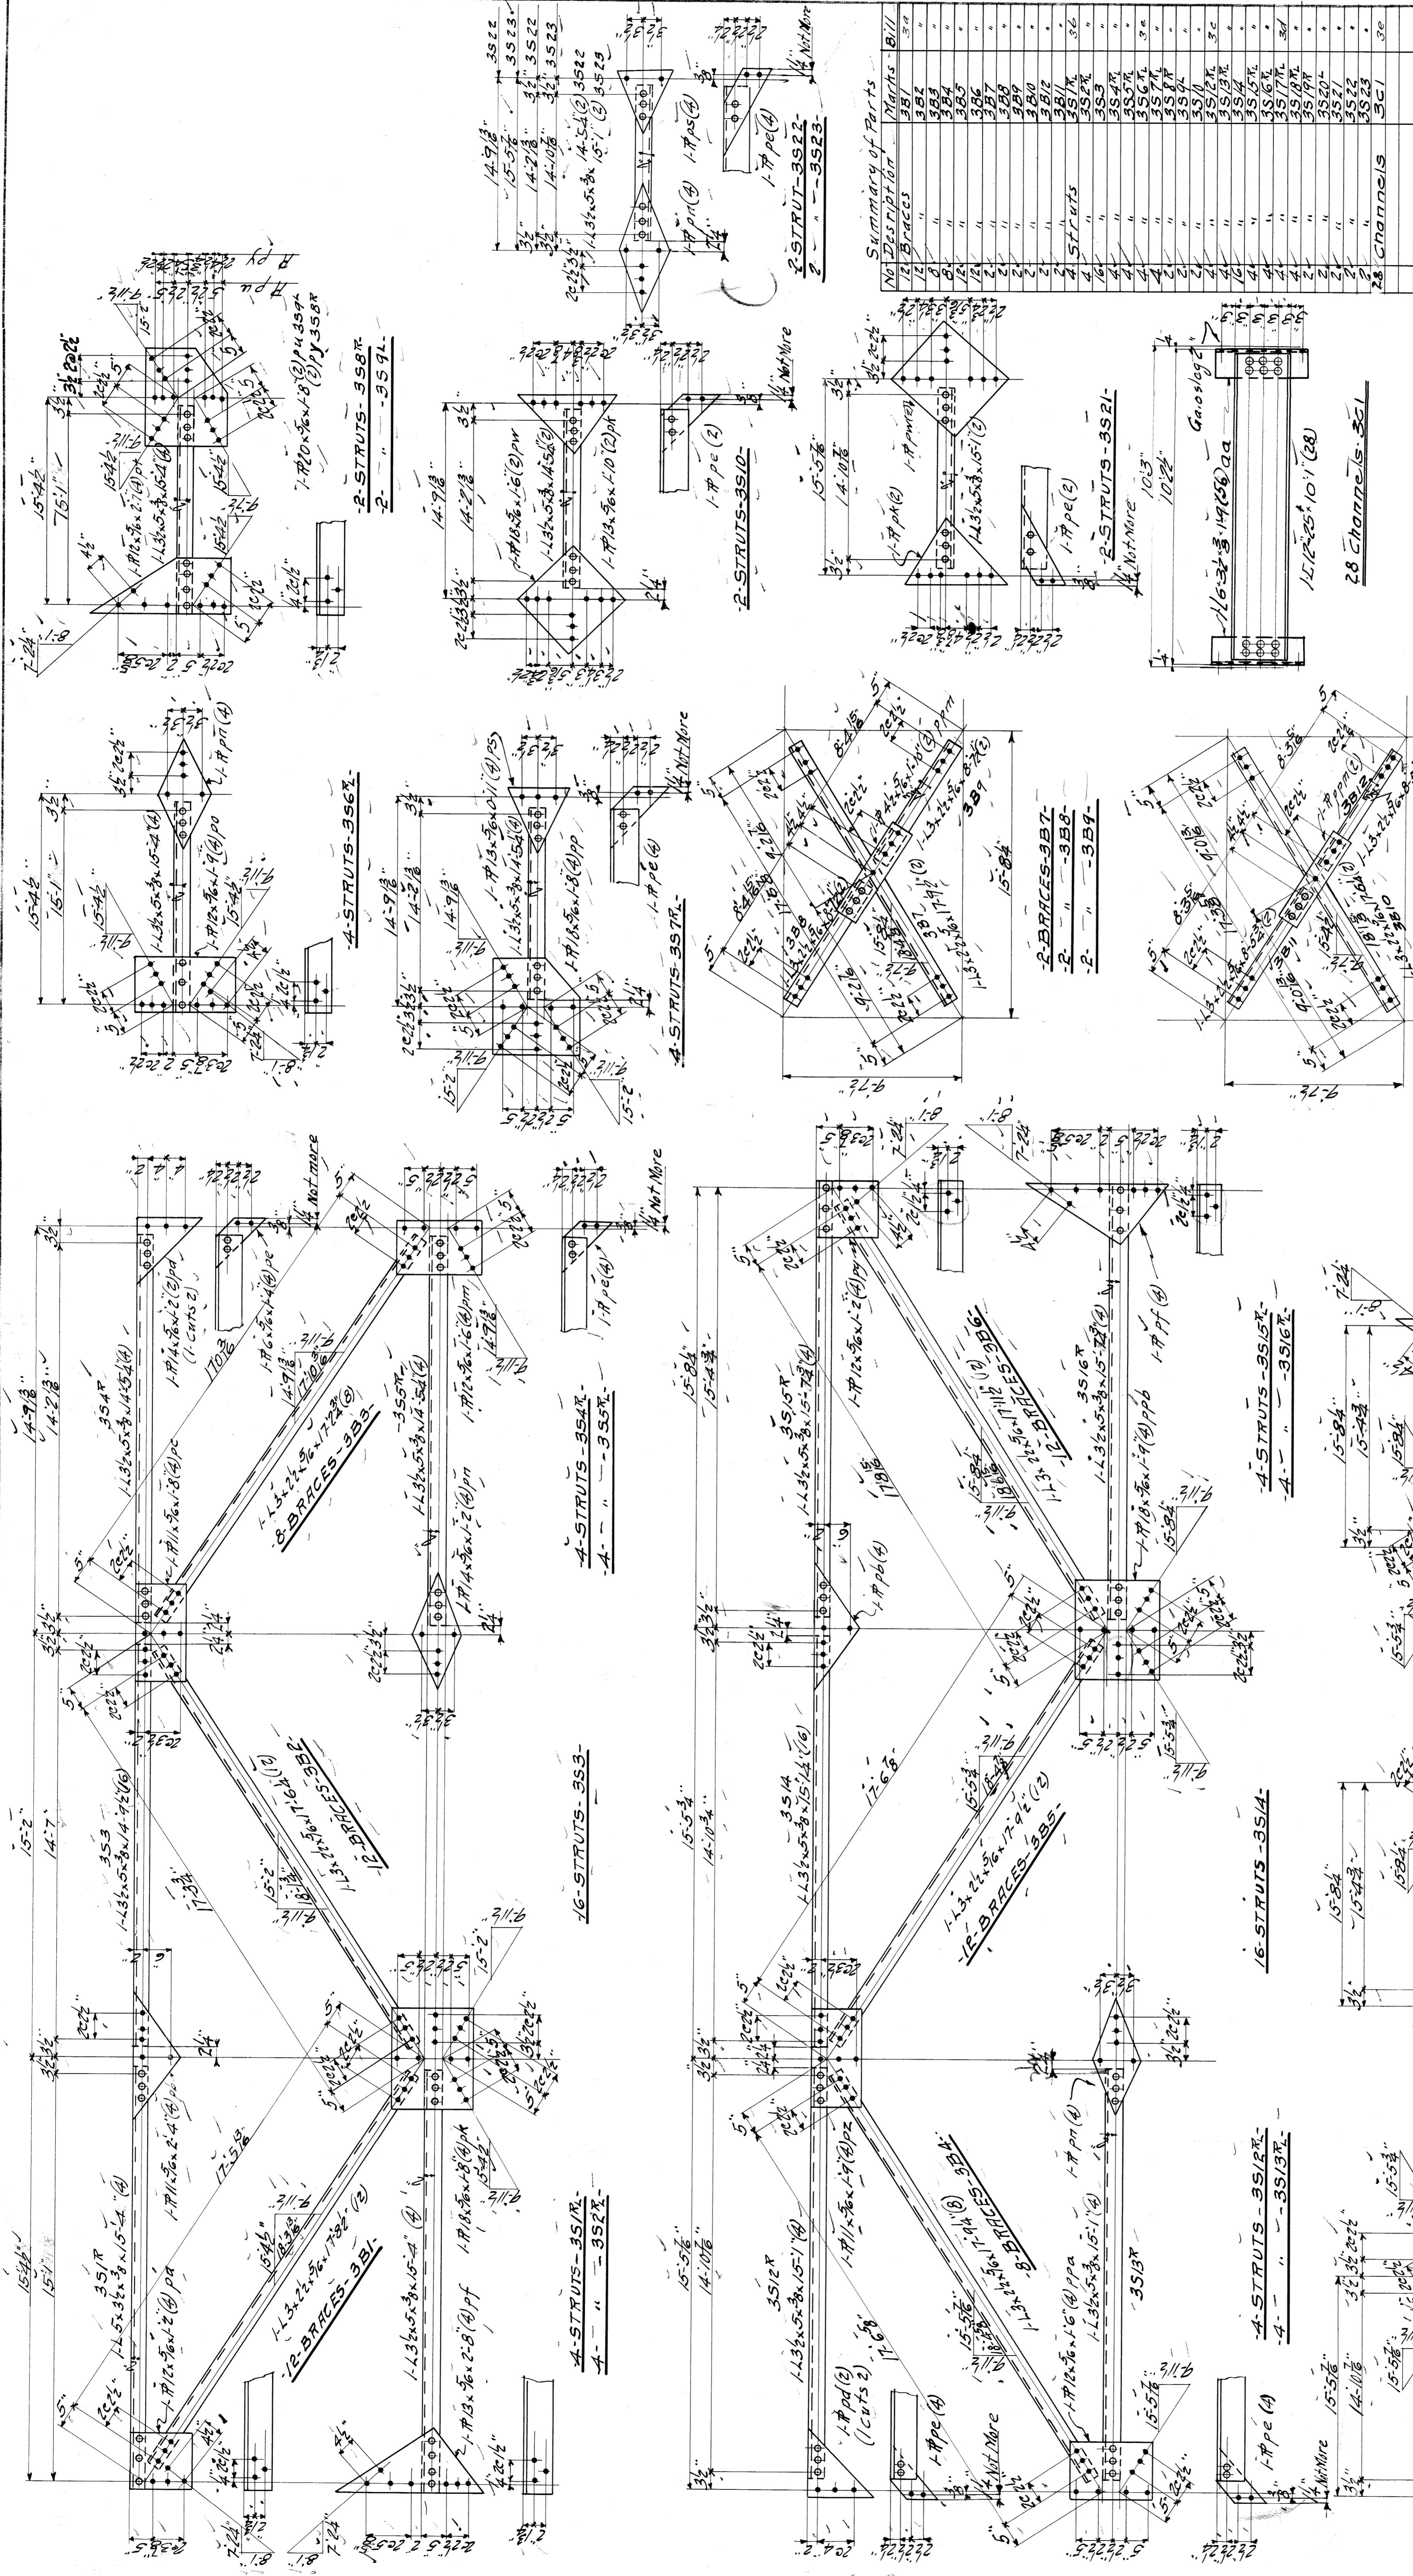


No.	Description of Parts	Quantity	Notes
1	Braces	12	
2	"	12	
3	"	12	
4	"	12	
100	"	12	

WISCONSIN BRIDGE & IRON CO.
 NORTH MILWAUKEE, WIS.


FOR CITY OF DETROIT
 LOCATION: Detroit, Mich.
 DESCRIPTION: Belle Isle Bridge
 DETAILS OF STRUCTURE: See Specifications
 SPECIFICATIONS: See Specifications
 SHOP PAINT: None
 FIELD PAINT: None
 MADE BY: L. F. ...
 TRACED BY: E. P. ...
 CHECKED BY: L. F. ...
 DATE: ...
 UNLESS INDICATED OTHERWISE
 SHEET NO. 3
 9380

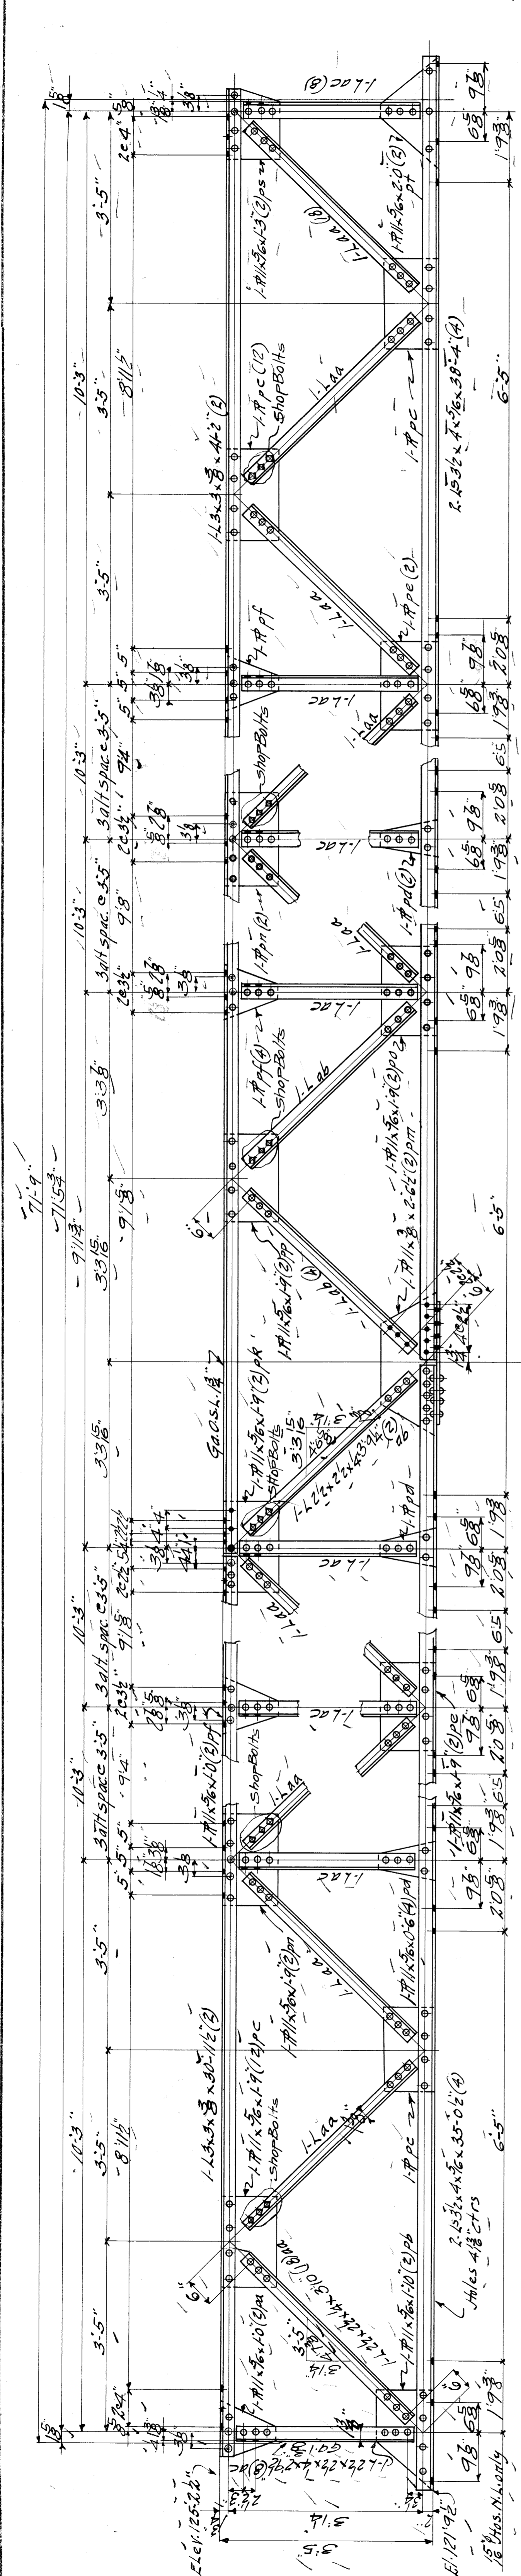

-R-STRUTS-451-


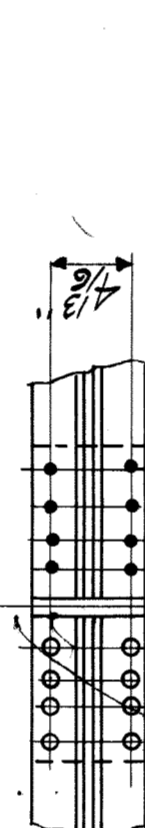


-R-STRUTS-452-

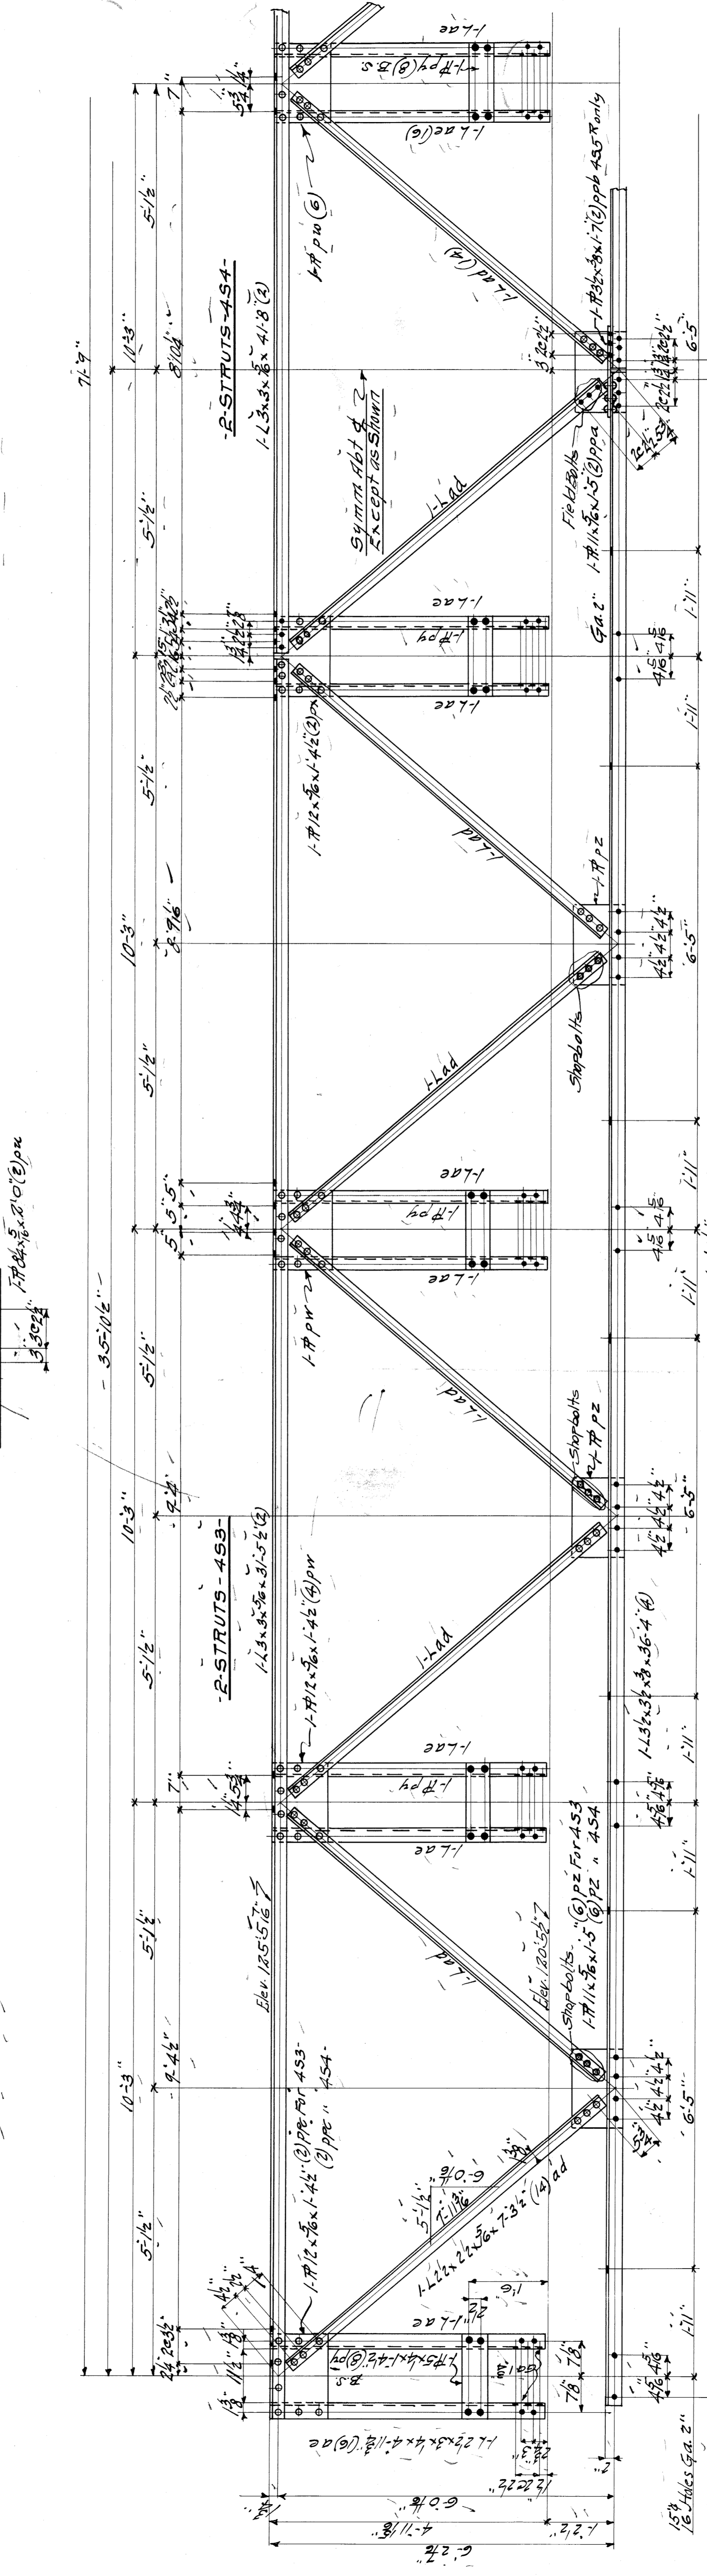


-R-STRUTS-453-

-R-STRUTS-454-

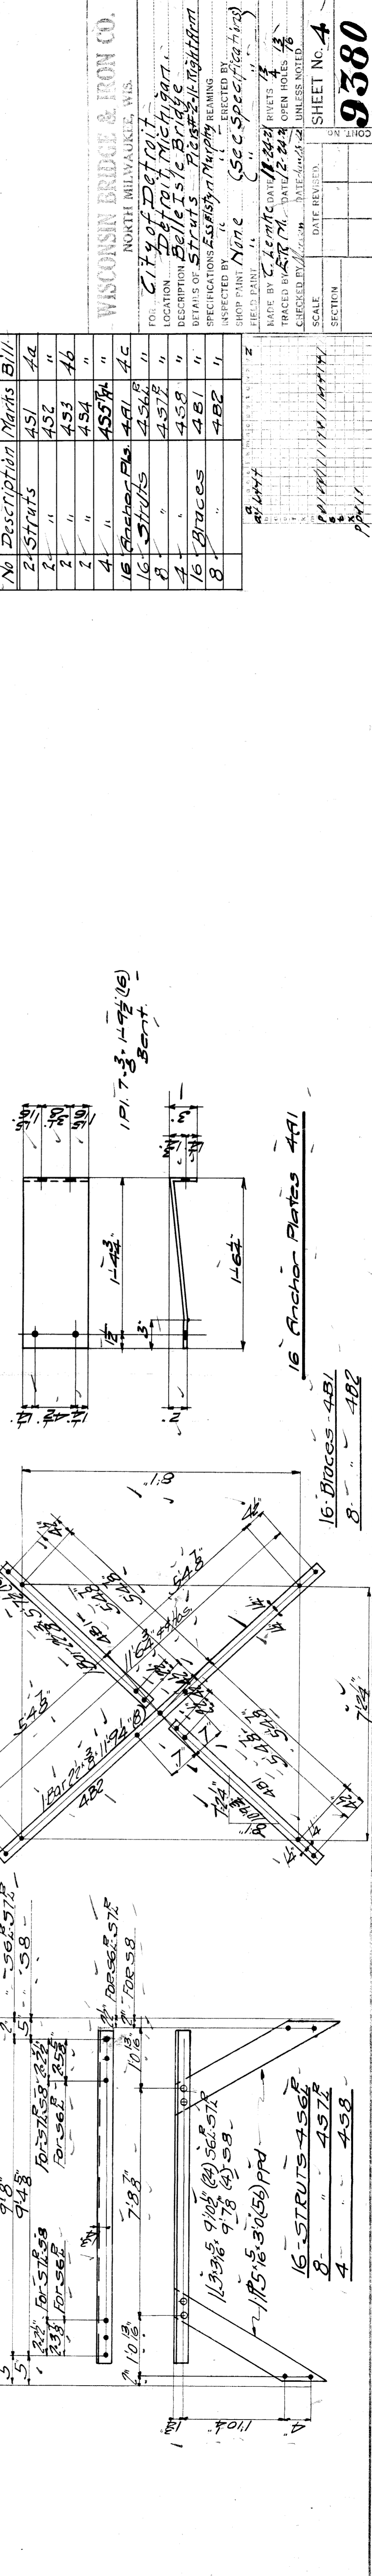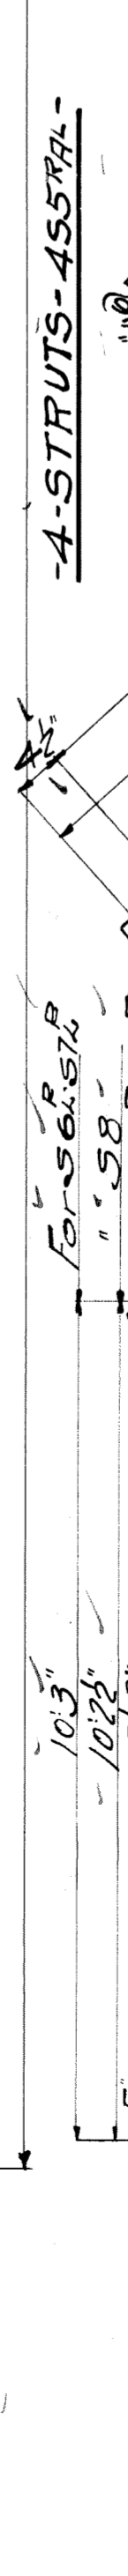




-A-STRUTS-455-

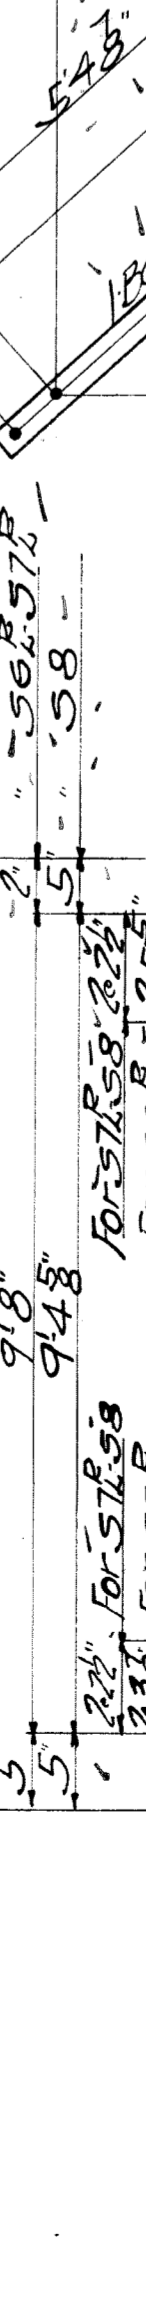

Summary of Parts

No	Description	Marks	Bill
2	Struts	451	4A
2	"	452	"
2	"	453	4B
2	"	454	"
4	"	455A	"
16	Anchor Plates	4A1	4C
8	Struts	457E	"
4	Braces	4B1	"
8	"	4B2	"

WISCONSIN BRIDGE & IRON CO.
NORTH MILWAUKEE, WIS.
FOR: City of Detroit
LOCATION: Detroit Michigan
DESCRIPTION: Belle Isle Bridge
DETAILS OF: Struts
SPECIFICATIONS: As Shown
INSPECTED BY: [Name]
FIELD PAINT: [Name]
MADE BY: [Name]
DATE: 12-24-23
CHECKED BY: [Name]
SCALE: [Scale]
SECTION: [Section]
SHEET NO. 4
9380

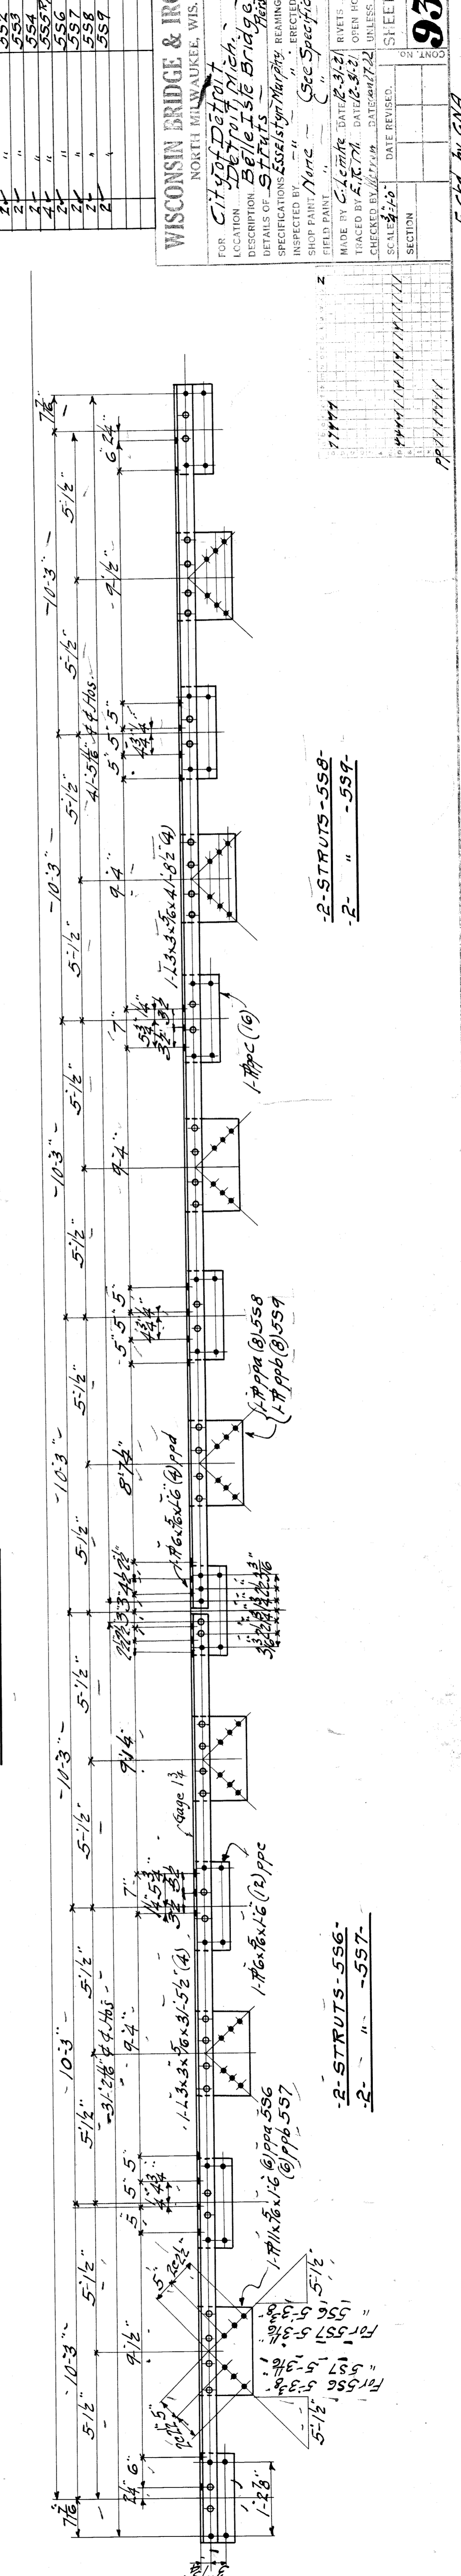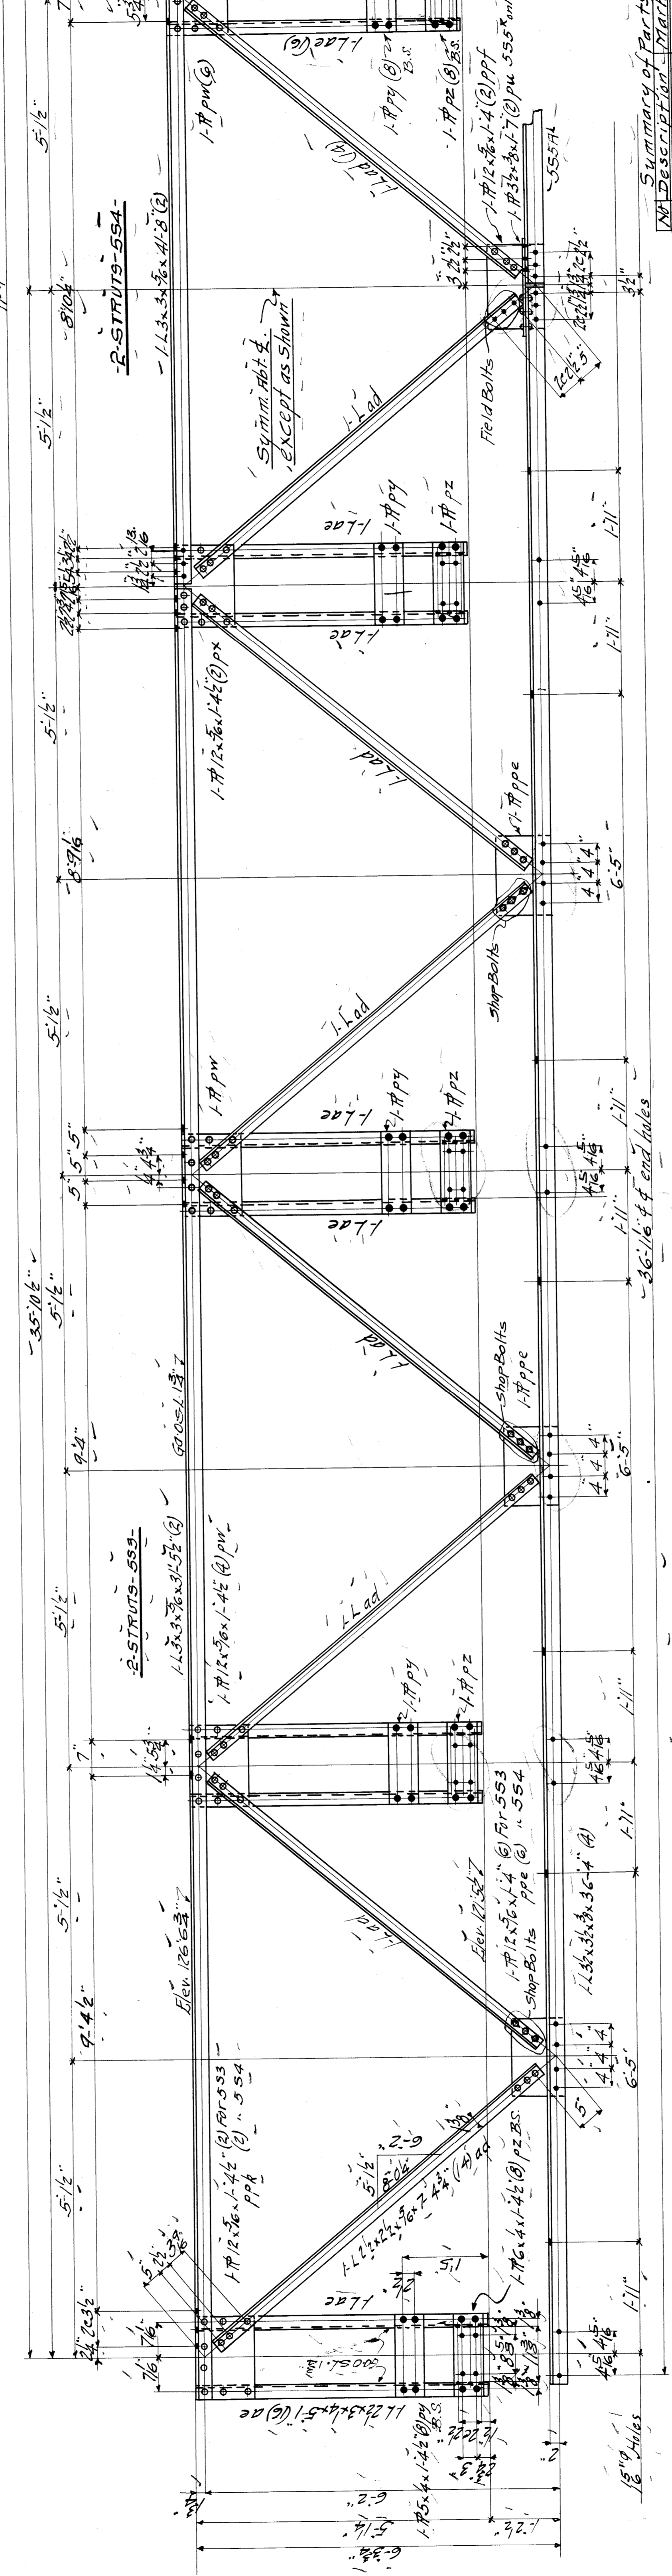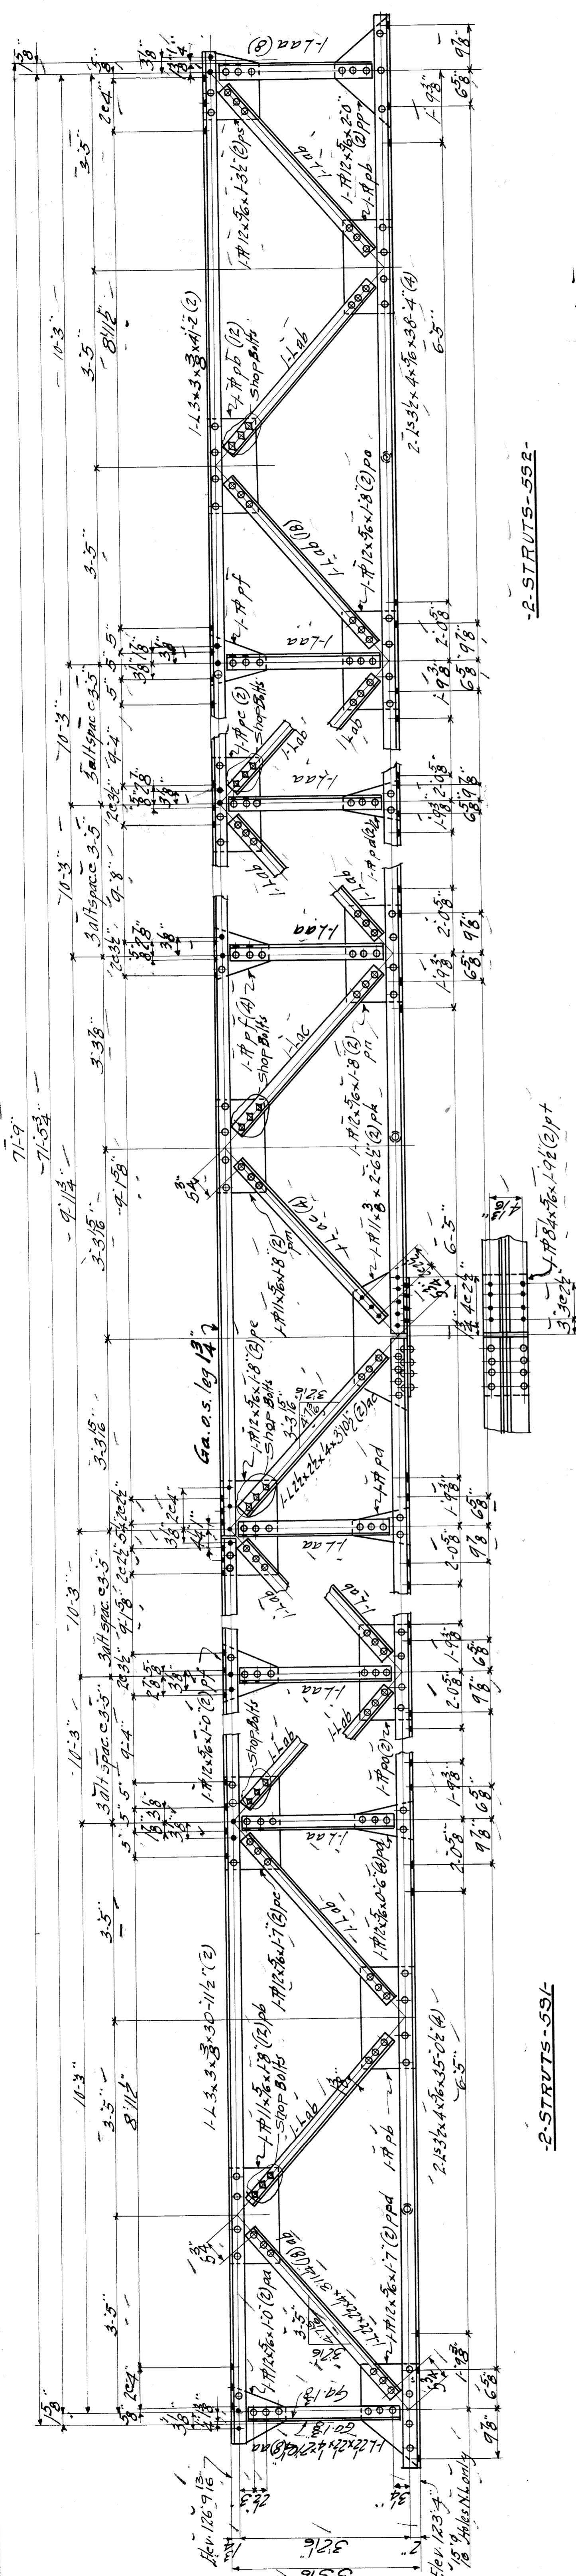


Summary of Parts

Part Description	Quantity	Part No.
2-STRUTS	551	551
"	552	552
"	553	553
"	554	554
"	555	555
"	556	556
"	557	557
"	558	558
"	559	559

WISCONSIN BRIDGE & IRON CO.
NORTH MILWAUKEE, WIS.

FOR CITY OF DETROIT
LOCATION Belle Isle Bridge
DESCRIPTION Belle Isle Bridge
DETAILS OF STRUTS
SPECIFICATIONS: WELDED REINFORCED
SHIP PAINT: None (See Specifications)
ERECTED BY
FIELD PAINT: None (See Specifications)
MADE BY Calculte DATE: 2-13-12
TRACED BY: L.C. 771 DATE: 2-13-12
CHECKED BY: J.P. 771 DATE: 2-13-12
SC ALL: 2-13-12
DATE REVISION: _____
SECTION _____
SHEET No. 5


FOR CITY OF DETROIT	LOCATION: DETROIT, MICH.	DATE: FEBRUARY 11, 1917	SCALE: AS SHOWN
DESCRIPTION: PILE DRIVING MACHINE	DESIGNED BY: W. L. RYAN	CHECKED BY: C. J. RYAN	DATE RECEIVED: 2/11/17
SECTION: ORIGINAL ASSEMBLY DRAWING	SECTION: ORIGINAL ASSEMBLY DRAWING	SECTION: ORIGINAL ASSEMBLY DRAWING	SECTION: ORIGINAL ASSEMBLY DRAWING

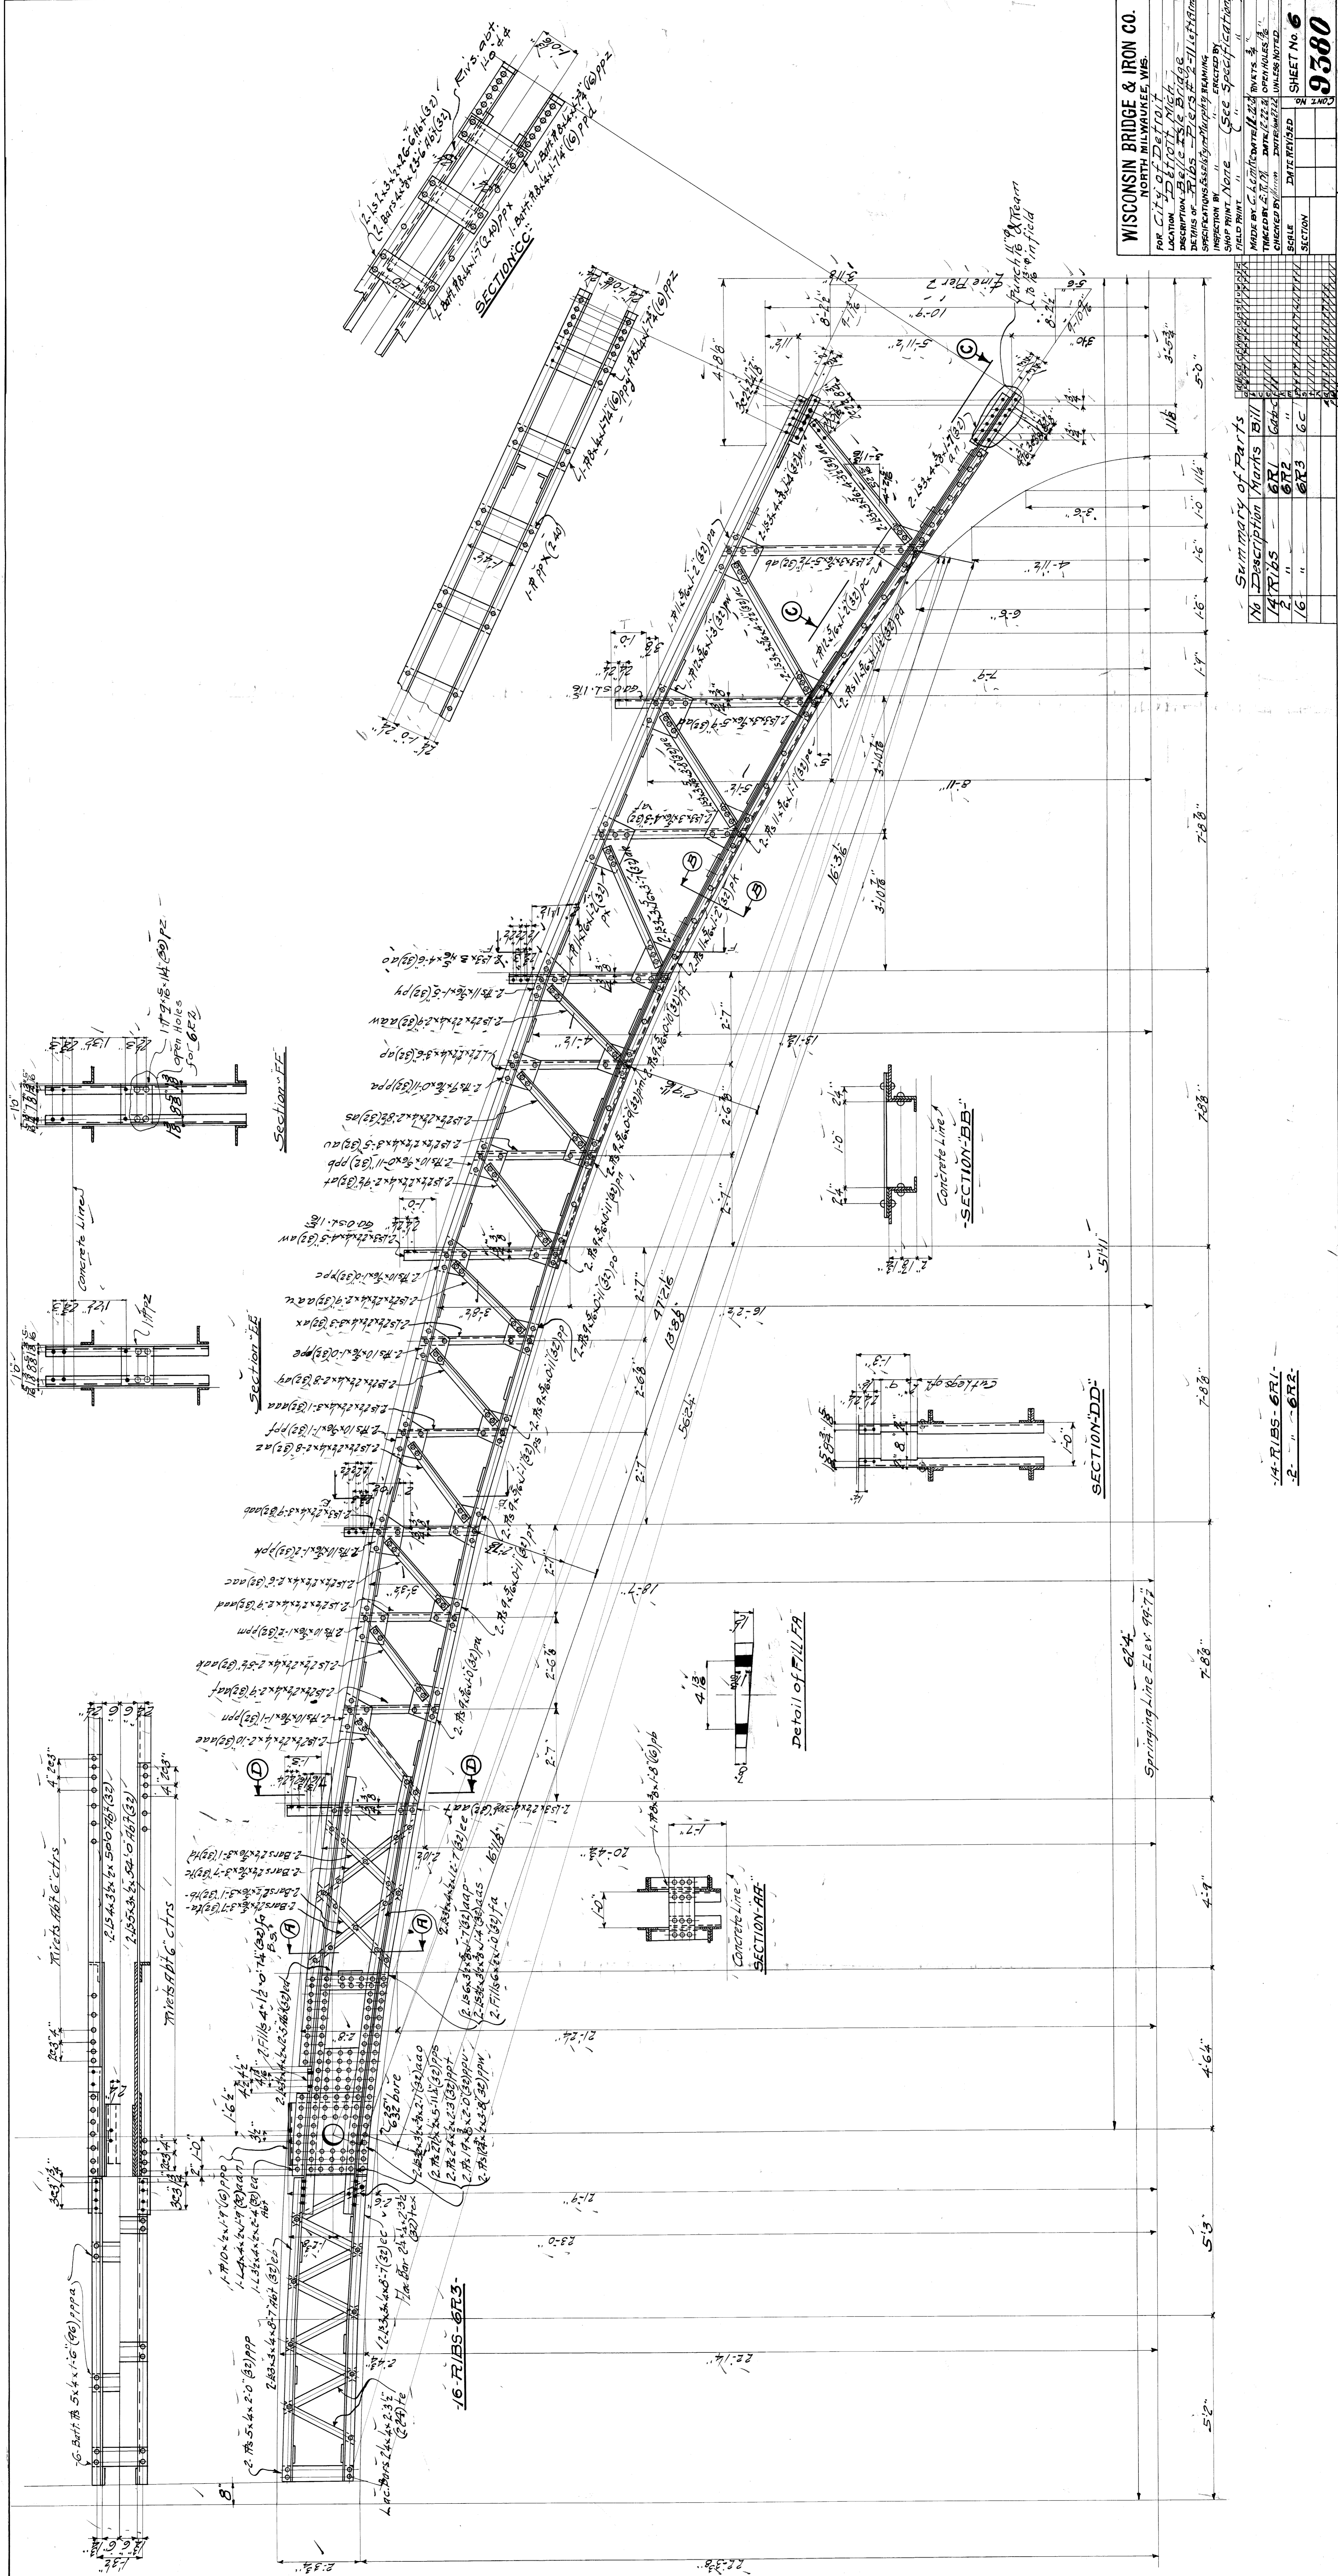

No	Description of Parts	Quantity	Bill of Materials
14	RIBS	6	6R1
15	TRUSS	1	6R2
16	CONCRETE	6	6R3

Summary of Parts

14 RIBS - 6R1
2 - 6R2

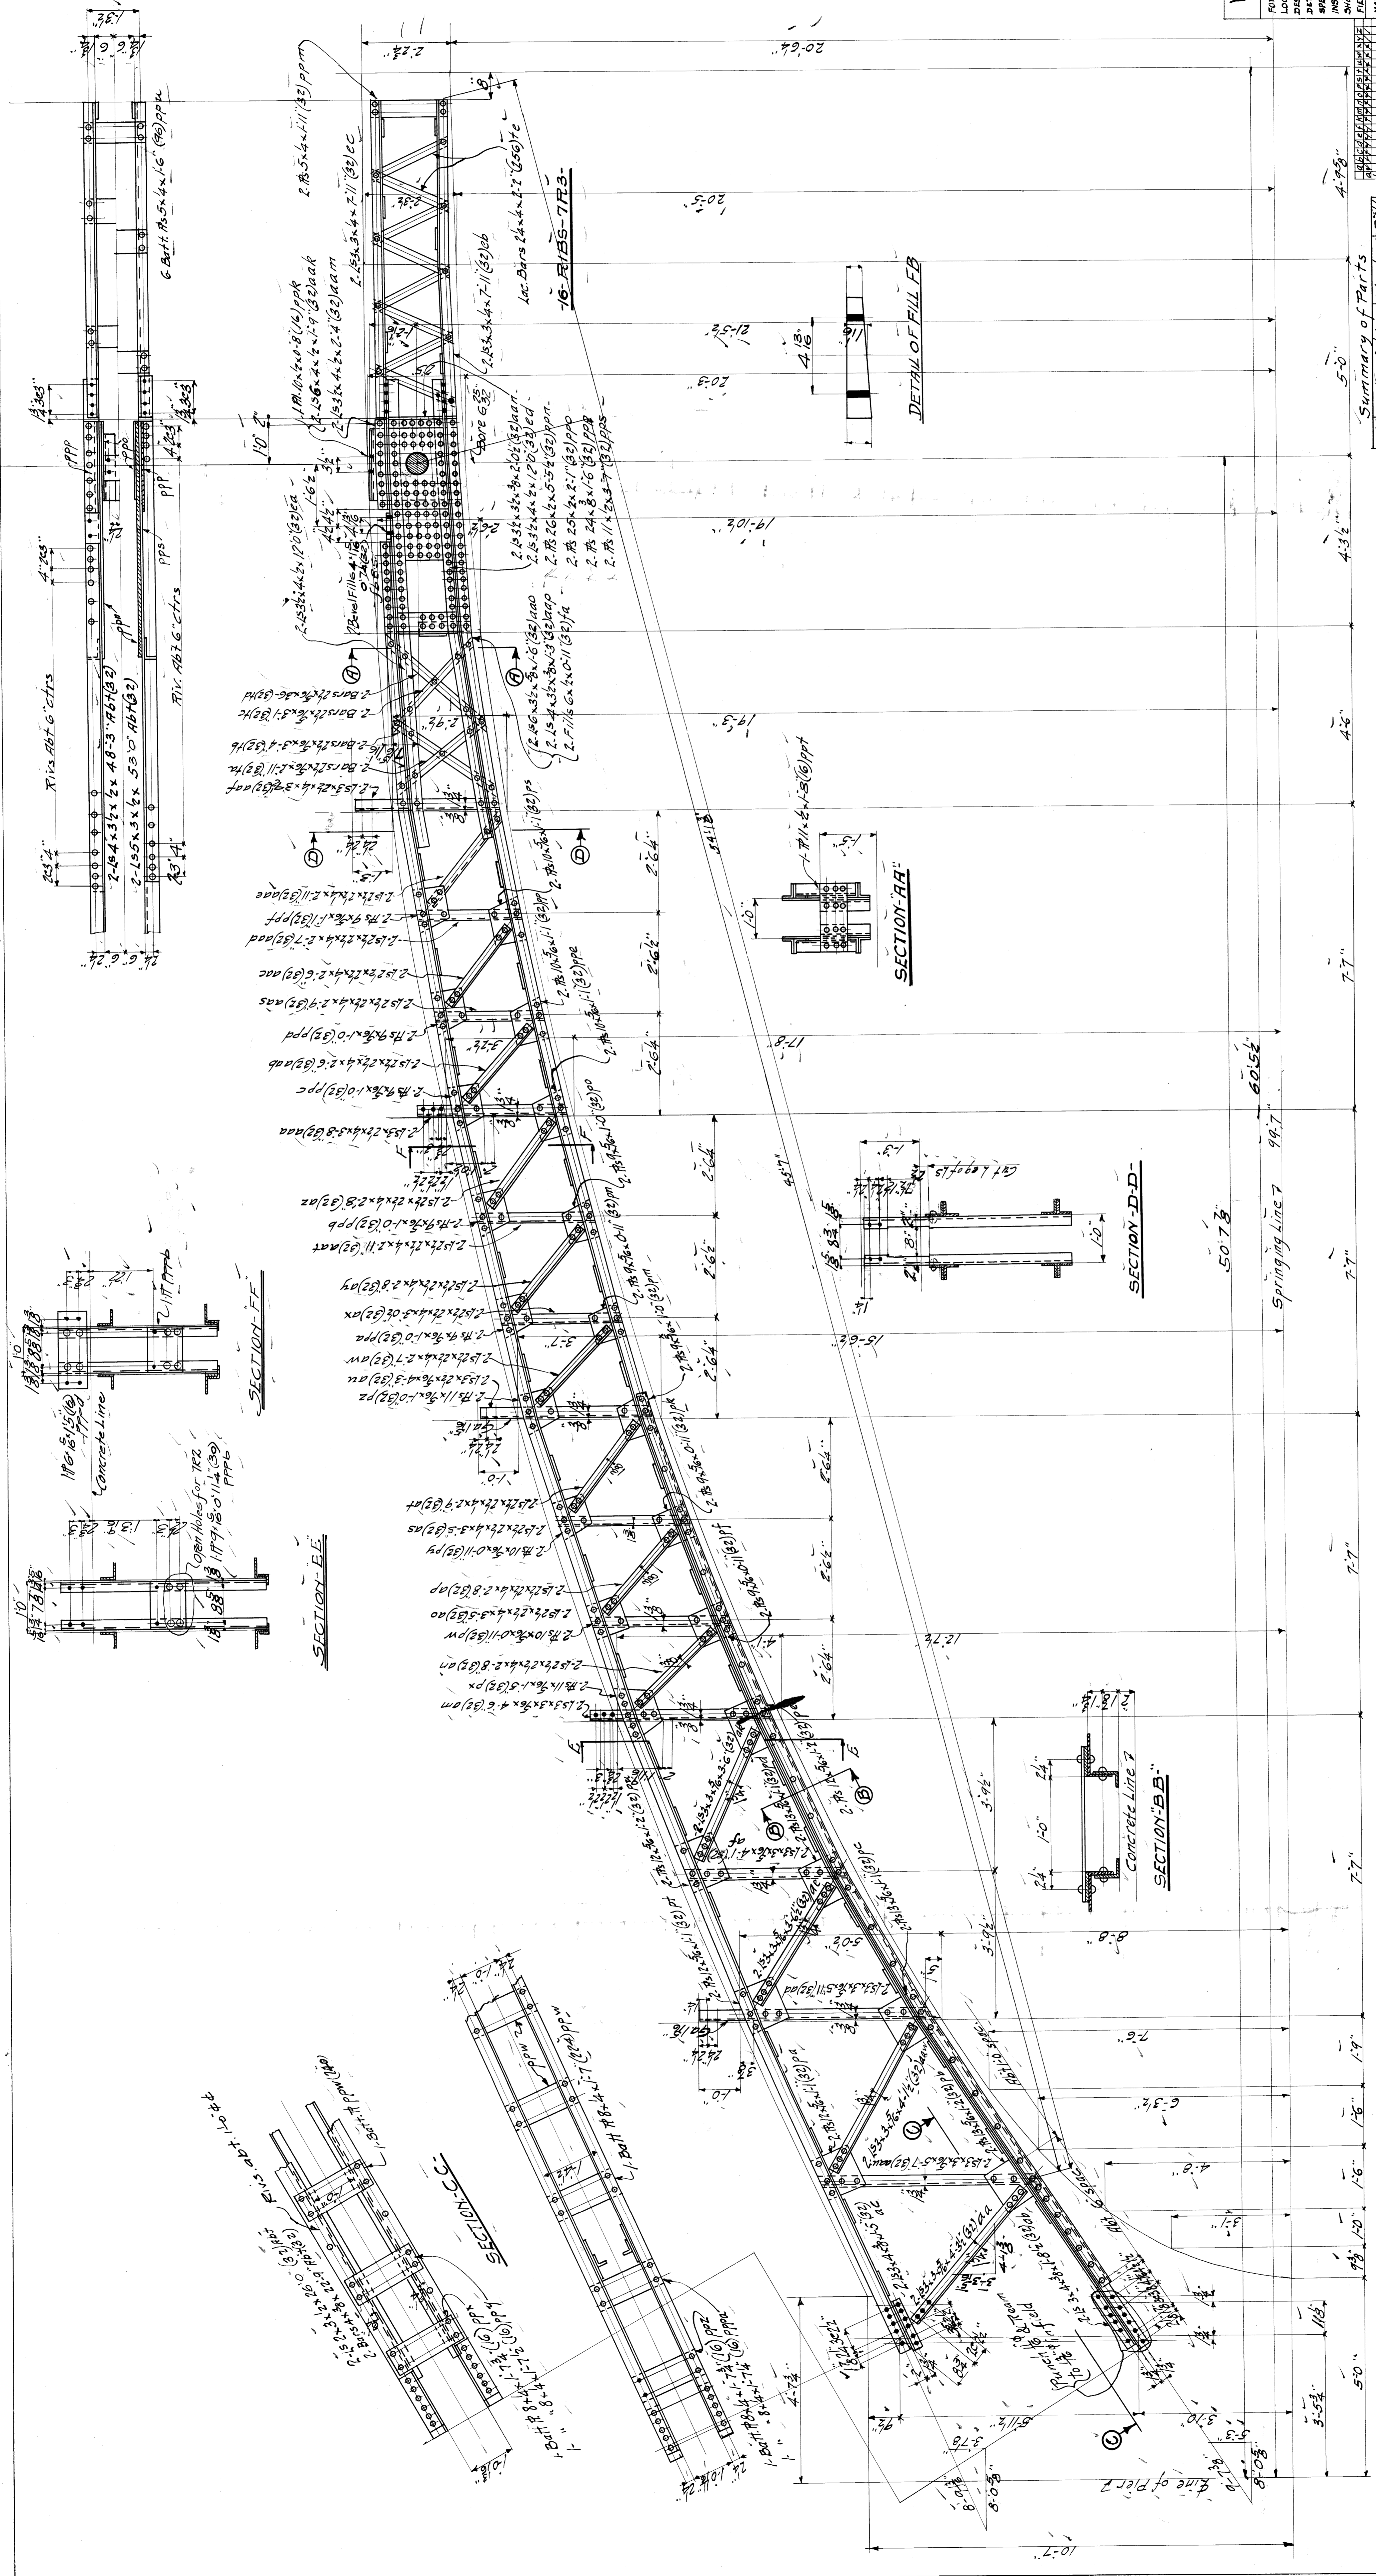

WISCONSIN BRIDGE & IRON CO.
 NORTH MILWAUKEE, WIS.
 FOR City of Detroit
 LOCATION Belle Isle Bridge
 DESCRIPTION Belle Isle Bridge
 DETAILS OF RIBS Pier 2-11
 DRAWING NUMBER 1050-15
 ARCHITECT ASSOCIATE ENGINEERS AND ARCHITECTS
 INSPECTOR NOTE (See Specifications)
 FIELD PAINT " (See Specifications)
 MADE BY C. Lester Smith (L.S.S.) DRAWING NO. 1050-15
 REVISIONS
 REVISION NO. DATE MADE BY
 SCALE 1/4" = 1'-0"
 DATE REVISED
 SECTION
 SHEET NO. 7
 9380

Summary of Parts	
No. Description	Parts
14 Ribs	TR1
2 "	TR2
16 "	TR3

14 RIBS - TRI-
 2 - " - TR2-

Summary of Parts	
No. Description	Parts
14 Ribs	TR1
2 "	TR2
16 "	TR3




50'-7 1/8"
 Springing line 7 99'-7"
 60'-5 1/2"

7'-7"
 7'-7"
 7'-7"

7'-6"
 7'-6"
 7'-6"
 7'-6"
 7'-6"
 7'-6"

9'-10"
 11'-5"
 5'-5 1/2"
 5'-0"
 10'-7"
 10'-7"
Filed by GNA
 BWR-206

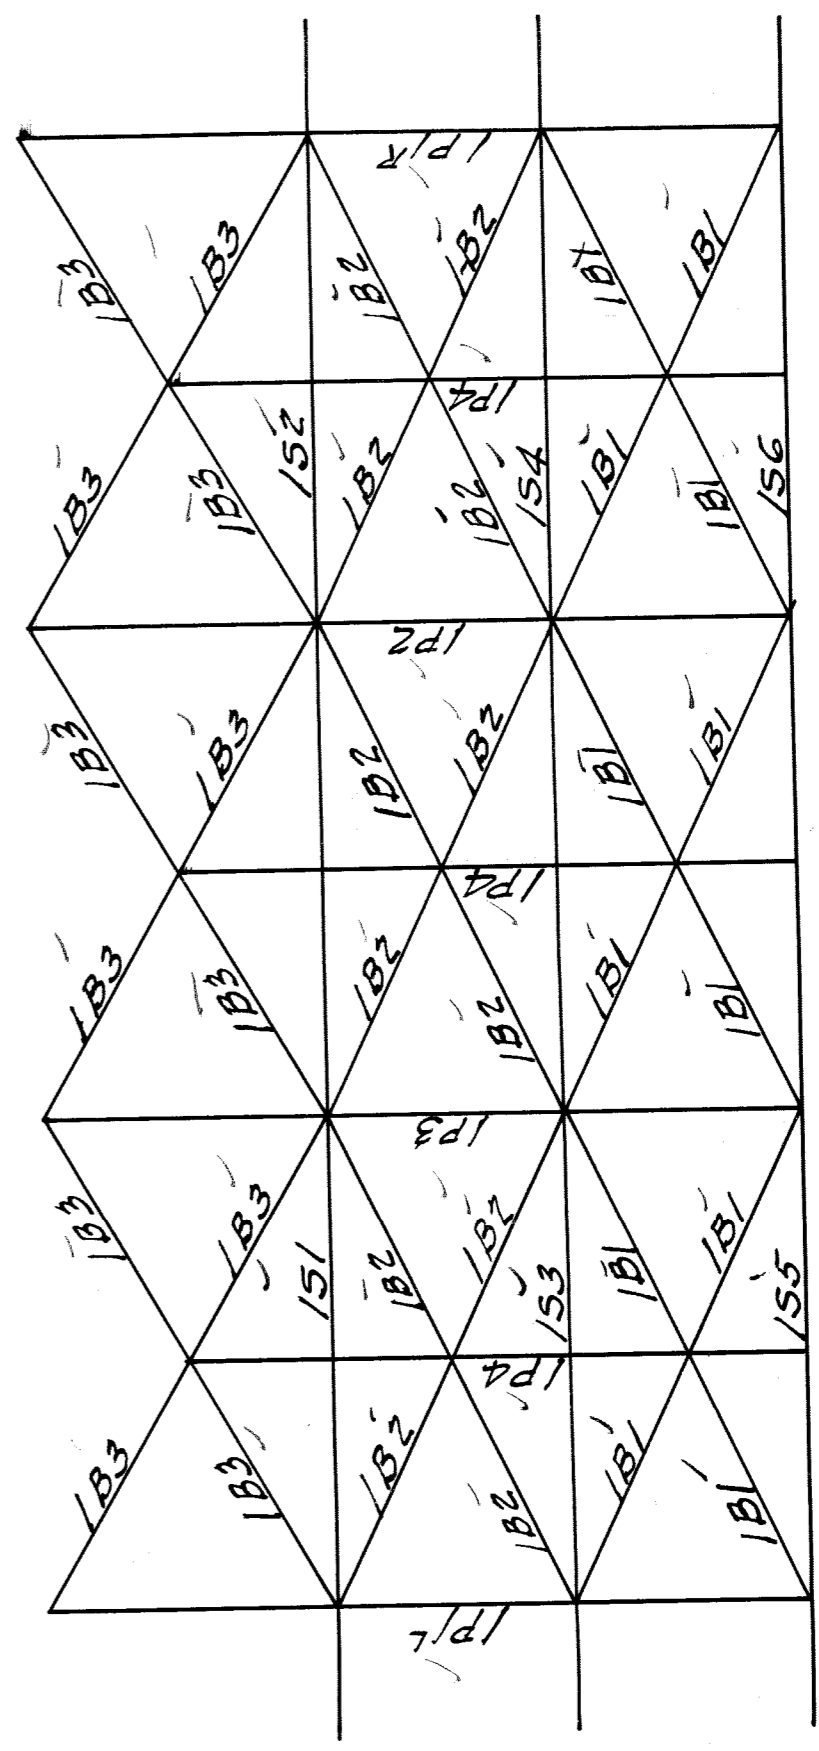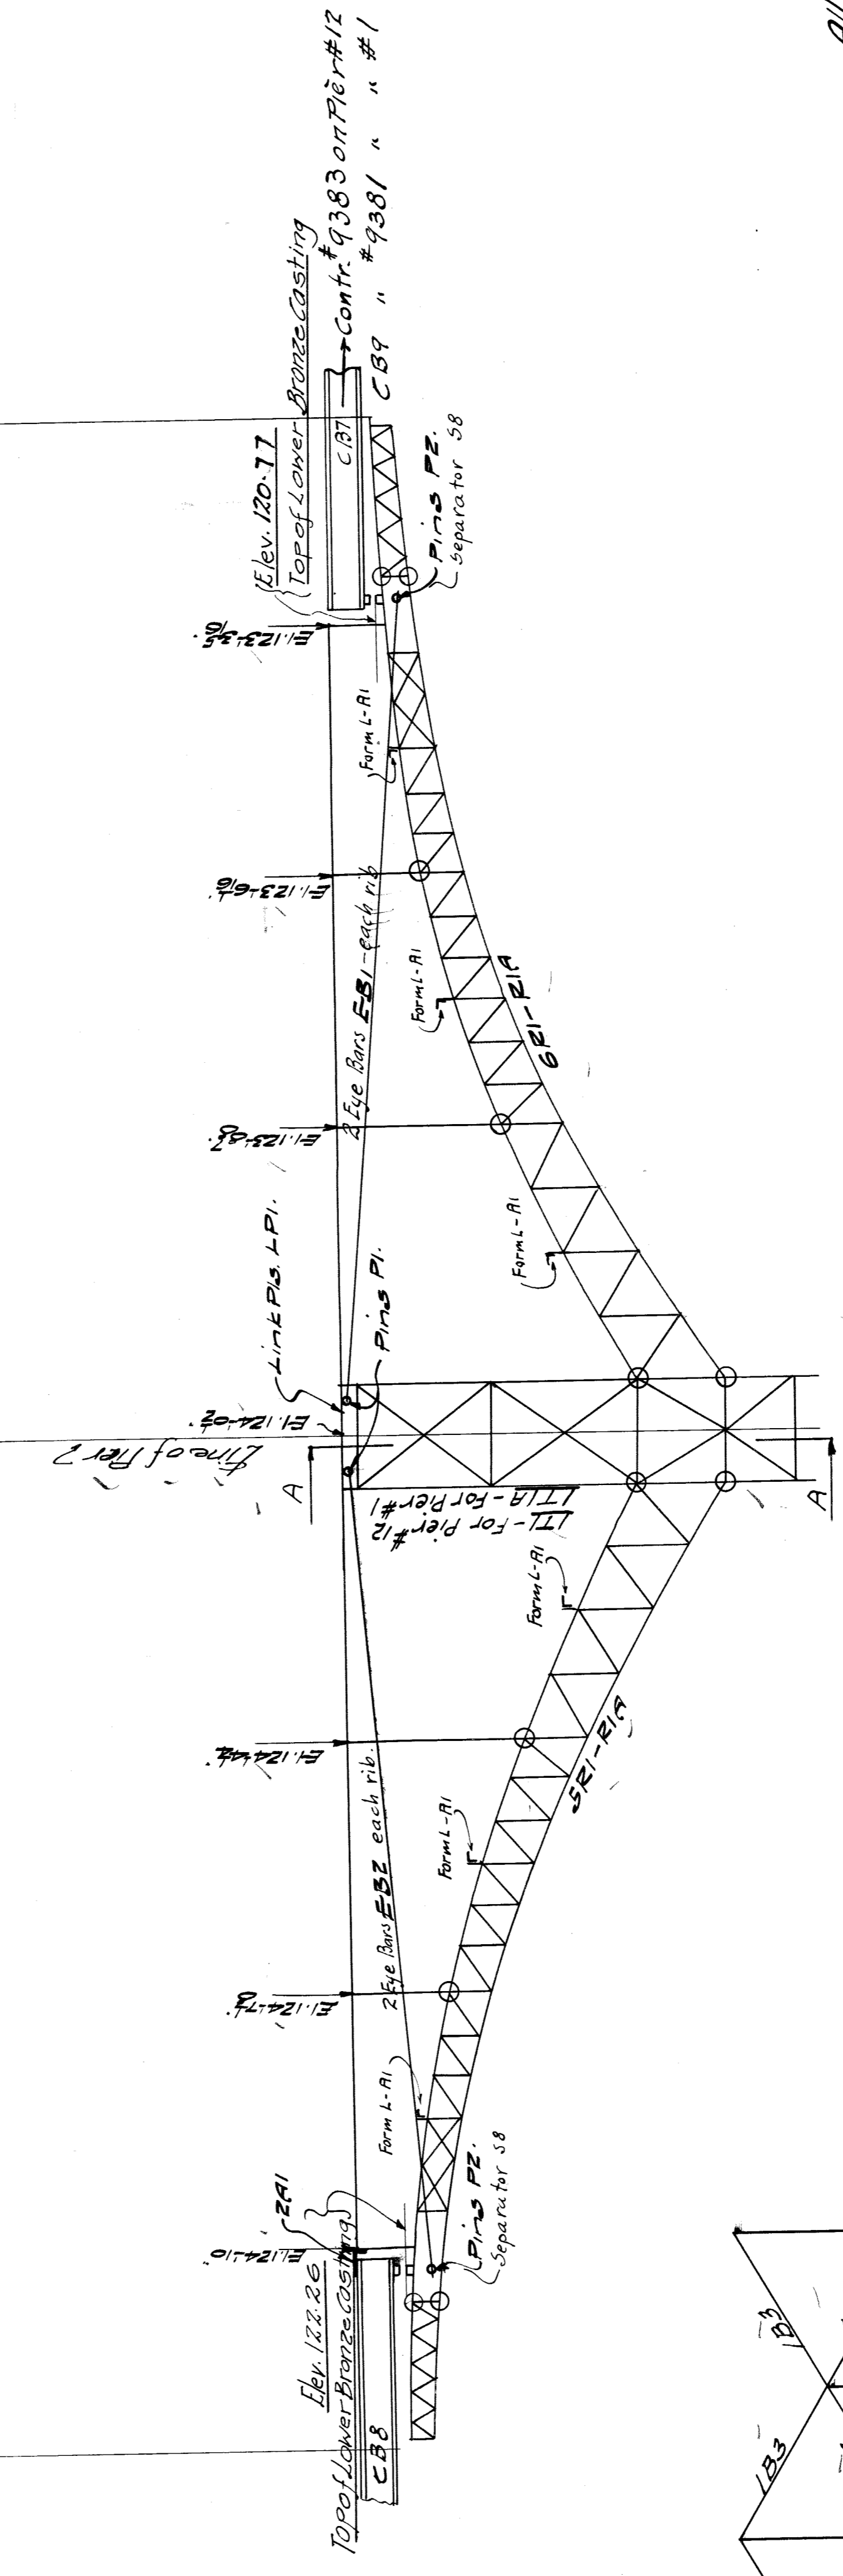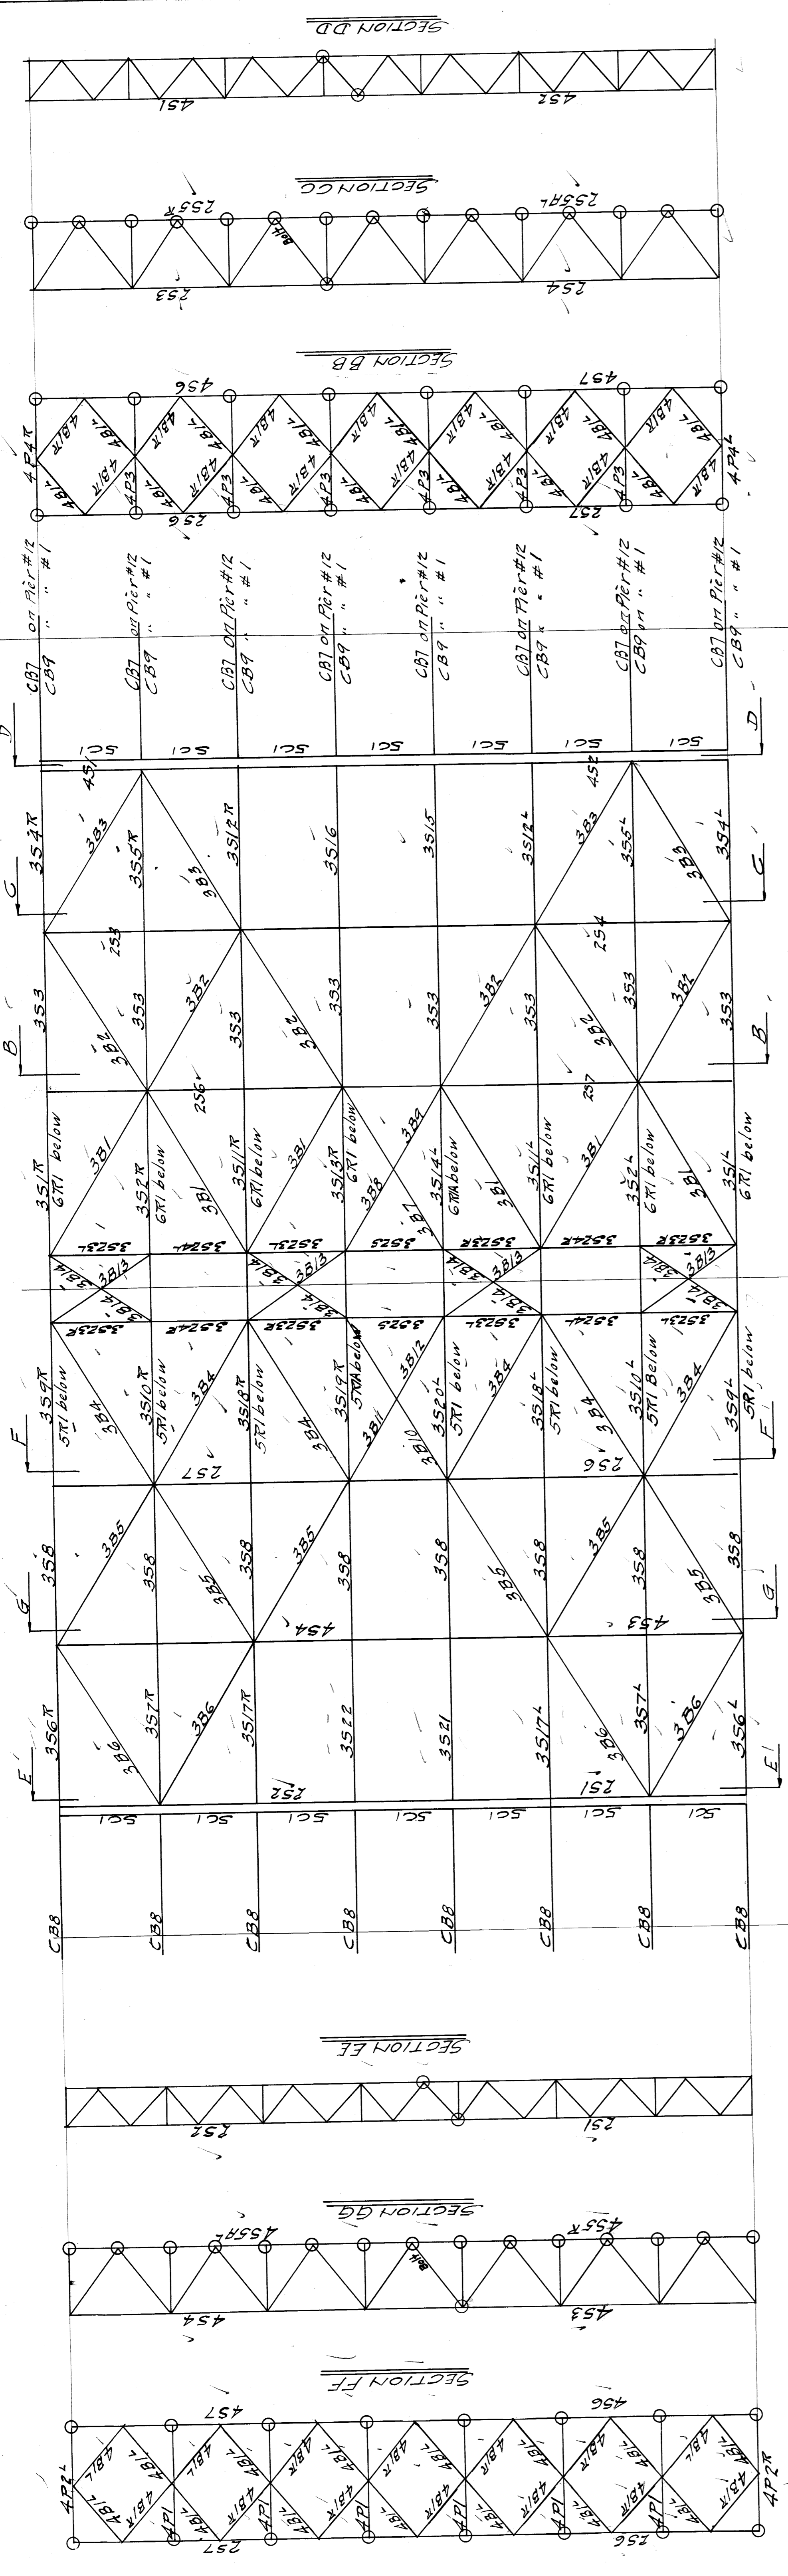

PIERS #1-12.
Pier-12 shown Pier #1 Sym by Rotation
Form L-R1 detailed on Bill #305-9377

All points encircled thus O to be riveted.
All other points bolted.

WISCONSIN BRIDGE & IRON CO.
NORTH MILWAUKEE, WIS.

FOR: CITY OF DETROIT
LOCATION: DETROIT, MICH.
DESCRIPTION: BELLE ISLE BRIDGE Pier #12
DETAILS OF: BRACING TRUSS


PREPARED BY: [Name]
SPECIFICATIONS: [Name]
INSPECTED BY: [Name]
ERECTED BY: [Name]
SHOP PAINT: [Name]

MADE BY: [Name] DATE: 9/22/22
TRACED BY: [Name] DATE: 10/15/22
CHECKED BY: [Name] DATE: 10/15/22
SCALE: 1/4" = 1'-0"
SECTION: [Name]

RIVETS: [Name]
OPEN HOLES: [Name]
UNLESS NOTED: [Name]

SHEET No. **9381**
of [Number]

File **BW261-207**

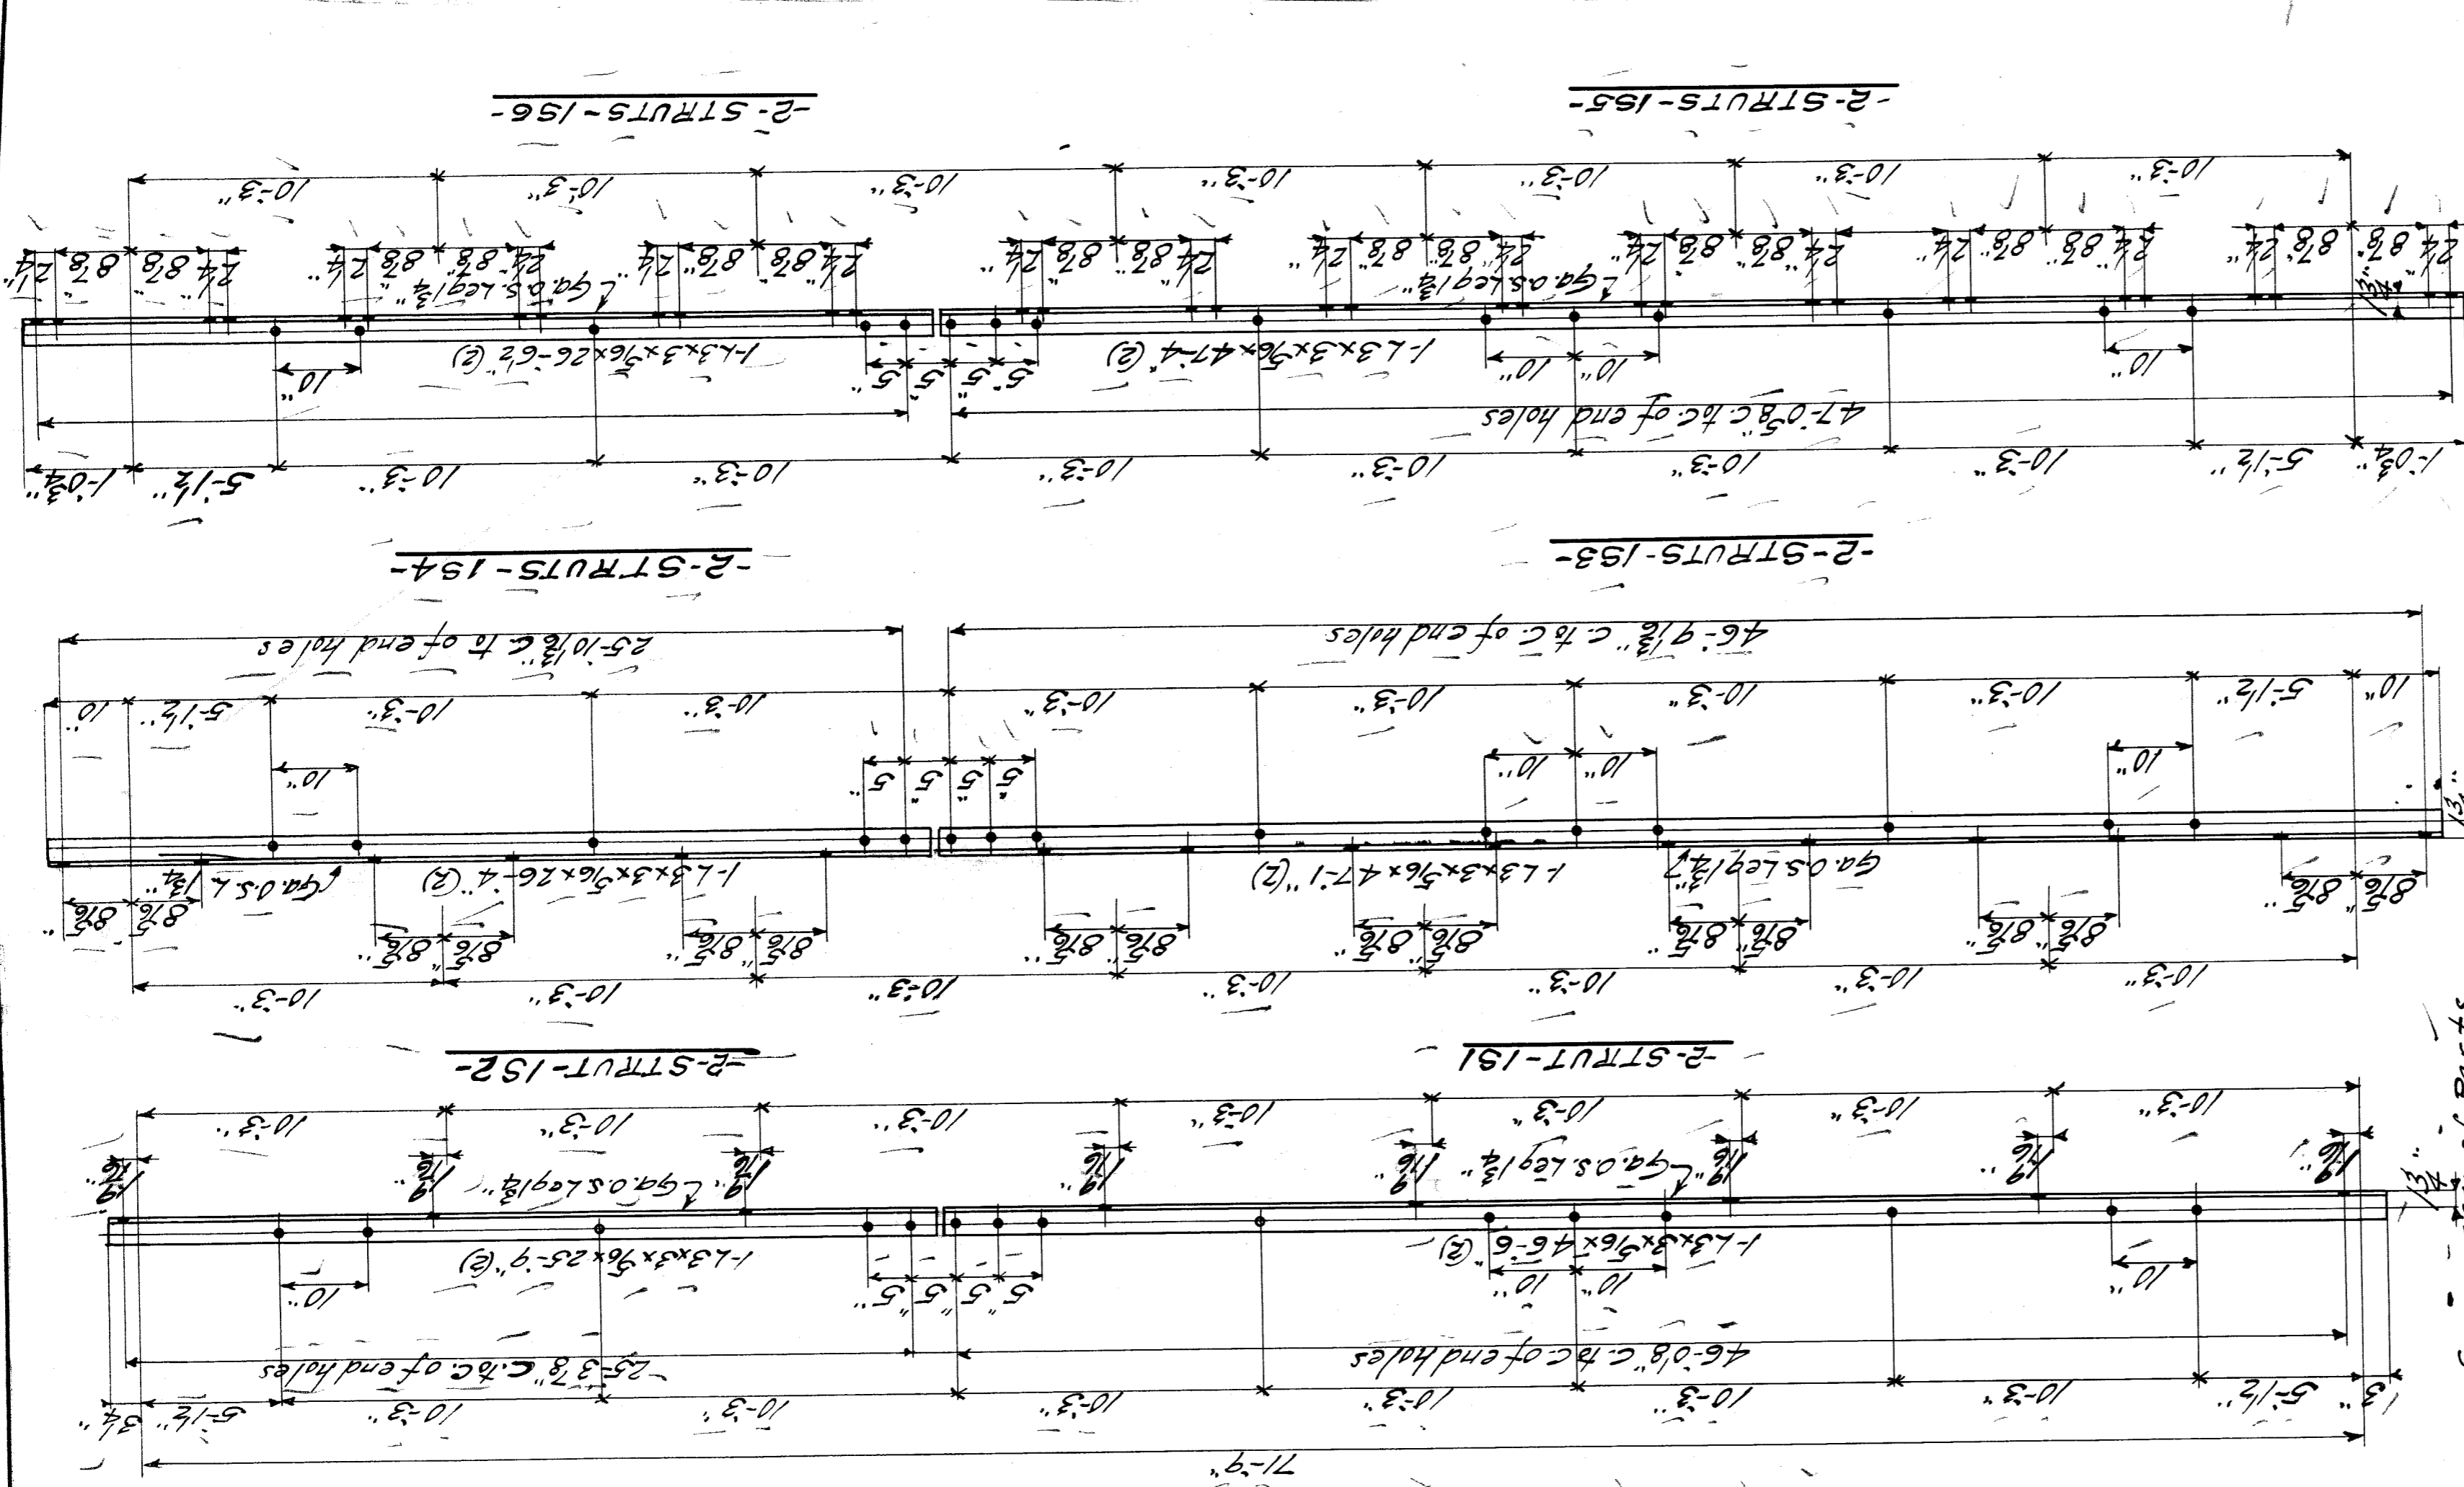



WISCONSIN BRIDGE & IRON CO.
 NORTH MILWAUKEE, WISCONSIN





CONTRACT NO. 9381
 ERECTED BY W.B.R.I.C.
 FOR City of Detroit
 LOCATION Detroit, Mich.
 DESCRIPTION Belle Isle Bridge
 DETAILS OF TOWERS (Pier 1 & 2)
 SPECIFICATIONS Caststeel-Murphy-Beaming
 INSPECTION BY
 SHOP PAINT Name (See Specifications)
 FIELD PAINT Name (See Specifications)
 RIVETS 3/4" φ OPEN HOLES 1 1/4" φ EXCEPT AS NOTED
 MADE BY C. N. A. & PETERS DATE 7-28-21
 TRACED BY A. G. H. & E. R. D. DATE 8-7-21
 CHECKED BY [Signature] FIELD BY GMA DATE [Signature]

SCALE 3/4" = 1'-0"
 SHEET NO. 1
 SECTION

Summary of Parts Bill

No.	Description	Quantity	Part	Material
1	Towers	2	IT1	MIG
2	Braces	24	IB1	MIG
3	Posts	4	IP1R	MIG
4	Posts	2	IP2	MIG
5	Posts	2	IP3	MIG
6	Posts	2	IP4	MIG
7	Struts	2	IS1	MIG
8	Struts	2	IS2	MIG
9	Struts	2	IS3	MIG
10	Struts	2	IS4	MIG
11	Struts	2	IS5	MIG
12	Struts	2	IS6	MIG
13	Towers	2	IT1A	MIG

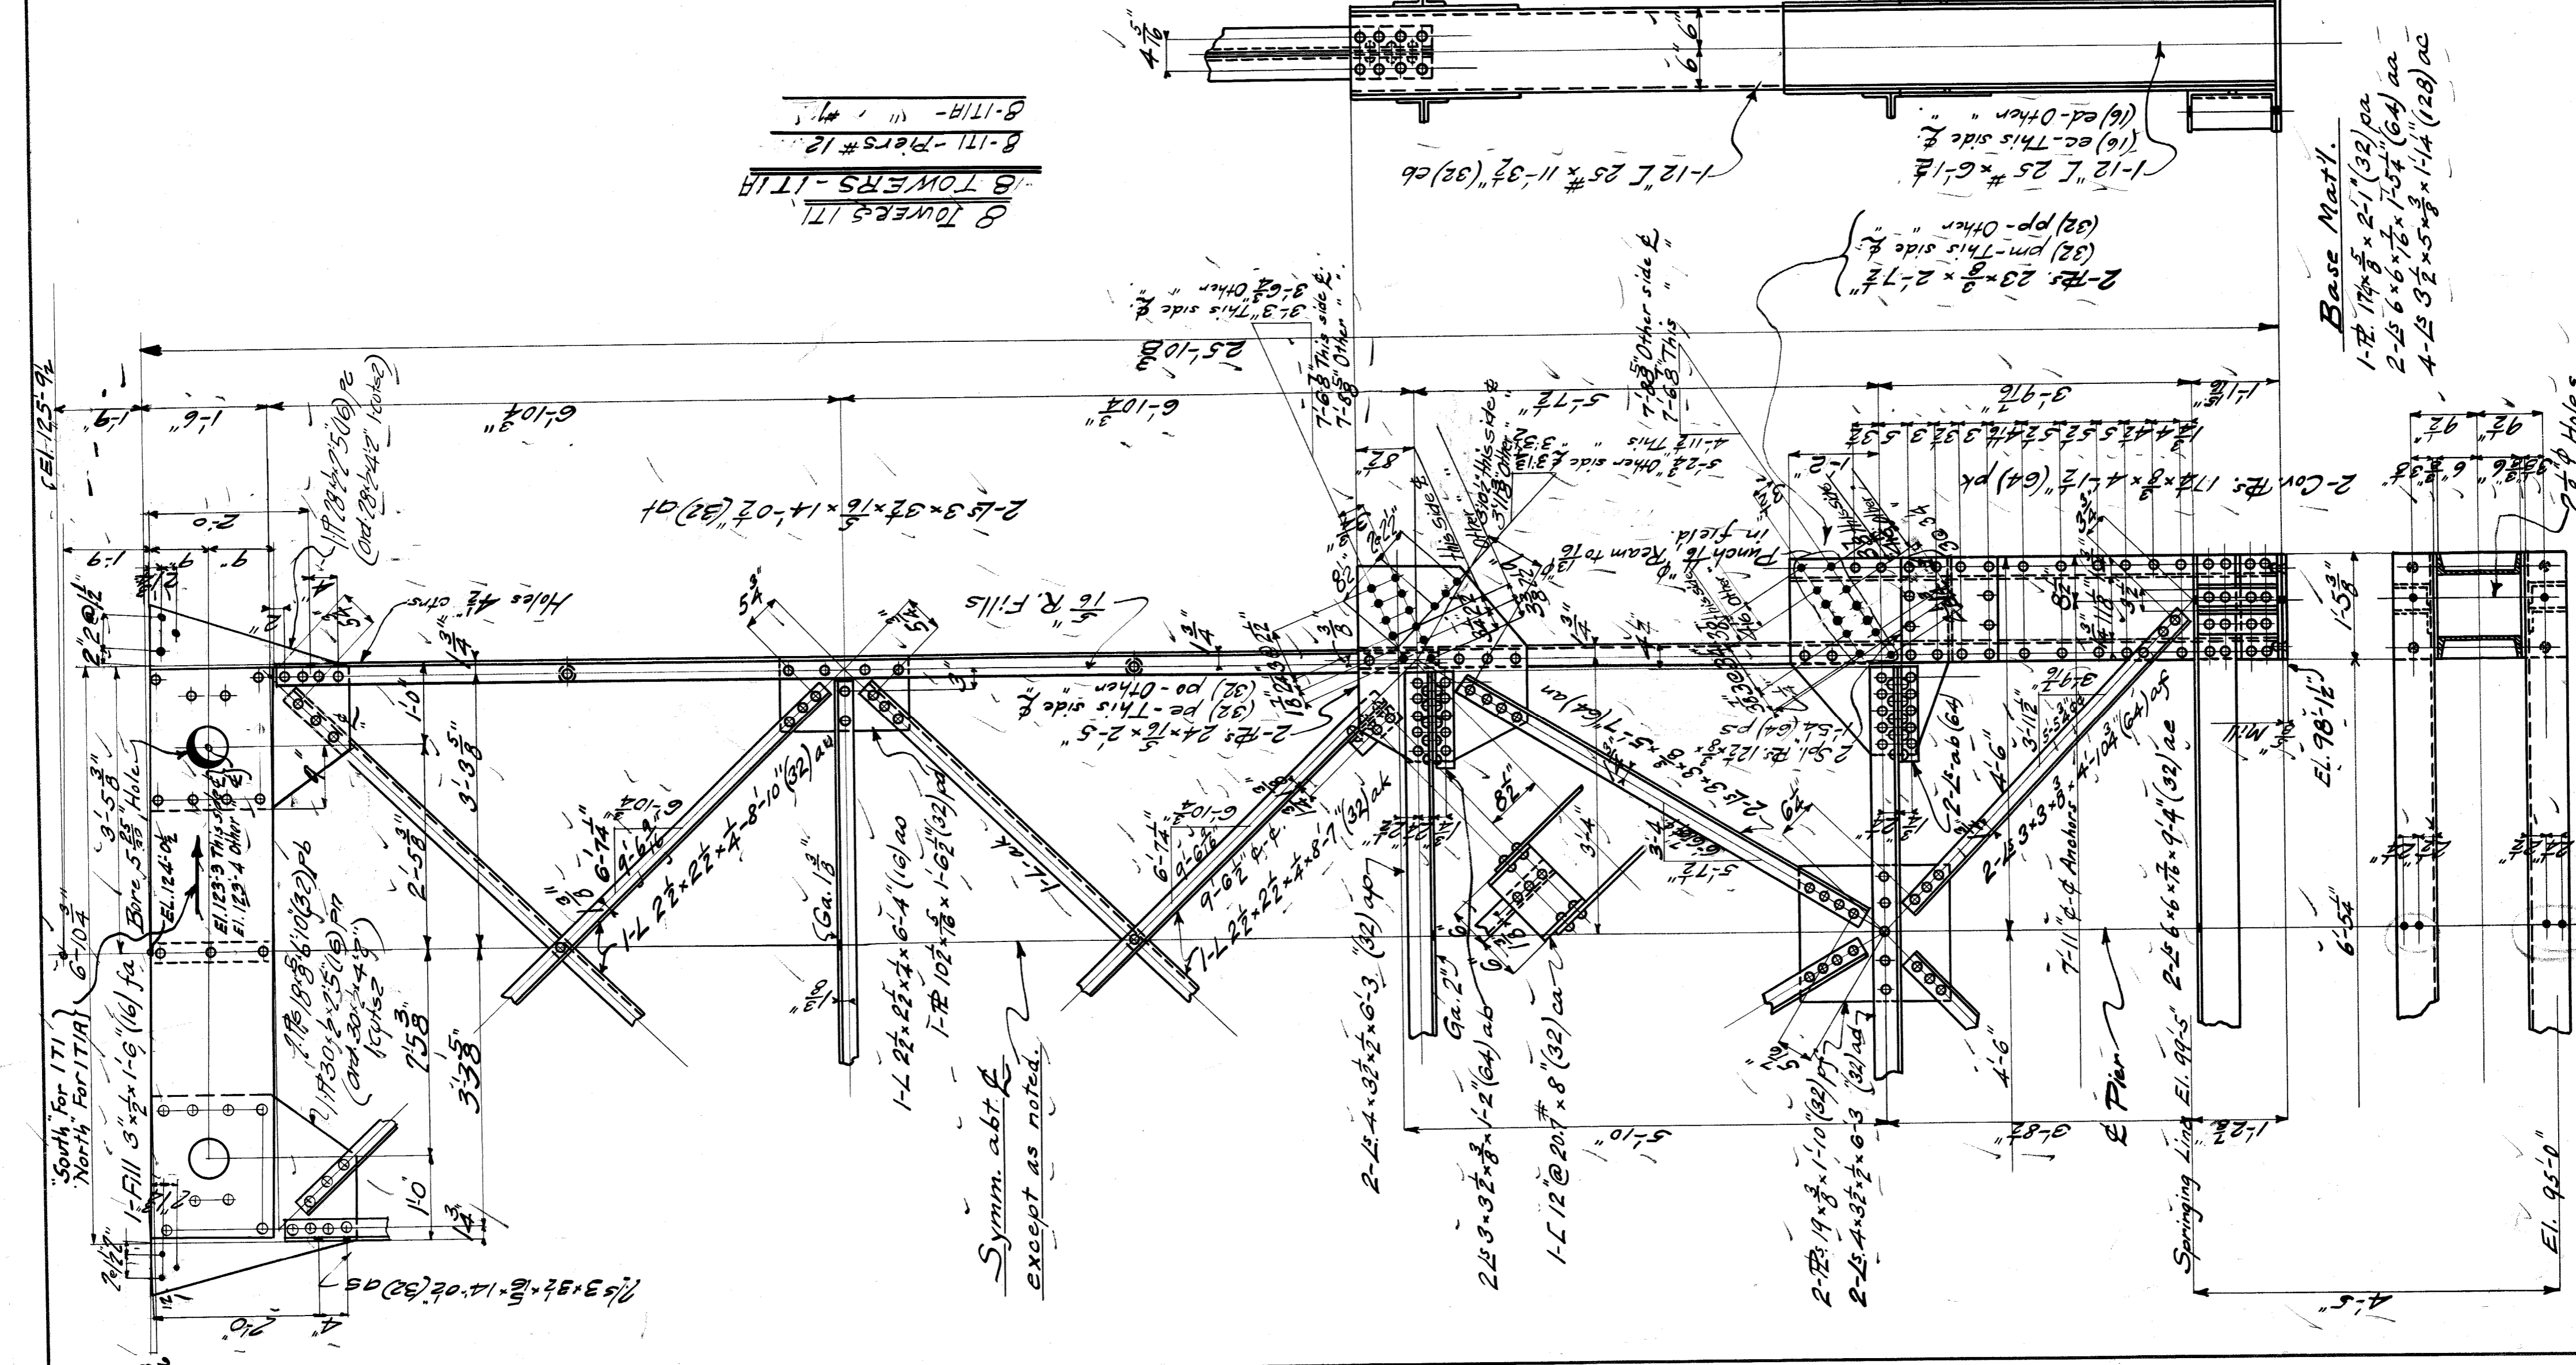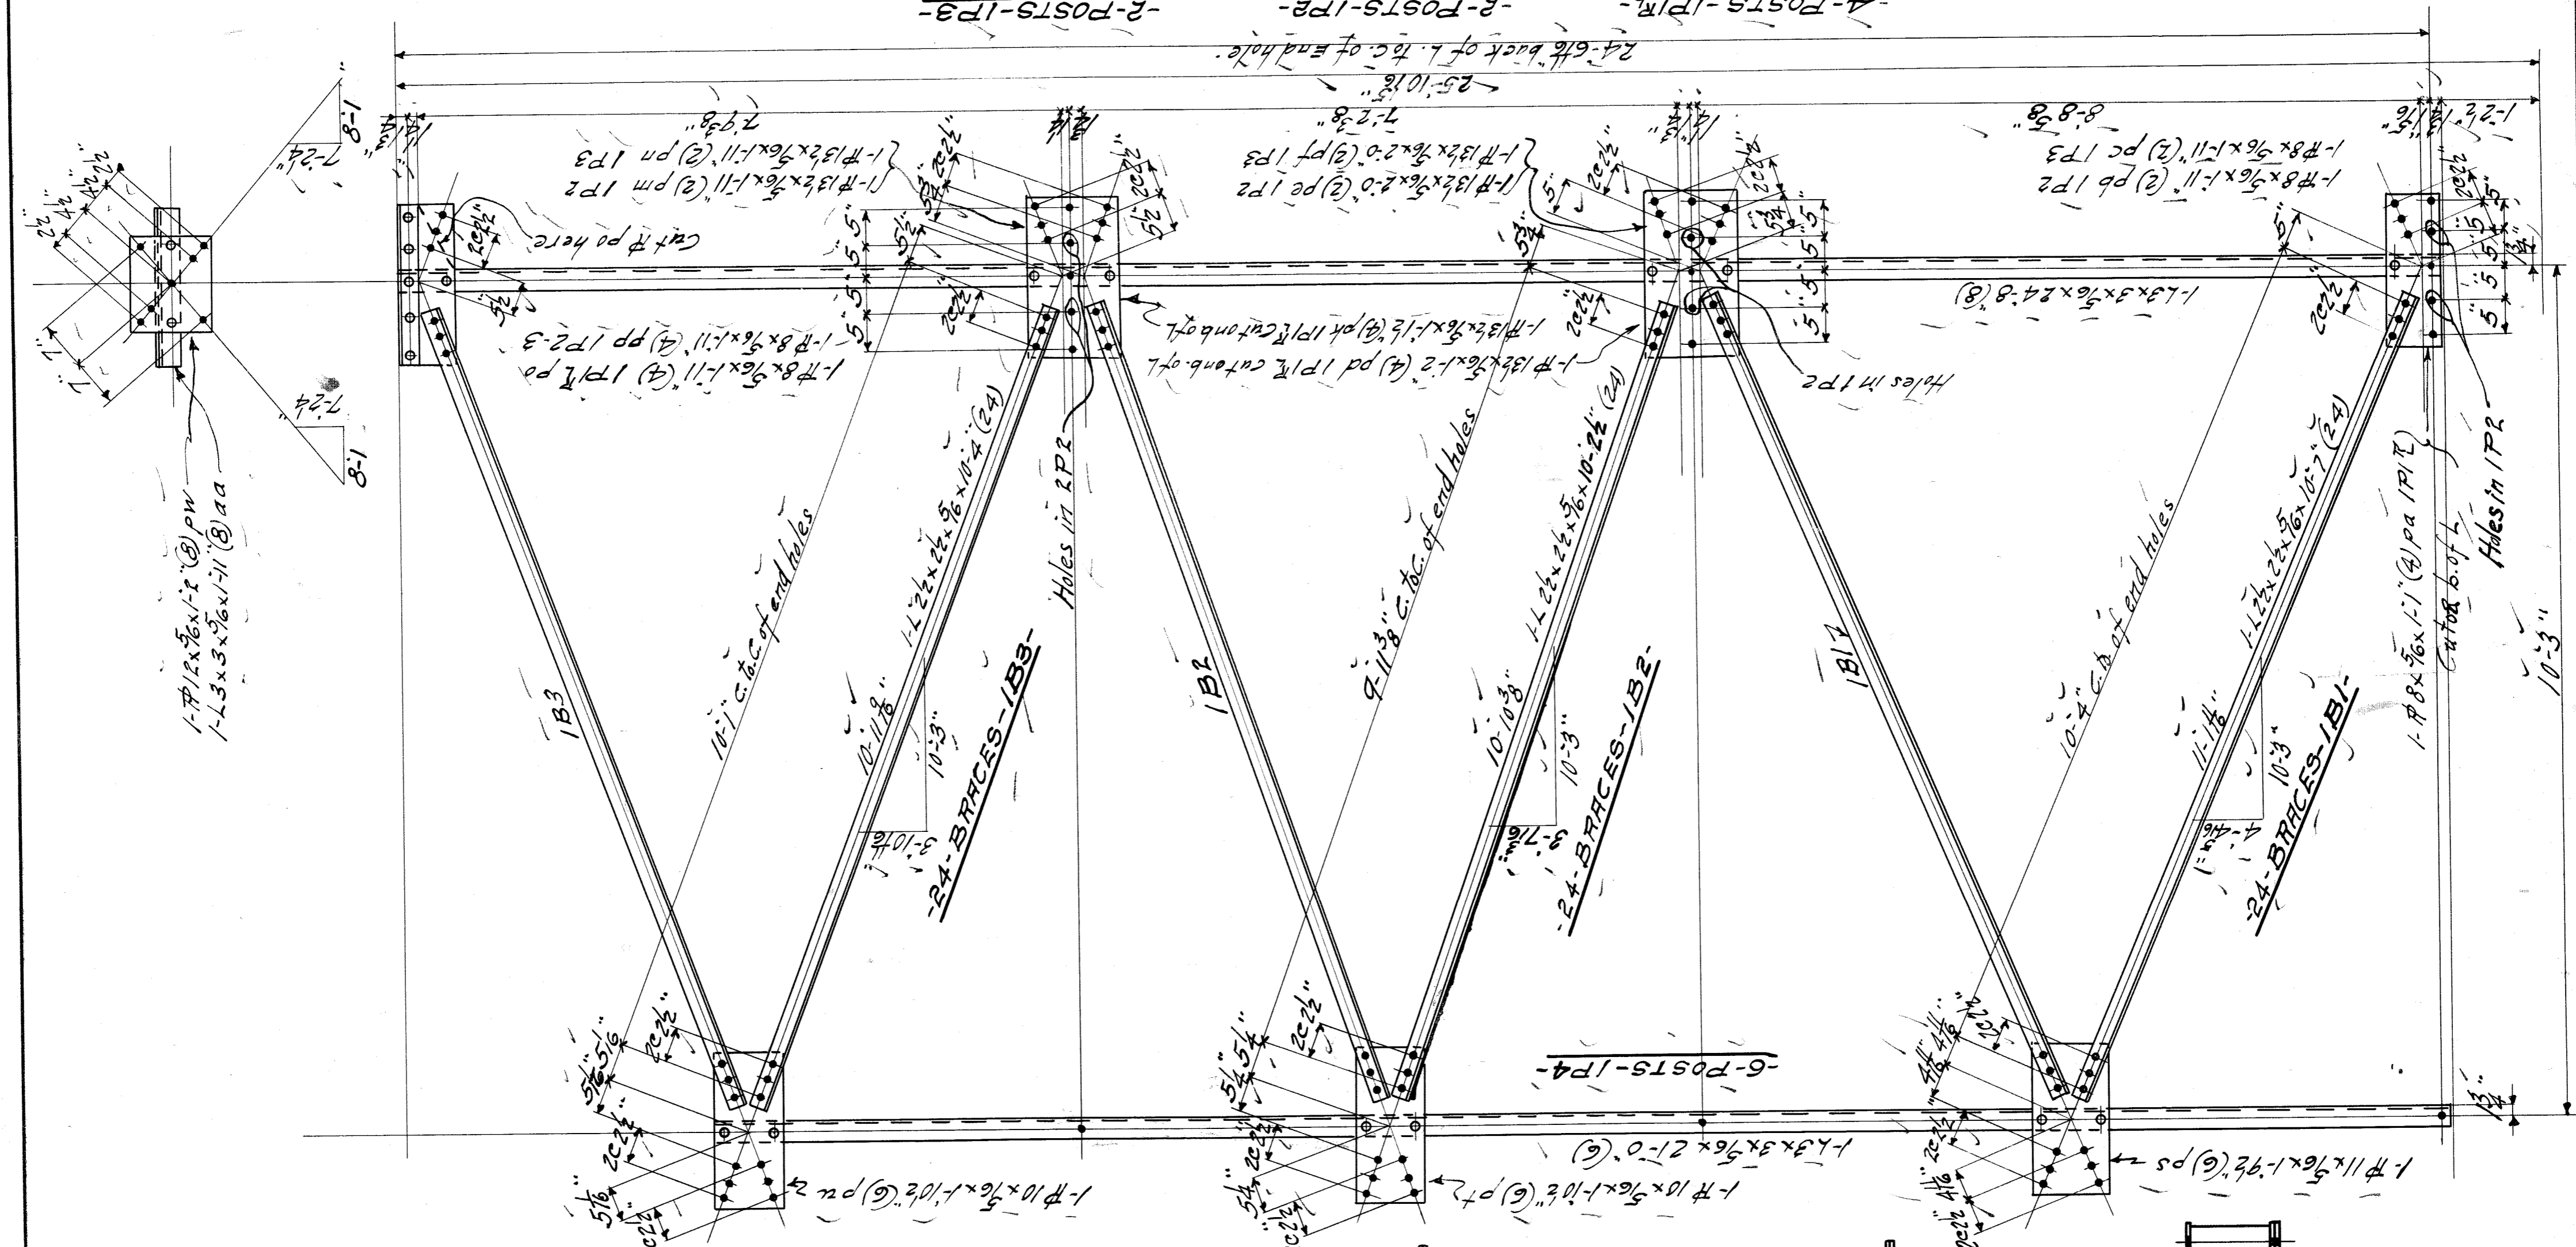

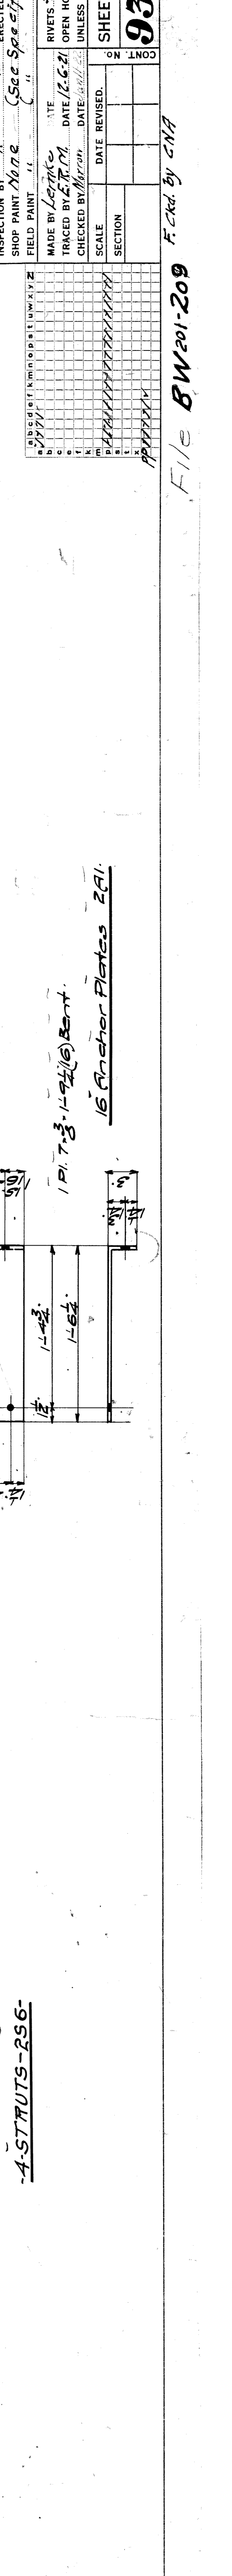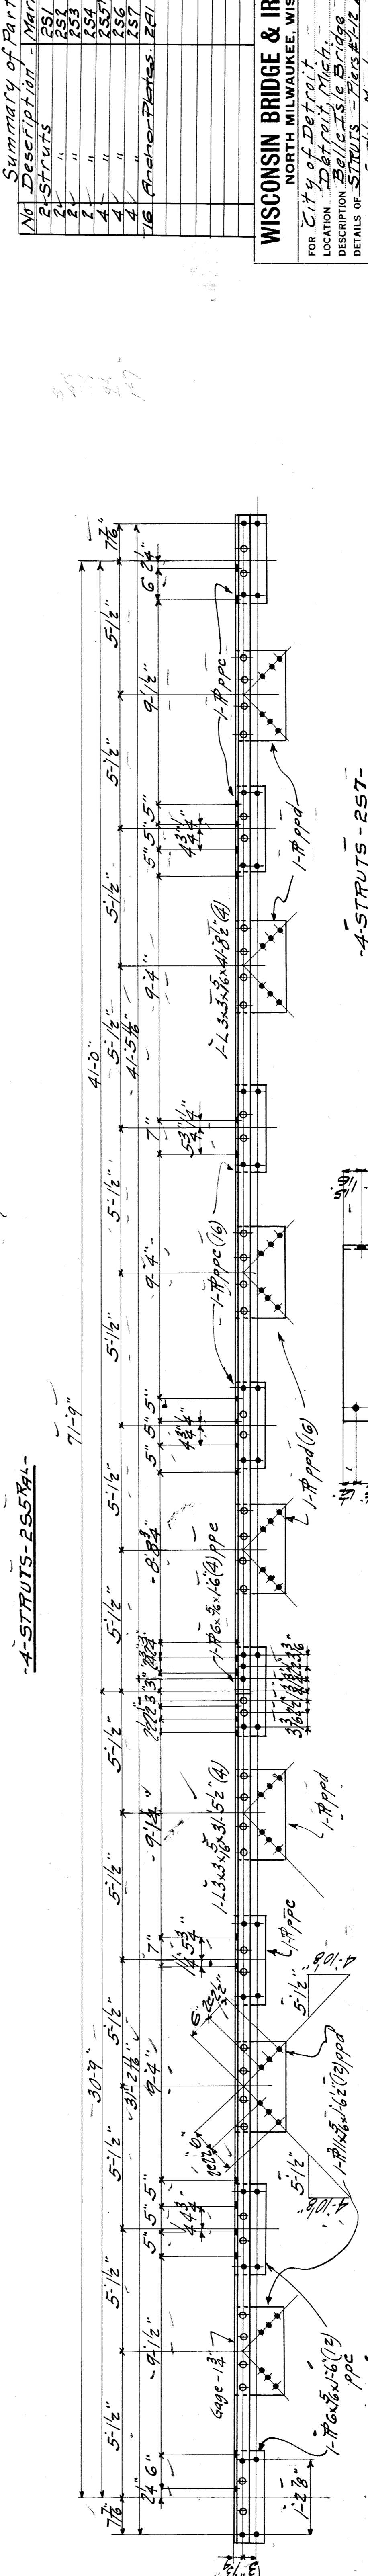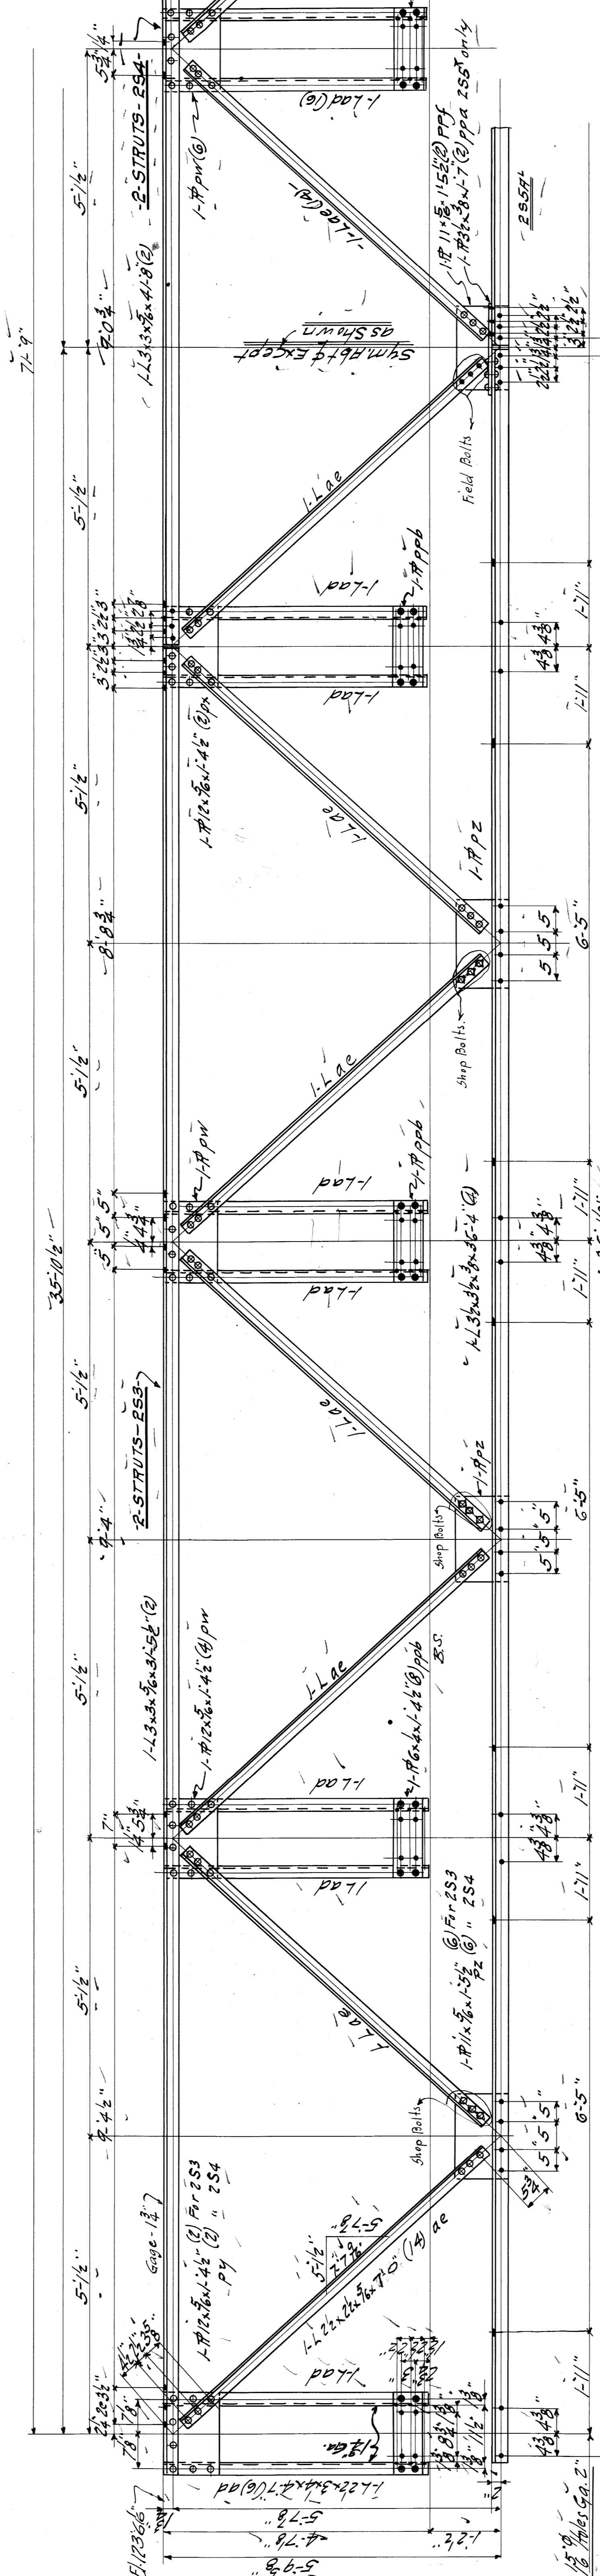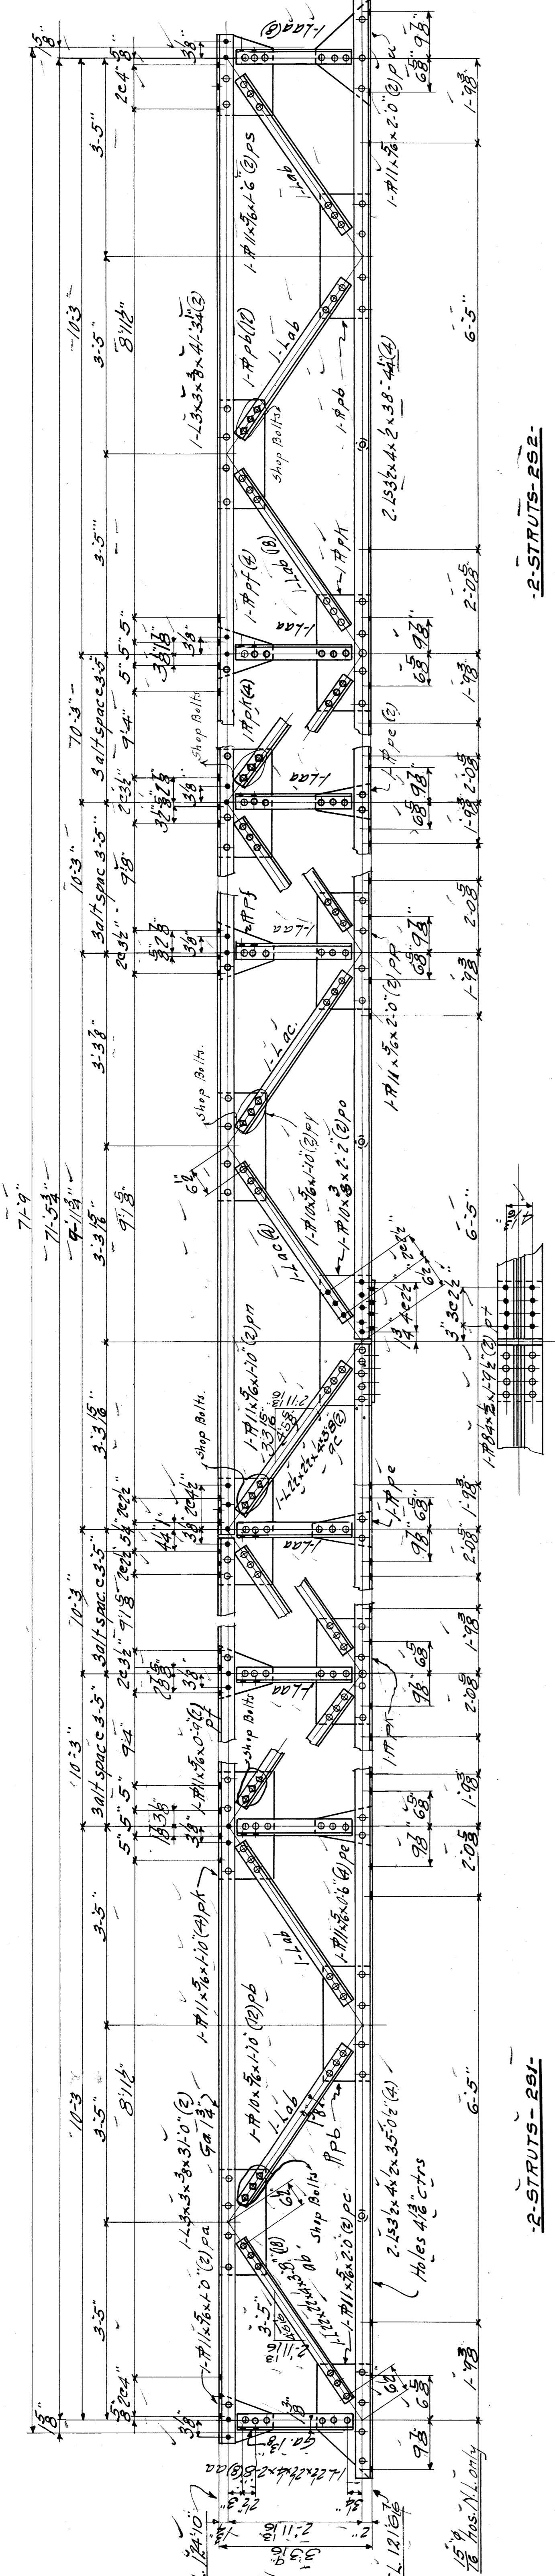


Summary of Parts

No.	Description	Quantity	Material	Notes
2	2-STRUTS	2	RS1	
4	4-STRUTS	4	RS3	
4	4-STRUTS	4	RS4	
4	4-STRUTS	4	RS6	
16	Anchor Plates	16	ZAI	

WISCONSIN BRIDGE & IRON CO.
NORTH MILWAUKEE, WIS.

FOR City of Detroit.
LOCATION Detroit, Mich.
DESCRIPTION Belle Isle Bridge
DETAILS OF STRUTS - FIELD & Left Hand
SPECIFICATIONS AS per Murphy & Reming Name
INSPECTED BY FIELD PAINTER
SHOP PAINT NAME (See Specifications)
FIELD PAINT
MADE BY L.P.M.
TRACED BY L.P.M. DATE 12-21-13
CHECKED BY [Signature] DATE 1-2-14
SCALE AS SHOWN
SECTION
RIVETS 3/4"
OPEN HOLES 1/8"
UNLESS NOTED
DATE REVISED
FILE NO. 2
9381






FILE 5W201-209
FILED BY CHA

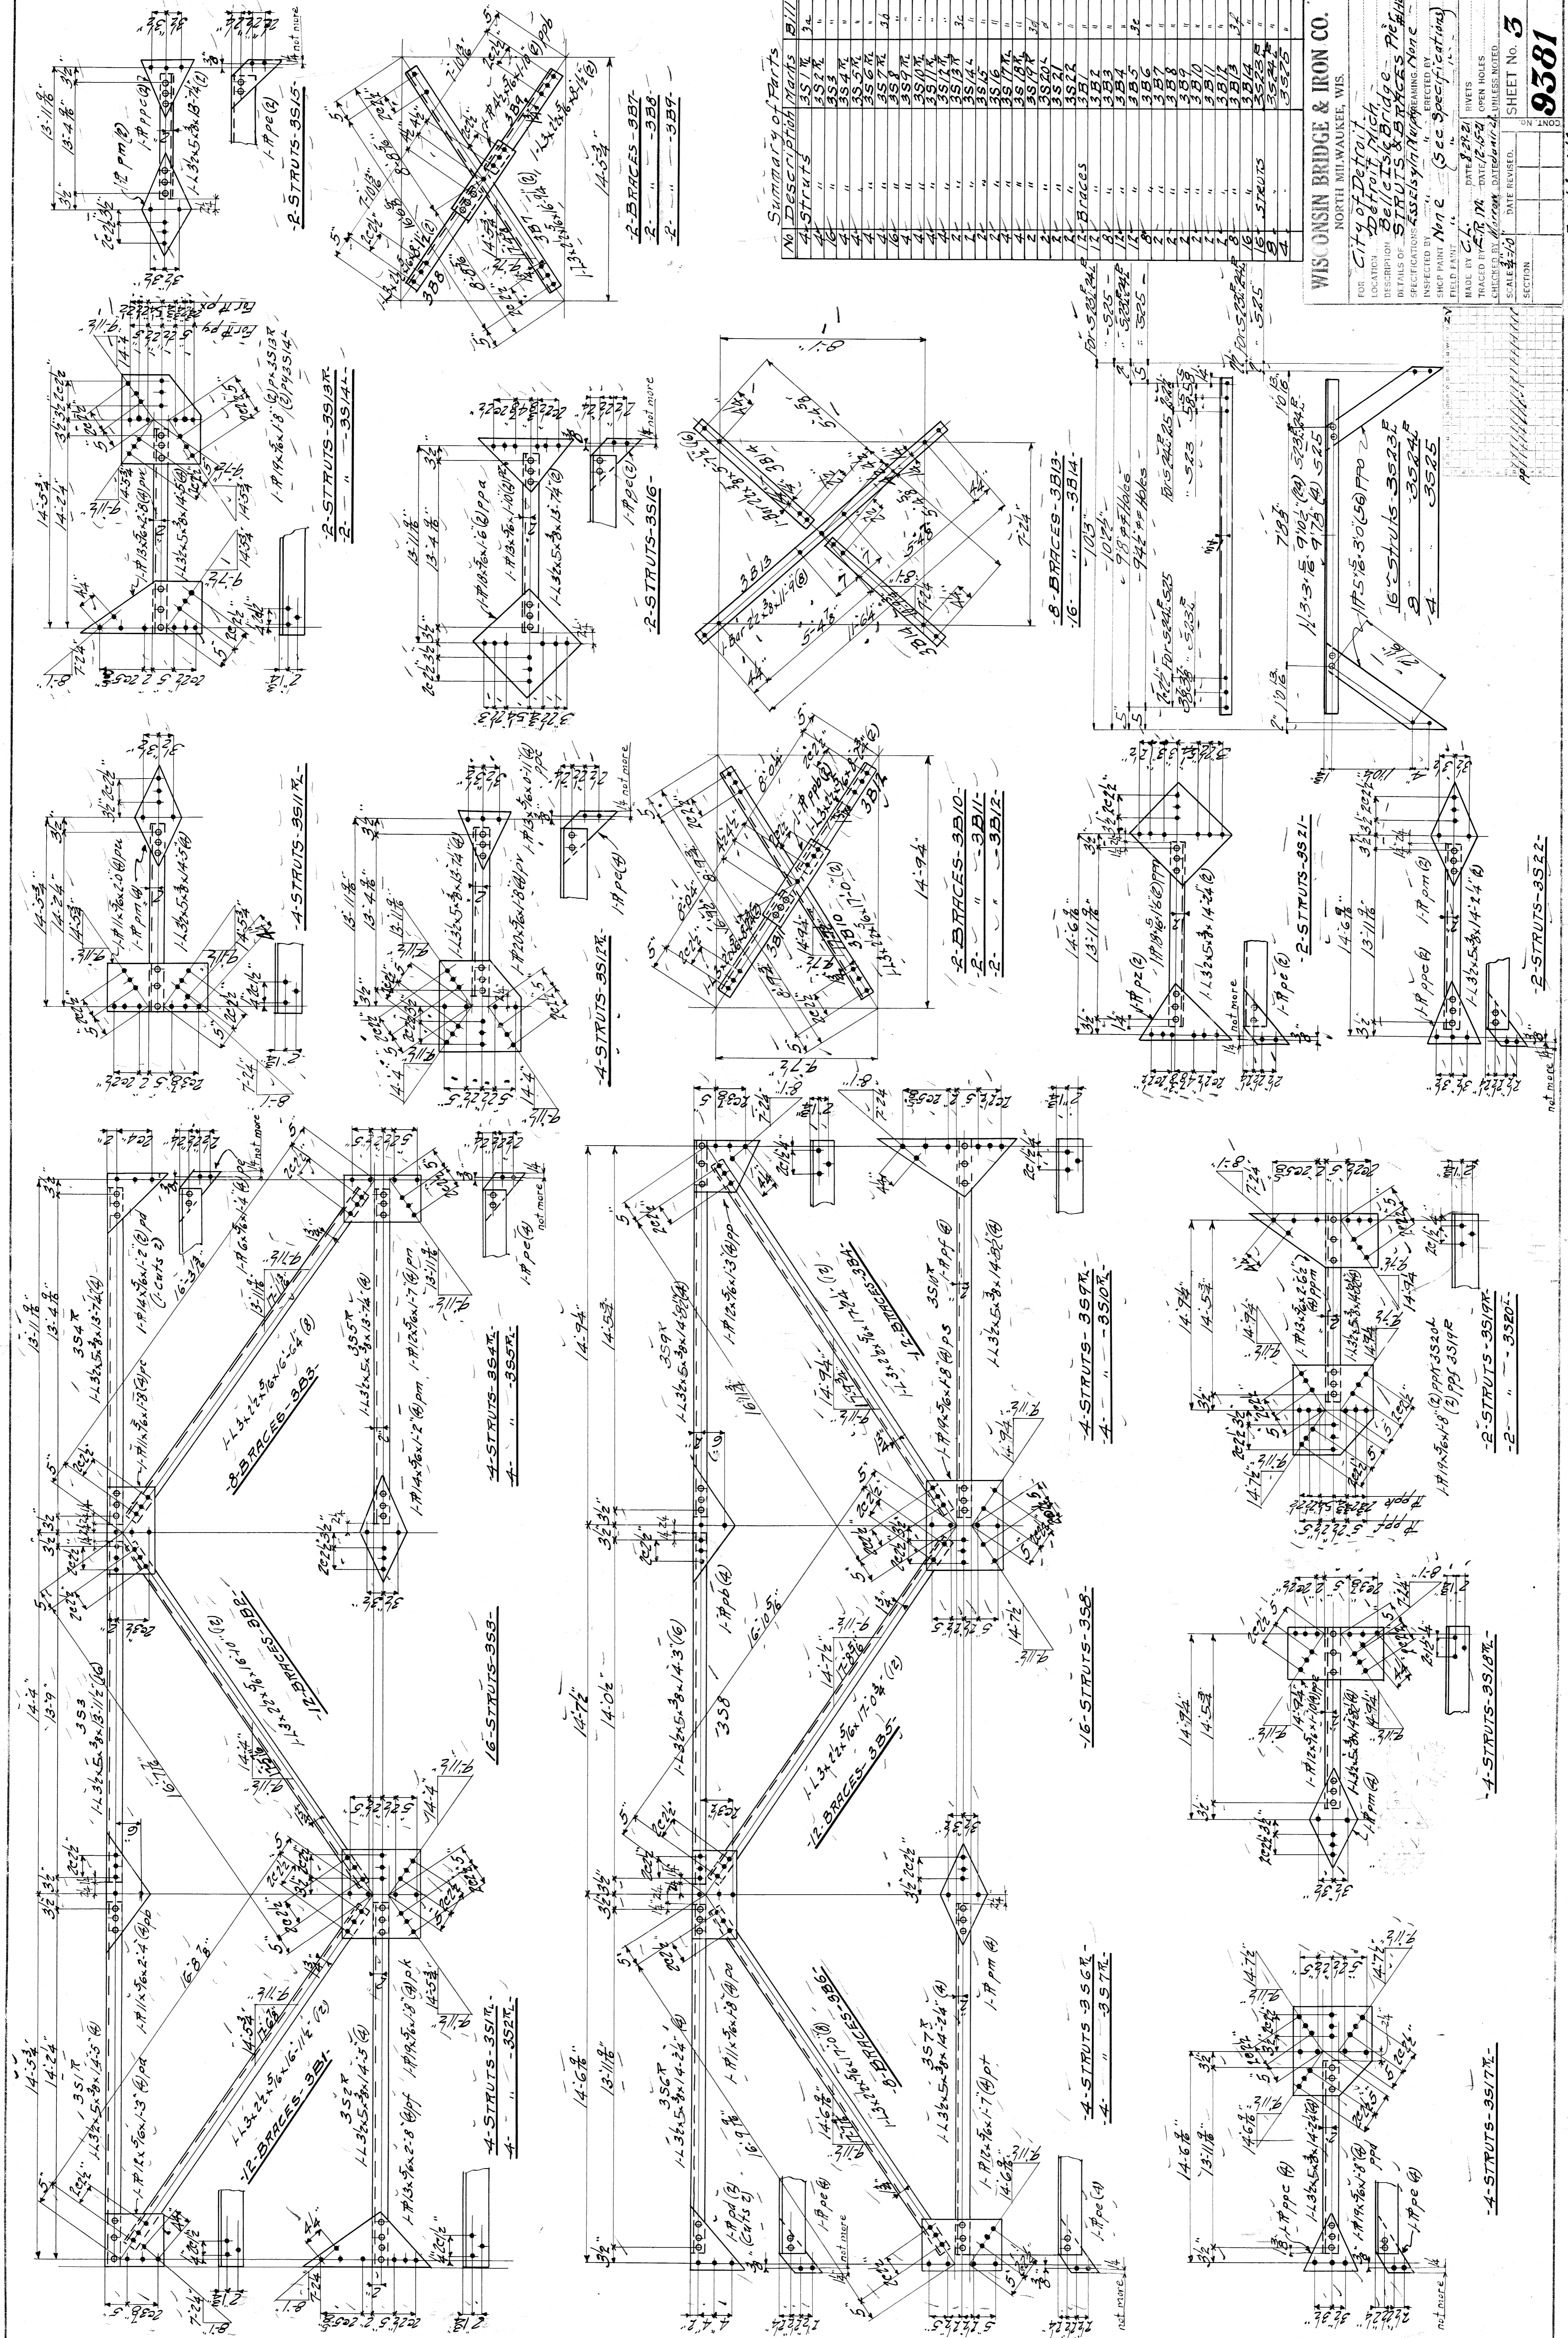

Summary of Parts

No	DESCRIPTION	QTY	UNIT
1	STRUTS	34	
2	"	34	
3	"	34	
4	"	34	
5	"	34	
6	"	34	
7	"	34	
8	"	34	
9	"	34	
10	"	34	
11	"	34	
12	"	34	
13	"	34	
14	"	34	
15	"	34	
16	"	34	
17	"	34	
18	"	34	
19	"	34	
20	"	34	
21	"	34	
22	"	34	
23	"	34	
24	"	34	
25	"	34	
26	"	34	
27	"	34	
28	"	34	
29	"	34	
30	"	34	
31	"	34	
32	"	34	
33	"	34	
34	"	34	

WISCONSIN BRIDGE & IRON CO.
 NORTH MILWAUKEE, WIS.
 FOR THE CITY OF DETROIT
 BELLEVILLE BRIDGE
 DETAILS OF
 STRUTS & BRACES
 SPECIFICATIONS AS SHOWN ON DRAWINGS MADE BY
 ENGR. PAUL N. N. (See Specifications)
 MADE BY
 TRACED BY
 CHECKED BY
 SCALE
 SECTION
 SHEET NO. **3**
9381

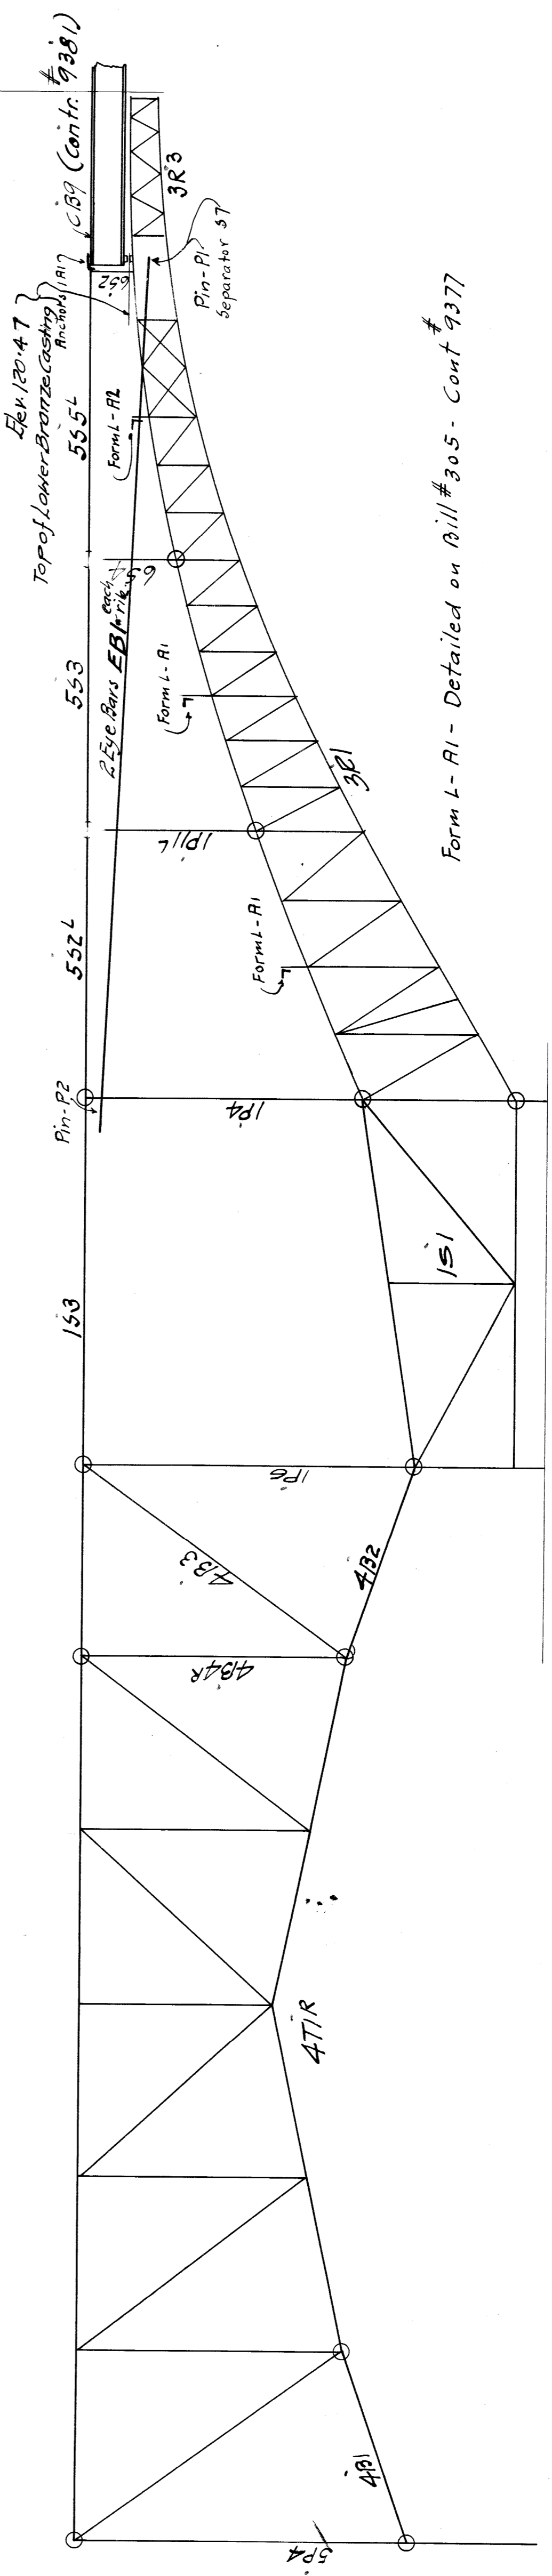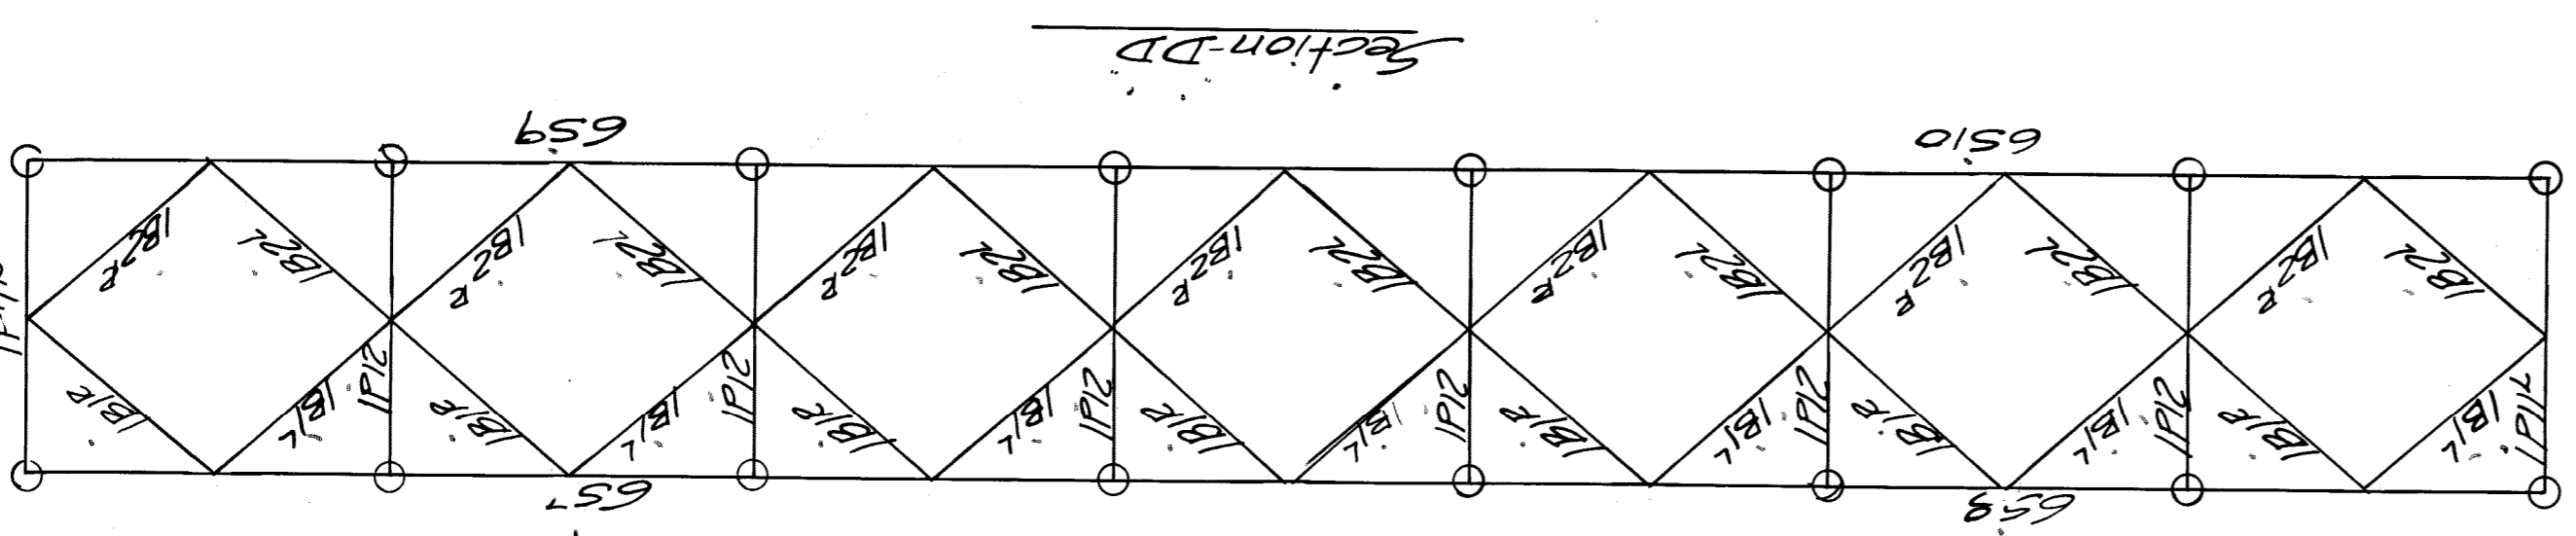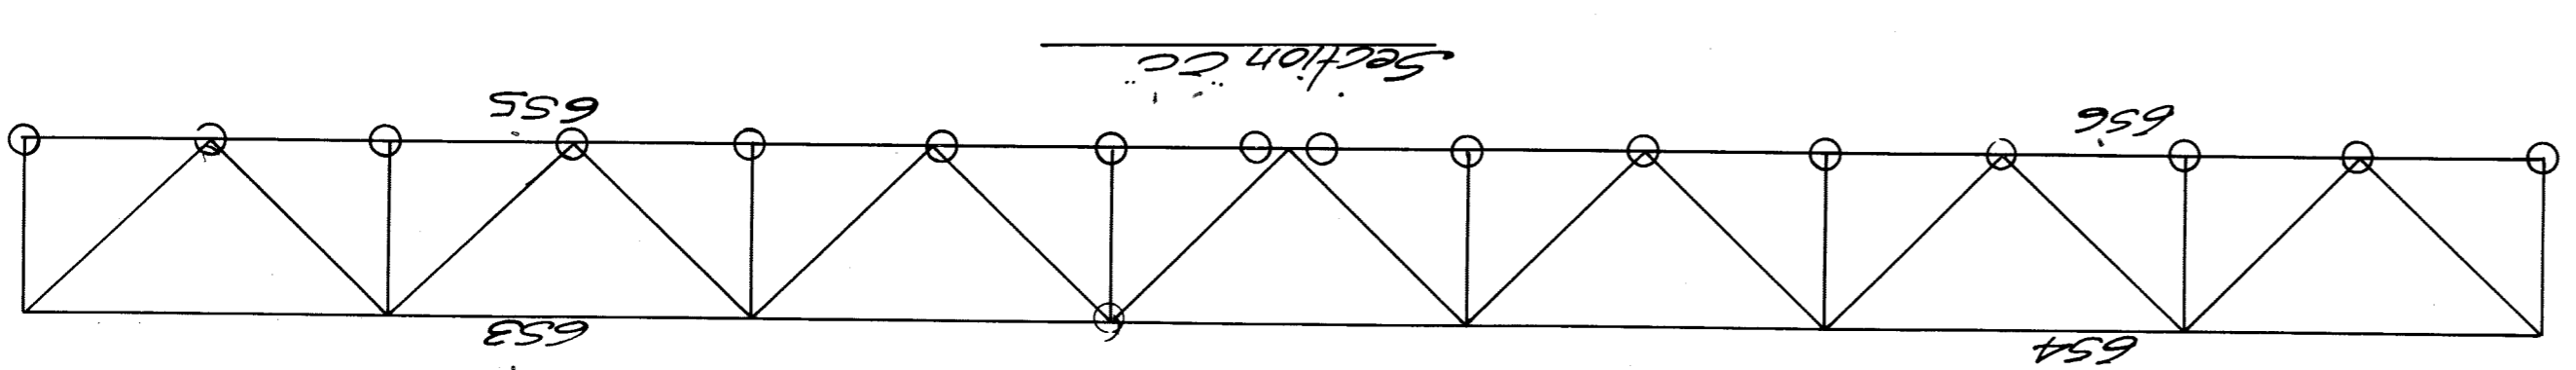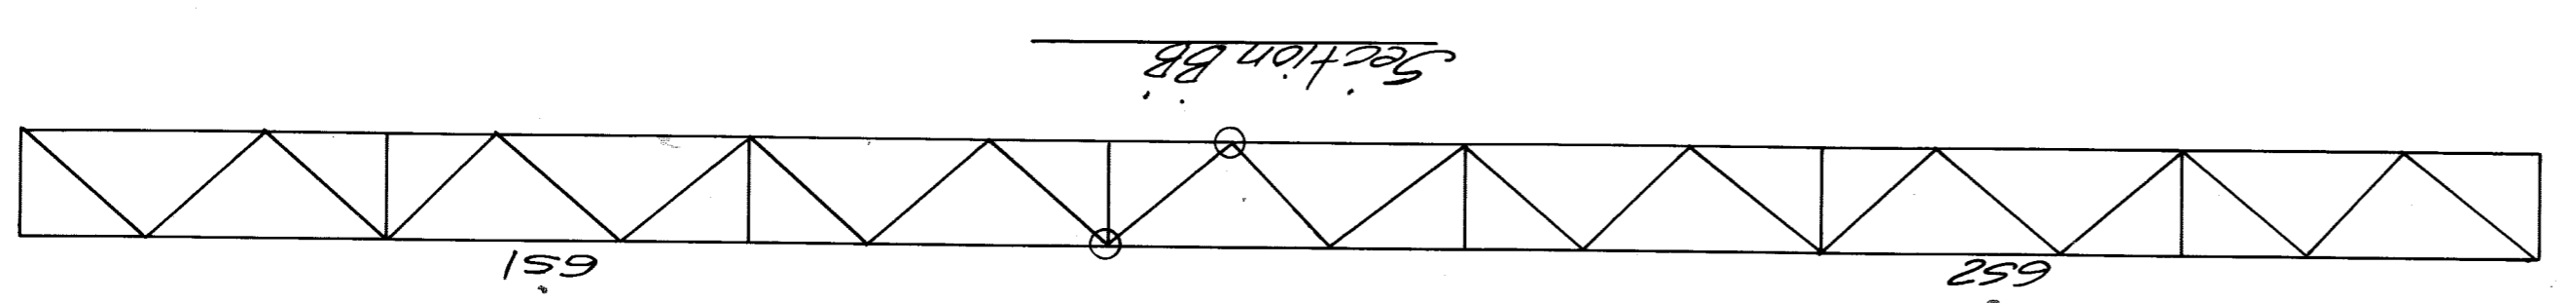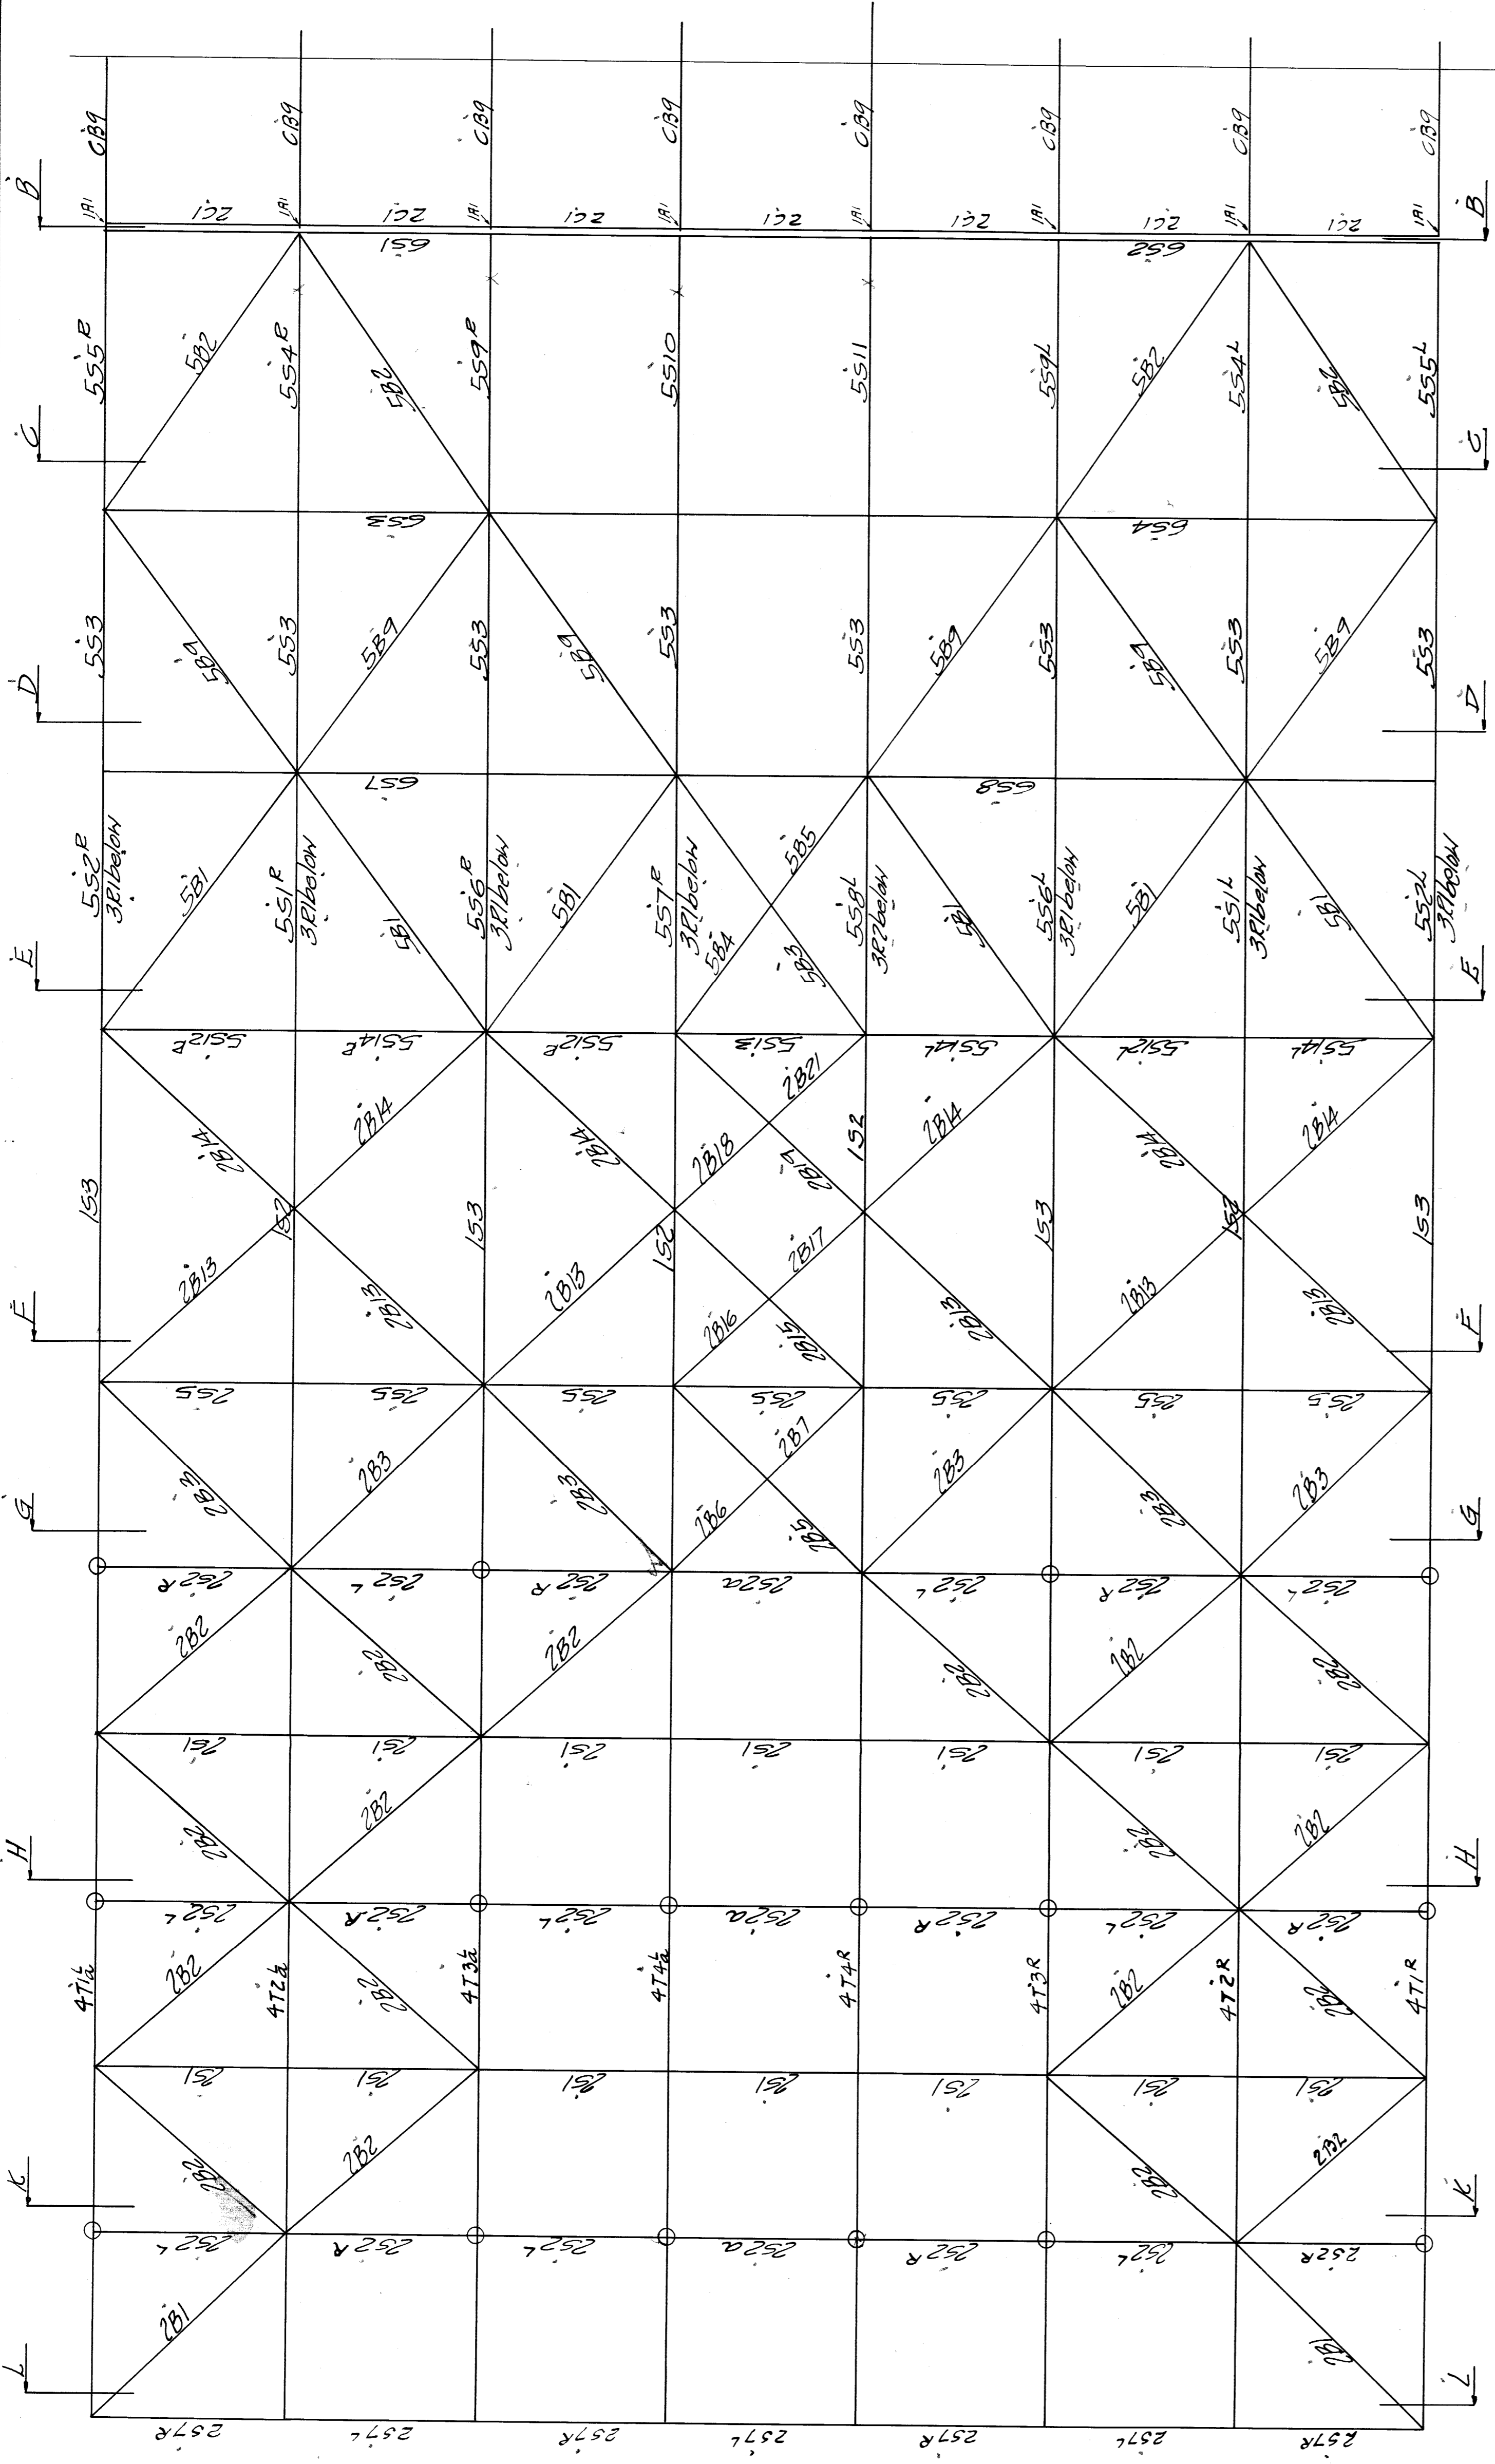

Rev 120-47
Top of Lower-Bracing
Pin-R1
Form-L-R1
Form-L-R2
Form-L-R3
Form-L-R100

Form L-R1 - Detailed on Bill # 305 - Cont 9377

For remainder of section see sheet

All points enclosed thus \circ are to be rivet
All other points bolted

WISCONSIN BRIDGE & IRON CO.
NORTH MILWAUKEE, WIS.

FOR: City of Detroit
LOCATION: Detroit, Mich.
DESCRIPTION: Belle Isle Bridge
DETAILS OF: Truss Iron Work


INSPECTION BY: _____
SPECIFICATIONS: _____
REMARKS: _____
ERECTED BY: A.B.T.A.

FIELD PAINT: _____
SHOP PAINT: _____

MADE BY: H.P.P. DATE: 11/27/21
TRACED BY: G.C. DATE: 11/27/21
OPEN HOLES: _____
UNLESS NOTED: _____

SCALE: 1/4" = 1'-0"
SECTION: _____

SHEET No. 51
9382

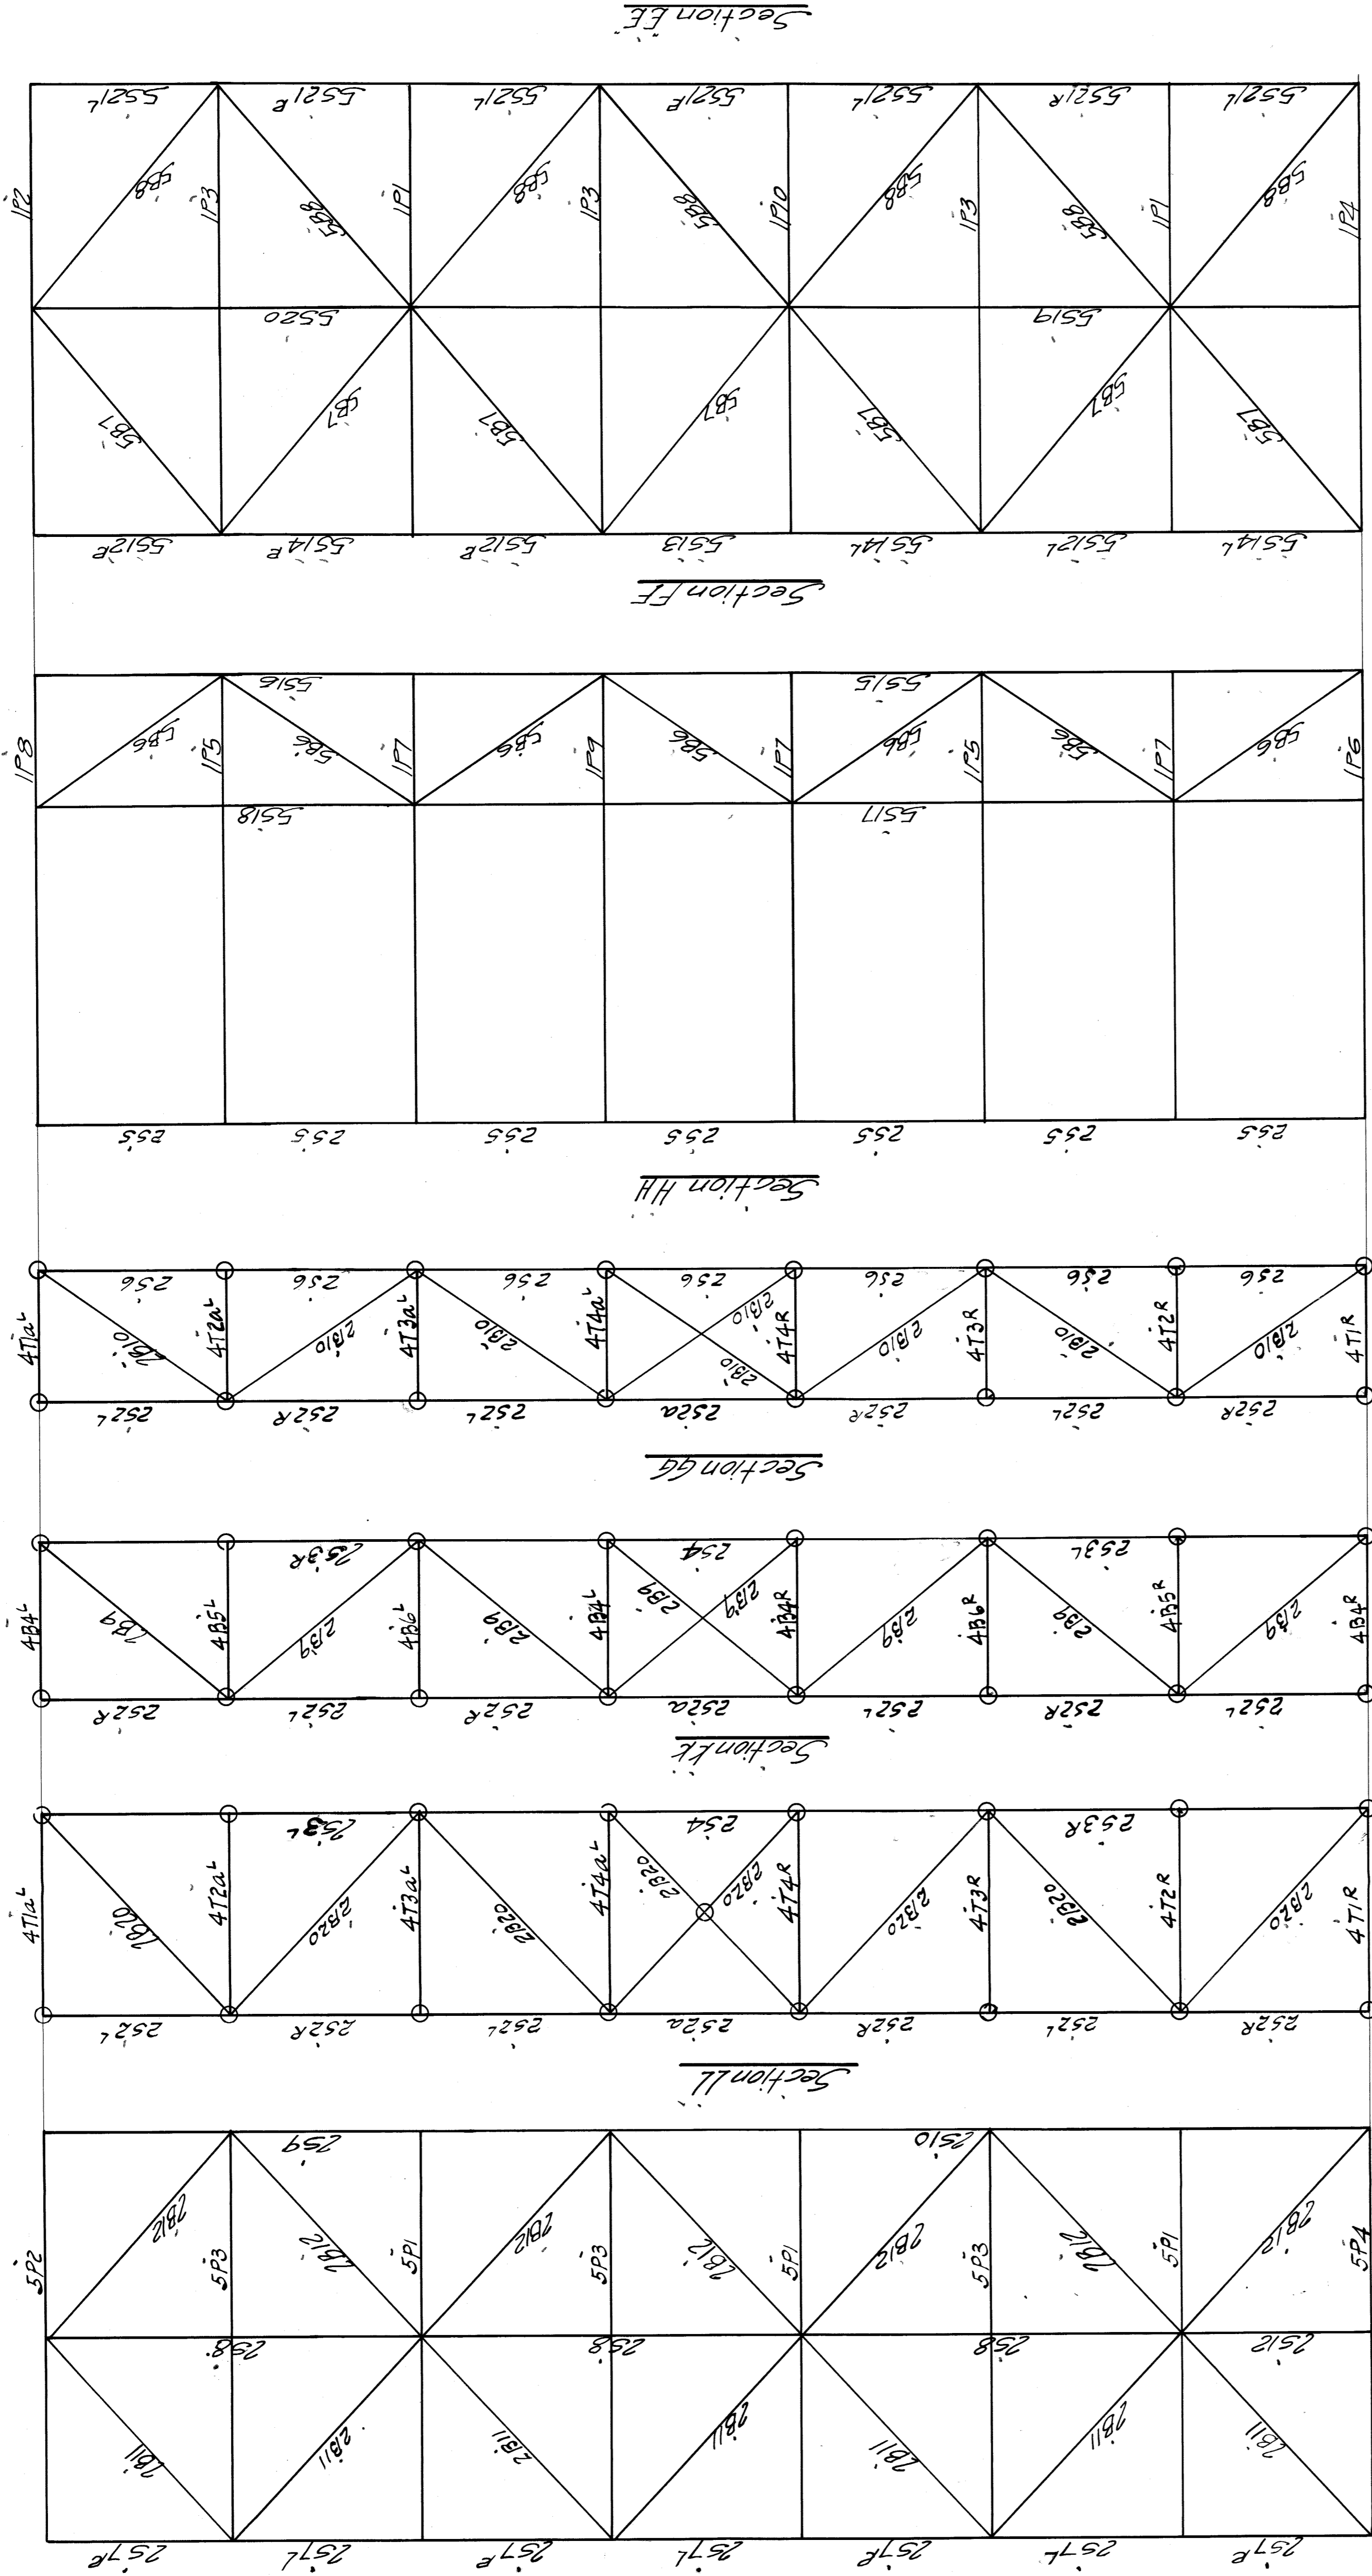

All points encircled thus O are to be riveted
 All other points bolted

Remainder see sheet # E1

WISCONSIN BRIDGE & IRON CO.
 NORTH MILWAUKEE, WIS.

FOR: City of Detroit
 LOCATION: Detroit Mich.
 DESCRIPTION: Belle Isle Bridge
 DETAILS OF: Section D-2

INSPECTION BY: None (See specifications)
 SHOP PAINT: None (See specifications)
 MADE BY: NHP (See specifications)
 TRACED BY: Lankle (See specifications)

ERECTED BY: M.B.I. Co.
 RIVETS: 3/4" OPEN HOLES 1/2" UNLESS NOTED


DATE: 11/22/27
 CHECKED BY: DATE: UNLESS NOTED

SCALE: SECTION: SHEET No. **E2**

9382


CONT. NO. SECTION

File BW29-215

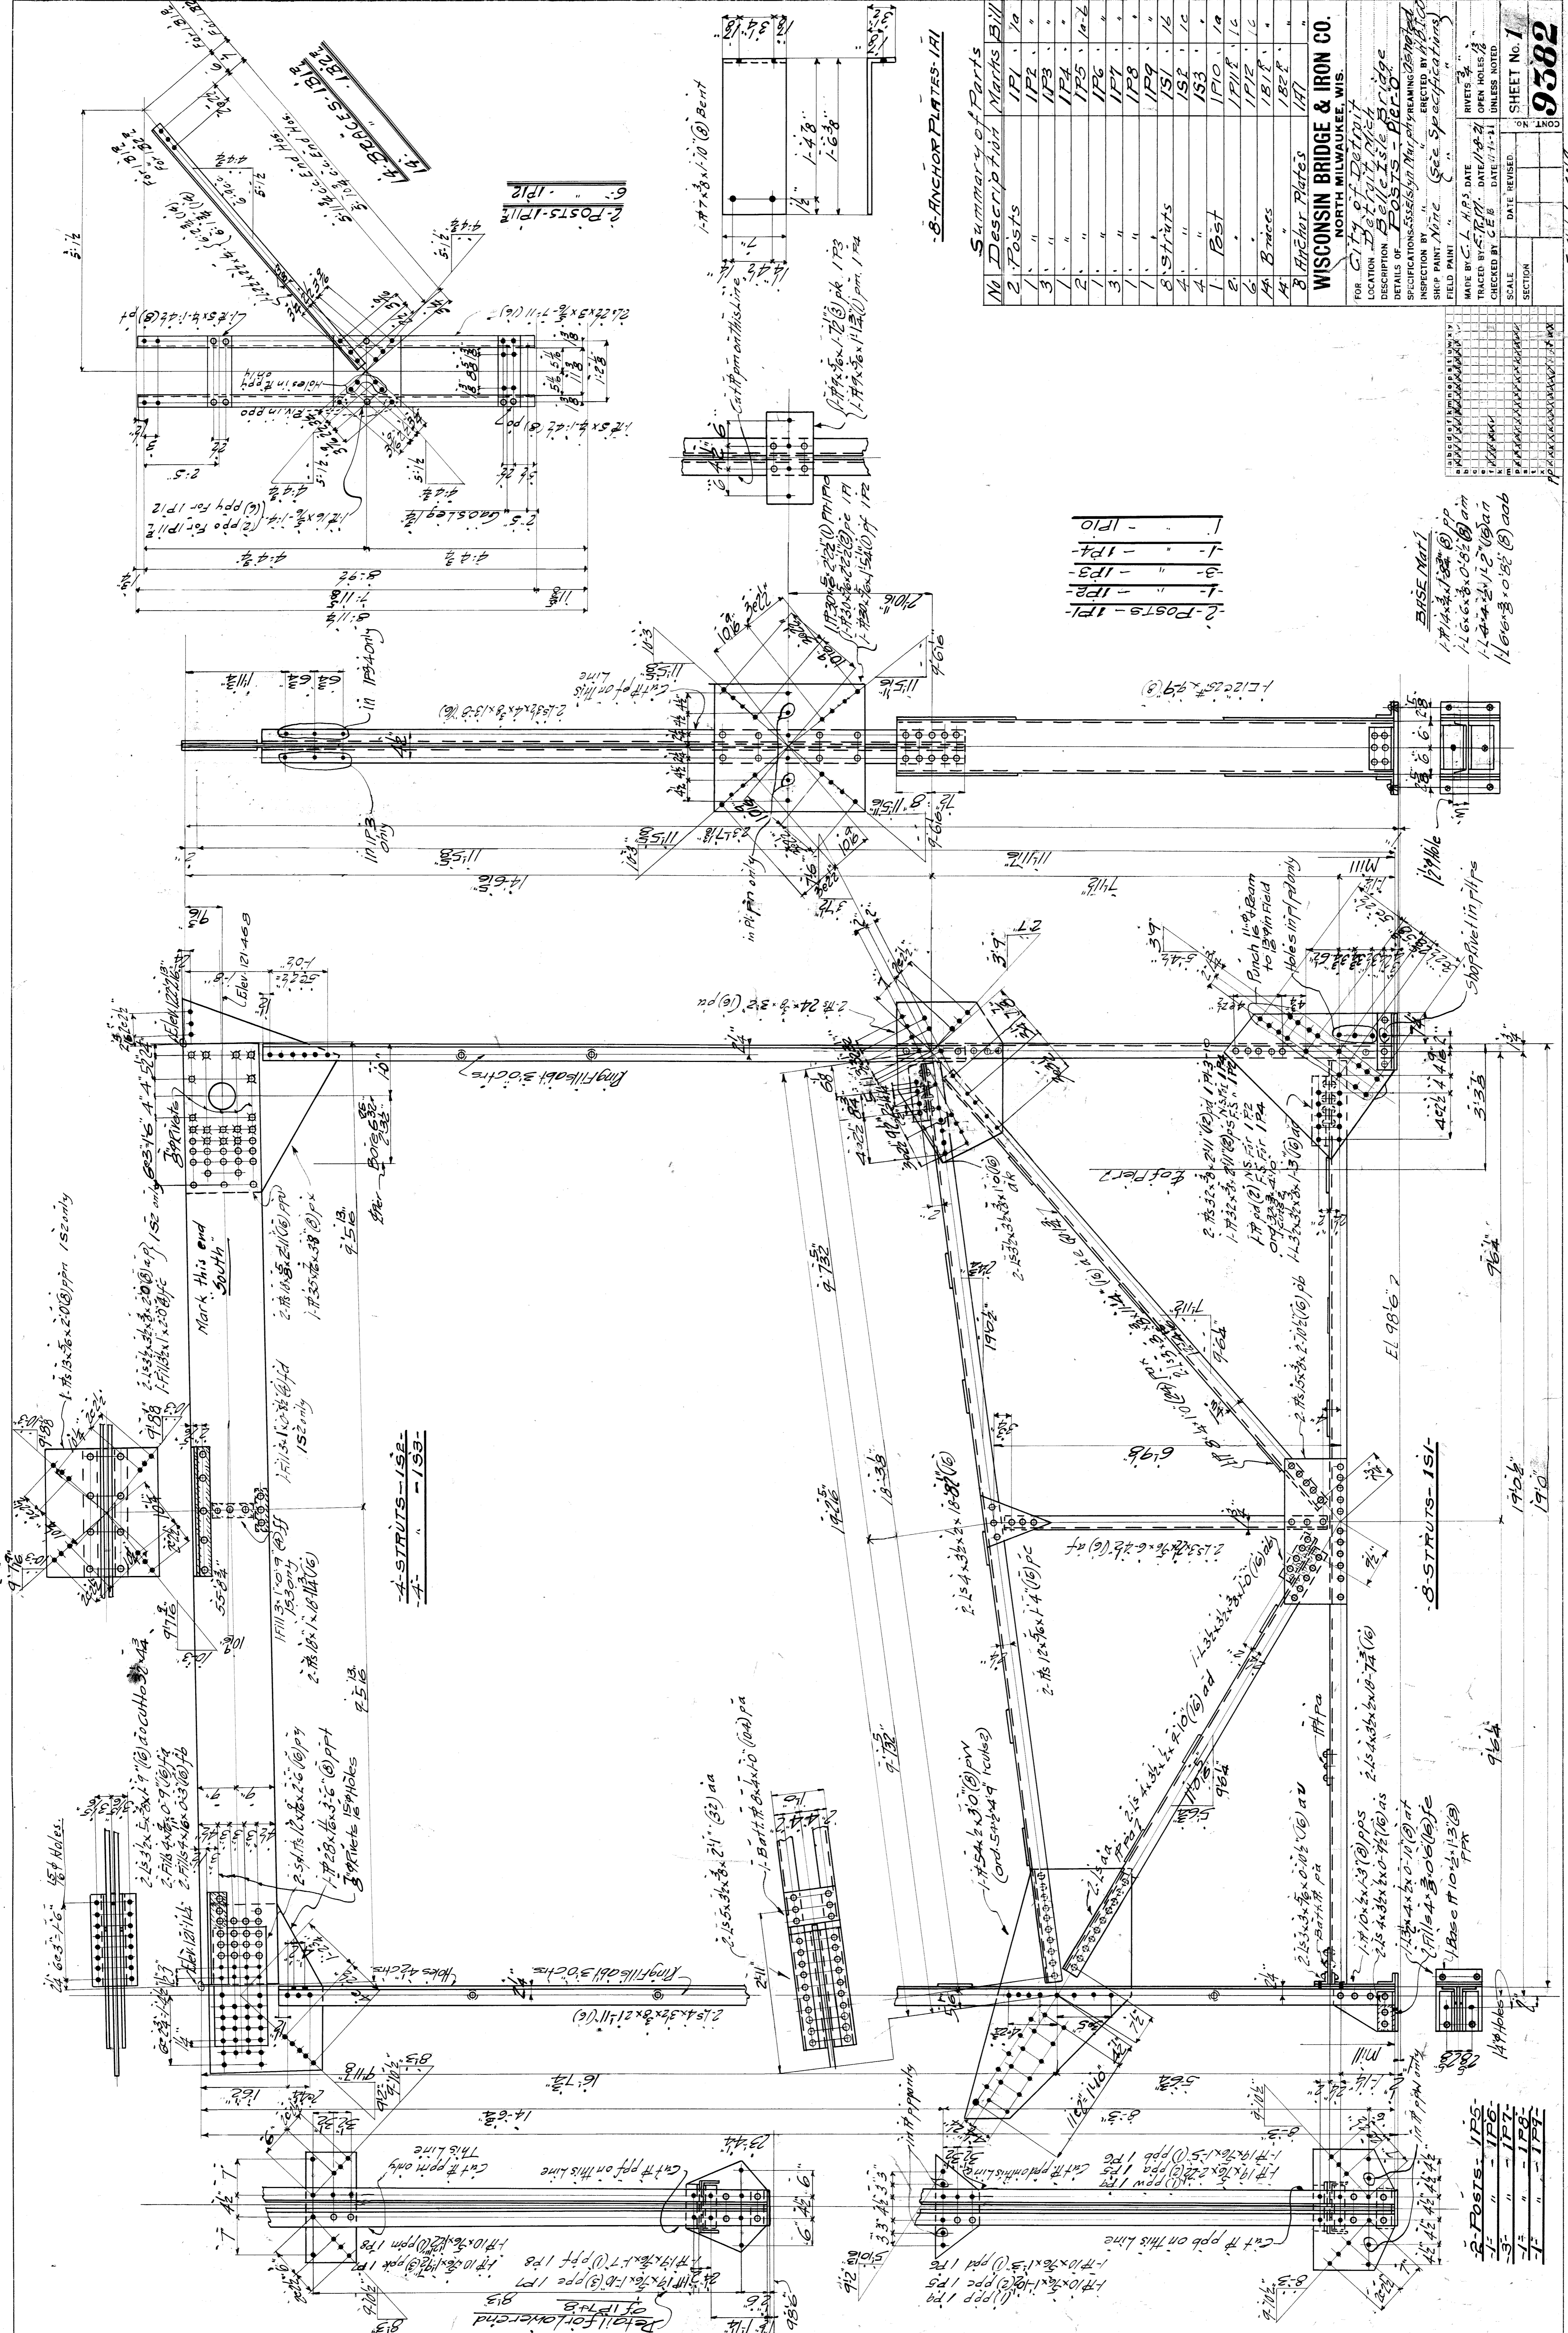

Summary of Parts


No	Description	Material	Quantity
1	Posts	IP1	10
2	"	IP2	"
3	"	IP3	"
4	"	IP4	"
5	"	IP5	"
6	"	IP6	"
7	"	IP7	"
8	"	IP8	"
9	"	IP9	"
10	Struts	IS1	16
11	"	IS2	16
12	"	IS3	16
13	"	IS4	16
309	"	IS300	16

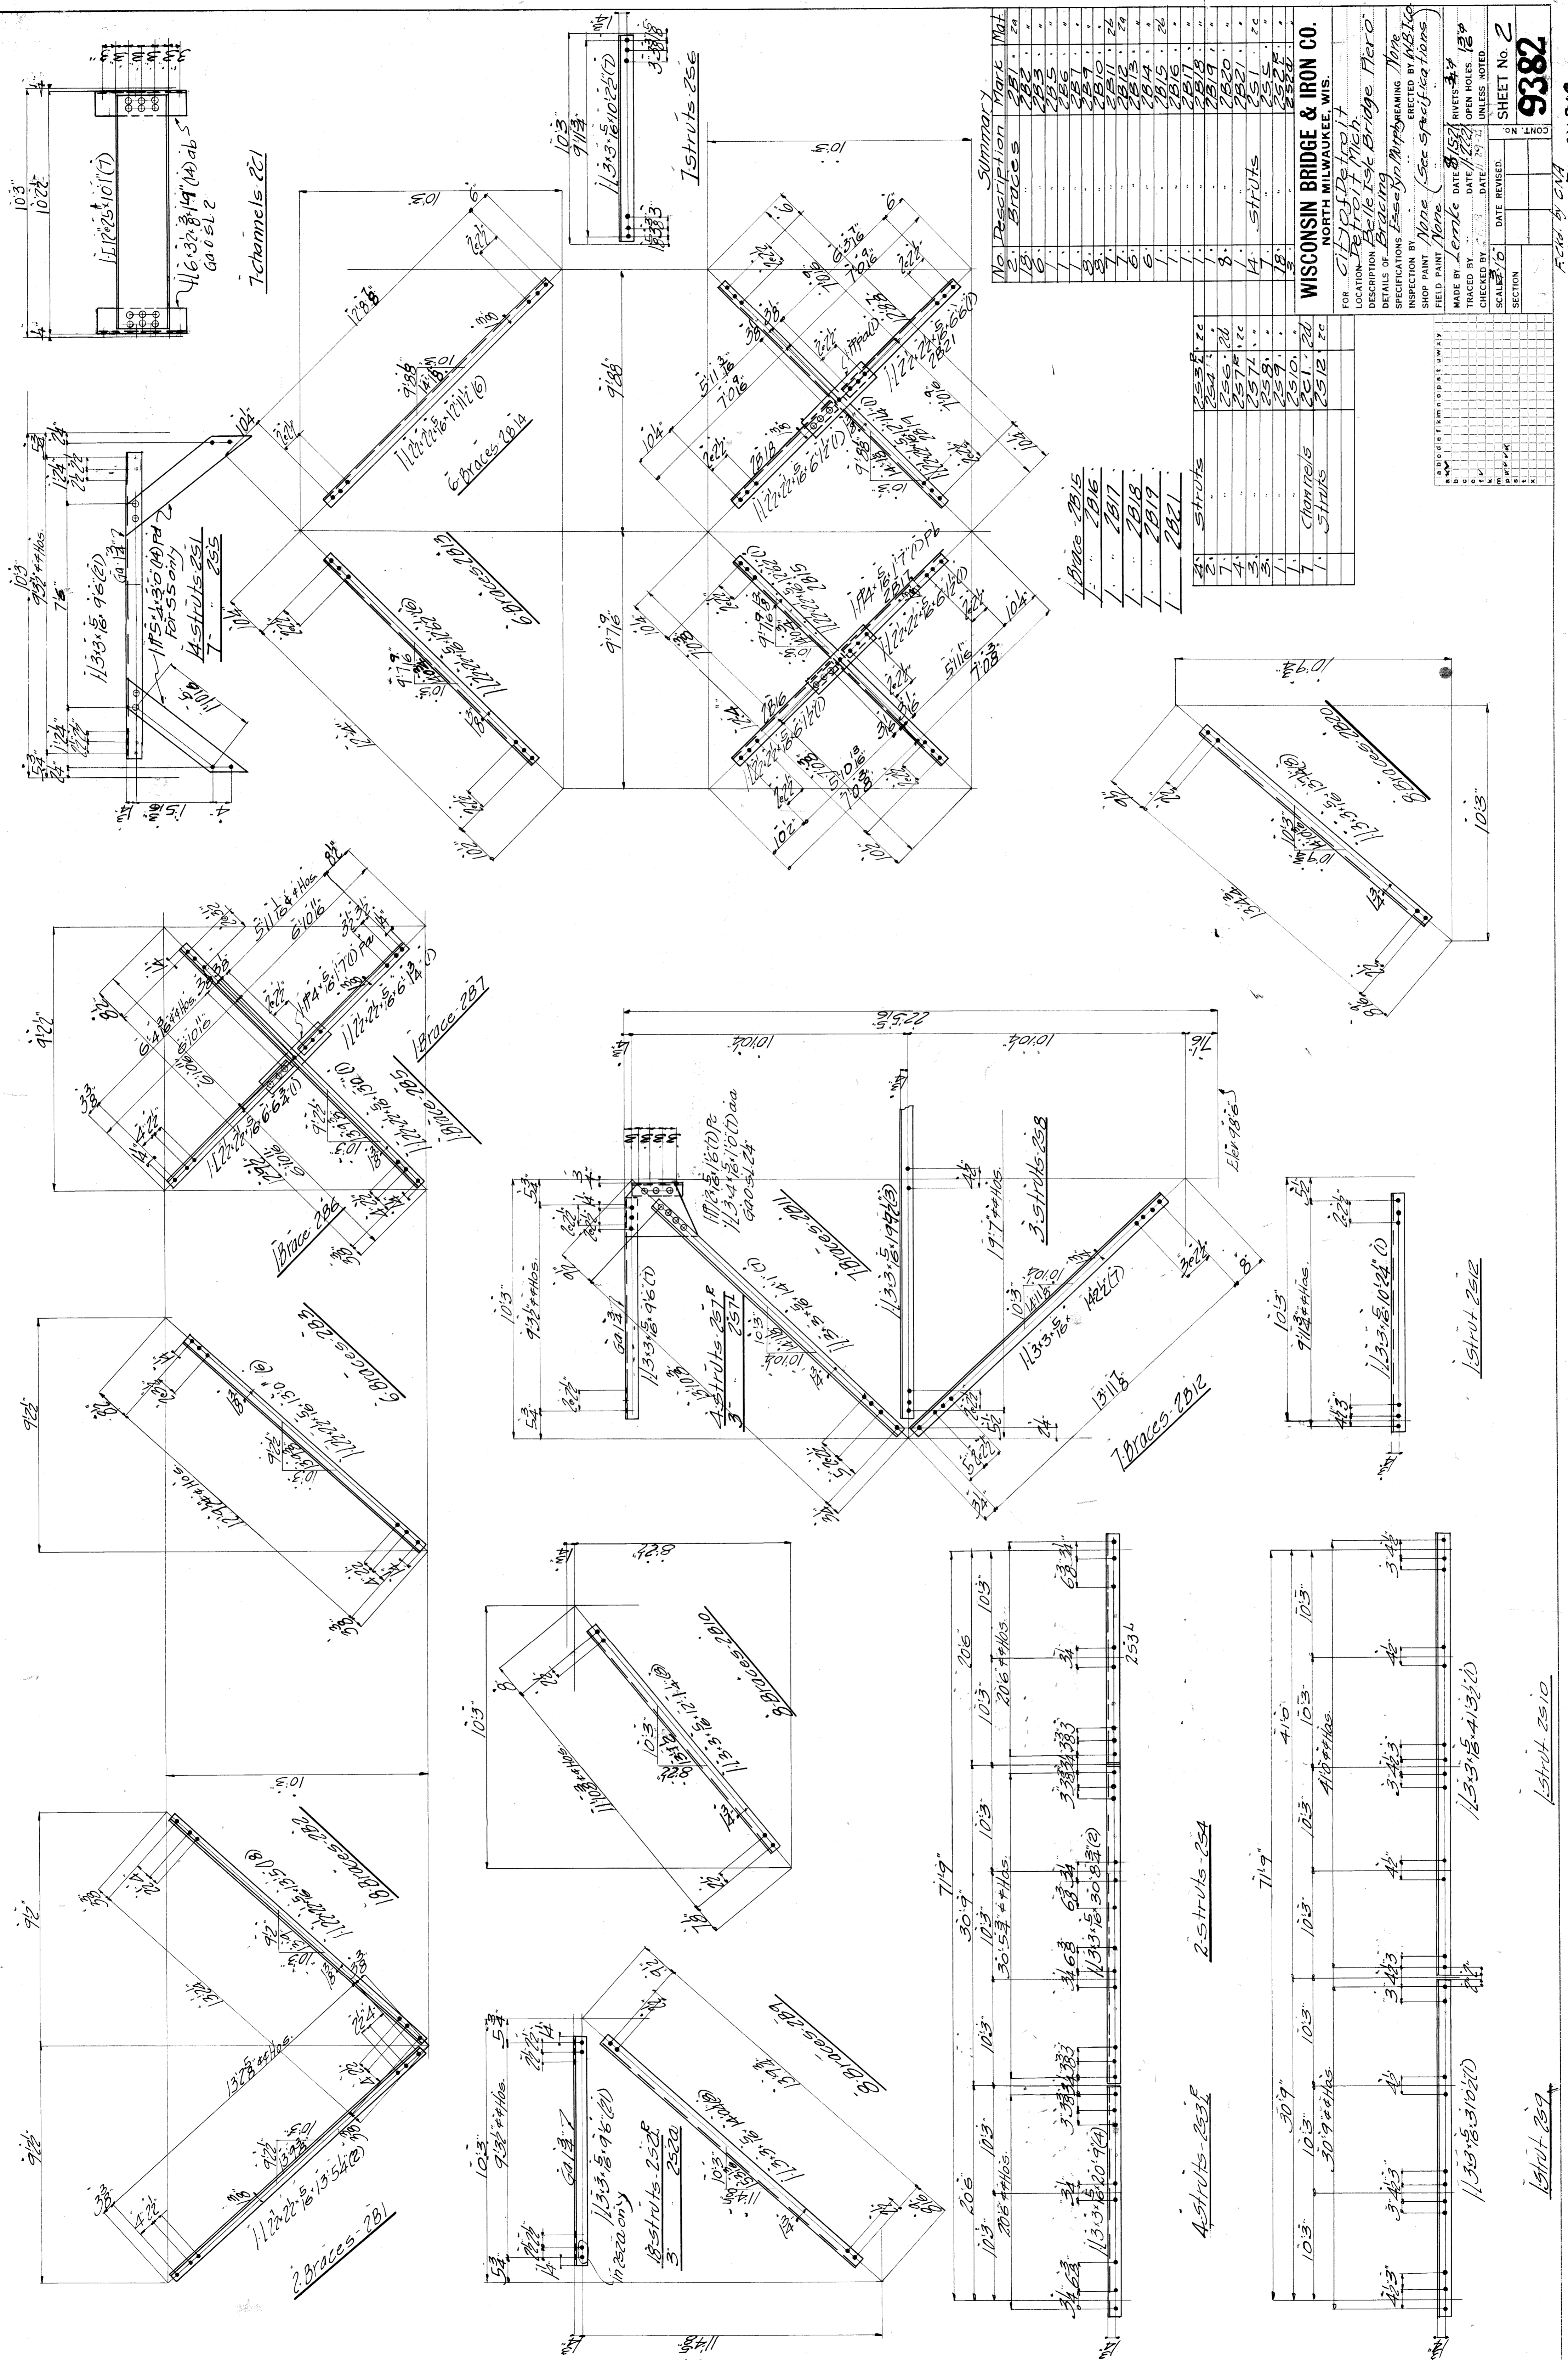

No.	Description	Mark	Mat.
1	Trusses	281	20
2	Trusses	282	20
3	Trusses	283	20
100	Trusses	380	20


WISCONSIN BRIDGE & IRON CO.
NORTH MILWAUKEE, WIS.

FOR CITY OF PORT HURON
LOCATION: Port Huron Mich.
DESCRIPTION: Port Huron Bridge Pier 0.
DETAILS OF BRACING: See Syn. Mfg. Bridge Pier 0.
SPECIFICATIONS: See Syn. Mfg. Bridge Pier 0.
INSPECTION BY: None (See Specifications)
SHOP PAINT: None
FIELD PAINT: None
MADE BY: Lemke DATE: 8/15/27
TRACED BY: Lemke DATE: 11/22/27
CHECKED BY: DATE: UNLESS NOTED
SCALE: 1/8" = 1'-0"
SECTION: SHEET NO. 2

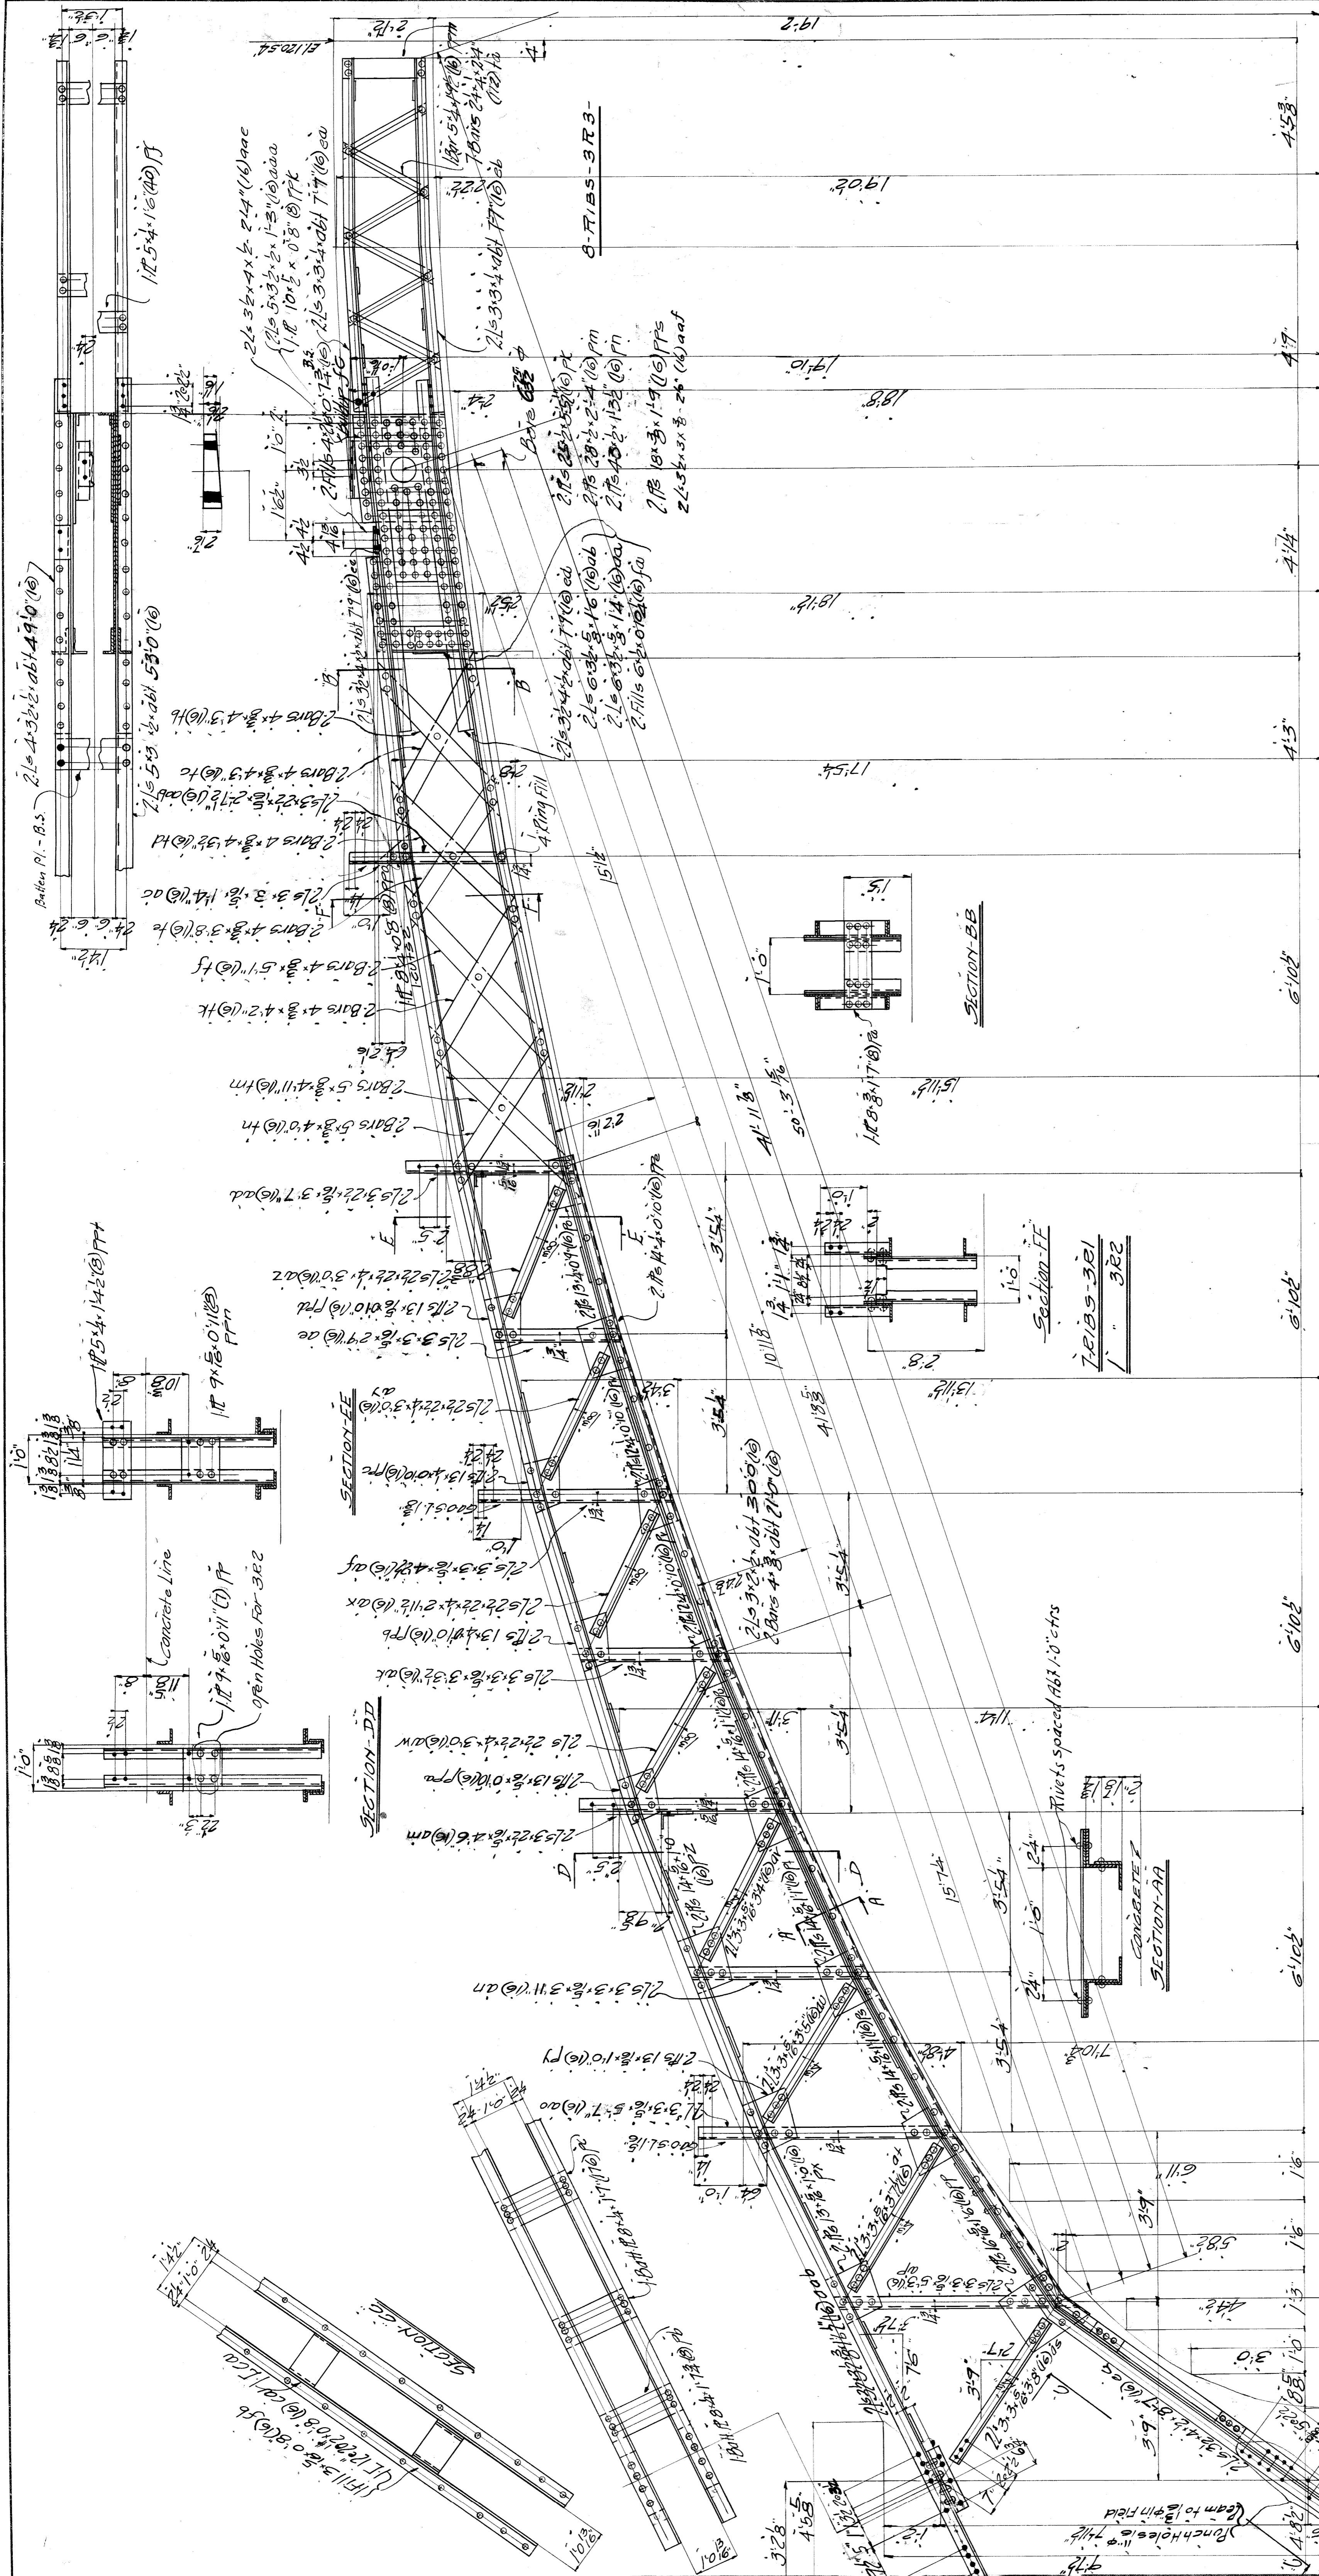

WISCONSIN BRIDGE & IRON CO.
 NORTH MILWAUKEE, WISCONSIN
 CONTRACT NO. 9382
 ERCTED BY W.B.I.C.O.
 FOR CITY OF DETROIT
 LOCATION DETROIT MI^{CH}
 DESCRIPTION BELLE ISLE BRIDGE
 DETAILS OF GIRDS PER 0
 SPECIFICATIONS E.S.S. & MURPHY REAMING AS NOTED
 INSPECTION BY
 SHOP PAINT NONE
 FIELD PAINT
 RIVETS OPEN HOLES 13"
 MADE BY Lemke DATE 8-16-21
 TRACED BY Lemke DATE 8-18-21
 CHECKED BY C.E.B. F.L.H. by C.M.H. DATE 11-22-21
 SCALE 3/4" = 1'-0" DATE REVISION SECTION ON SHEET NO. 3

Springing Line Elev 99'3"
 46'6" to 48'0" to 5' of Pin
 Rivets spaced 48" c'trs
 Concrete
 SECTION-AA
 SECTION-BB
 SECTION-CC
 SECTION-DD
 SECTION-EE
 SECTION-FF
 SECTION-GG
 SECTION-HH
 SECTION-II
 SECTION-JJ
 SECTION-KK
 SECTION-LL
 SECTION-MM
 SECTION-NN
 SECTION-OO
 SECTION-PP
 SECTION-QQ
 SECTION-RR
 SECTION-SS
 SECTION-TT
 SECTION-UU
 SECTION-VV
 SECTION-WW
 SECTION-XX
 SECTION-YY
 SECTION-ZZ

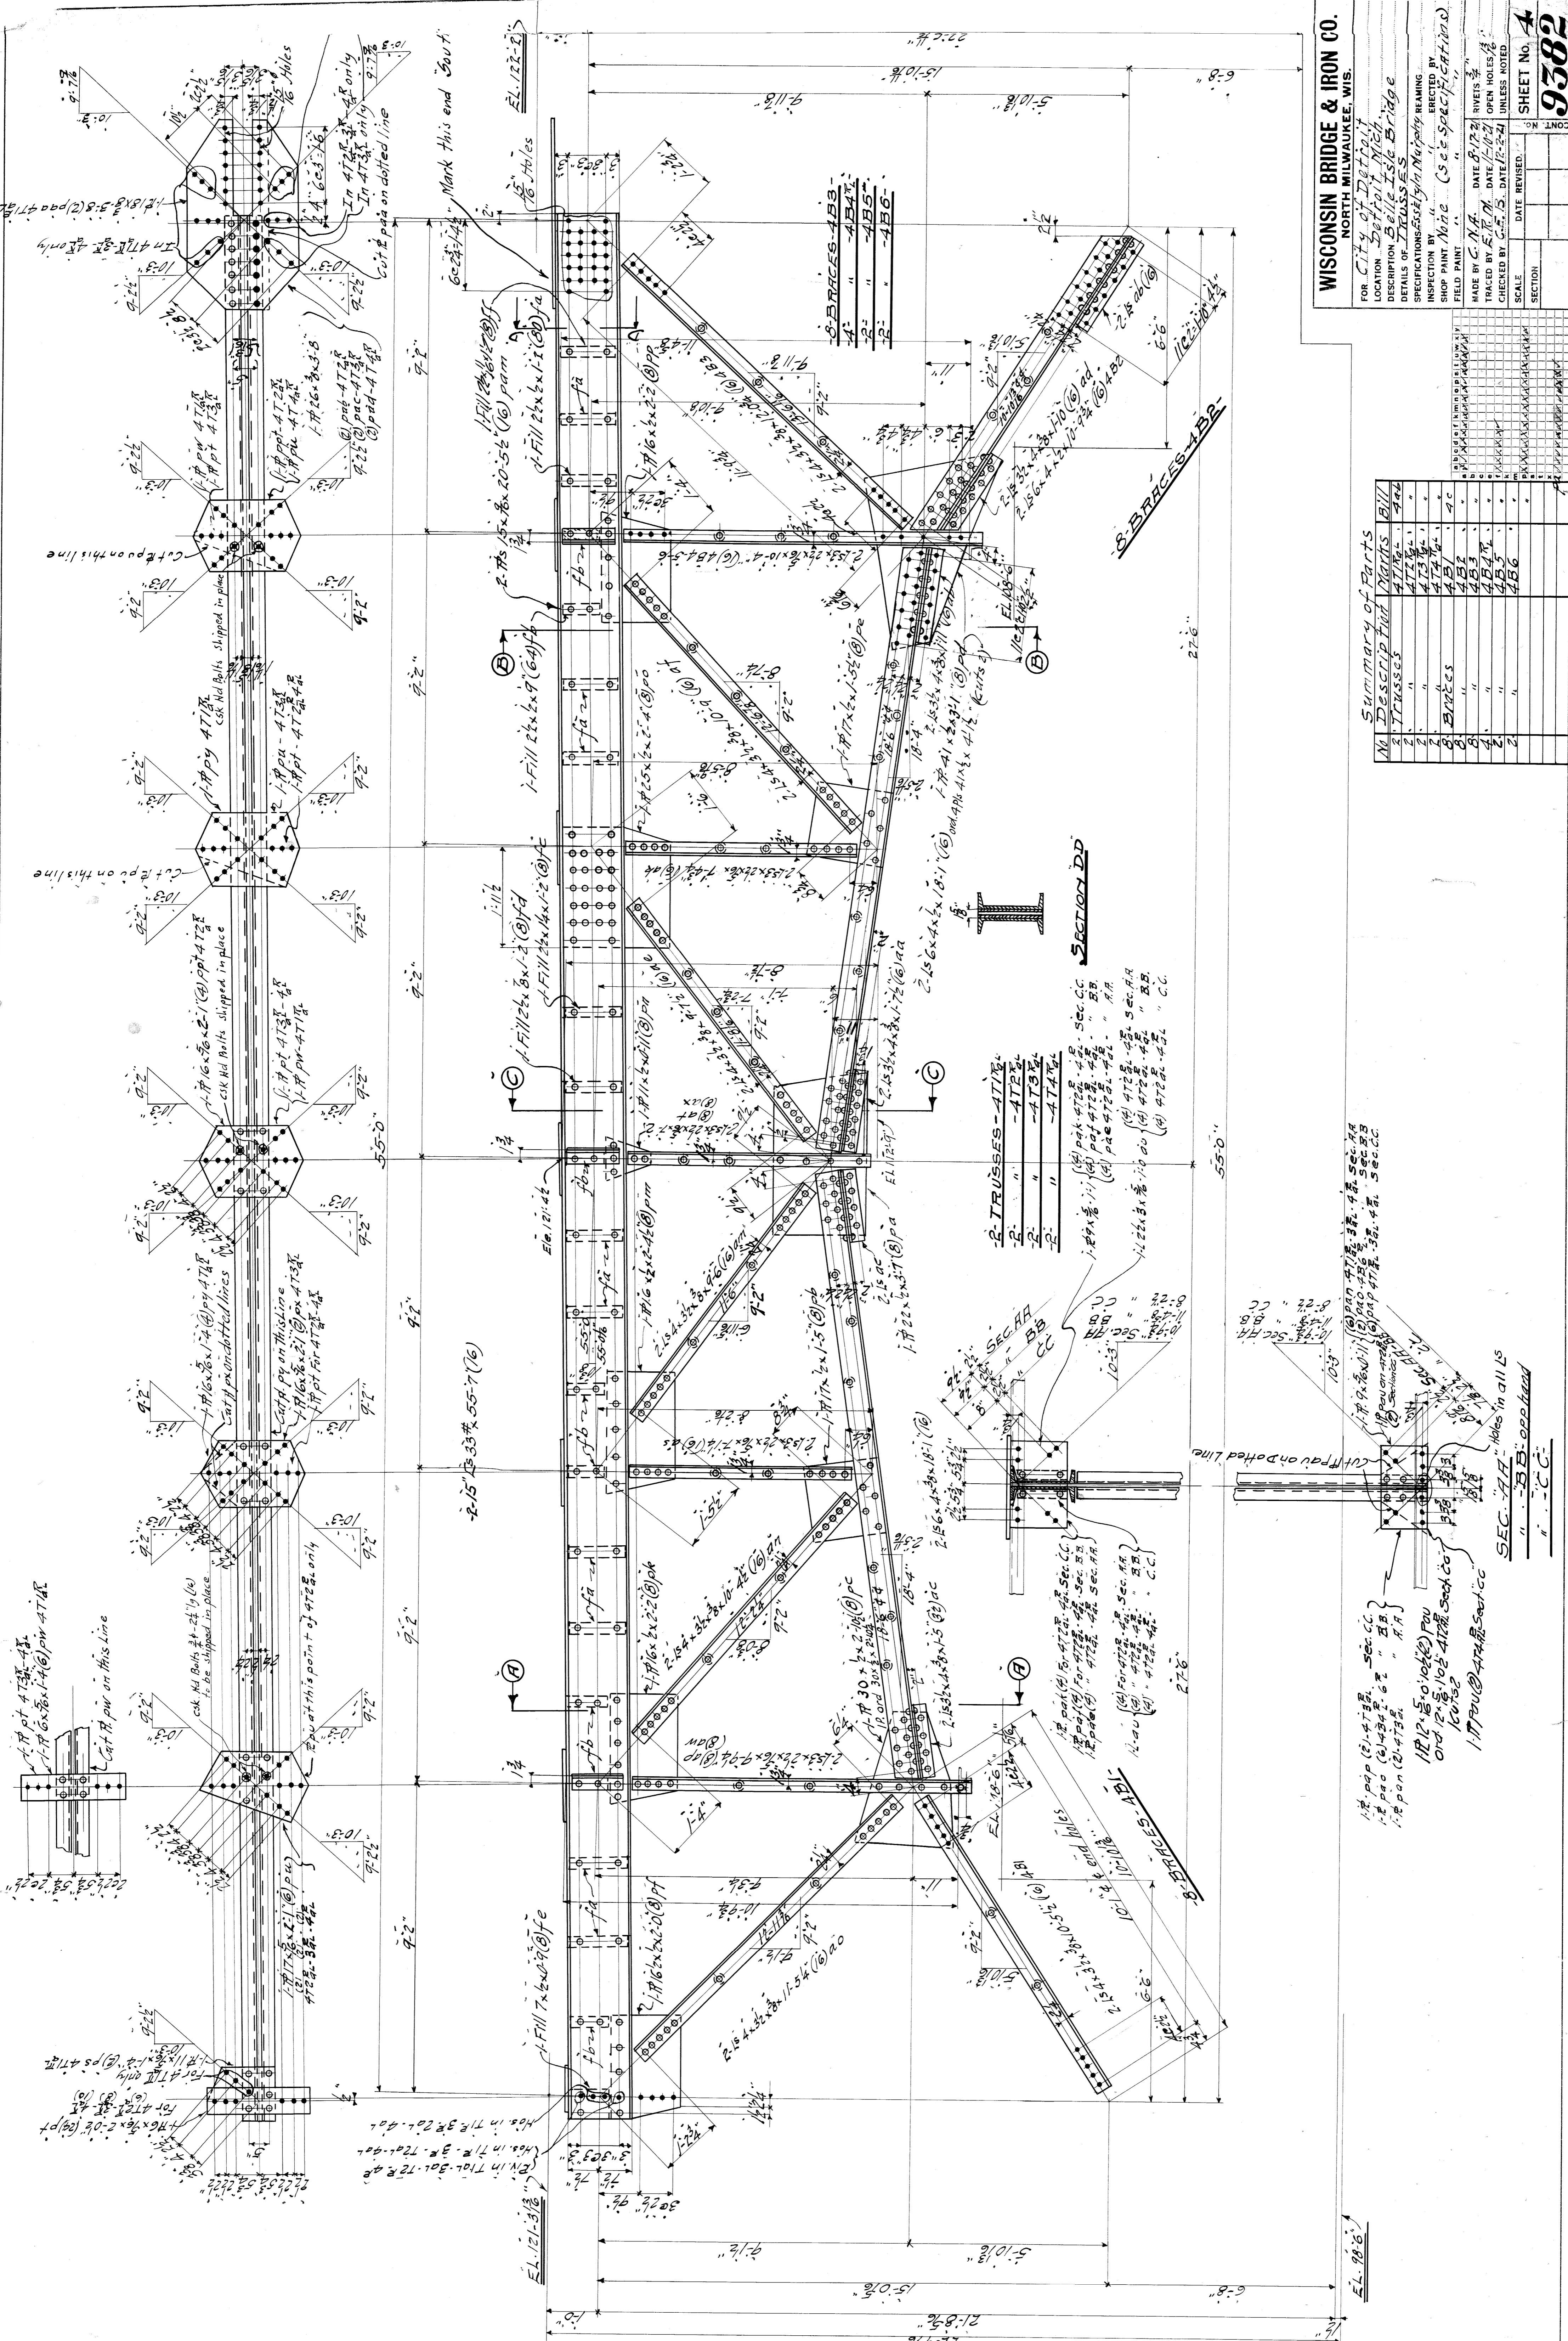

WISCONSIN BRIDGE & IRON CO.
 NORTH MILWAUKEE, WIS.

FOR City of Detroit
 LOCATION Detroit Mich
 DESCRIPTION Belle Isle Bridge
 DETAILS OF TRUSSES

INSPECTED BY [Signature]
 SPECIFICATIONS [Signature]
 SHOP PAINT [Signature]

MADE BY [Signature] DATE [Signature]
 TRACED BY [Signature] DATE [Signature]
 CHECKED BY [Signature] DATE [Signature]


SCALE [Signature]
 SECTION [Signature]

RIVETS 3/4"
 OPEN HOLES 1"
 UNLESS NOTED

SHEET NO. **A**
9382

Summary of Parts

No.	Description	Quantity	Part
1	TRUSSES	4	41714
2	"	1	41715
3	"	1	41716
4	"	1	41717
5	BRACES	4	41718
6	"	4	41719
7	"	4	41720
8	"	4	41721
9	"	4	41722
10	"	4	41723

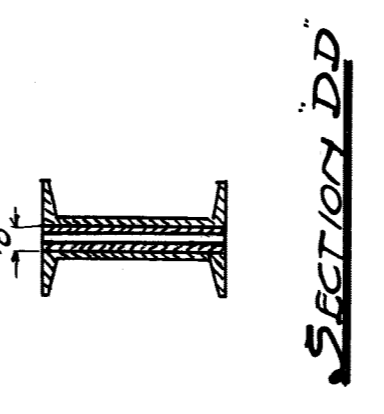


TRUSSES-41714
 1-17 1/2 x 20 x 1/2 (6) pa
 2-17 1/2 x 20 x 1/2 (6) pa
 3-17 1/2 x 20 x 1/2 (6) pa


TRUSSES-41715
 1-17 1/2 x 20 x 1/2 (6) pa
 2-17 1/2 x 20 x 1/2 (6) pa
 3-17 1/2 x 20 x 1/2 (6) pa

TRUSSES-41716
 1-17 1/2 x 20 x 1/2 (6) pa
 2-17 1/2 x 20 x 1/2 (6) pa
 3-17 1/2 x 20 x 1/2 (6) pa

TRUSSES-41717
 1-17 1/2 x 20 x 1/2 (6) pa
 2-17 1/2 x 20 x 1/2 (6) pa
 3-17 1/2 x 20 x 1/2 (6) pa

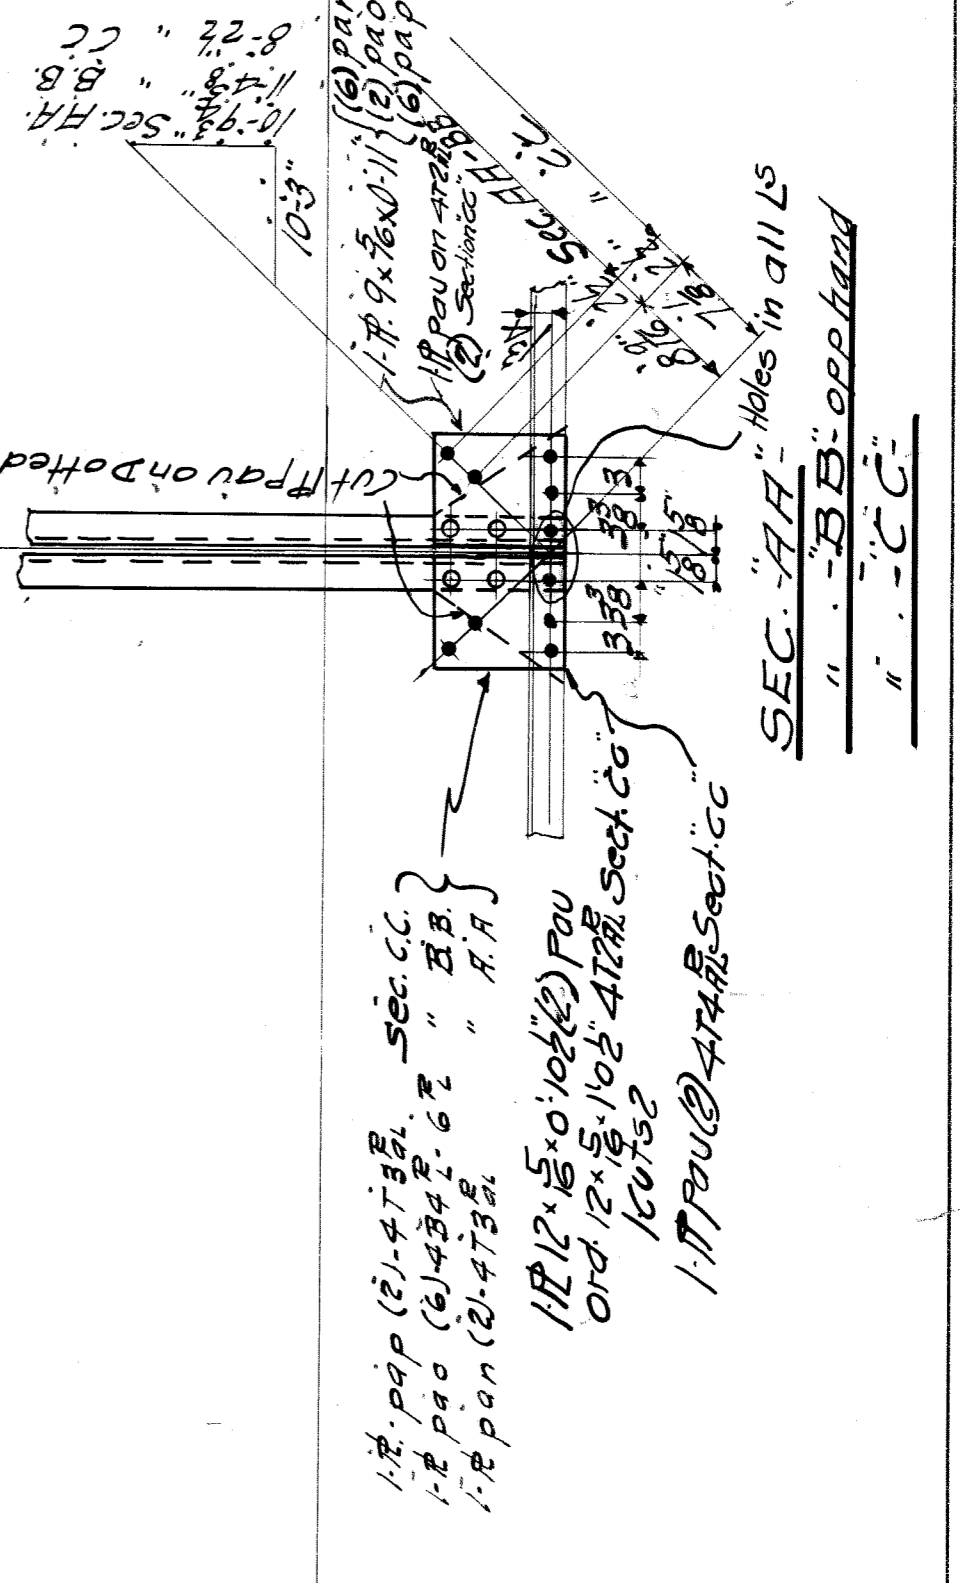


File **BWP422** Filed by CMA

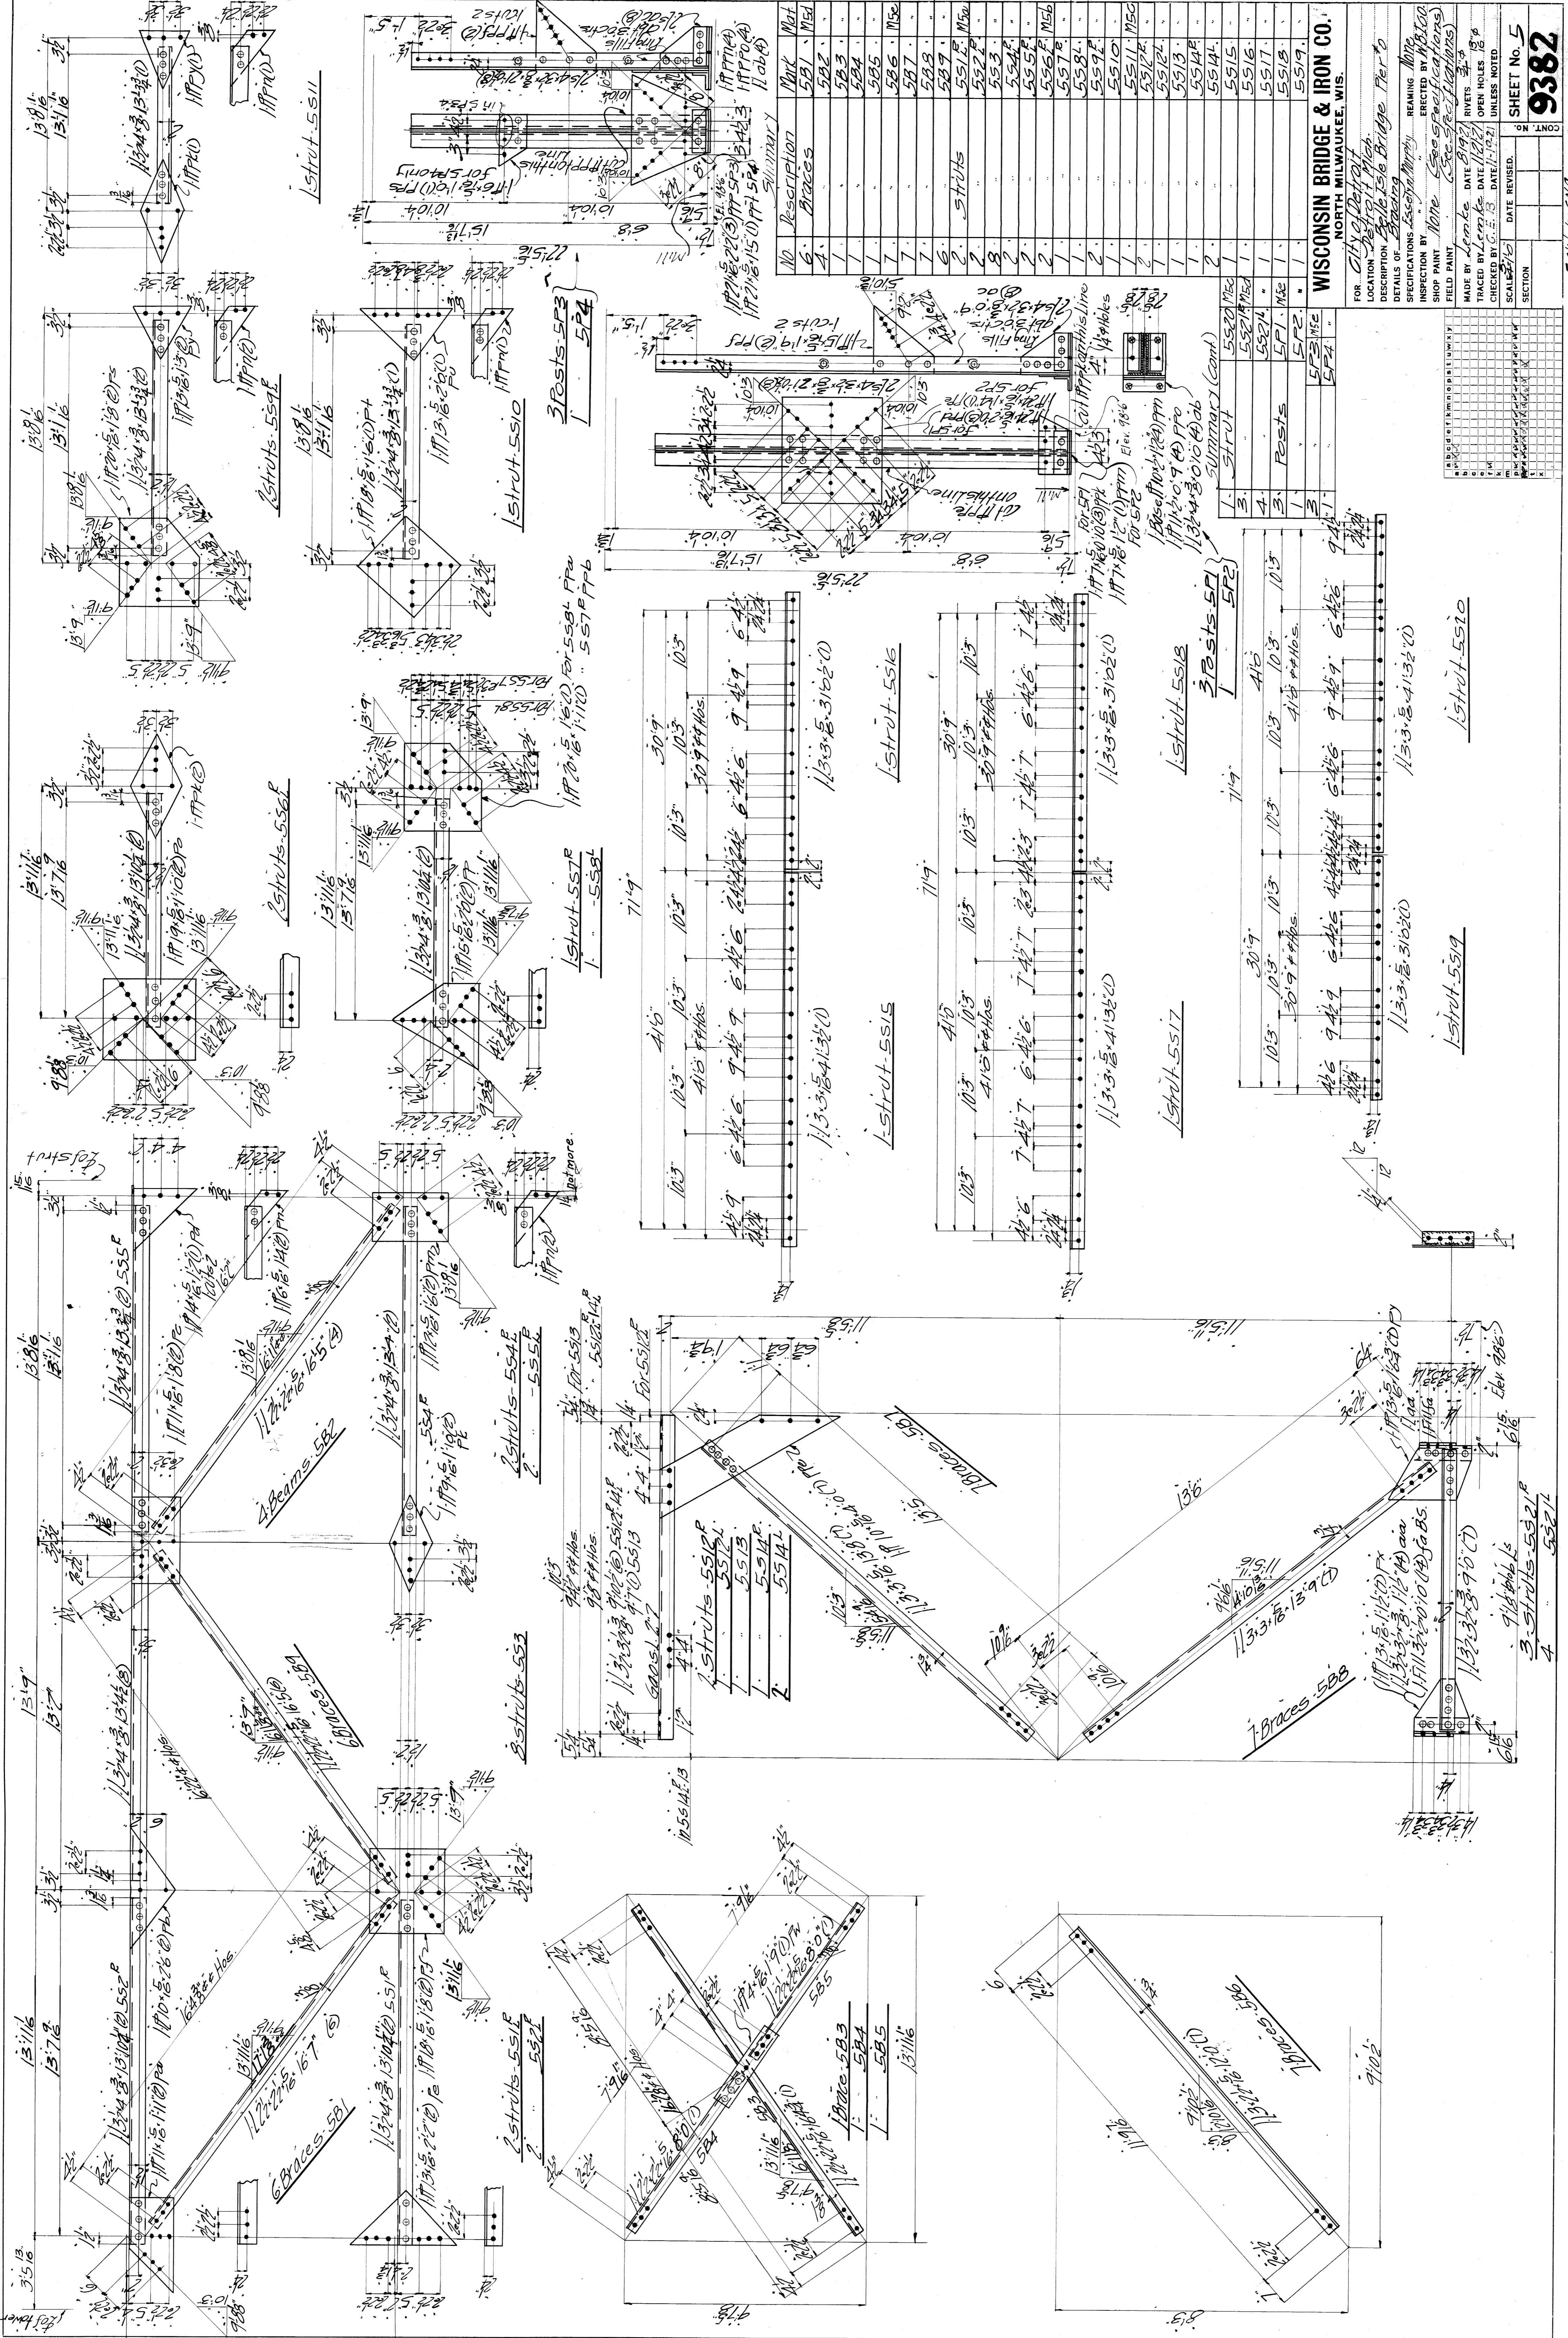

NO	Description	Mat	Qty
1	Braces	581	1
2	Braces	582	1
3	Braces	583	1
4	Braces	584	1
5	Braces	585	1
6	Braces	586	1
7	Braces	587	1
8	Braces	588	1
9	Braces	589	1
10	Braces	590	1
11	Braces	591	1
12	Braces	592	1
13	Braces	593	1
14	Braces	594	1
15	Braces	595	1
16	Braces	596	1
17	Braces	597	1
18	Braces	598	1
19	Braces	599	1
20	Braces	600	1


WISCONSIN BRIDGE & IRON CO.
 NORTH MILWAUKEE, WIS.
 FOR: City of Detroit
 LOCATION: Detroit Mich.
 DESCRIPTION: Belle Isle Bridge Pier
 SPECIFICATIONS: See General Notes
 INSPECTION BY: None (See Specifications)
 SHOP PAINT: None (See Specifications)
 MADE BY: Lemke DATE: 8/19/21 RIVETS: 3/8"
 TRACED BY: Lemke DATE: 8/19/21 OPEN HOLES: UNLESS NOTED
 CHECKED BY: G.E.S. DATE: 8/19/21
 SCALE: 1/4" = 1'-0" DATE REVISED: SECTION
 SHEET No. 5
9382

File BWest-251 d. by 0174

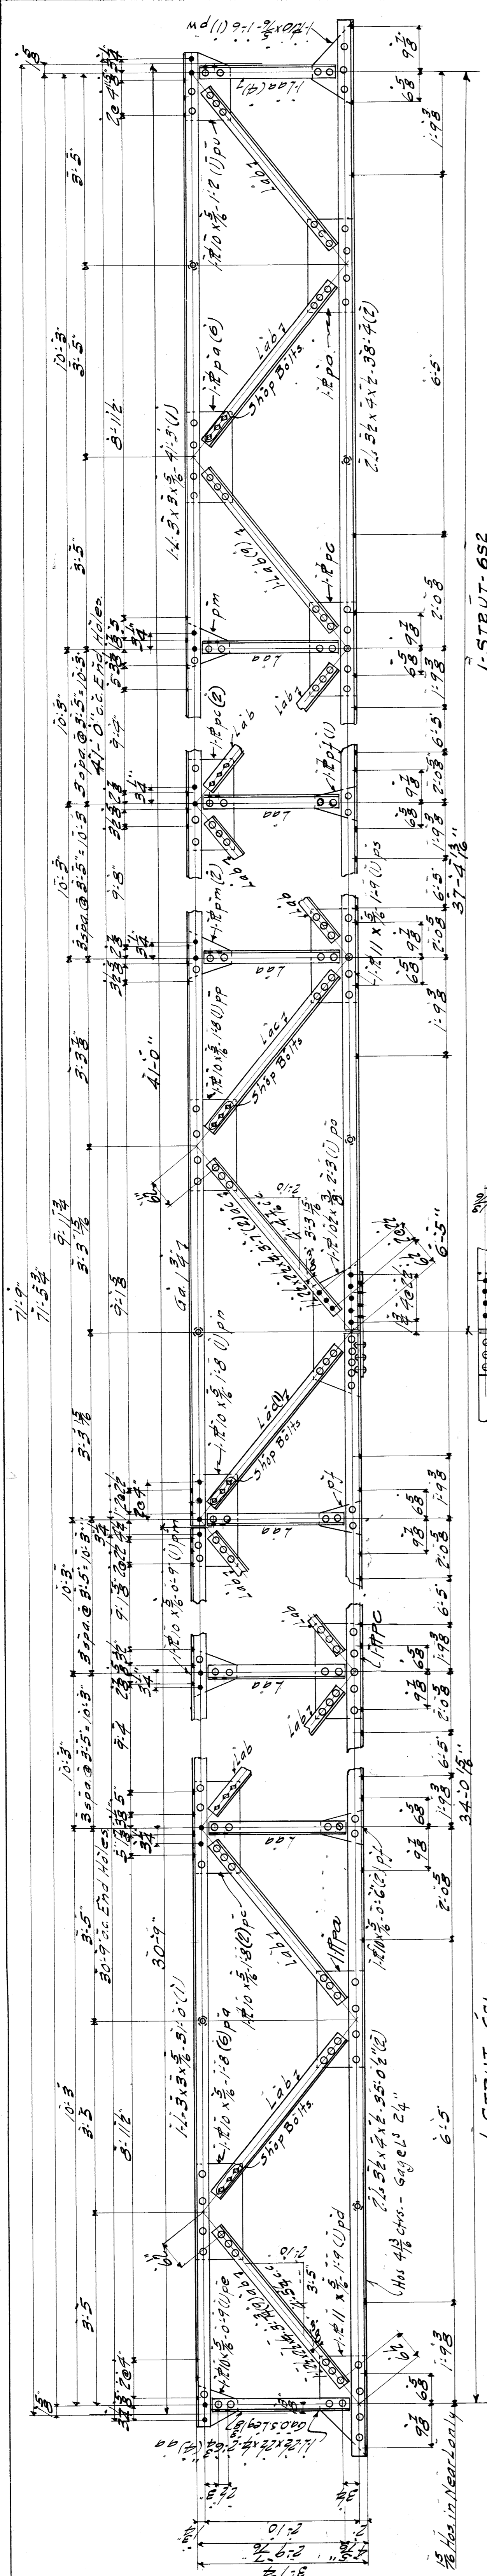

I-STEUT-651


I-STEUT-652

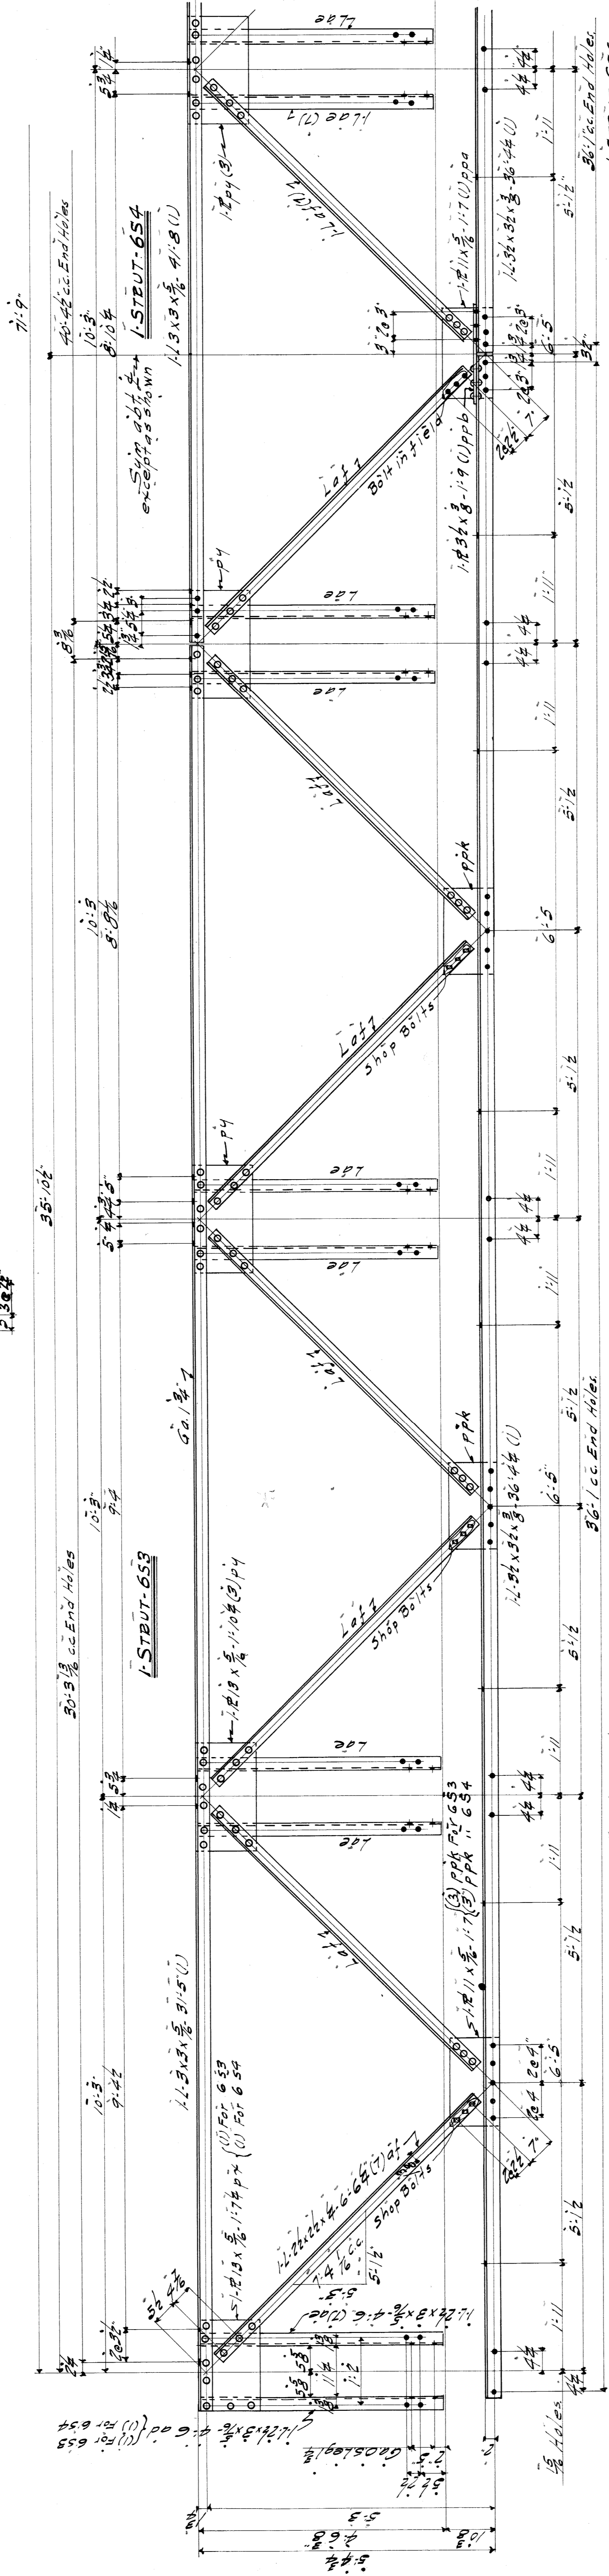

I-STEUT-653

I-STEUT-654


I-STEUT-655

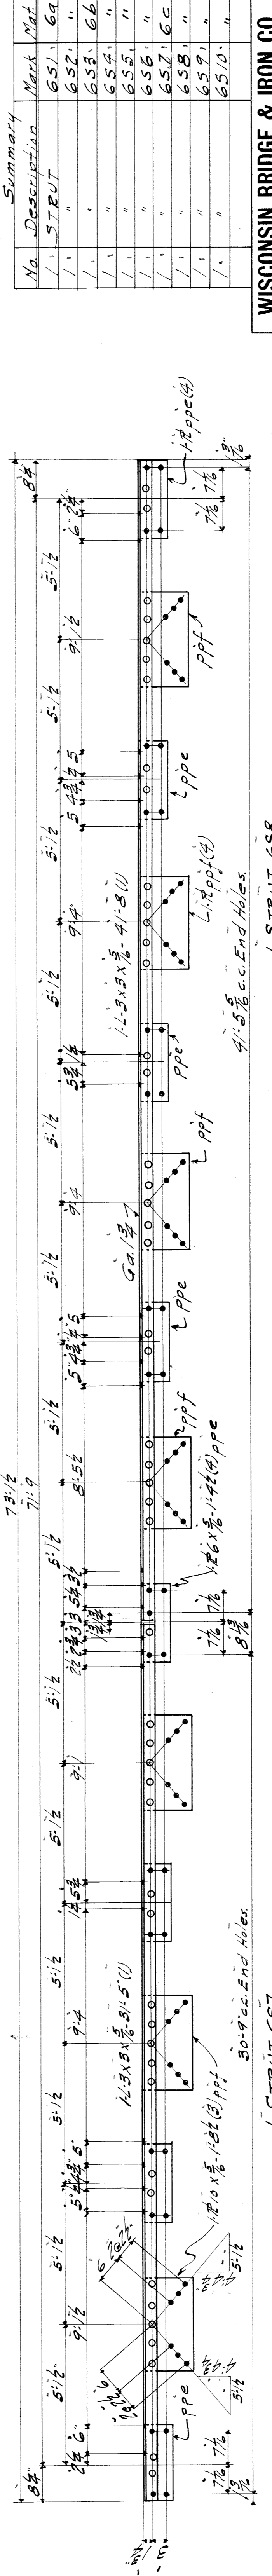

I-STEUT-655

I-STEUT-657

I-STEUT-658



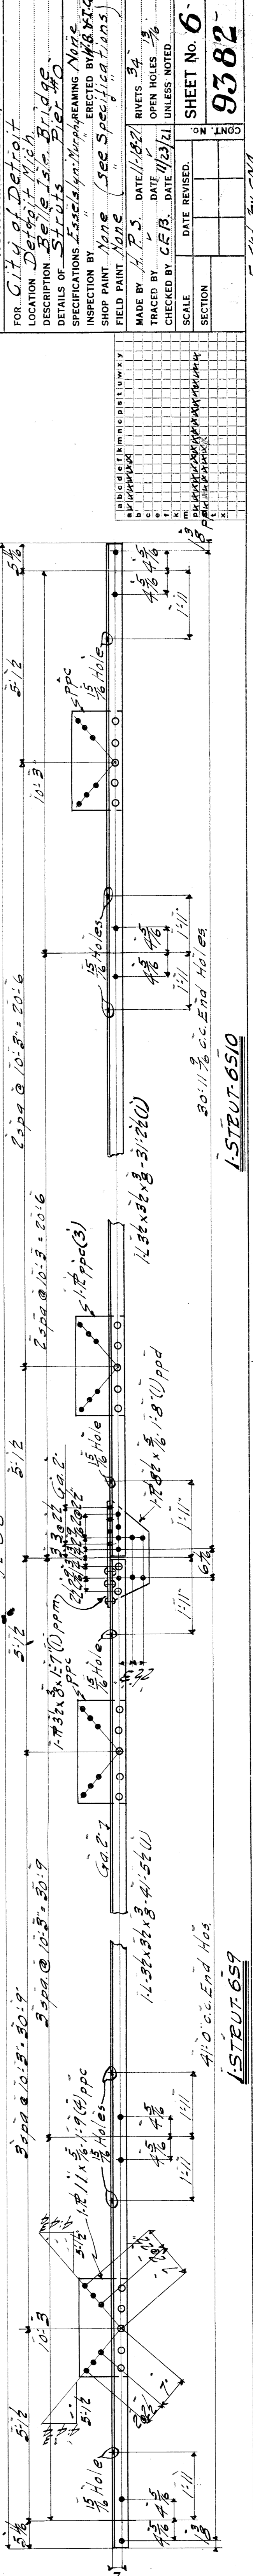


I-STEUT-650

No.	Description	Mark	Mat.
1	STEUT	651	6a
1	"	652	"
1	"	653	6b
1	"	654	"
1	"	655	"
1	"	656	"
1	"	657	6c
1	"	658	"
1	"	659	"
1	"	6510	"

WISCONSIN BRIDGE & IRON CO.
NORTH MILWAUKEE, WIS.

FOR: City of Detroit
LOCATION: Detroit, Mich.
DESCRIPTION: Bridge over River
DETAILS OF: Truss in Pier
INSPECTION BY: J. P. S. DATE: 11-18-21
FIELD PAINT: None (see Specifications)
MADE BY: H. P. S. DATE: 11-18-21
TRACED BY: H. P. S. DATE: 11-18-21
CHECKED BY: C. E. B. DATE: 11-18-21
SCALE: UNLESS NOTED
RIVETS: 3/4"
OPEN HOLES: 1/8"
SHEET NO. 6

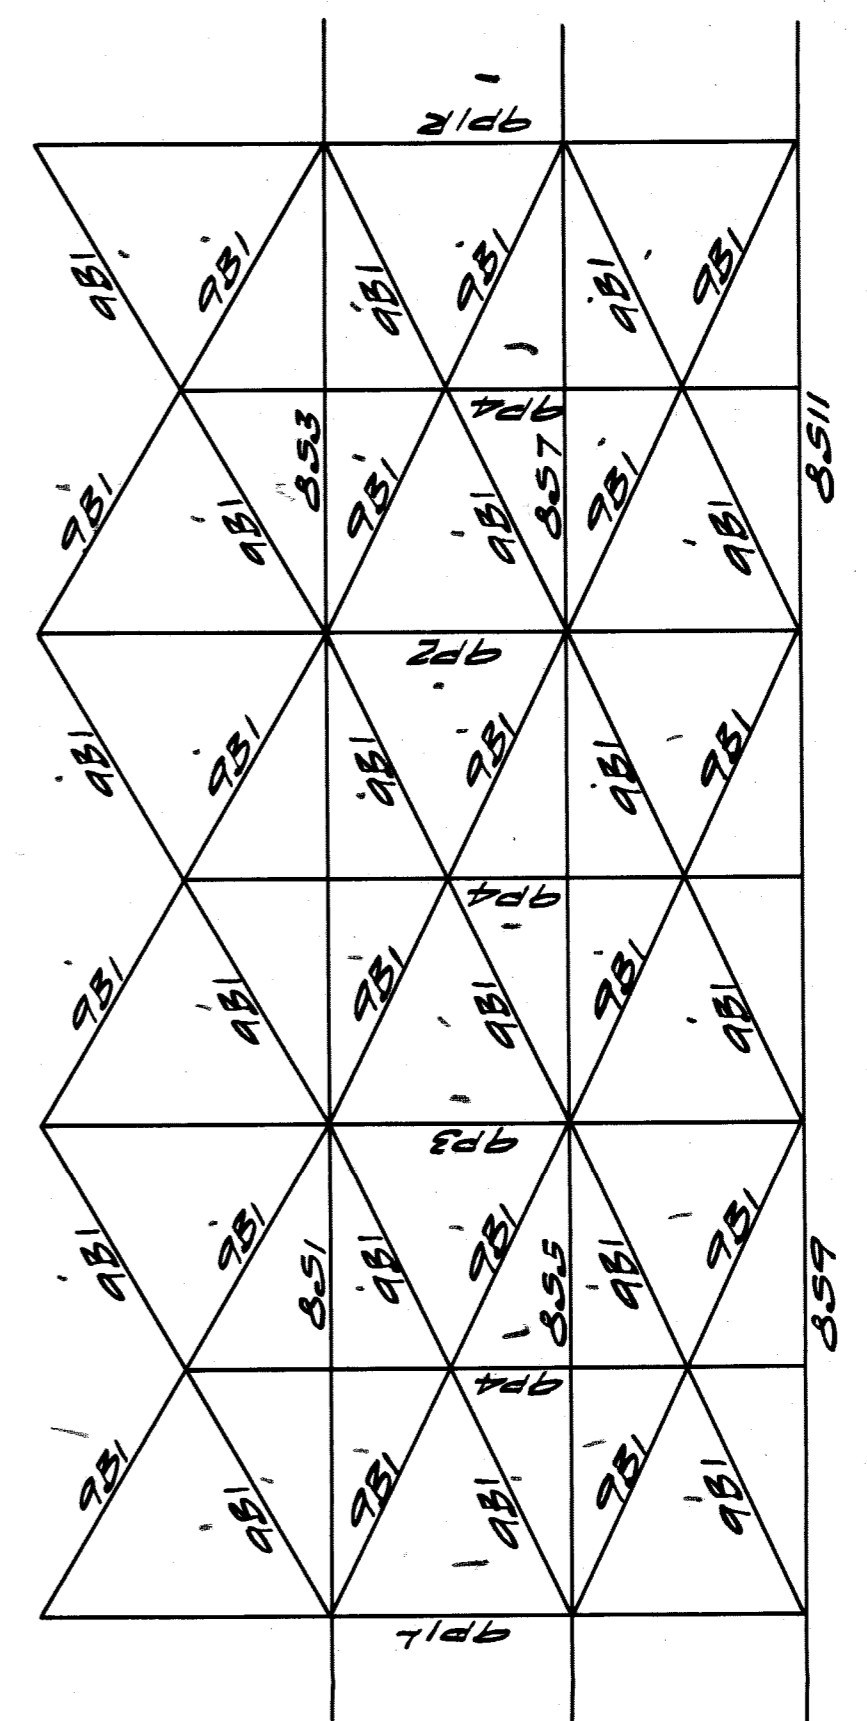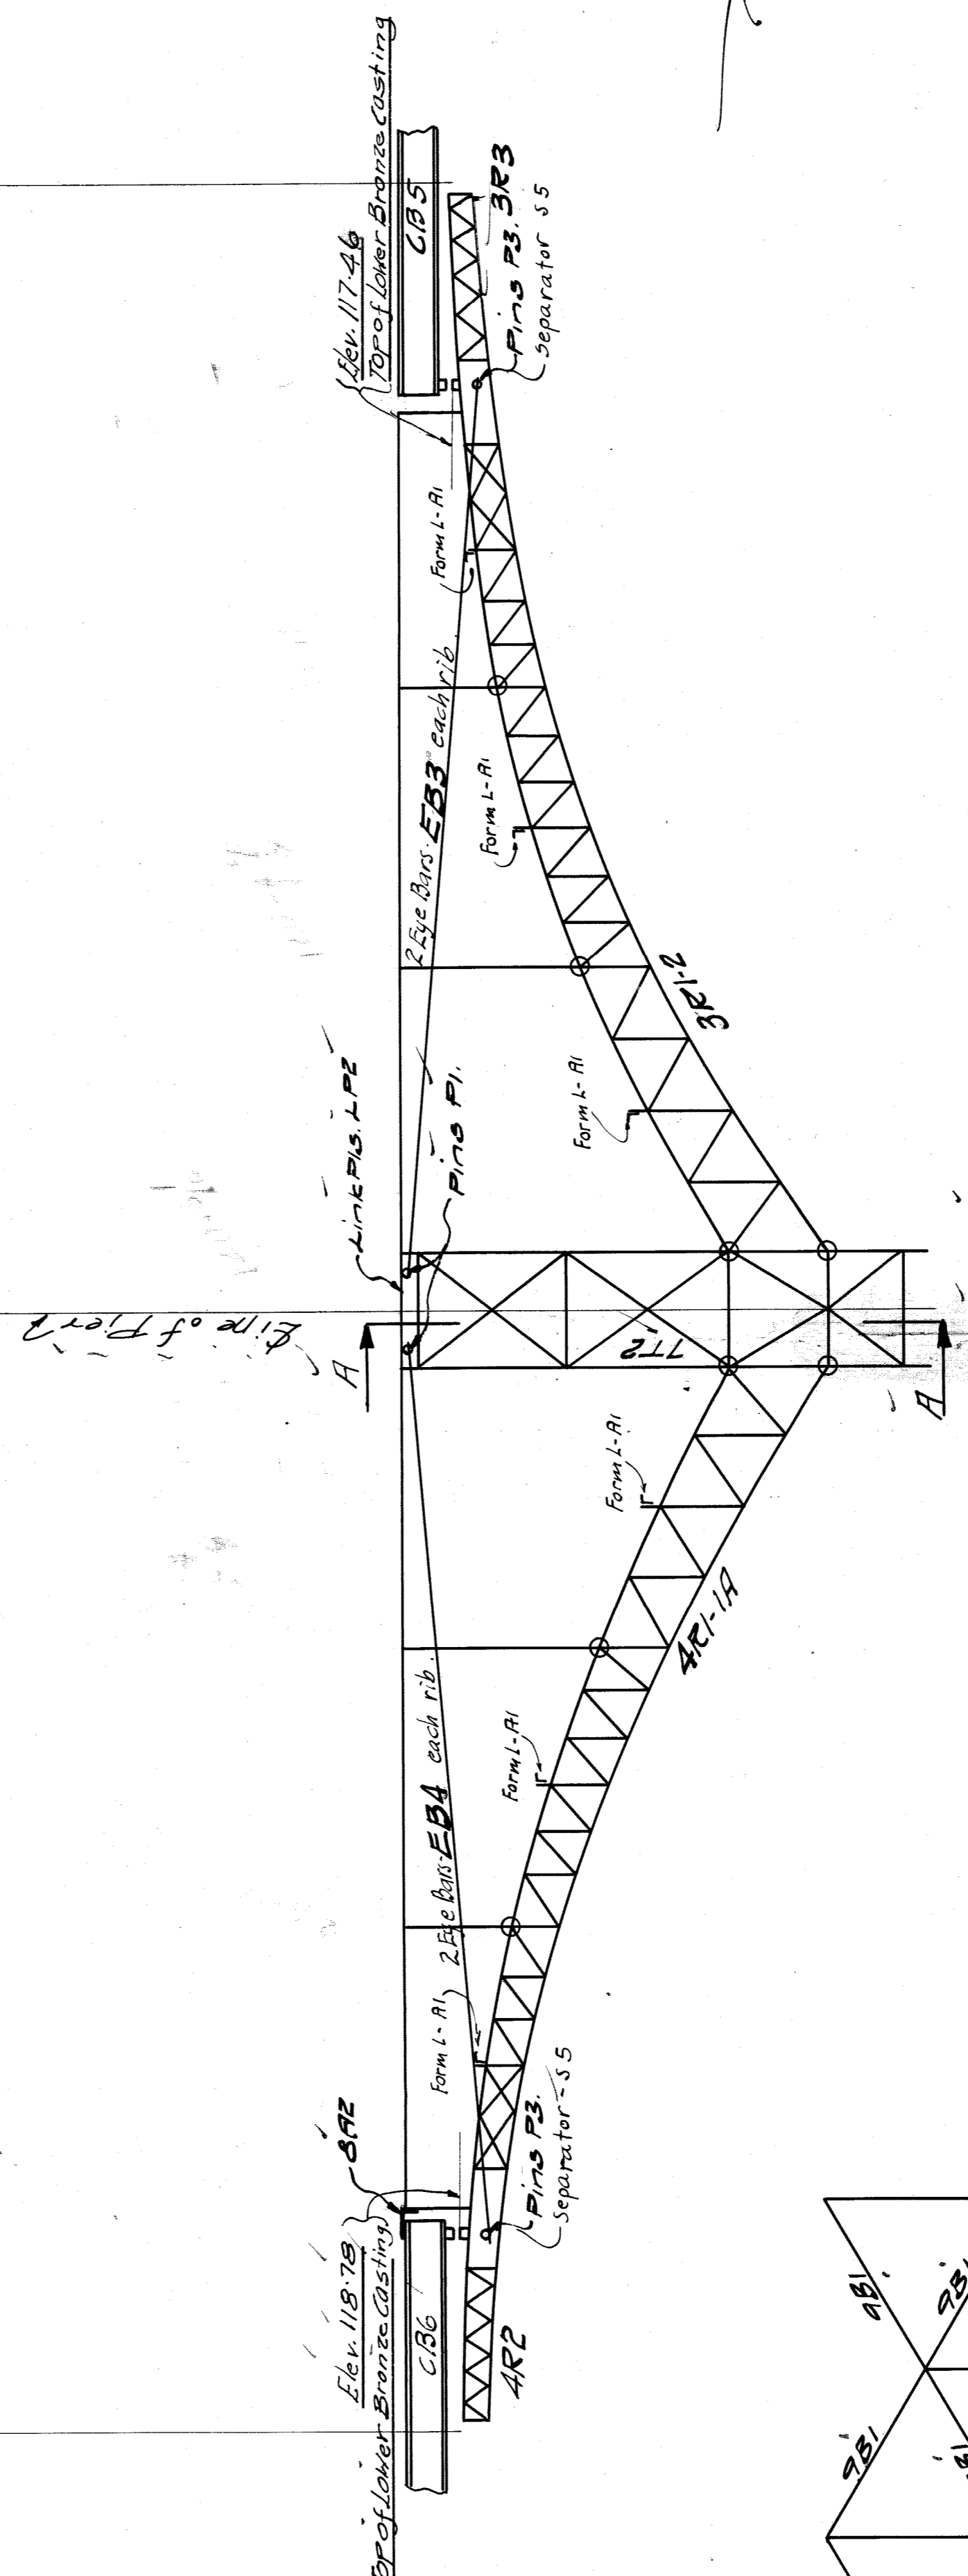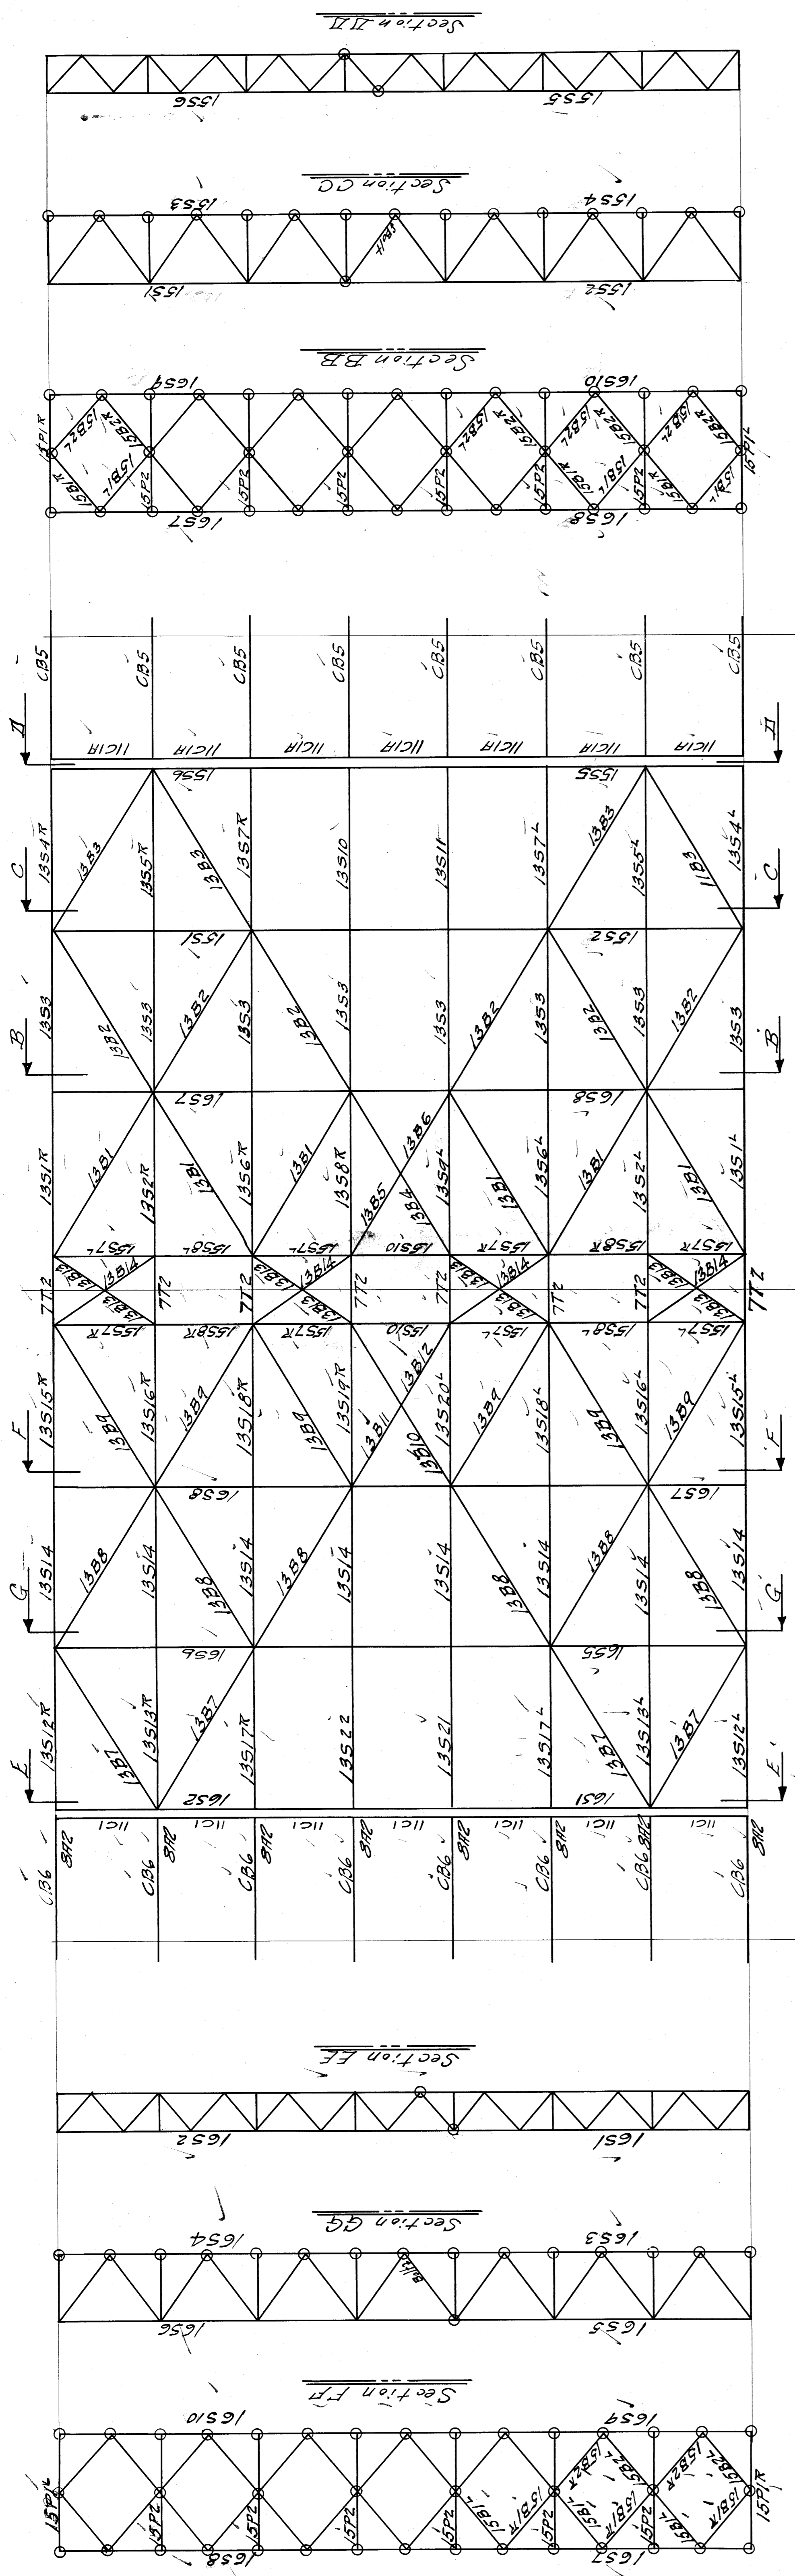

NOTE:
 All points encircled thus O to be riveted.
 All other points bolted.

WISCONSIN BRIDGE & IRON CO.
 NORTH MILWAUKEE, WISCONSIN

CONTRACT NO. 2383
 ERCTED BY
 City of Detroit, Mich.
 LOCATION
 Belle Isle Bridge
 DESCRIPTION
 Details of Erection Plan Pier # 14

SPECIFICATIONS
 INSPECTION BY
 SHOP PAINT
 FIELD PAINT

RIVETS
 OPEN HOLES
 EXCEPT AS NOTED

MADE BY
 W. H. Peters
 DATE
 1-25-21

TRACED BY
 DATE
 1-25-21

CHECKED BY
 DATE
 1-25-21

SCALE 3/4" = 1'-0"

SECTION
 21
 22
 23

DATE REVISED



SHEET NO. 14

9383


Form L-R1- Detailed on Bill #305-Contr #377

PIER # 14

Bracing on Line of Pier
 Section AA

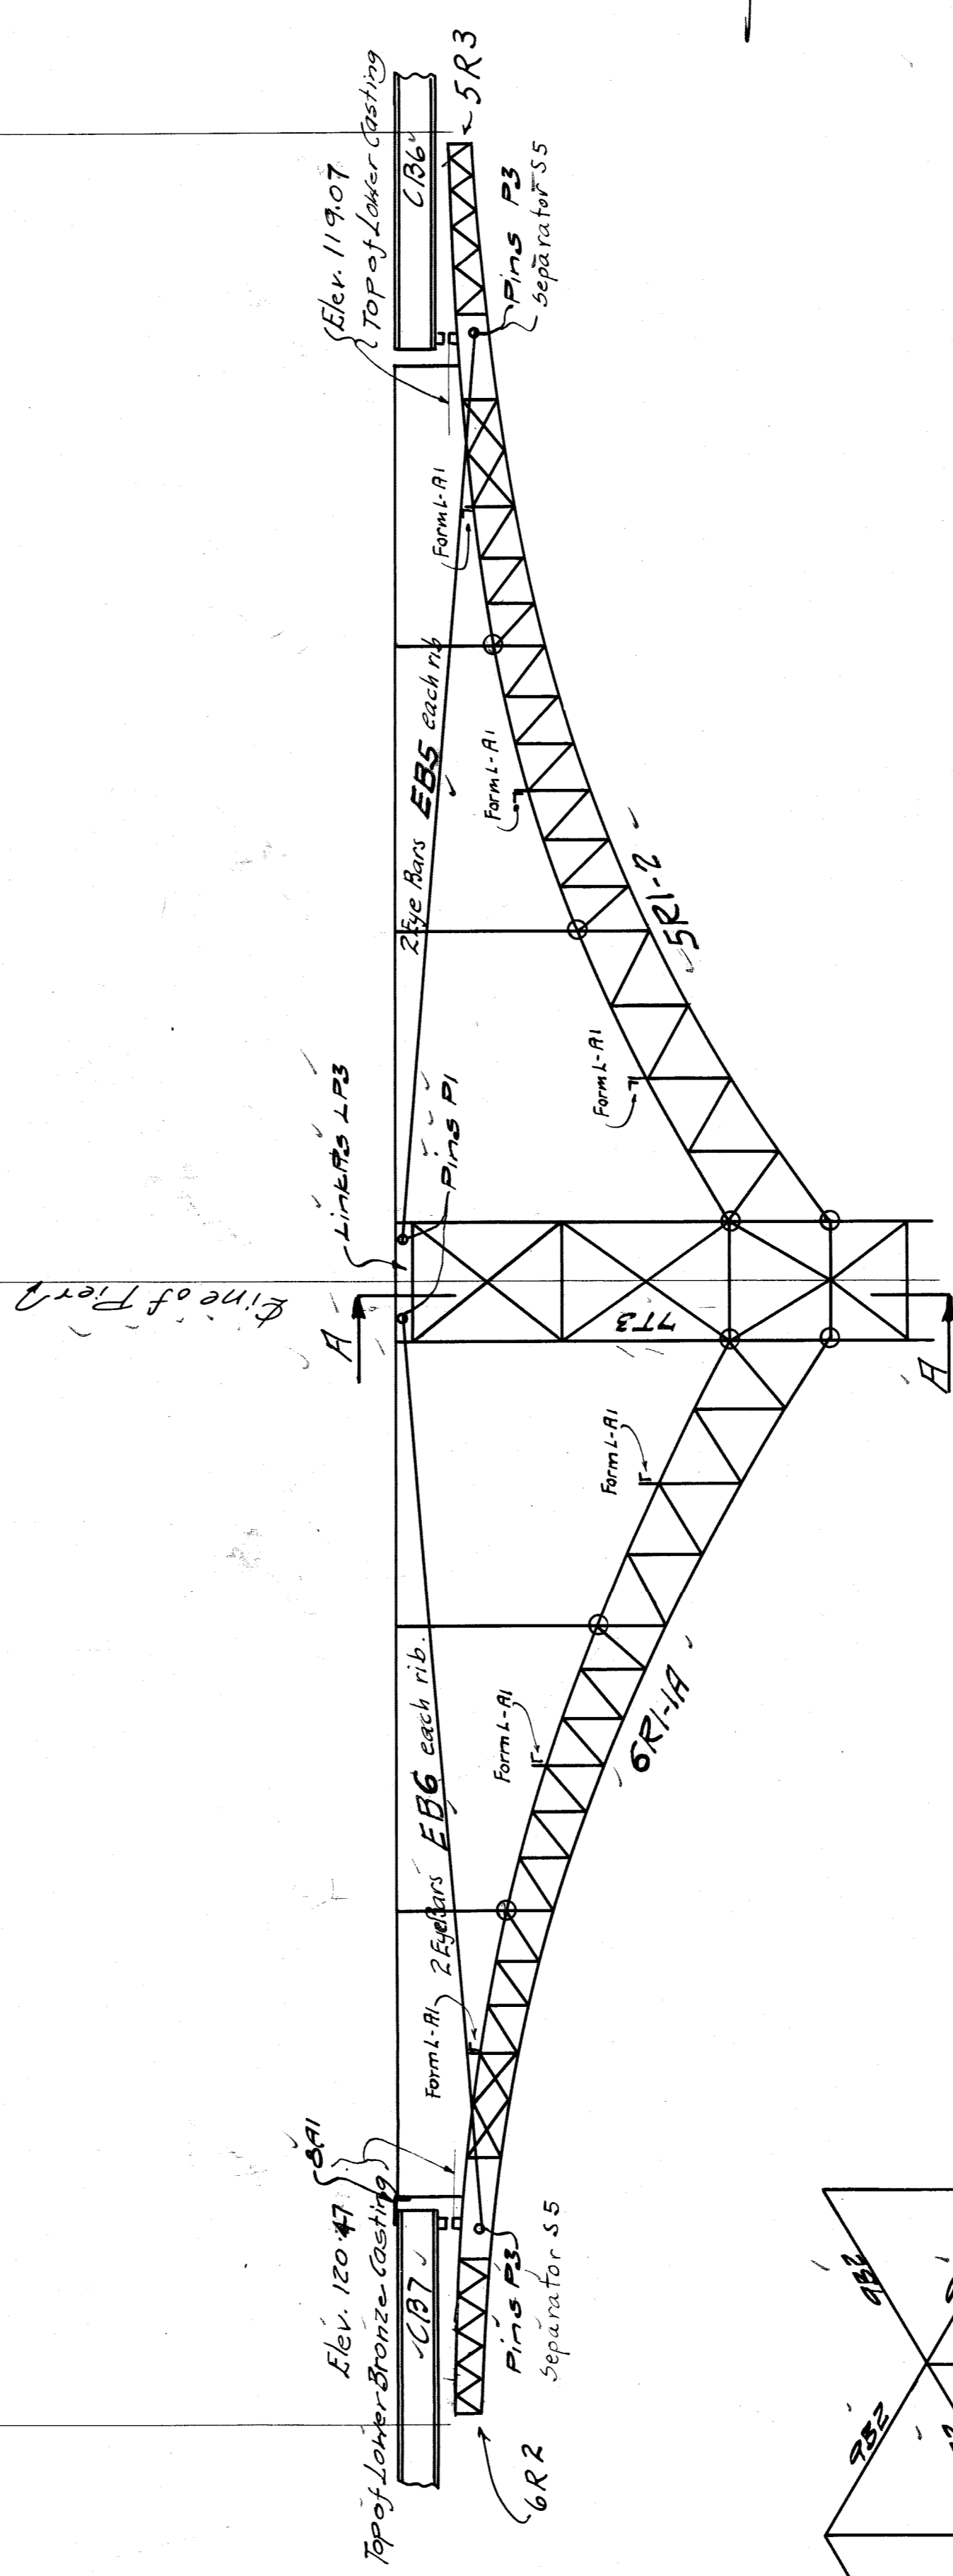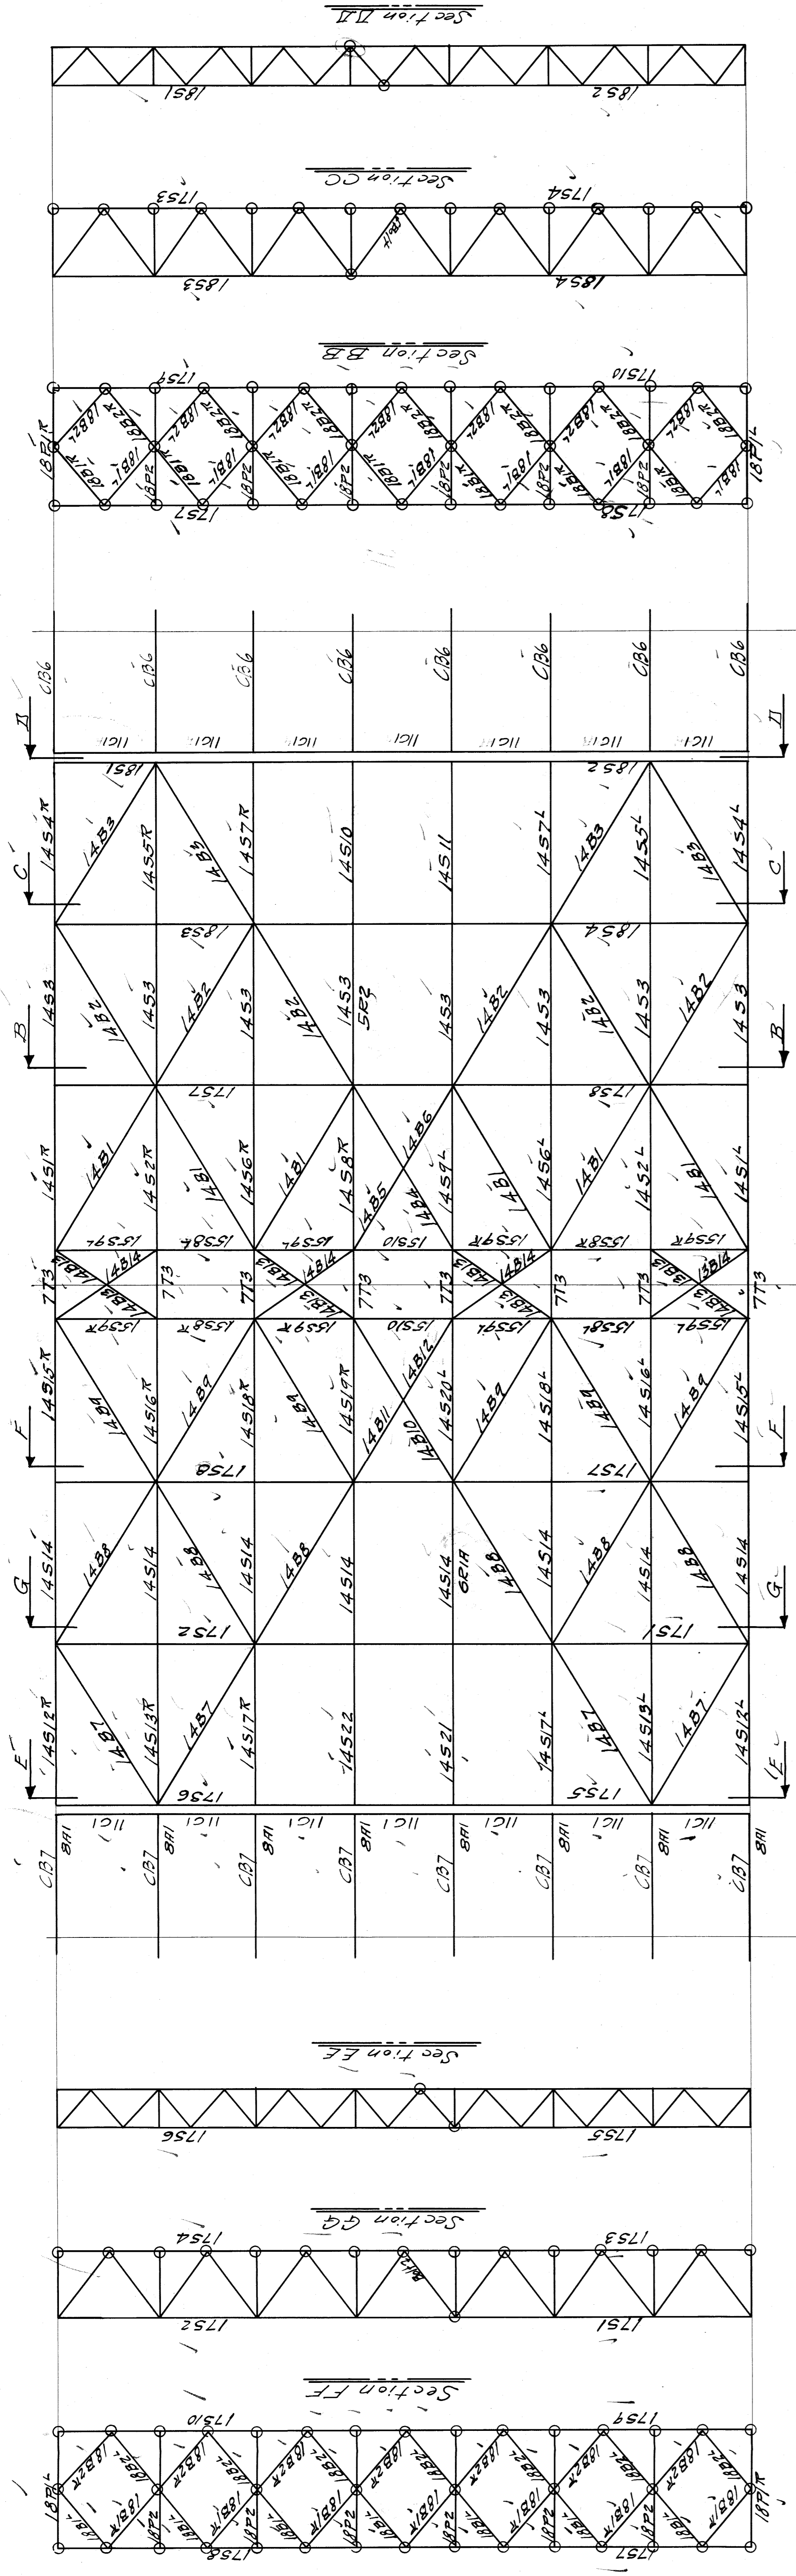

NOTE:
All points encircled thus O to be riveted.
All other points bolted.

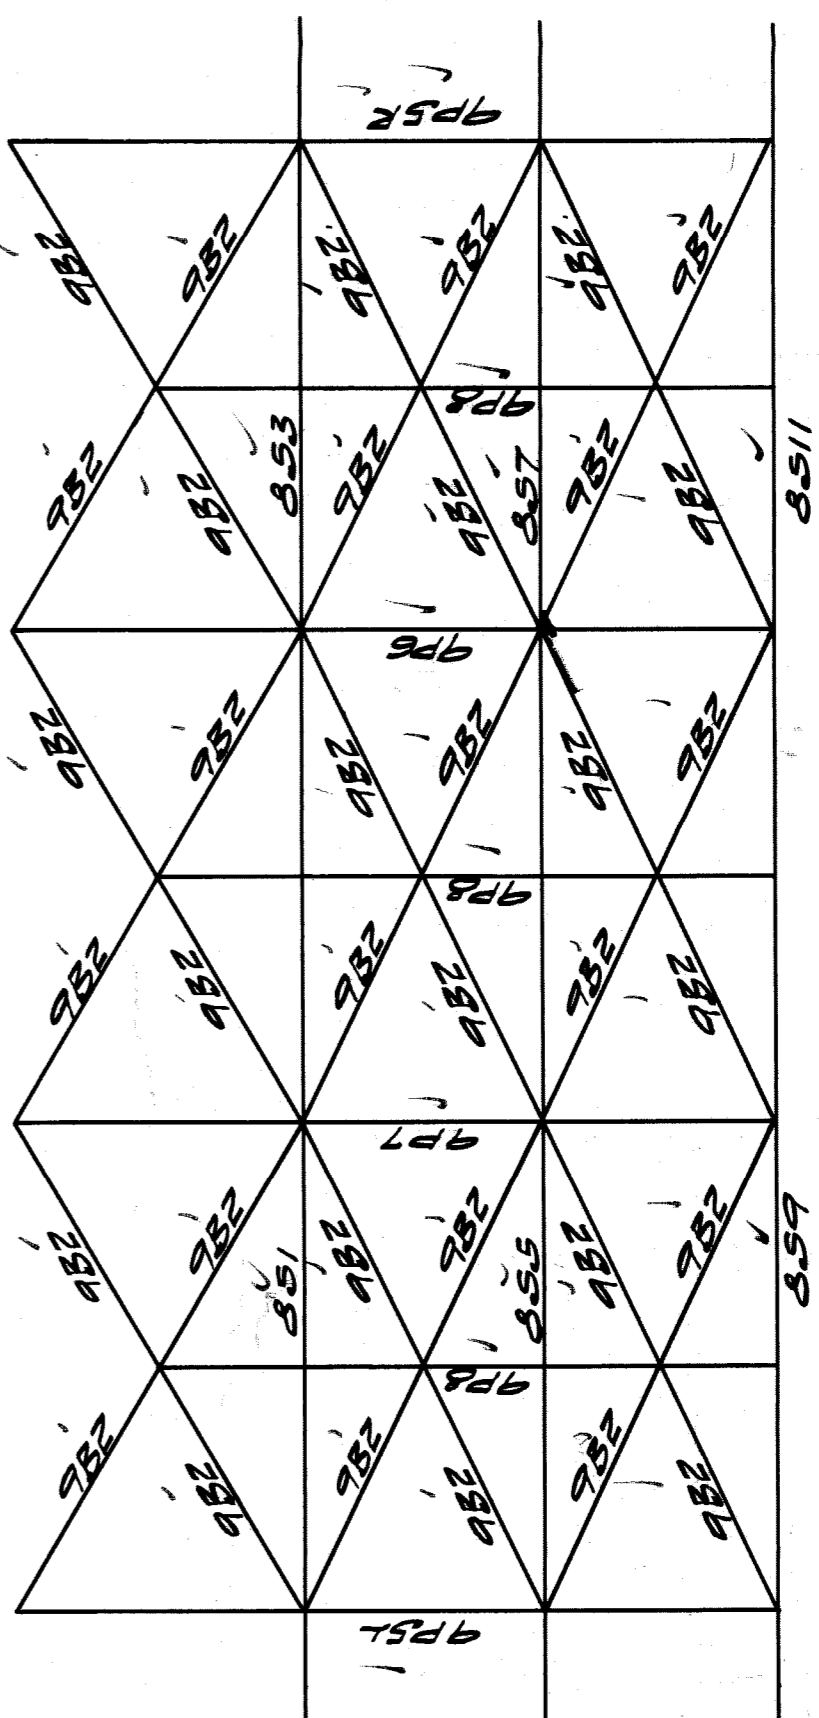

Bracing on Line of Pier
Section AA

WISCONSIN BRIDGE & IRON CO.
NORTH MILWAUKEE, WISCONSIN

CONTRACT NO. 9383
ERECTED BY
FOR City of Detroit
LOCATION Detroit, Mich.
DESCRIPTION Belle Isle Bridge
DETAILS OF Erection Pier #13


SPECIFICATIONS REAMING
INSPECTION BY
SHOP PAINT
FIELD PAINT

RIVETS OPEN HOLES EXCEPT AS NOTED
MADE BY W. H. Rivers DATE 7-28-21
TRACED BY DATE Feb 6, 22
CHECKED BY DATE Feb 6, 22

SCALE 8" = 1'-0"
SECTION

DATE REVISED
NO. 1
NO. 2
NO. 3
NO. 4
NO. 5
NO. 6
NO. 7
NO. 8
NO. 9
NO. 10

SHEET NO. 23
9383

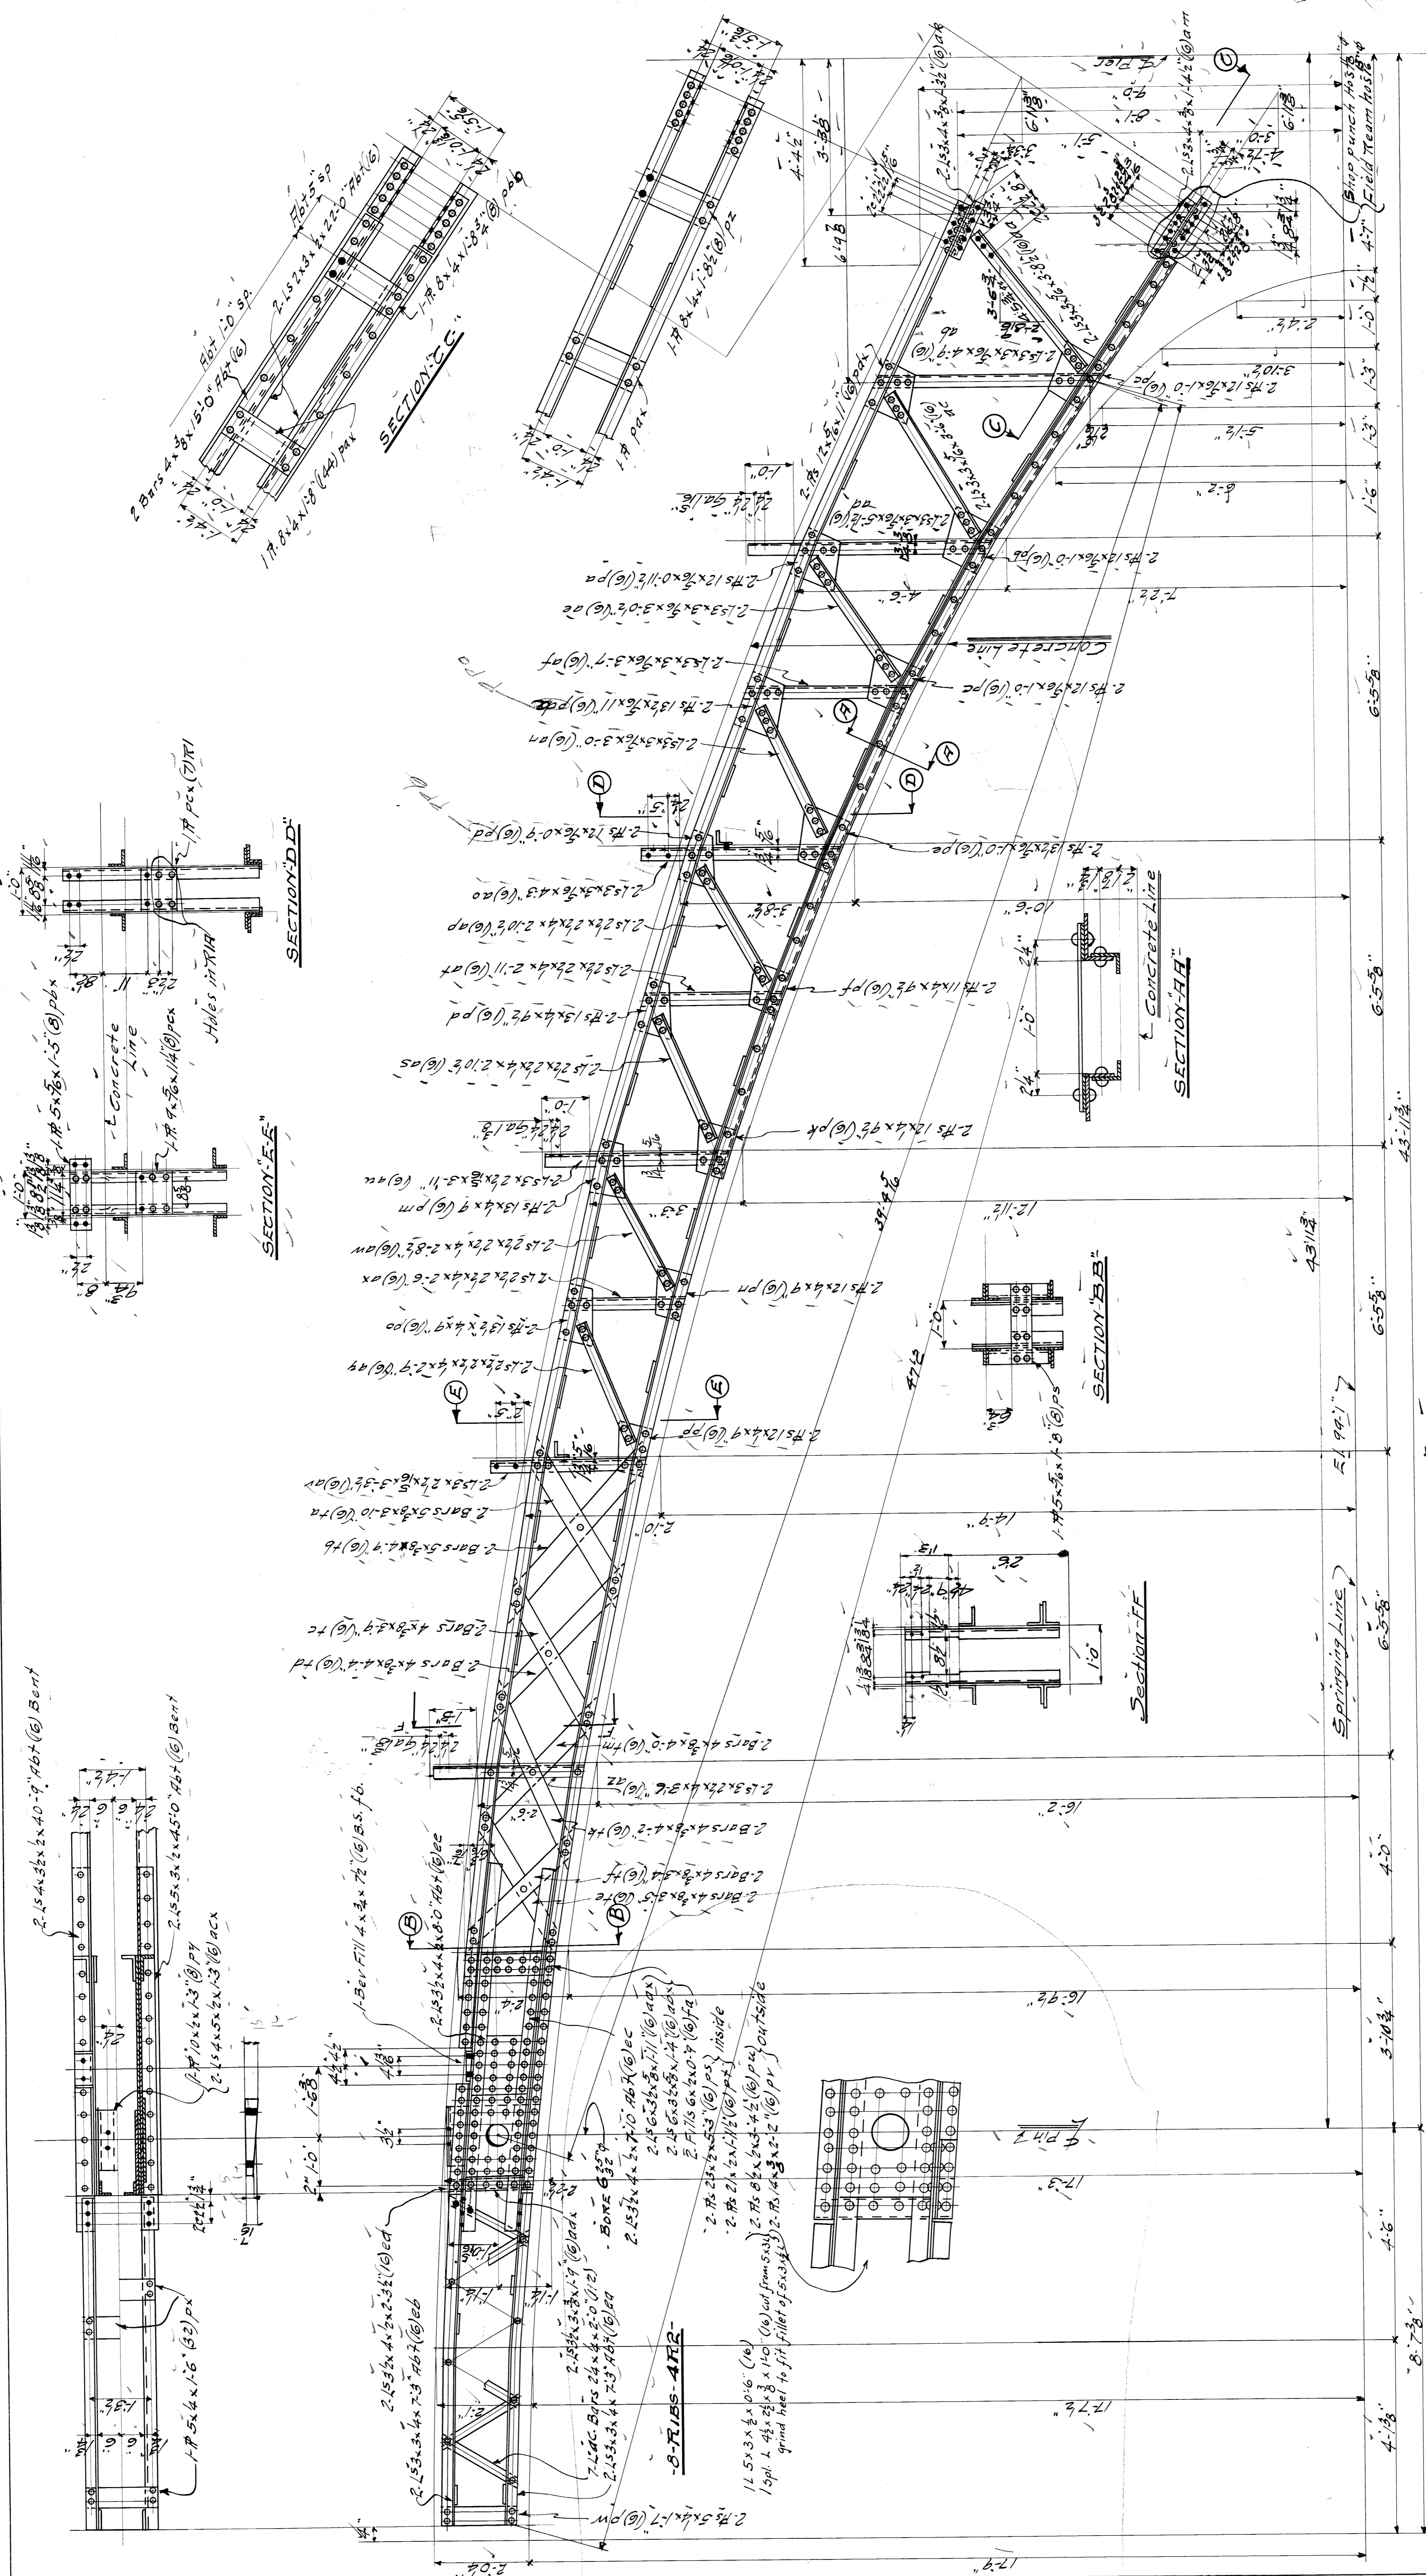

WISCONSIN BRIDGE & IRON CO.
 NORTH MILWAUKEE, WIS.

FOR City of Detroit
 LOCATION Detroit Mich
 DESCRIPTION Belle Isle Bridge
 DETAILS OF TRUSS
 INSPECTION BY S. S. S. (See Specifications)
 SHOP PAINT
 MADE BY T. E. S. DATE 11-1-21 RIVETS 3/8"
 TRACED BY F. R. O. DATE 11-1-21 OPEN HOLES 3/8"
 CHECKED BY M. W. DATE 6-23-21 UNLESS NOTED
 SCALE DATE REVISION
 SECTION


Summary of Parts

No	Description	Marks	Bill
7	TRUSS	ARI	4a-b
1	"	ARIA	4c
8	"	ATP	4c

TRUSS-ARI
1-1-ARIA

File BW 20-229 C.M.A.

SHEET No. 4
 9585

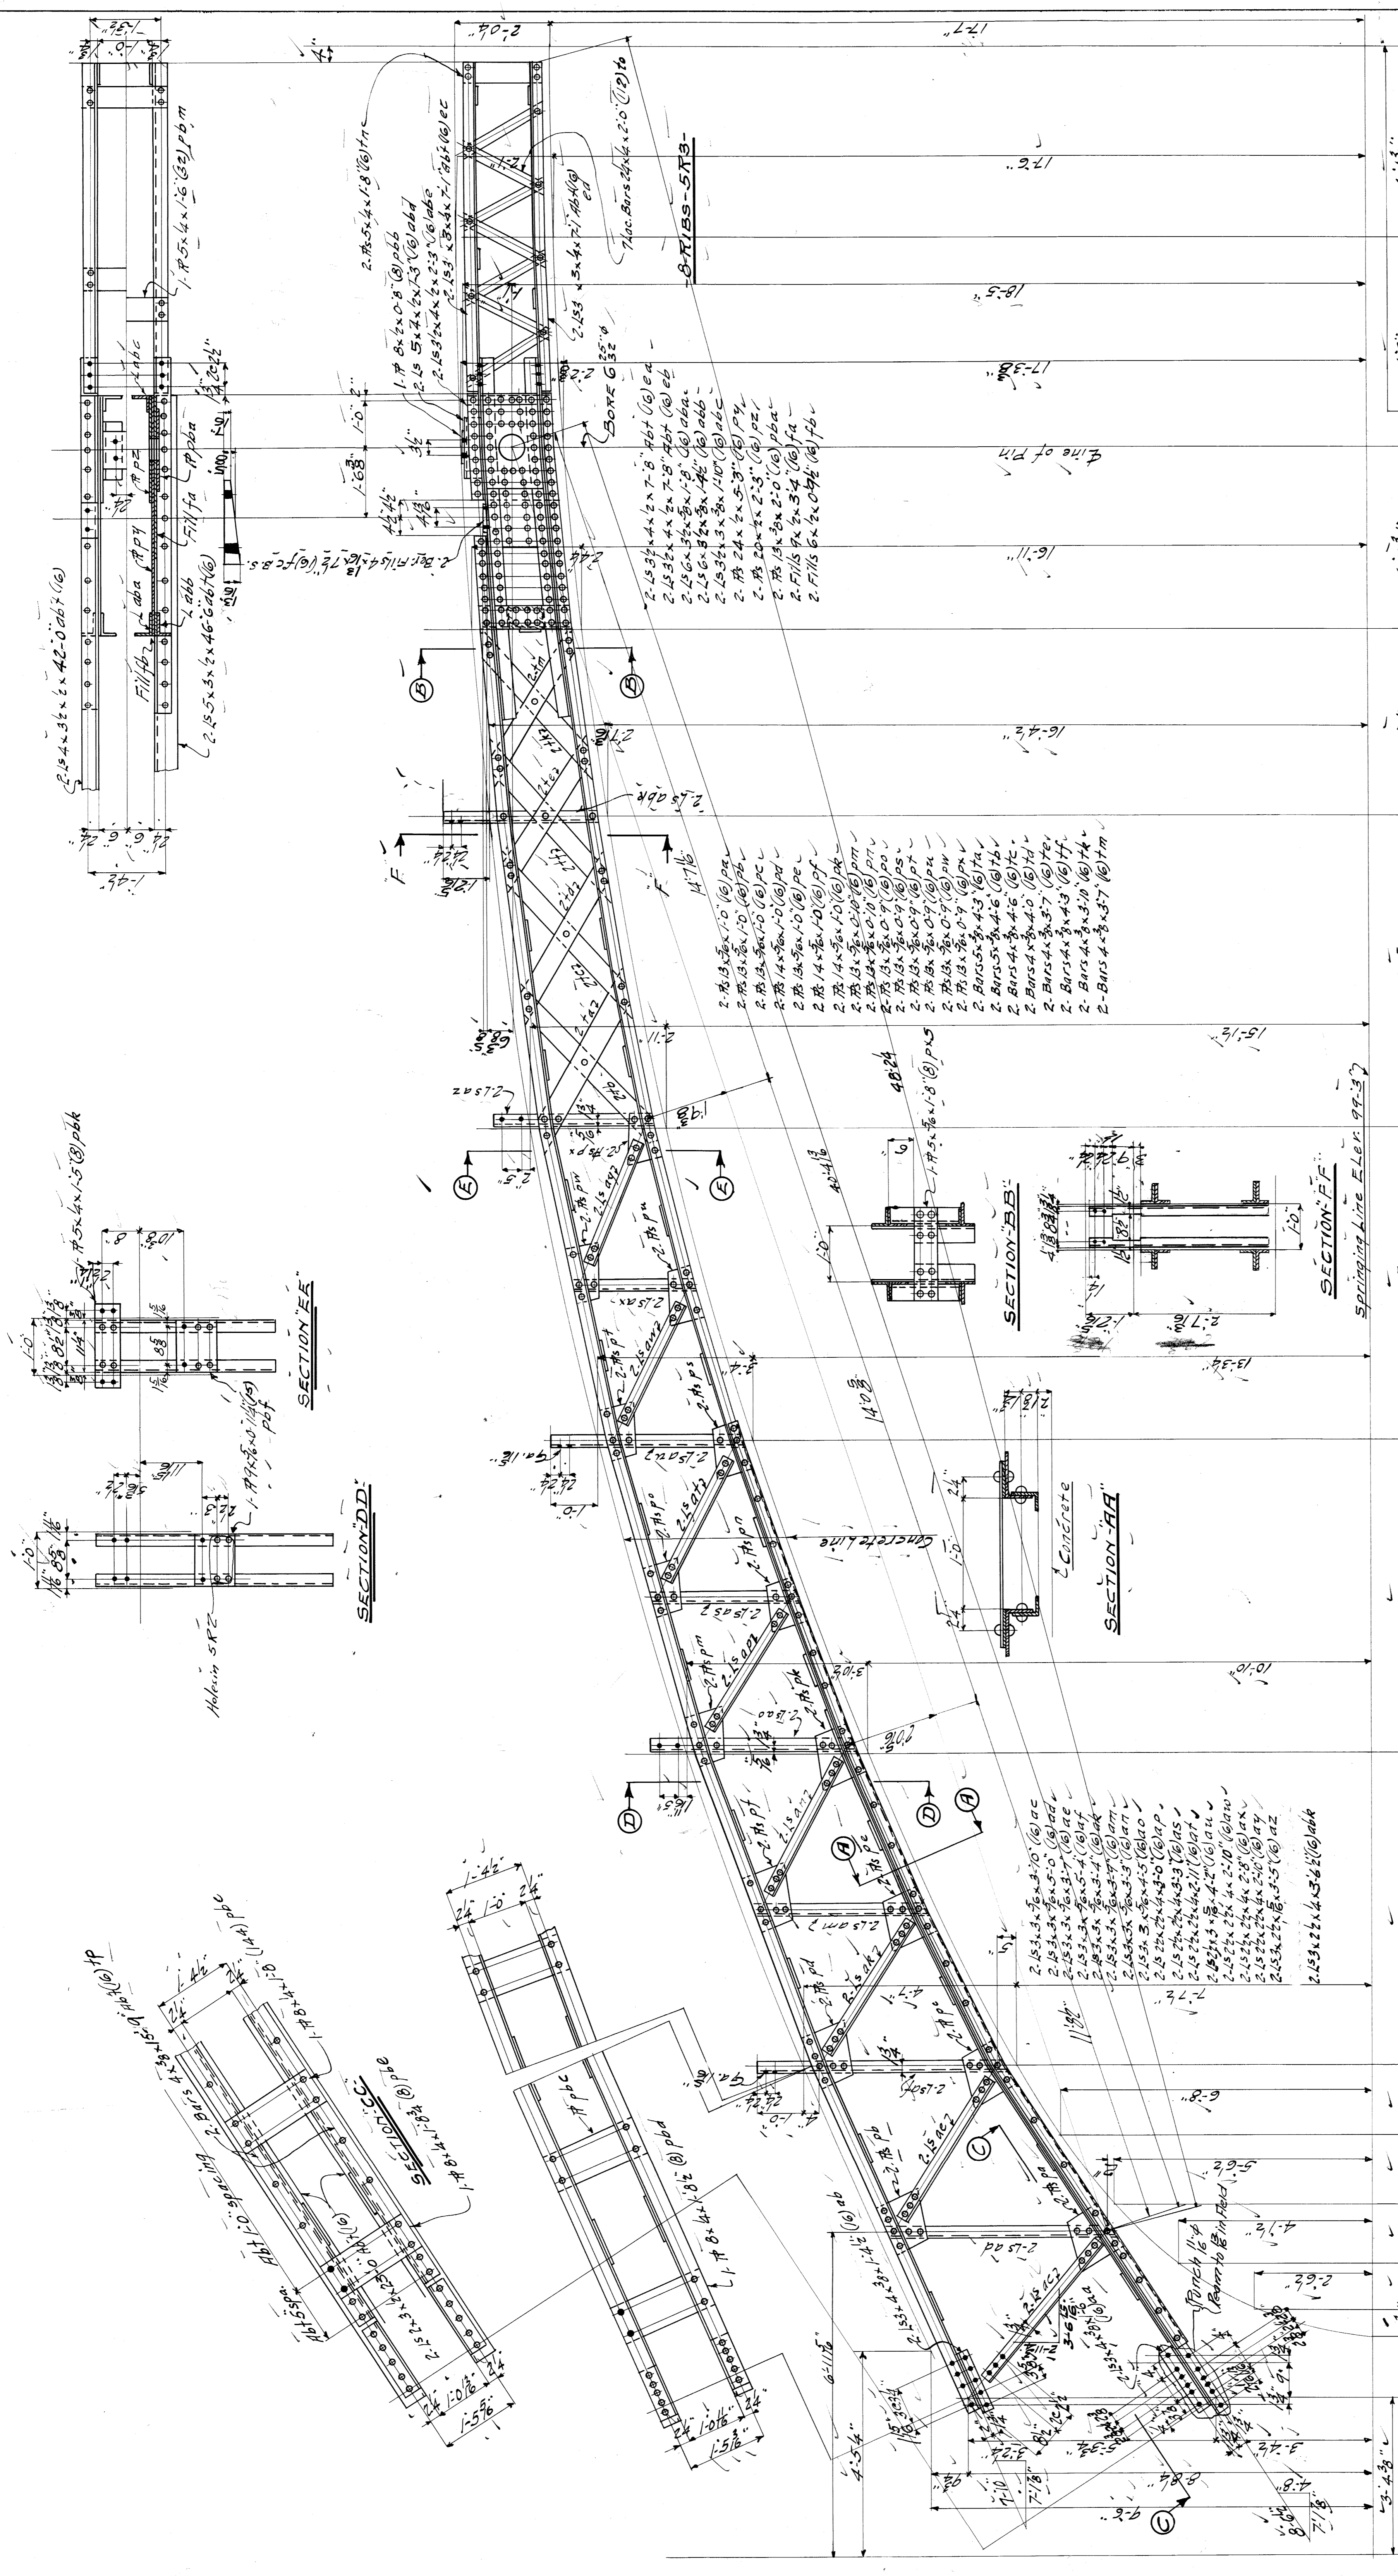


WISCONSIN BRIDGE & IRON CO.
 NORTH MILWAUKEE, WIS.
 FOR City of Detroit
 LOCATION Detroit, Mich.
 DESCRIPTION Belle Isle Bridge
 DETAILS OF RIBS
 SPECIFICATIONS ASSETS/STANDARD DRAWING No. 7-3
 INSPECTED BY W. H. B. DATE 11-15-21 FIELD PAINT
 SHOP PAINT None (See Specifications)
 MADE BY W. H. B. DATE 11-15-21 RIVETS 3/4"
 TRACED BY E. T. M. DATE 11-16-21 OPEN HOLES 3/4"
 CHECKED BY M. J. C. DATE 11-16-21 UNLESS NOTED
 SCALE _____ SECTION _____
 SHEET No. **5**

Summary of Parts

No. Description	Quantity	Material
7-RIBS	1	5R1
1 "	1	5R2
8 "	1	5R3

No.	Description	Quantity	Material
1	7-RIBS-5R1	1	5R1
1	7-RIBS-5R2	1	5R2
1	7-RIBS-5R3	1	5R3

7-RIBS-5R1-
 1-5R2-
 1-5R3-

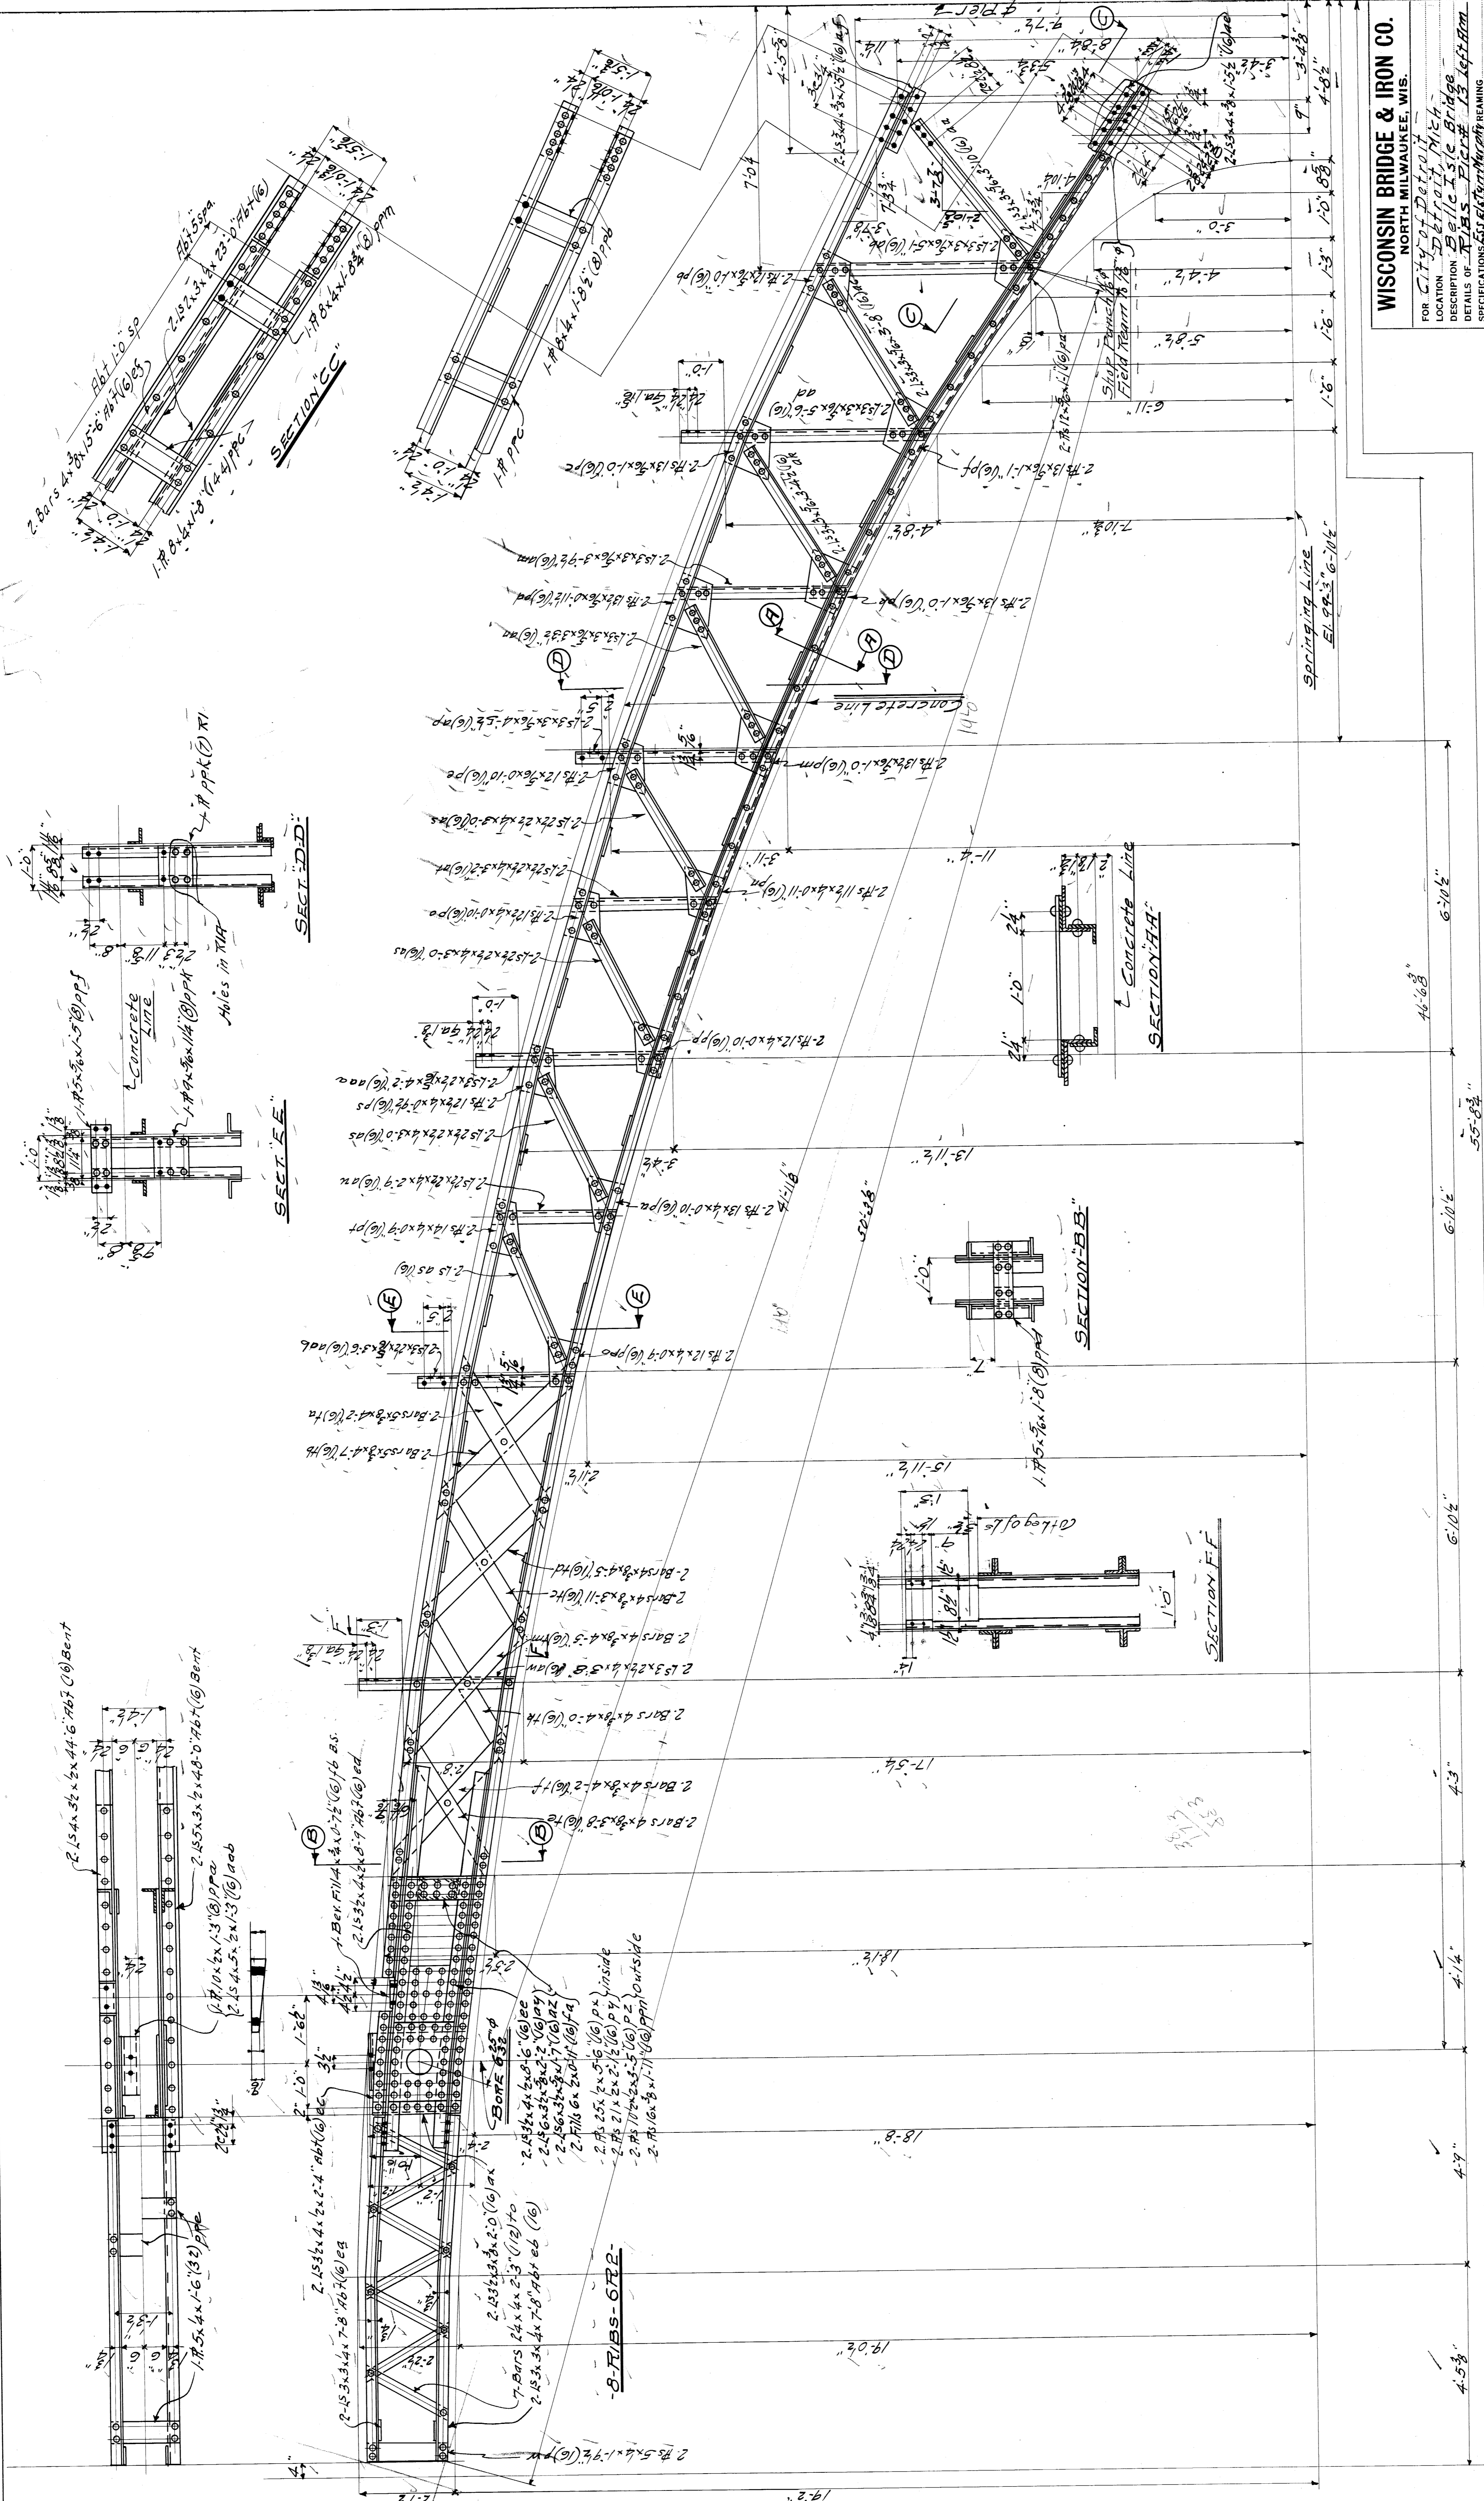

WISCONSIN BRIDGE & IRON CO.
 NORTH MILWAUKEE, WIS.

FOR CITY OF DETROIT
 LOCATION Belle Isle Bridge
 DESCRIPTION Belle Isle Bridge
 DETAILS OF RIBS - PIER # 13 LEFT RIB

INSPECTED BY [Signature]
 SPECIFICATIONS See Specifications
 SHOP PAINT [Signature]
 FIELD PAINT [Signature]

MADE BY T.F.S. DATE 1/14/21
 TRACED BY T.F.S. DATE 1/16/21
 CHECKED BY [Signature] DATE 1/16/21
 UNLESS NOTED

SCALE SECTION
 DATE REVISED


SHEET No. 6
 9383

Summary of Parts

No.	Description	Marks	Bill
7	RIBS	GT1	MAN
1	"	GT1A	"
8	"	GT2	MAC

B-RIBS-6R1
 1. - 6R1A



File BW 201.231
 F. S. C. BY CMA

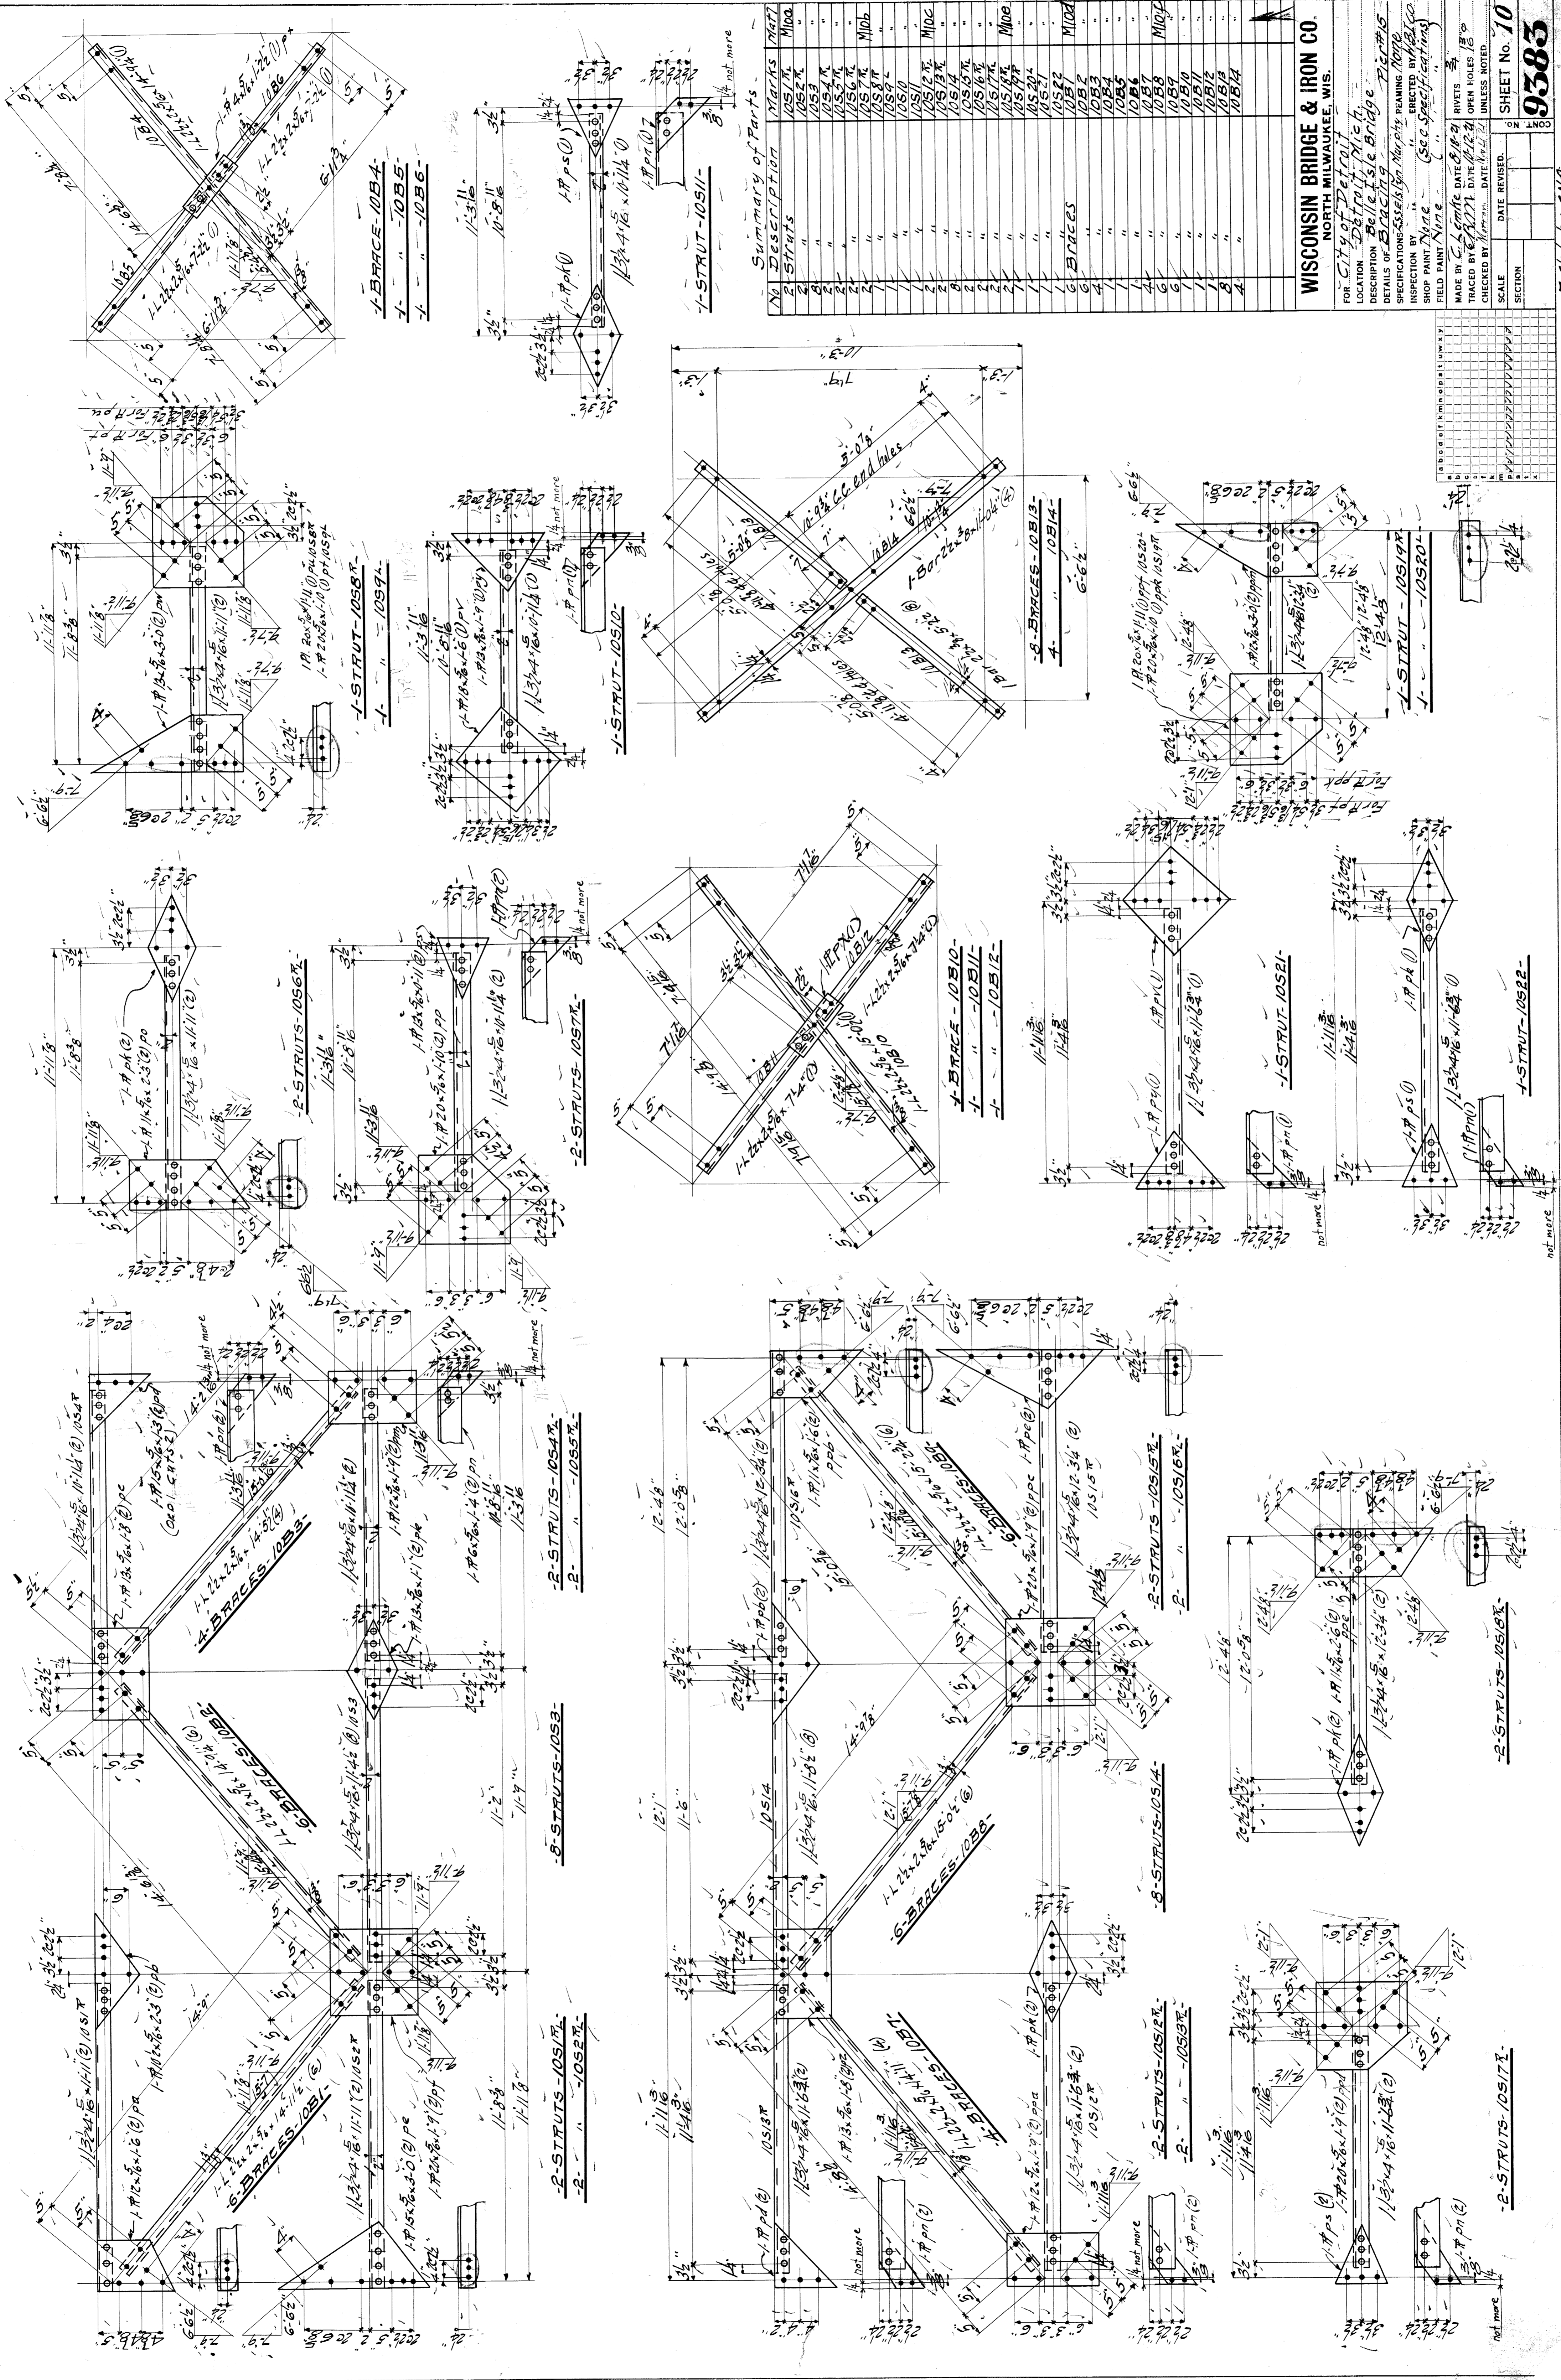


Summary of Parts

NO	DESCRIPTION	MARKS	QTY
1	STRUTS	10S10	1000
2	"	10S11	1000
3	"	10S12	1000
4	"	10S13	1000
91	"	10S100	1000

WISCONSIN BRIDGE & IRON CO.
 NORTH MILWAUKEE, WIS.
 FOR City of Detroit
 LOCATION Belle Isle Bridge
 DETAILS OF BRACING
 INSPECTION BY [Signature]
 SHOP PAINT NAME [Signature]
 FIELD PAINT NAME [Signature]
 MADE BY [Signature] RIVETS [Signature]
 TRACED BY [Signature] OPEN HOLES [Signature]
 CHECKED BY [Signature] DATE [Signature]
 SCALE [Signature]
 SHEET No. 10
 SECTION [Signature]

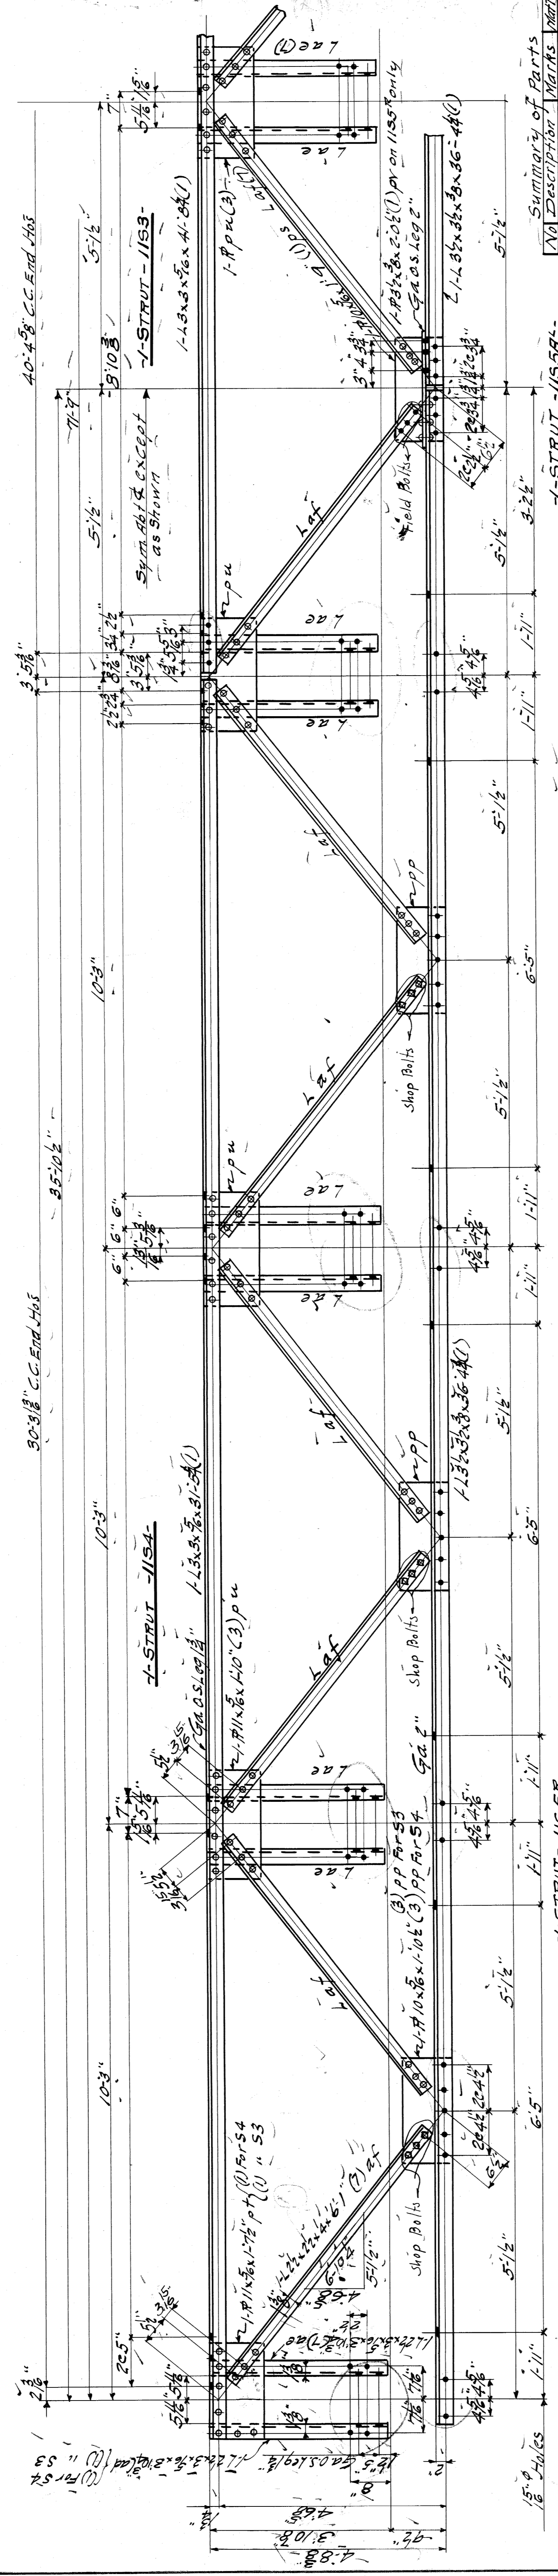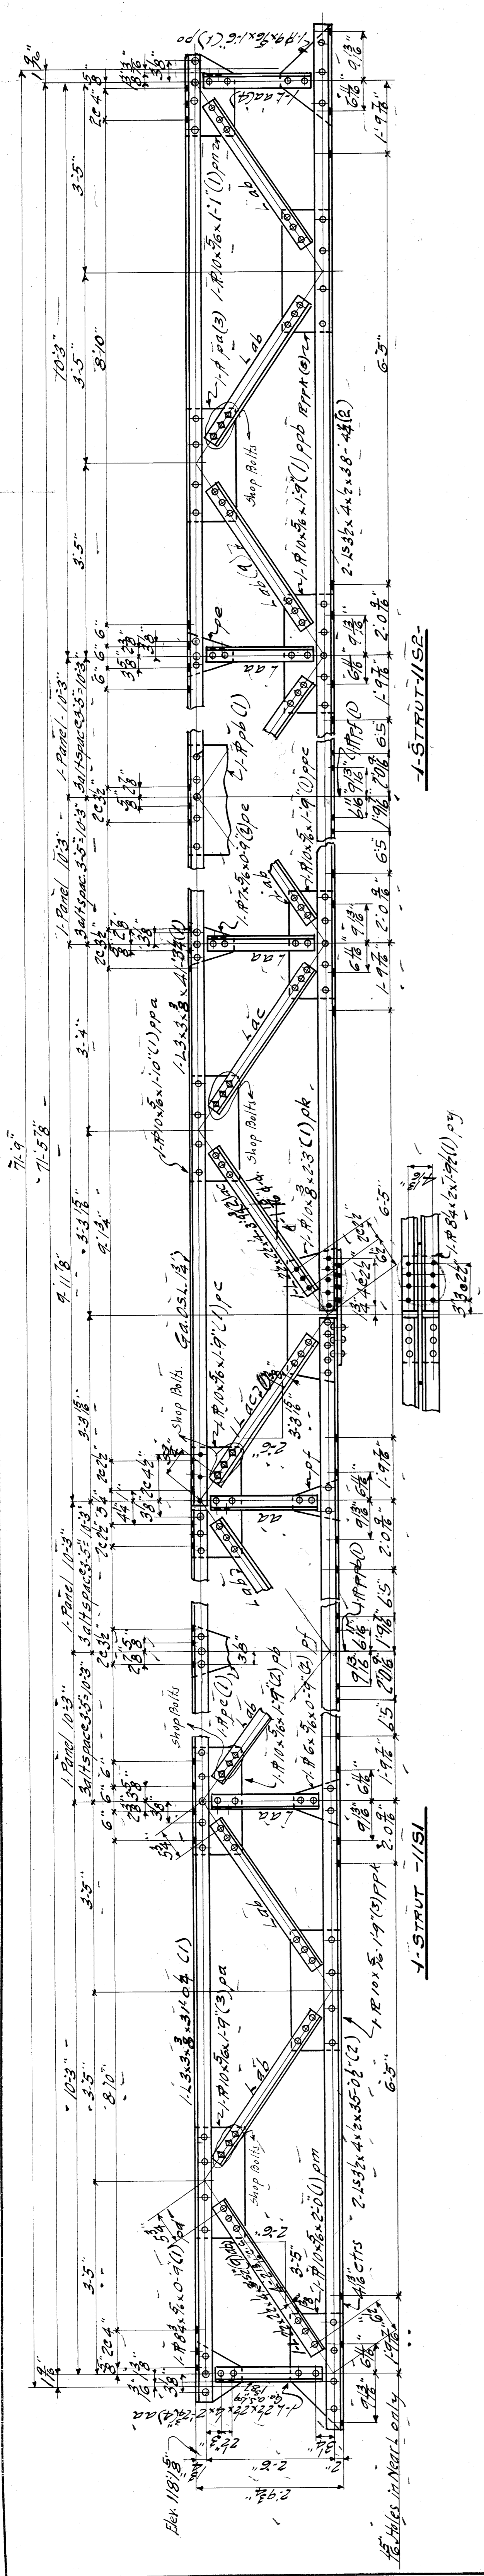

No	Description	Marks	Qty
1	STRUT	1151	1
2	"	1152	1
3	"	1153	1
4	BARCES	1154	1
5	"	1155A	1
6	"	1155B	1
7	Posts	1156	1
8	"	1157	1
9	"	1158	1
10	Channels	1159	1
11	"	1160	1
12	"	1161	1
13	"	1162	1
309	"	1458	1
310			

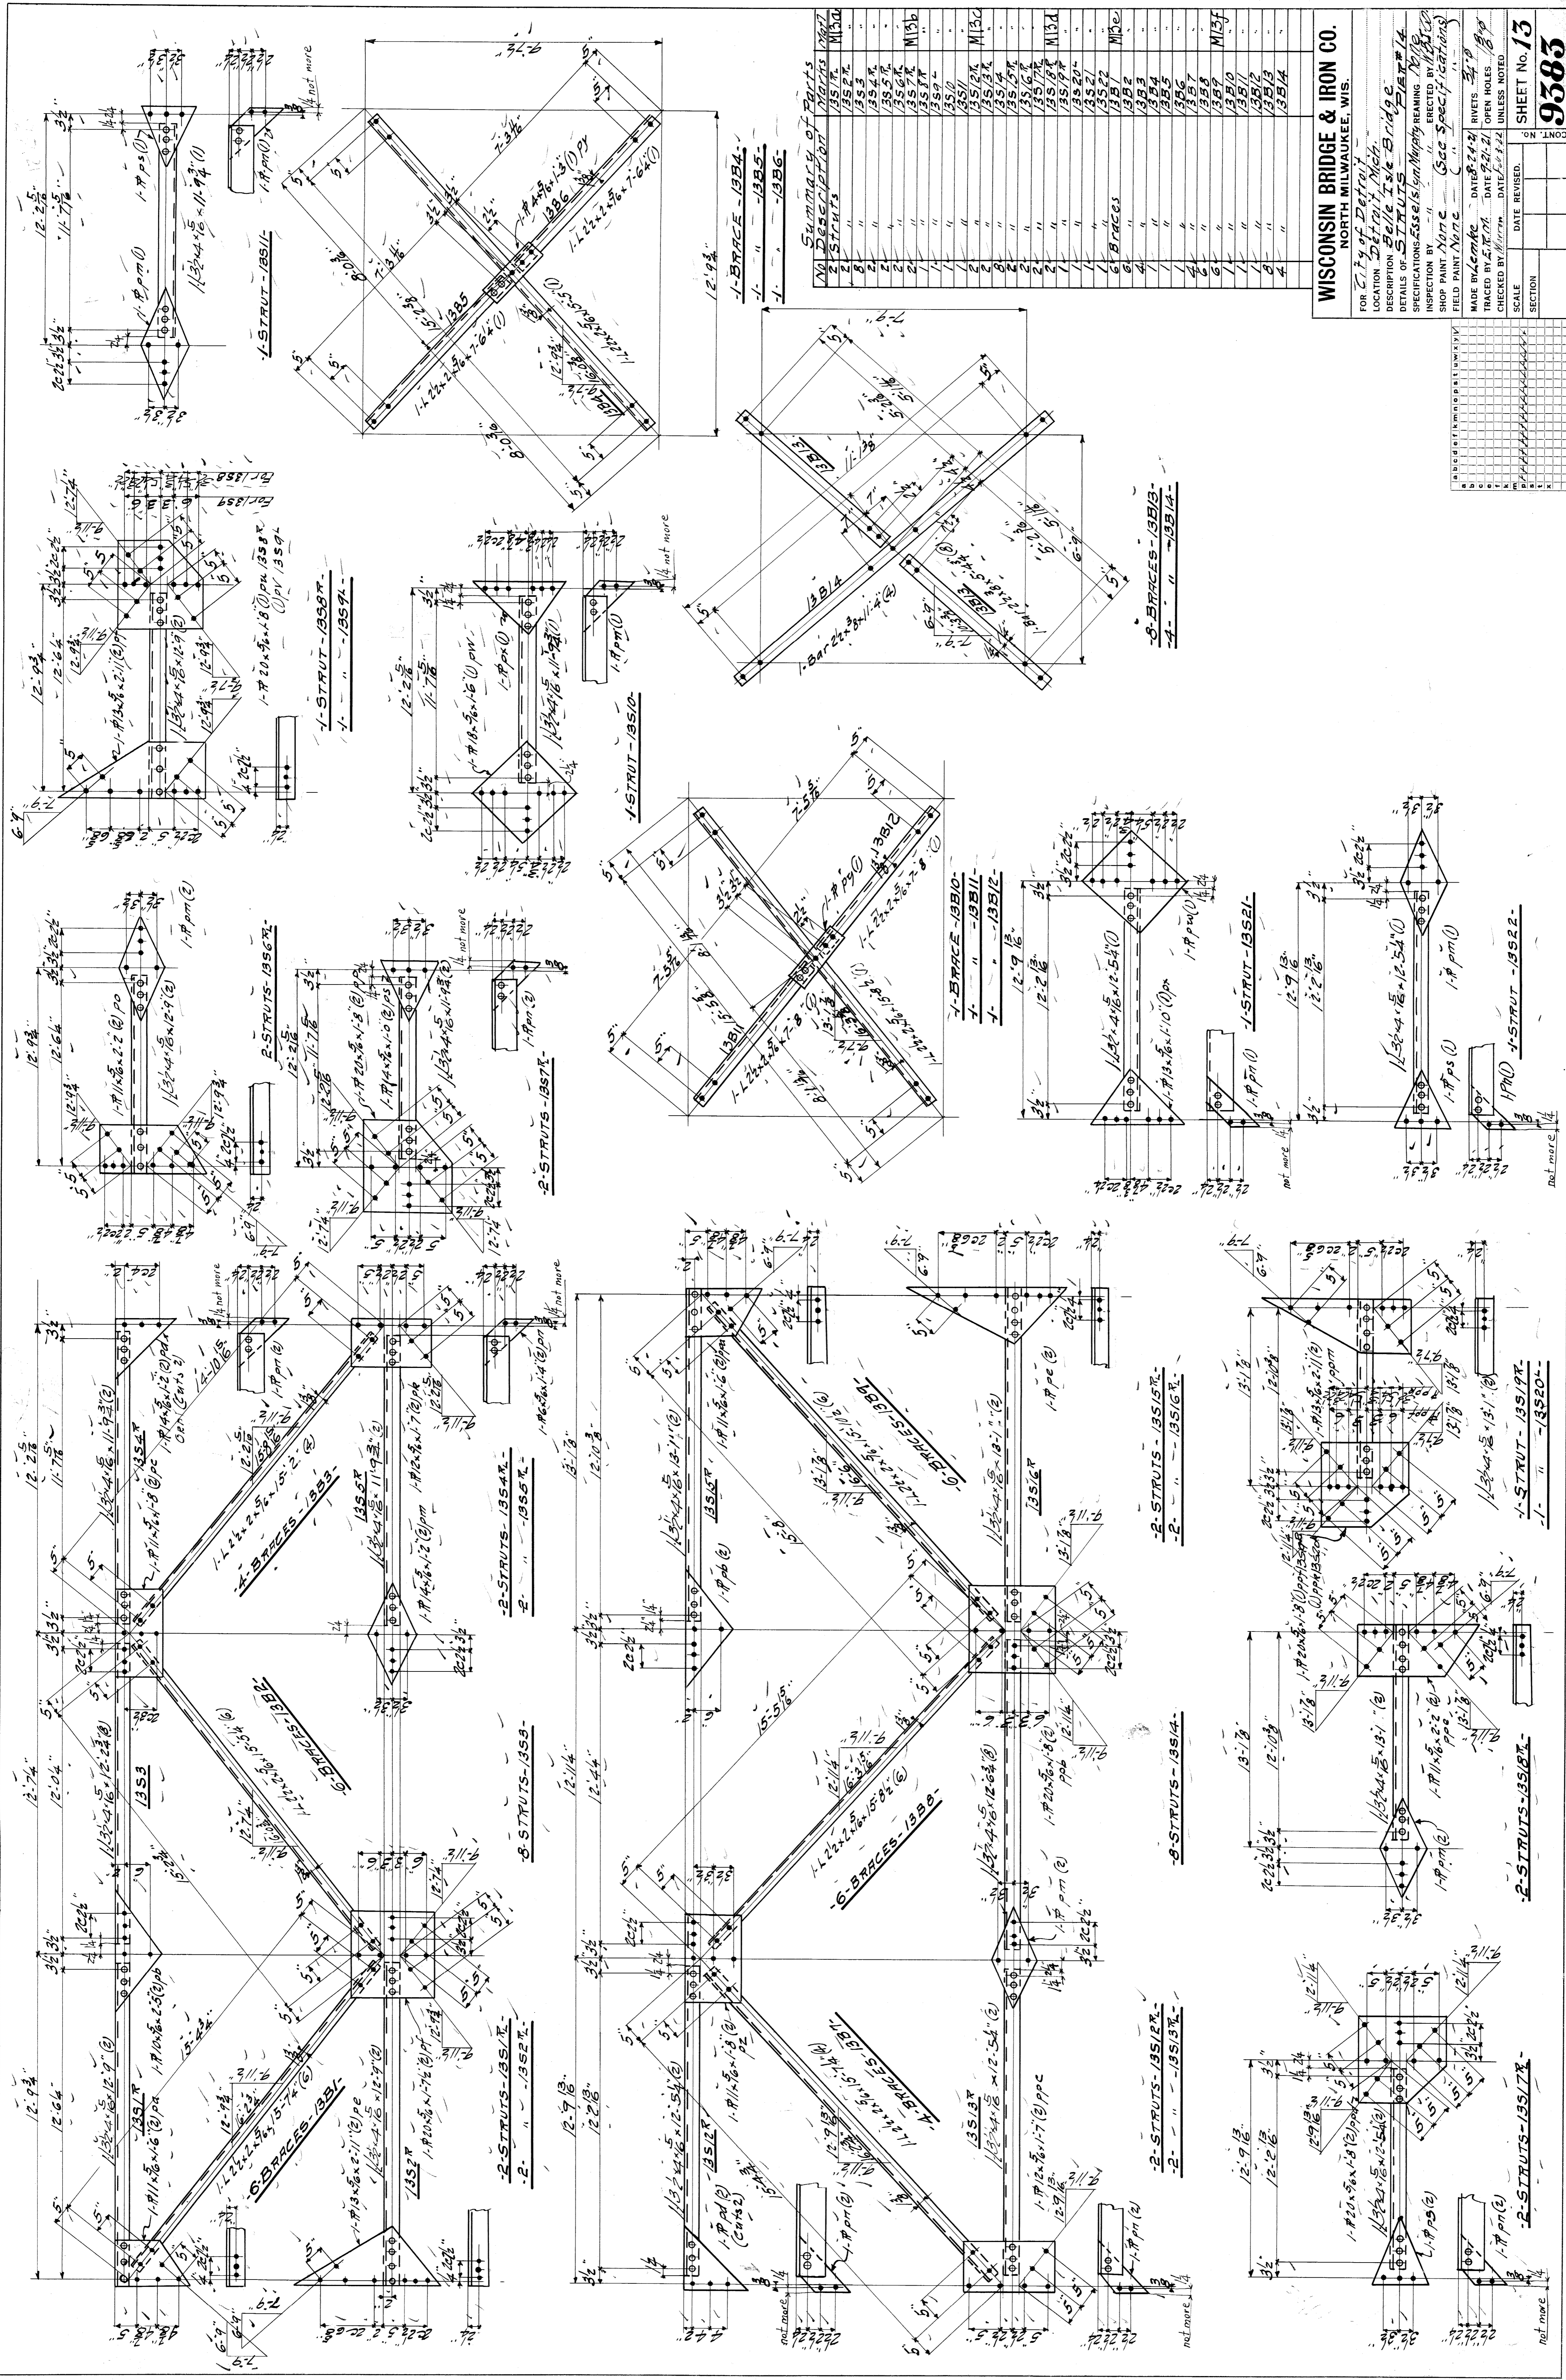

NO.	DESCRIPTION	QUANTITY	UNIT
1	1-STRUTS	1351A	
2	2-STRUTS	1352A	
3	3-STRUTS	1353A	
4	4-BRACES	1354A	
5	5-STRUTS	1355A	
6	6-BRACES	1356A	
7	7-STRUTS	1357A	
8	8-BRACES	1358A	
9	9-STRUTS	1359A	
10	10-BRACES	1360A	
11	11-STRUTS	1361A	
12	12-BRACES	1362A	
13	13-STRUTS	1363A	
14	14-BRACES	1364A	
15	15-STRUTS	1365A	
16	16-BRACES	1366A	
17	17-STRUTS	1367A	
18	18-BRACES	1368A	
19	19-STRUTS	1369A	
20	20-BRACES	1370A	
21	21-STRUTS	1371A	
22	22-BRACES	1372A	
23	23-STRUTS	1373A	
24	24-BRACES	1374A	
25	25-STRUTS	1375A	
26	26-BRACES	1376A	
27	27-STRUTS	1377A	
28	28-BRACES	1378A	
29	29-STRUTS	1379A	
30	30-BRACES	1380A	

WISCONSIN BRIDGE & IRON CO.
 NORTH MILWAUKEE, WIS.


FOR City of Detroit
 LOCATION Detroit, Mich.
 DESCRIPTION Belle Isle Bridge
 DETAILS OF STRUTS
 SPECIFICATIONS See Specifications Form #14
 INSPECTED BY [Signature]
 SHOP PAINT NAME (See Specifications)
 FIELD PAINT NAME (See Specifications)

MADE BY [Signature] DATE [Date]
 TRACED BY [Signature] DATE [Date]
 CHECKED BY [Signature] DATE [Date]

RIVETS 3/8"
 OPEN HOLES 1/8"
 UNLESS NOTED

SCALE [Scale]
 DATE REVISED [Date]
 SECTION [Section]

SHEET No. 13
 9385

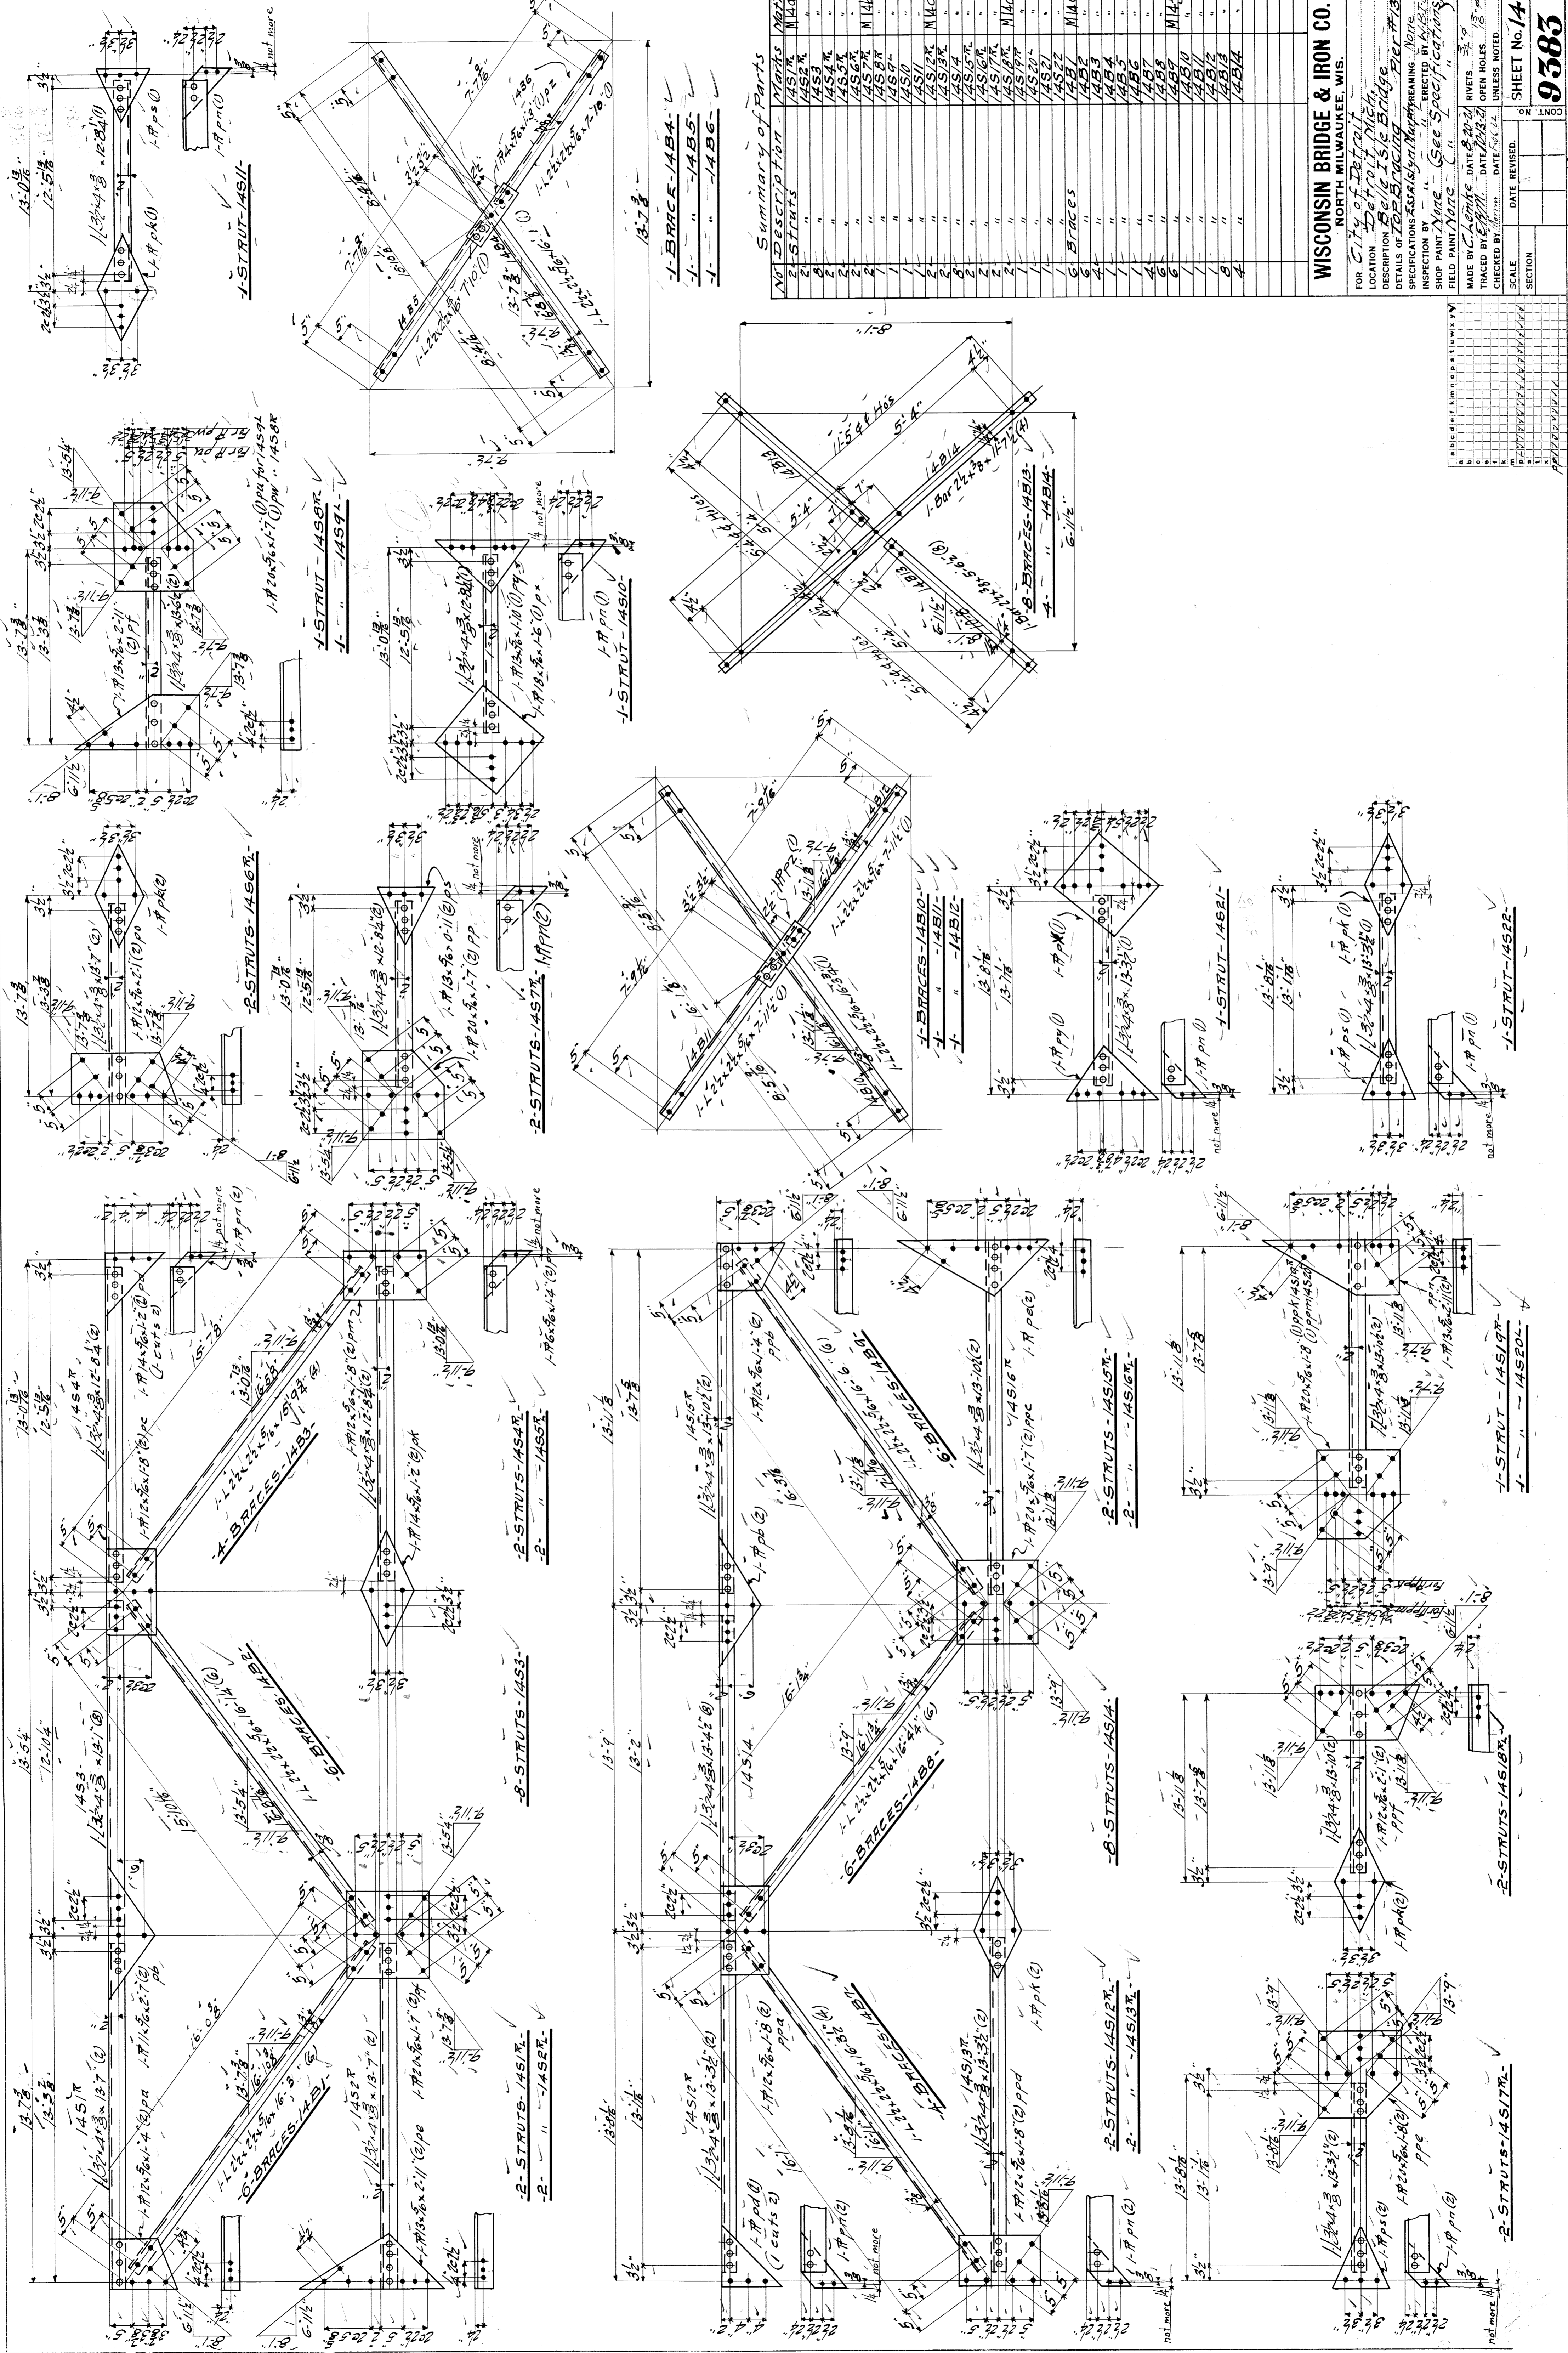

Summary of Parts

No.	Description	Marks	QTY
1	STRUTS	1451R	2
2	"	1452R	2
3	"	1453R	2
4	"	1454R	2
5	"	1455R	2
6	"	1456R	2
7	"	1457R	2
8	"	1458R	2
9	"	1459R	2
10	"	1460R	2
11	"	1461R	2
12	"	1462R	2
13	"	1463R	2
14	"	1464R	2
15	"	1465R	2
16	"	1466R	2
17	"	1467R	2
18	"	1468R	2
19	"	1469R	2
20	"	1470R	2
21	"	1471R	2
22	"	1472R	2
23	"	1473R	2
24	"	1474R	2
25	"	1475R	2
26	"	1476R	2
27	"	1477R	2
28	"	1478R	2
29	"	1479R	2
30	"	1480R	2
31	"	1481R	2
32	"	1482R	2
33	"	1483R	2
34	"	1484R	2
35	"	1485R	2
36	"	1486R	2
37	"	1487R	2
38	"	1488R	2
39	"	1489R	2
40	"	1490R	2
41	"	1491R	2
42	"	1492R	2
43	"	1493R	2
44	"	1494R	2
45	"	1495R	2
46	"	1496R	2
47	"	1497R	2
48	"	1498R	2
49	"	1499R	2
50	"	1500R	2

WISCONSIN BRIDGE & IRON CO.
 NORTH MILWAUKEE, WIS.

FOR: City of Detroit
 LOCATION: Detroit Mich.
 DESCRIPTION: Belle Isle Bridge Pier #3
 DETAILS OF: BRACING
 SPECIFICATIONS: As per City of Detroit Specifications
 INSPECTED BY: [Name]
 SHOP PAINT: Name (See Specifications)



MADE BY: [Name] DATE: [Date]
 TRACED BY: [Name] DATE: [Date]
 CHECKED BY: [Name] DATE: [Date]
 UNLESS NOTED OTHERWISE

SCALE: _____ SECTION: _____

DATE REVISION: _____

SHEET No. 14
 9585

File BW 201-239
 F. C. By E. M. A.

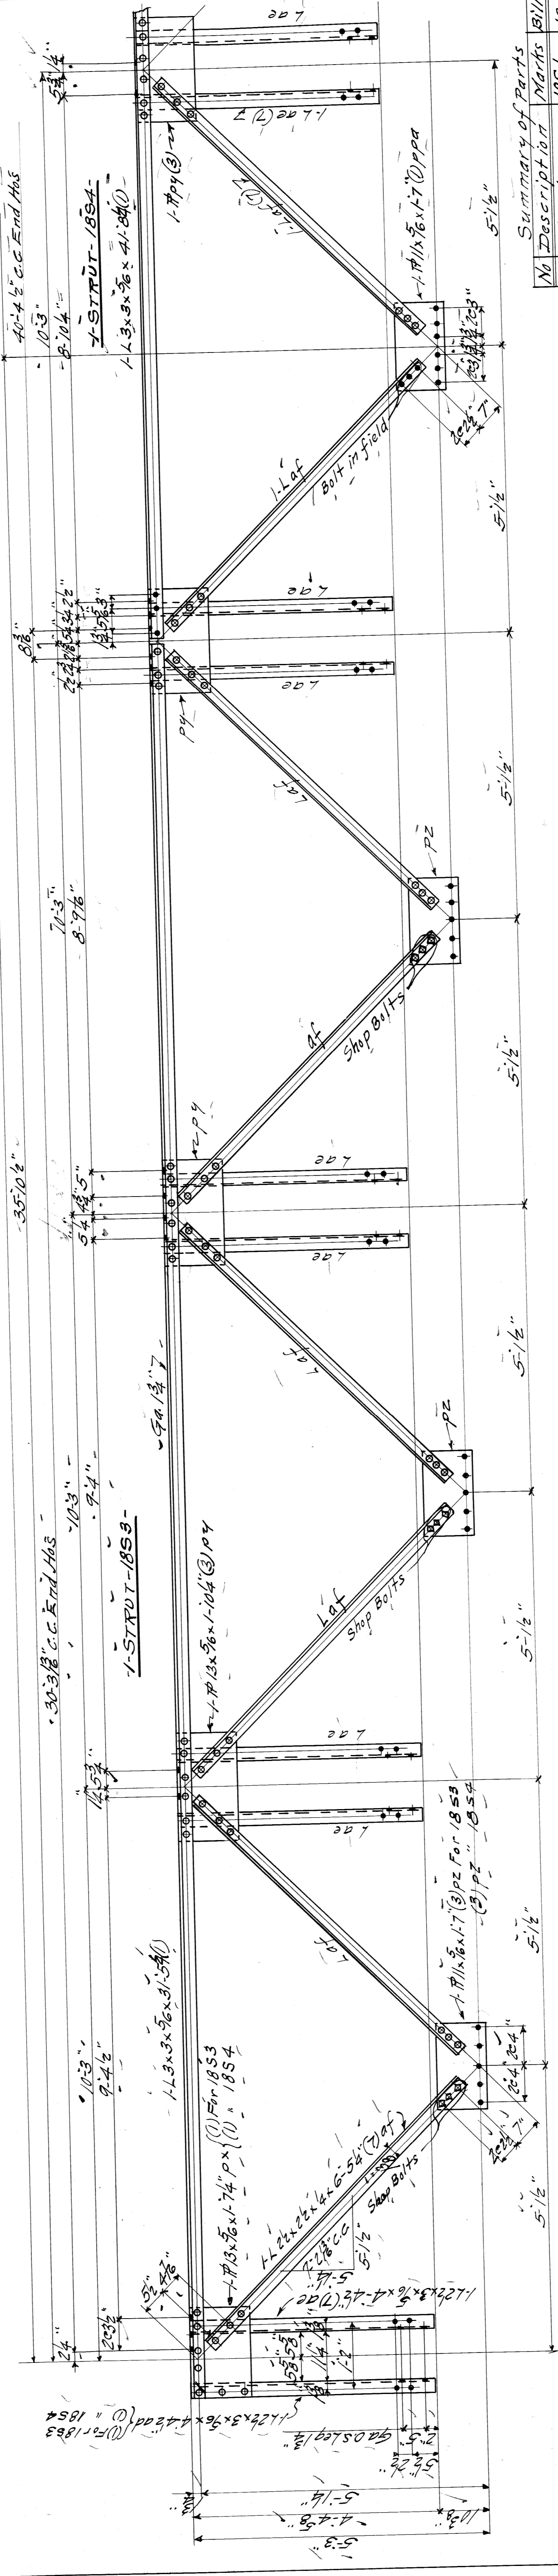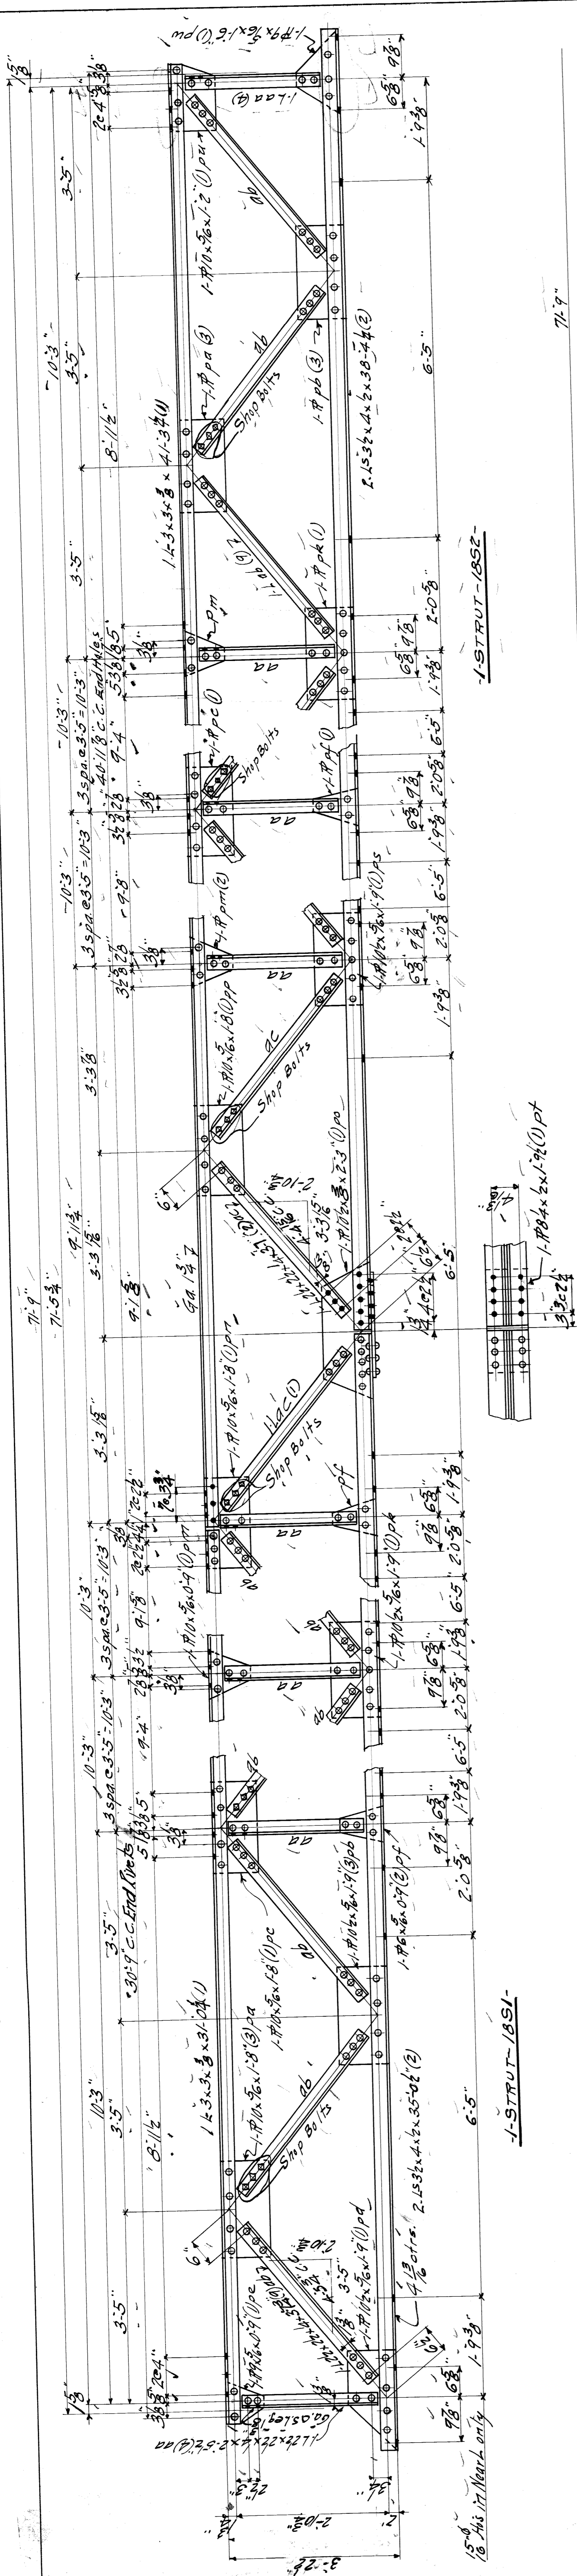

Summary of Parts

No	Description	1851	1852	1853	1854
1	Strut				
1	"				
1	"				
4	Posts				
12	"				
28	Braces				
28	"				

WISCONSIN BRIDGE & IRON CO.
 NORTH MILWAUKEE, WIS.

FOR City of Detroit
 LOCATION Detroit, Mich.
 DESCRIPTION Belle Isle Bridge
 DETAILS OF STRUCTURE Beloit-Installation
 SPECIFICATIONS See Michigan Bridge REMAINING
 INSPECTED BY
 SHOP PAINT Name (See Specifications)
 FIELD PAINT


MADE BY H.F.S. DATE 1/16/21 RIVETS 3/4"
 TRACED BY E.P.M. DATE 1/18/21 OPEN HOLES 1/2"
 CHECKED BY J.S.P. DATE 2/1/22 UNLESS NOTED
 SCALE DATE REVISED
 SECTION

SHEET No. 10
 9583




File BW291-293-2nd. by C.N.A.


WISCONSIN BRIDGE & IRON CO.
 NORTH MILWAUKEE, WISCONSIN
 CONTRACT NO. 9384
 ERECTED BY
 FOR *City of Detroit*
 LOCATION *Detroit, Mich.*
 DESCRIPTION *Belle Isle Bridge (Piers #19)*
 DETAILS OF
 SPECIFICATIONS *See Style Murphy Reaming*
 INSPECTION BY
 SHOP PAINT
 FIELD PAINT
 RIVETS
 OPEN HOLES
 EXCEPT AS NOTED
 MADE BY *W.H.P.* DATE *7-1-21*
 TRACED BY *S.M.M.* DATE *7-25-21*
 CHECKED BY *Murray* DATE *Oct 14 21*
 SCALE SECTION
 DATE REVISED
 SHEET NO. **9384**
 ON 1 NO. 0

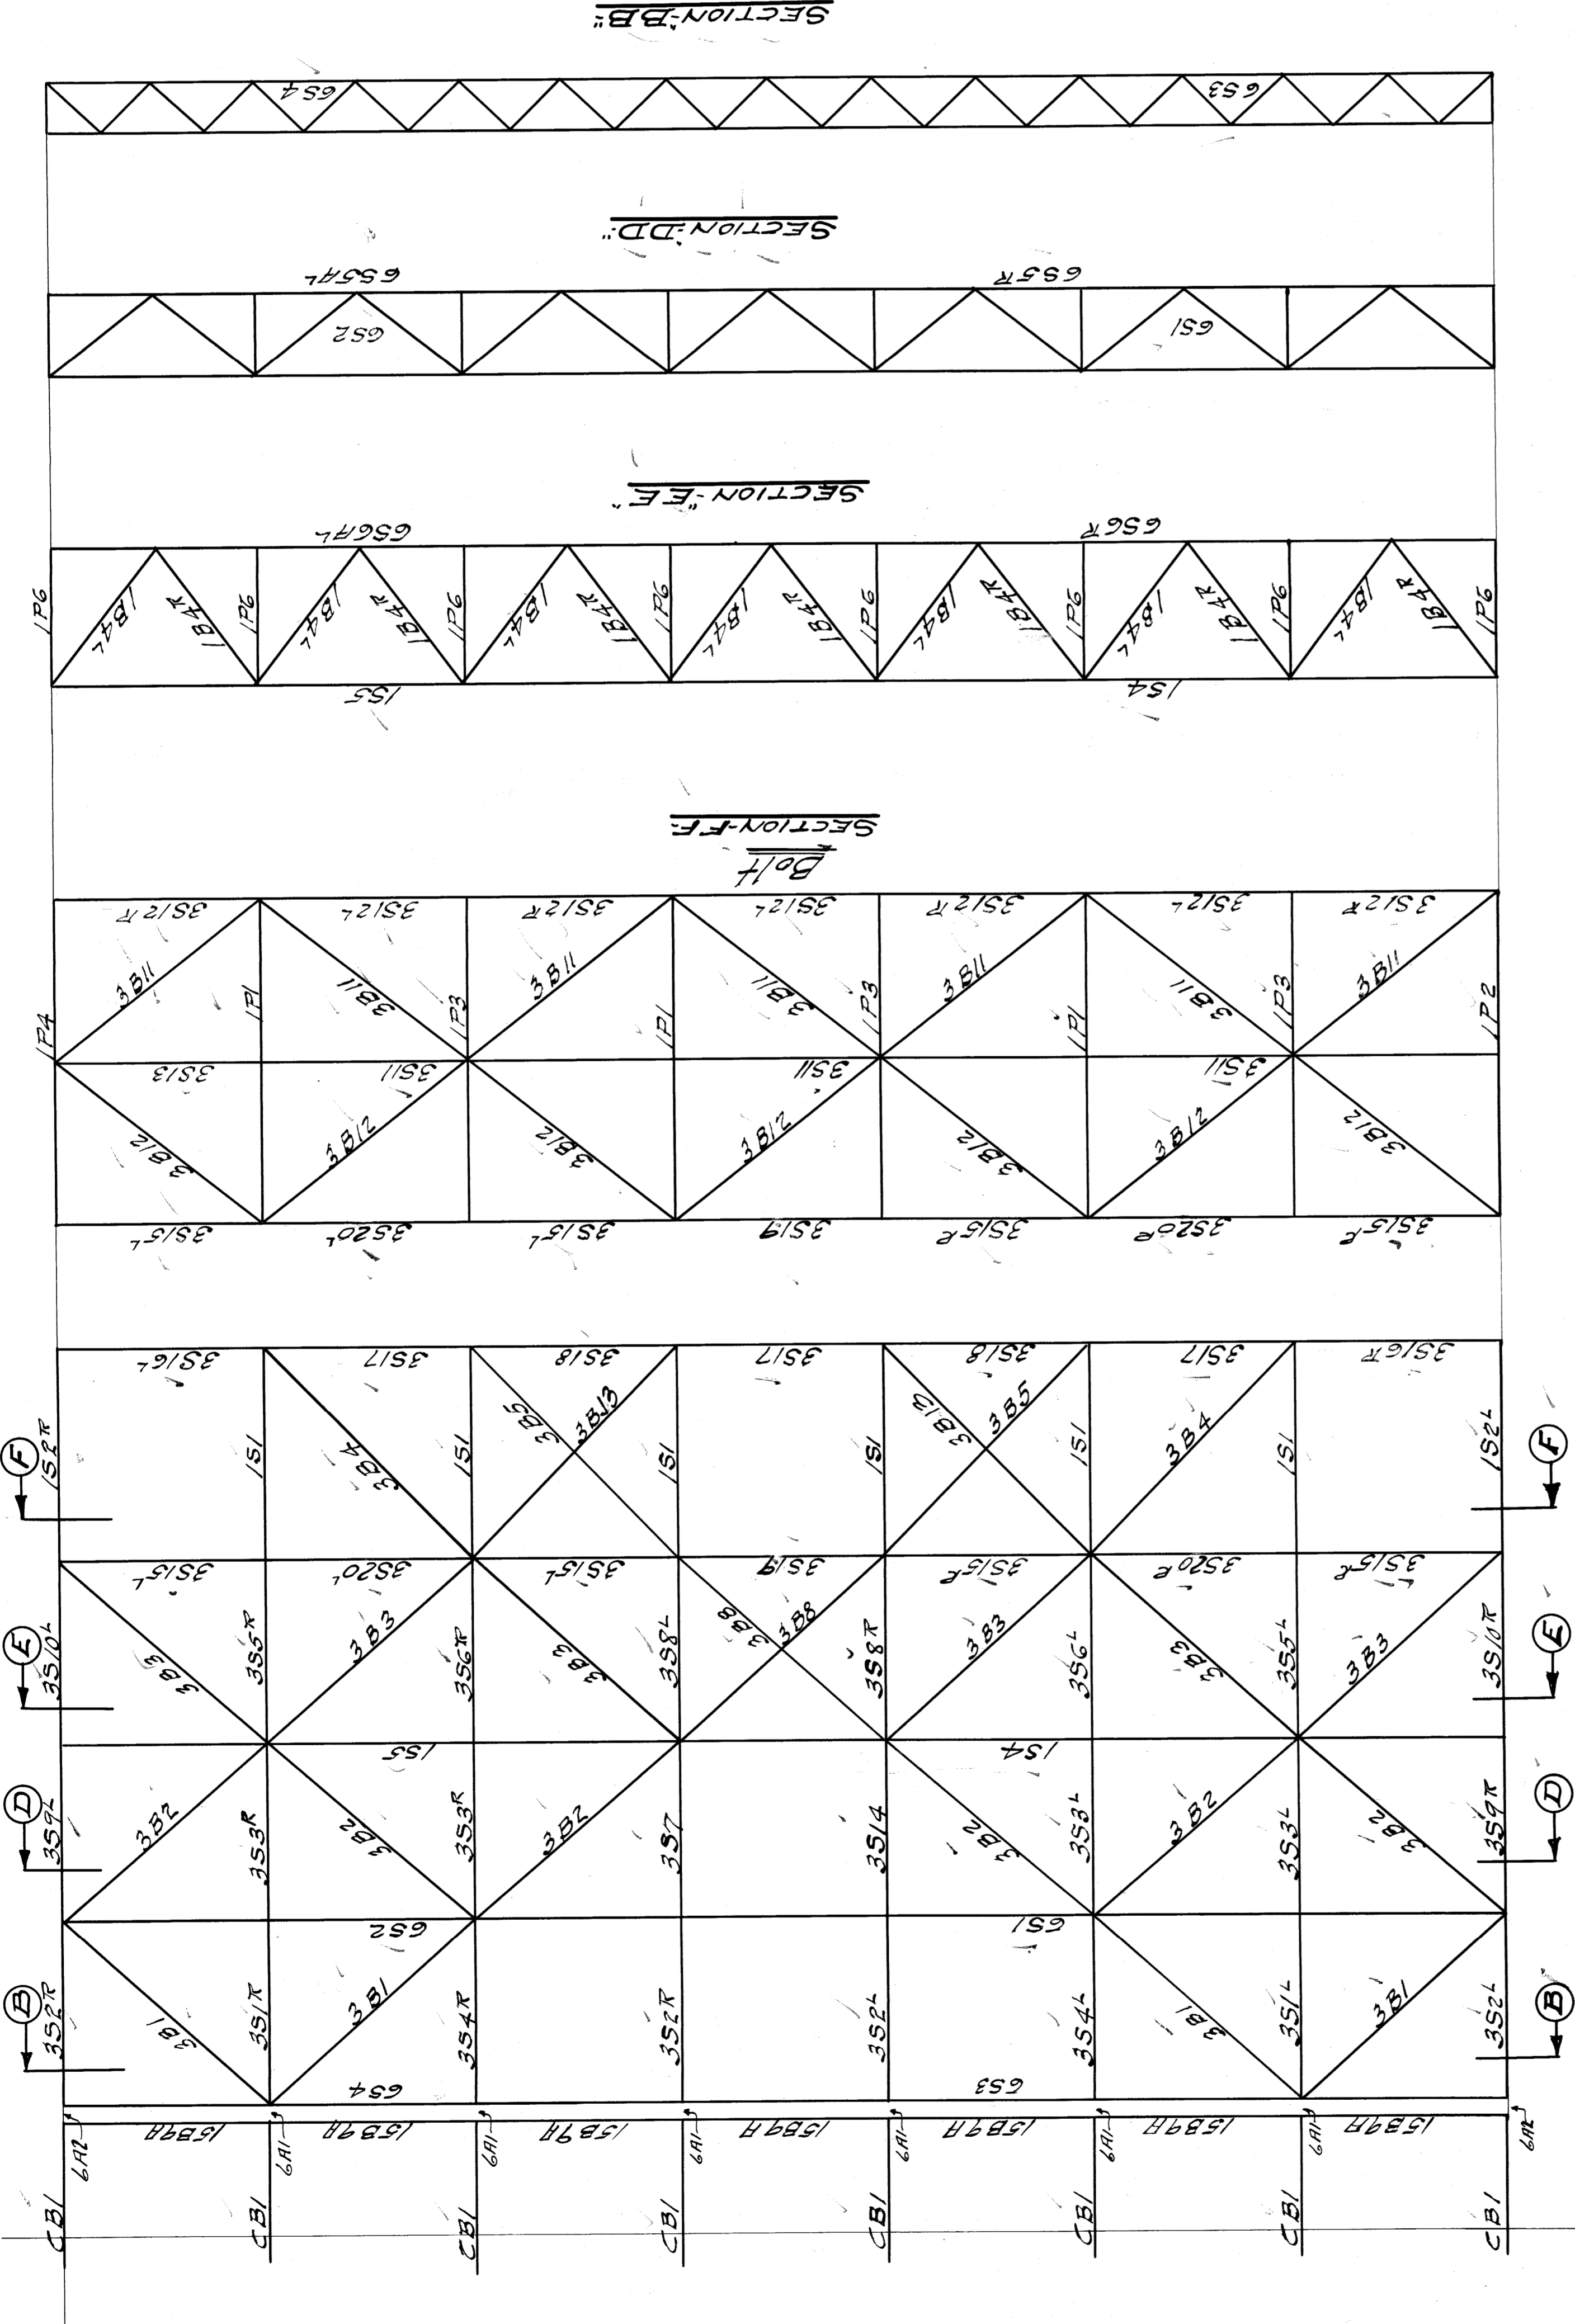

Bolt Top Lateral Bracing & Longitudinal Struts

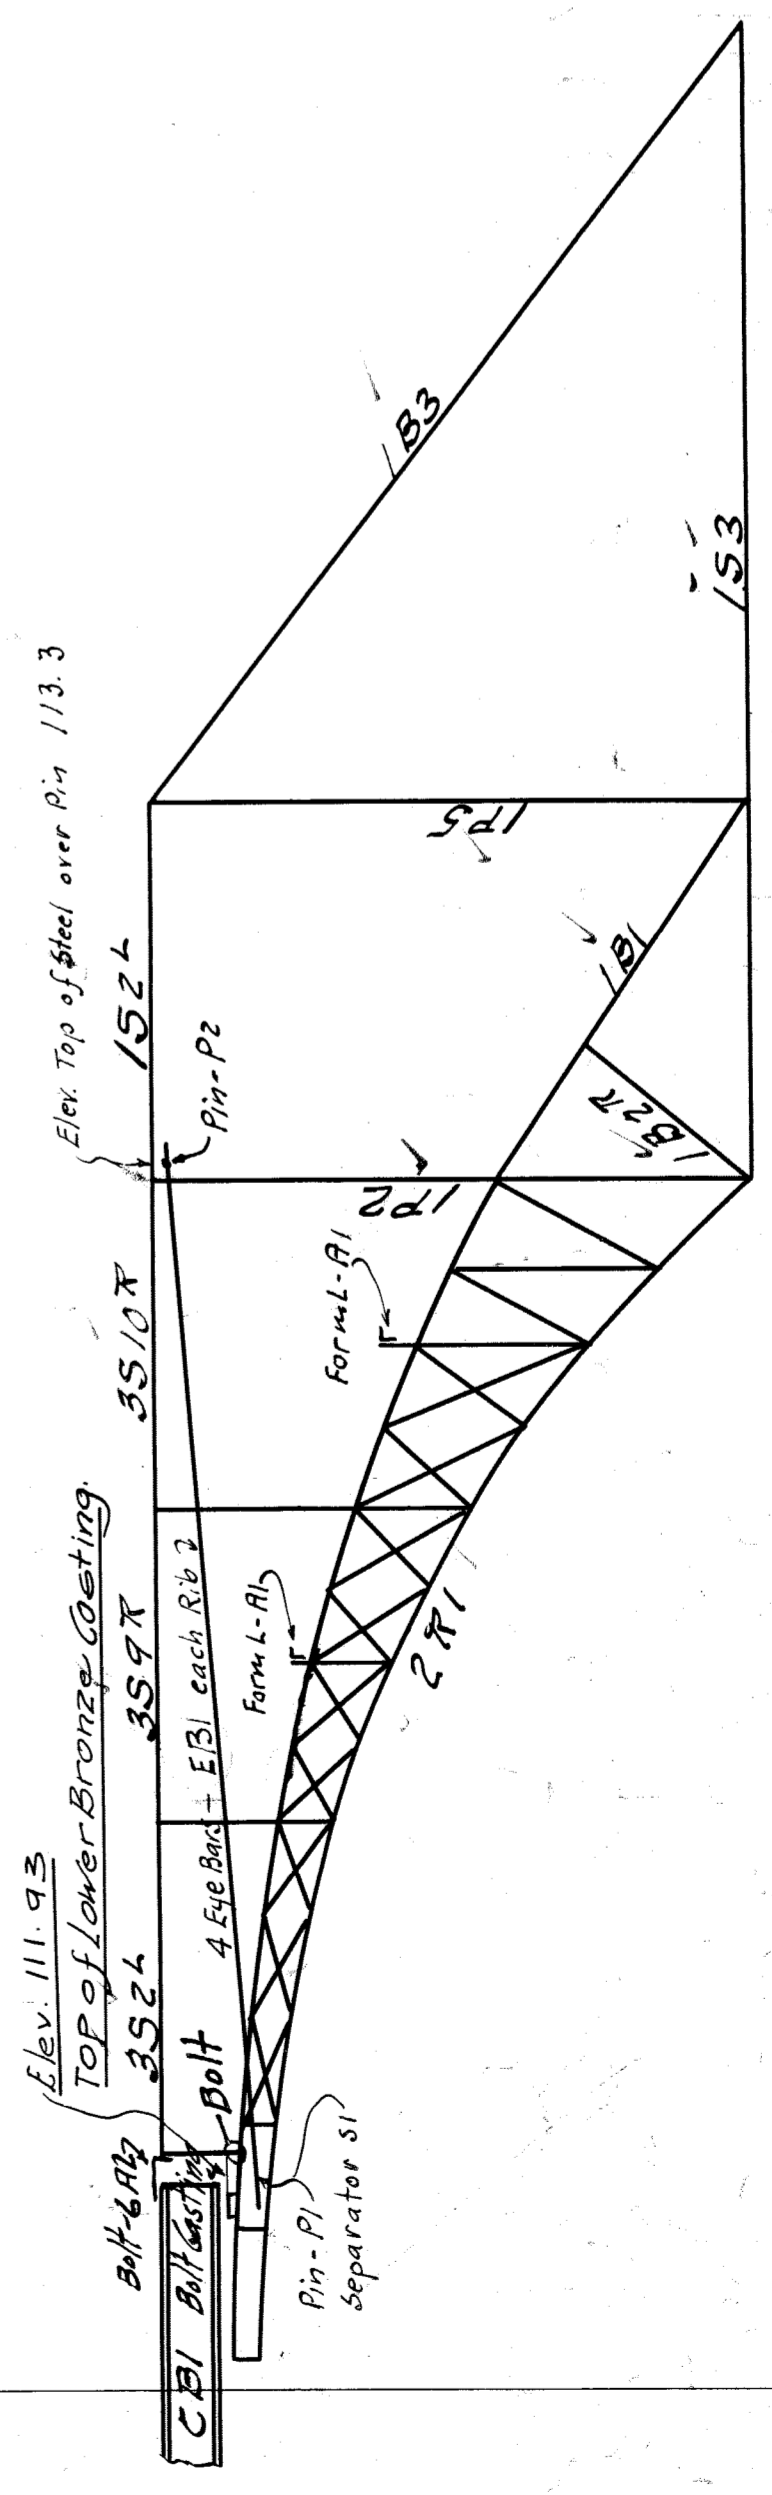


Form L-R1 - Detailed on Bill #305 - Contr #9377

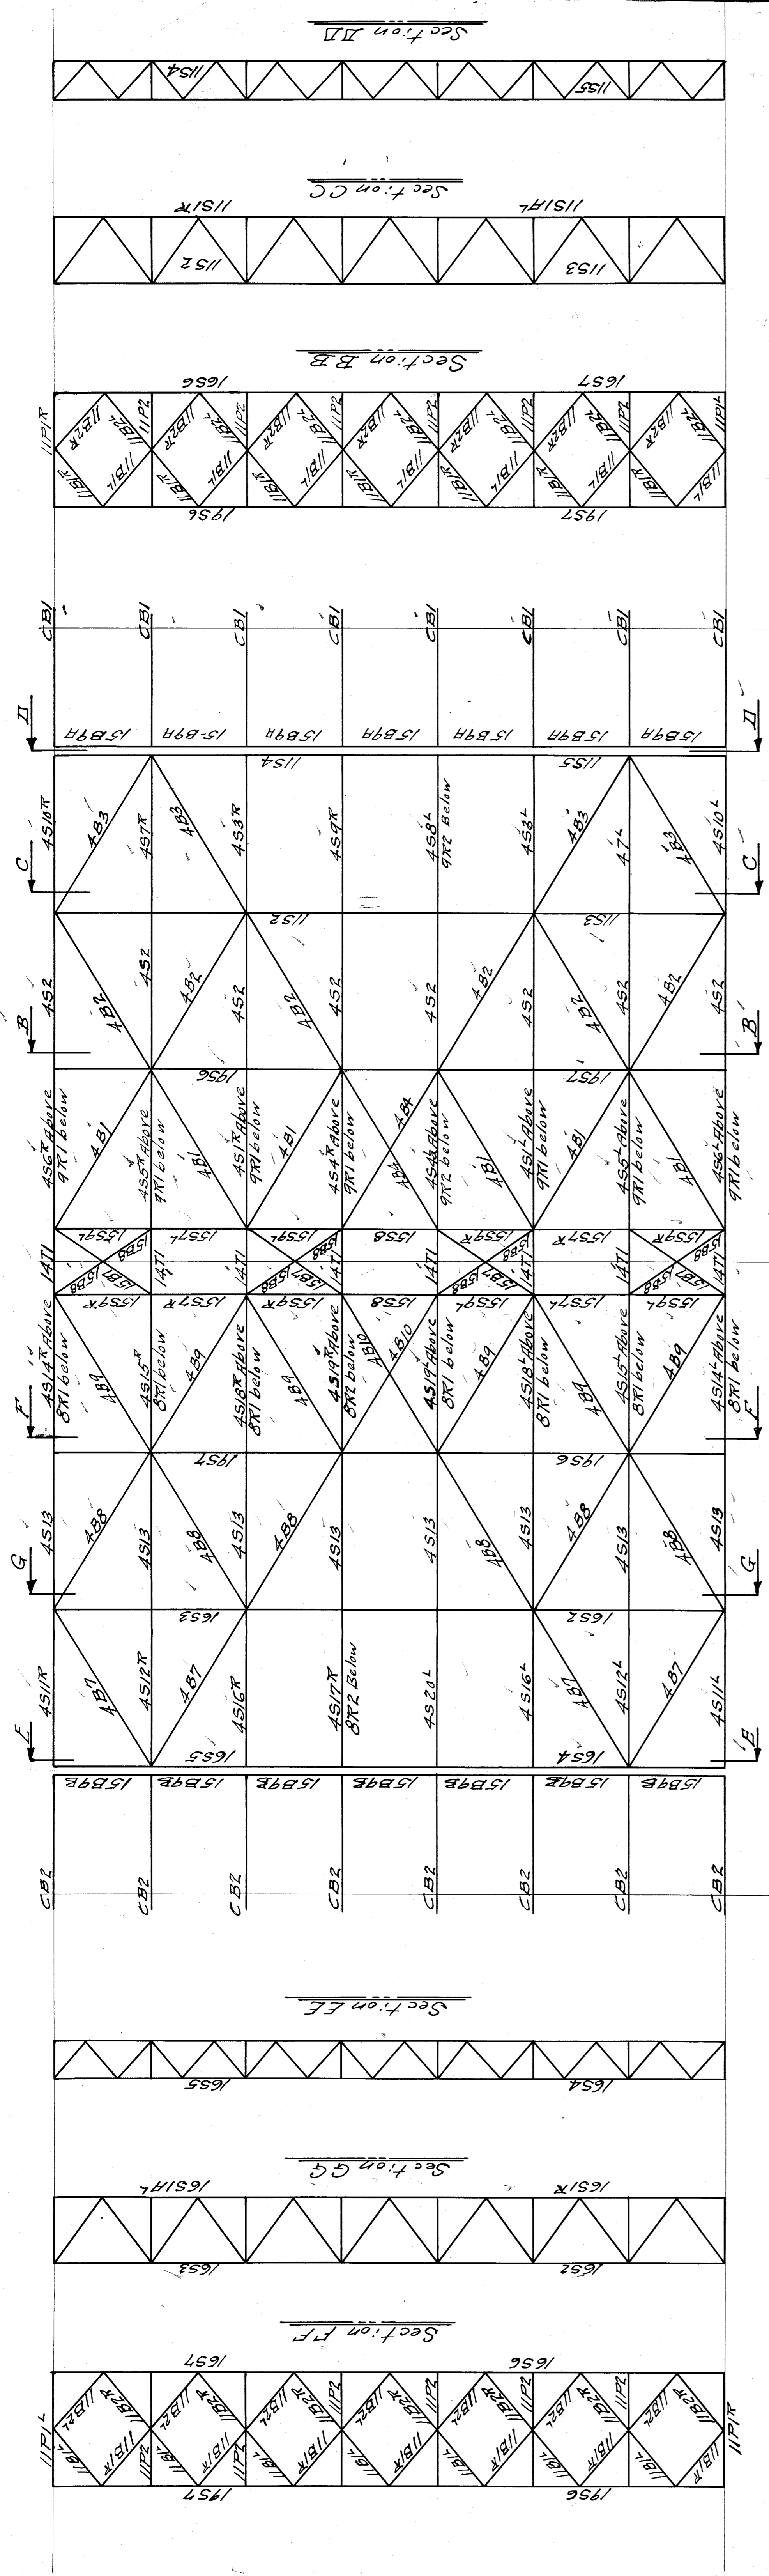


Built top Lateral Bracing & Longitudinal Struts

NOTE TO ERECTOR Link #s L-P were shipped in three different
 Mails, namely 14", 16" & 18". Care should
 be taken to assemble girders of same width
 one together as far as possible, keeping this distance
 to the top

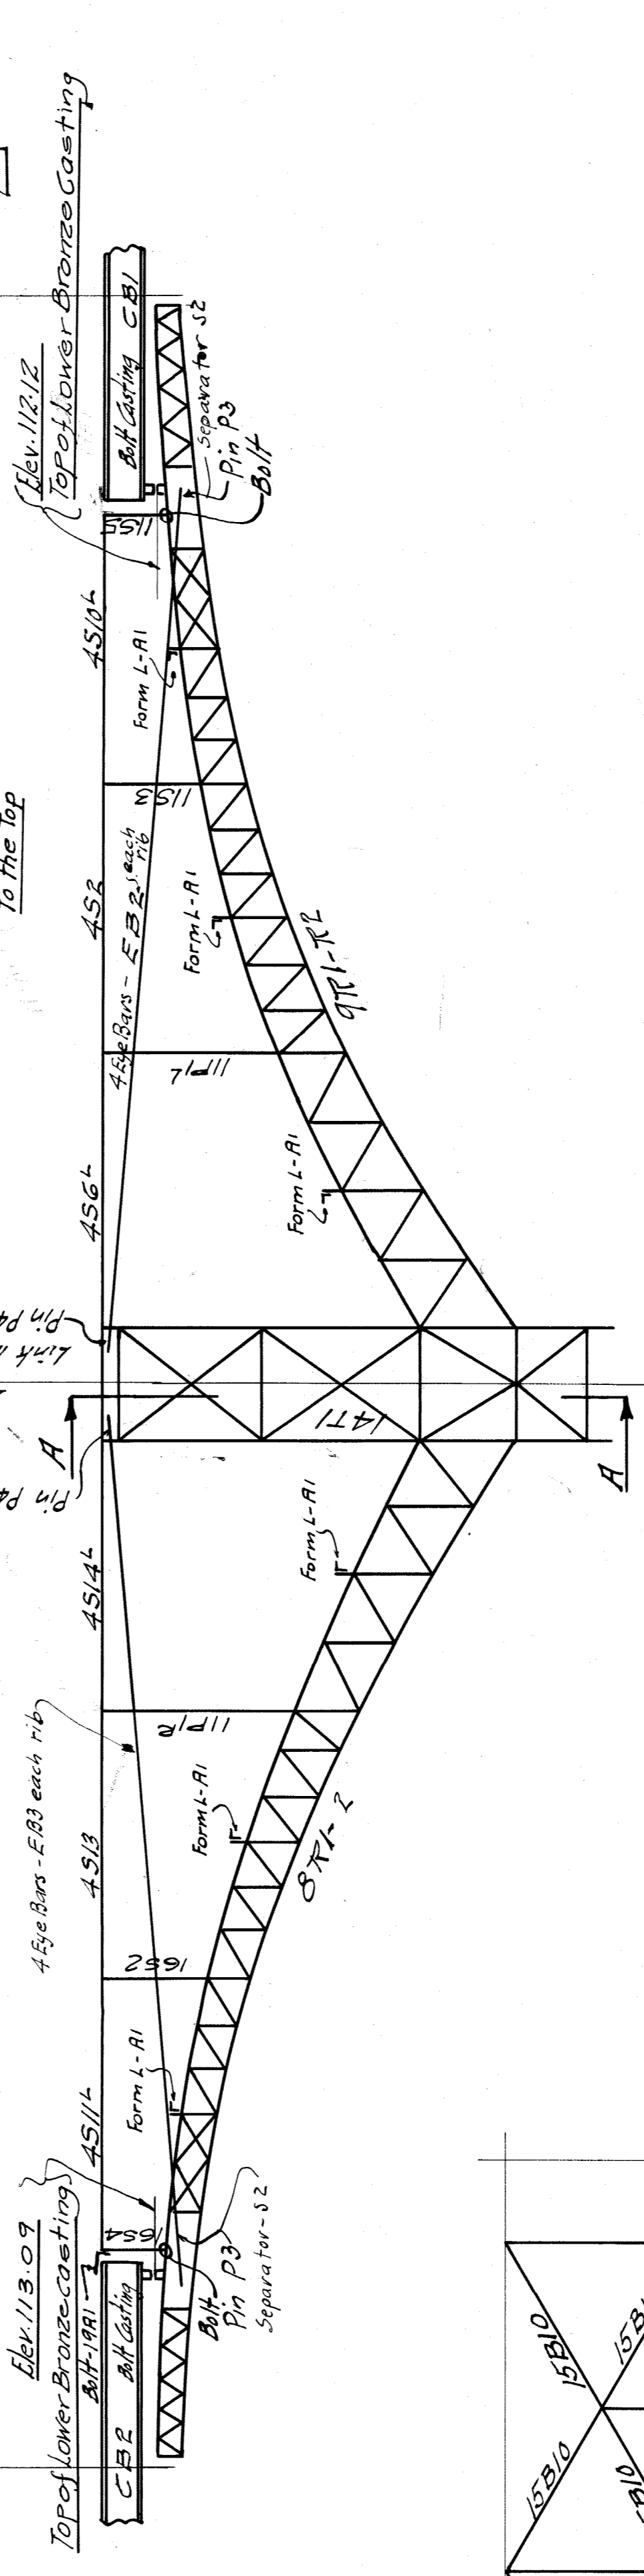

PIER #18
 Form L-R1 Detailed on Bill #305 - Cont #377

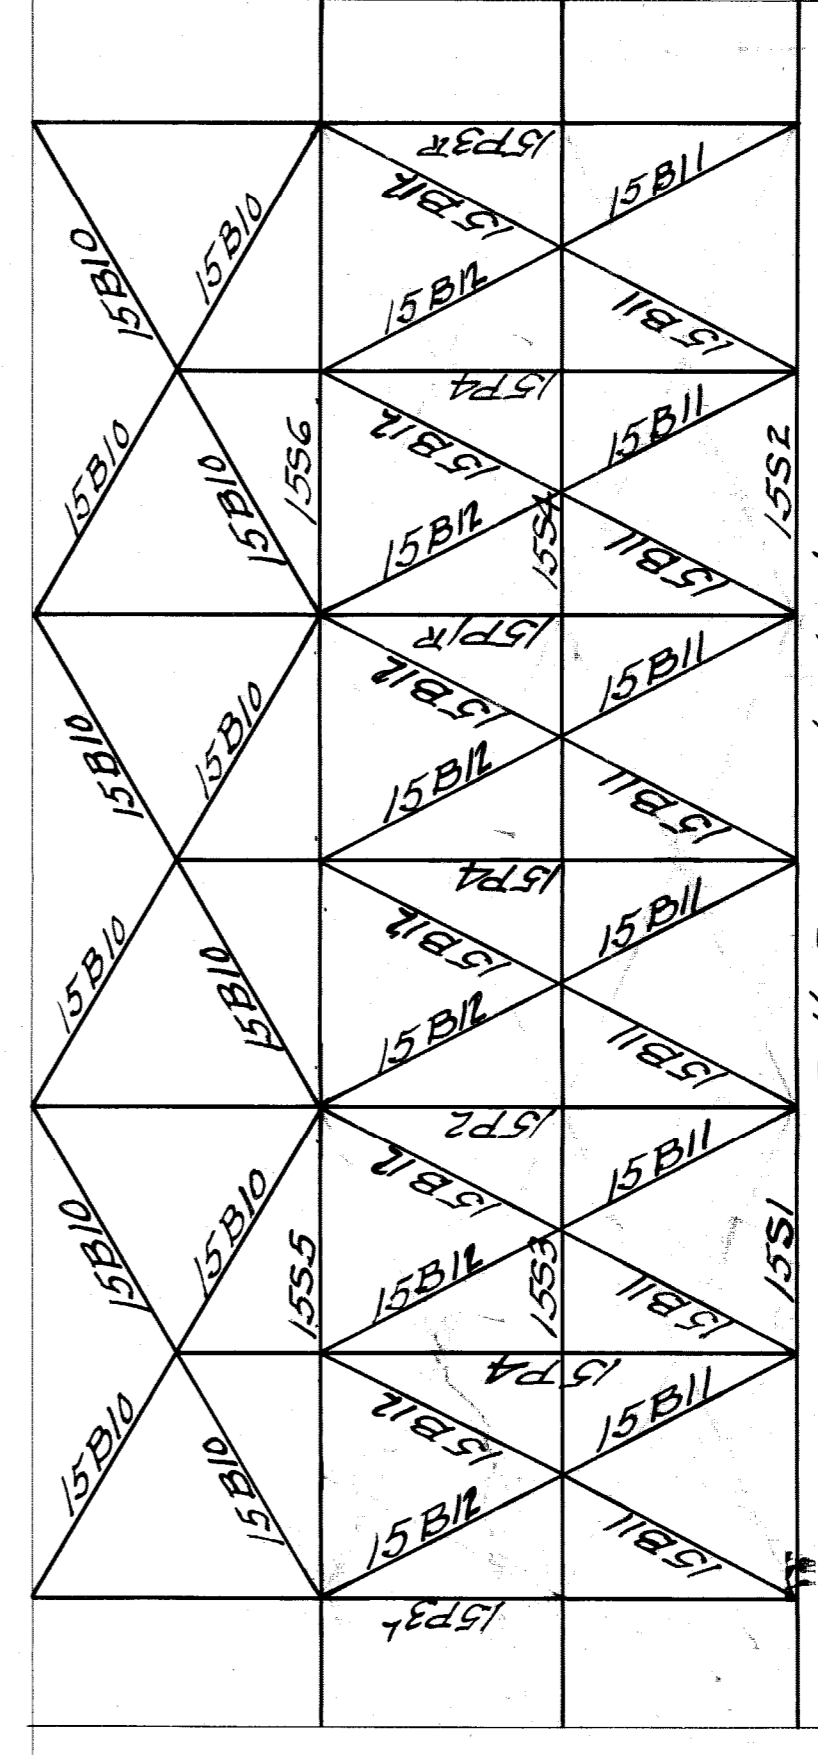

Bolt Bracing & Struts
 Bracing on Line of Pier
 Section AA

WISCONSIN BRIDGE & IRON CO.
 NORTH MILWAUKEE, WISCONSIN


CONTRACT NO. 9384
 ERECTED BY
 FOR City of Detroit
 LOCATION Belle Isle Bridge
 DESCRIPTION Belle Isle Bridge
 DETAILS OF Erection Pier #18
 SPECIFICATIONS REAMING
 INSPECTION BY
 SHOP PAINT
 FIELD PAINT

RIVETS OPEN HOLES EXCEPT AS NOTED
 MADE BY W. H. Peters DATE 7/2/21
 TRACED BY DATE
 CHECKED BY W. H. Peters DATE Mar 9, 21
 SCALE 8" = 16'

SECTION 10
 DATE REVISED 10/21/21
 SHEET NO. F2


9384

File BW201-245

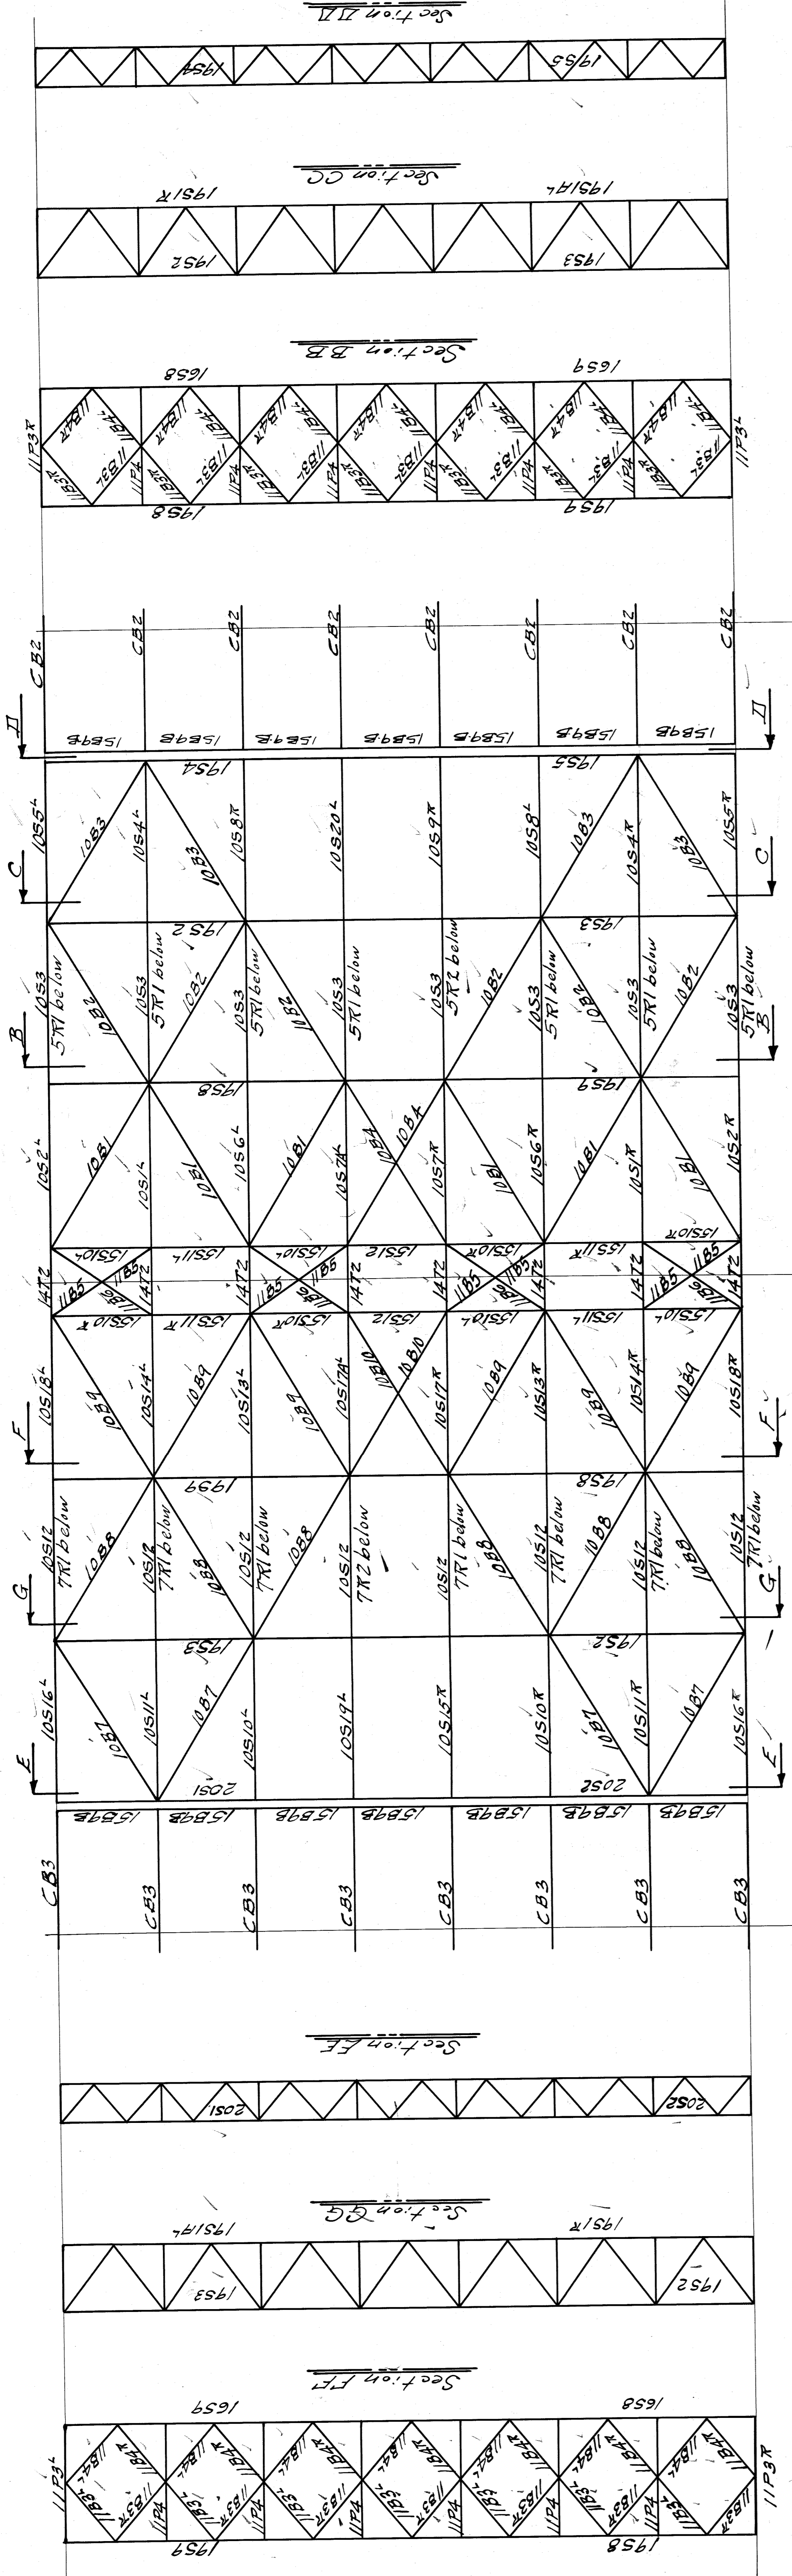


Bolt top Lateral Bracing & Longitudinal Struts

Note to Erector
 Link lbs. L P2 were shipped 18" wide instead of 16" wide. Care should be taken to assemble lbs with this distance to the top.

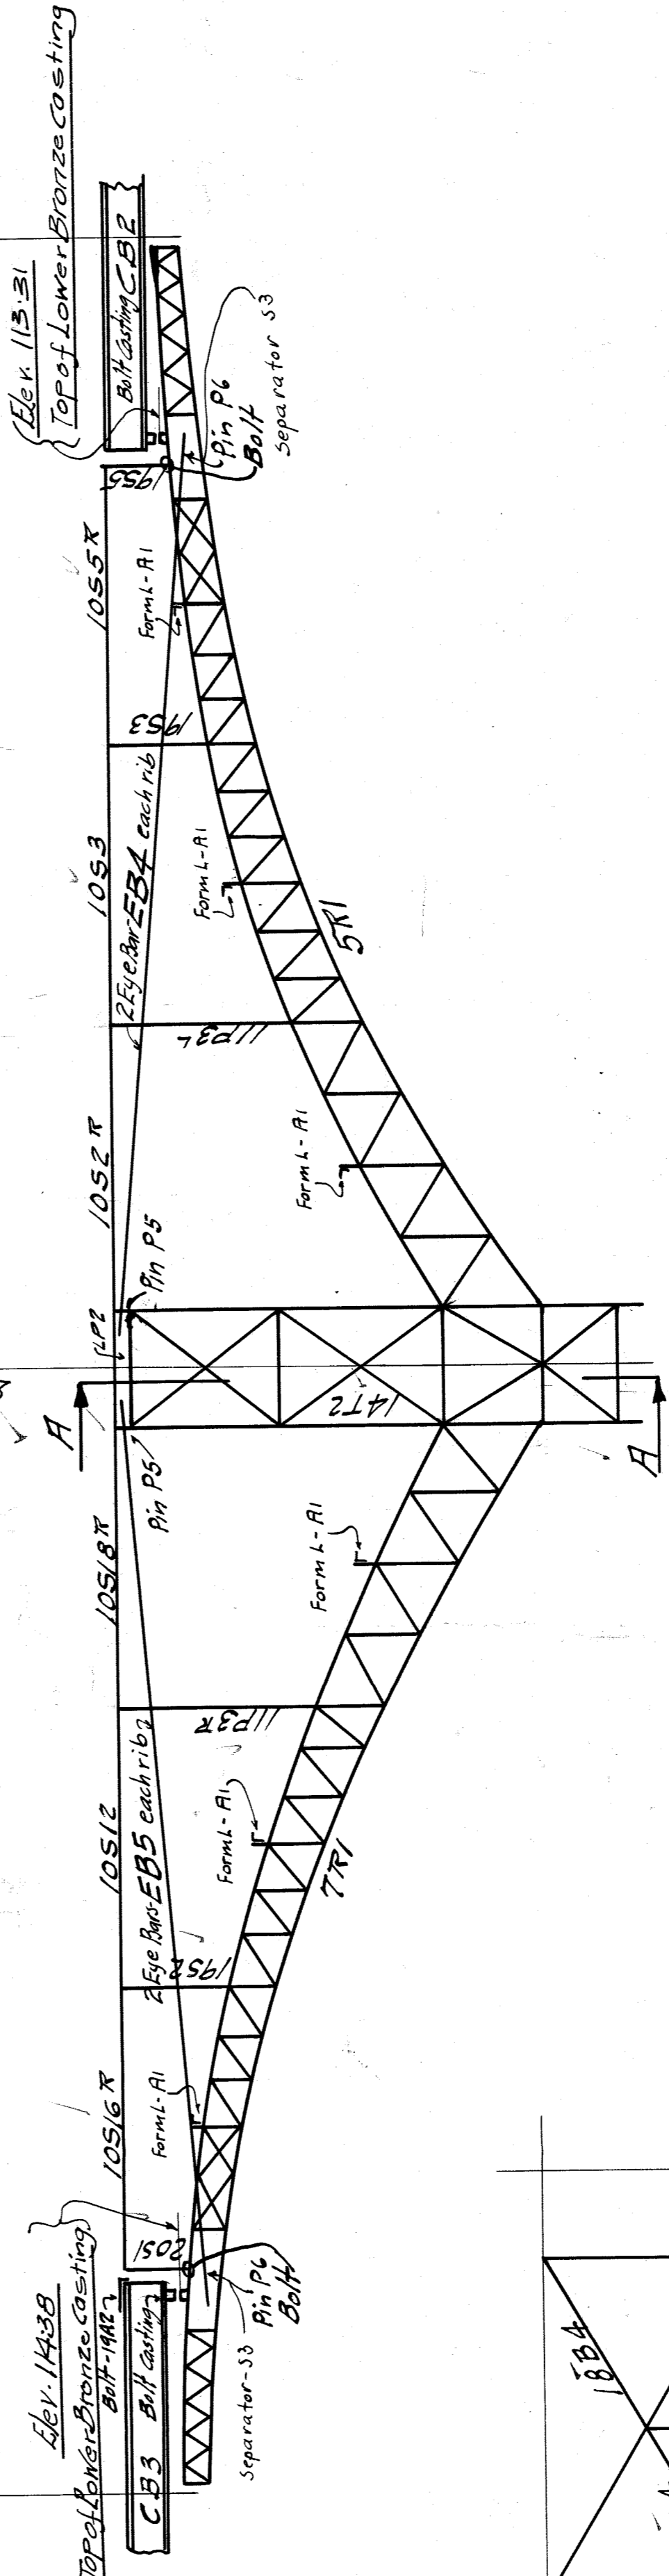

Pier #11

Form L-A1 - Detailed on Bill 305-Contr-9377


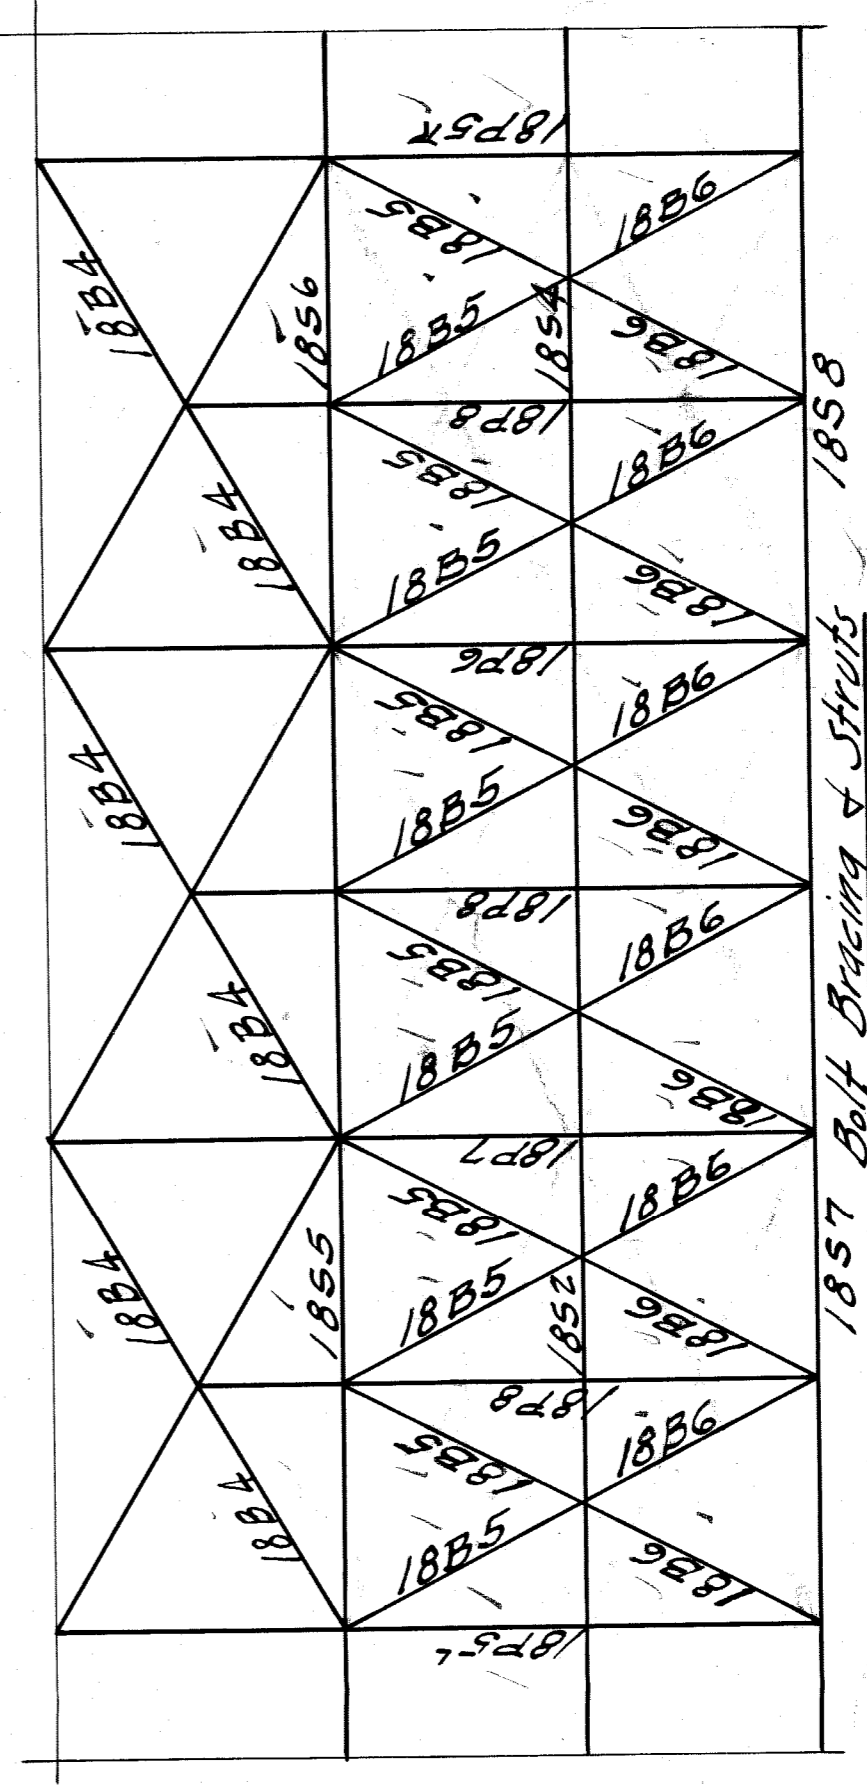


18B7 Bolt Bracing & Struts
 Bracing on Line of Pier
 Section AA

WISCONSIN BRIDGE & IRON CO.
 NORTH MILWAUKEE, WISCONSIN

CONTRACT NO. 7387
 ERCTED BY
 City of Detroit, Mich.
 LOCATION
 Belle Isle Bridge
 DESCRIPTION
 Execution Plan Part #17
 DETAILS OF REAMING
 INSPECTION BY
 SHOP PAINT
 FIELD PAINT
 RIVETS
 OPEN HOLES
 EXCEPT AS NOTED
 DATE 7-12-21
 MADE BY
 W. H. Peters
 DATE
 TRACED BY
 CHECKED BY
 DATE
 SCALE 8" = 1'-0"
 SHEET NO. 9384

File BW21-246

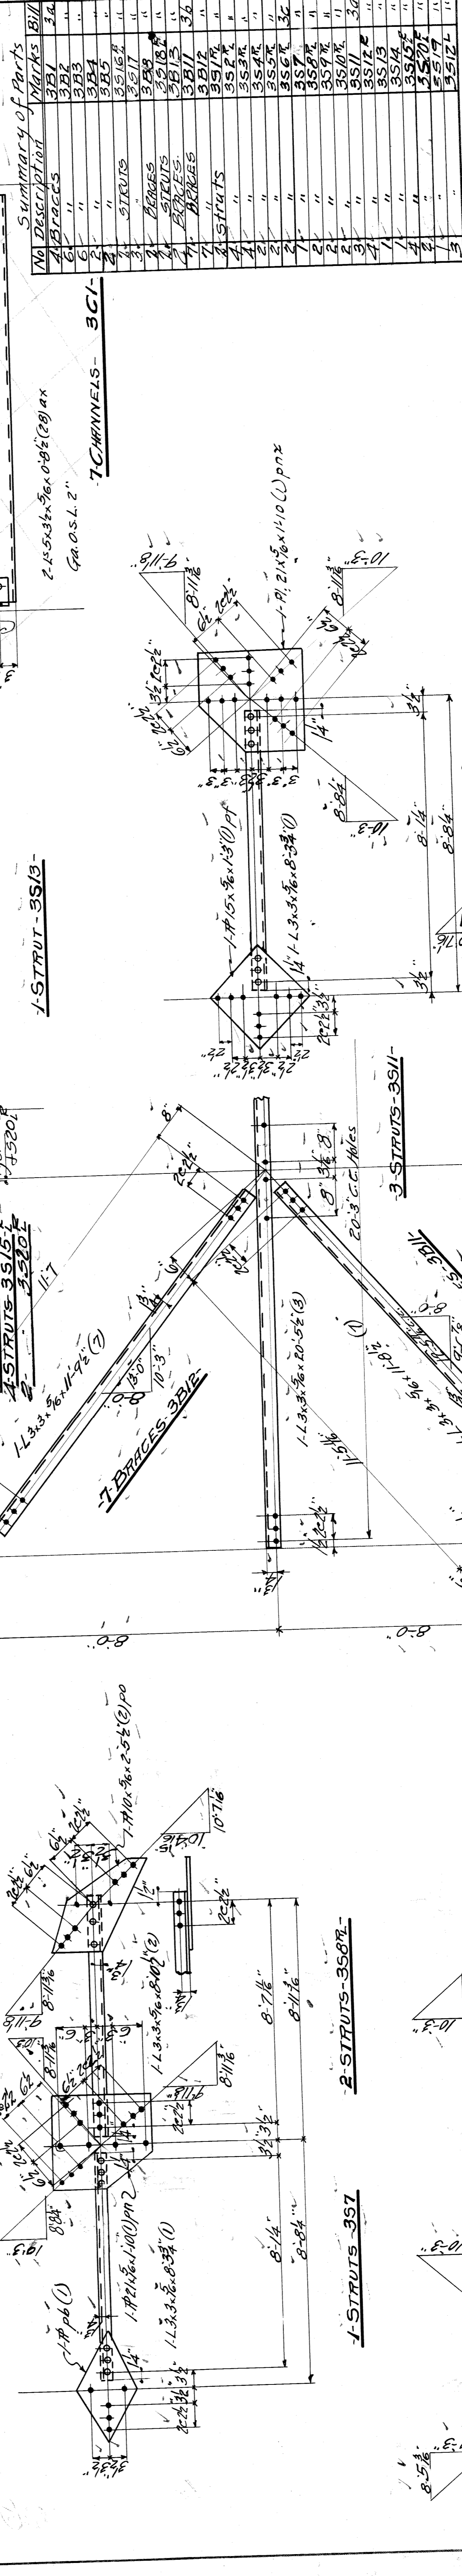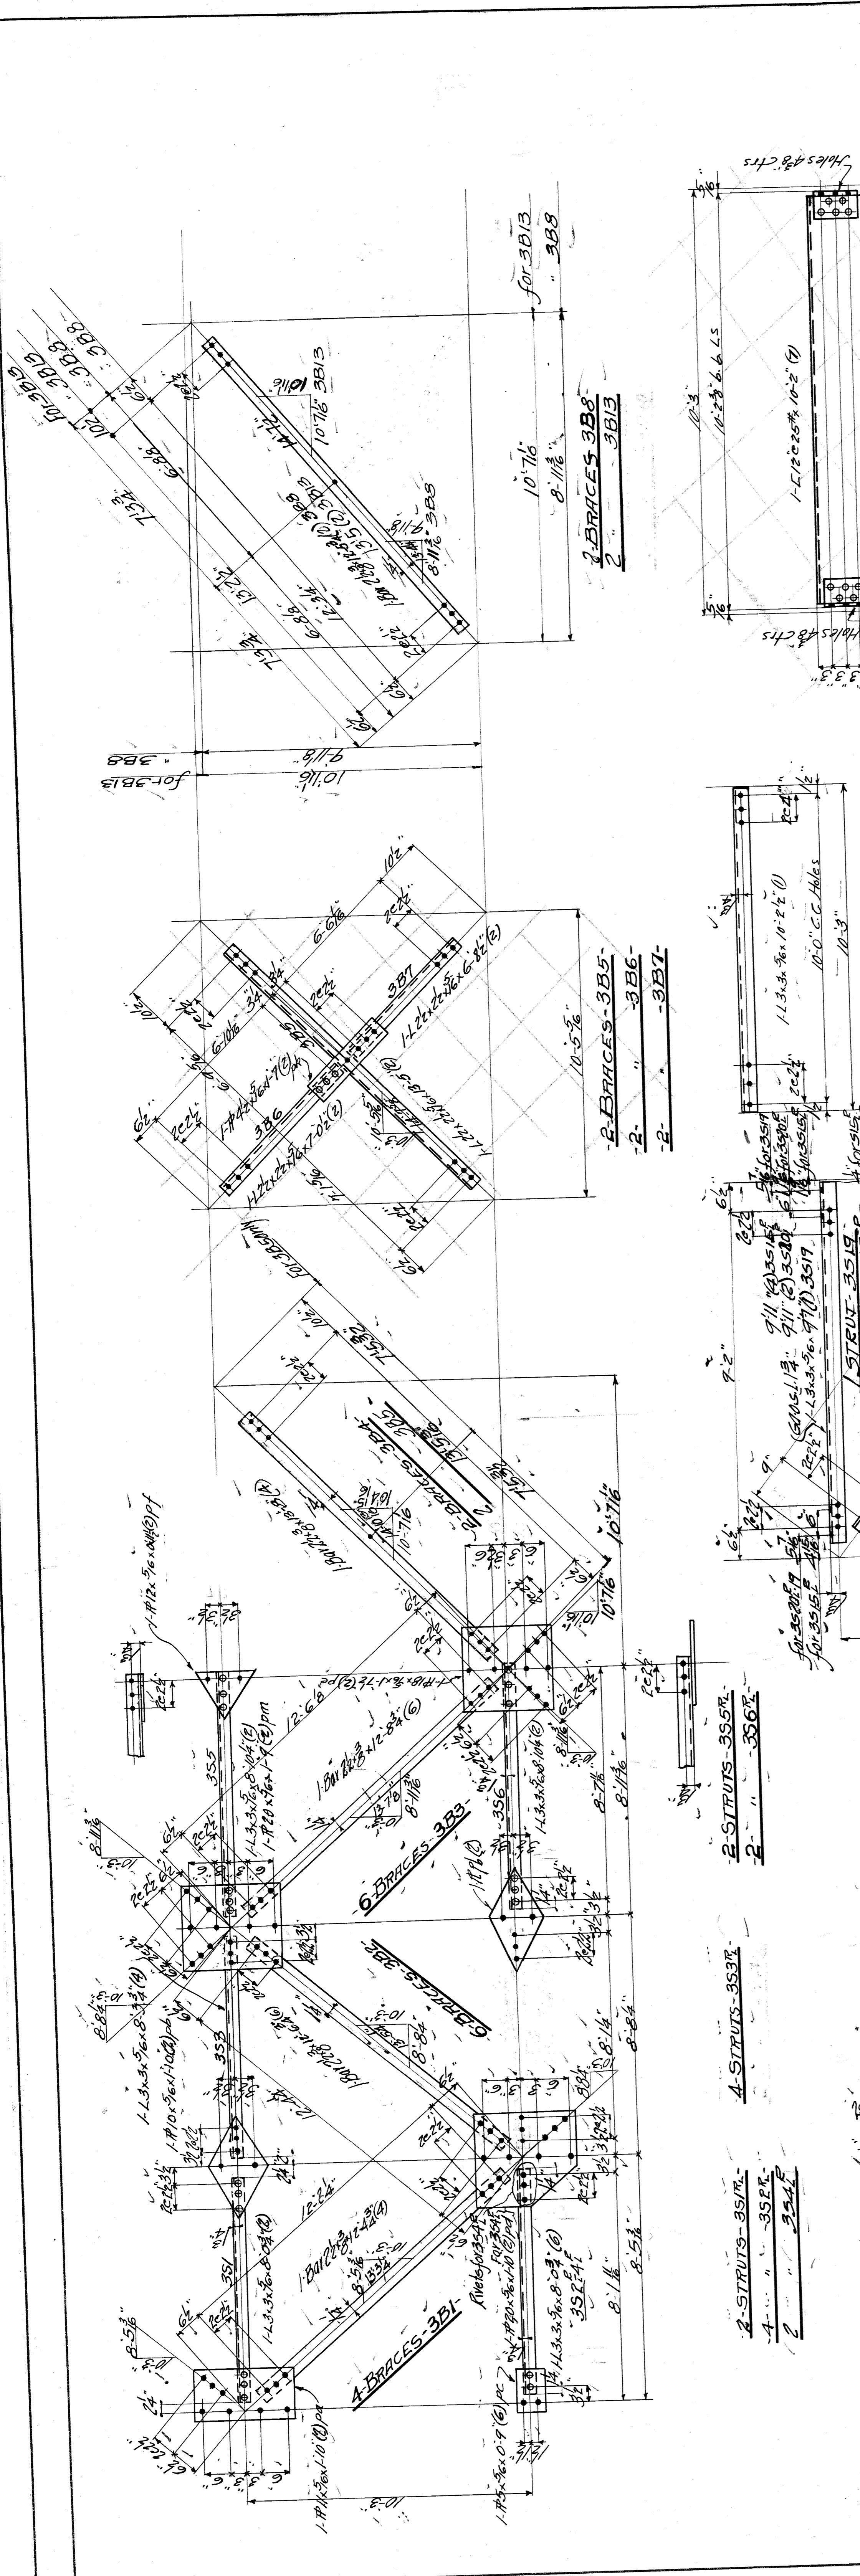

WISCONSIN BRIDGE & IRON CO.
NORTH MILWAUKEE, WISCONSIN

ERECTED BY
City of Detroit
DESCRIPTION **Belle Isle Bridge** (Piers 19)

CONTRACT NO. 9384
LOCATION **Detroit Mich**

DETAILS OF SPECIFICATIONS **See by Murphy, Reaming Name**

INSPECTION BY **None** (See Specification)

SHOP PAINT **None**

FIELD PAINT **OPEN HOLES**

RIVETS **A** EXCEPT AS NOTED

MADE BY **Aemke** DATE 7-9-21

TRACED BY **Morrison** DATE 7-9-21

CHECKED BY **Morrison** DATE 7-9-21

SCALE 3/4" = 1'-0"

SECTION **1**

DATE REVISED


SHEET NO. **3**

9384

File **BW201-250**

Summary of Parts

No	Description	Quantity	Remarks
1	BRACES	34	
2	"	34	
3	"	34	
4	"	34	
5	"	34	
6	"	34	
7	"	34	
8	"	34	
9	"	34	
10	"	34	
11	"	34	
12	"	34	
13	"	34	
14	"	34	
15	"	34	
16	"	34	
17	"	34	
18	"	34	
19	"	34	
20	"	34	
21	"	34	
22	"	34	
23	"	34	
24	"	34	
25	"	34	
26	"	34	
27	"	34	
28	"	34	
29	"	34	
30	"	34	
31	"	34	
32	"	34	
33	"	34	
34	"	34	

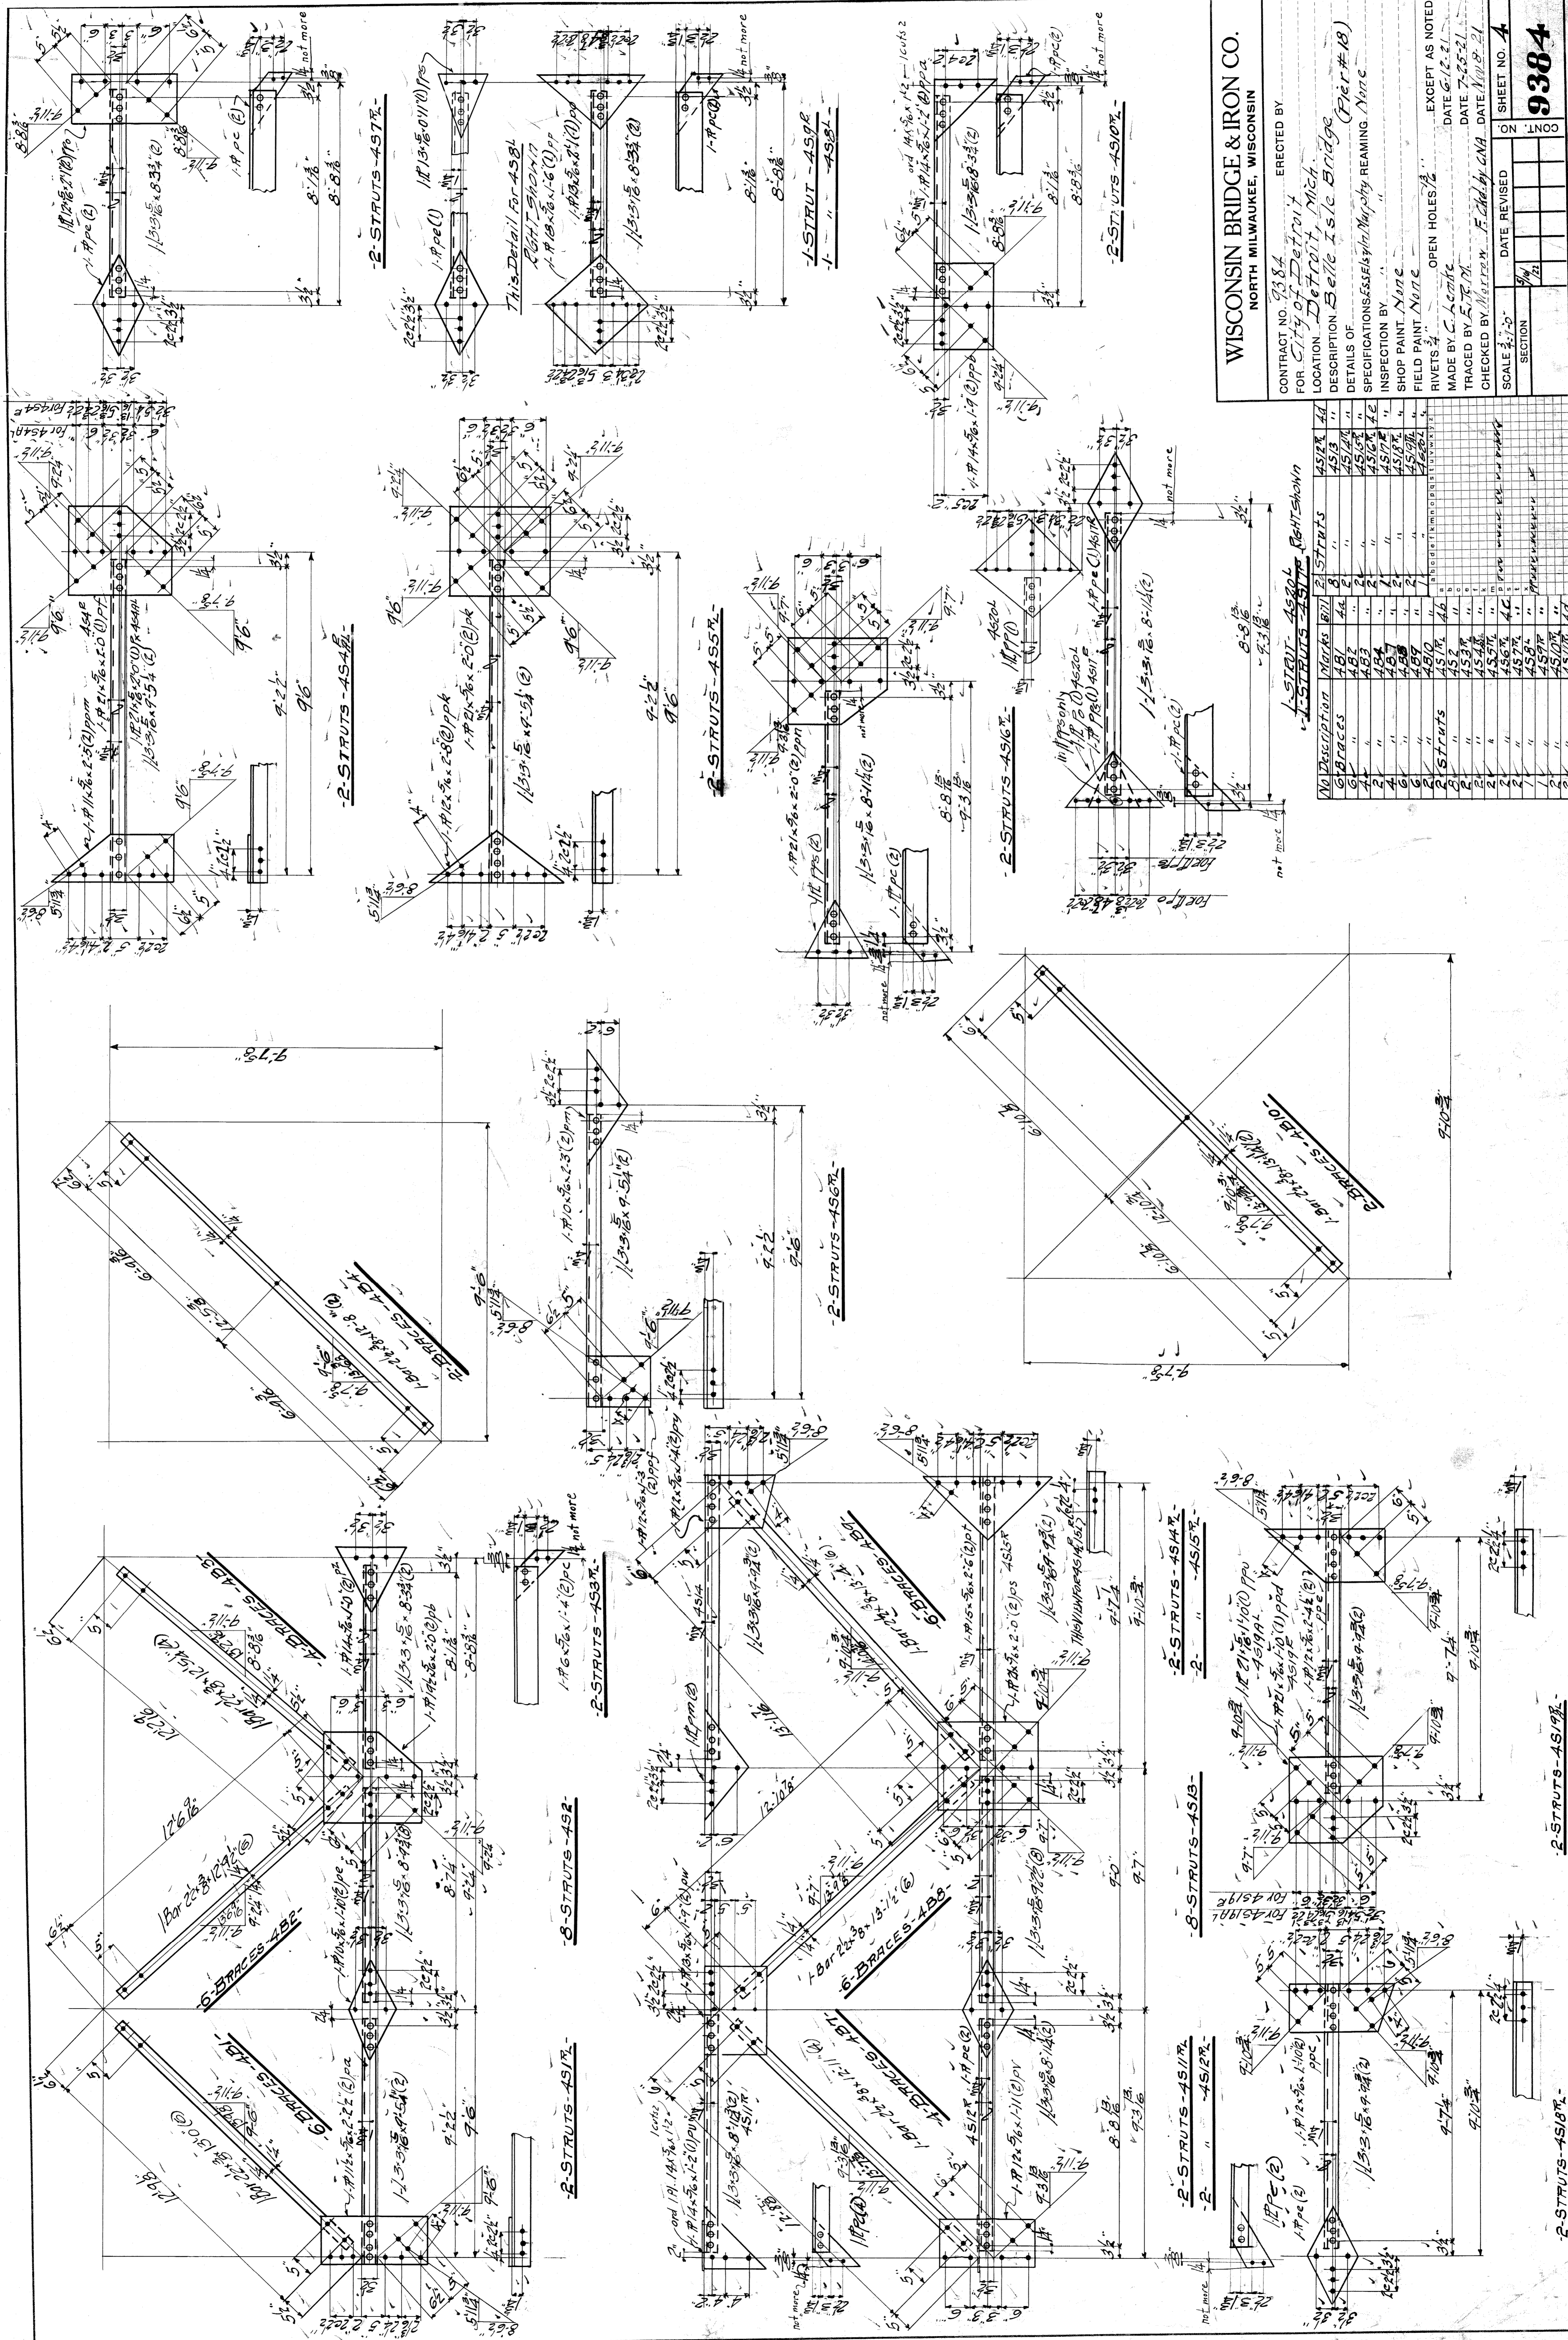

WISCONSIN BRIDGE & IRON CO.
 NORTH MILWAUKEE, WISCONSIN

ERECTED BY
 CONTRACT NO. 9384
 FOR City of Detroit
 LOCATION Belle Isle Bridge (Pier #18)
 DETAILS OF SPECIFICATIONS ESSEX Iron Works (Pier #18)
 INSPECTION BY
 SHOP PAINT None
 FIELD PAINT None
 RIVETS 4 OPEN HOLES 1/2"


EXCEPT AS NOTED
 MADE BY C. Lamb
 DATE 7-25-21
 TRACED BY E. J. M.
 CHECKED BY H. J. M.
 F. G. G. by CNA DATE 10-8-21

DATE REVISION
 SCALE 3/4" = 1'-0"
 SECTION

SHEET NO. 4
 9384

File B Weol-257

No	Description	Quantity	Unit	Remarks
1	2-STRUTS-AS17	2	pc	
2	2-STRUTS-AS18	2	pc	
3	2-STRUTS-AS19	2	pc	
84	2-STRUTS-AS100	2	pc	

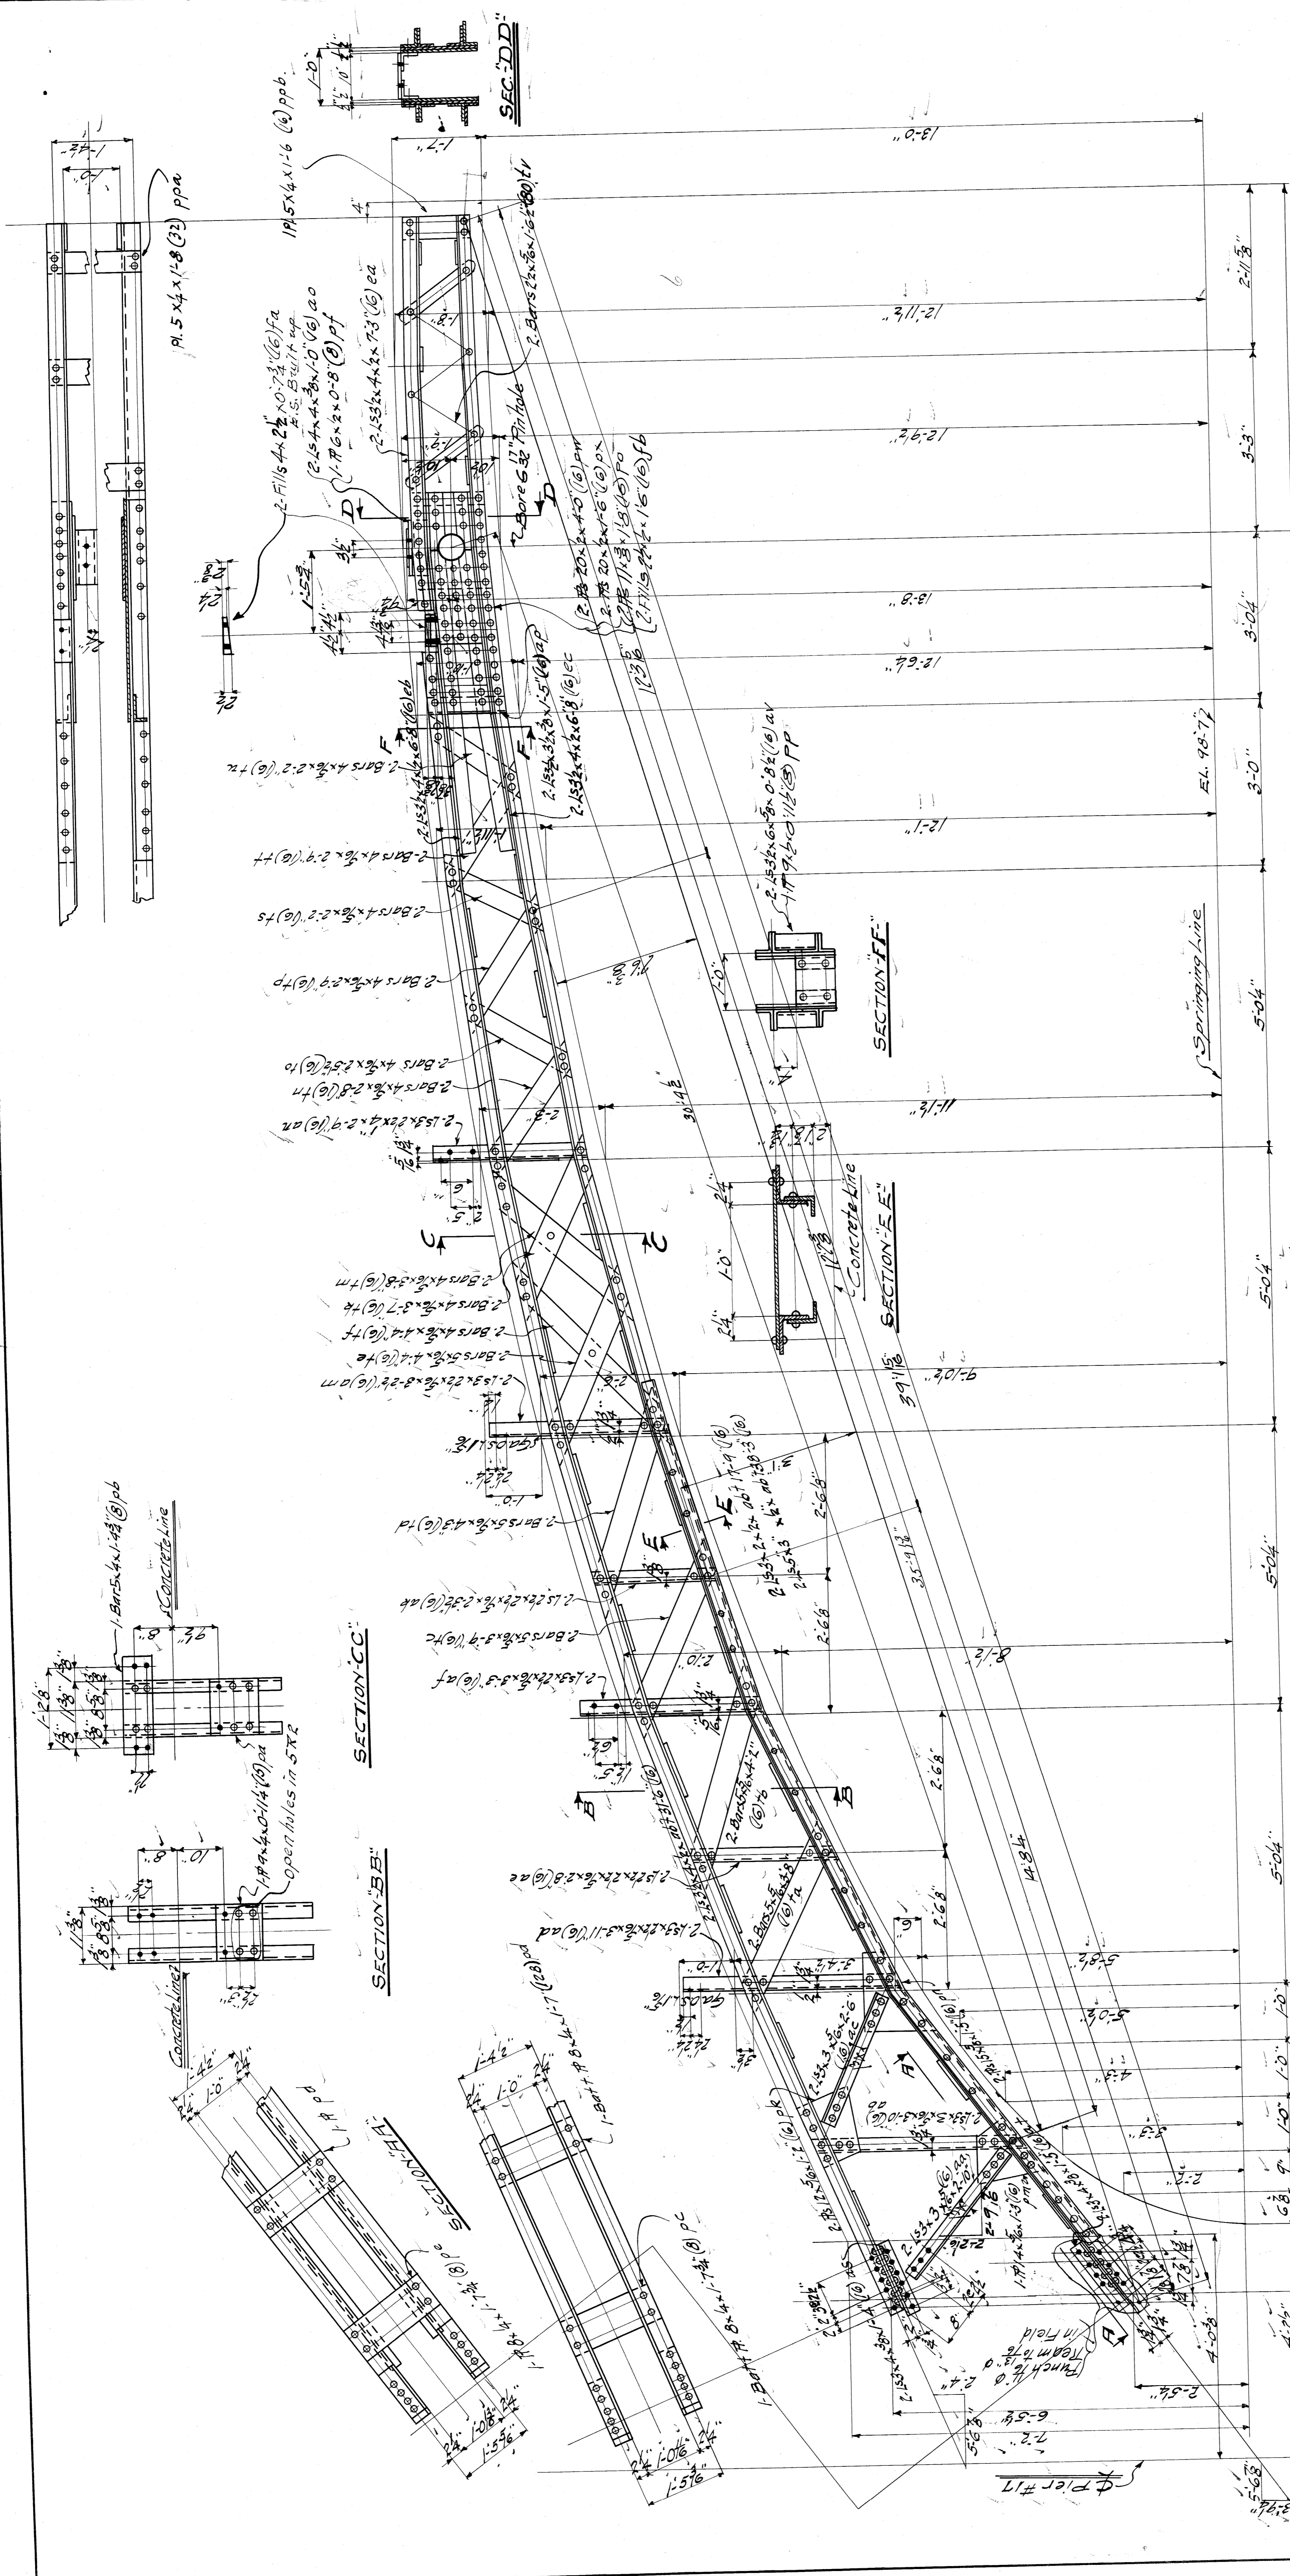

WISCONSIN BRIDGE & IRON CO.
 NORTH MILWAUKEE, WISCONSIN

ERECTED BY:
 CONTRACT NO. 19384
 FOR City of Detroit
 LOCATION Detroit, Mich.
 DESCRIPTION Belle Isle Bridge Pier #17 Right Arm
 DETAILS OF REINFORCEMENT See Notes
 INSPECTION BY: (See Specifications)
 SHOP PAINT NAME: (See Specifications)
 FIELD PAINT NAME: (See Specifications)
 RIVETS 4 OPEN HOLES 1/8"
 MADE BY C. N. A. & Co. DATE 7-9-21
 TRACED BY E. J. M. DATE 8-2-21
 CHECKED BY W. J. M. DATE 8-2-21
 F. C. M. by C. M. D. DATE 8-2-21

EXCEPT AS NOTED

SCALE: 1" = 6'-0"

DATE REVISION: 1/1/21


SHEET NO. 5

9384

File BW201-252

FRASER-SEB-
 7-20-21-571


1	1/1/21	1/1/21	1/1/21	1/1/21
2	1/1/21	1/1/21	1/1/21	1/1/21
3	1/1/21	1/1/21	1/1/21	1/1/21
4	1/1/21	1/1/21	1/1/21	1/1/21
5	1/1/21	1/1/21	1/1/21	1/1/21
6	1/1/21	1/1/21	1/1/21	1/1/21
7	1/1/21	1/1/21	1/1/21	1/1/21
8	1/1/21	1/1/21	1/1/21	1/1/21
9	1/1/21	1/1/21	1/1/21	1/1/21
10	1/1/21	1/1/21	1/1/21	1/1/21

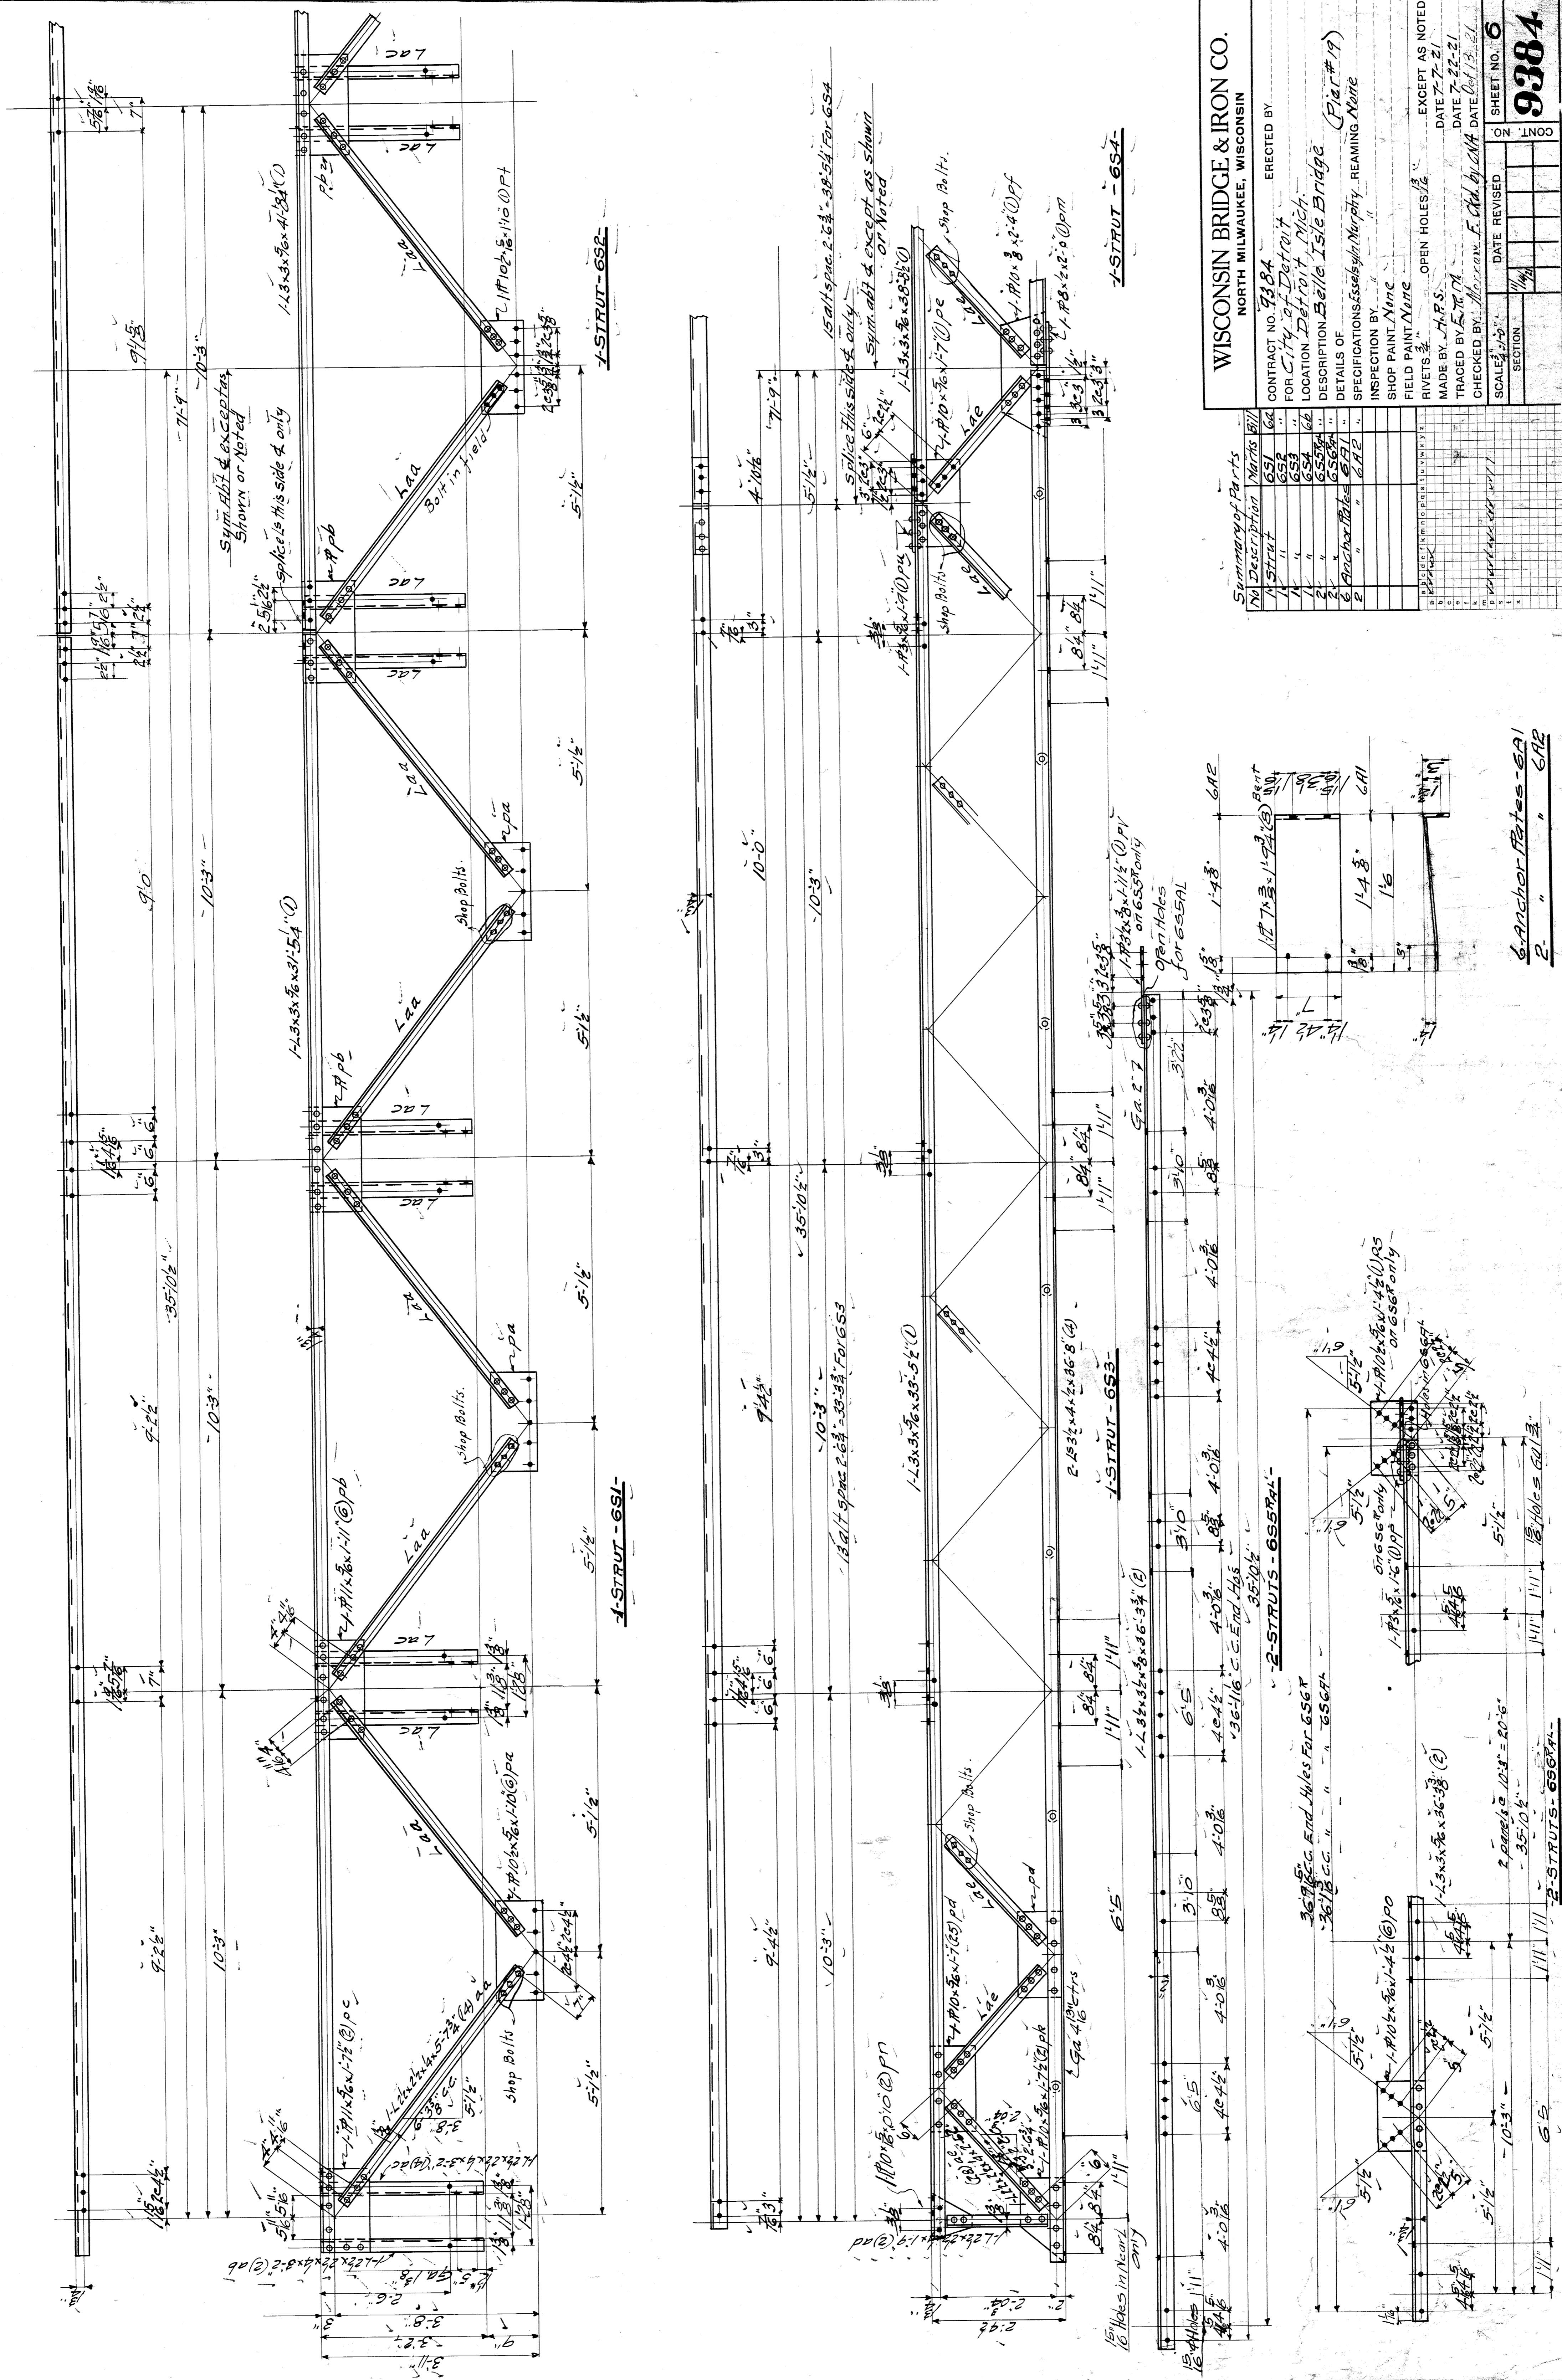

WISCONSIN BRIDGE & IRON CO.		NORTH MILWAUKEE, WISCONSIN	
CONTRACT NO. 9384		ERECTED BY	
FOR City of Detroit		City of Detroit	
LOCATION Belle Isle Bridge		Pier #19	
DETAILS OF		SPECIFICATIONS Issued by Murphy, Reaming, Neve	
INSPECTION BY		SHOP PAINT NAME	
RIVETS 3/4"		OPEN HOLES 1/2"	
MADE BY J.P.S.		DATE 7-22-21	
TRACED BY F.M.R.		DATE 7-22-21	
CHECKED BY Morrison, F. Ch. by G.M.A.		DATE Oct 13, 21	
SCALE 1/4" = 1'-0"	DATE REVISION	SHEET NO. 6	9384
SECTION			

Summary of Parts	Qty	Description	Notes
1	1	1-STRUT	
2	2	Anchor Bolts	
3	2	Shop Bolts	
4	2	1/2" x 1/2" x 1/2" (3) 1/2"	
5	2	1/2" x 1/2" x 1/2" (3) 1/2"	
6	2	1/2" x 1/2" x 1/2" (3) 1/2"	
100	2	1/2" x 1/2" x 1/2" (3) 1/2"	

6 Anchor Bolts - 6A1
2 " " " 6A2

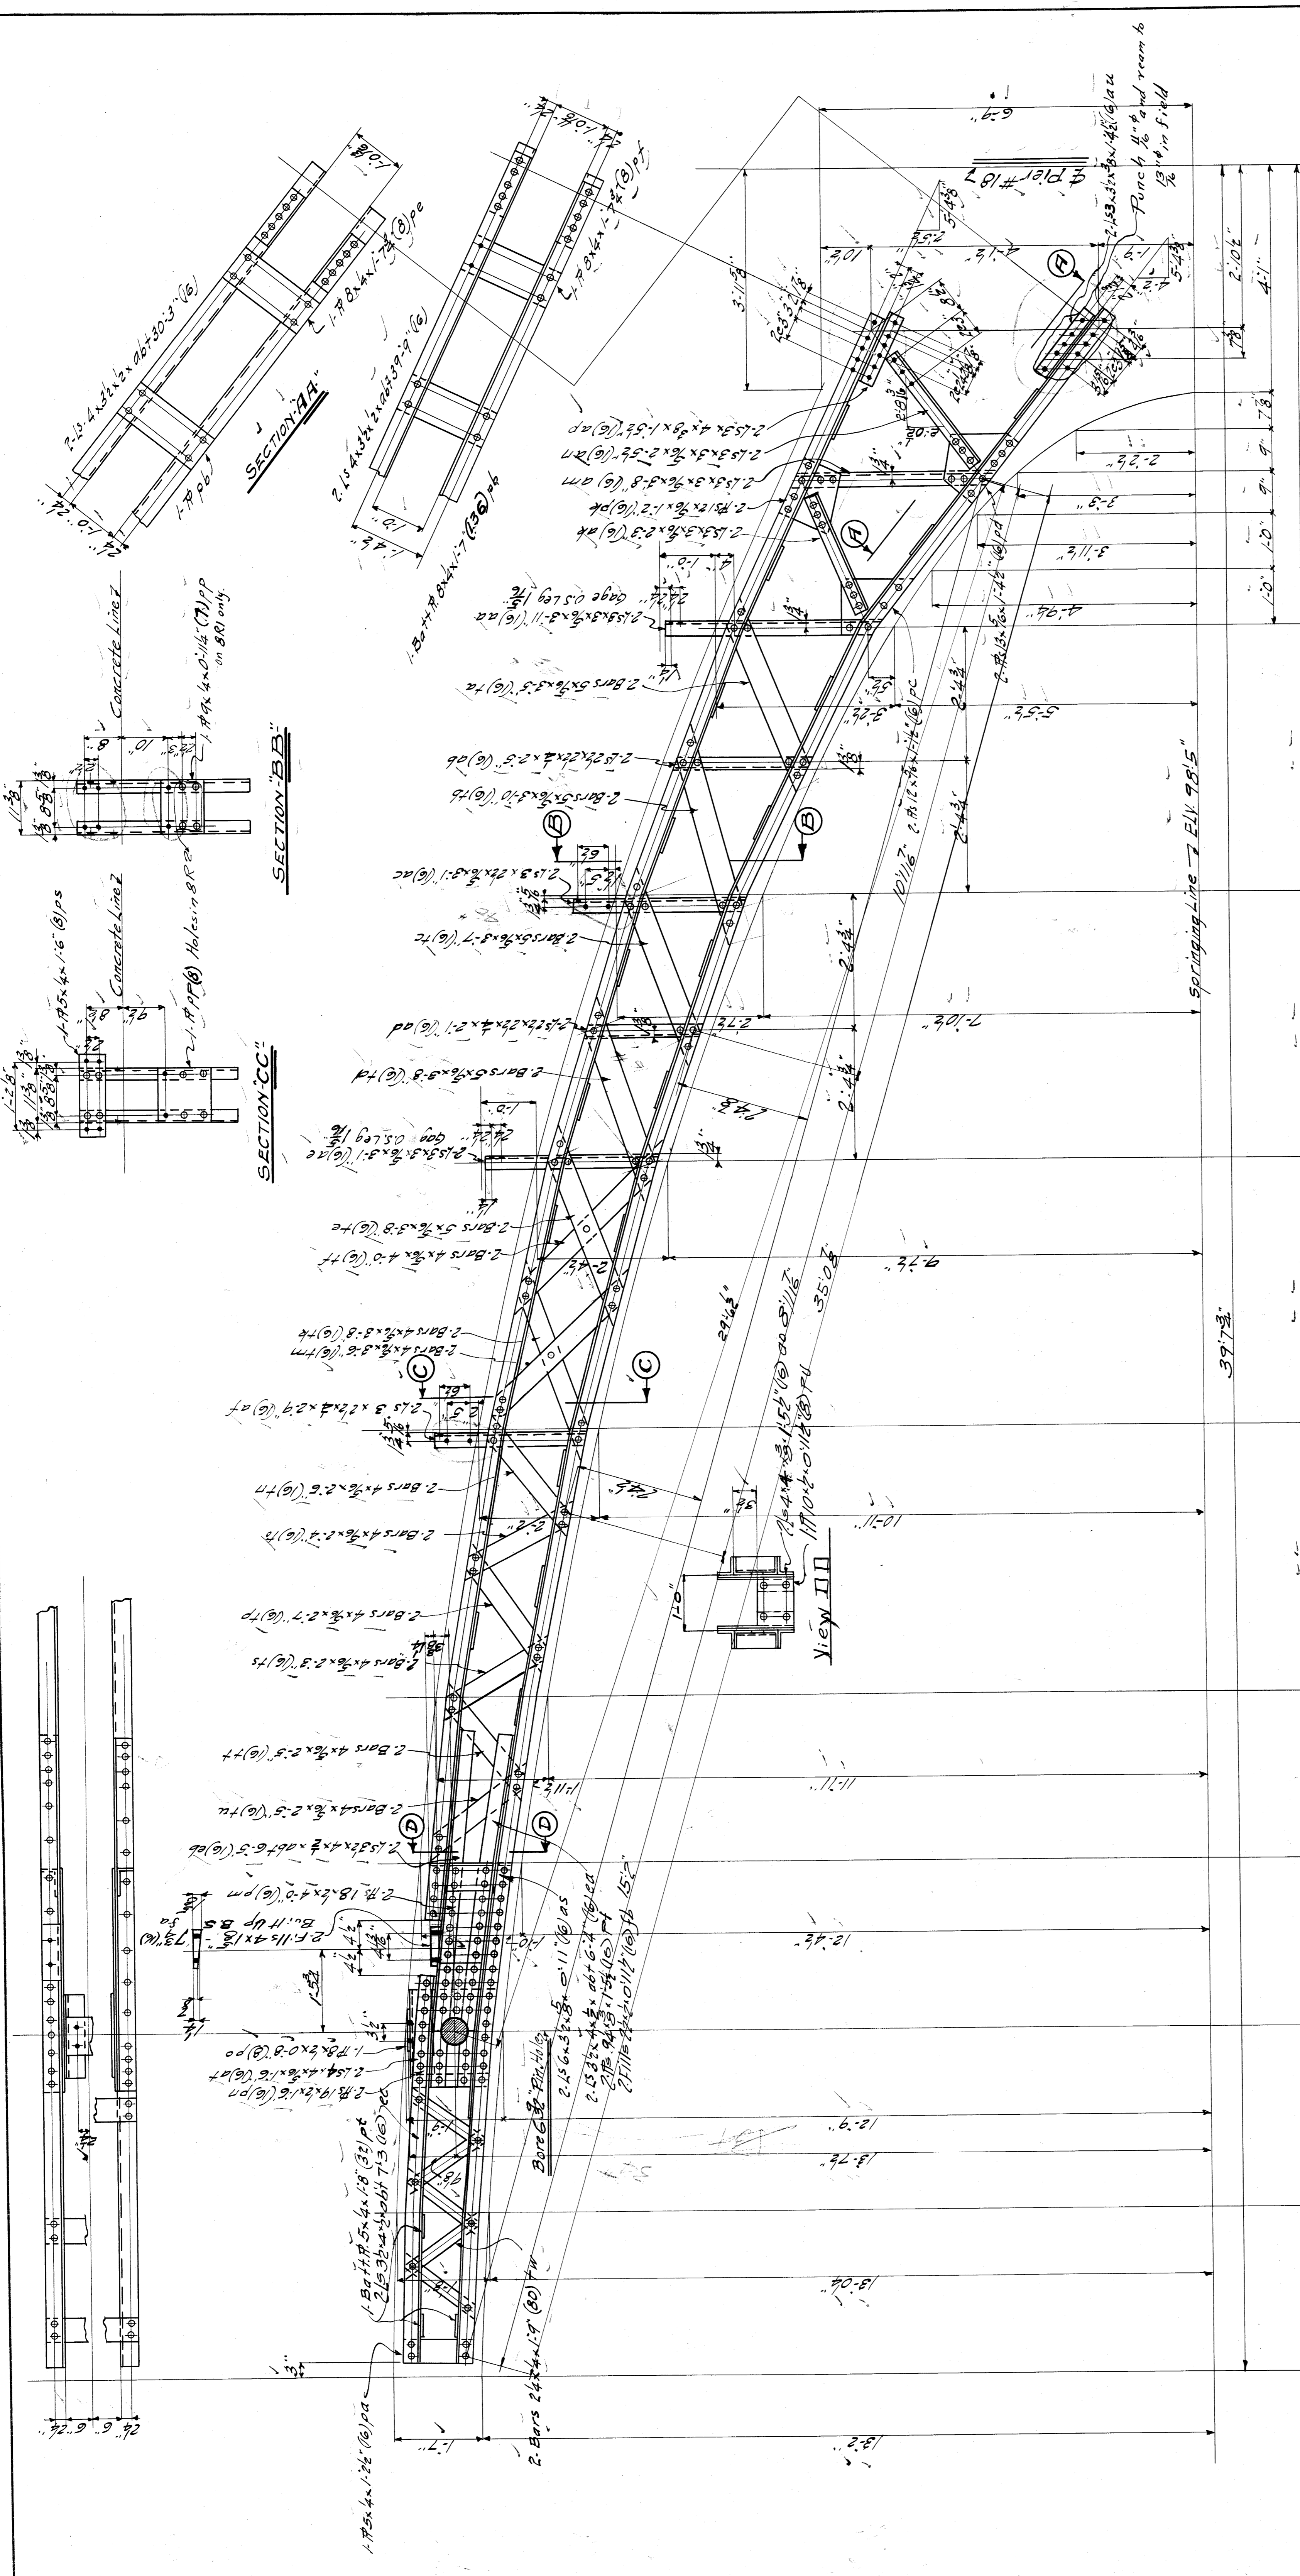

WISCONSIN BRIDGE & IRON CO.
 NORTH MILWAUKEE, WISCONSIN

ERECTED BY
City of Detroit Mich.
DESCRIPTION Belle Isle Bridge
DETAILS OF Piers
SPECIFICATIONS FASSELBYN MURPHY REAMING



CONTRACT NO. 9384
 FOR **City of Detroit Mich.**
 LOCATION **Detroit Mich.**
 DESCRIPTION **Belle Isle Bridge**
 DETAILS OF **Piers**
 SPECIFICATIONS **FASSELBYN MURPHY REAMING**

INSPECTION BY
 SHOP PAINT NAME
 FIELD PAINT NAME
 RIVETS
 MADE BY
 TRAGED BY
 CHECKED BY


EXCEPT AS NOTED
 DATE
 DATE
 DATE
 DATE

SCALE
 SECTION
 SHEET NO. **9384**
 OF **100**

FILE **BW291-255**

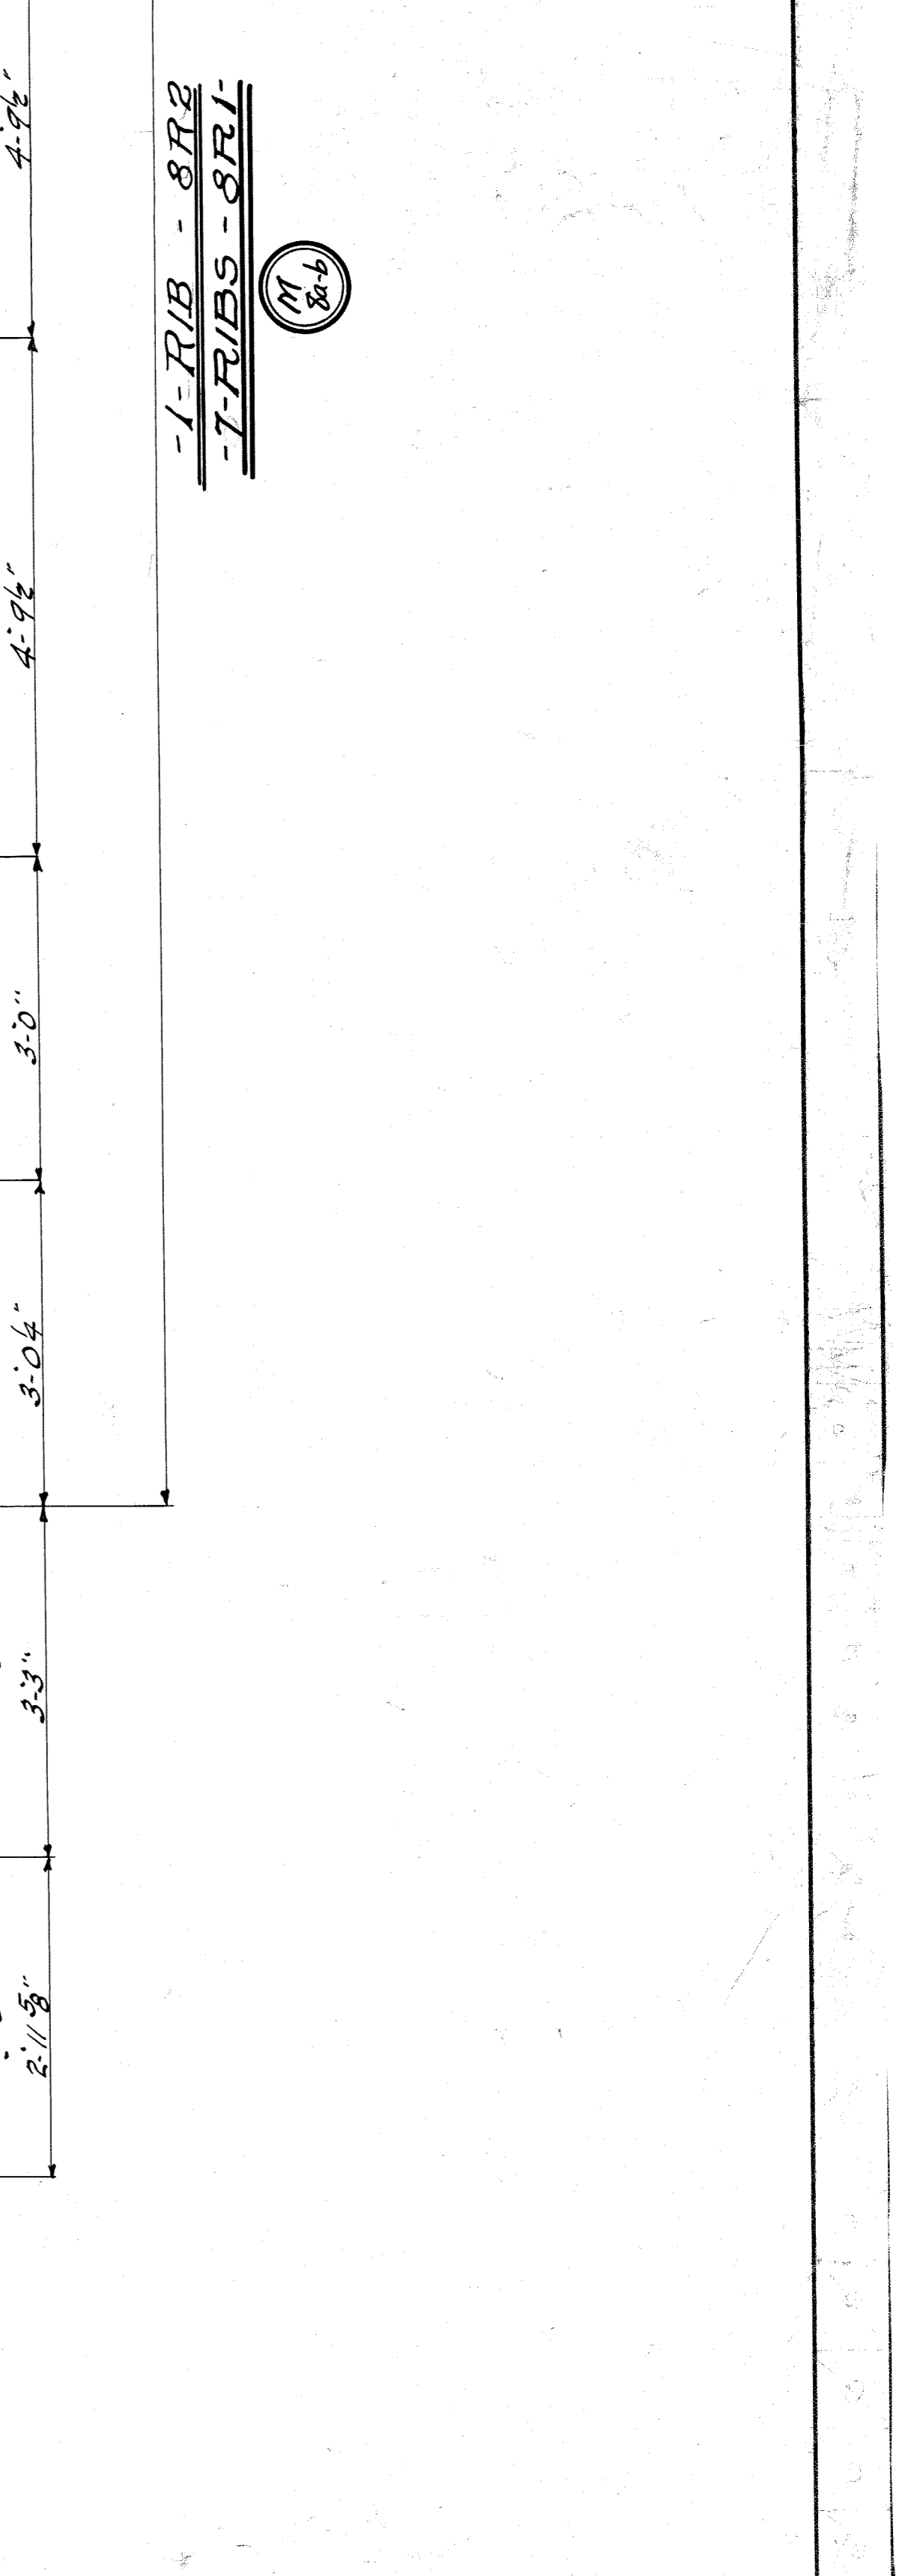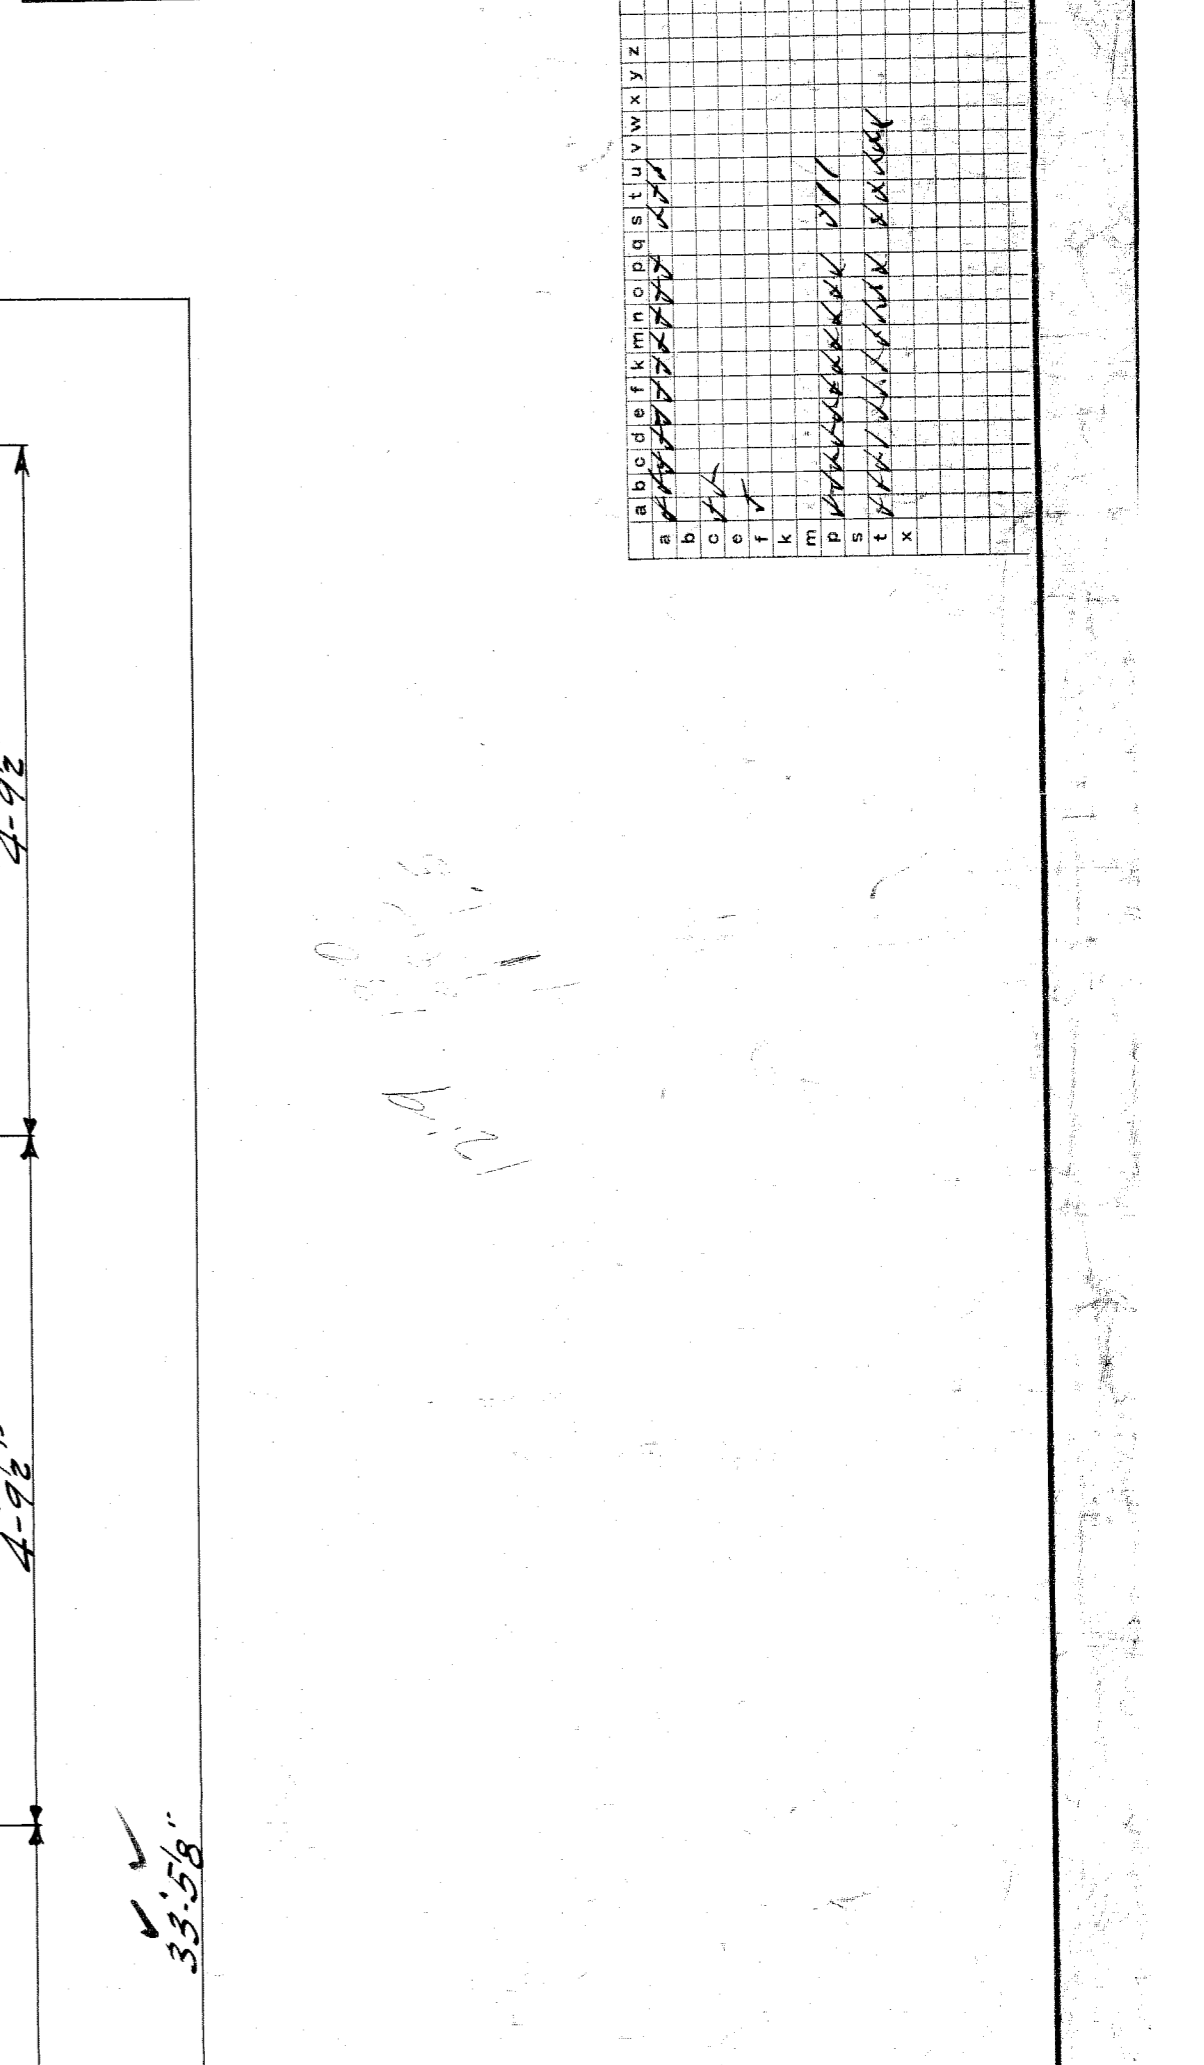

View II

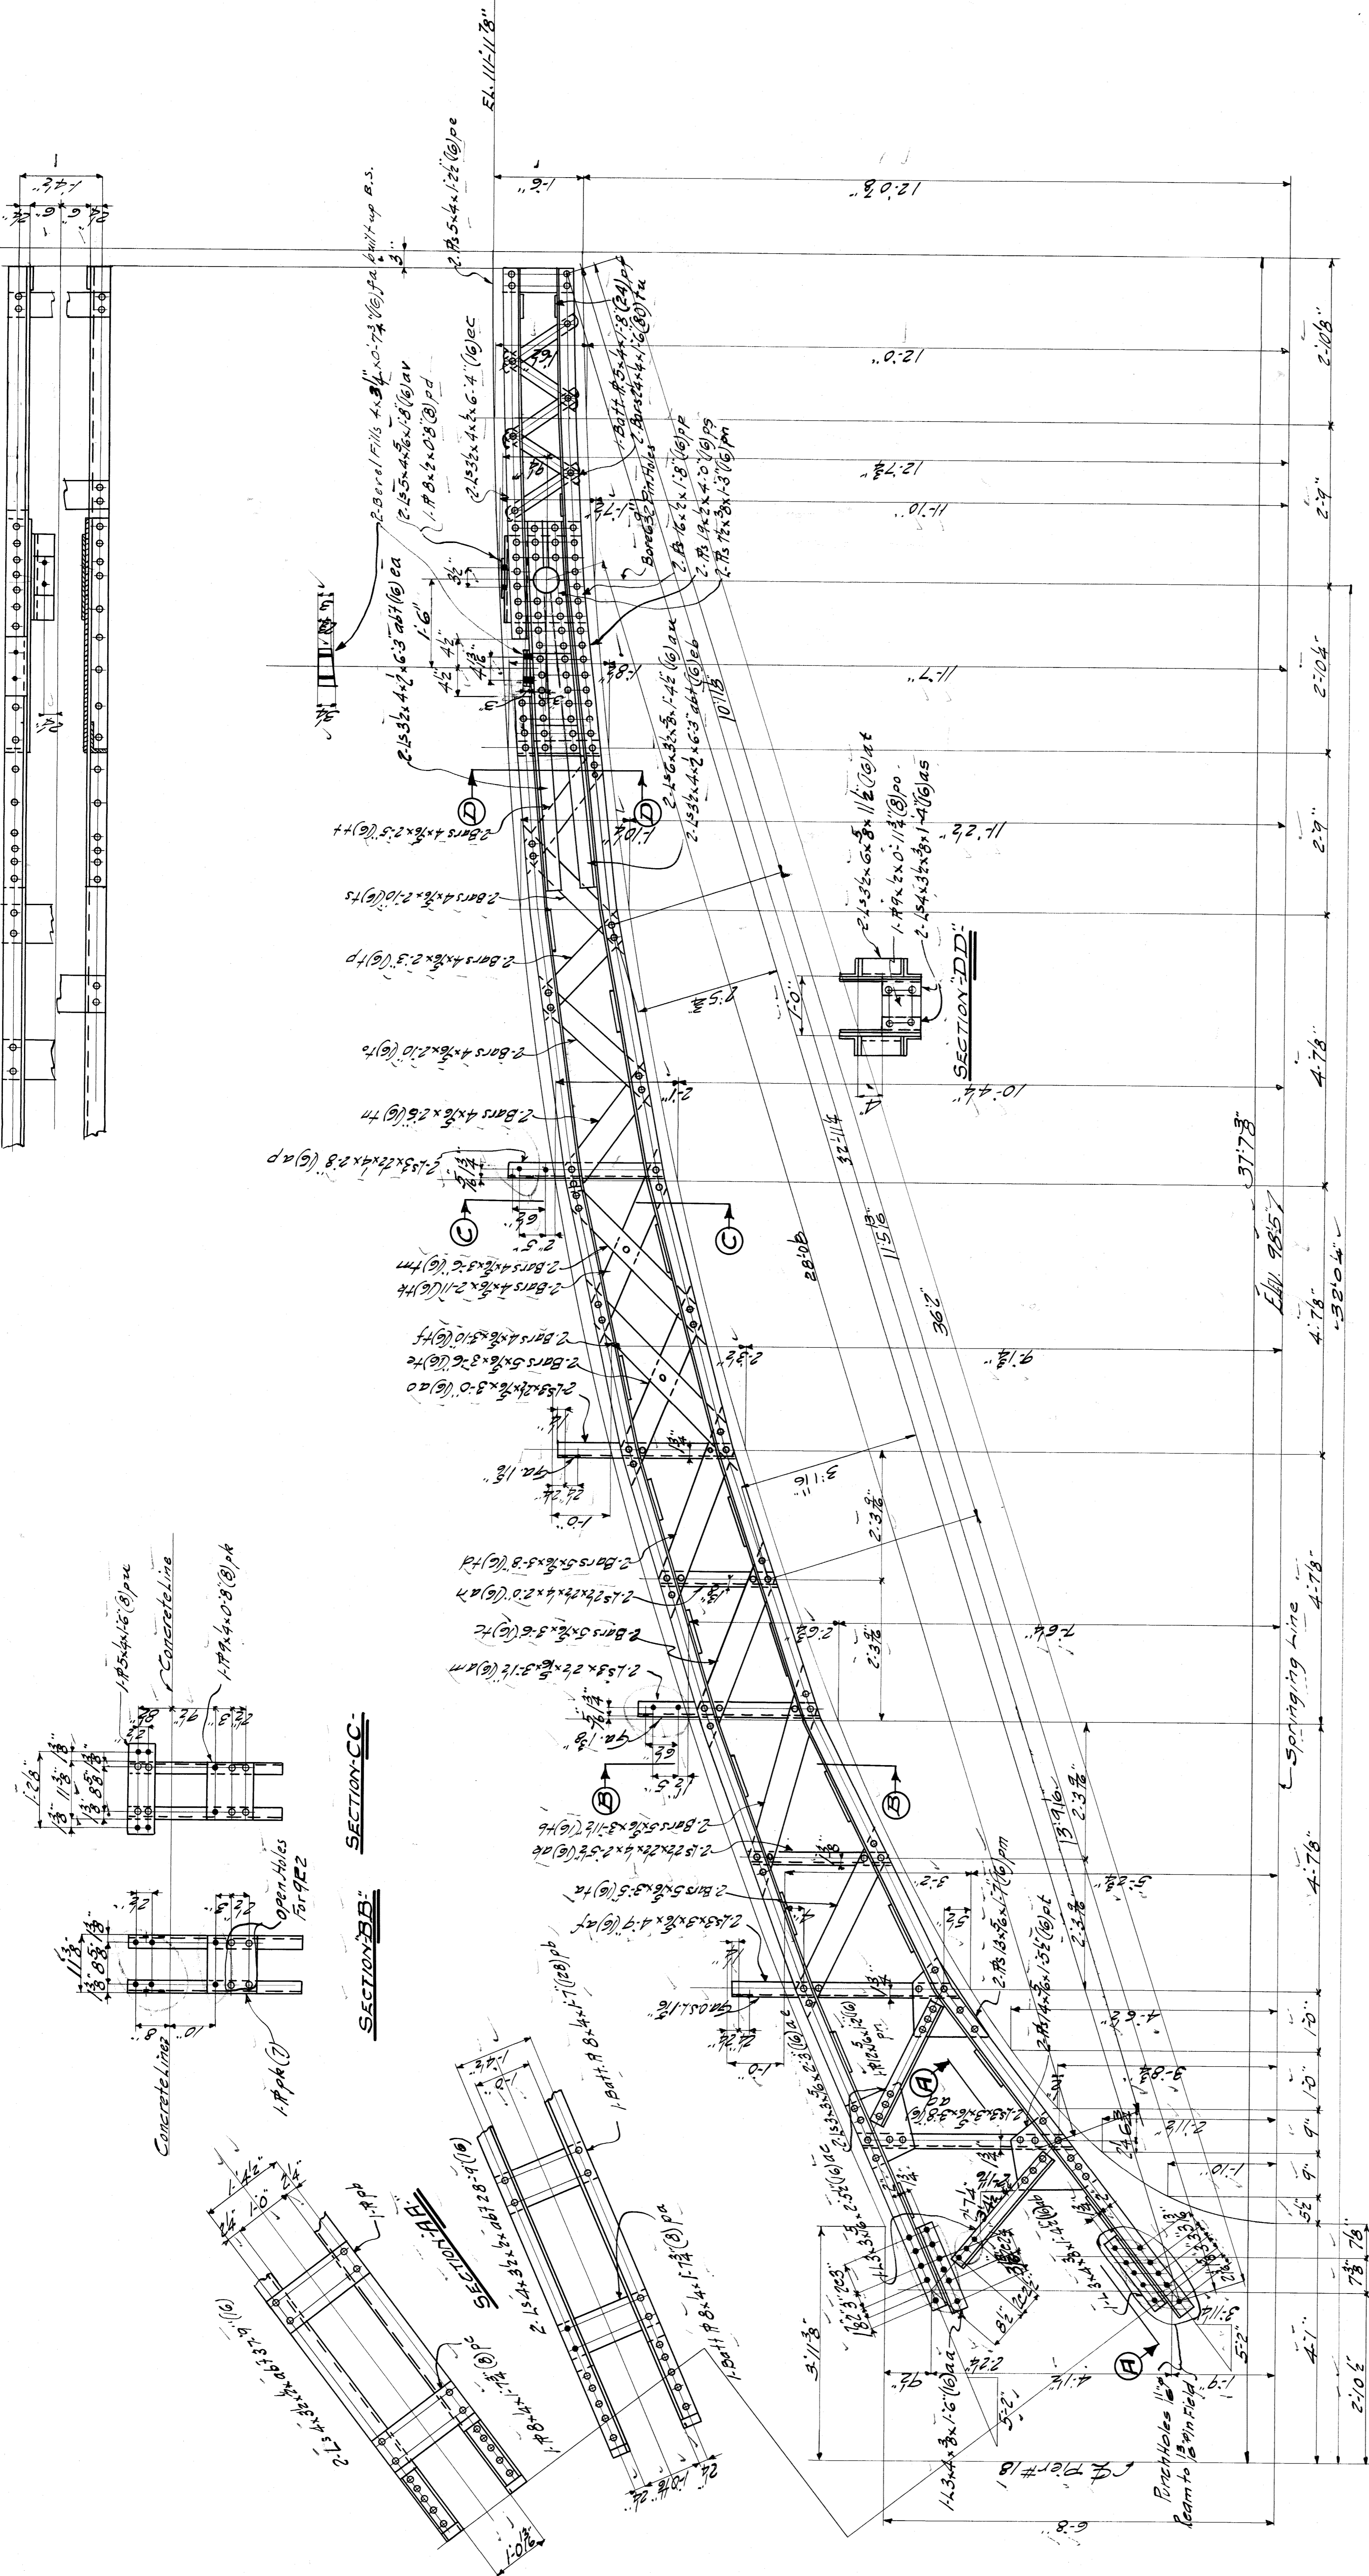

WISCONSIN BRIDGE & IRON CO.
NORTH MILWAUKEE, WISCONSIN


CONTRACT NO. 9384
ERECTED BY
City of Detroit
LOCATION Detroit, Mich.
DESCRIPTION Belle Isle Bridge
DETAILS OF Piers Pier #18 Right Arm.
SPECIFICATIONS Esseylyn Murphy REAMING.
INSPECTION BY
SHOP PAINT None (See Specifications)
FIELD PAINT None
RIVETS 3/8" OPEN HOLES 1/2"
MADE BY C. Leland
TRACED BY E. T. March
CHECKED BY W. G. M. J. S. J.
DATE 7-24-21
DATE 8-9-21
DATE 10-5-21

DATE REVISION	SECTION	SHEET NO.
7-24-21	1	9
8-9-21		
10-5-21		

File BW201-256 CB by GMA

TRIBS-9R1
-1- -9R2-

NO.	REVISION	DATE	BY	SECTION
1				
2				
3				
4				
5				
6				
7				
8				
9				
10				

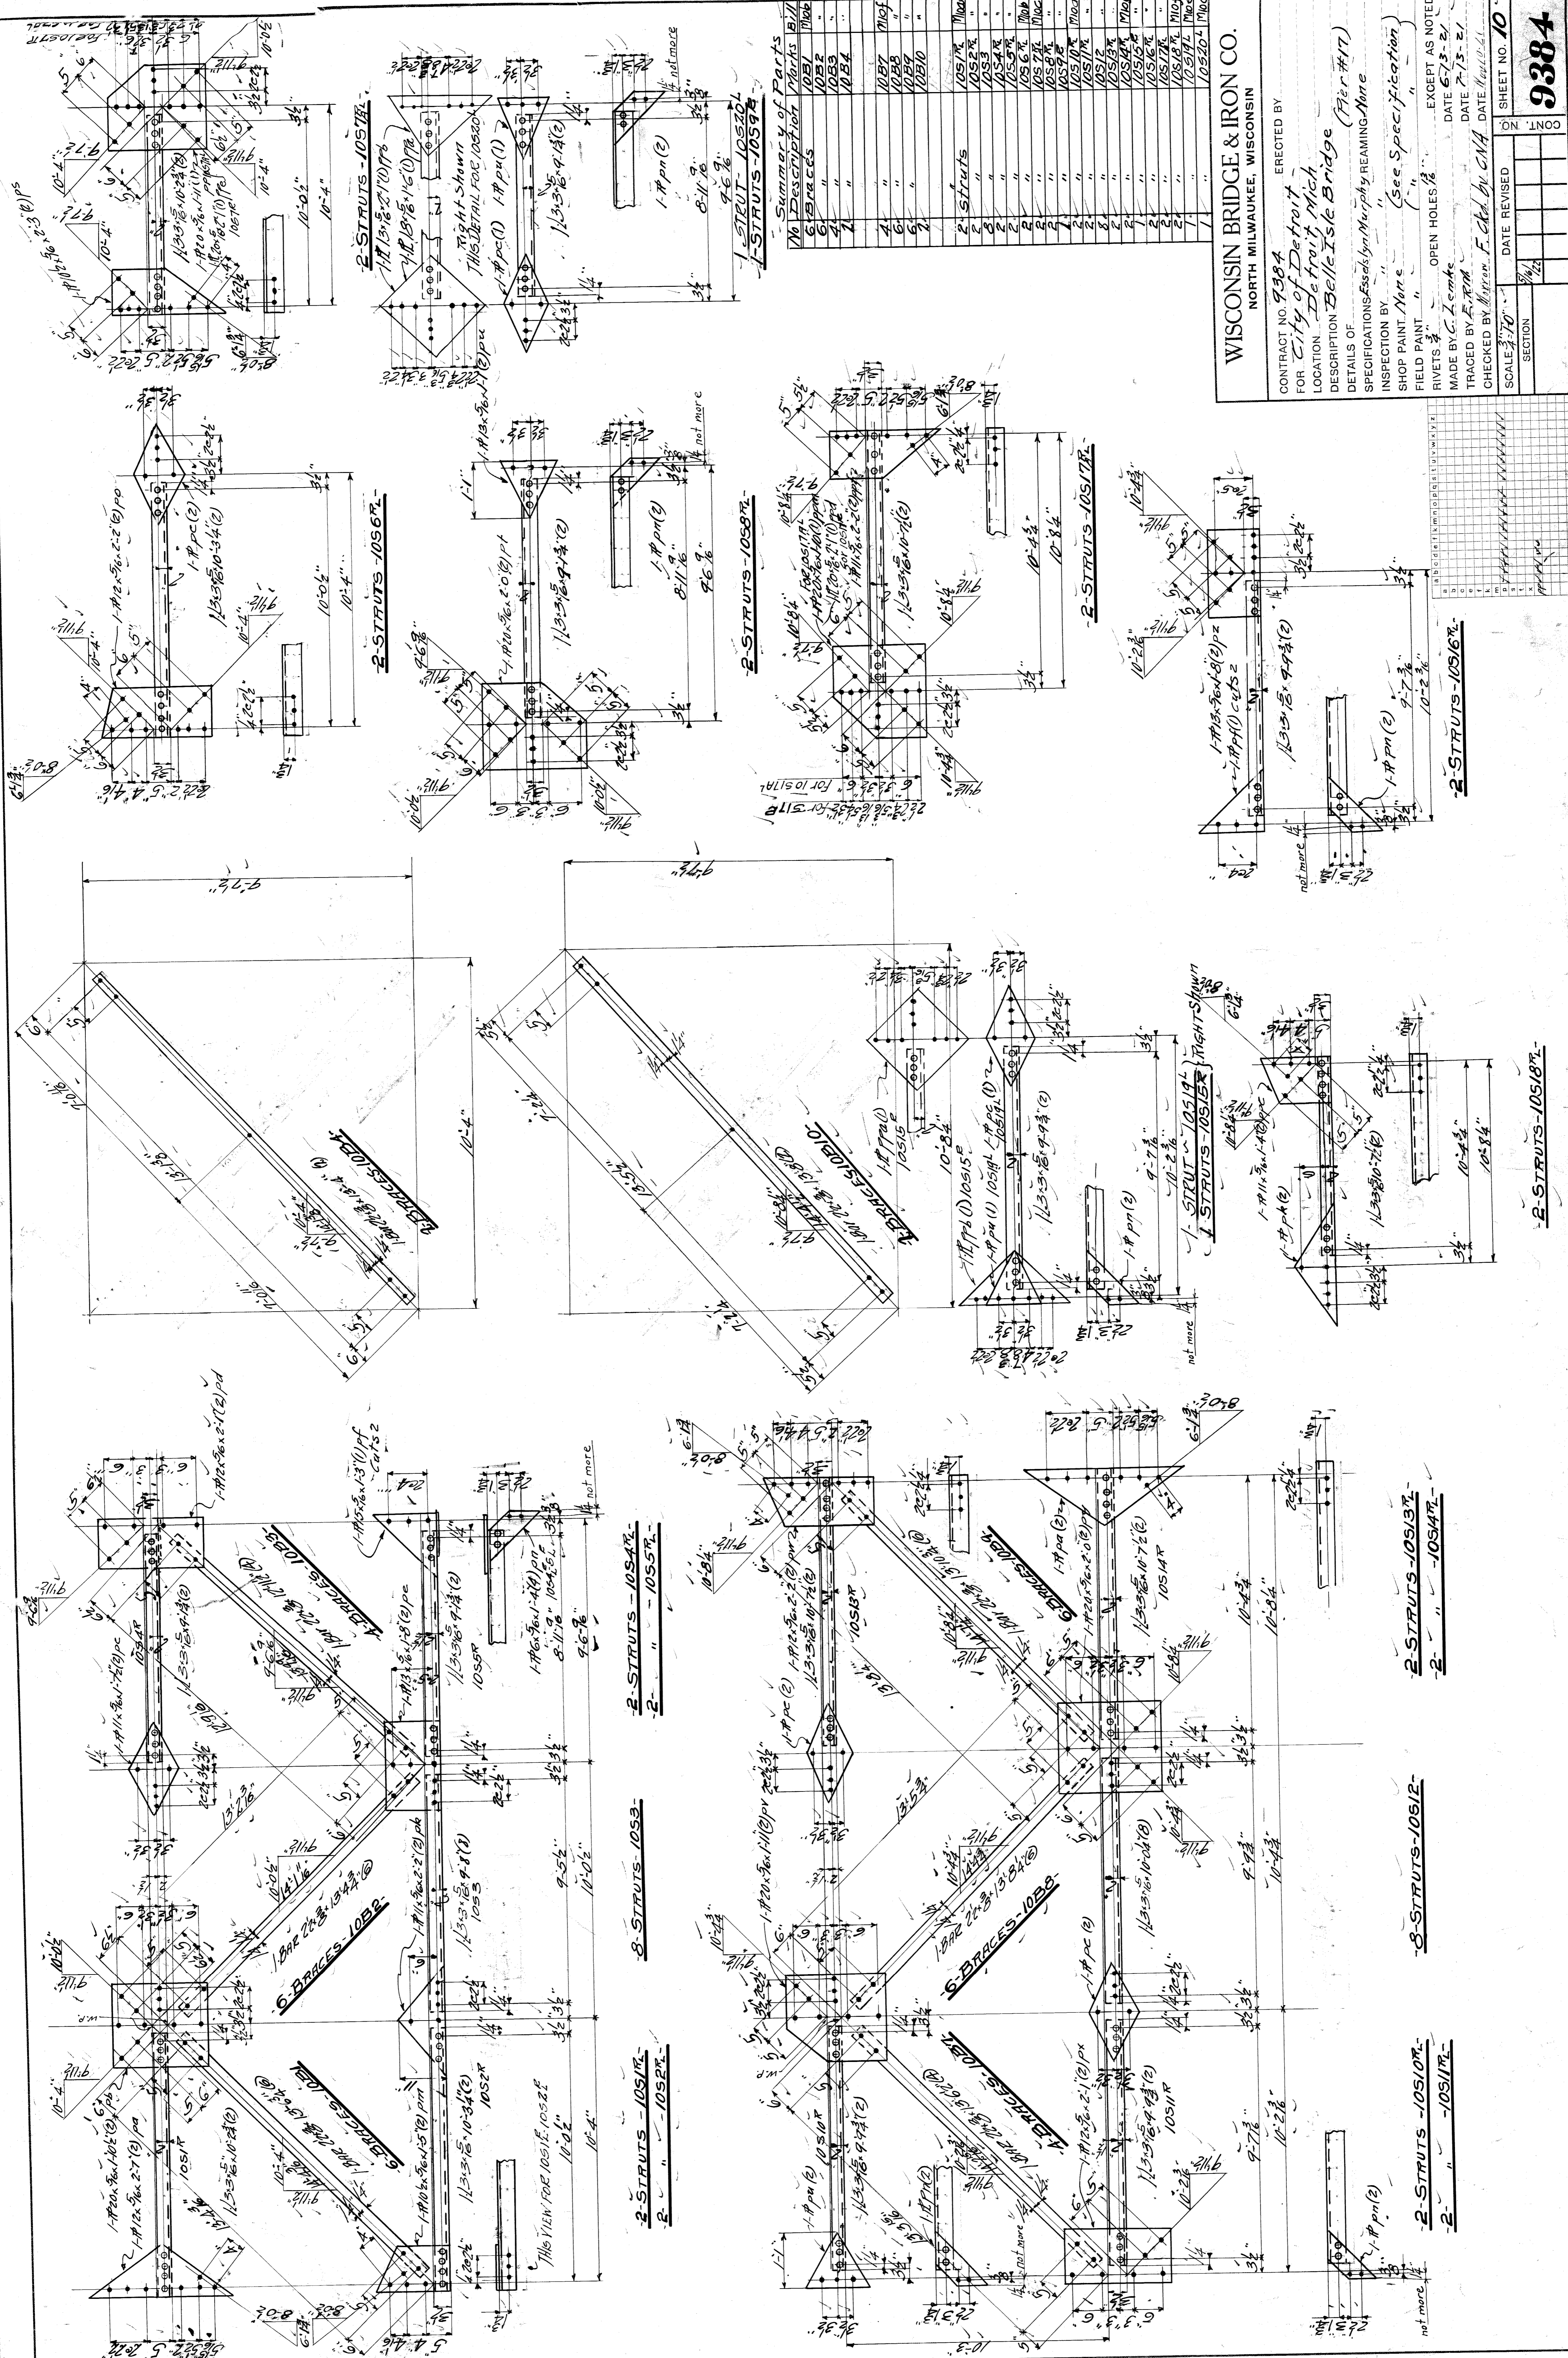

Summary of Parts

No	Description	Parts	Bill
			Material
1	6 BRACES	10S1	1100
2	2 STRUTS	10S2	1100
3	2 STRUTS	10S3	1100
4	2 STRUTS	10S4	1100
100	2 STRUTS	10S100	1100

WISCONSIN BRIDGE & IRON CO.
 NORTH MILWAUKEE, WISCONSIN

ERECTED BY
 City of Detroit
 Detroit Mich

DESCRIPTION
 Belle Isle Bridge (Plan #17)

SPECIFICATIONS
 As per Murphy & Remond

INSPECTION BY
 Name (See Specification)

SHOP PAINT
 Name

FIELD PAINT
 Name

RIVETS
 OPEN HOLES

EXCEPT AS NOTED
 MADE BY
 DATE

TRACED BY
 DATE

CHECKED BY
 DATE


SCALE
 1" = 10'

SECTION

DATE REVISED

SHEET NO. 10

9384

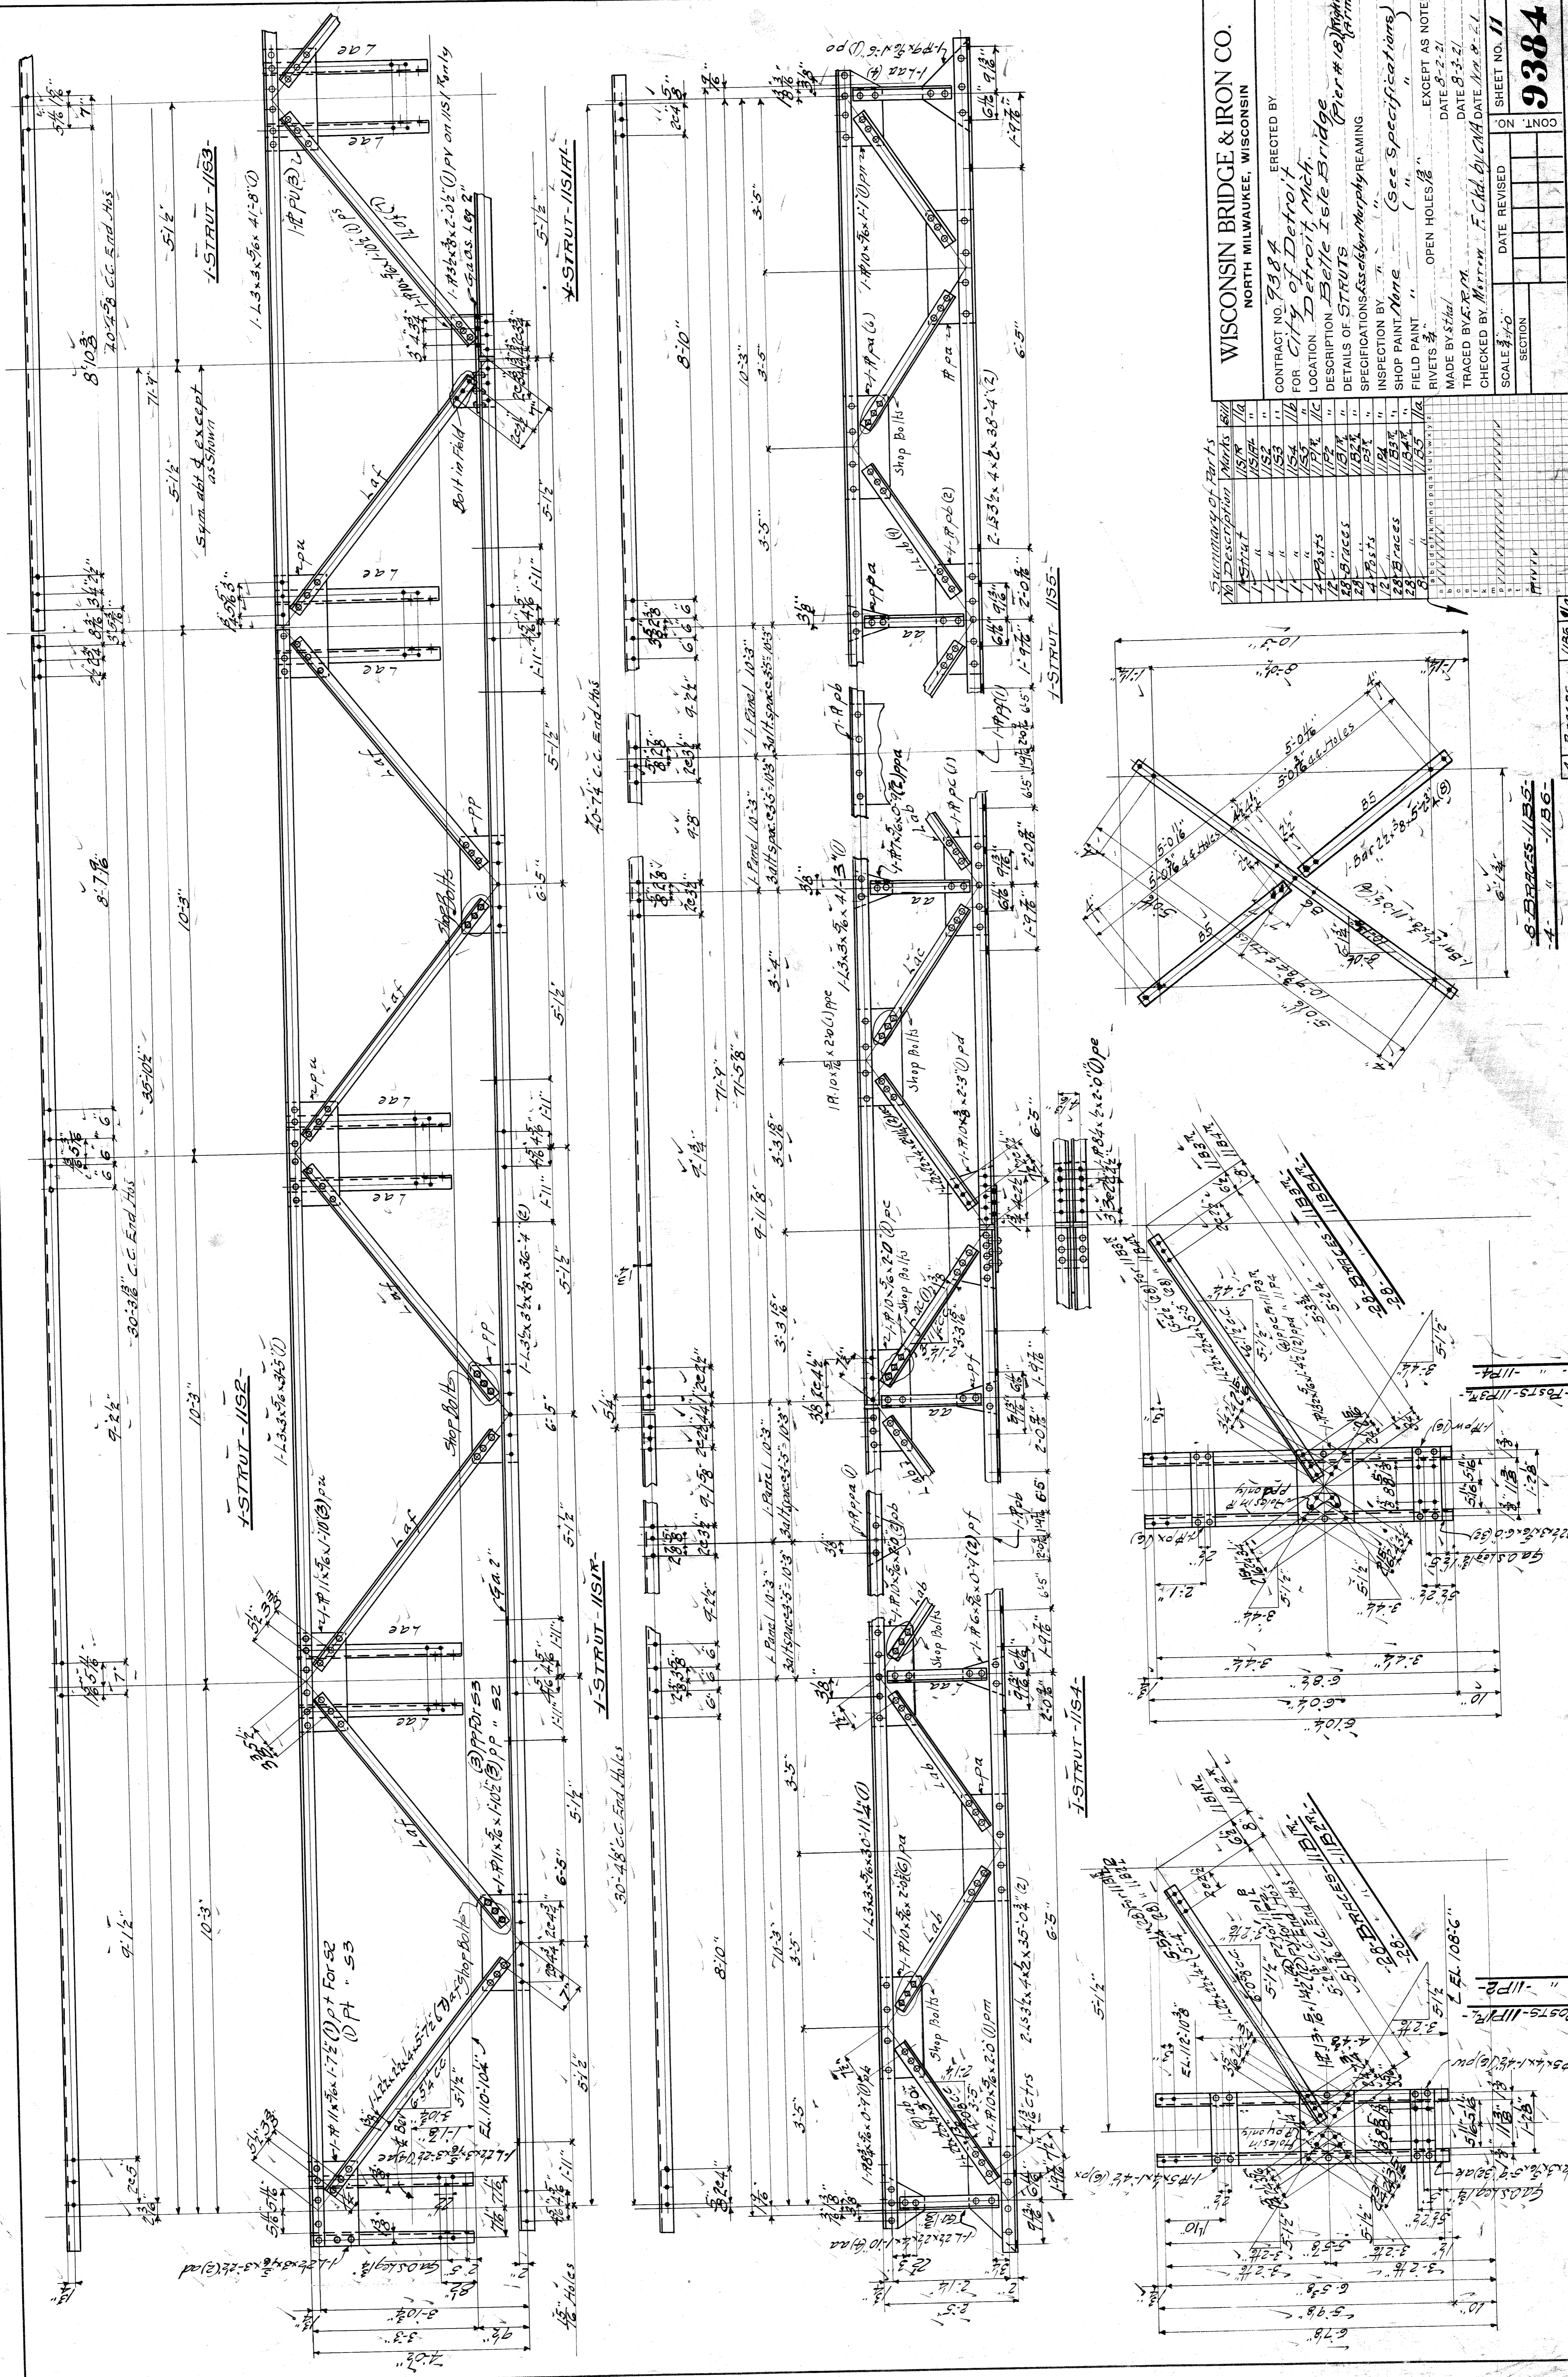


Summary of Parts	
No.	Description
1	I-Strut
2	"
3	"
4	"
100	"

WISCONSIN BRIDGE & IRON CO.
 NORTH MILWAUKEE, WISCONSIN

ERECTED BY
 CONTRACT NO. 9384
 FOR City of Detroit
 LOCATION Belle Isle Bridge
 DETAILS OF STRUTS
 SPECIFICATIONS As by Murphy & Reming
 INSPECTION BY
 SHOP PAINT None (See Specifications)
 FIELD PAINT
 RIVETS AS NOTED
 MADE BY Steel
 DATE 8-3-21
 TRACED BY S.R.M.
 CHECKED BY Marrow F. C. Ad. by CNA DATE 11-8-21

SCALE 3/4" = 1'-0"
 SECTION
 DATE REVISED
 SHEET NO. 11
9384

FILE BW204-258

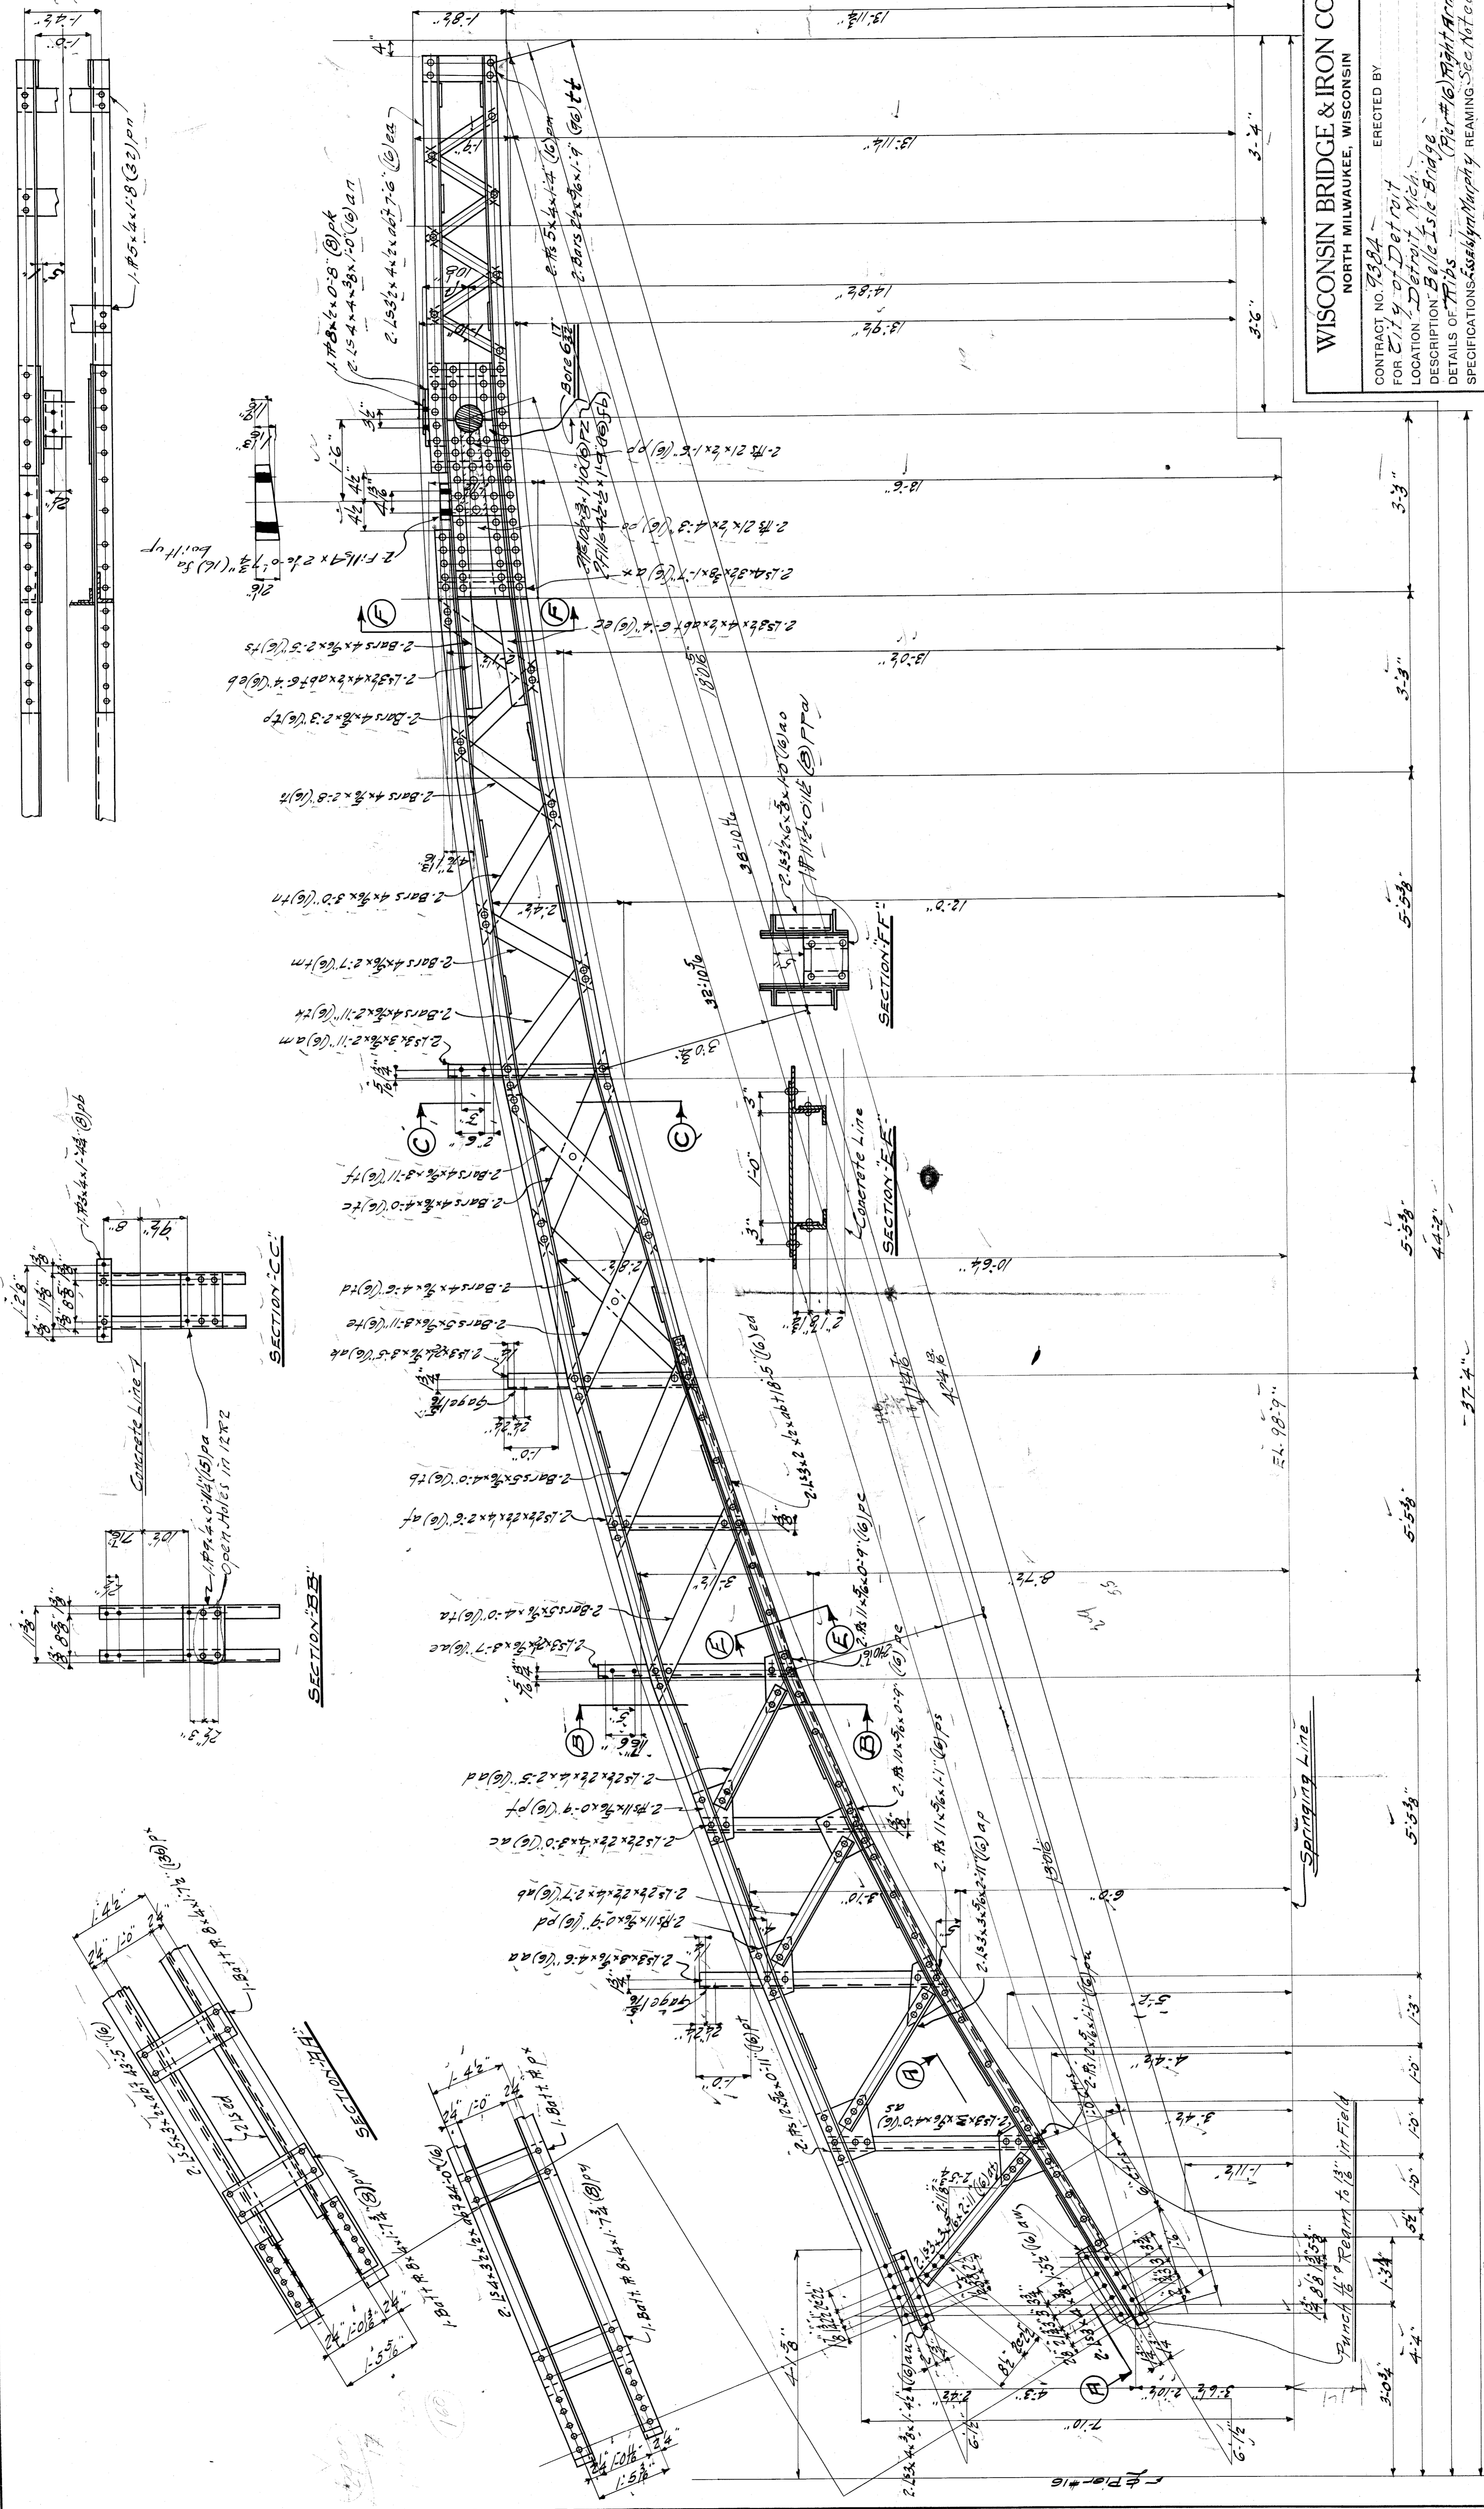


WISCONSIN BRIDGE & IRON CO.
 NORTH MILWAUKEE, WISCONSIN

ERECTED BY
 CONTRACT NO. 9384
 FOR City of Detroit Mich.
 LOCATION - Detroit Mich.
 DESCRIPTION - Belle Isle Bridge
 DETAILS OF TRUSS (Part of Right Arm)
 SPECIFICATIONS - See Specifications
 INSPECTION BY
 SHOP PAINT None (See Specifications)
 FIELD PAINT None
 RIVETS 3/8" OPEN HOLES 1/8"
 MADE BY M. H. Peters.
 TRACED BY F. R. M.
 CHECKED BY J. W. M. F. Gled. by CMA
 DATE 8-2-21
 DATE REVISION 1-1-21
 SCALE 1/4" = 1'-0"

SHEET NO. 12	NO. 00
DATE REVISION	SECTION


File BWay-259

1-RIB-12RB
 1-RIBS-12R1-12R2

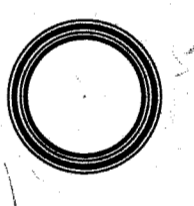

1	2	3	4	5	6	7	8	9	10	11	12	13	14	15	16	17	18	19	20

9584

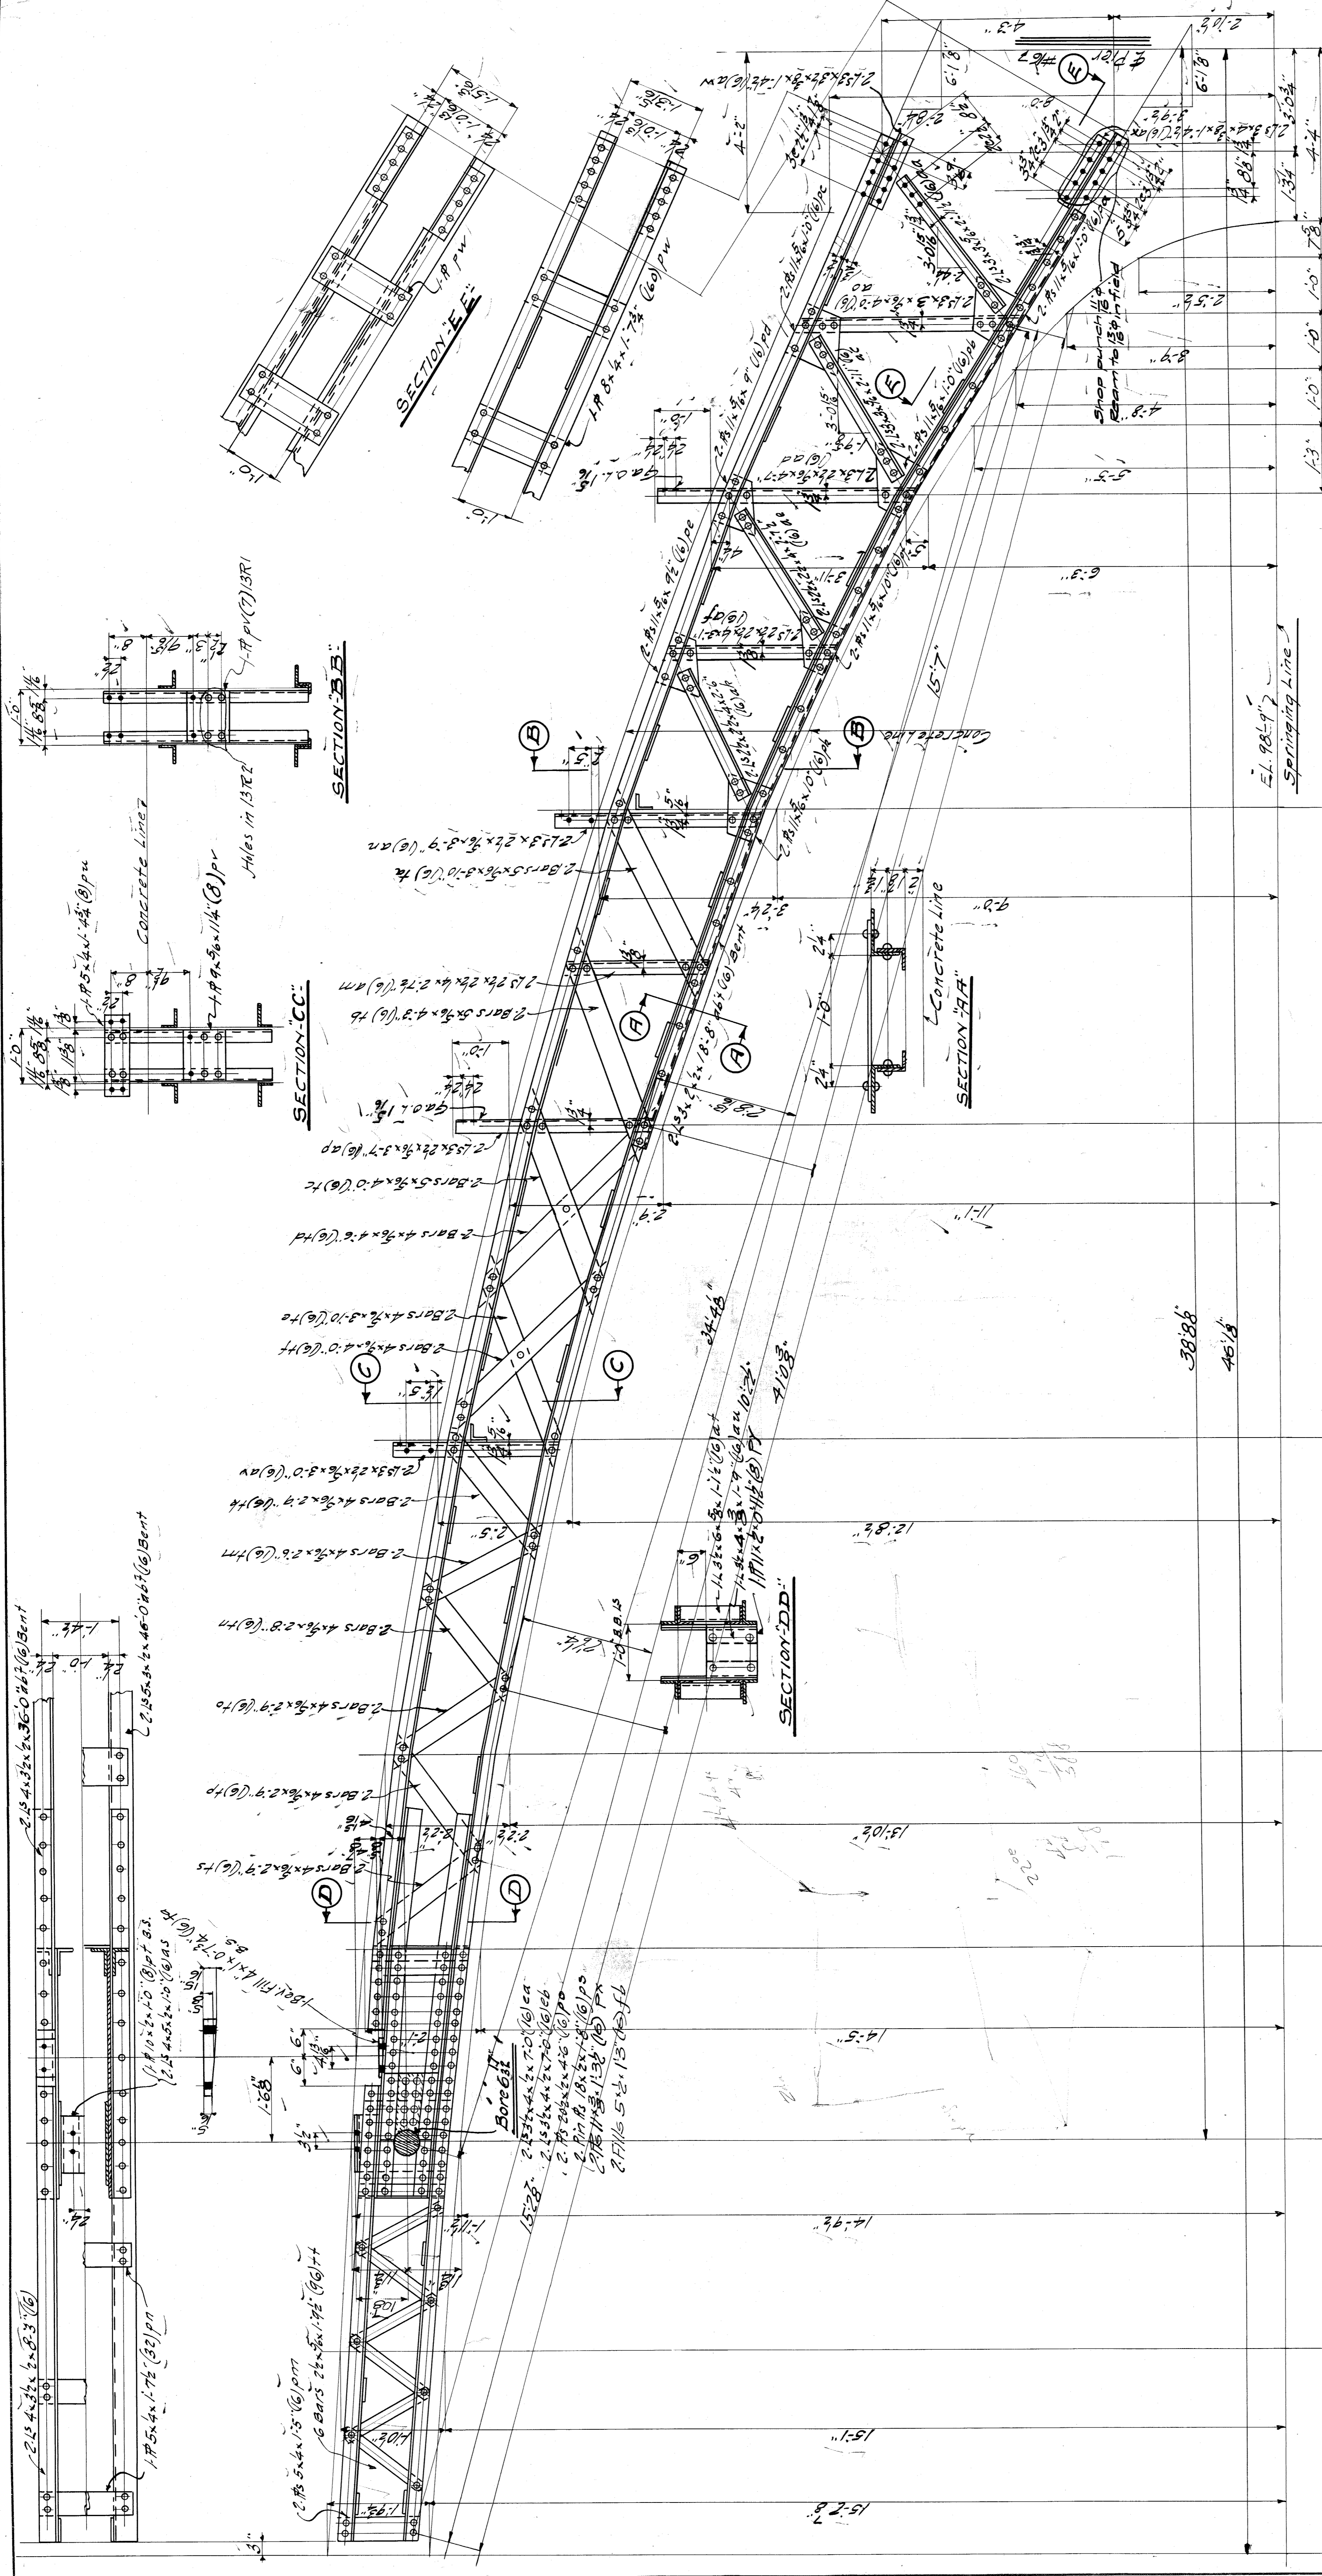

WISCONSIN BRIDGE & IRON CO.
 NORTH MILWAUKEE, WISCONSIN




ERECTED BY:
 CONTRACT NO. 9384
 FOR City of Detroit
 LOCATION Detroit, Mich
 DESCRIPTION Belle Isle Bridge
 Pier #16 Left Arm
 DETAILS OF PILES
 SPECIFICATIONS AS SET FORTH IN REAMING
 INSPECTION BY
 SHOP PAINT None (See Specifications)
 FIELD PAINT None
 RIVETS 3/8" OPEN HOLES 1/2"
 MADE BY R.F.S. DATE 8/3/21
 TRACED BY S.P.M. DATE 8/12/21
 CHECKED BY Martin F. Gekelby CNA DATE 11/1/21

SCALE 3/4" = 1'-0"
 DATE REVISED
 SECTION NO. 13
 SHEET NO. 9384
 OF 1 NOO

13R13-13R2
 13R13S-13R1



FILE BN201-260

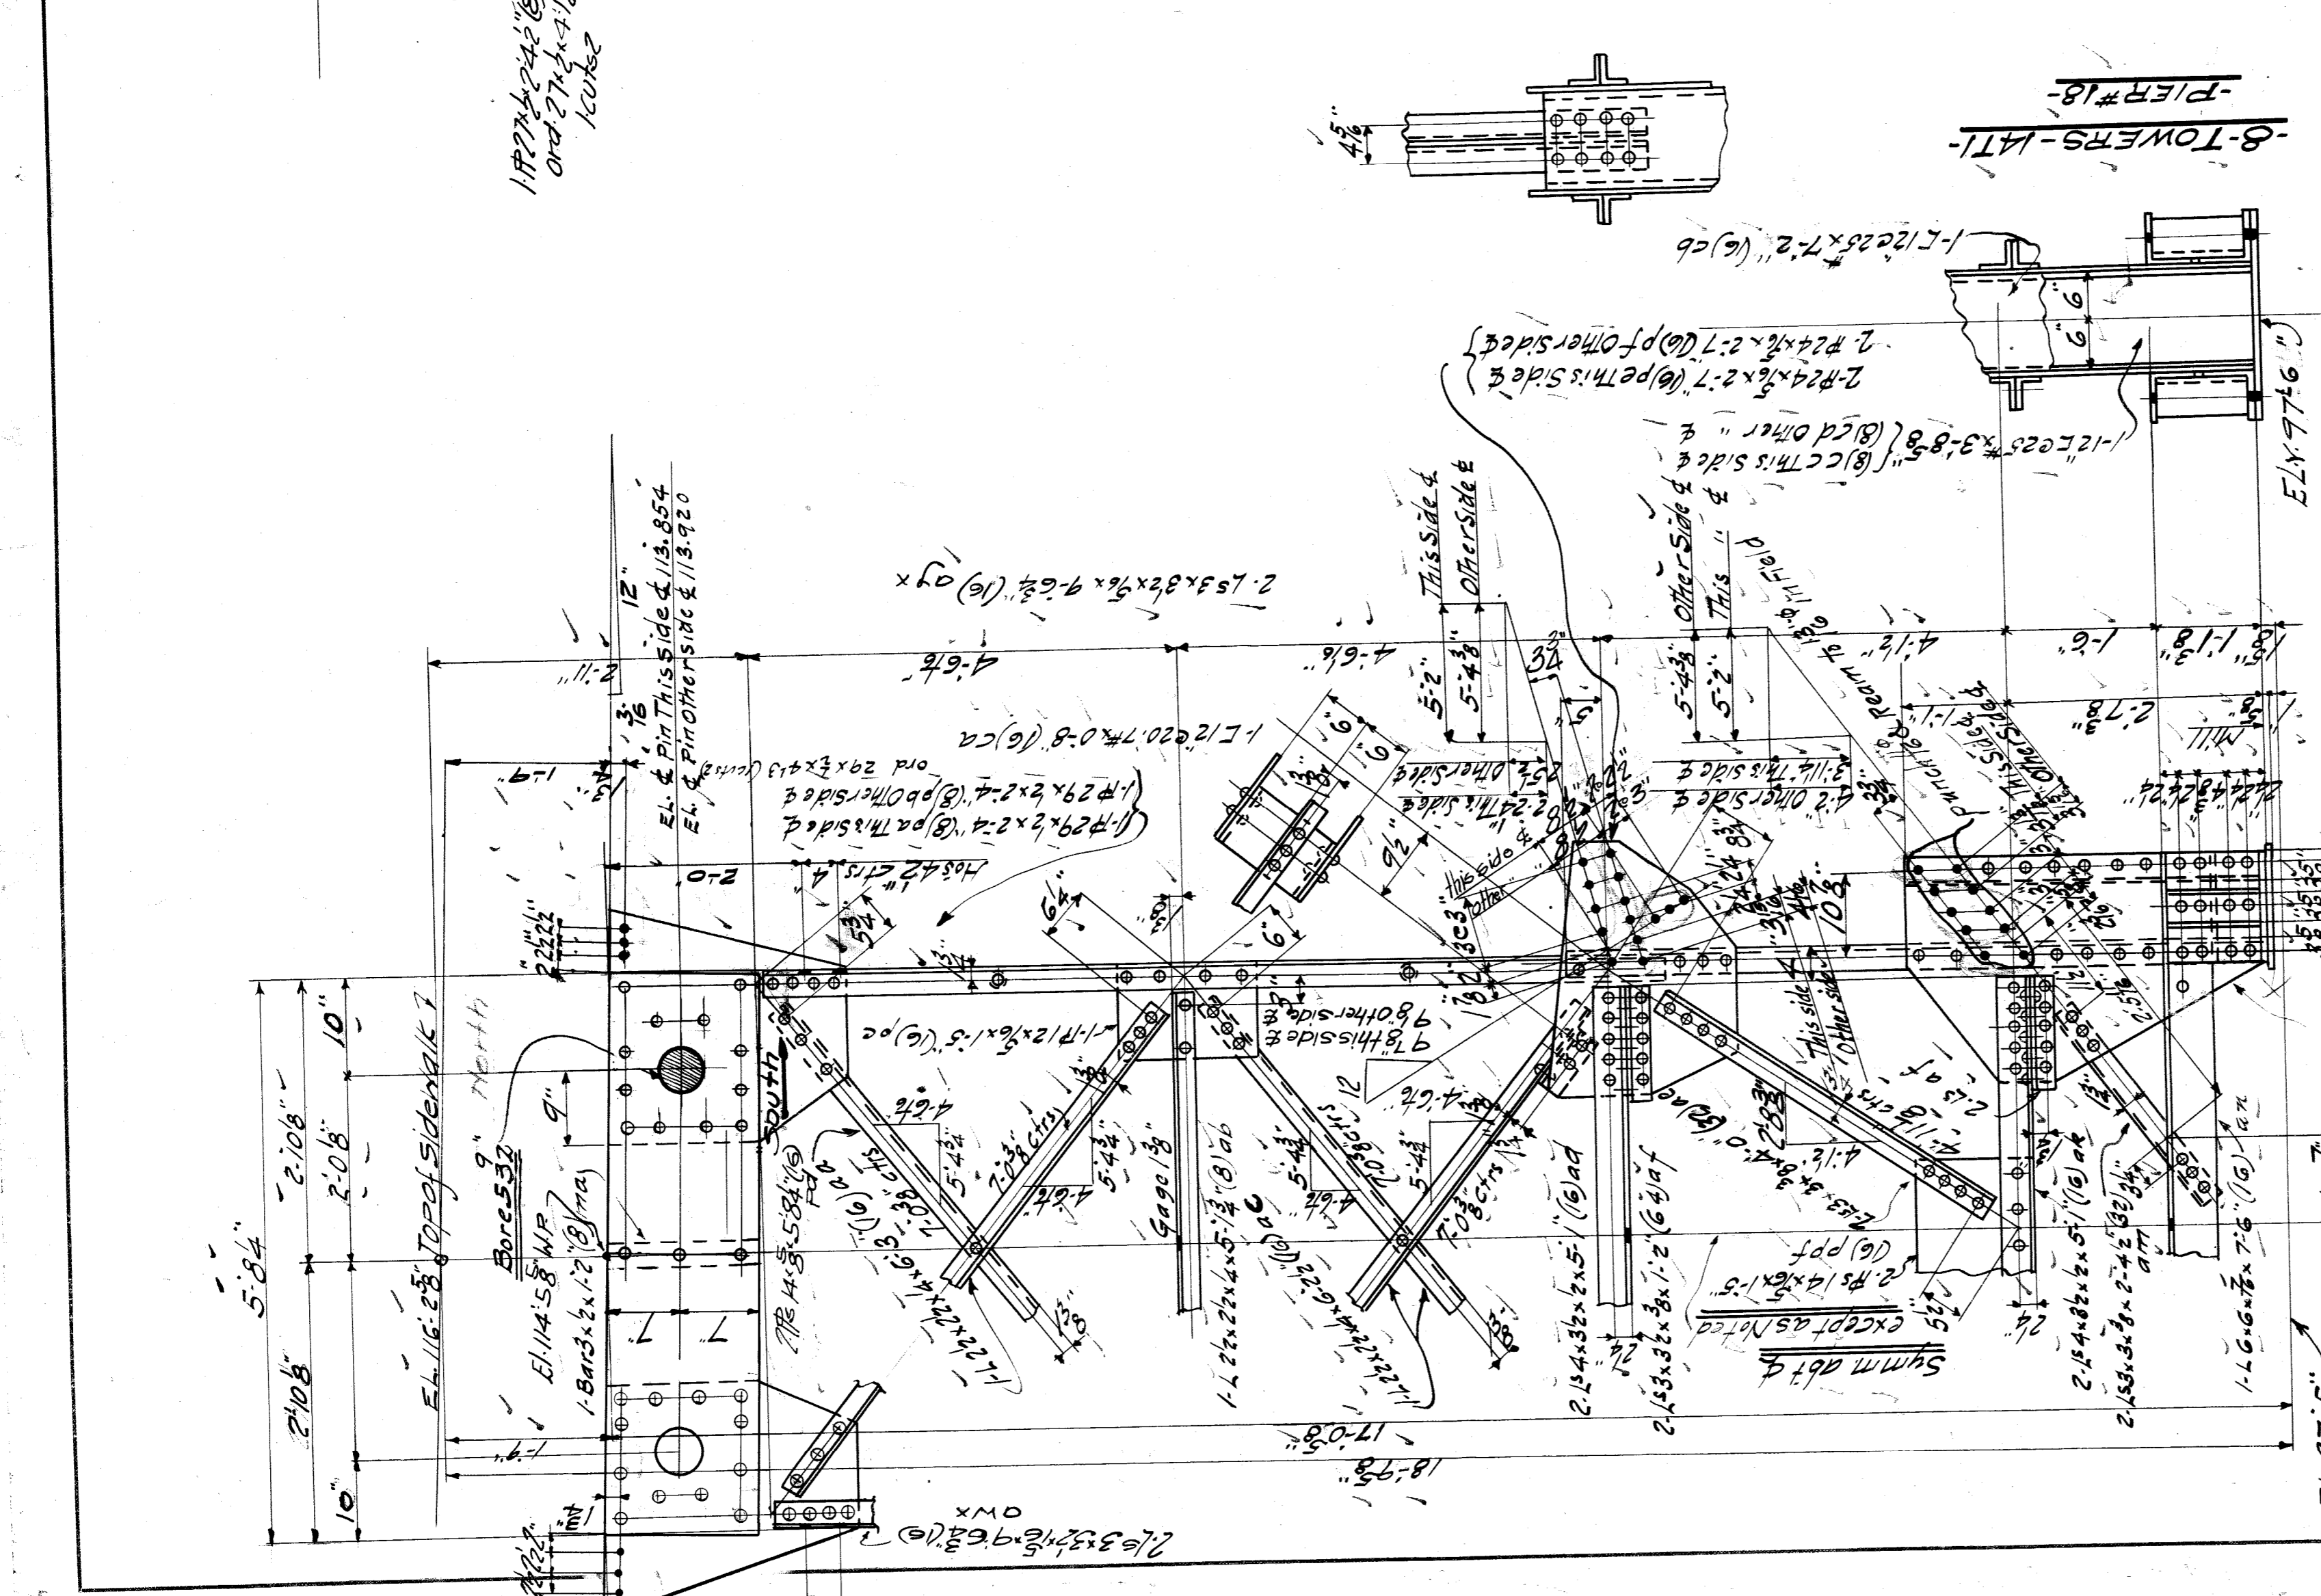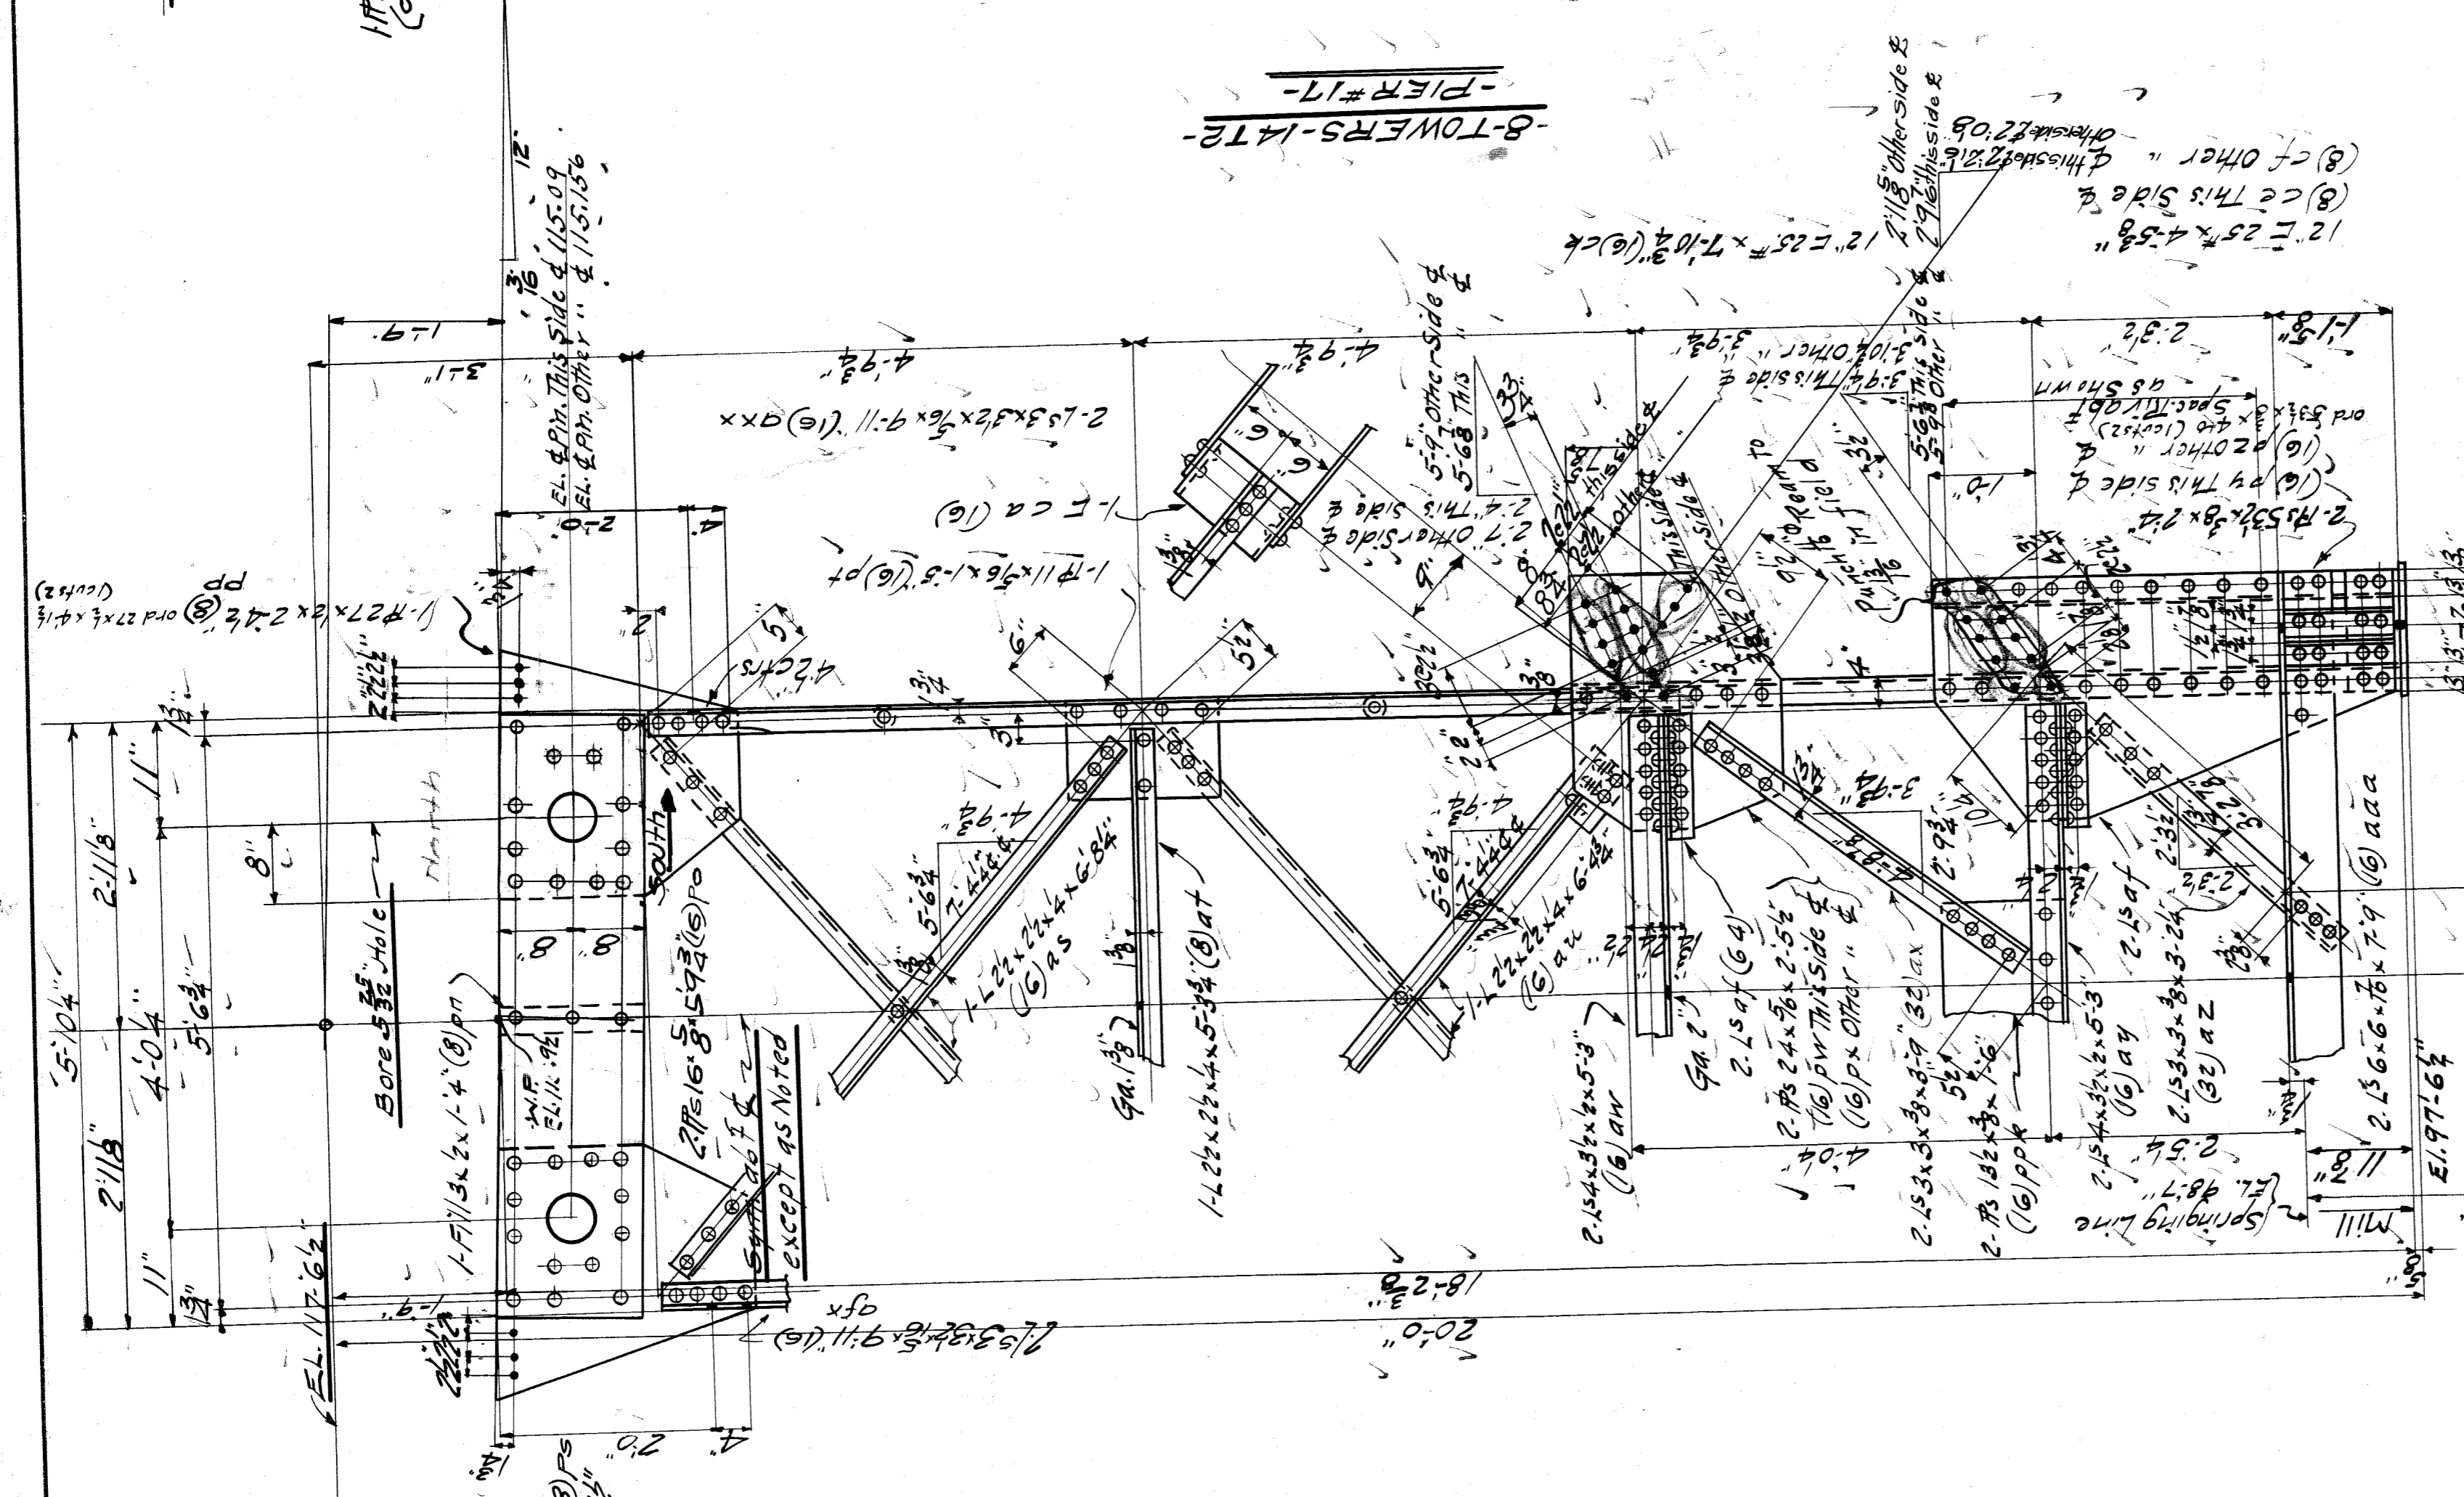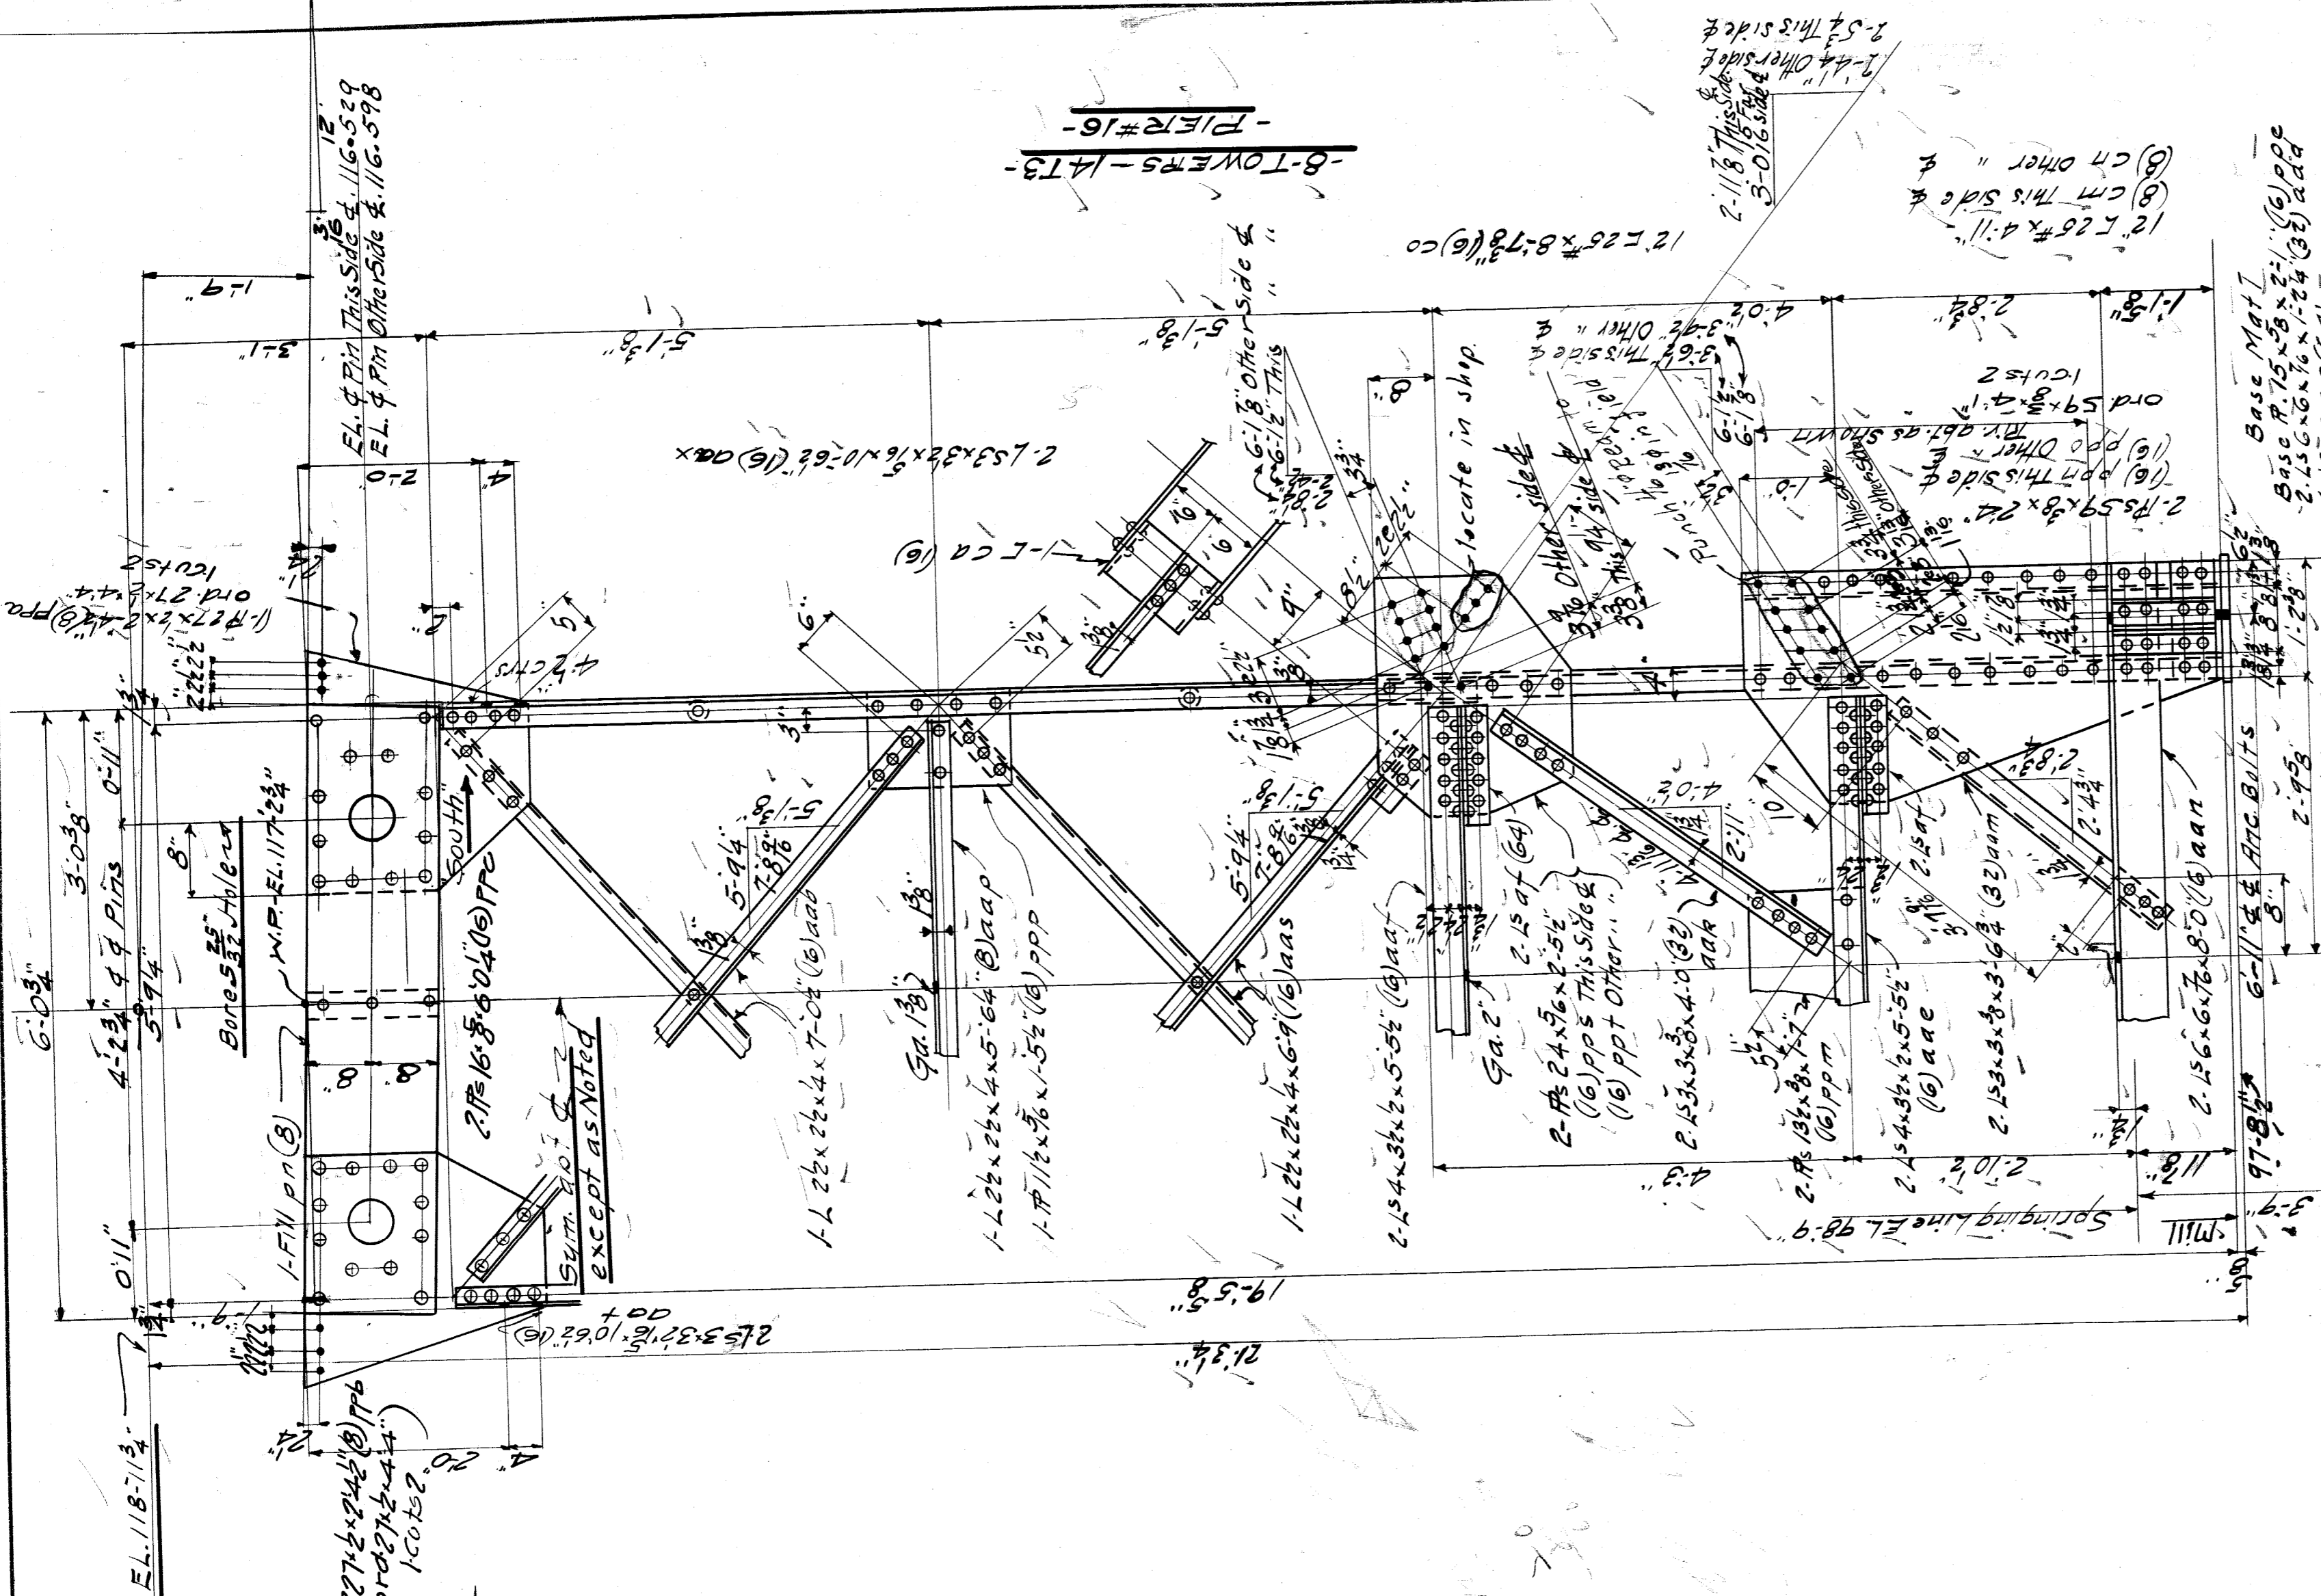

WISCONSIN BRIDGE & IRON CO.
 NORTH MILWAUKEE, WISCONSIN

ERECTED BY
 CONTRACT NO. 9384
 FOR City of Detroit
 LOCATION Detroit, Mich.
 DESCRIPTION Beloit Bridge
 DETAILS OF TOWERS - PIER# 18-17-16
 SPECIFICATIONS: See Notes
 INSPECTION BY
 SHOP PAINT NOTE: (See specifications)
 FIELD PAINT NOTE: OPEN HOLES 1/8"
 RIVETS: C
 MADE BY C.N.A.
 TRACED BY E.T.M.
 CHECKED BY M.T.E.
 SCALE 3/8" = 1'-0"

EXCEPT AS NOTED
 DATE 8-4-21
 DATE 8-16-21
 DATE 8-16-21
 DATE 8-16-21



DATE REVISED
 SHEET NO. 14
 SECTION


CONT. NO. 9584
 FILE BW24-261

-Bottom View Same as A11-

No.	Description of Parts	Material
1	Summary of Parts	Matl
2	10 Description of Parts	Matl
3	8 Towers Pier #17	14A
4	8 " " " " " "	17/14/2
5	8 " " " " " "	16/4/3
6	8 " " " " " "	14C
7	8 " " " " " "	14C
8	8 " " " " " "	14C
9	8 " " " " " "	14C
10	8 " " " " " "	14C
11	8 " " " " " "	14C
12	8 " " " " " "	14C
13	8 " " " " " "	14C
14	8 " " " " " "	14C
15	8 " " " " " "	14C
16	8 " " " " " "	14C
17	8 " " " " " "	14C
18	8 " " " " " "	14C
19	8 " " " " " "	14C
20	8 " " " " " "	14C
21	8 " " " " " "	14C
22	8 " " " " " "	14C
23	8 " " " " " "	14C
24	8 " " " " " "	14C
25	8 " " " " " "	14C
26	8 " " " " " "	14C
27	8 " " " " " "	14C
28	8 " " " " " "	14C
29	8 " " " " " "	14C
30	8 " " " " " "	14C
31	8 " " " " " "	14C
32	8 " " " " " "	14C
33	8 " " " " " "	14C
34	8 " " " " " "	14C
35	8 " " " " " "	14C
36	8 " " " " " "	14C
37	8 " " " " " "	14C
38	8 " " " " " "	14C
39	8 " " " " " "	14C
40	8 " " " " " "	14C
41	8 " " " " " "	14C
42	8 " " " " " "	14C
43	8 " " " " " "	14C
44	8 " " " " " "	14C
45	8 " " " " " "	14C
46	8 " " " " " "	14C
47	8 " " " " " "	14C
48	8 " " " " " "	14C
49	8 " " " " " "	14C
50	8 " " " " " "	14C


Base Matl.
 Base Pl. 15' x 8' x 2' (6) pld
 2.156 x 2.156 x 1.12 (32) aab
 4.15 x 5.5 x 1.03 (64) aac

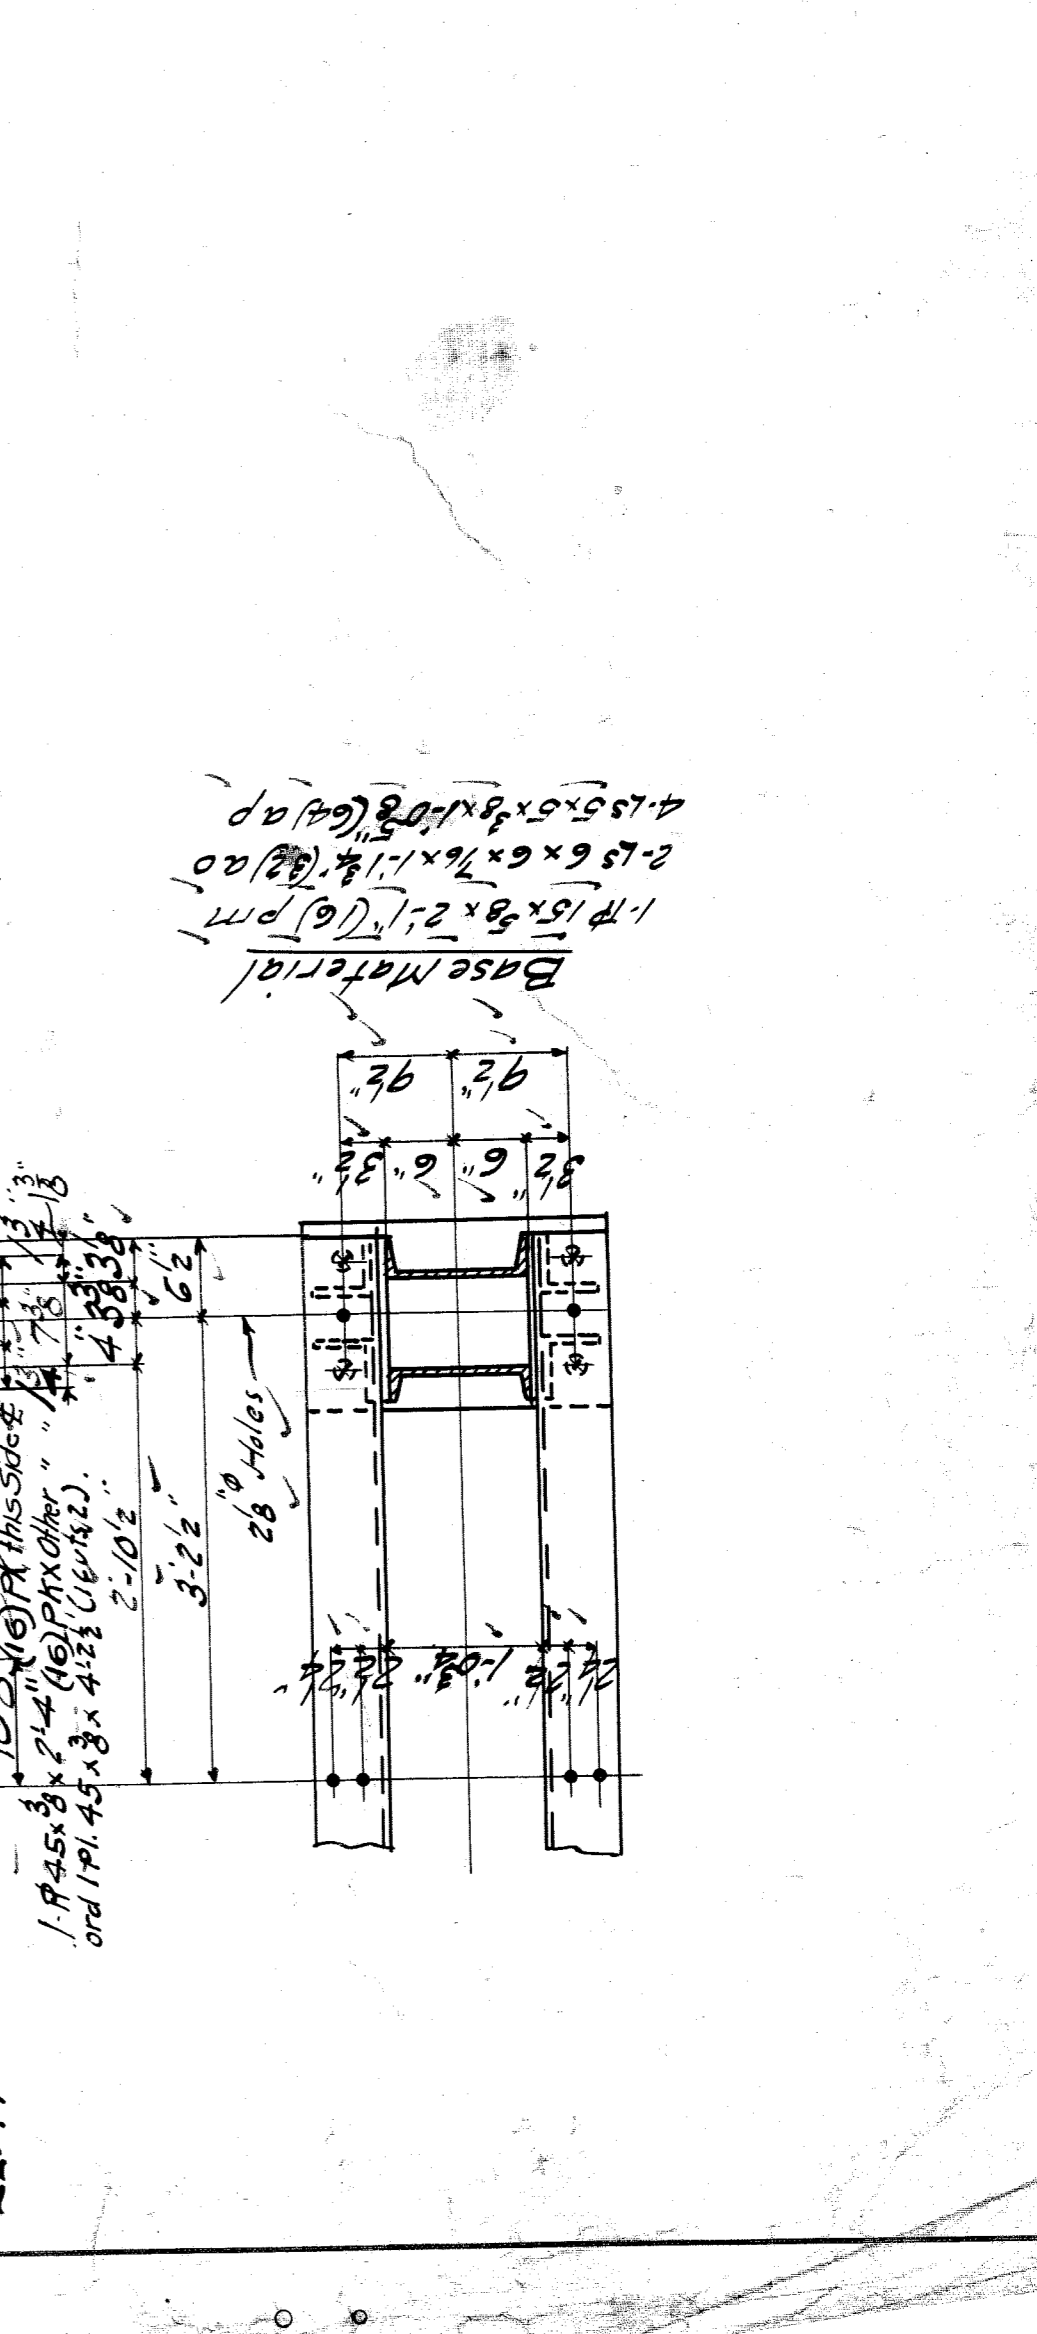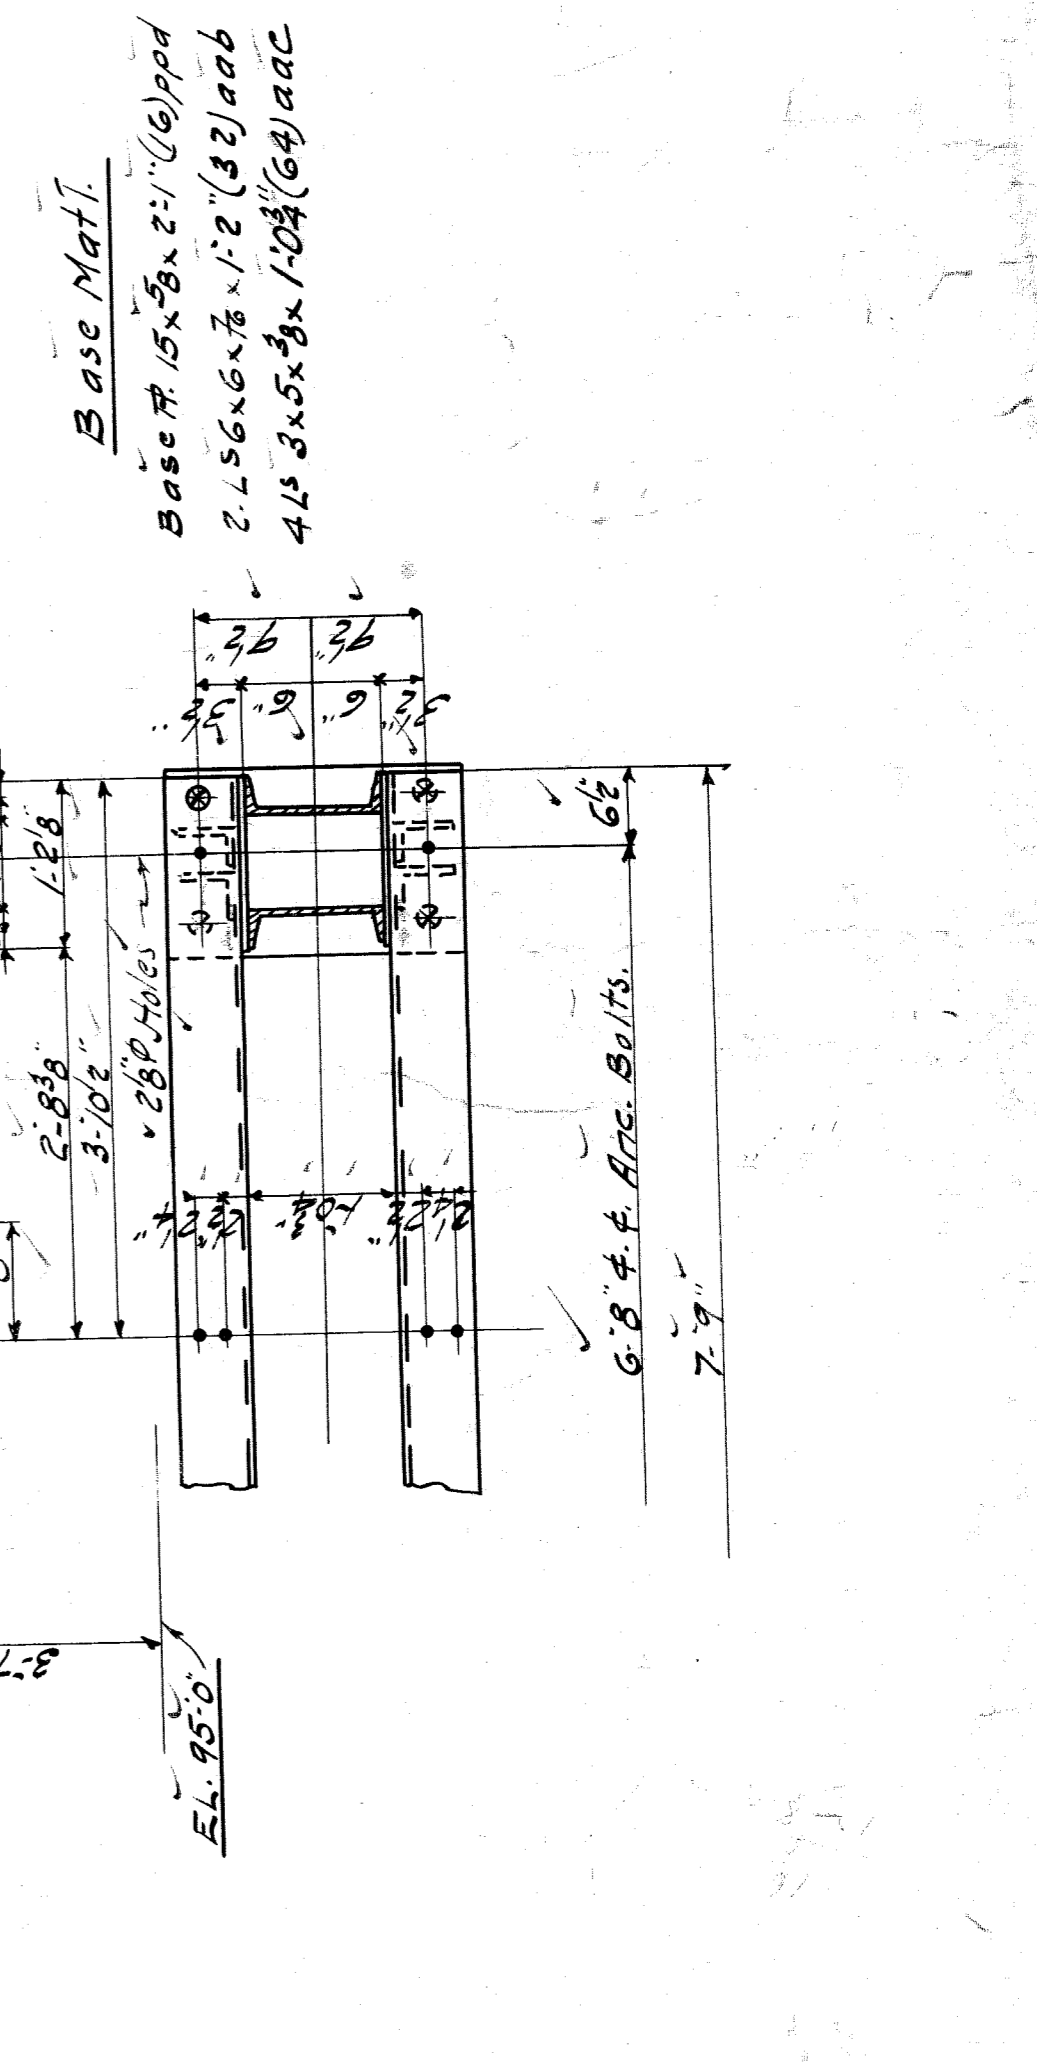

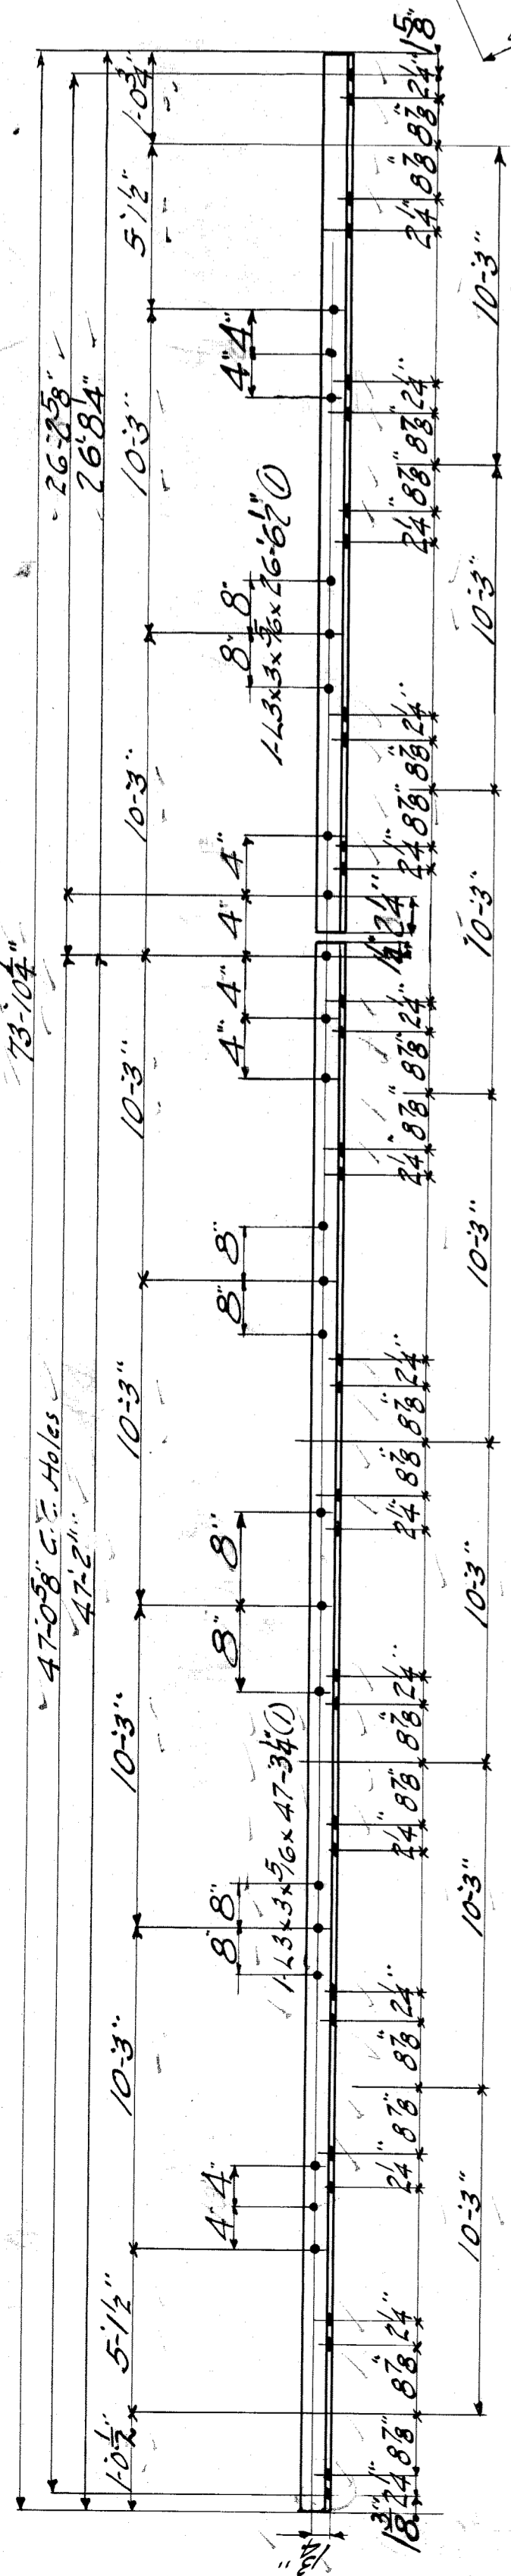


1-STRUT -1551-

1-STRUT -1552-

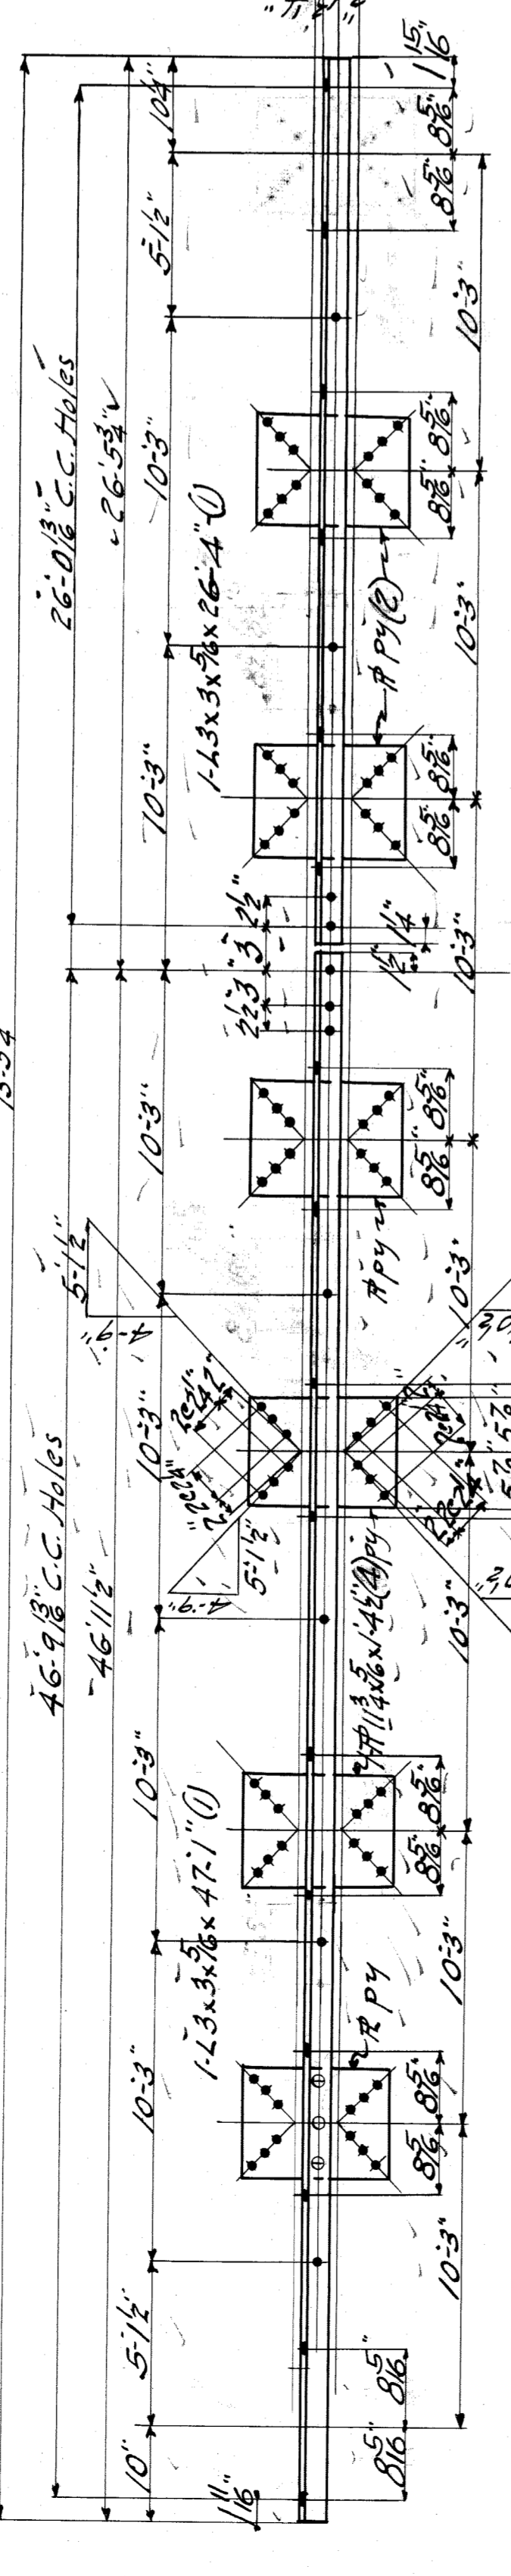


1-STRUT -1553-

1-STRUT -1554-

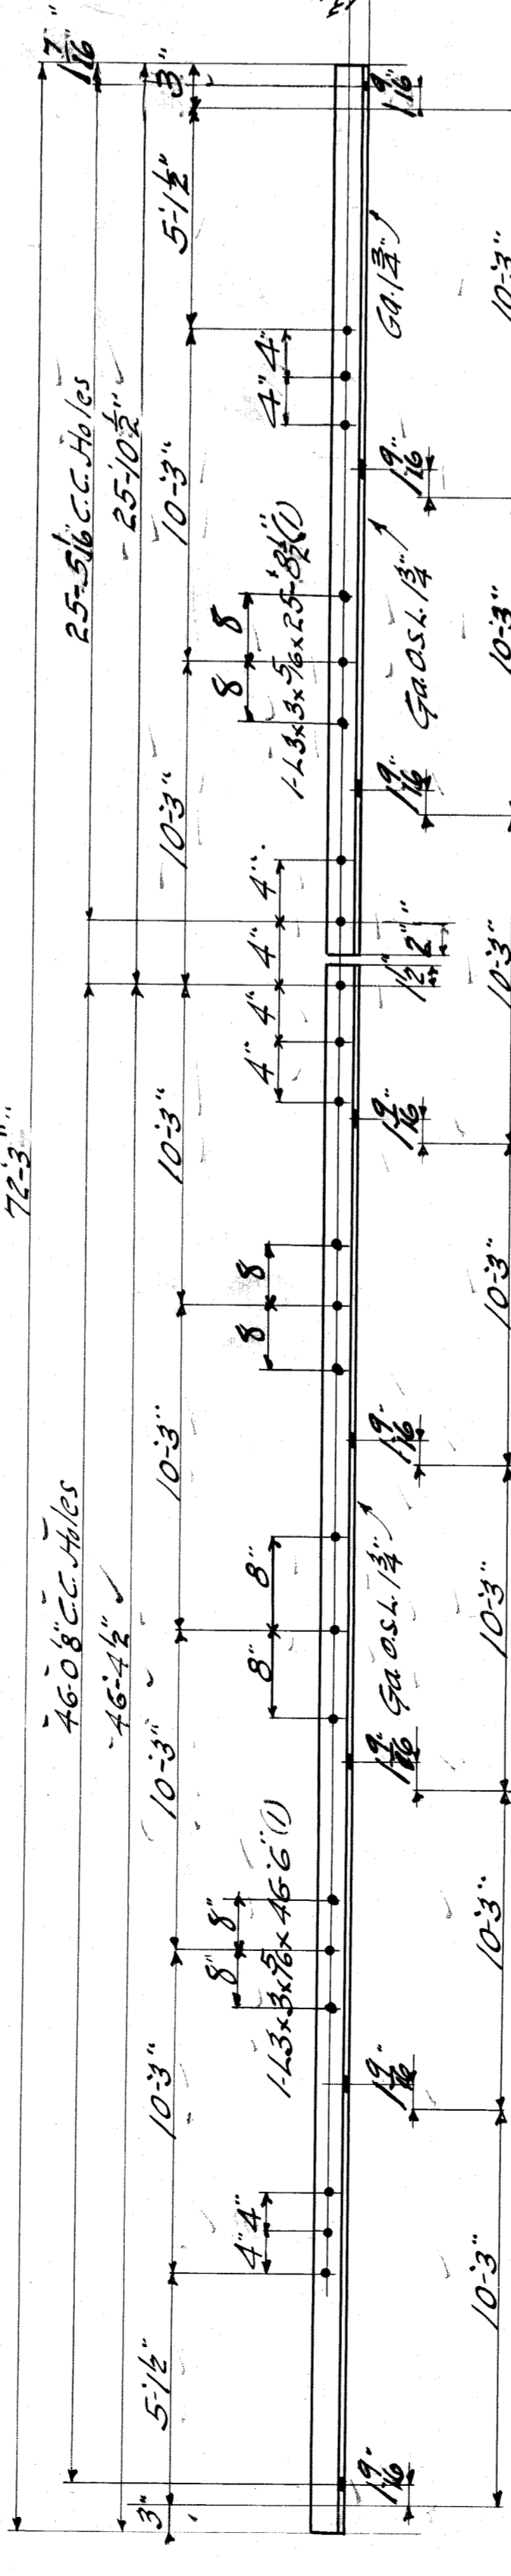


1-STRUT -1555-

1-STRUT -1556-

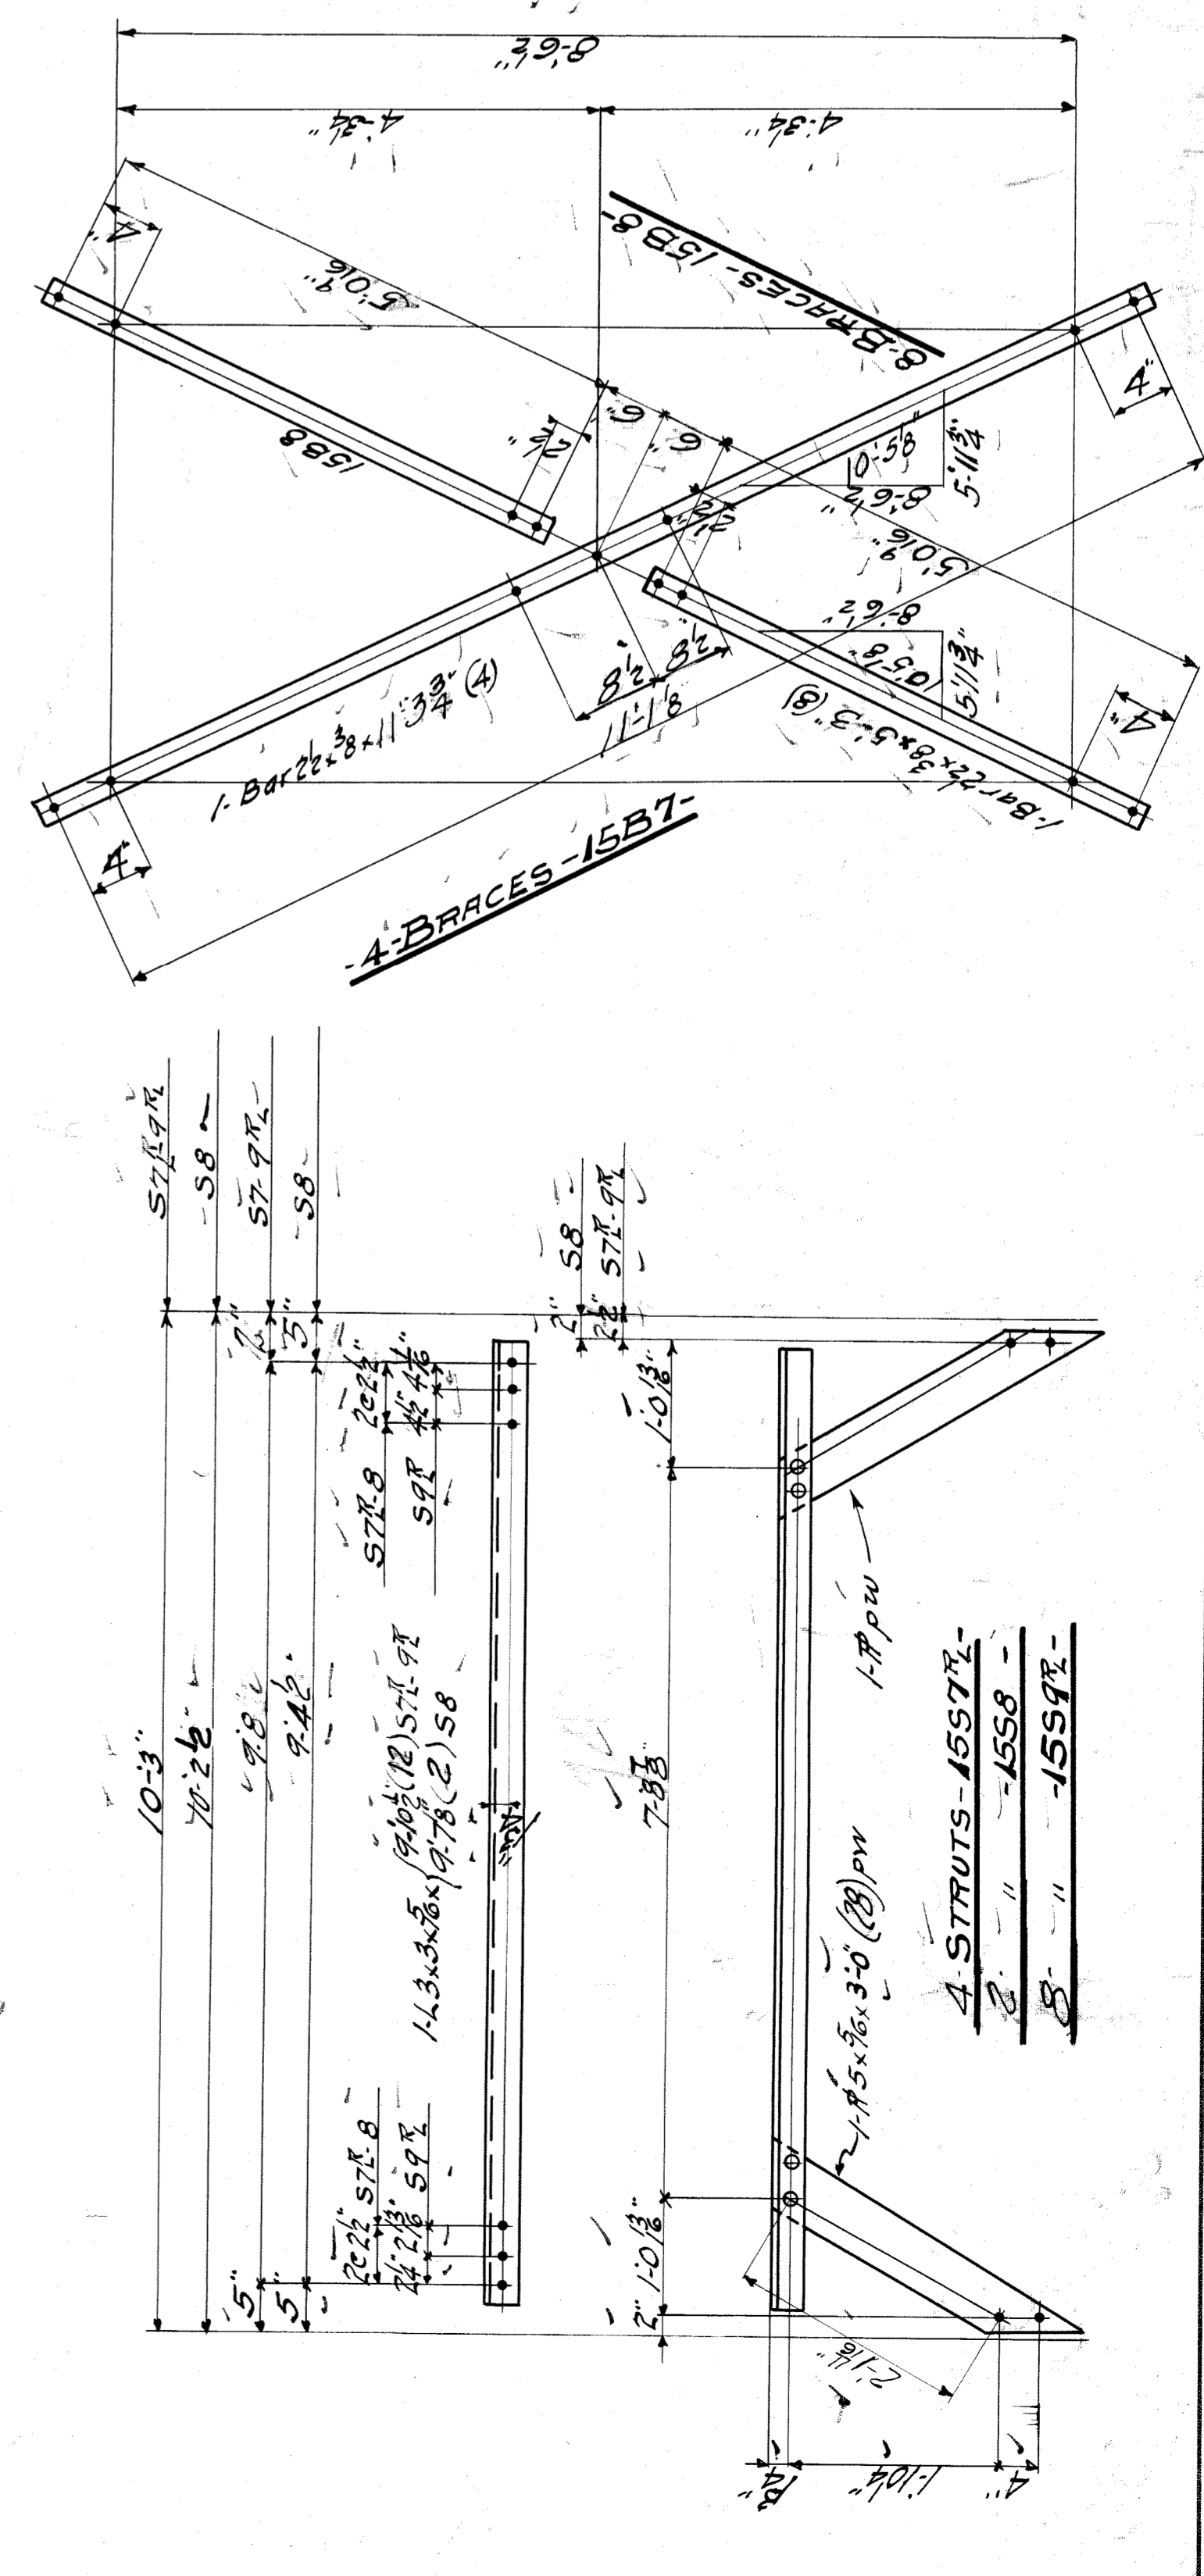

4-BRACES -1557-

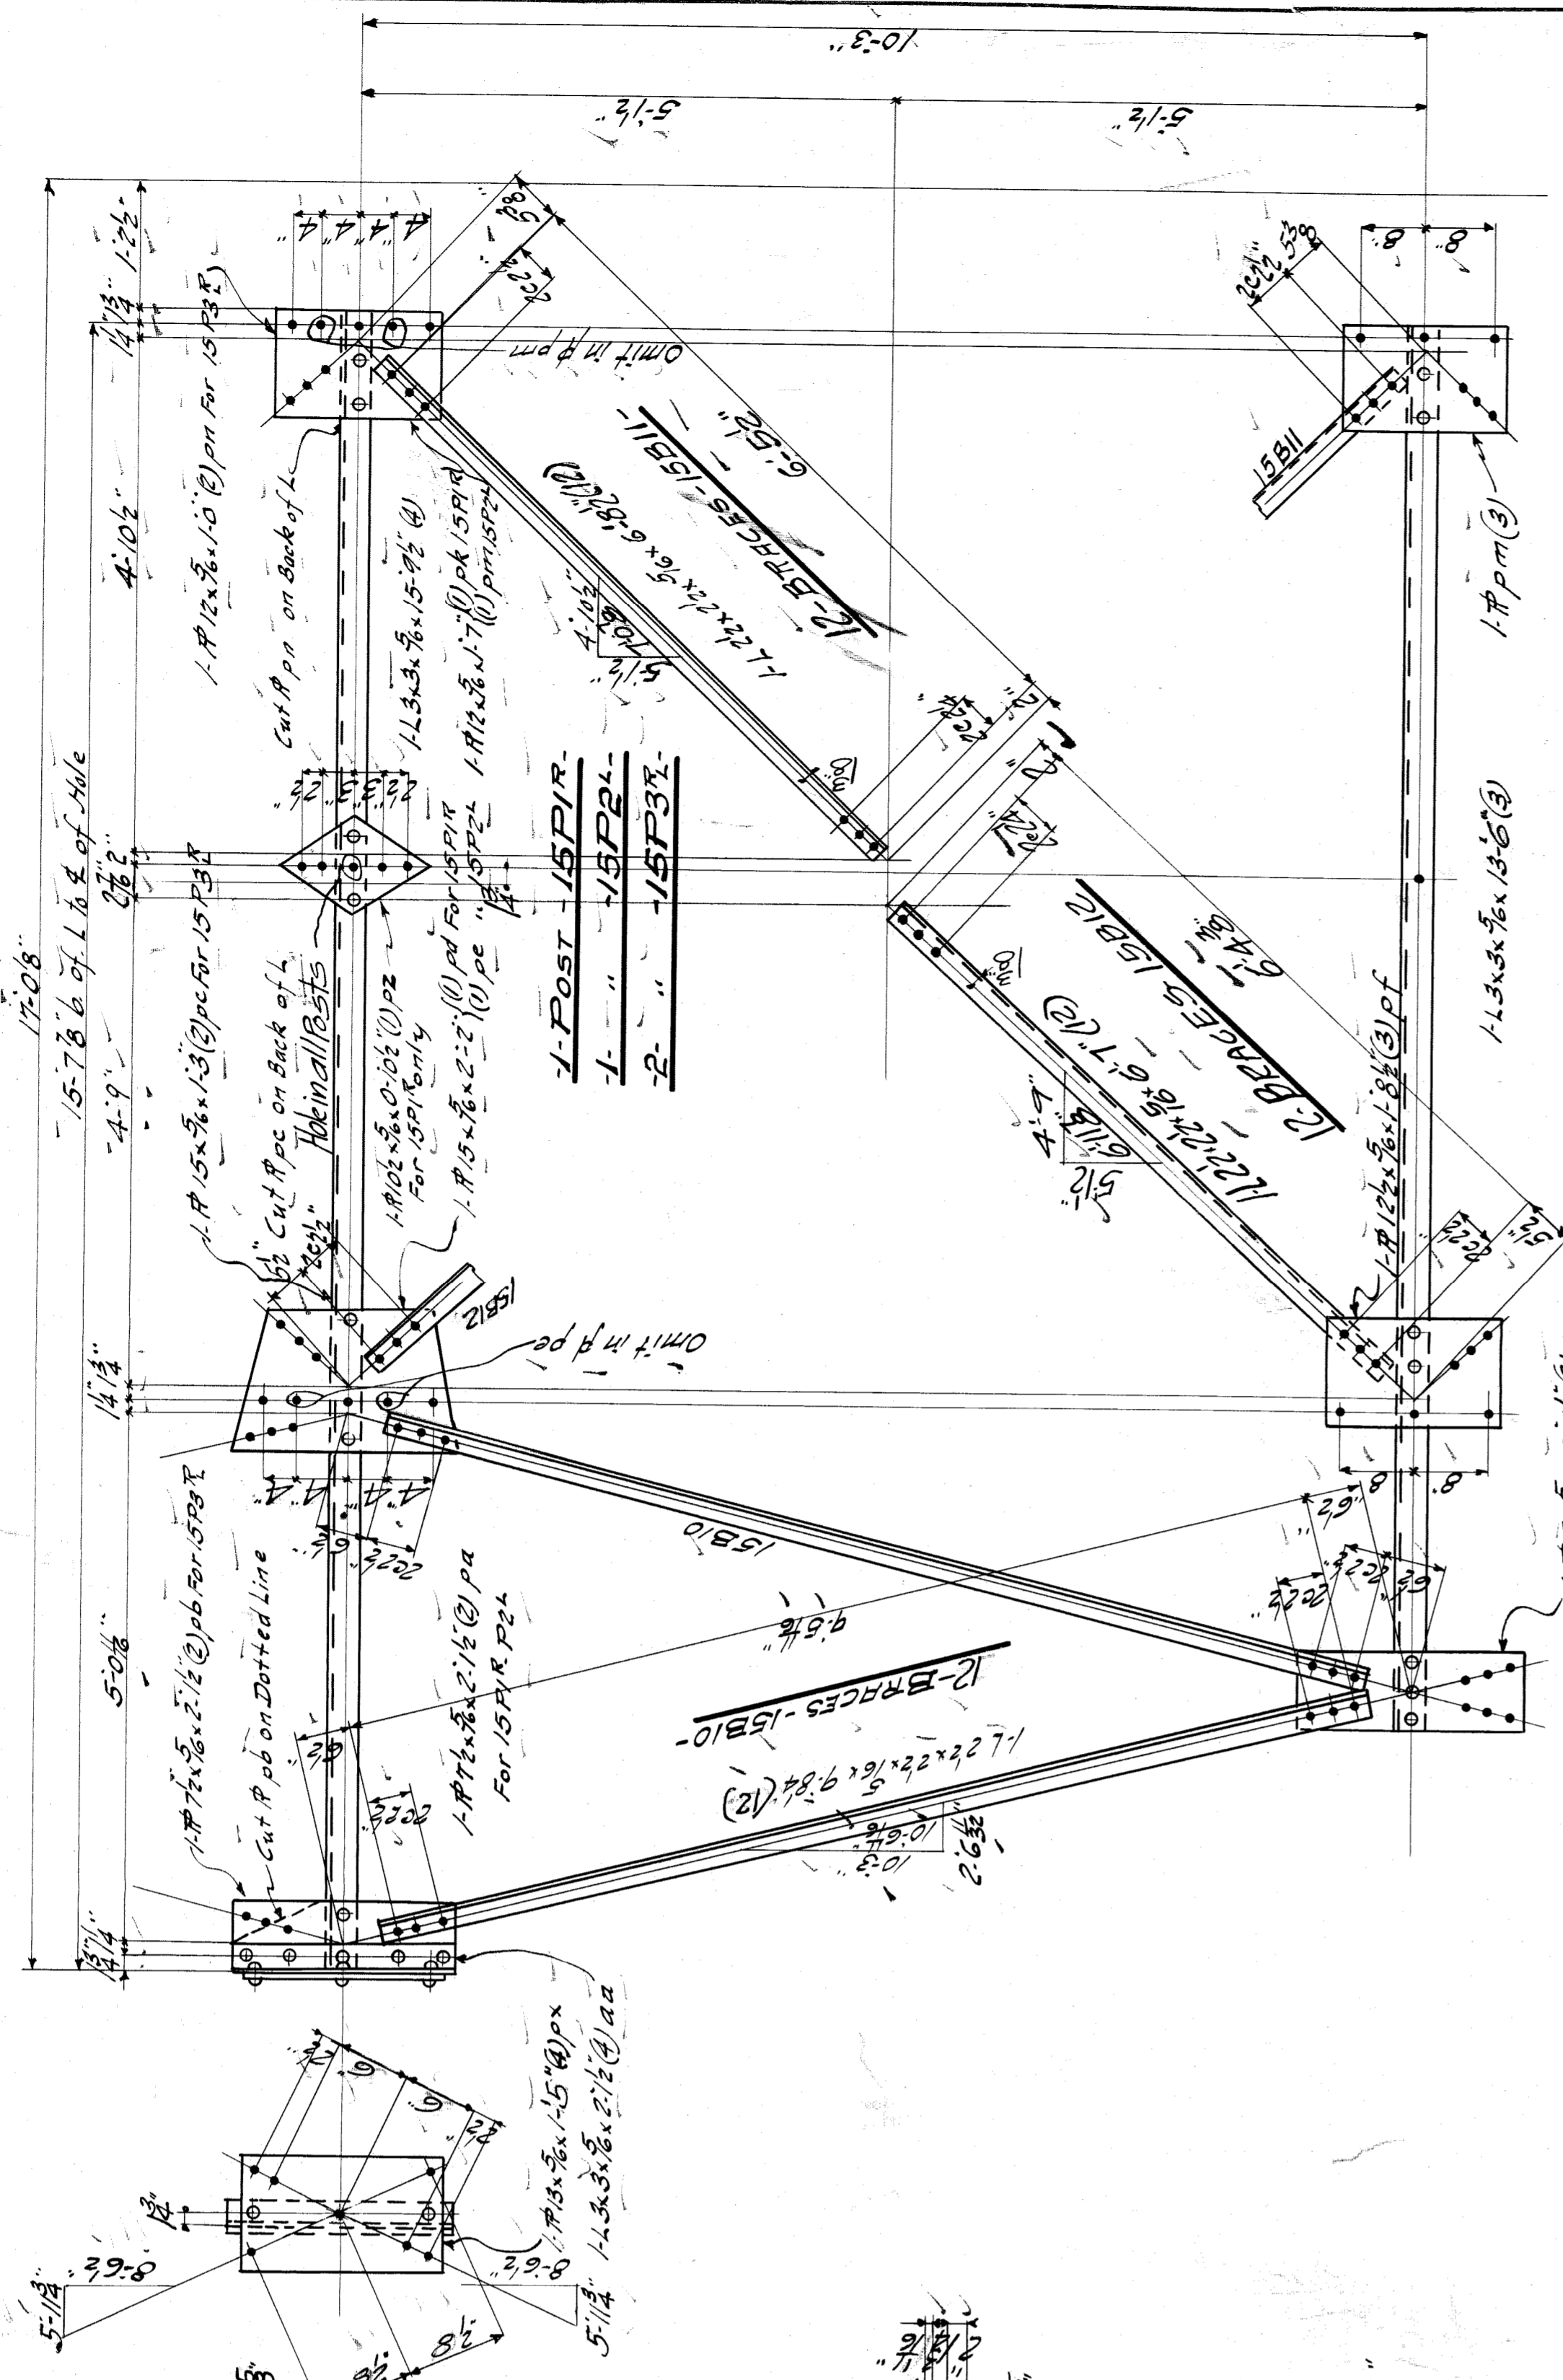

3-POSTS -15P1-

2-BRACES -15B1-

3-STRUTS -15S1-

MARKS	DESCRIPTION	QUANTITY
15S1	1-STRUT	109
15S2	"	109
15S3	"	109
15P1	1-POST	109
15P2	"	109
15P3	"	109
15B1	2-BRACES	109
15B2	"	109
15B3	"	109
15S4	4-BRACES	109
15S5	"	109
15S6	"	109
15S7	"	109
15S8	"	109
15S9	"	109
15S10	"	109
15S11	"	109
15S12	"	109
15S13	"	109
15S14	"	109
15S15	"	109
15S16	"	109
15S17	"	109
15S18	"	109
15S19	"	109
15S20	"	109
15S21	"	109
15S22	"	109
15S23	"	109
15S24	"	109
15S25	"	109
15S26	"	109
15S27	"	109
15S28	"	109
15S29	"	109
15S30	"	109

WISCONSIN BRIDGE & IRON CO.
NORTH MILWAUKEE, WISCONSIN

ERECTED BY
City of Detroit
Detroit, Mich.
DESCRIPTION Belle Isle Bridge
DETAILS OF Tower Spacing Pier #18

CONTRACT NO. 9384
LOCATION Detroit, Mich.
DESCRIPTION Belle Isle Bridge
DETAILS OF Tower Spacing Pier #18

INSPECTION BY
SPECIFICATIONS by Murphy & Reaming
FIELD PAINT None (See Specifications)
RIVETS 3/8" OPEN HOLES 1/8"

MADE BY LORAIN
DATE 7-20-21
EXCEPT AS NOTED


TRACED BY A.F.H.
DATE 7-22-21

CHECKED BY M.P.R. & F. Ed. by C.H.F.
DATE Nov 21

SCALE SECTION DATE REVISED SHEET NO. 15

9384

File BW201-262

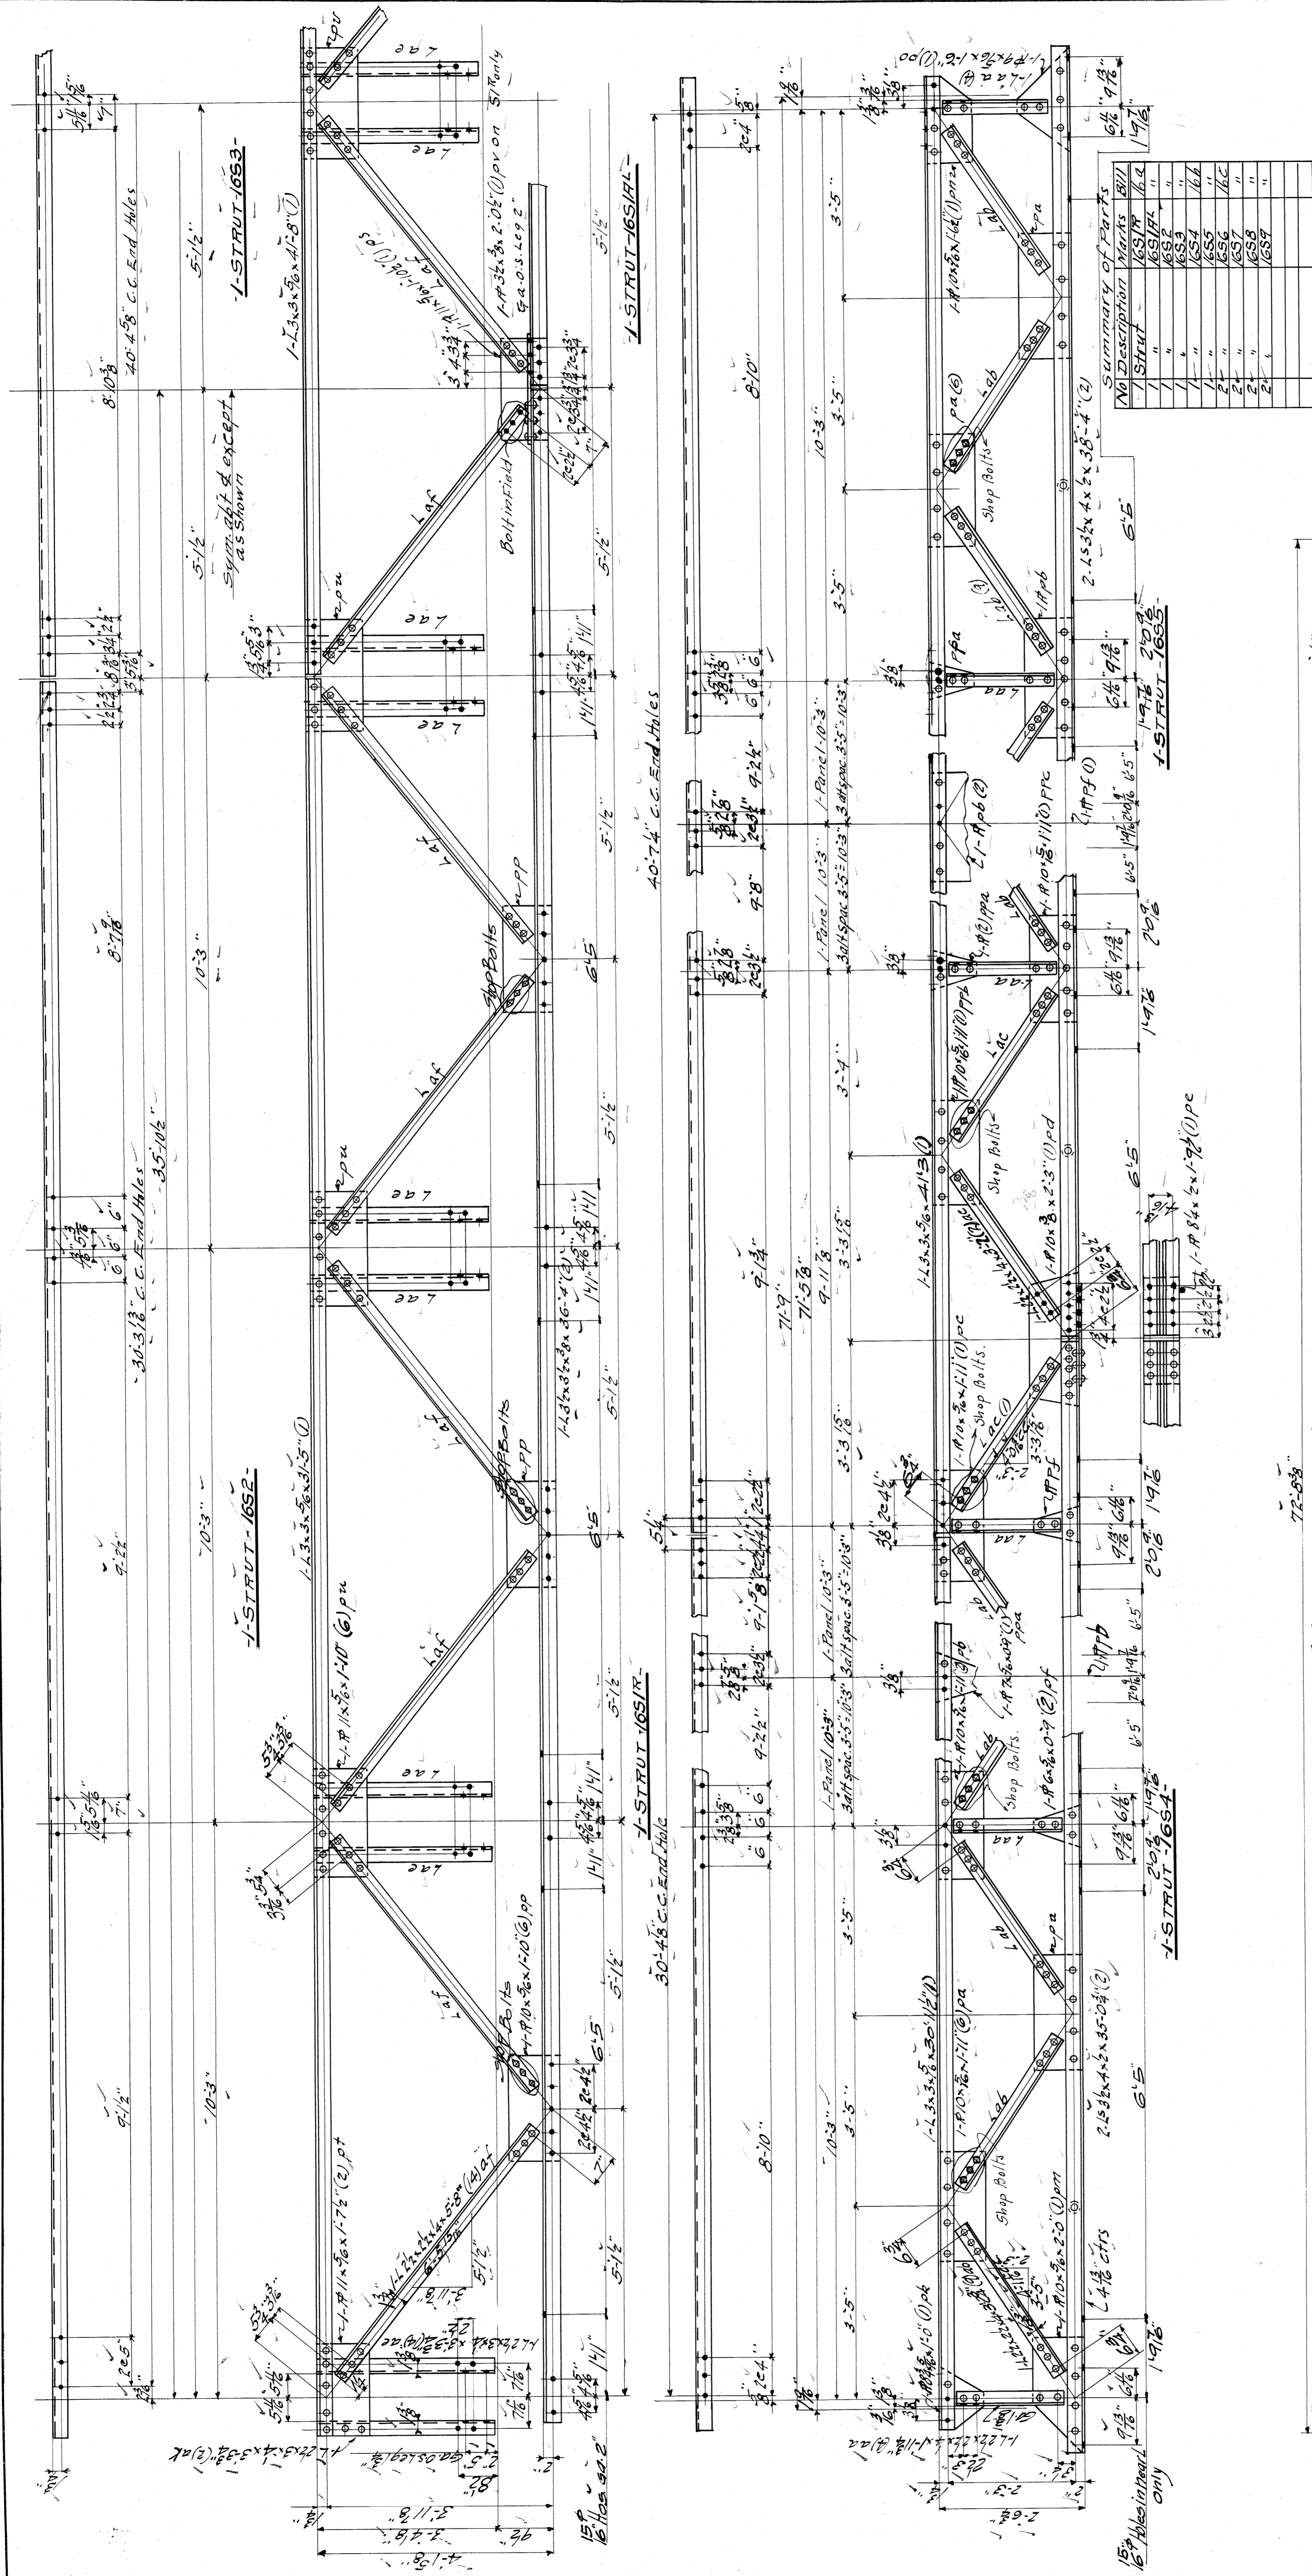

No.	Description	Marks	Qty
1	I-STRUT	1651	16
2	"	1652	16
3	"	1653	16
4	"	1654	16
5	"	1655	16
6	"	1656	16
7	"	1657	16

WISCONSIN BRIDGE & IRON CO.
 NORTH MILWAUKEE, WISCONSIN


ERECTED BY
 CONTRACT NO. 9384
 FOR City of Detroit
 LOCATION Detroit, Mich.
 DESCRIPTION Belle Isle Bridge
 DETAILS OF TRUSSES (Part #18) Left Arm



SPECIFICATIONS: Assemble by Murphy Reaming
 INSPECTION BY " (See Specifications)
 SHOP PAINT None
 FIELD PAINT None
 RIVETS 3/8" OPEN HOLES 1/8"

EXCEPT AS NOTED
 MADE BY S.M.
 TRACED BY E.M.M.
 CHECKED BY M.P. F. Ctd. by CNA DATE 11-2-21


DATE 8-2-21
 DATE 11-2-21

SCALE SECTION DATE REVISED SHEET NO. 16

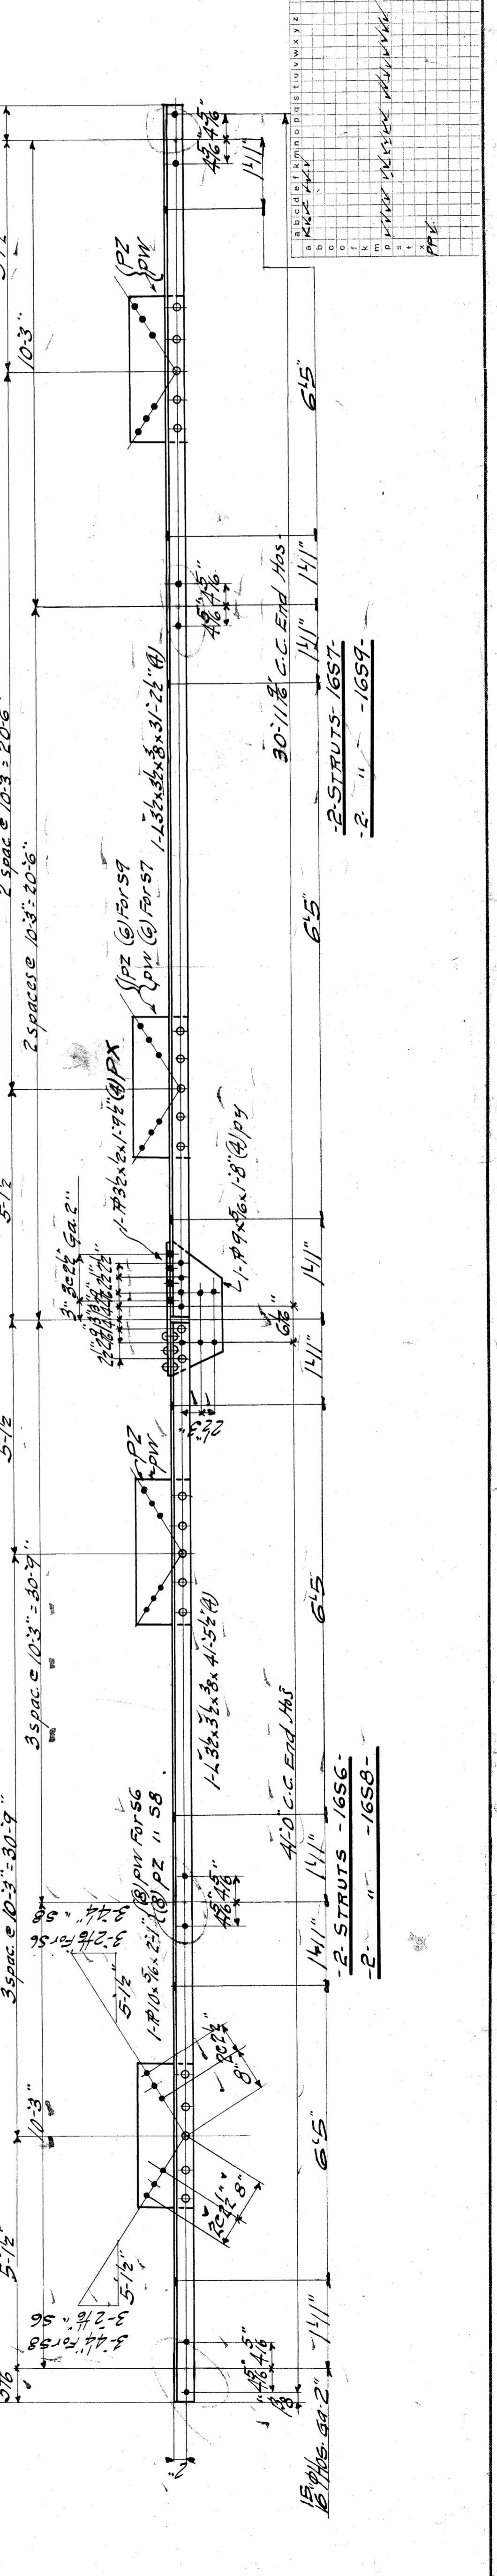

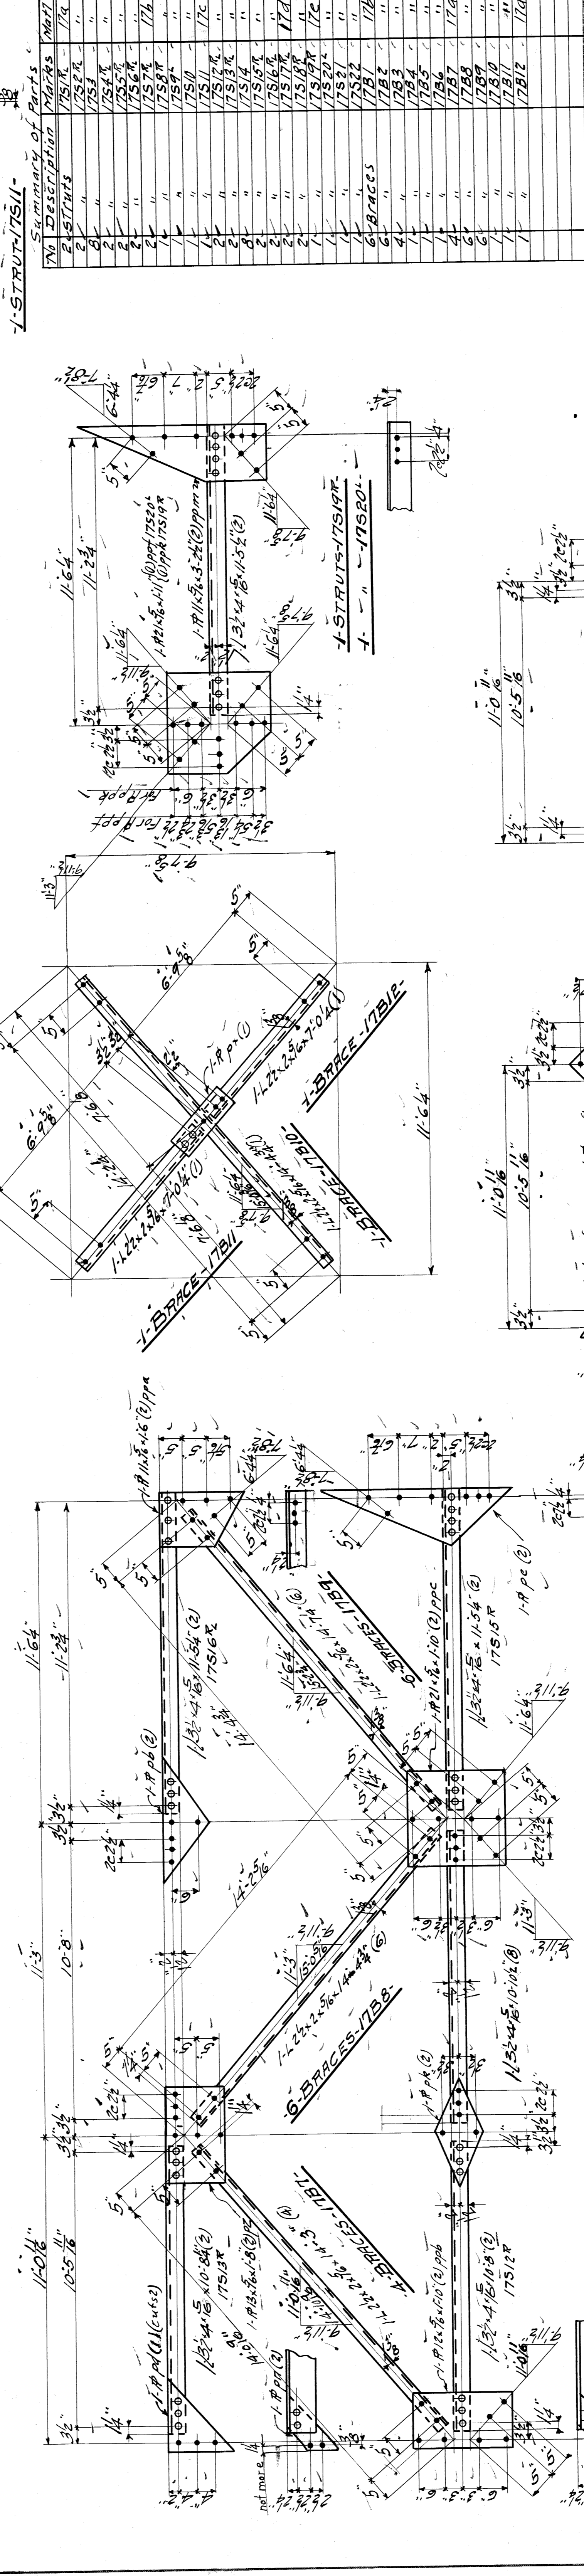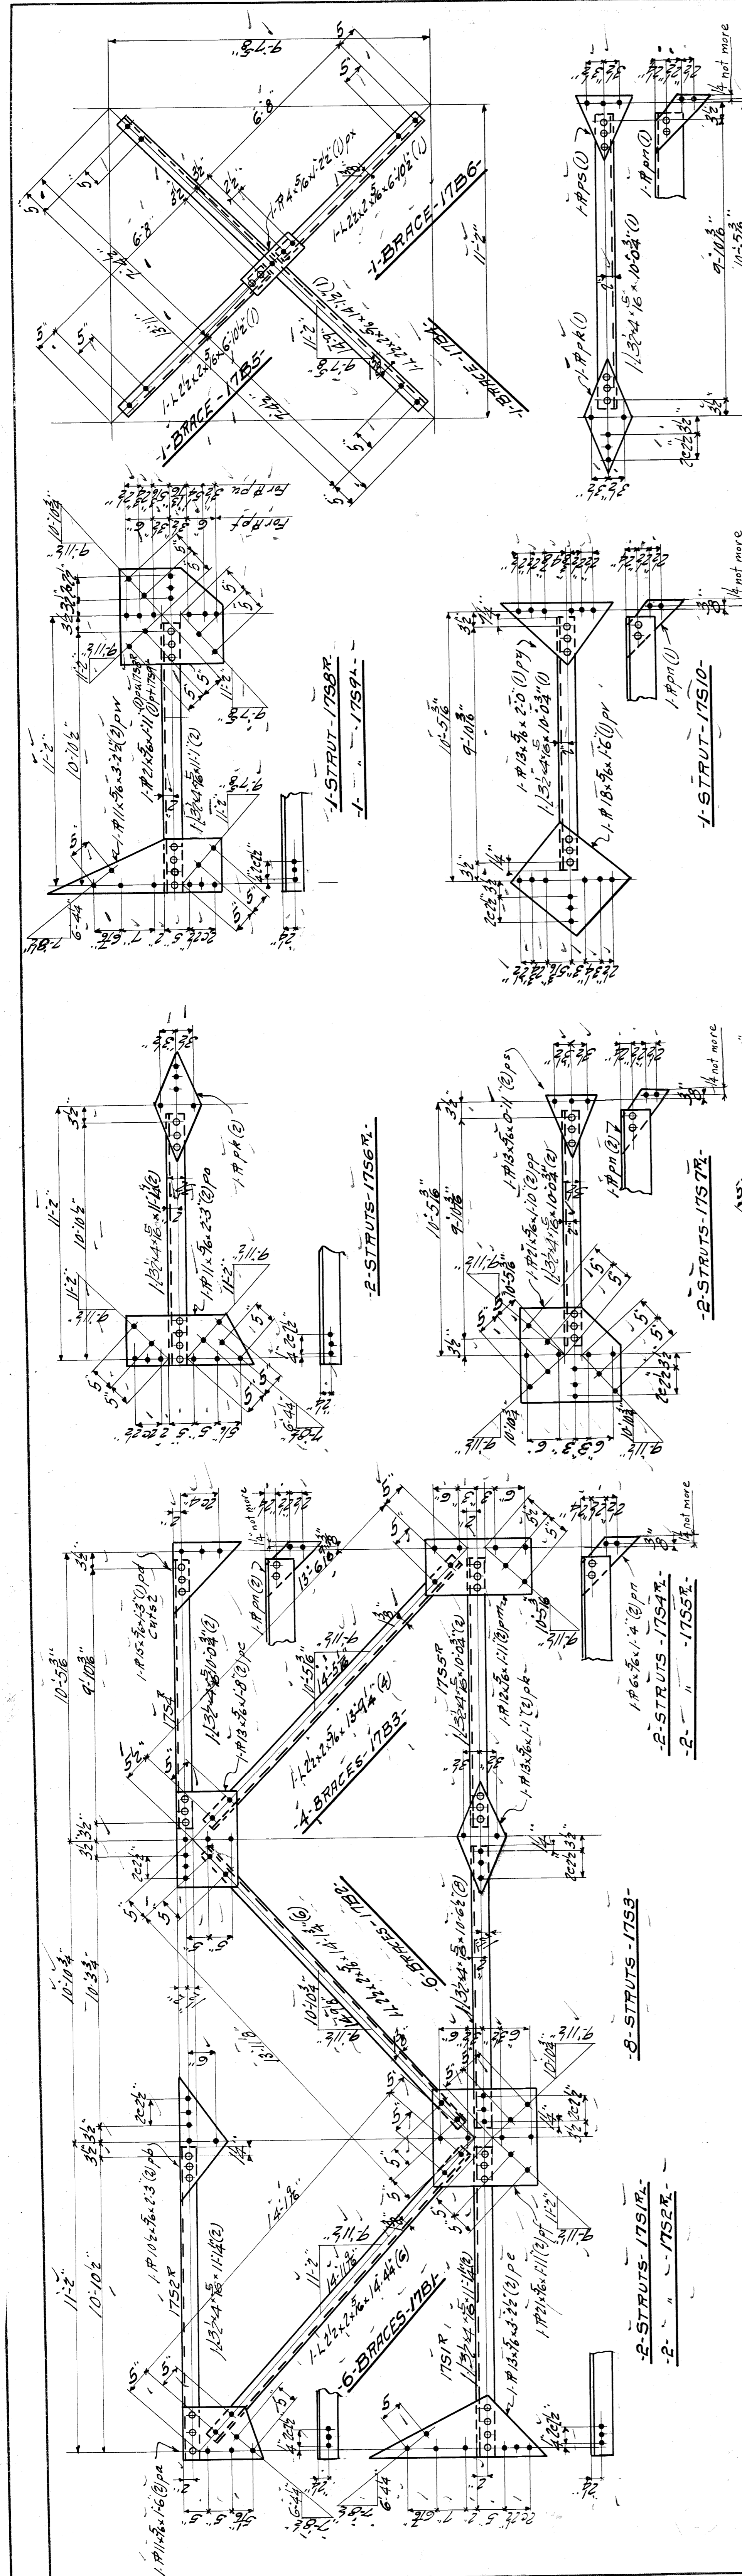

No.	Description	Quantity	Material
1	"	"	"
2	"	"	"
3	"	"	"
4	"	"	"
5	"	"	"
6	"	"	"
7	"	"	"
8	"	"	"
9	"	"	"
10	"	"	"
11	"	"	"
12	"	"	"
13	"	"	"
14	"	"	"
15	"	"	"
16	"	"	"
17	"	"	"
18	"	"	"
19	"	"	"
20	"	"	"
21	"	"	"
22	"	"	"
23	"	"	"
24	"	"	"
25	"	"	"
26	"	"	"
27	"	"	"
28	"	"	"
29	"	"	"
30	"	"	"

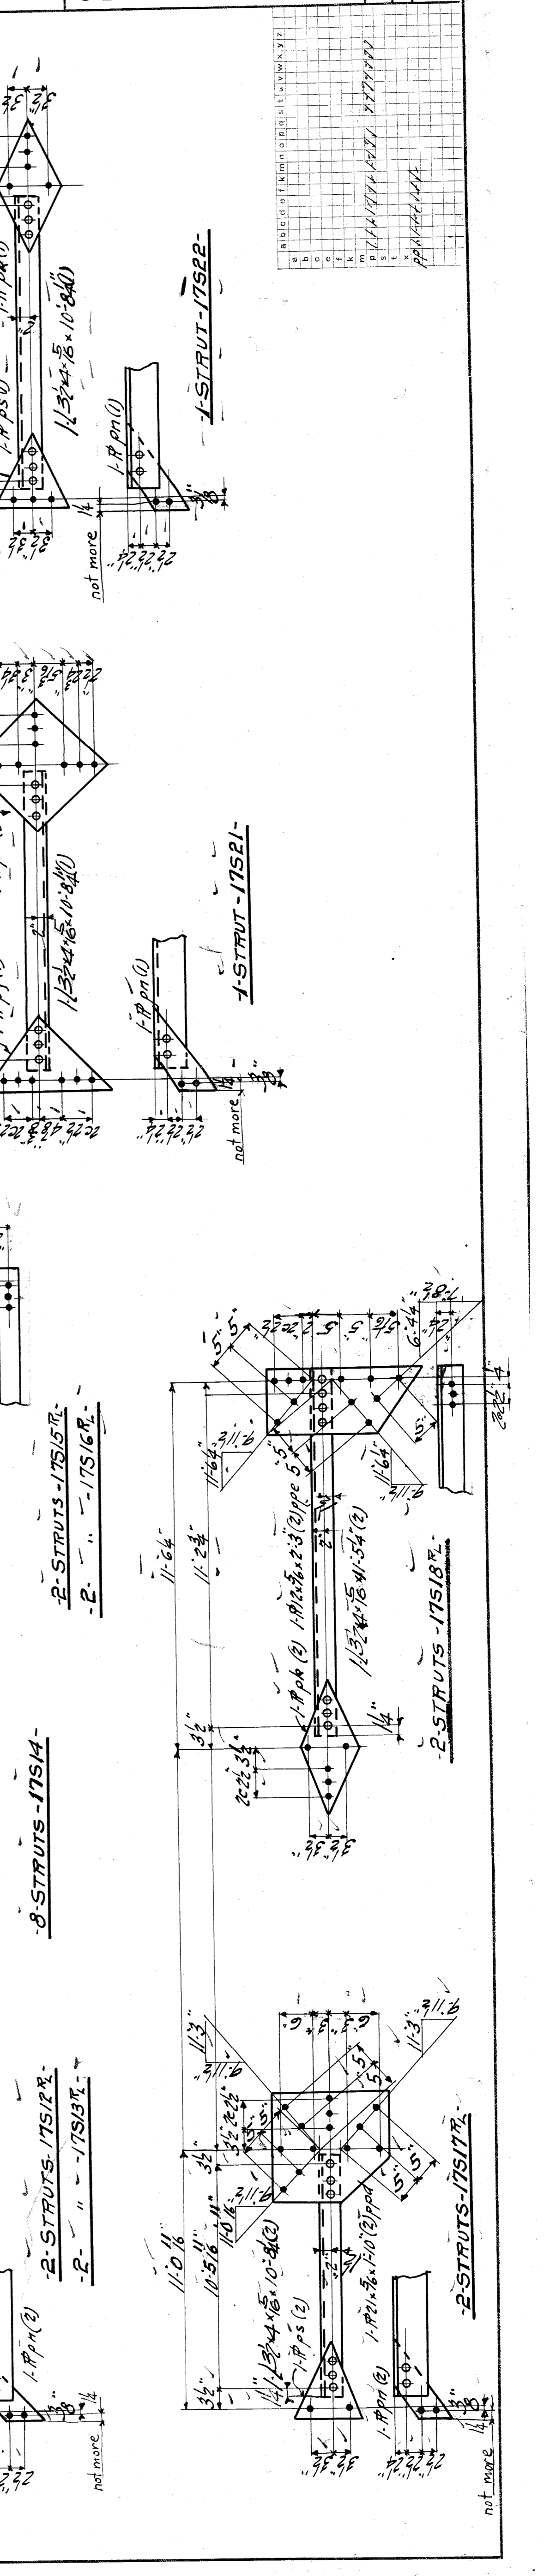

WISCONSIN BRIDGE & IRON CO.
NORTH MILWAUKEE, WISCONSIN

ERECTED BY
CONTRACT NO. 9384
FOR City of Detroit
LOCATION - Detroit, Mich.
DESCRIPTION - Belle Isle Bridge
DETAILS OF Struts & Bracing Pier # 16

INSPECTED BY
SPECIFICATIONS Ass'n by Murphy Reaming & Co.
SHOP PAINT None

RIVETS
FIELD PAINT None
OPEN HOLES


MADE BY C. Lemke
TRACED BY E. T. Ruppel
CHECKED BY W. L. M. F. Chab. by C. M. A.

DATE 12/21/21
DATE 1/17/21
DATE 1/12/21

SHEET NO. 17

SECTION

SCALE

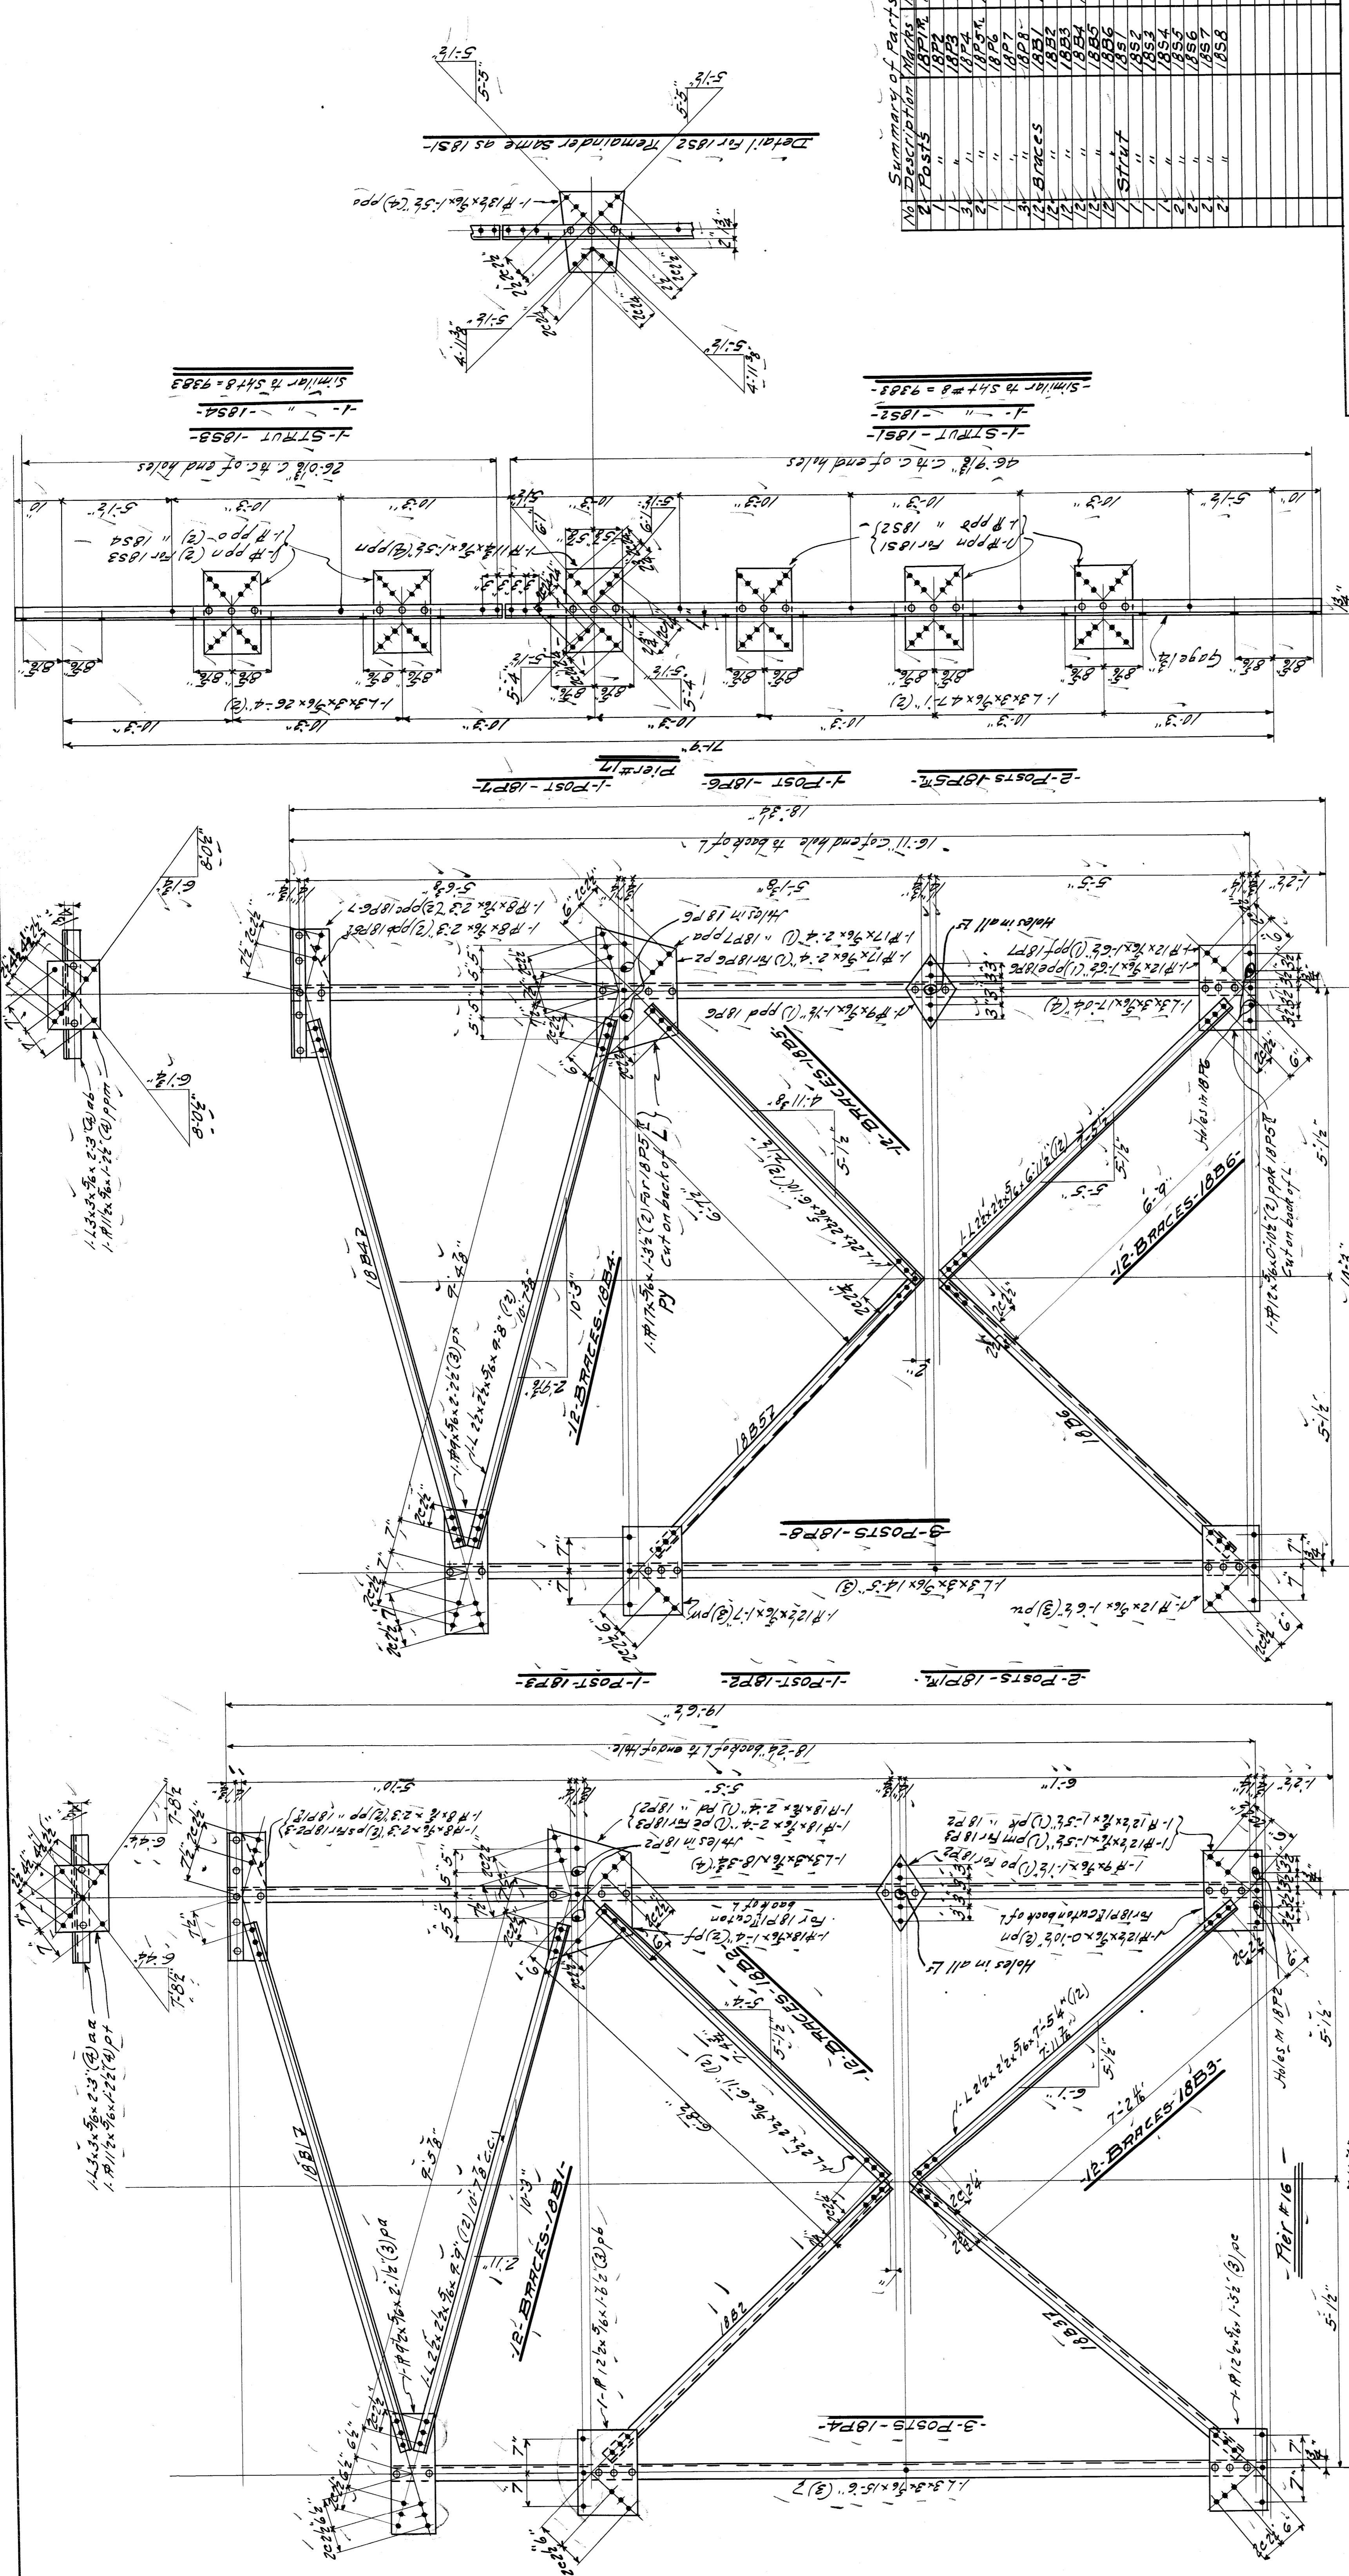


WISCONSIN BRIDGE & IRON CO.
 NORTH MILWAUKEE, WISCONSIN






ERECTED BY
City of Detroit
 LOCATION **Detroit, Mich.**
 DESCRIPTION **Belle Isle Bridge**
 DETAILS OF **TOWER BRACING**
 SPECIFICATIONS **AS NOTED**
 INSPECTION BY **None** (See Specifications)
 SHOP PAINT **None**
 FIELD PAINT **None**
 RIVETS $\frac{3}{4}$ " OPEN HOLES $\frac{1}{8}$ "
 MADE BY **M. H. P.** DATE **8-6-21**
 TRACED BY **L. B. M.** DATE **8-19-21**
 CHECKED BY **F. C. M.** DATE **8-19-21**

CONTRACT NO. **9384**
 SHEET NO. **18**

Summary of parts

No.	Description	Quantity	Notes
1	POSTS	18P1	
2	"	18P2	
3	"	18P3	
4	"	18P4	
5	"	18P5	
6	"	18P6	
7	"	18P7	
8	BRACES	18B1	
9	"	18B2	
10	"	18B3	
11	"	18B4	
12	"	18B5	
13	"	18B6	
14	"	18B7	
15	"	18B8	
16	STAYS	18S1	
17	"	18S2	
18	"	18S3	
19	"	18S4	
20	"	18S5	
21	"	18S6	
22	"	18S7	
23	"	18S8	

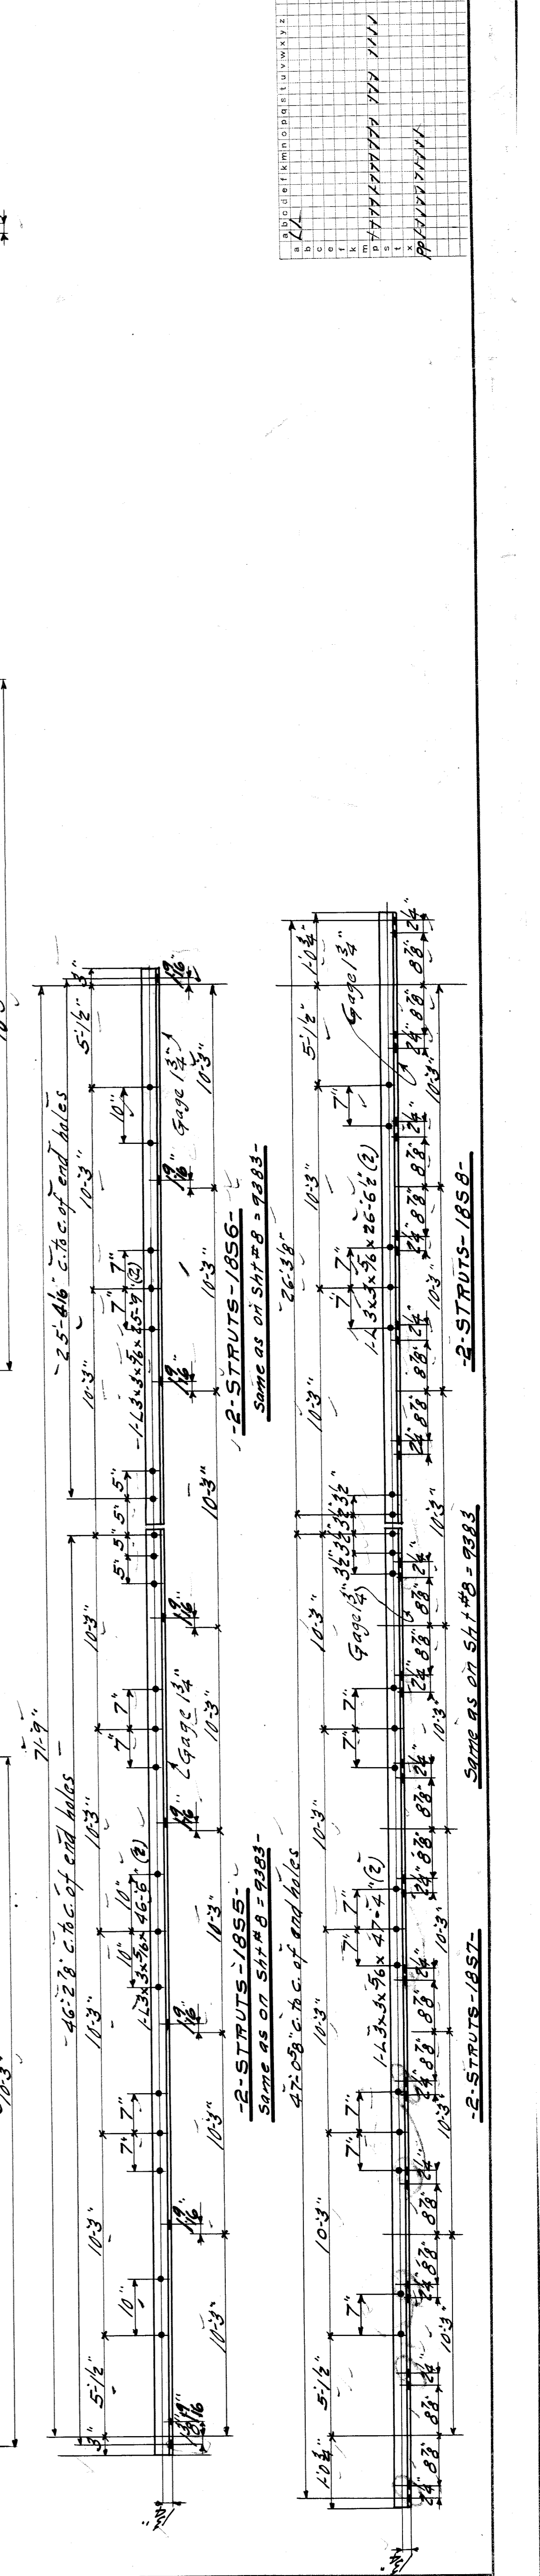

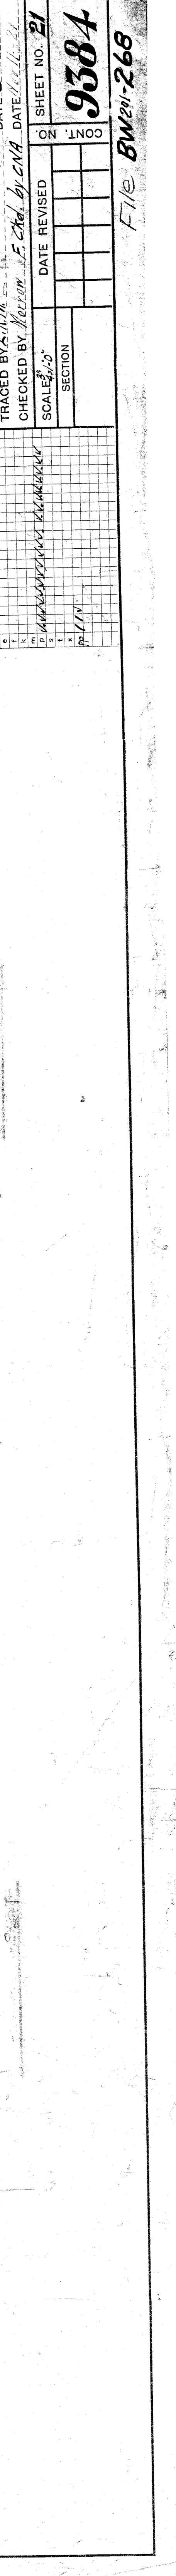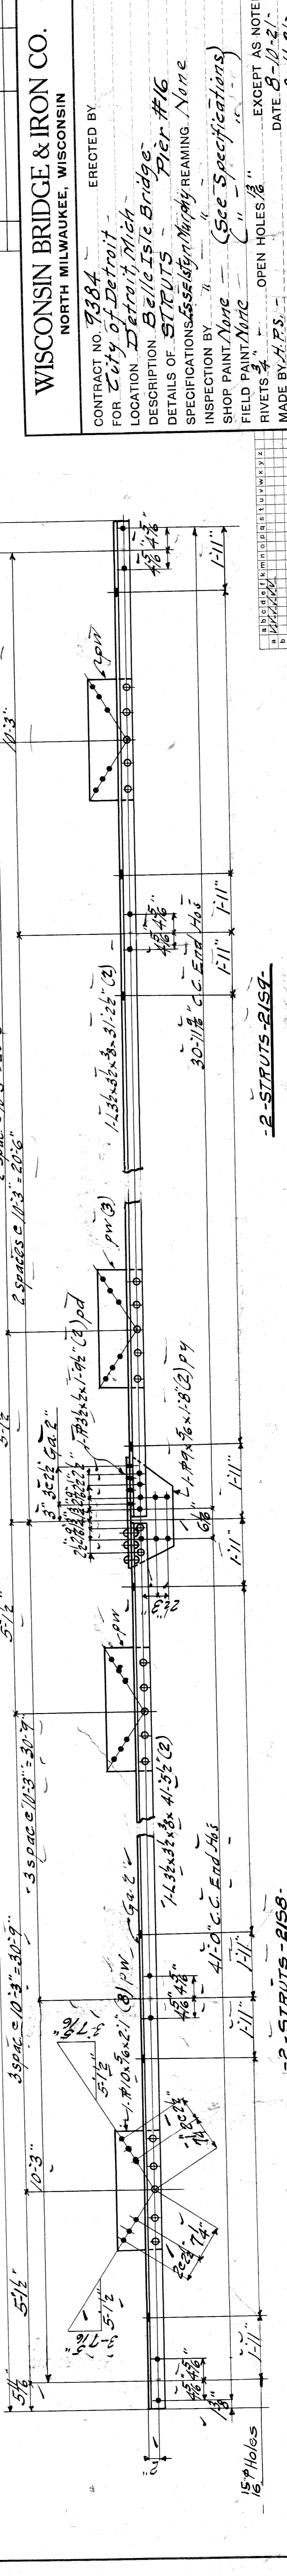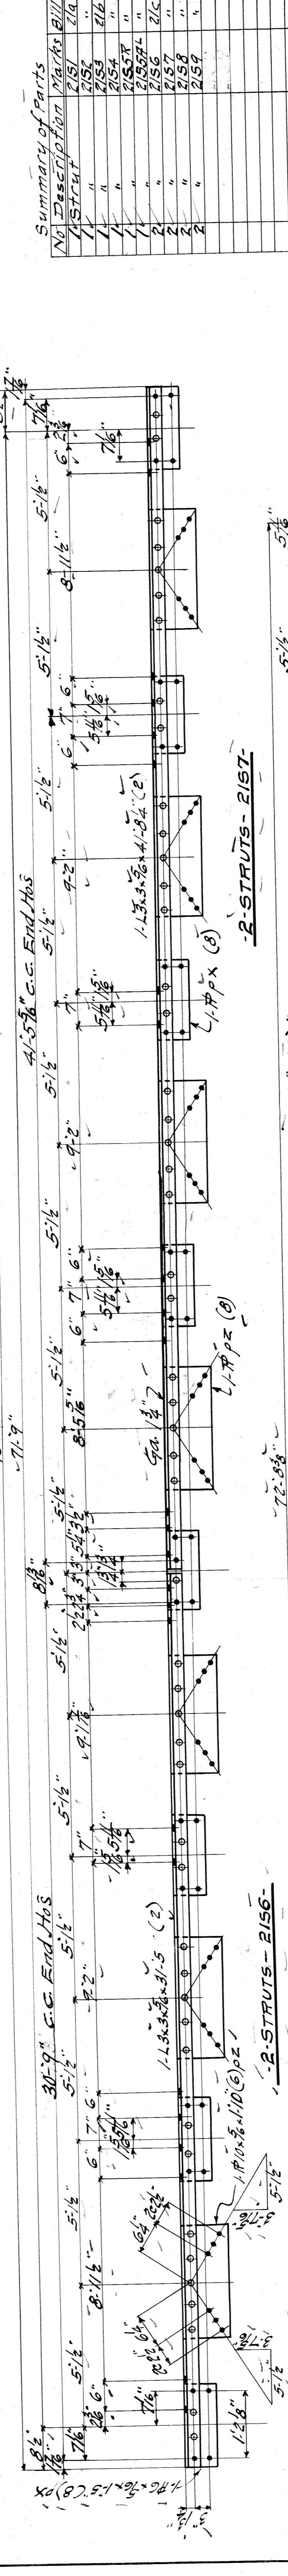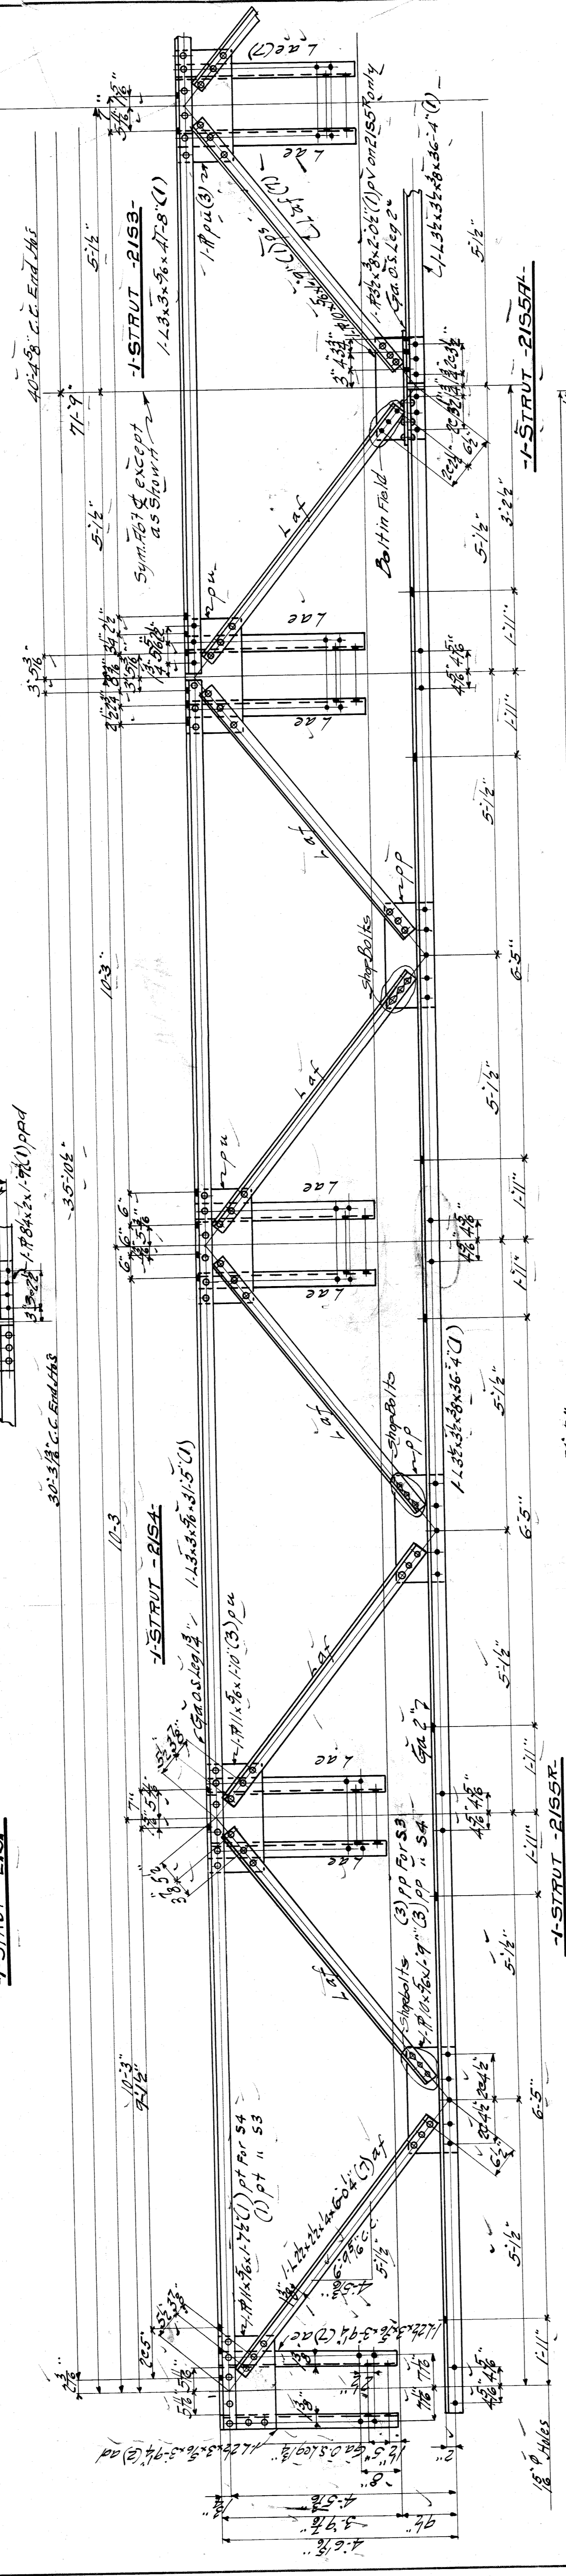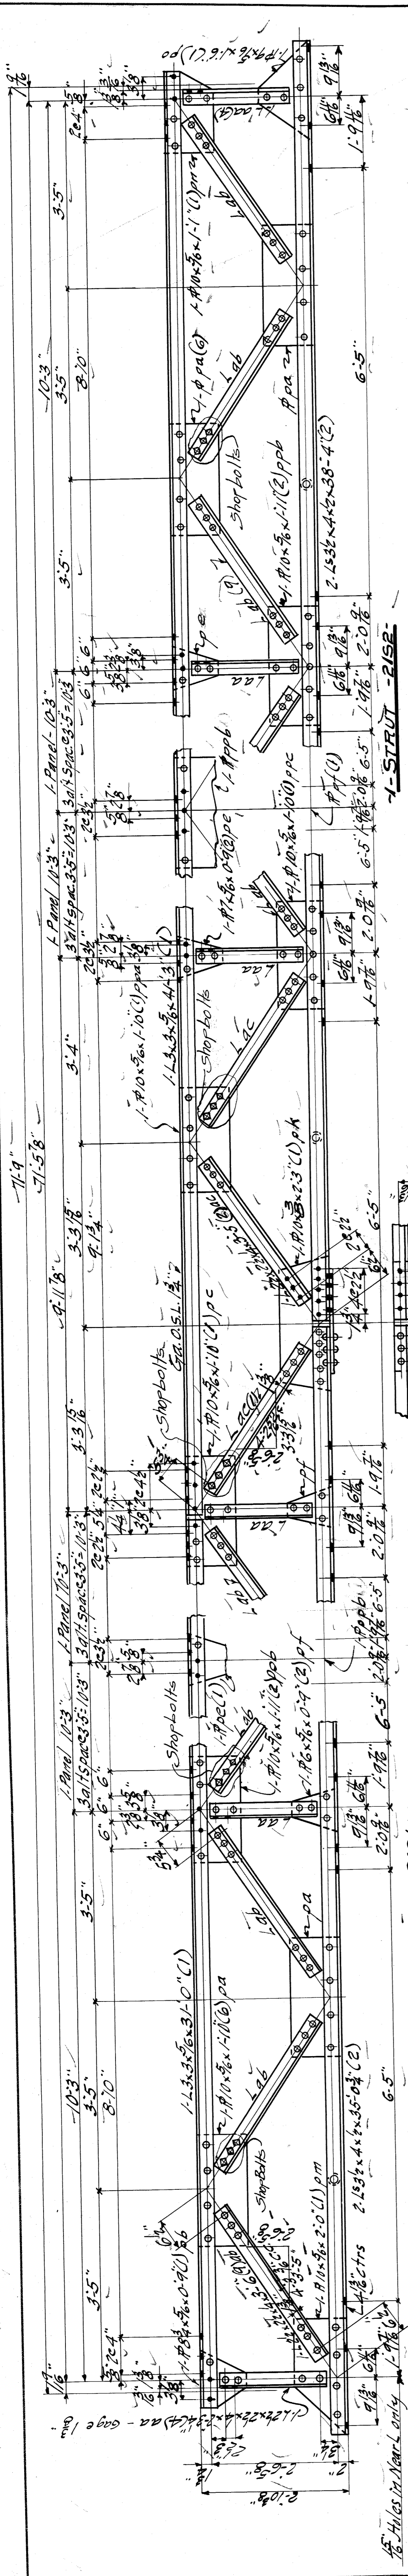

Summary of Parts

No.	Description	Quantity	Notes
1	I-STRUT	2151	
2	"	2152	
3	"	2153	
4	"	2154	
5	"	2155	
6	"	2156	
7	"	2157	
8	"	2158	
9	"	2159	

WISCONSIN BRIDGE & IRON CO.
 NORTH MILWAUKEE, WISCONSIN

ERECTED BY
City of Detroit
 LOCATION **Detroit, Mich**
 DESCRIPTION **Bellevue Bridge**
 DETAILS OF **STRUTS** **Pier #16**
 SPECIFICATIONS **See Design Manual**
 INSPECTION BY **None**
 SHOP PAINT **None**
 FIELD PAINT **None**
 RIVETS **OPEN HOLES**
 MADE BY **H.F.S.**
 TRACED BY **F.T.M.**
 CHECKED BY **M.H.W.**
 SCALE **1/4" = 1'-0"**
 SHEET NO. **21**
 OF **1703**
9384
 FILE **BW21-268**