



Drainage Plan
SCALE 1"=50'

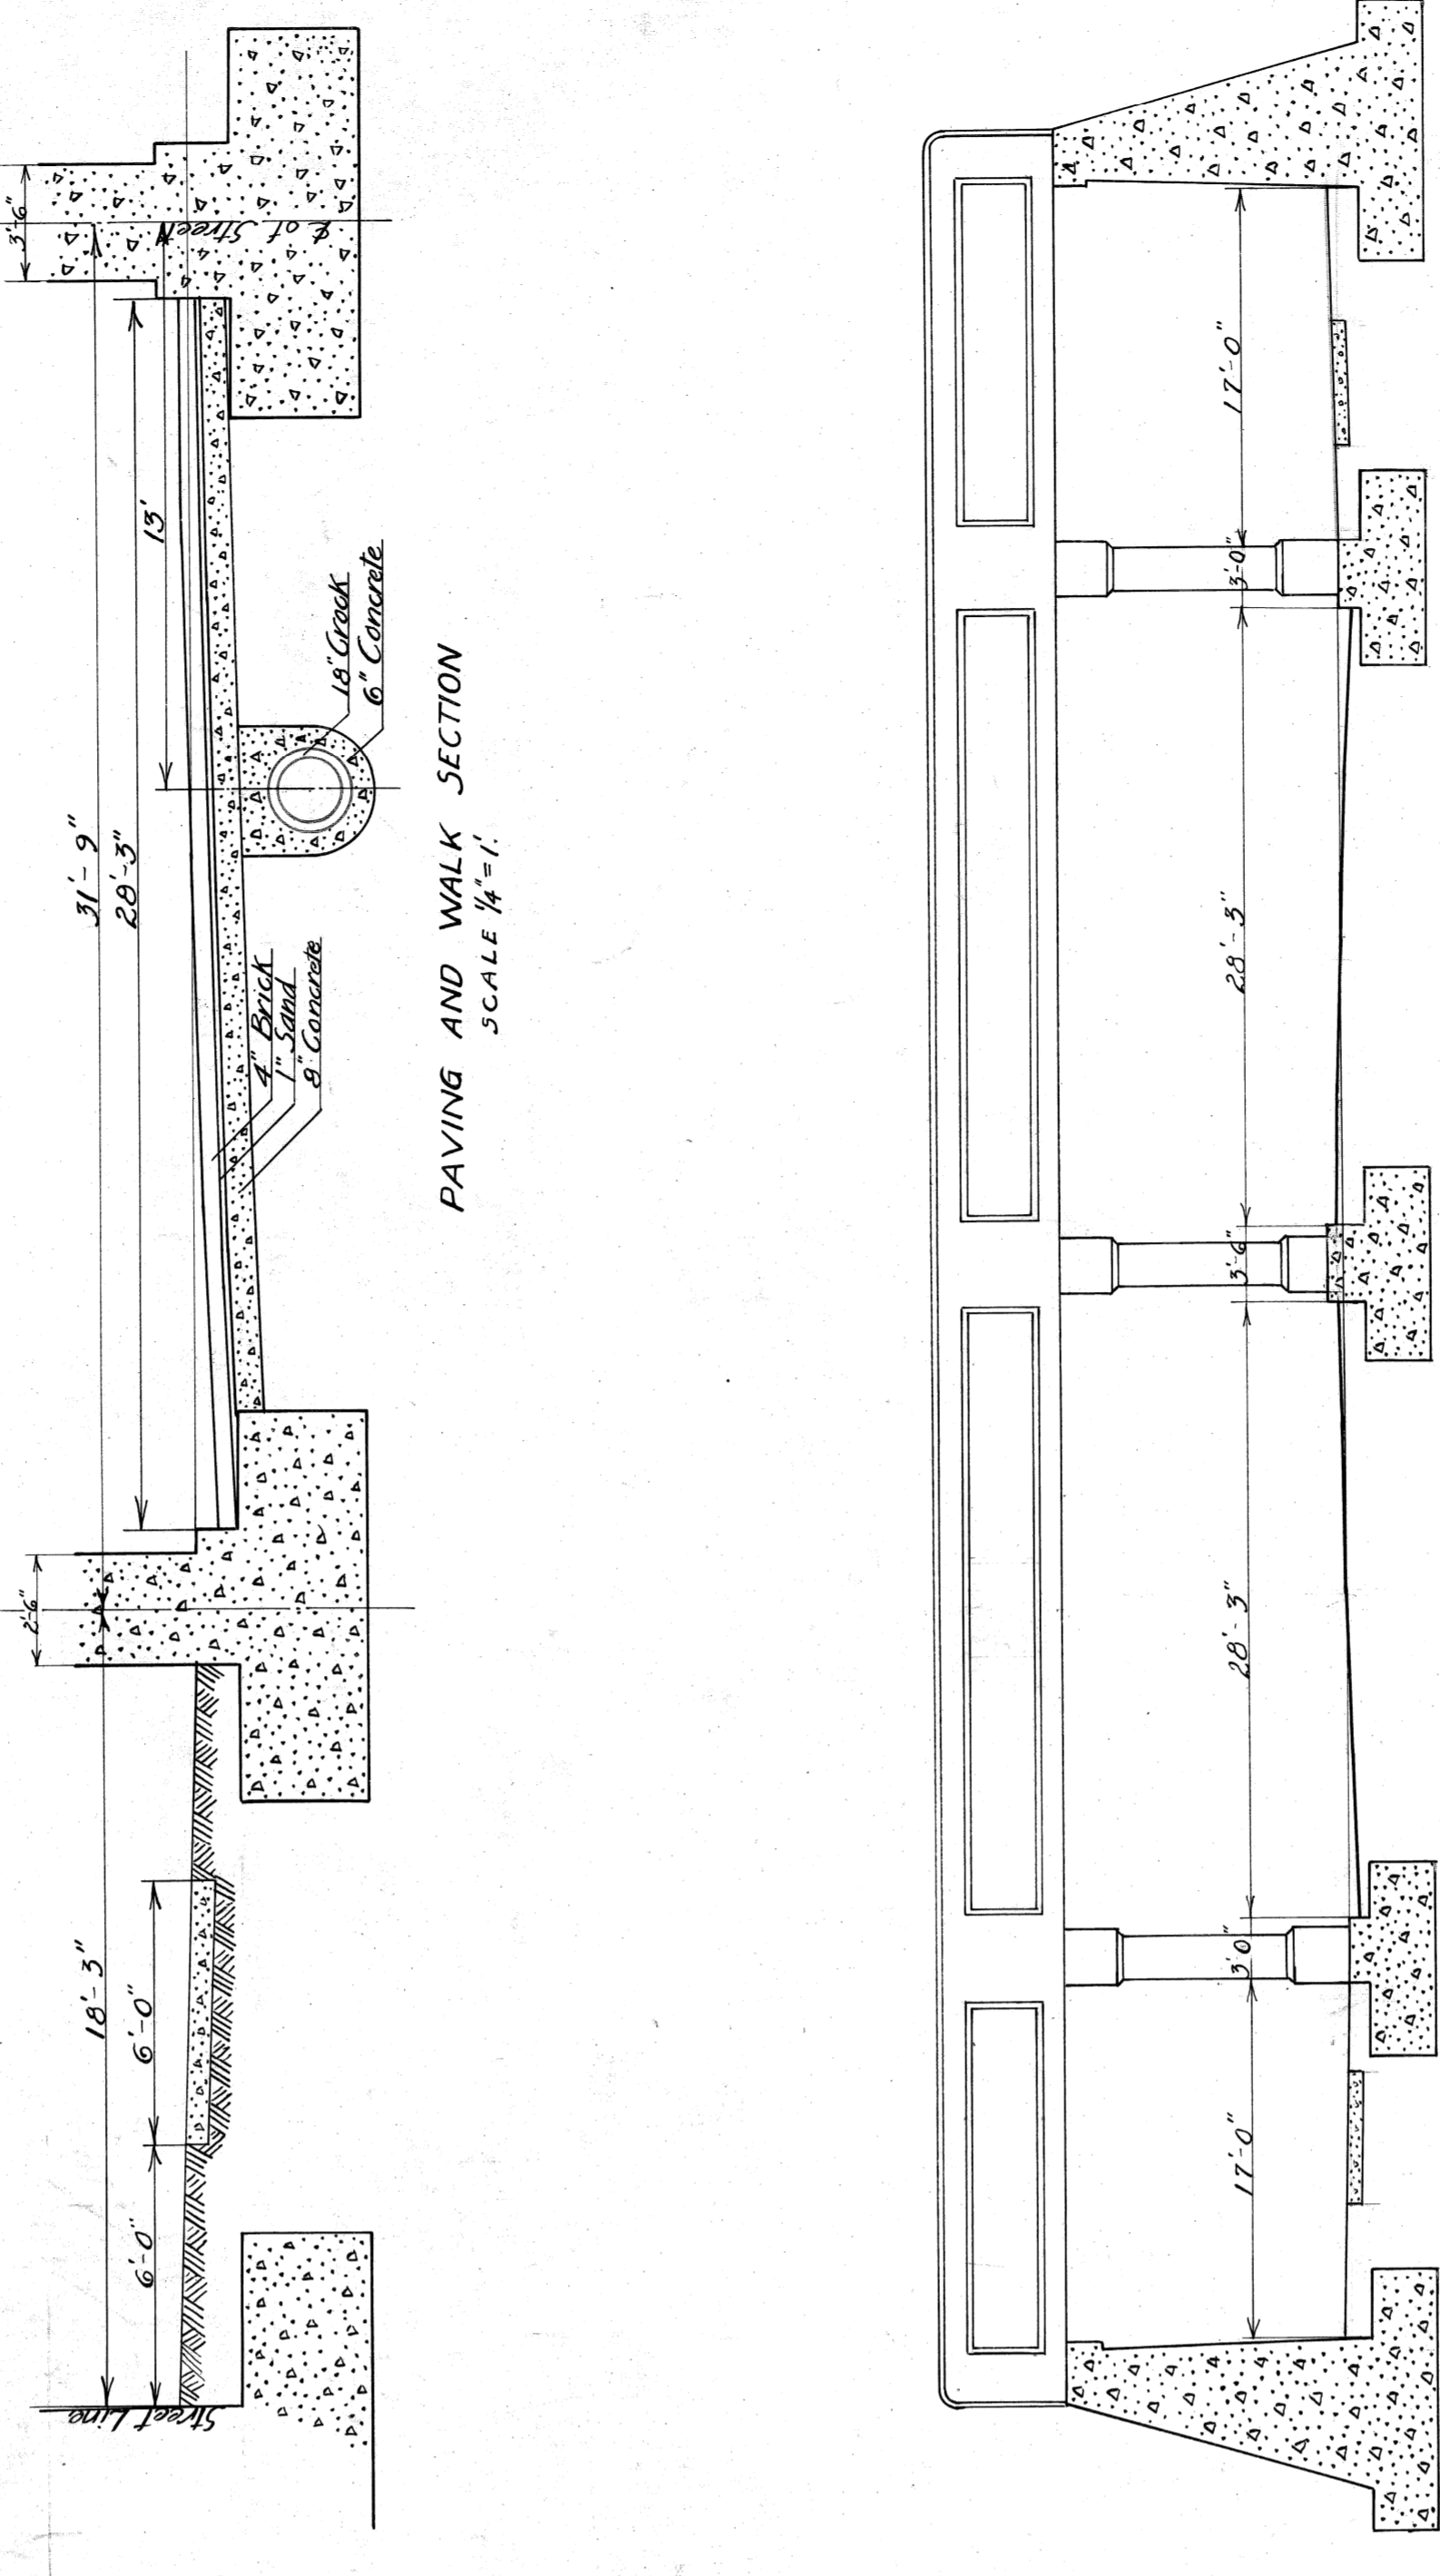

Elevation-Section of Livernois
SCALE 1/8"=1'

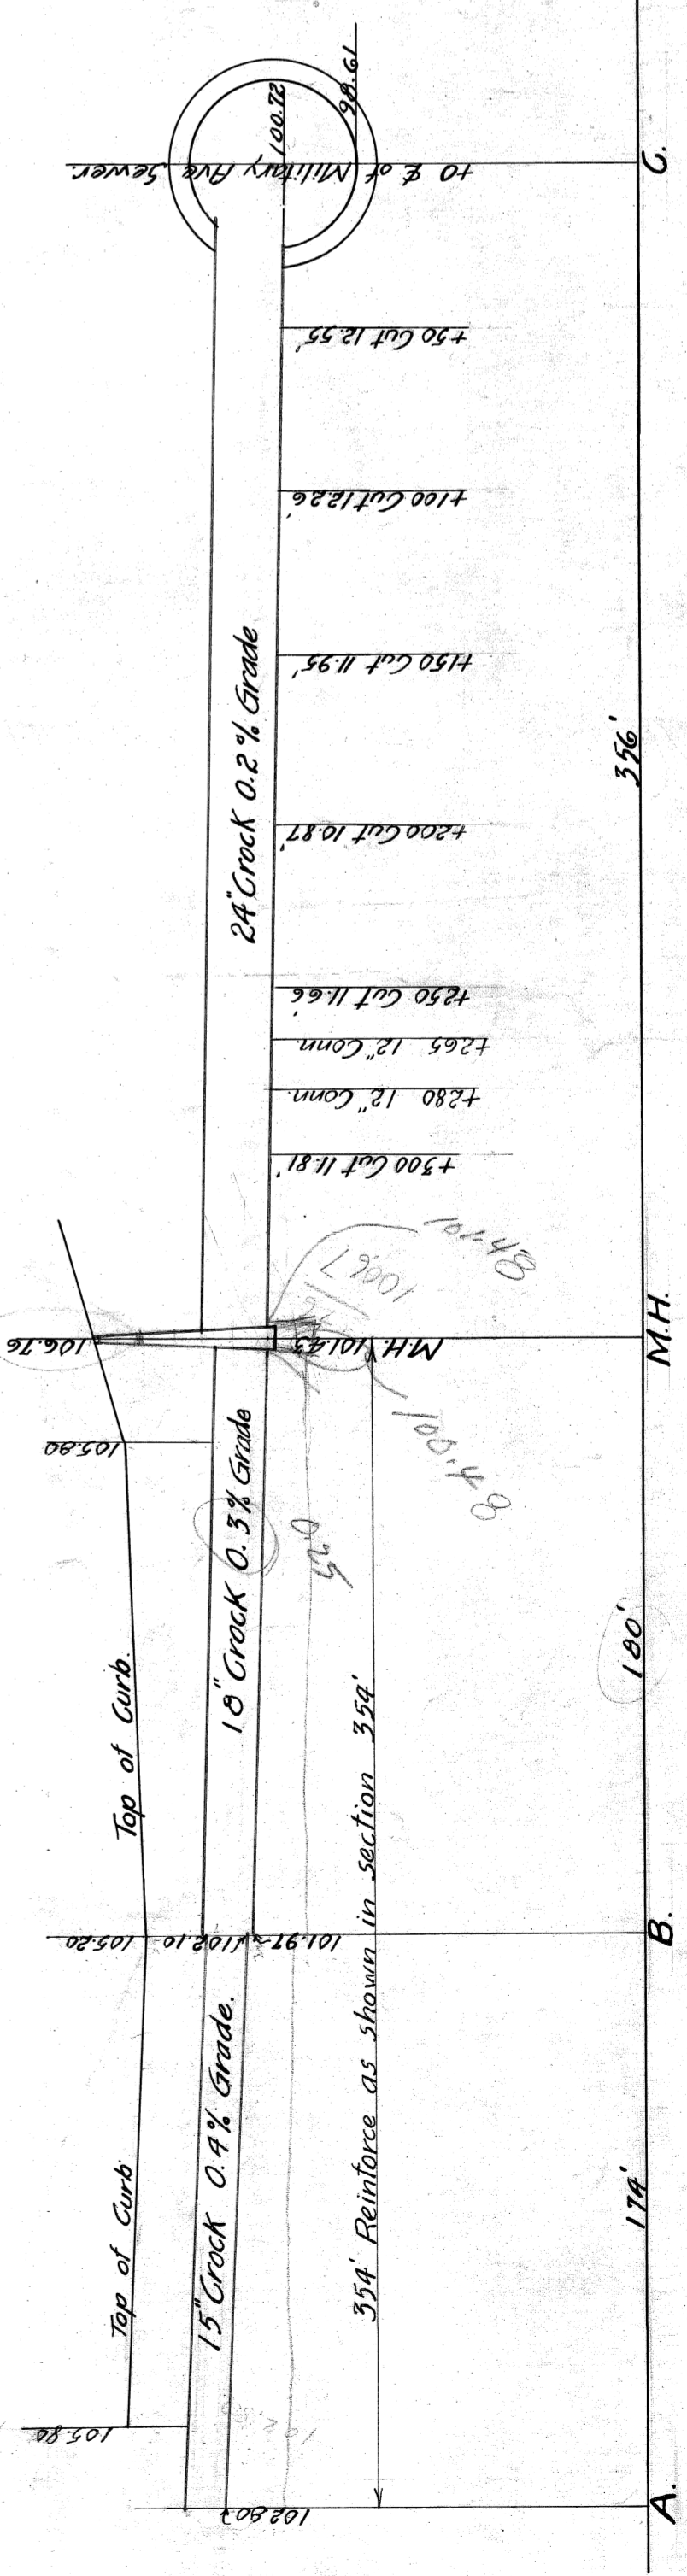

Drainage Profile A-C
SCALE: HOR. 1"=50', VERT. 1"=5'

CITY OF DETROIT
DEPARTMENT OF PUBLIC WORKS
OFFICE OF CITY ENGINEER DIVISION OF GRADE SEPARATION
LIVERNOIS AVE
SCALES AS INDICATED

APPROVED _____ 1920
CITY ENGINEER
CHIEF ENGINEER - M.C.A.R.

JOS. A. MARTIN, Commr. Public Works
JOHN W. WELLS, Engr. Grade Separation