

DEPARTMENT OF PUBLIC WORKS, DETROIT  
CITY ENGINEERS OFFICE - DIVISION OF PAVING DESIGN

STREET PAVING PLAN  
FIELDING

400.44'S. OF S.P.L. OF ELMIRA ✓  
36.5' N. OF S.P.L. OF PLYMOUTH ✓

DESIGNED BY: S.F. DAVIS R3  
DRAWN BY: G.F. STOFFLET  
CHECKED BY: G.F.S.  
APPROVED BY: *S. J. Batten*  
ENGINEER OF STREETS  
DEPUTY CITY ENGINEER



DATE: 11-2-49  
SHEET NO. 2 OF 2  
JOB NO. 8348  
RECORD NO. 77 110

CONTRACT APPROVAL: PET# 8348 H. SL. ATKIN 11-8-49 25% PD. 11-2-49

BENCH MARKS  
PLBM #10-255INE. COR. CHICAGO & EVERGREEN 136.68' ✓  
PLBM #11-WATER GATE NW. COR. FIELDING & W. CHICAGO 139.11' ✓  
PLBM #12-ARROW TOP OF HYD. SW. COR. PLYMOUTH & BRAILE 144.35' ✓  
PLBM #11-253-A SE. COR. PLYMOUTH & BRAILE 141.716' ✓

- NOTE:
- 1. (A) C. CONSTRUCT 3 STD. PIPE CATCH BASINS WITH STD. FRAMES AS SHOWN. SEE STD. DRAWS C-324A
  - 2. (A) M. CONSTRUCT 1 STD. MANHOLE COMPLETE.
  - 3. (A) H. CONTRACTOR SHALL REMOVE CONCRETE HEADER OF NEET AS SHOWN. SEE STD. DRAWS C-324A
  - 4. (A) W. CONTRACTOR SHALL REMOVE CONCRETE CURB UNDER EXCAVATIONS TOTALS 10' FOR 105'.
  - 5. (A) X. CONSTRUCT 1180 59' FT. OF STD. 4" WALKS.
  - 6. (A) Y. CONSTRUCT 40' FT. RETURN OF 8" UNIFORM CONCRETE WITH TYPE III UNIFORM CONCRETE. SEE UNIFORM DRAWING UNDER EARTH.
  - 7. BACKFILL SEWER PIPE TRENCHES APPROVED MATERIAL SHALL BE PAVED WITH APPROVED SAND WITH TAMP LAYERS AS REQUIRED.
  - 8. (A) Z. ADJUST TOP OF 1 EXISTING SEWER MANHOLE.
  - 9. (A) AA. ADJUSTED BASINS TO BE AVAILABLE FOR USE AT ALL TIMES.
  - 10. (A) AB. ADJUSTED BASINS TO BE AVAILABLE FOR USE AT ALL TIMES.

CONTRACTOR SHALL FURNISH NEW CASTING CURB FOR ALL ADJUSTED BASINS. CURB SHALL BE 12" HIGH AND 18" WIDE AT TOP. CURB SHALL BE SET IN PLACE AND ADJUSTED TO PROPER ELEVATION. CURB SHALL BE SET IN PLACE AND ADJUSTED TO PROPER ELEVATION. CURB SHALL BE SET IN PLACE AND ADJUSTED TO PROPER ELEVATION.

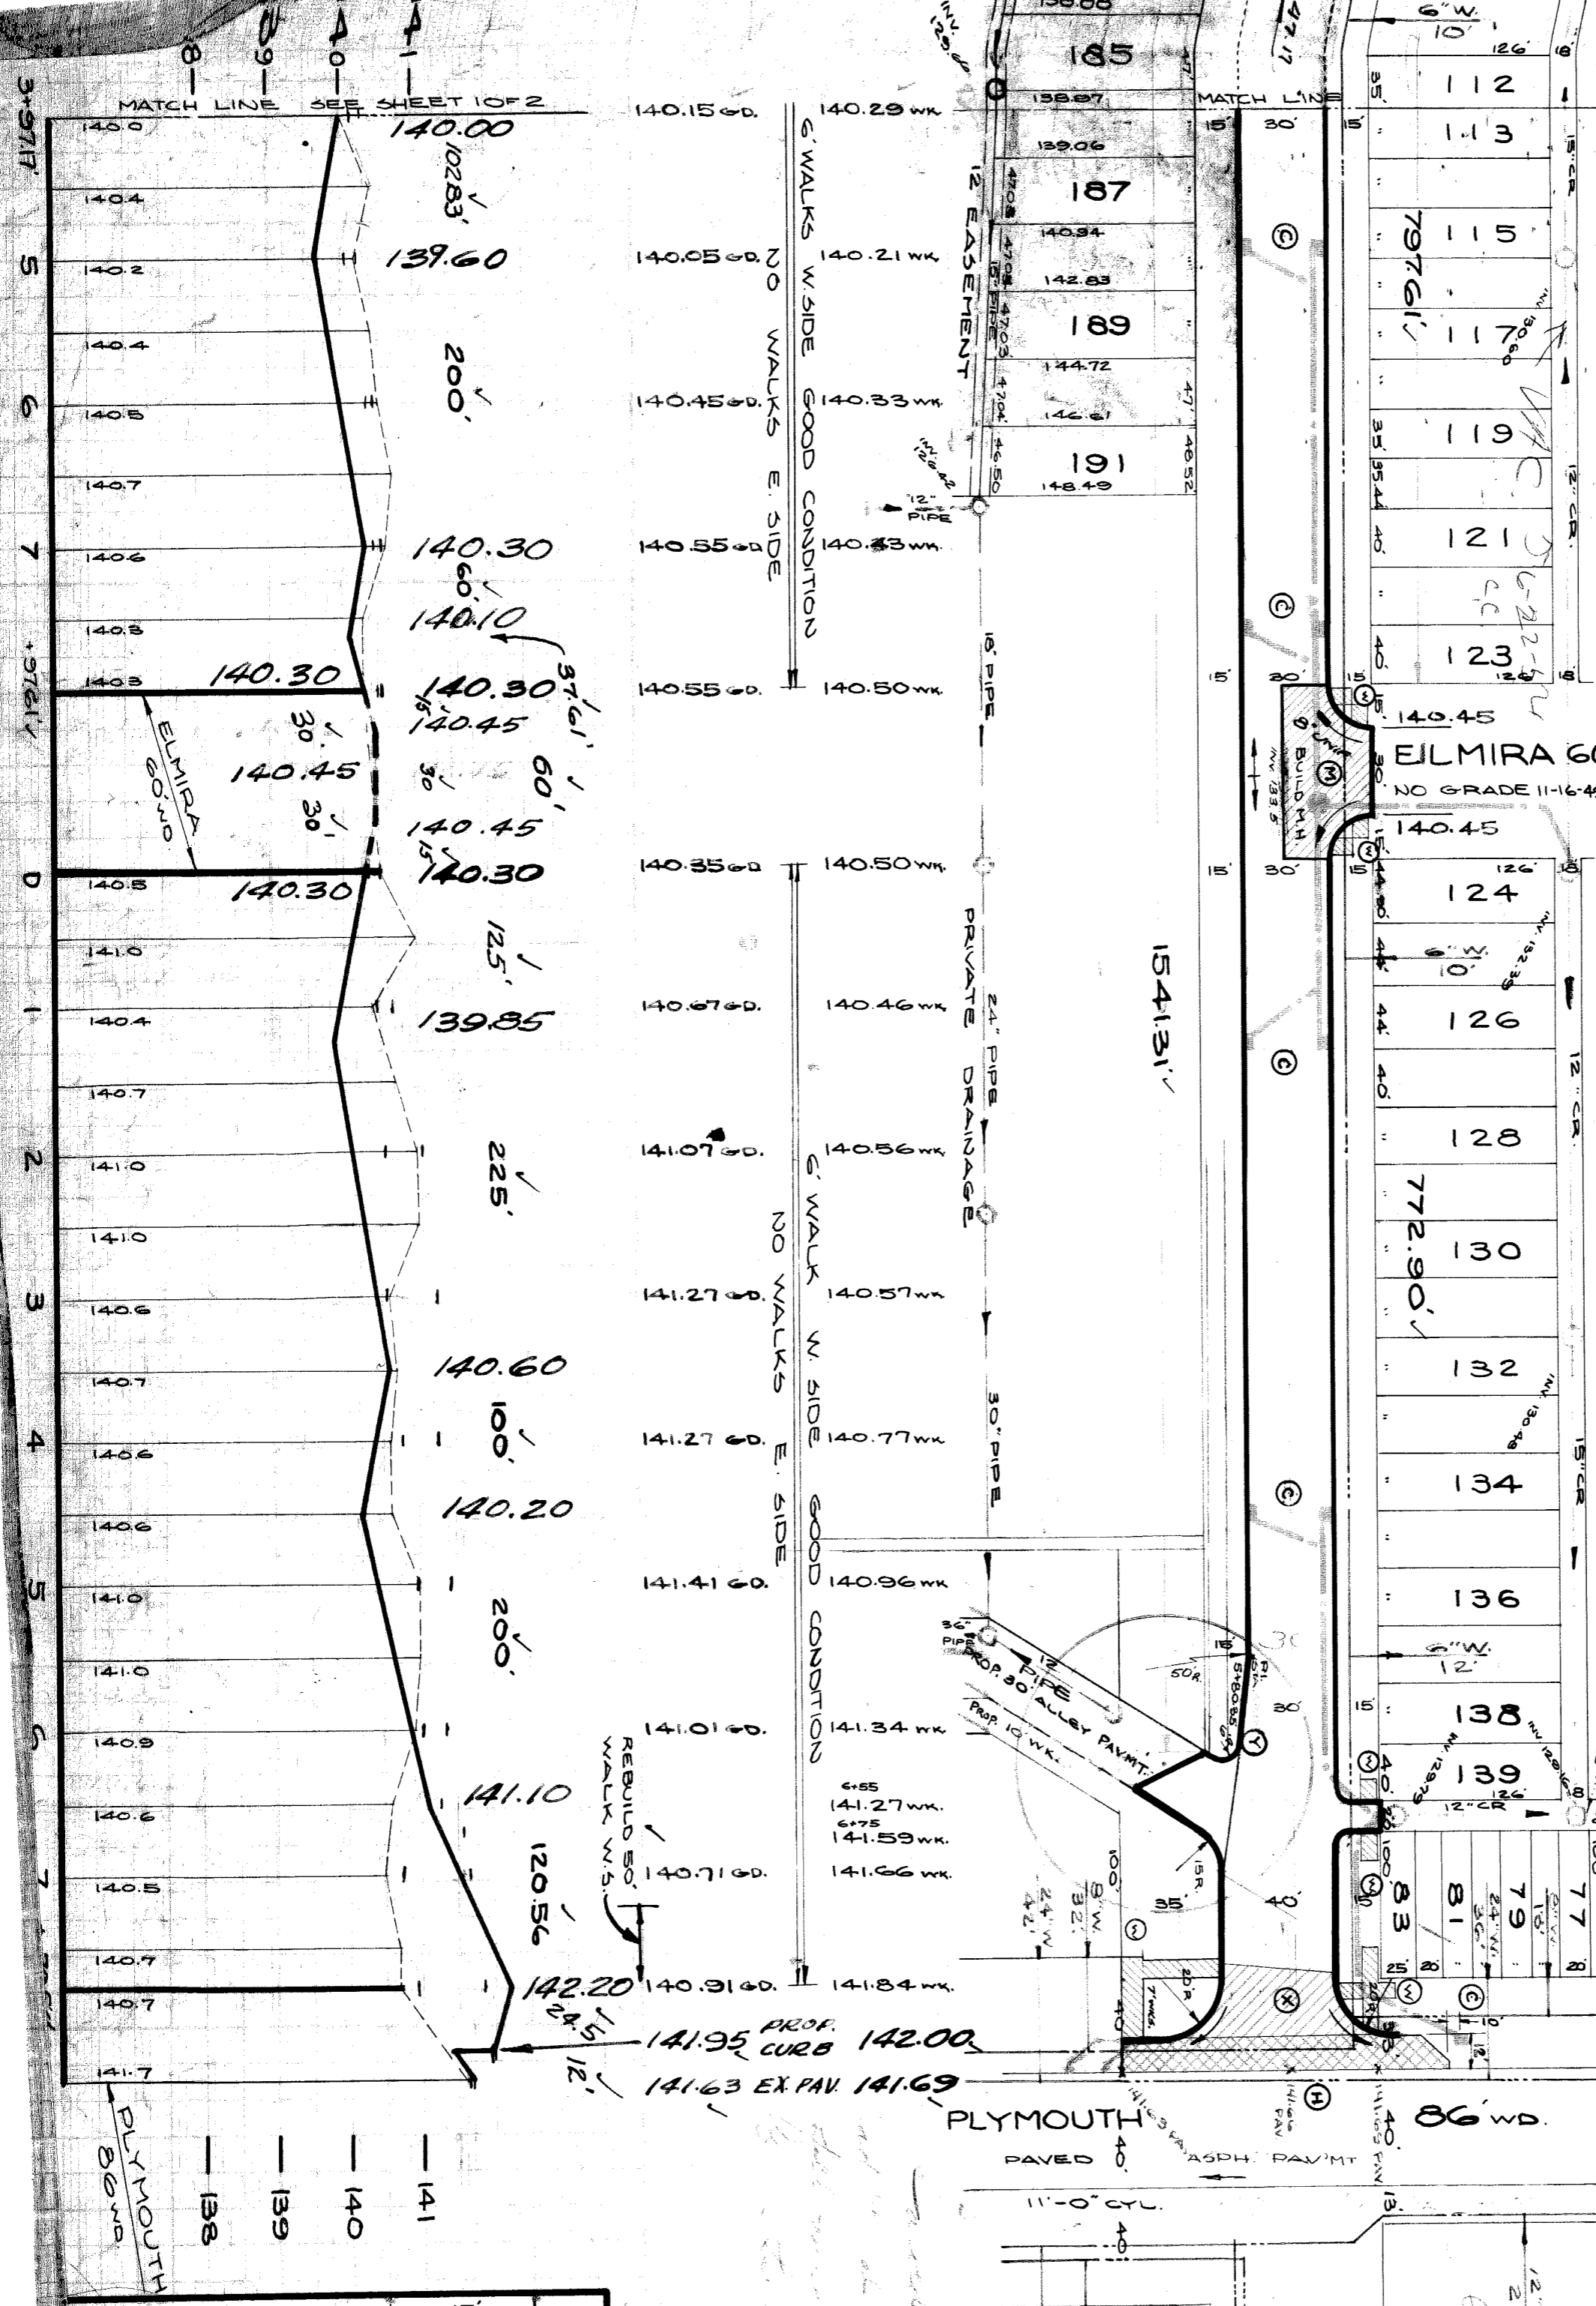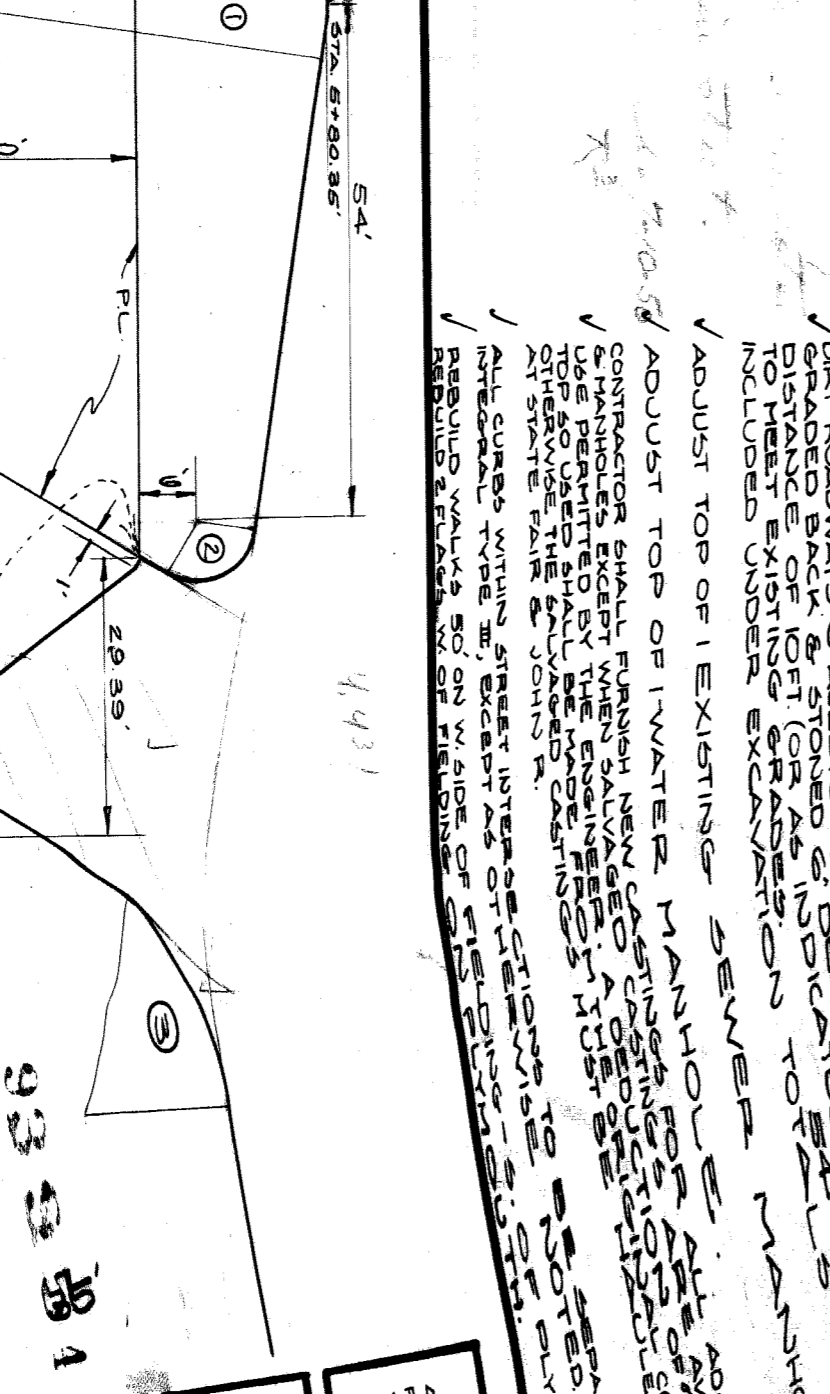

NOTE: SET STARTING CONSTRUCTION CONSTRUCTION MUST CHECK WITH CHICAGO FOR LOCATION OF EXISTING STRUCTURES WHETHER OR NOT INDICATED ON PLANS.

PLAN SCALE DISTORTED  
LOTS & ALLEYS: 1" = 100'  
STREET WIDTHS: 1" = 50'  
DRAINAGE COMPLETED  
PAVING COMPLETED C.C. 9-12-50

SEWER	C-324A	C-390	C-587	C-739B
REVISIONS	C-325	C-524	C-733	C-938
	C-326A	C-585	C-739	
	C-327	C-586	C-739A	

QUANTITIES	ESTIMATED	FINAL
EXCAVATION CU YDS		
NEW CURB LIN FT		
PAVING SQ YDS		
SIDWALK 90 FT		
MANHOLES ADJUST		
BASINS ADJUST		
SEWER 12" LIN FT		

FOR SCALE 1" = 2'	BOOK 1712	PAGE 15
DATE NOV 1949		
DATE SHOWN 11-2-49		
CHECKED BY: S.F.D.	GRADE	C.F.D.
CHECKED BY: S.F.S.	CONTRACT	S.F.S.
CHECKED BY: S.F.S.	CITY	

CIRCLE 1	9'-10" 12"
CIRCLE 2	4'-10" 46" 25"
CIRCLE 3	4'-11" 10" 14"
CIRCLE 4	4'-12" 44"
CIRCLE 5	4'-12" 58"
CIRCLE 6	4'-10" 5"
CIRCLE 7	4'-11" 46" 25"
CIRCLE 8	4'-11" 10" 14"
CIRCLE 9	4'-12" 44"
CIRCLE 10	4'-12" 58"
CIRCLE 11	4'-10" 5"