

O.K.

1381

TO WATER RD 9-29-38

1381

B-2029



4-11-38

DEPARTMENT OF PUBLIC WORKS
CITY ENGINEER'S OFFICE - DIVISION OF PAVING DESIGN
STREET PAVING PLAN

LONGACRE GO'
PLYMOUTH

PLAN NO.	
DATE	12-13-37
SCALE	1"=40'
CHECKED	C.M.A.
DESIGNED BY	W.P.A.
TRACED BY	W.P.A.
CHECKED BY	W.P.A.
INDEX NO.	69
TOPO. NO.	101
RECORD NO.	245020
CITY	

CLASS B - 8" MACADAM
FORCED PAVING - C.C. PROC. 7-5-39

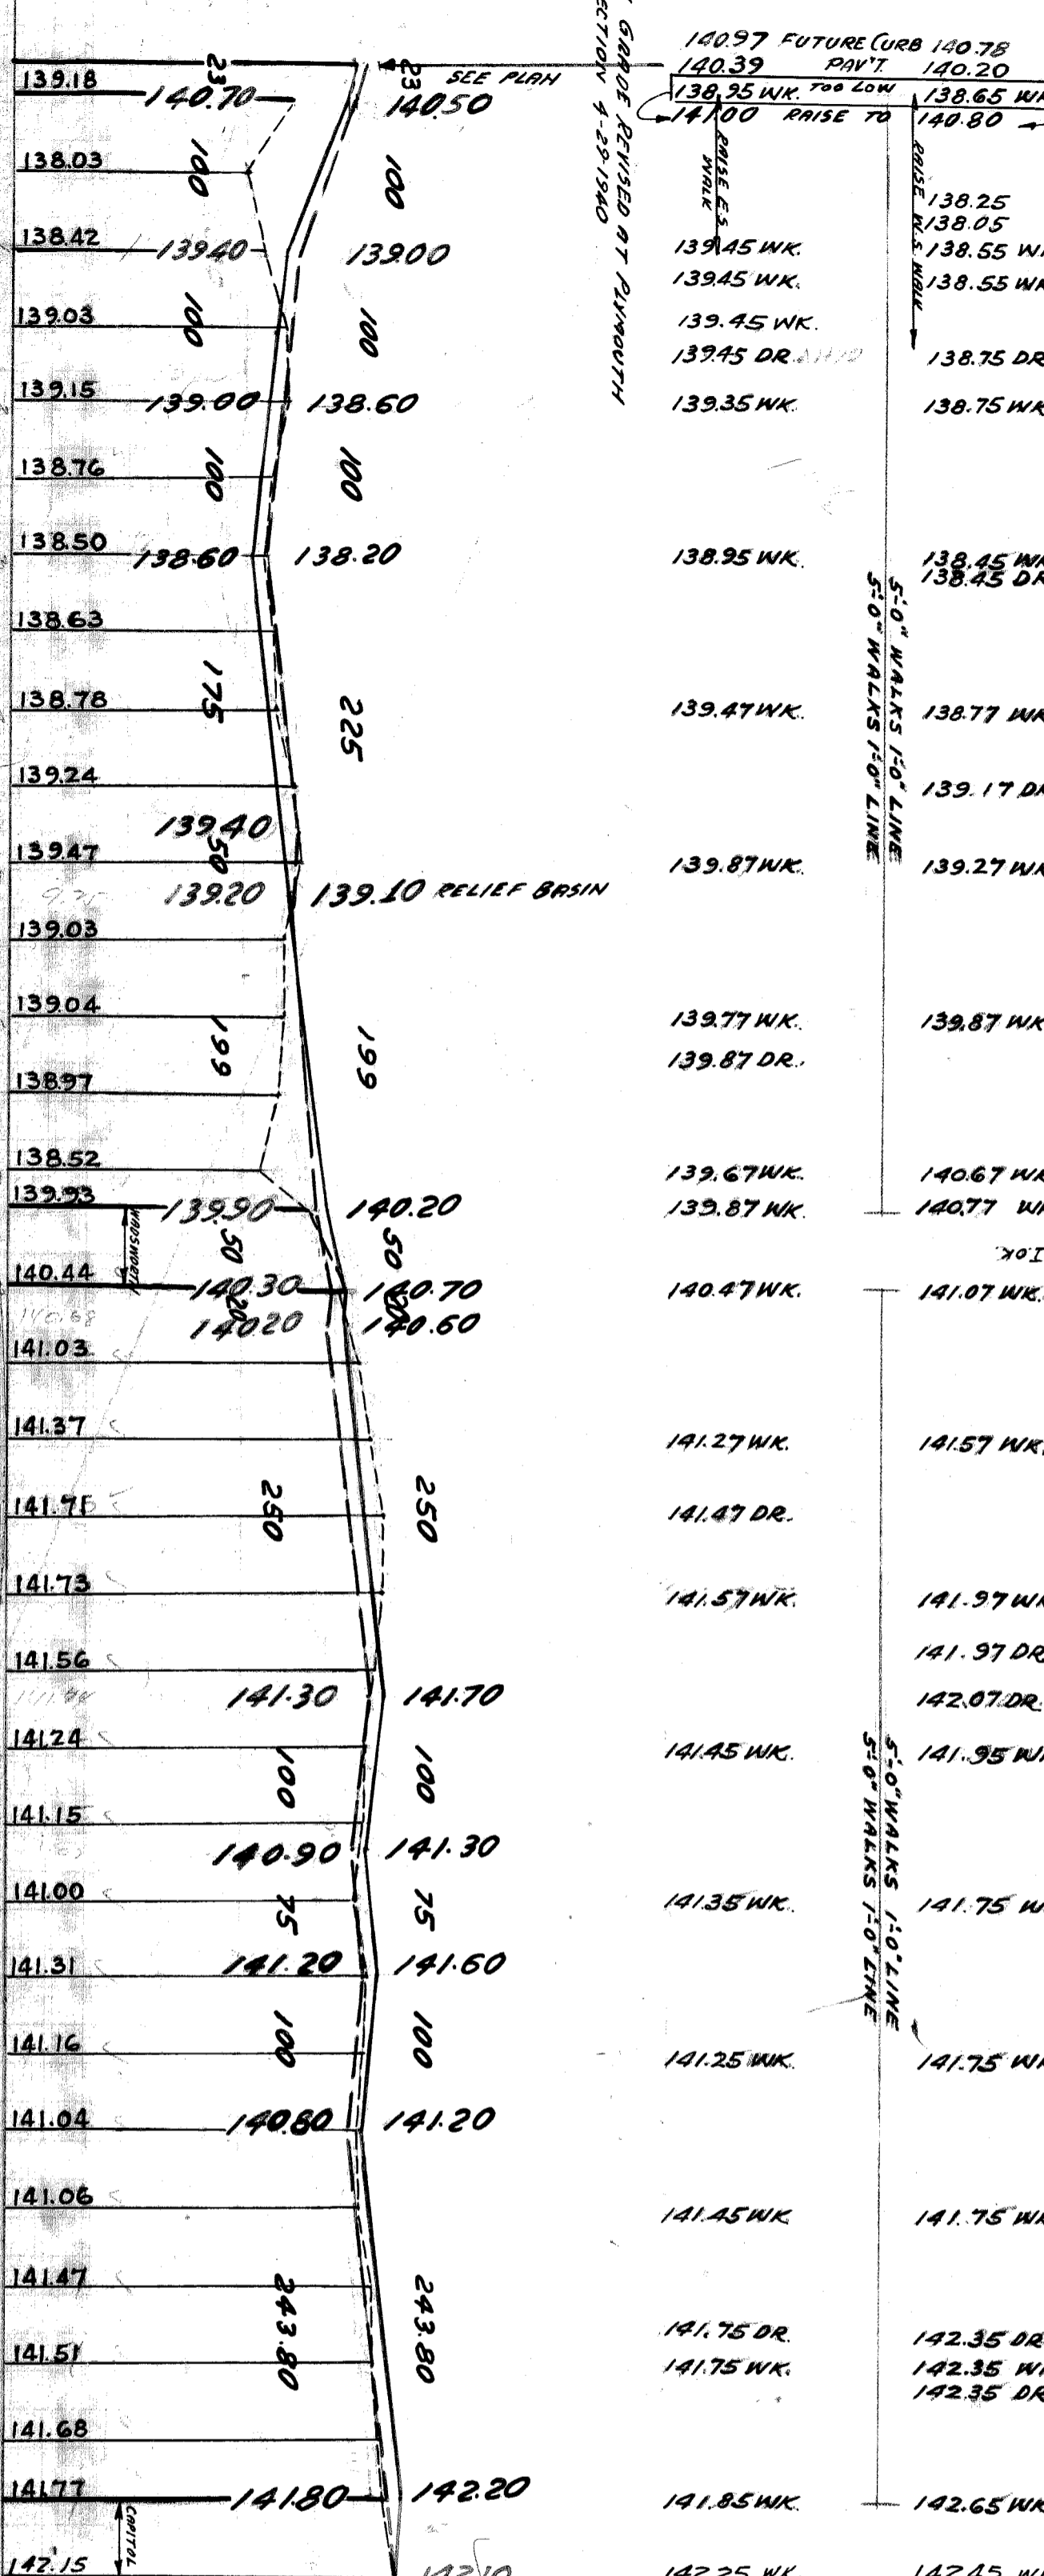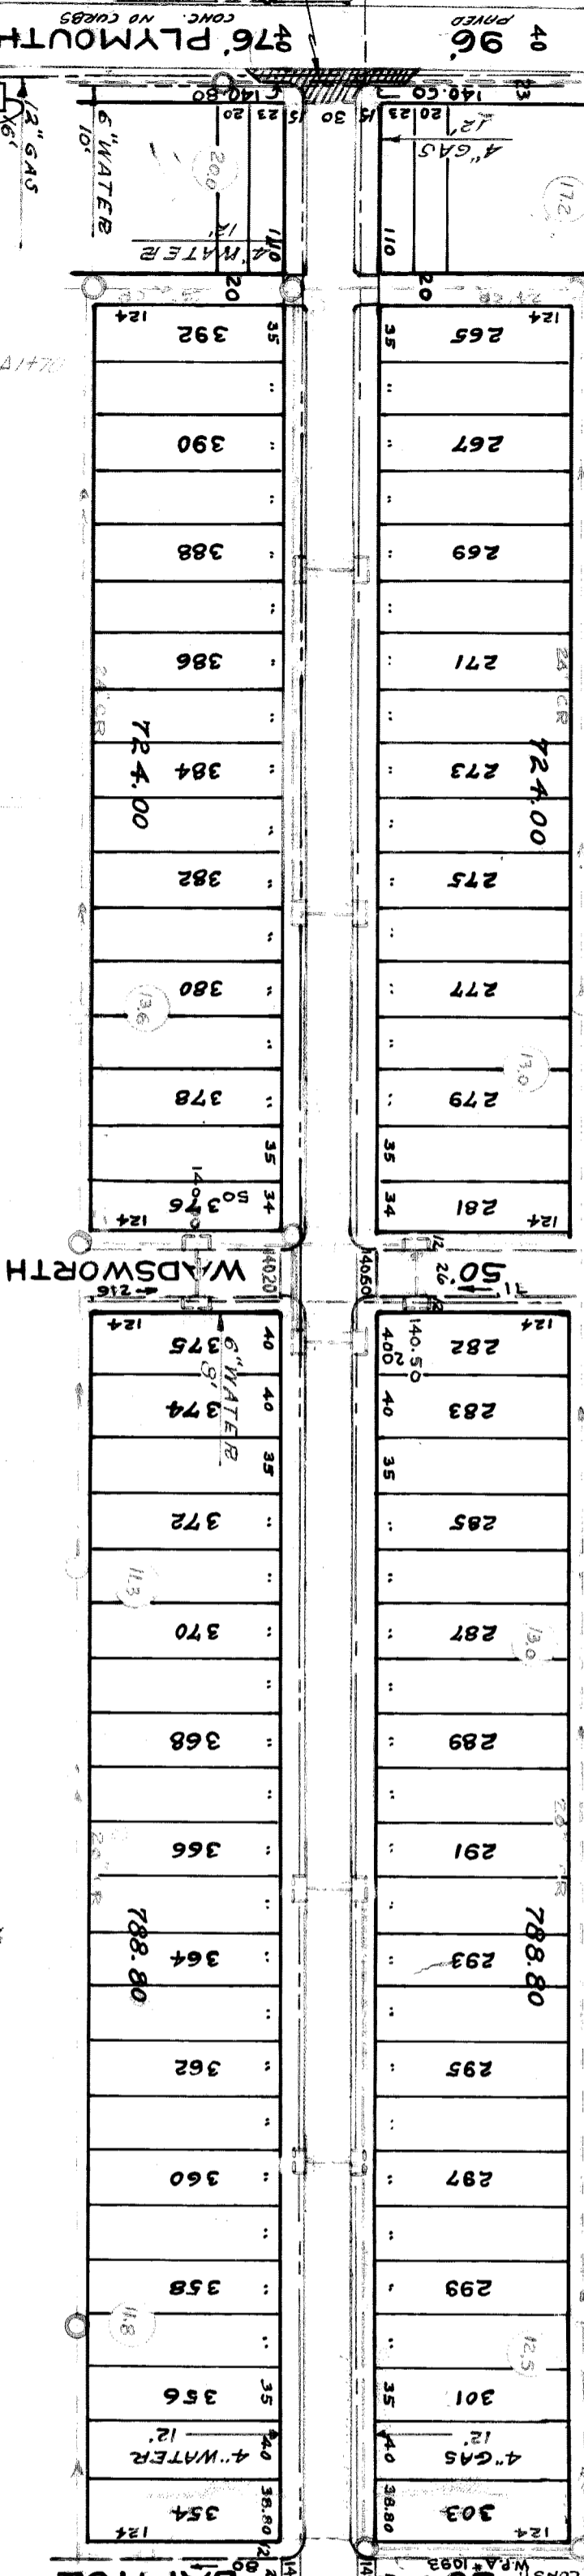

DESIGNED BY	W.P.A.	APPROVED	W.P.A.
DRAWN BY	W.P.A.	ENGINEER OF STREETS	W.P.A.
TRACED BY	W.P.A.	ASSY. CIV. ENGINEER	W.P.A.
CHECKED BY	W.P.A.		

REVISOR 11-1-38
PAVING WIDTH CHANGED FROM 30 FT. TO 26 FT. WIDE WHERE SHOWN ONLY ON INTERSECTING 50 FT. STREETS.

REVISIONS:
142.56 -
142.13 -
144.69 -

GENE REVISOR PLYMOUTH TO CAPITOL ON ACCOUNT WRONG H.T.'S IN P.B. 1272, P.G. 744, 739.

SUMP MANHOLE BASINS BY W.P.A. COMPLETED 7-15-39

142 DRAINAGE O.K.

DRAINAGE COMPLETED
PAVING COMPLETED 9/21/40

