

SEWER & WATER TRACING CLOTH  
K & E CO., N. Y.

SEWER & WATER TRACING CLOTH K & E CO., N. Y.		JOB NO.		PROGRESS		QUANTITIES		LOTS		CITY		CITY		CITY		CITY		CITY		CITY		CITY	
INDEXED		BLUE PRINT ISSUED FOR:		DATE		START		FINISH		EXCAVATION		STRAIGHT CURB NEW		OLD CURB RESET		CIRCULAR CURB		PAVING		CONCRETE BASE		GAS CO.	
REVISED		GRADE ONLY								CATCH BASINS													
		PAYING-CLASS:																					
		DEPT. OF WATER SUPPLY																					
		GAS CO.																					
		NON. SCALE 1" = 100'		BOOK 1487		PAGE 52		DESIGNED BY		R. R. R.		DRAWN BY		R. R. R.		TRACED BY		R. R. R.		CHECKED BY		R. R. R.	
		VER. SCALE 1" = 2'		DATE 11-5-42				APPROVED				CHECKED BY											
		PLAN		S.S.		PROFILE		S.S.		COMPUTED		CHECKED		R2									
		CHECKED		SHAPE		S.S.		CHECKED		R2													
		TOTAL 2L		2090.45		LENGTH		1048.22		54.00													
		CITY		100.00		LENGTH		1095.22		1095.22													
		TOTAL 2L		2190.45		LENGTH		1095.22		1095.22													
		CITY																					
		COST ADVERTISING BLANKS																					
		COST INSPECTION																					
		ENGINEER OF STREETS																					
		ASSIST. CITY ENGINEER																					

CARD NO.

DEPARTMENT OF PUBLIC WORKS DETROIT

CITY ENGINEER'S OFFICE ... DIVISION OF PAVING DESIGN

### STREET PAVING PLAN

NAME OF STREET: Mc KINNEY AVE.

FROM: 358.62 N. OF N.P.L. OF CASINO AVE.

TO: 30' N. OF S.P.L. OF MOROSS RD.

TYPE OF PAVEMENT: ONE CO. CONCRETE

WIDTH: 30'



INDEX TOPO NO. 36

INDEX NO. 97

RECORD NO.

NAME OF SHEETS: 1

SHEET NO. 1

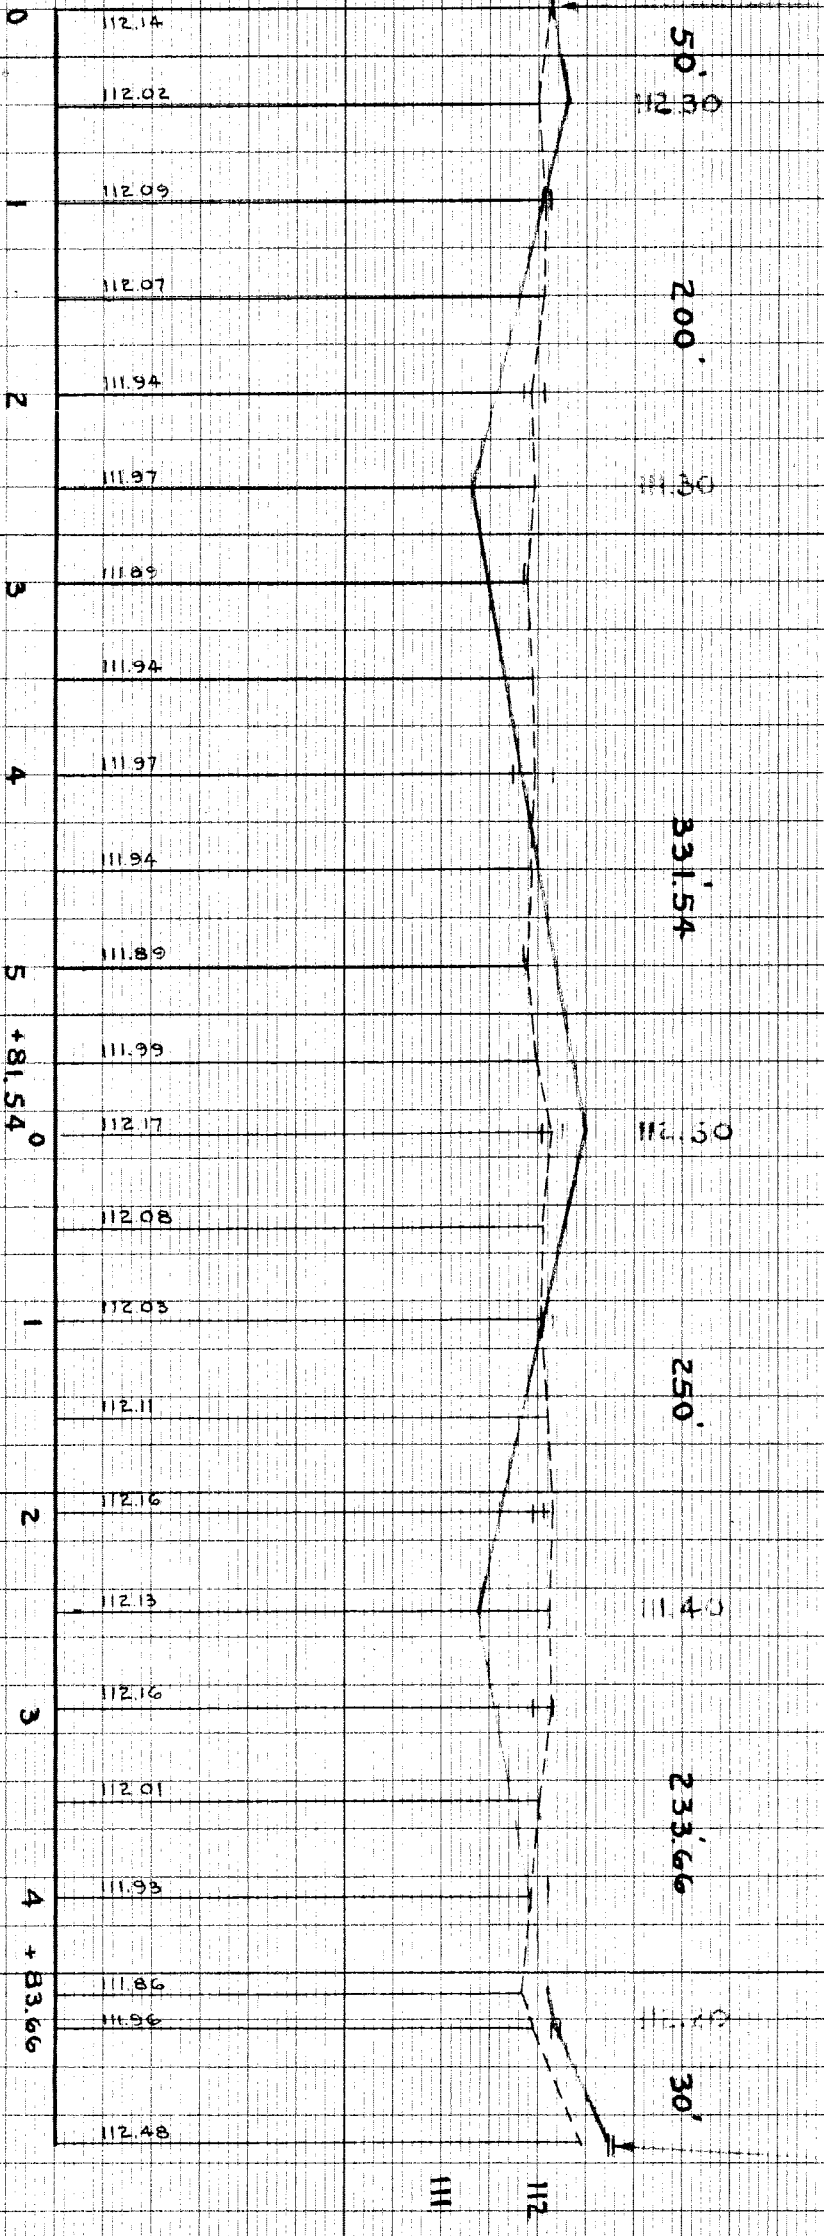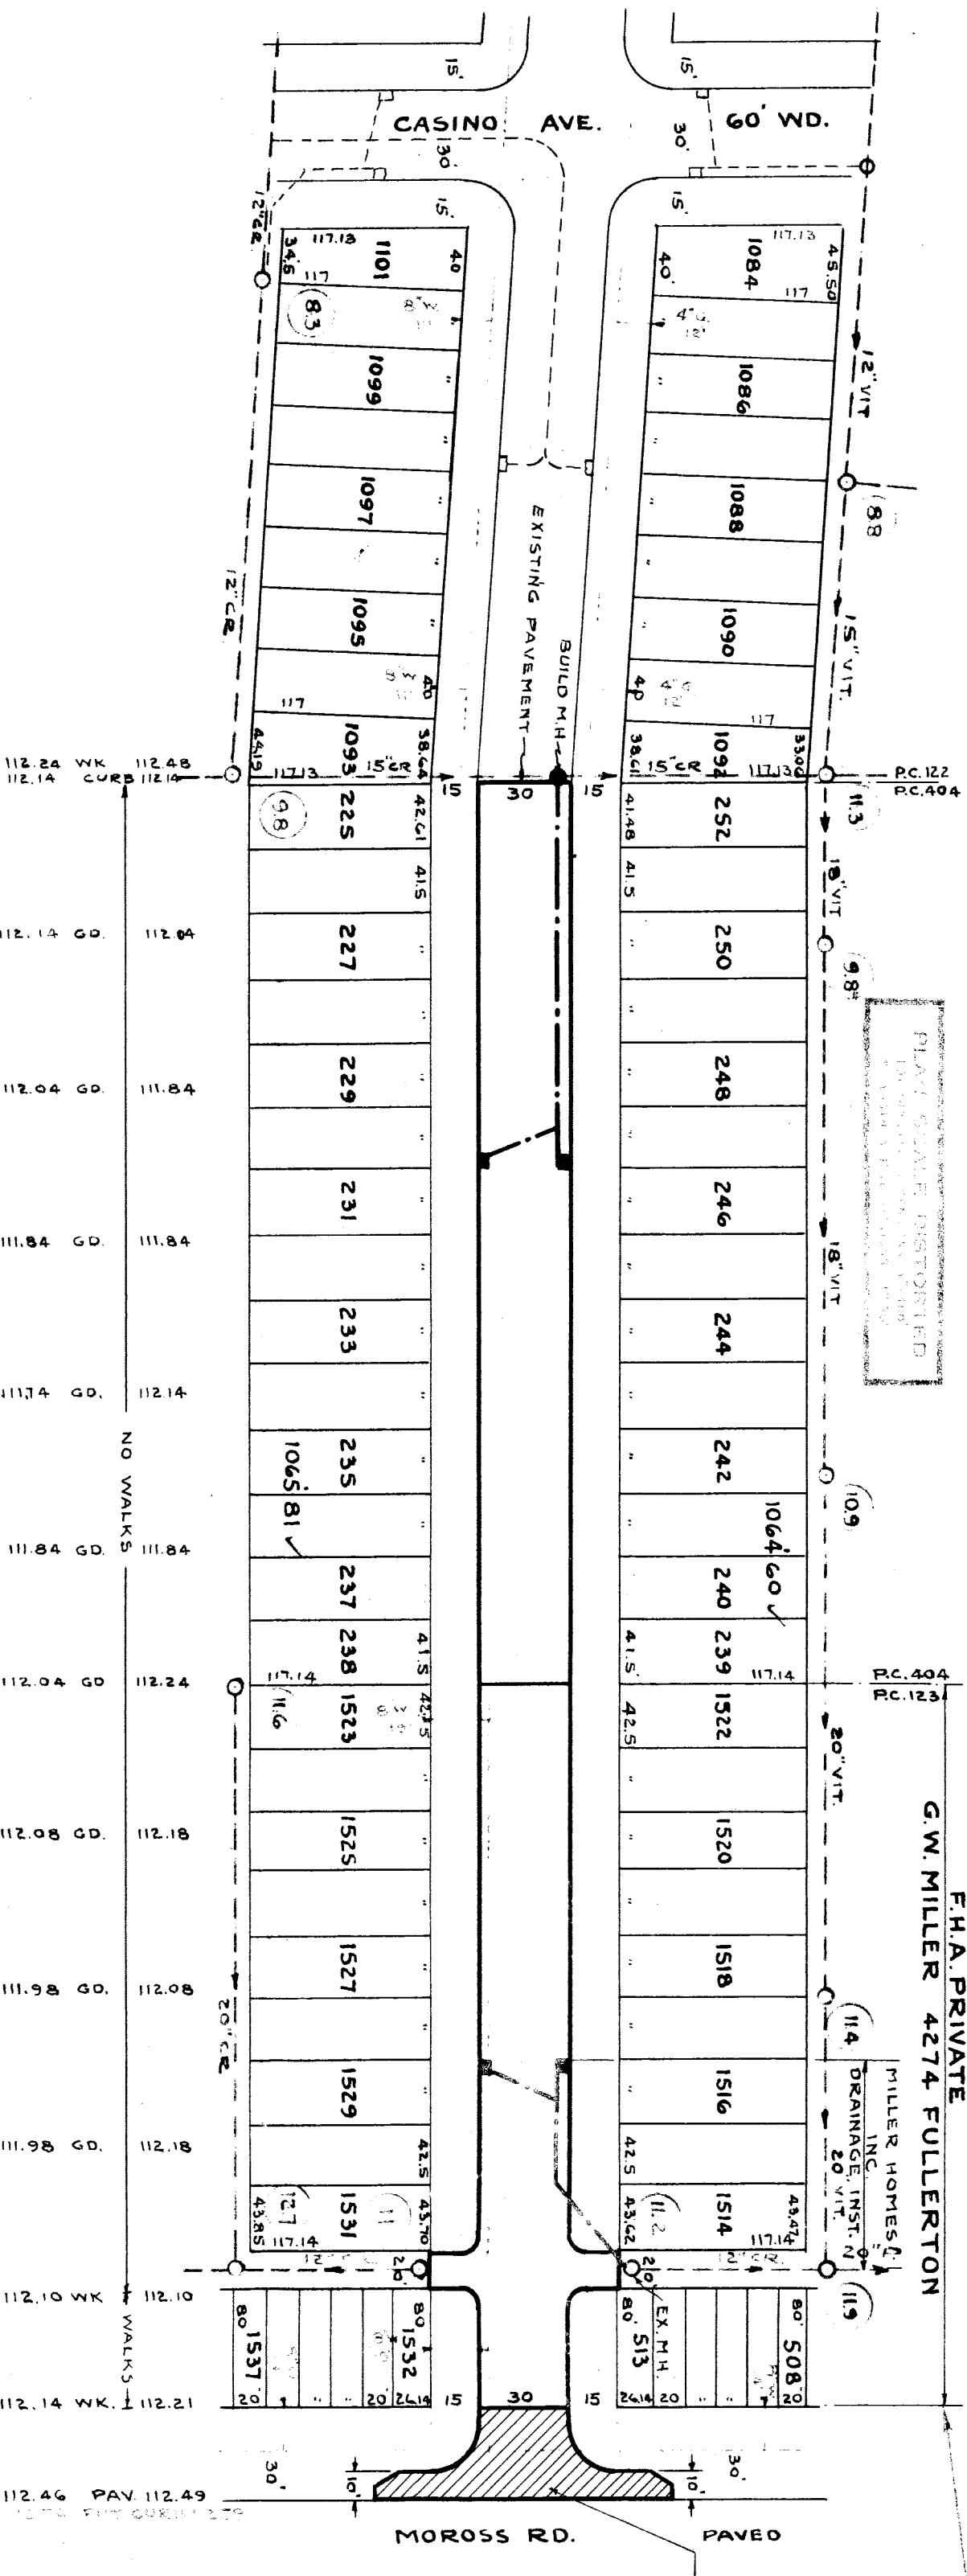

BENCH MARKS	ELEV.
MON. E. SIDE OF MCKINNEY AT SIX LINE OF P.C. 404	112.76
P.L. MON. E.S. OF MCKINNEY AT N.P.L. LINE OF P.C. 404	112.22

CONSTRUCT CONCRETE RETURNS AND 10' WIDENINGS. SEE SPECIAL DETAIL SHEET. CONCRETE SLAB IN MOROSS RD. TO BE 10" THICK.