

DEPARTMENT OF PUBLIC WORKS DETROIT
CITY ENGINEER'S OFFICE - DIVISION OF PAVING DESIGN
STREET PAVING PLAN

MONTROSE

NAME OF STREET: N.P.L. OF PAUL
TO: S.P.L. OF WHITLOCK

LEVEL OF PAVEMENT: 8 5 8
ONE COURSE CONCRETE - MEDIAN, CURB
8" UNIFORM AT STREET INTERSECTIONS EXCEPT AS NOTED

CONTRACT APPROVED: CC _____

DESIGNED BY: L.G. VANTUYL.
DRAWN BY: J.L.M.19
TRACED BY: _____
CHECKED BY: _____
APPROVED: _____

INDEX TOPO NO. 40
NO. 98
RECORD NO. _____

CARD NO. _____

ASSIGN. NO. 375 W-19
PETITION NO. _____


SHEET 1 OF 1 SHEETS

NO.	SCALE	1" = 50'	BOOK	1732	PAGE	3
VER.	SCALE	1" = 4'	DATE LEVELS	6-14-49		
PLAN			DATE DRAWING	3-28		
CHECKED	H.K.	PROFILE	COMPUTED			
LOT 1	2	3	4	5	6	7
LENGTH	2,417.02	0.21	LENGTH	1,208.51		
CITY	100.00	0.01	LENGTH	50.00		
TOTAL 2L	2,517.02		LENGTH	1,258.51		


QUANTITIES	ESTIMATED	FINAL
EXCAVATION 'CU. YDS.		
NEW CURB LIN. FT.		
PAVING SQ. YDS.		
SIDWALK SQ. FT.		
MANHOLES ADJUST CONSTRUCT		
ADJUST CONSTRUCT		
SEWERS 12" LIN. FT.		

NOTE: BEFORE STARTING CONSTRUCTION CONTRACTOR MUST CHECK WITH UTILITIES FOR LOCATIONS OF EXISTING STRUCTURES WHETHER OR NOT INDICATED ON PLANS.
PLAN SCALE DISTORTED
LOTS & ALLEYS 1" = 100'
STREET WIDTHS 1" = 50'
DRAINAGE COMPLETED
PAVING COMPLETED

SEWER	REVISIONS	DATE
C-324A	C-380	C-587
C-325	C-524	C-733
C-326A	C-585	C-739
C-327	C-586	C-739A

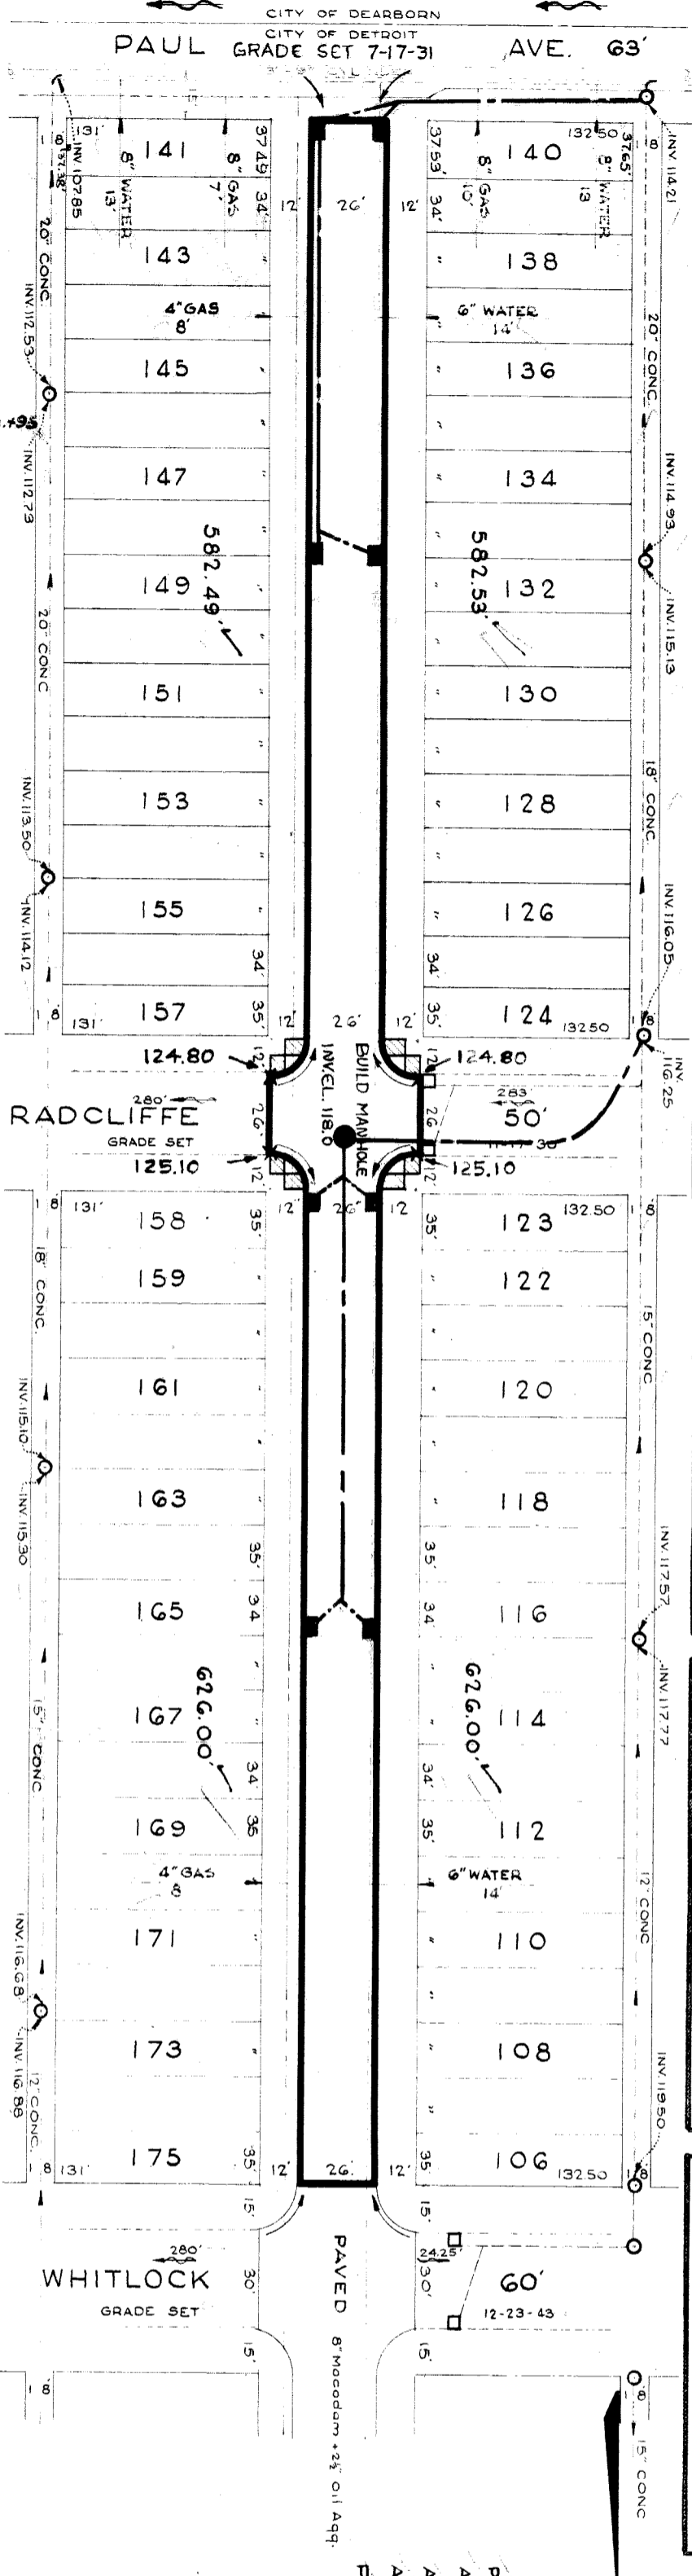

LOT NO.	WALKWAY	WALKWAY
122.98	Wk.	123.26
123.69	Wk.	124.12
124.21	Wk.	124.21
123.78	Wk.	123.72
124.02	Wk.	124.33
124.37	Wk.	124.64
124.81	Wk.	124.89
125.32	Wk.	125.27
125.51	Wk.	126.04
125.53	Wk.	126.34
125.49	Wk.	125.72
126.25	Wk.	126.58
126.64	C.D.	
126.73	C.D.	
126.94	Wk.	127.18
127.05	C.D.	
127.61	Wk.	128.02
127.96	Wk.	128.26
127.74	RETURN	128.02
127.84	CURB	128.12

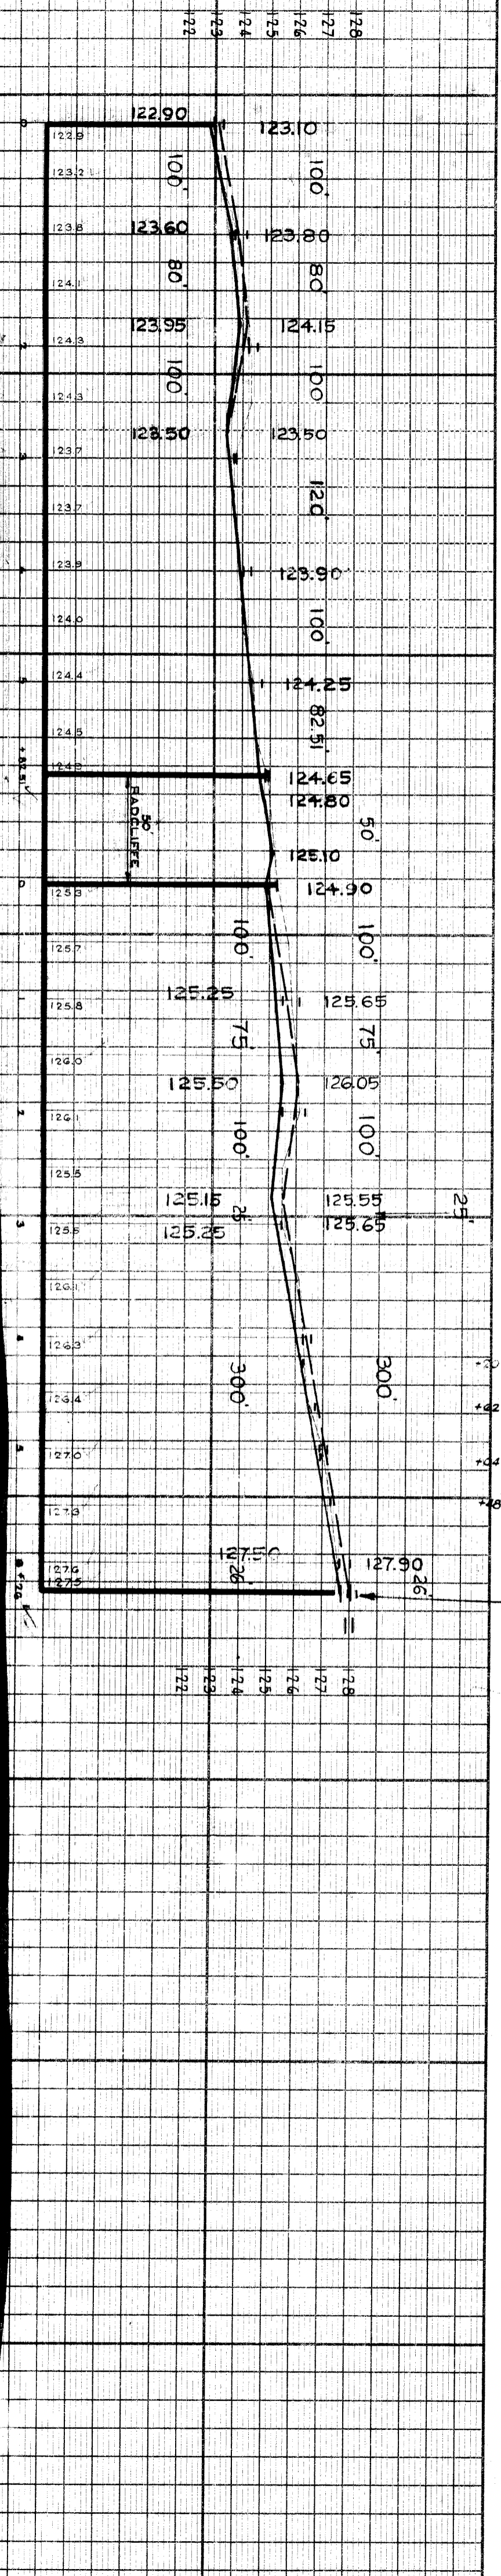

BENCH MARKS
P.L.B.M. # 98-235 A NORTHWEST COR. GREENFIELD & RADCLIFFE
ARROW ON HYDRANT NORTHWEST COR. MONTROSE & PAUL
ARROW ON HYDRANT NORTHWEST COR. MONTROSE & RADCLIFFE
ARROW ON HYDRANT SOUTHWEST COR. MONTROSE & WHITLOCK
P.L.B.M. # 99-256 NORTHWEST COR. GREENFIELD & WARREN

122