



DEPARTMENT OF PUBLIC WORKS  
 CITY ENGINEER'S OFFICE - DIVISION OF PAVING DESIGN  
**STREET PAVING PLAN**  
**PLAINVIEW 80**  
 FROM: OUTER DRIVE  
 TO: FENKELL

INDEX TO PD NO. 76 112  
 SHEET NO. 1

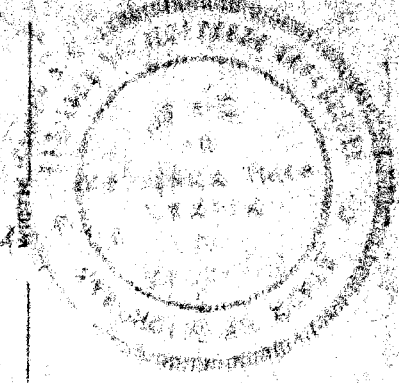

BOOK 137-B PAGE 35	DATE 2-11-37
HOR SCALE 1"=100'	VER SCALE 1"=2'
PLAN	CHECKED
CL W	GRADE
1733	65
26	26
1759	65
866	83
879	83

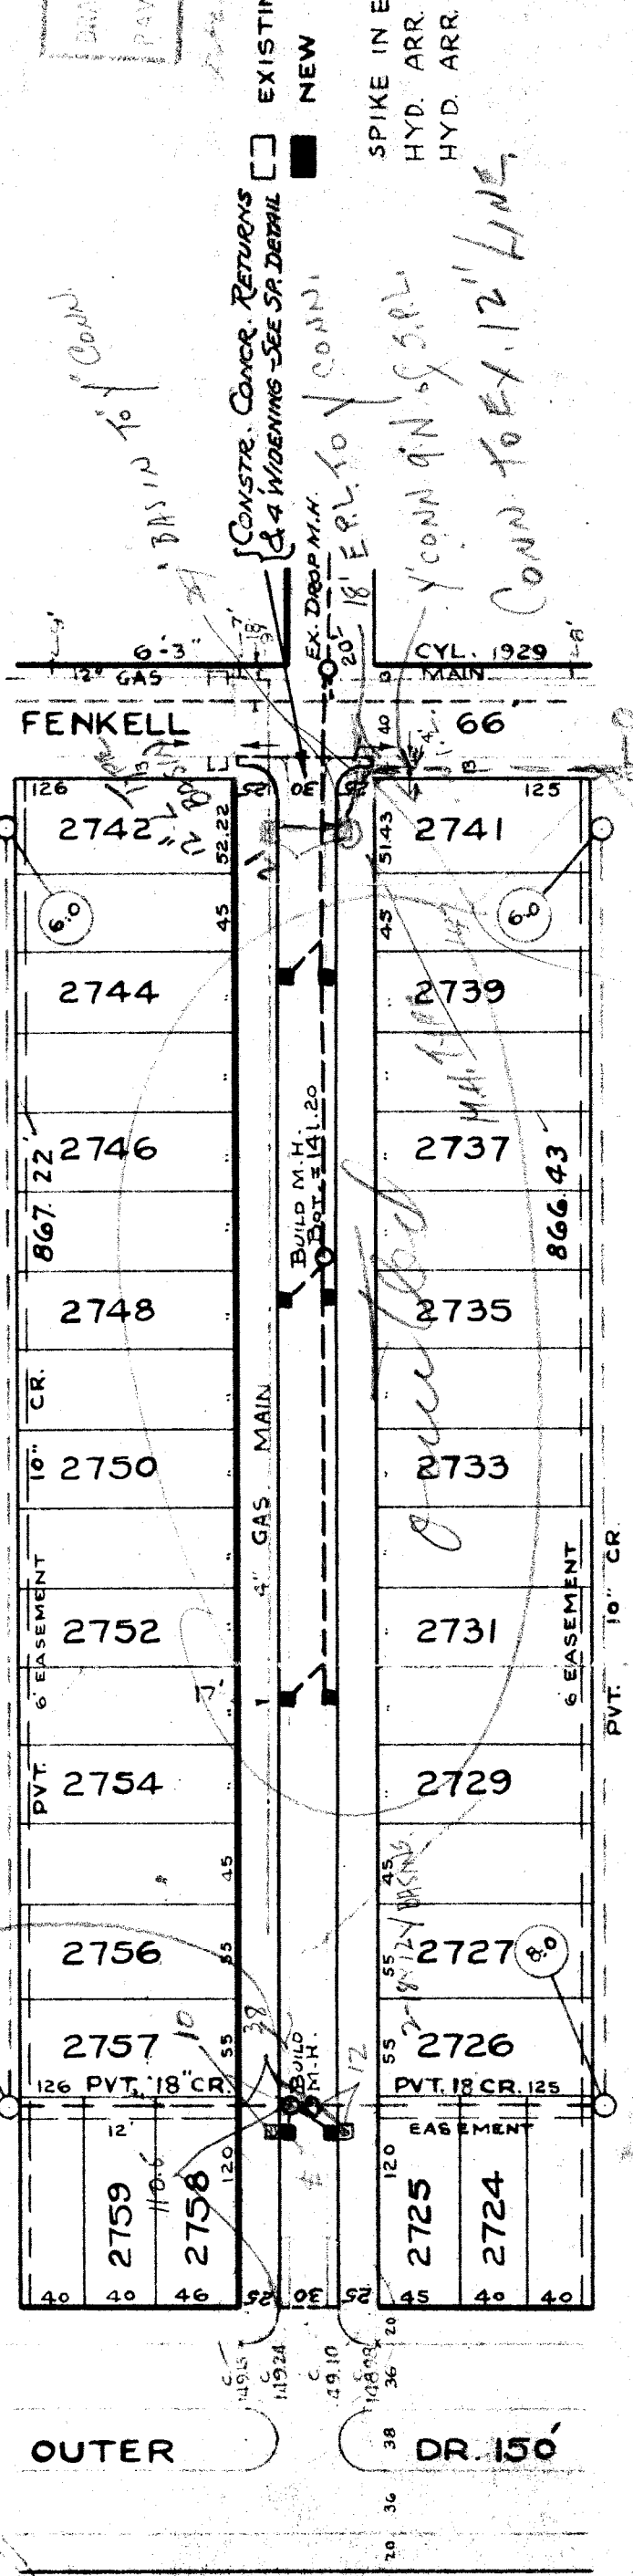

W. J. WELLS  
 CIVIL ENGINEER

JOB-NO-D-2128

DRAINAGE ONLY

