


Revision

01 DWG - Coordination Review 3/8/2023

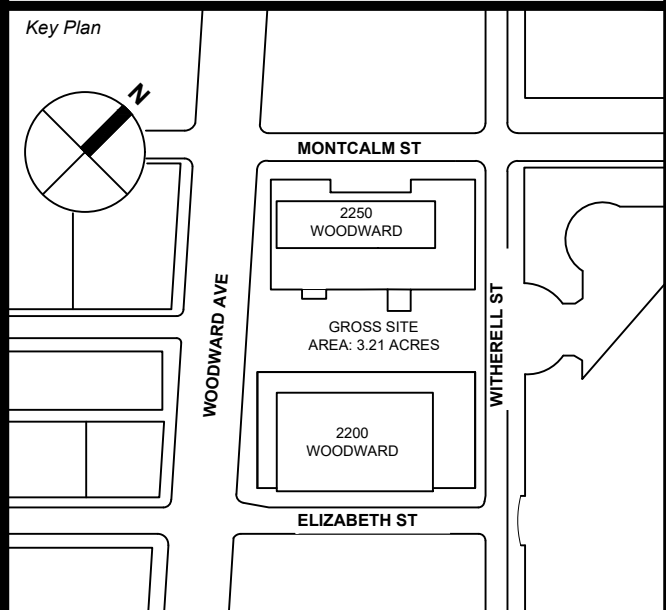

Seal & Signature

Issue Date 3/1/2023 Project No. 18279-114



Scale 1" = 20'

Drawing Title


**C-700  
UTILITY PLAN**

**UTILITY NOTE**

THE OMISSION OF ANY CURRENT STANDARD DETAIL DOES NOT RELIEVE THE CONTRACTOR FROM THIS REQUIREMENT. THE WORK SHALL BE PERFORMED IN COMPLETE CONFORMANCE WITH THE CURRENT DWSD STANDARD SPECIFICATIONS AND DETAILS.

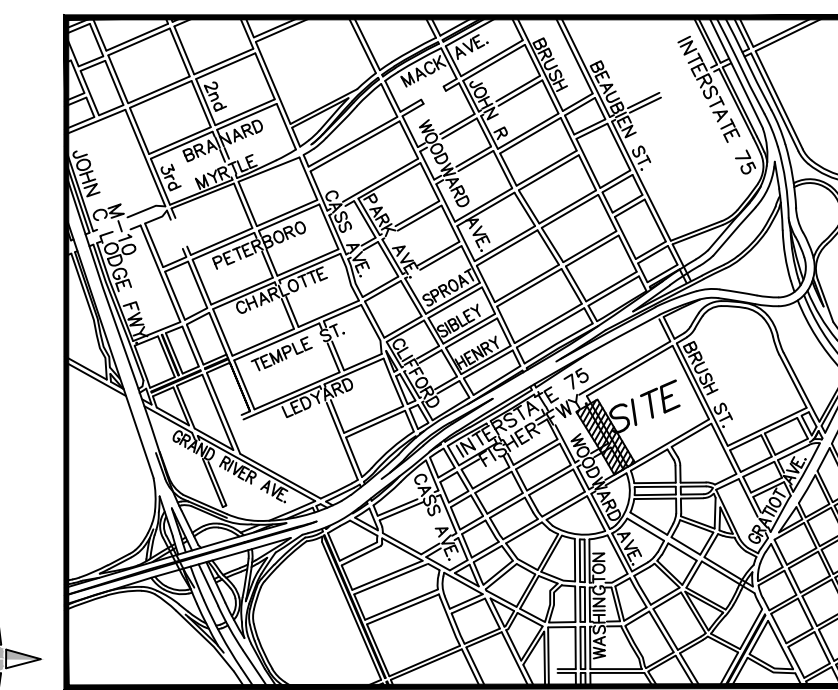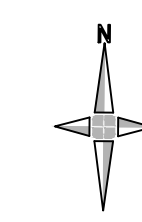


LOCATION MAP  
( NOT TO SCALE )

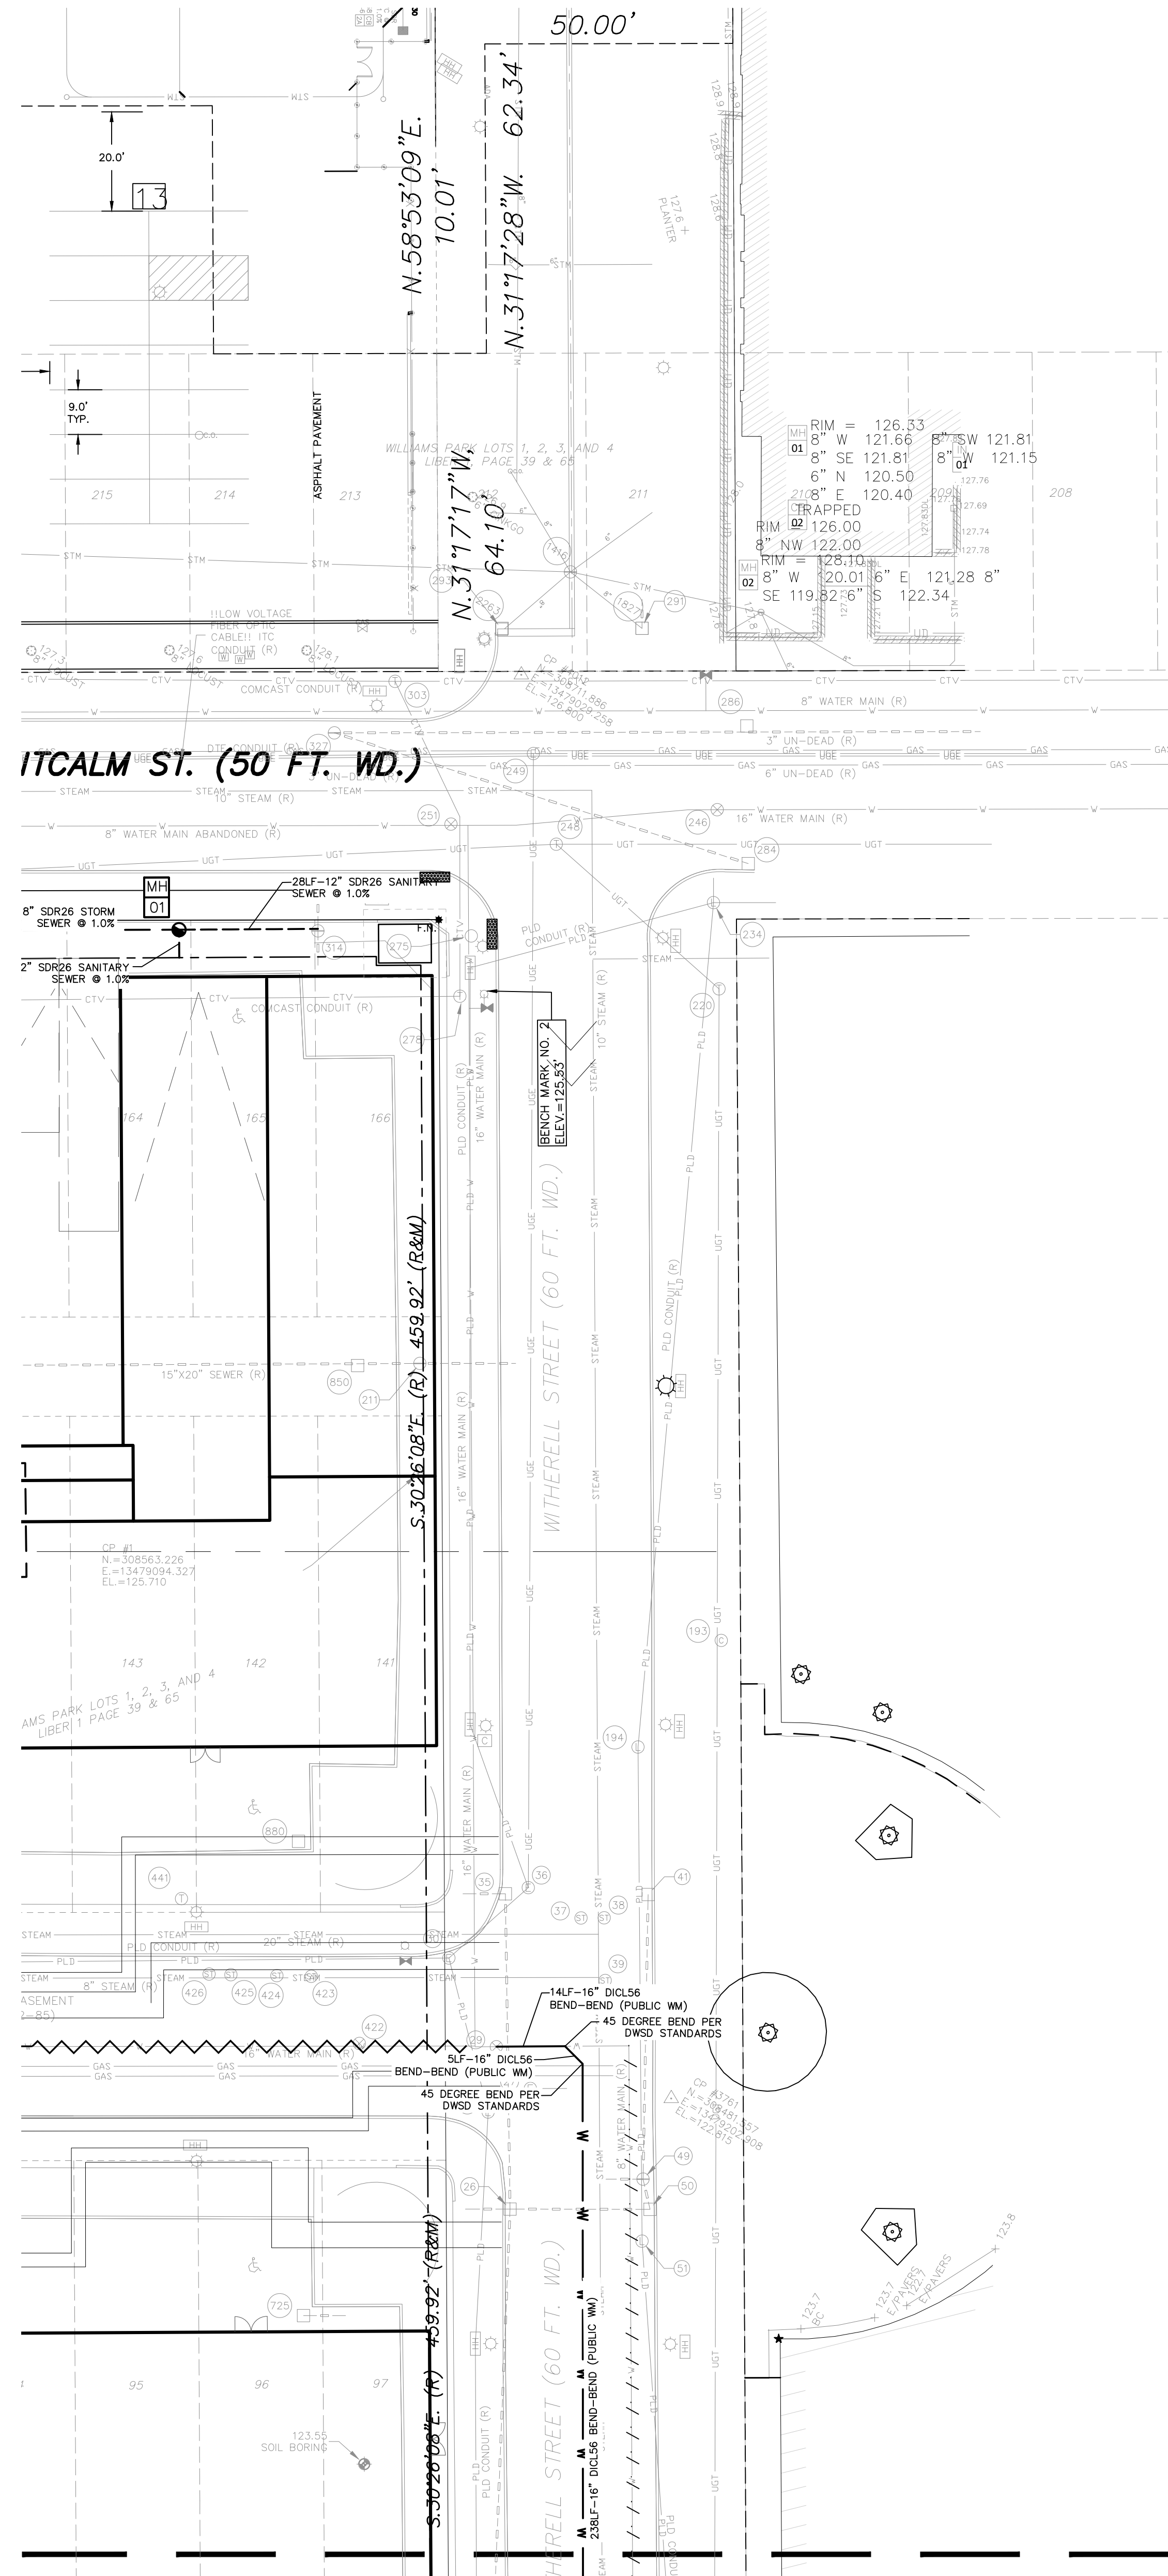


MATCHLINE - SEE SHEET C701

**UTILITY PLAN - LEGEND**

- PROPOSED STORM SEWER ————
- PROPOSED SANITARY SEWER ————
- PROPOSED WATER SERVICE — W — W
- PROPOSED GAS SERVICE BY OTHERS — G —
- PROPOSED ELECTRIC SERVICE — E —
- PROPOSED STOP BOX AND VALVE ●
- PROPOSED GATE VALVE ■
- PROPOSED CATCH BASIN ■
- PROPOSED YARD INLET ■
- PROPOSED DRAIN INLET ■
- PROPOSED STORM MANHOLE ○
- PROPOSED SANITARY MANHOLE ○
- PROPOSED FIRE DEPARTMENT CONNECTION ●
- PROPOSED STORM CLEANOUT ●

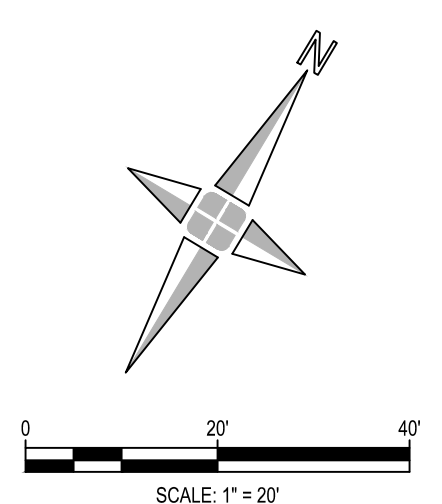

SCALE 1" = 20'

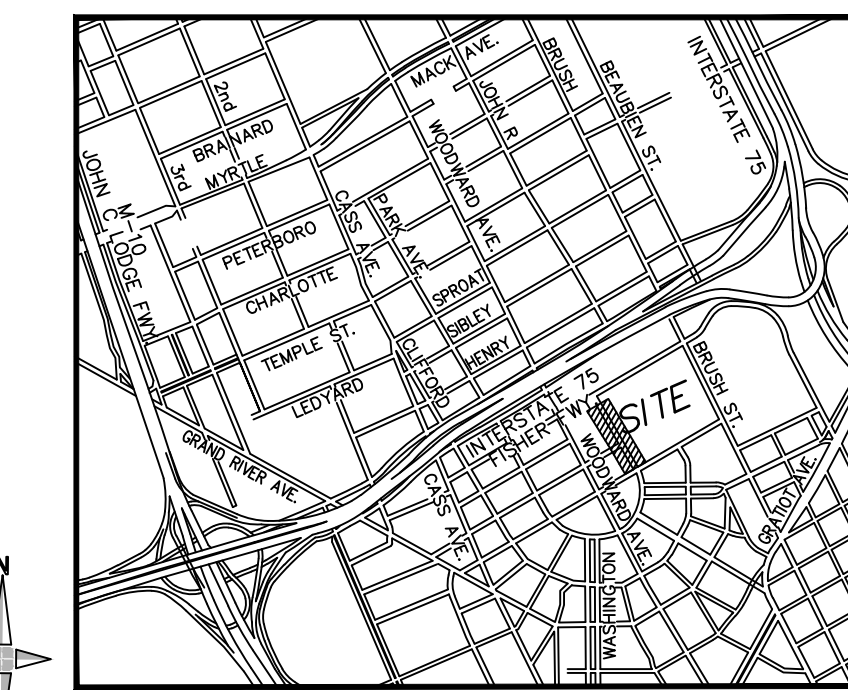


LOCATION MAP  
( NOT TO SCALE )

**UTILITY NOTE**

THE OMISSION OF ANY CURRENT STANDARD DETAIL  
DOES NOT RELIEVE THE CONTRACTOR FROM THIS  
REQUIREMENT. THE WORK SHALL BE PERFORMED IN  
COMPLETE CONFORMANCE WITH THE CURRENT  
DWSO STANDARD SPECIFICATIONS AND DETAILS.

MATCHLINE - SEE SHEET C700

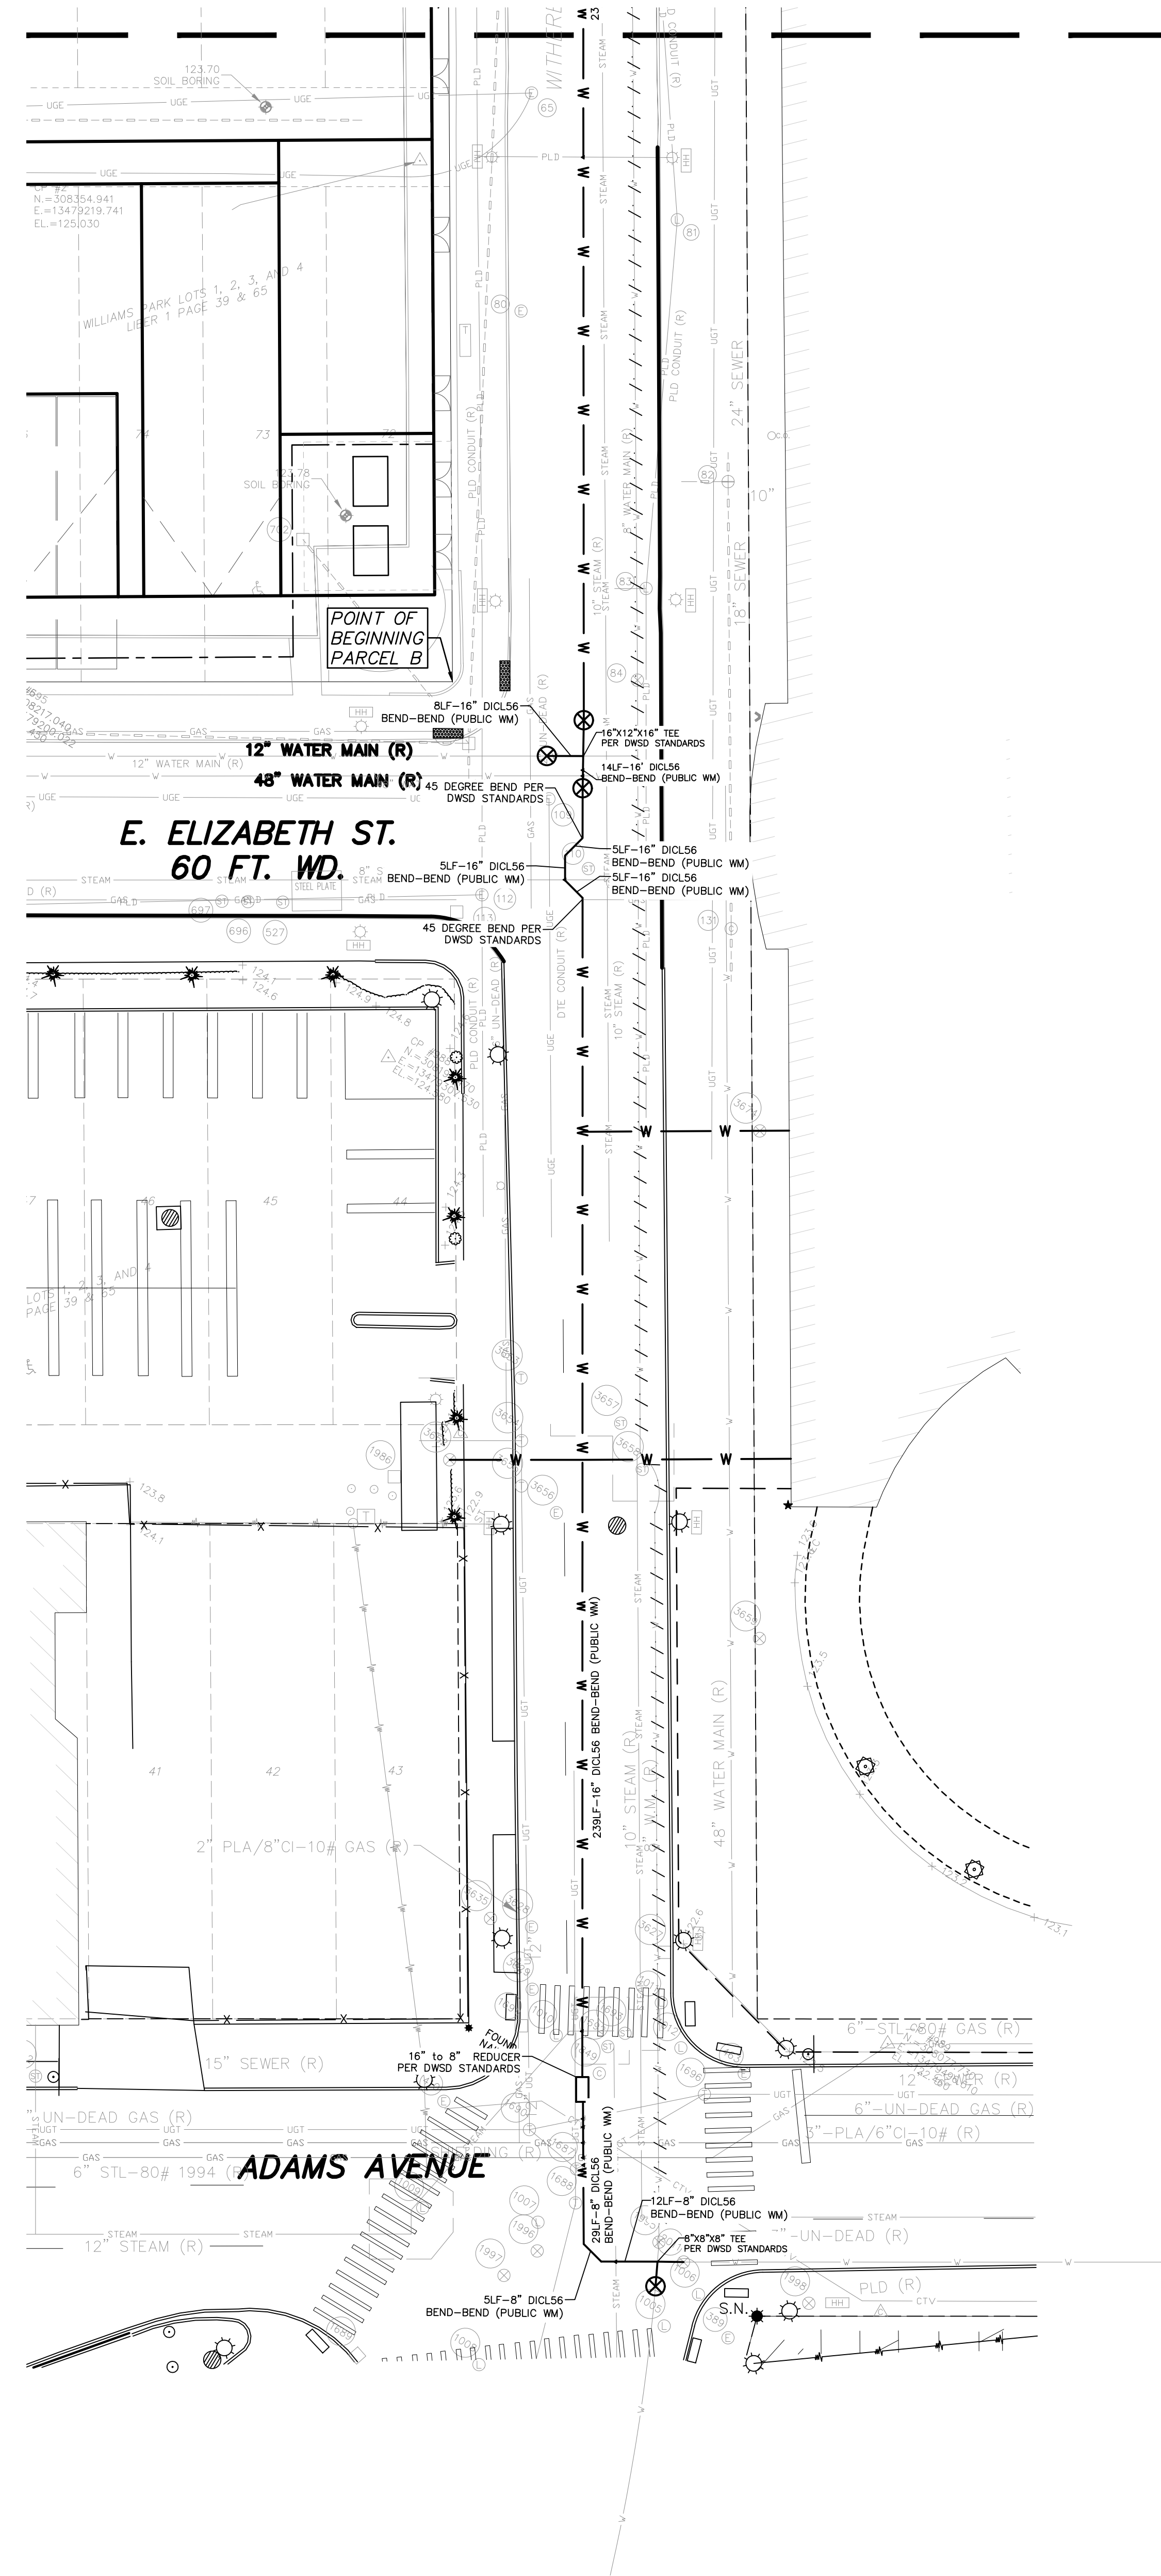


**UTILITY PLAN - LEGEND**

- PROPOSED STORM SEWER
- PROPOSED SANITARY SEWER
- PROPOSED WATER SEWER
- PROPOSED GAS SERVICE BY OTHERS
- PROPOSED ELECTRIC SERVICE
- PROPOSED STOP BOX AND VALVE
- PROPOSED GATE VALVE
- PROPOSED CATCH BASIN
- PROPOSED YARD INLET
- PROPOSED DRAIN INLET
- PROPOSED STORM MANHOLE
- PROPOSED SANITARY MANHOLE
- PROPOSED FIRE DEPARTMENT CONNECTION
- PROPOSED STORM CLEANOUT

Revision

| No. | Description                | Date     |
|-----|----------------------------|----------|
| 01  | DWSO - Coordination Review | 3/8/2023 |

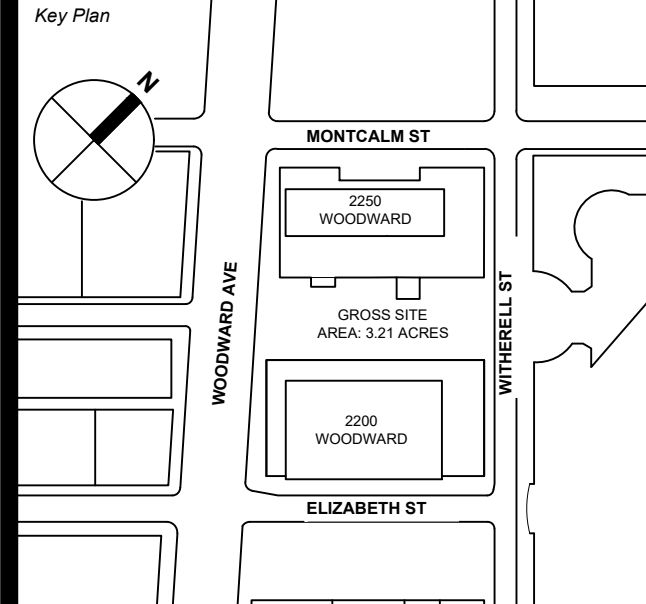

Seal & Signature

| Issue Date | Project No. | Project No. |
|------------|-------------|-------------|
| 3/1/2023   | 10279-114   | 10279-114   |

Scale: 1" = 20'

Drawing Title

**C-701  
UTILITY PLAN**

