

E

D

C

B

A

SECURITY GENERAL NOTES


1. PARKING LOT RFID READERS, COORDINATE LOCATION OF READER WITH LANDSCAPE / CIVIL TRADES. SEE SHEETS T-705 & T-706 FOR DETAILS.

GENERAL NOTES

1. REFER TO T-001 FOR ABBREVIATIONS, SYMBOLS, AND GENERAL NOTES.
2. WIRELESS RFID READER SHALL TIE INTO ACCESS CONTROL SYSTEM IN BUILDING C, COORDINATE LOCATION OF READER WITH LANDSCAPE, CIVIL AND ELECTRICAL TRADES.
3. ALL CONDUIT IS 4" U.O.N.
4. COMCAST SERVICE TIE-IN TO BE CONFIRMED BY COMCAST PRIOR TO UG CONDUIT INSTALLATION. SERVICE TIE-IN CURRENTLY PLANNED FROM NORTH SIDE OF HENRY ST VIA EXISTING CONDUIT FROM HENRY ST TO SOUTHWEST CORNER OF BLDG D. CURRENTLY ON A WOODEN POLE, WILL BE TRANSITIONED TO UNDERGROUND.

KEYED NOTES


1. PROVIDE AND INSTALL SAFETY BLUE PHONE.

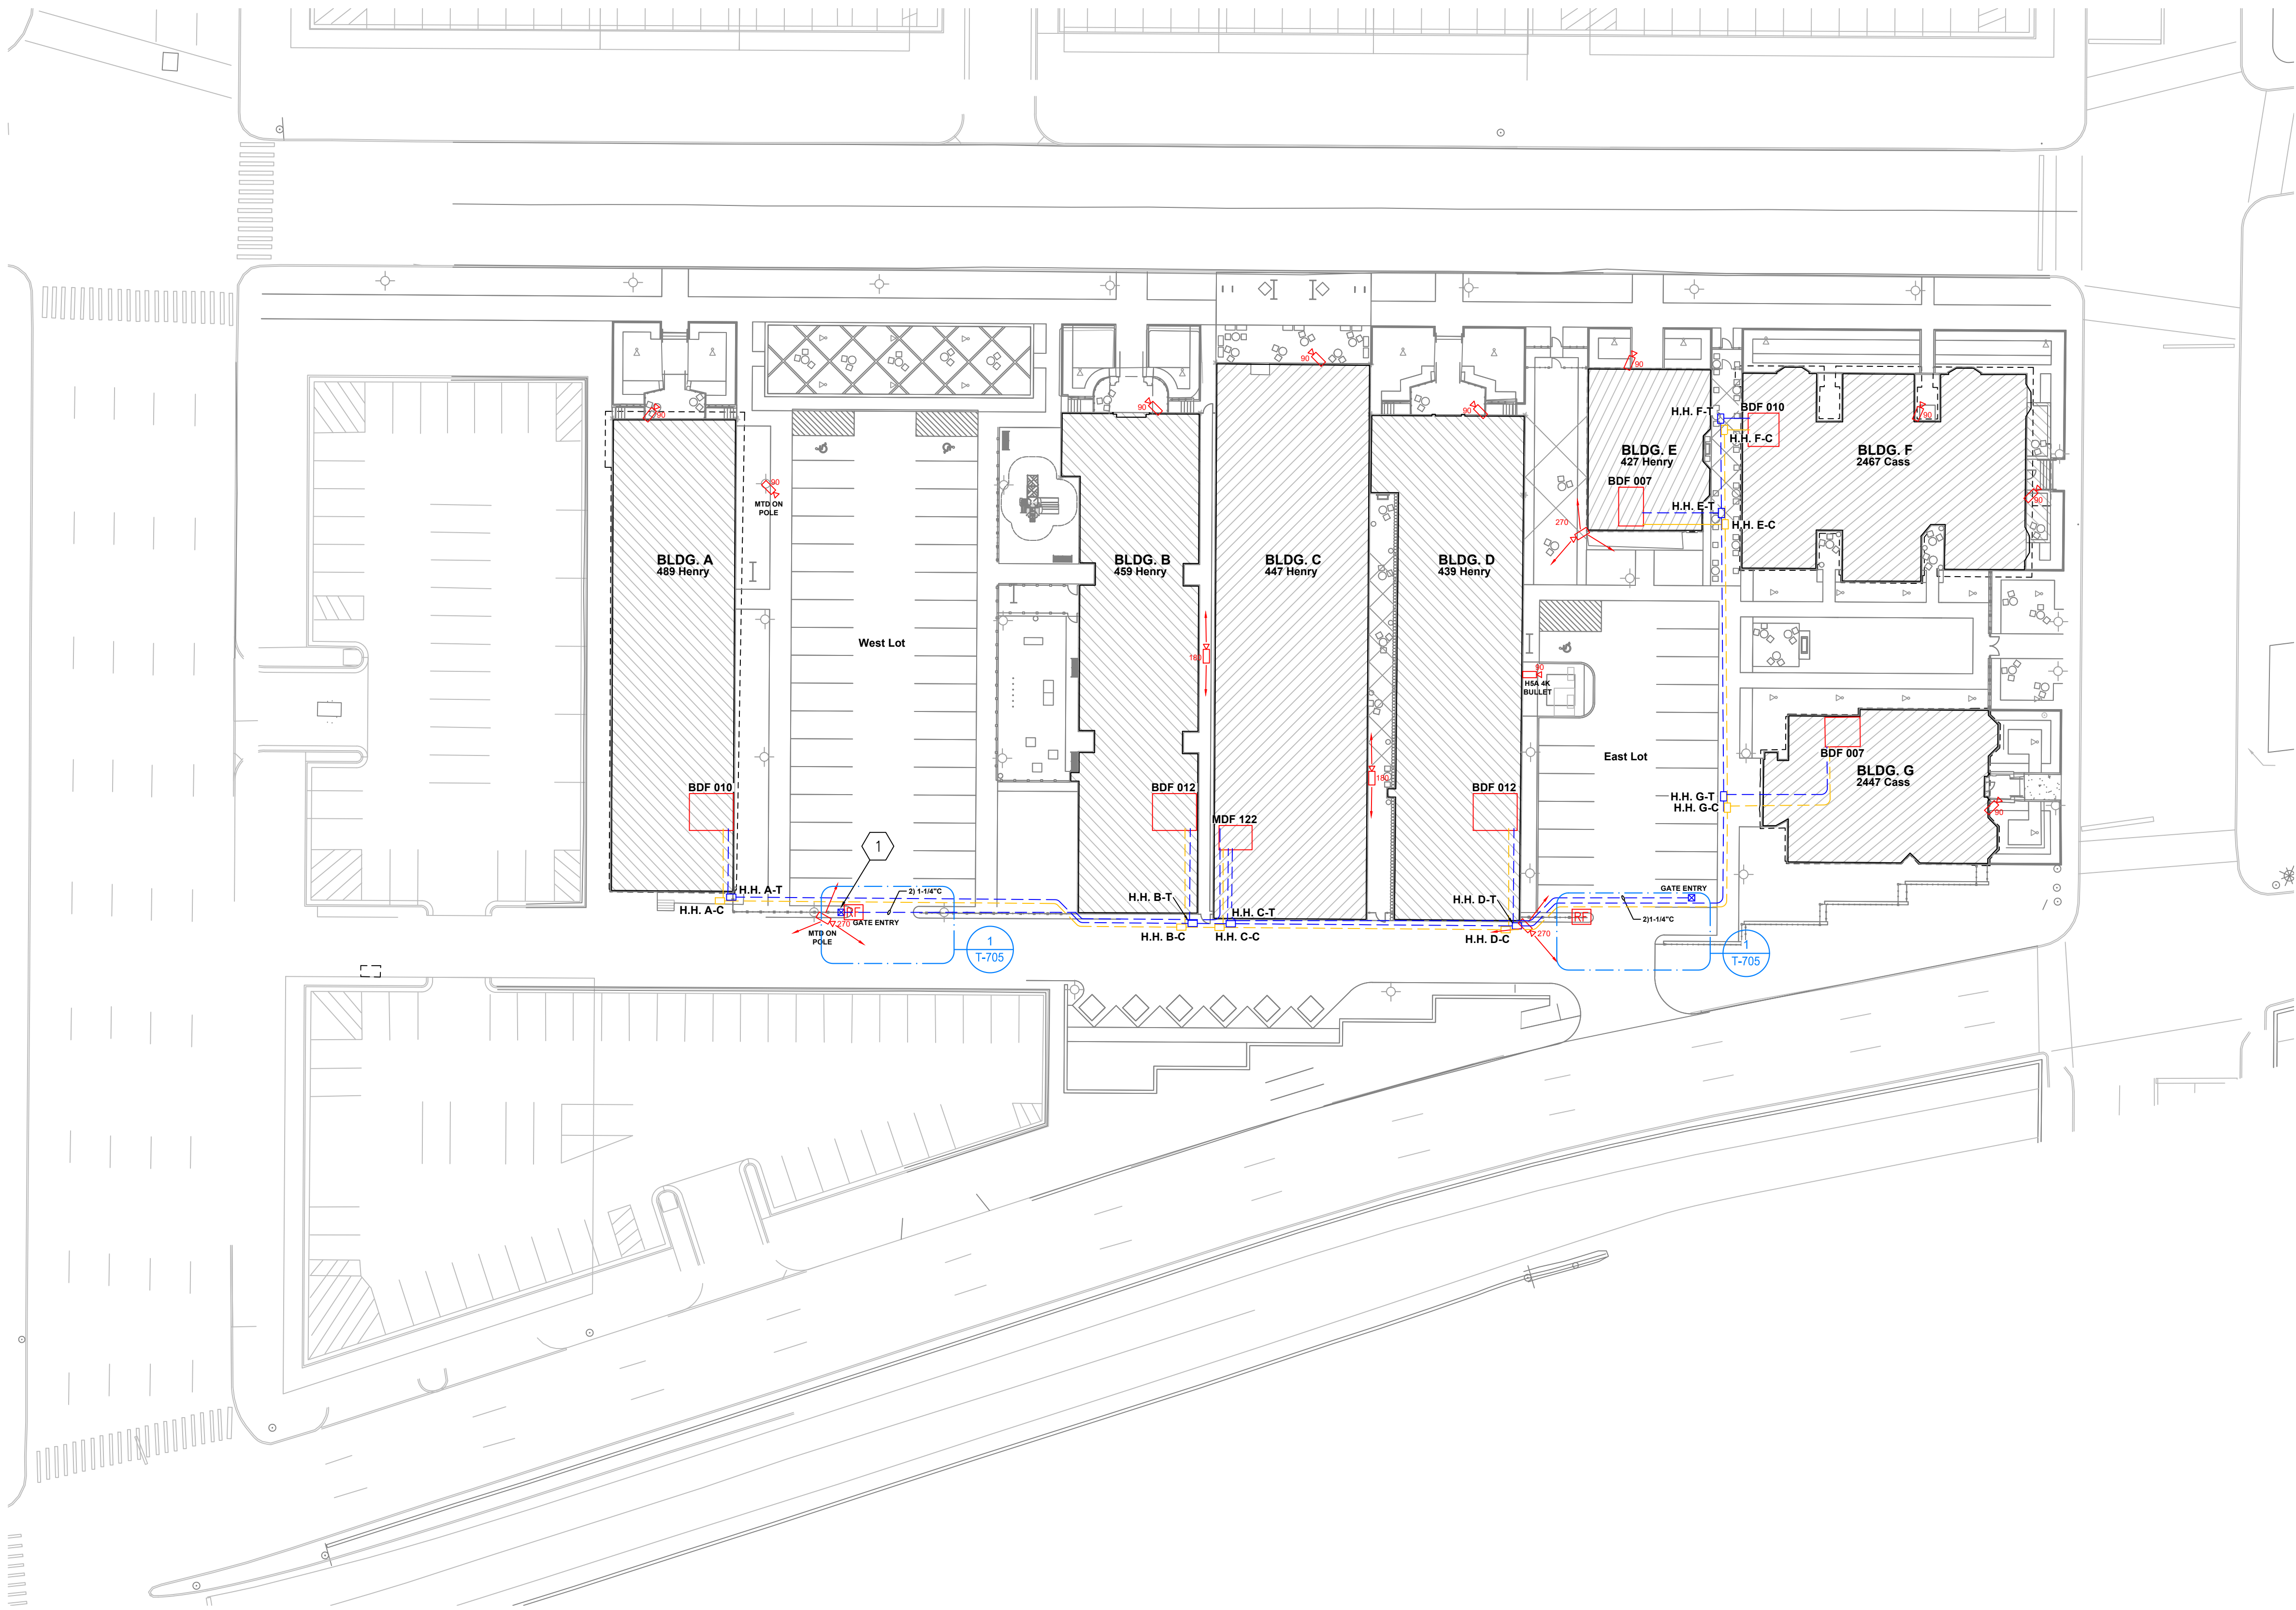

SITE PLAN
1" = 30'


LEGEND

- COMCAST HAND HOLE 24"L X 36"W X 24"D
- OWNER/TELECOM HAND HOLE 24"L X 36"W X 24"D
- MDF/BDF LOCATION (APPROXIMATE)
- COMCAST UNDERGROUND CONDUIT ROUTE
- OWNER/TELECOM UNDERGROUND CONDUIT ROUTE

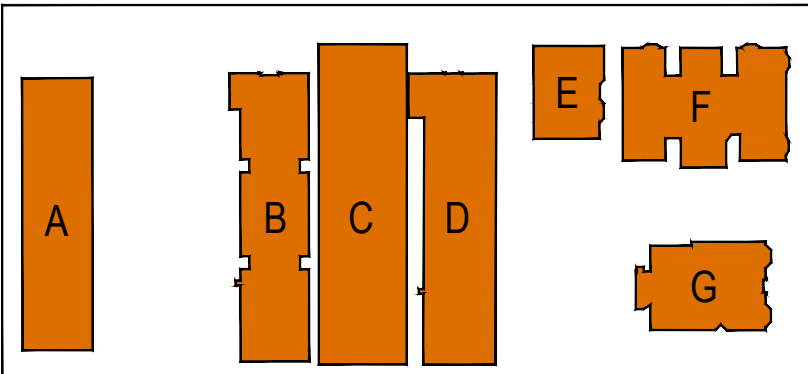

KEY PLAN

 THE FOLLOWING DIMENSION EQUALS ONE INCH WHEN PRINTED TO SCALE.



2211 WOODWARD AVE
DETROIT, MI 48201
313.471.6600

Owner

NEUMANN/SMITH
ARCHITECTURE
400 GALLERIA OFFICENTRE, SUITE 555
SOUTHFIELD, MICHIGAN 48034
248.352.8310

Architect

O'BRIEN CONSTRUCTION
COMPANY
966 LIVERNOIS
TROY, MI 48063
248.334.2470

Pre-Construction Services

GIFFELS WEBSTER
28 W. ADAMS STREET, SUITE 1200
DETROIT, MICHIGAN 48226
313.962.4442

Civil Engineer

GRISSIM METZ ANDRIESE
ASSOCIATES
311 EAST CADY STREET SUITES A&B
NORTHVILLE, MICHIGAN 48167
248.347.7010

Landscape Architect

RESURGET ENGINEERING
4219 WOODWARD AVENUE, SUITE 306
DETROIT, MICHIGAN, 48201
313.315.3290

Structural Engineer

STRATEGIC ENERGY
SOLUTIONS, INC.
4000 WEST 11 MILE RD.
BERKLEY, MICHIGAN 48072
248.399.1900

Mech/Elect Engineer



Motor City Electric
Technologies

9440 GRINNELL DETROIT, MI 48213
PH: (313) 921-5300 FAX: (313) 921-5310

Consultant

HENRY STREET
REDEVELOPMENT
489 HENRY, 459 HENRY, 447 HENRY,
439 HENRY, 427 HENRY,
2467 CASS, 2447 CASS
DETROIT, MI. 48201

Project

ADDENDUM #2 rev 1	12/20/23
ADDENDUM #2	12/08/23
ADDENDUM #1	06/01/23
FINAL IFC	12/21/22
100%DD UPDATED	10/20/22
100%DD	09/29/22
90%DD	09/21/22
60%DD	08/05/22

Issue For	Date
Drawn By	EH
Checked By	TE
Approved By	JB
Date	05/17/2022

Sheet Title
AUXILIARY SYSTEMS
SITE PLAN

Project Number 922100

Sheet Number

T-100