


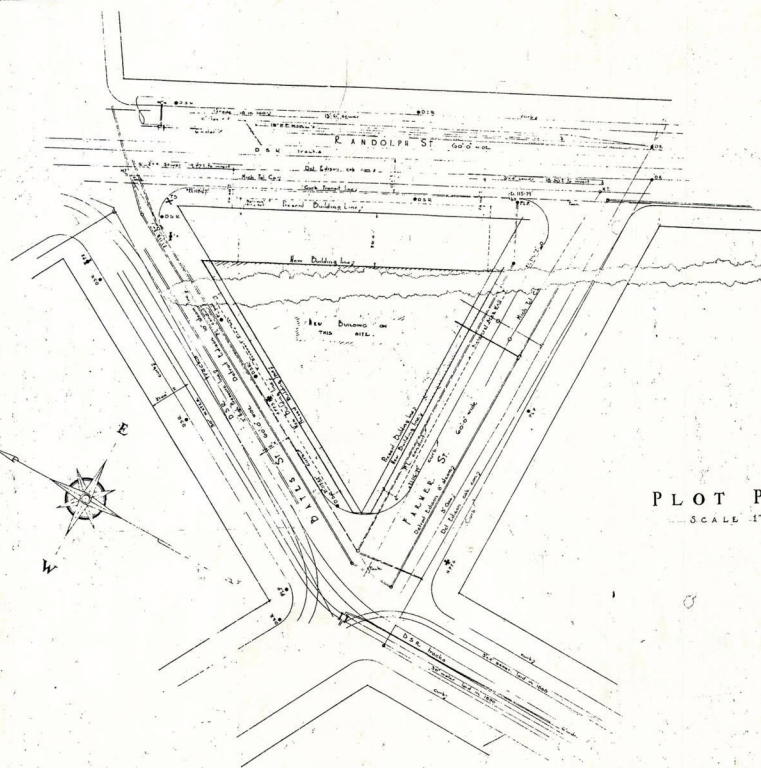


PLOT PLAN
SCALE 1" = 20'

WATER BOARD BUILDING


DETROIT


MICHIGAN

LOUIS KAMPER, INC.
ARCHITECTS
3729 CASS AVE. DETROIT MICH.

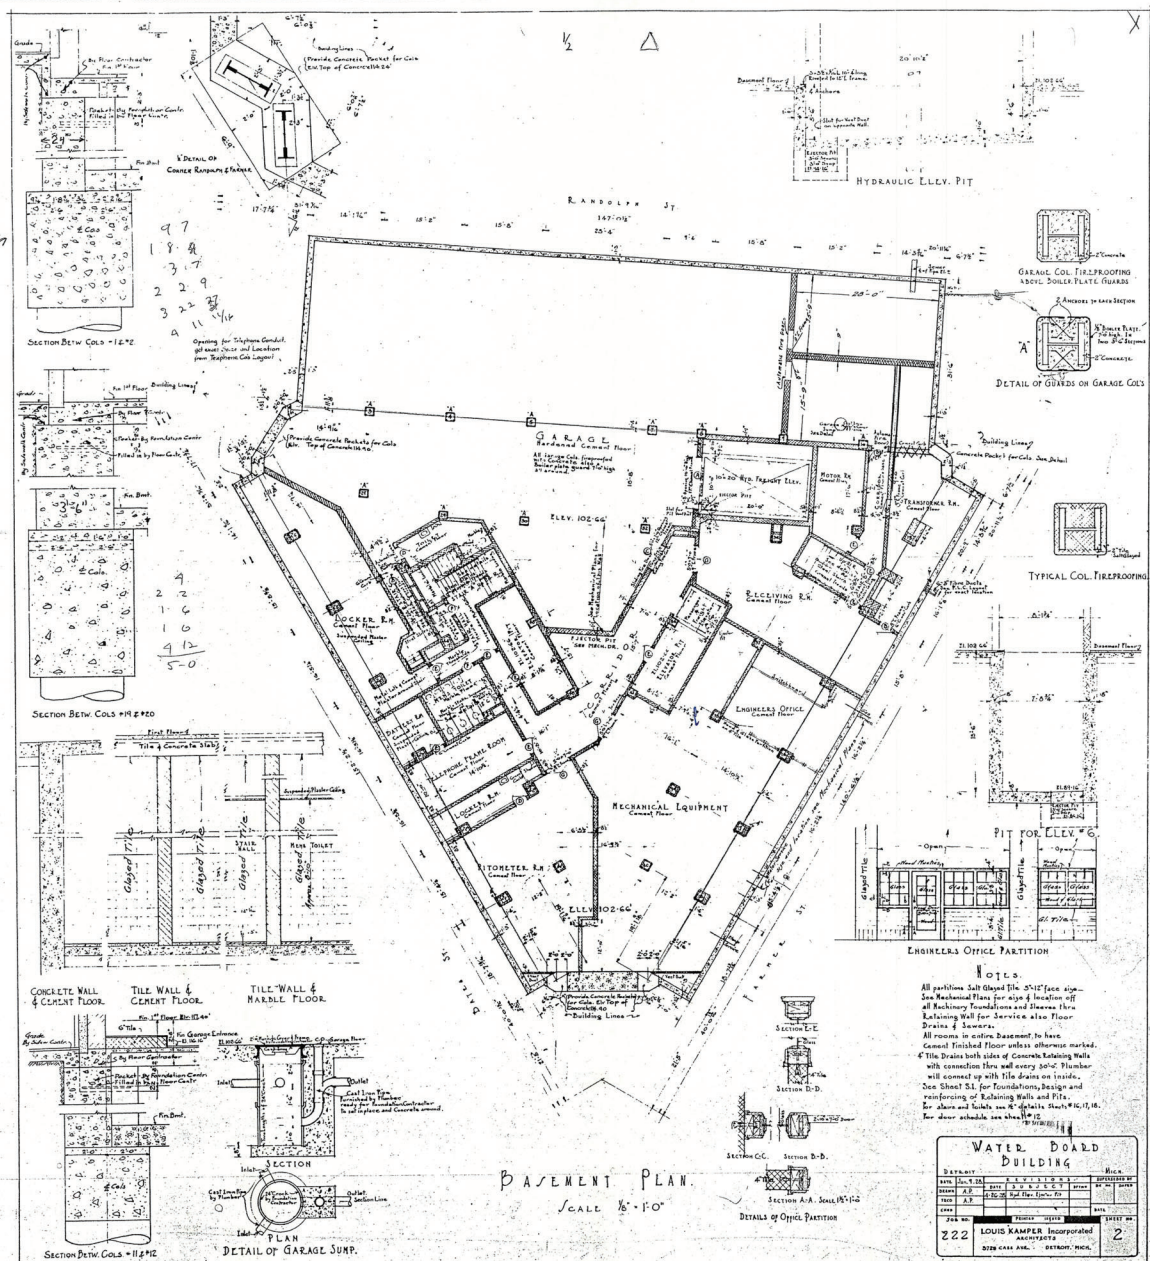

HALF INCH SECTION AT RANDOLPH ST. ENTRY

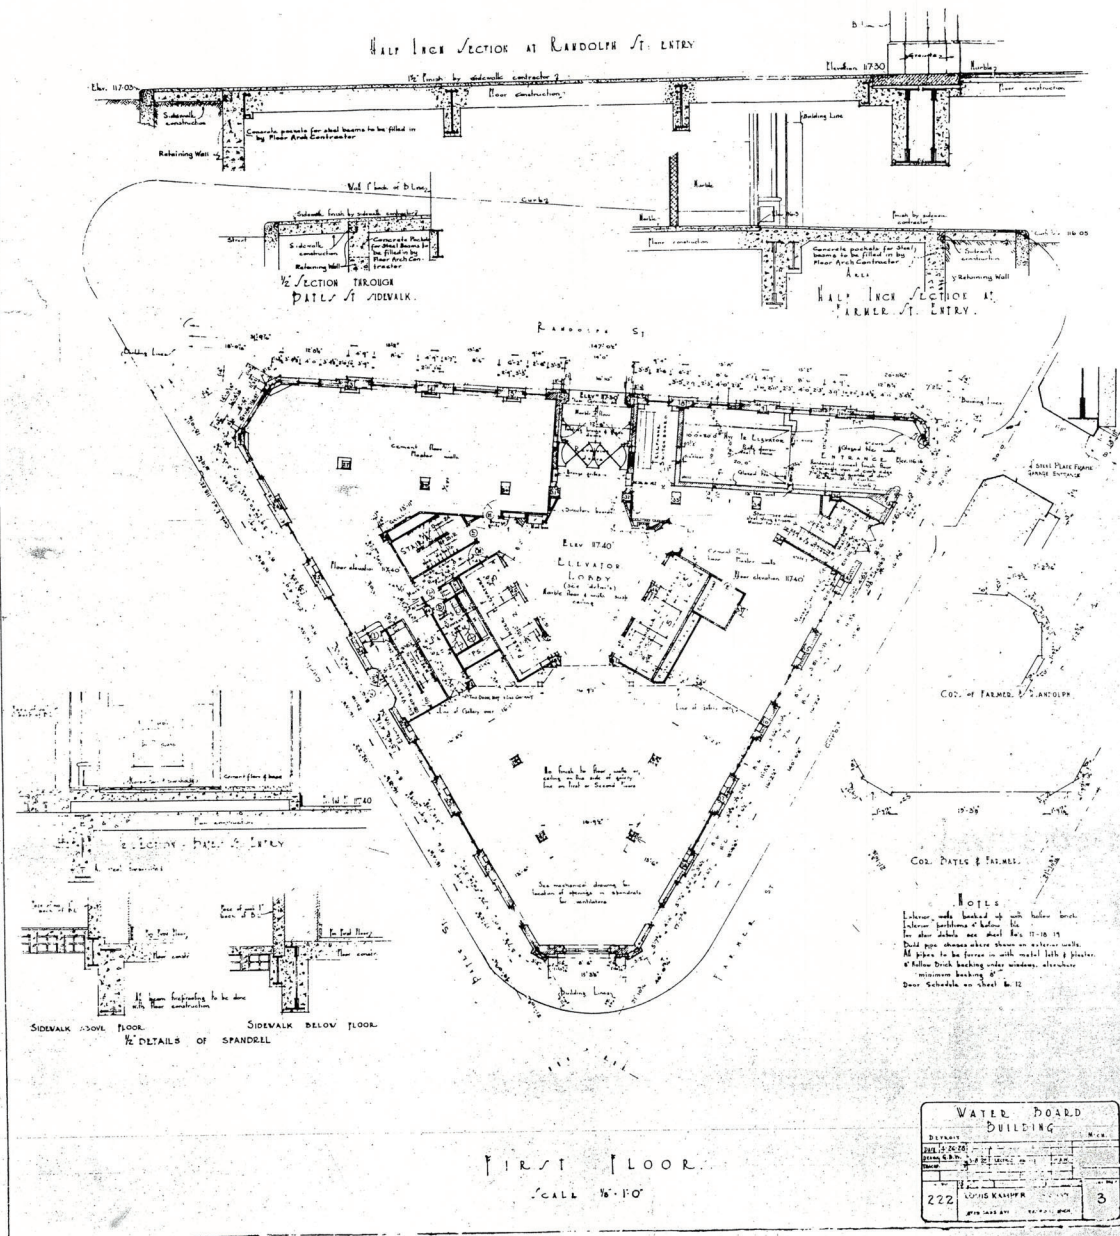

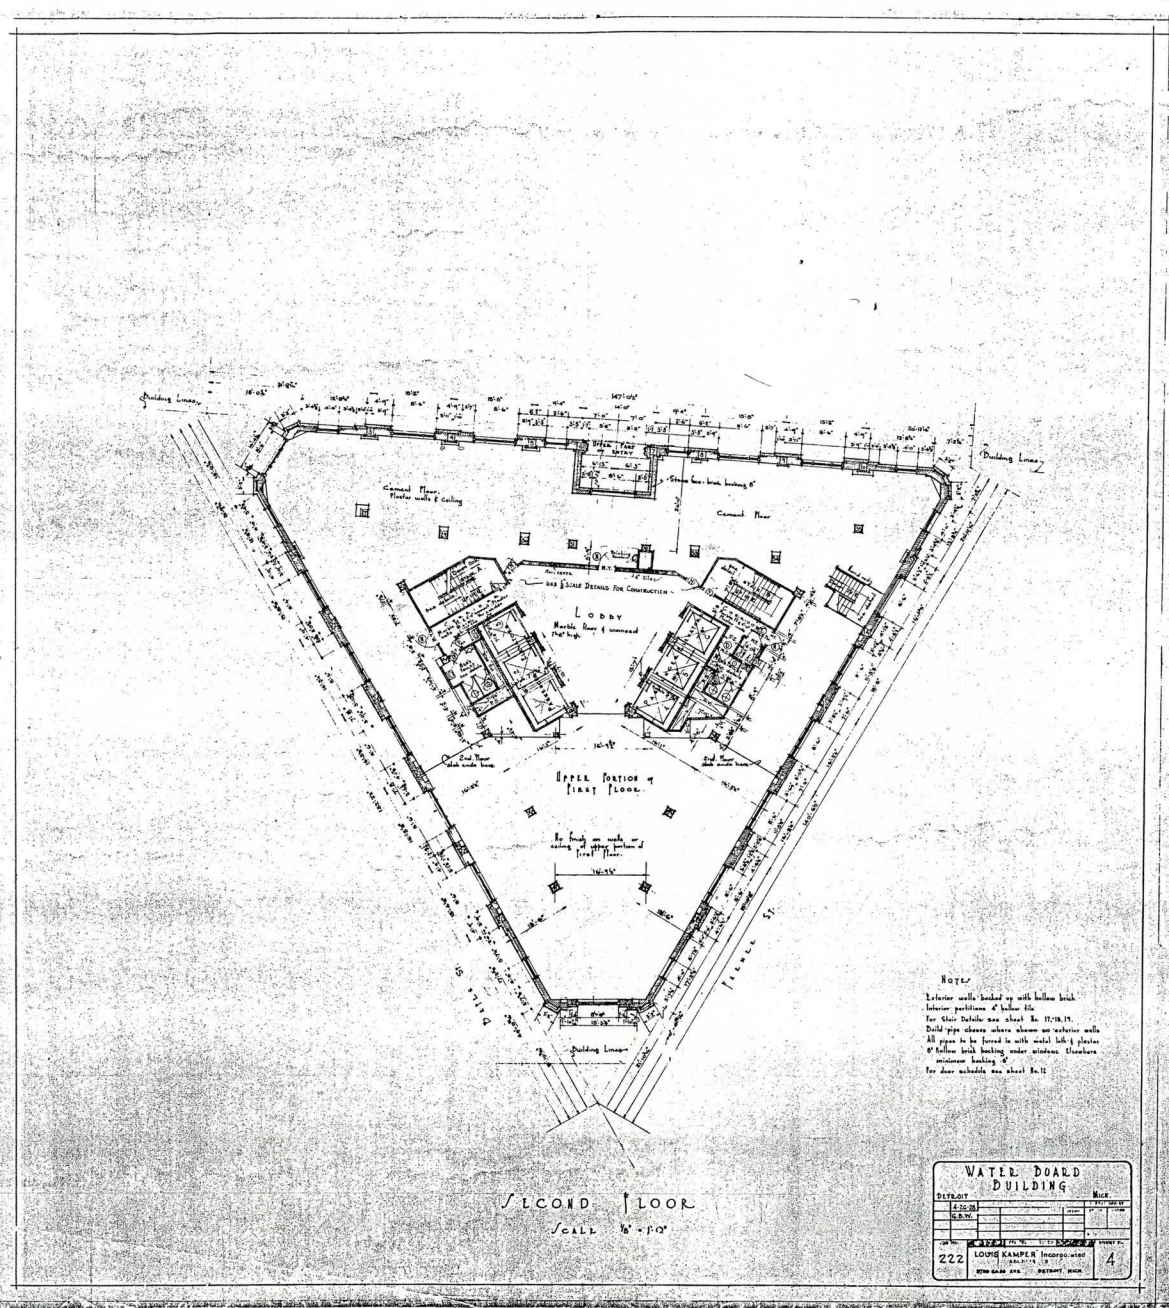

NOTE:
 Exterior walls finished up with hollow brick
 Interior partitions of hollow tile
 For steel trusses see sheet No. 11-12-13
 Duct pipes shown where shown on exterior walls
 All pipes to be lined in with metal lath & plaster
 8" hollow brick backing under windows. Elsewhere
 minimum backing 4"
 For door schedule see sheet No. 12

WATER BOARD BUILDING			
DATE	BY	FOR	NO.
1918	W. B. K.	W. B. K.	4
222	LOUIS KAMPER Incorporated	222	4
NEW YORK, N.Y.	1918	NEW YORK, N.Y.	1918