



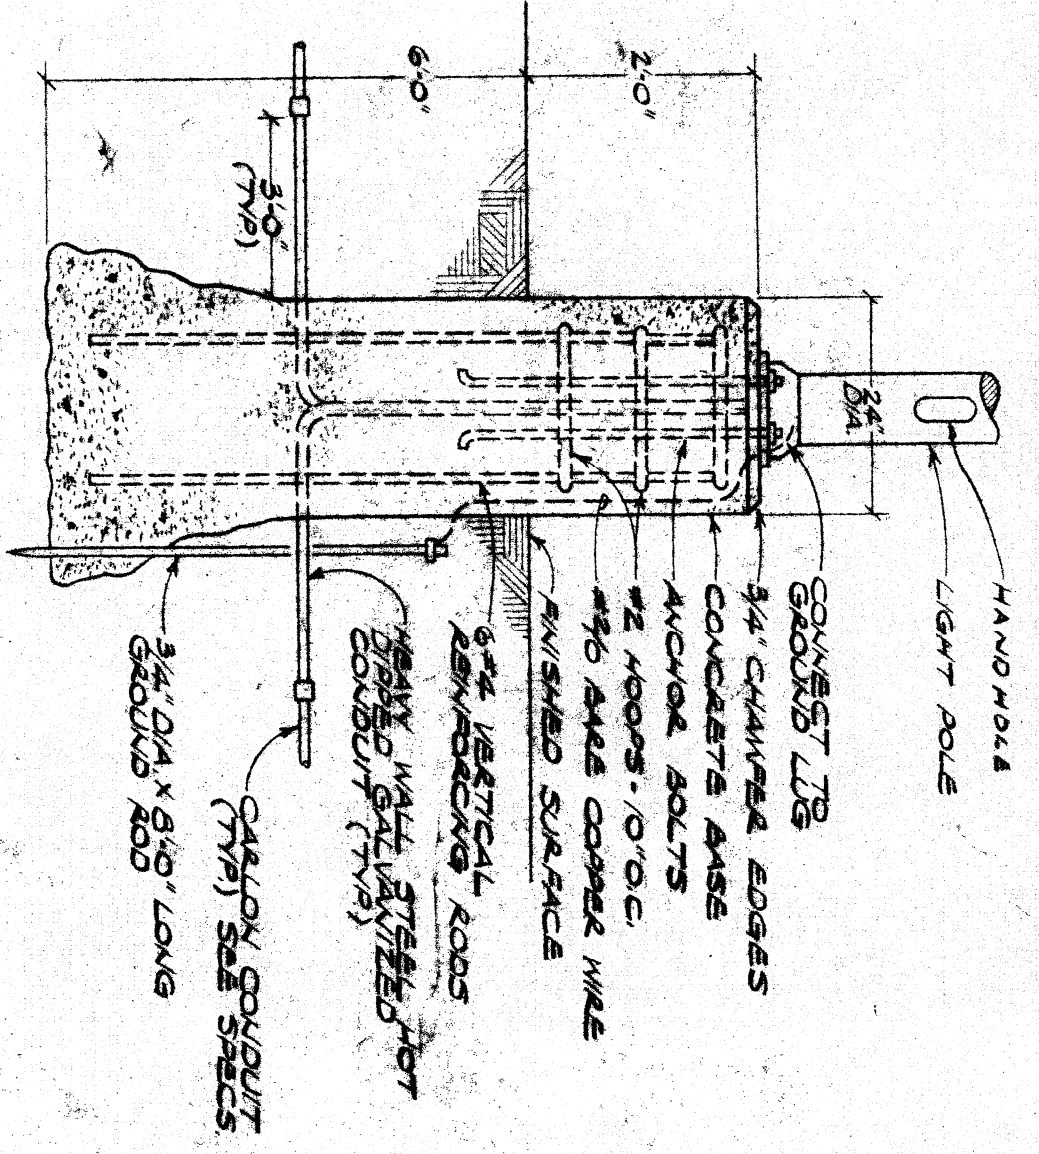

MOUNTING BASE FOR
TYPE OA LIGHTING FIXTURE

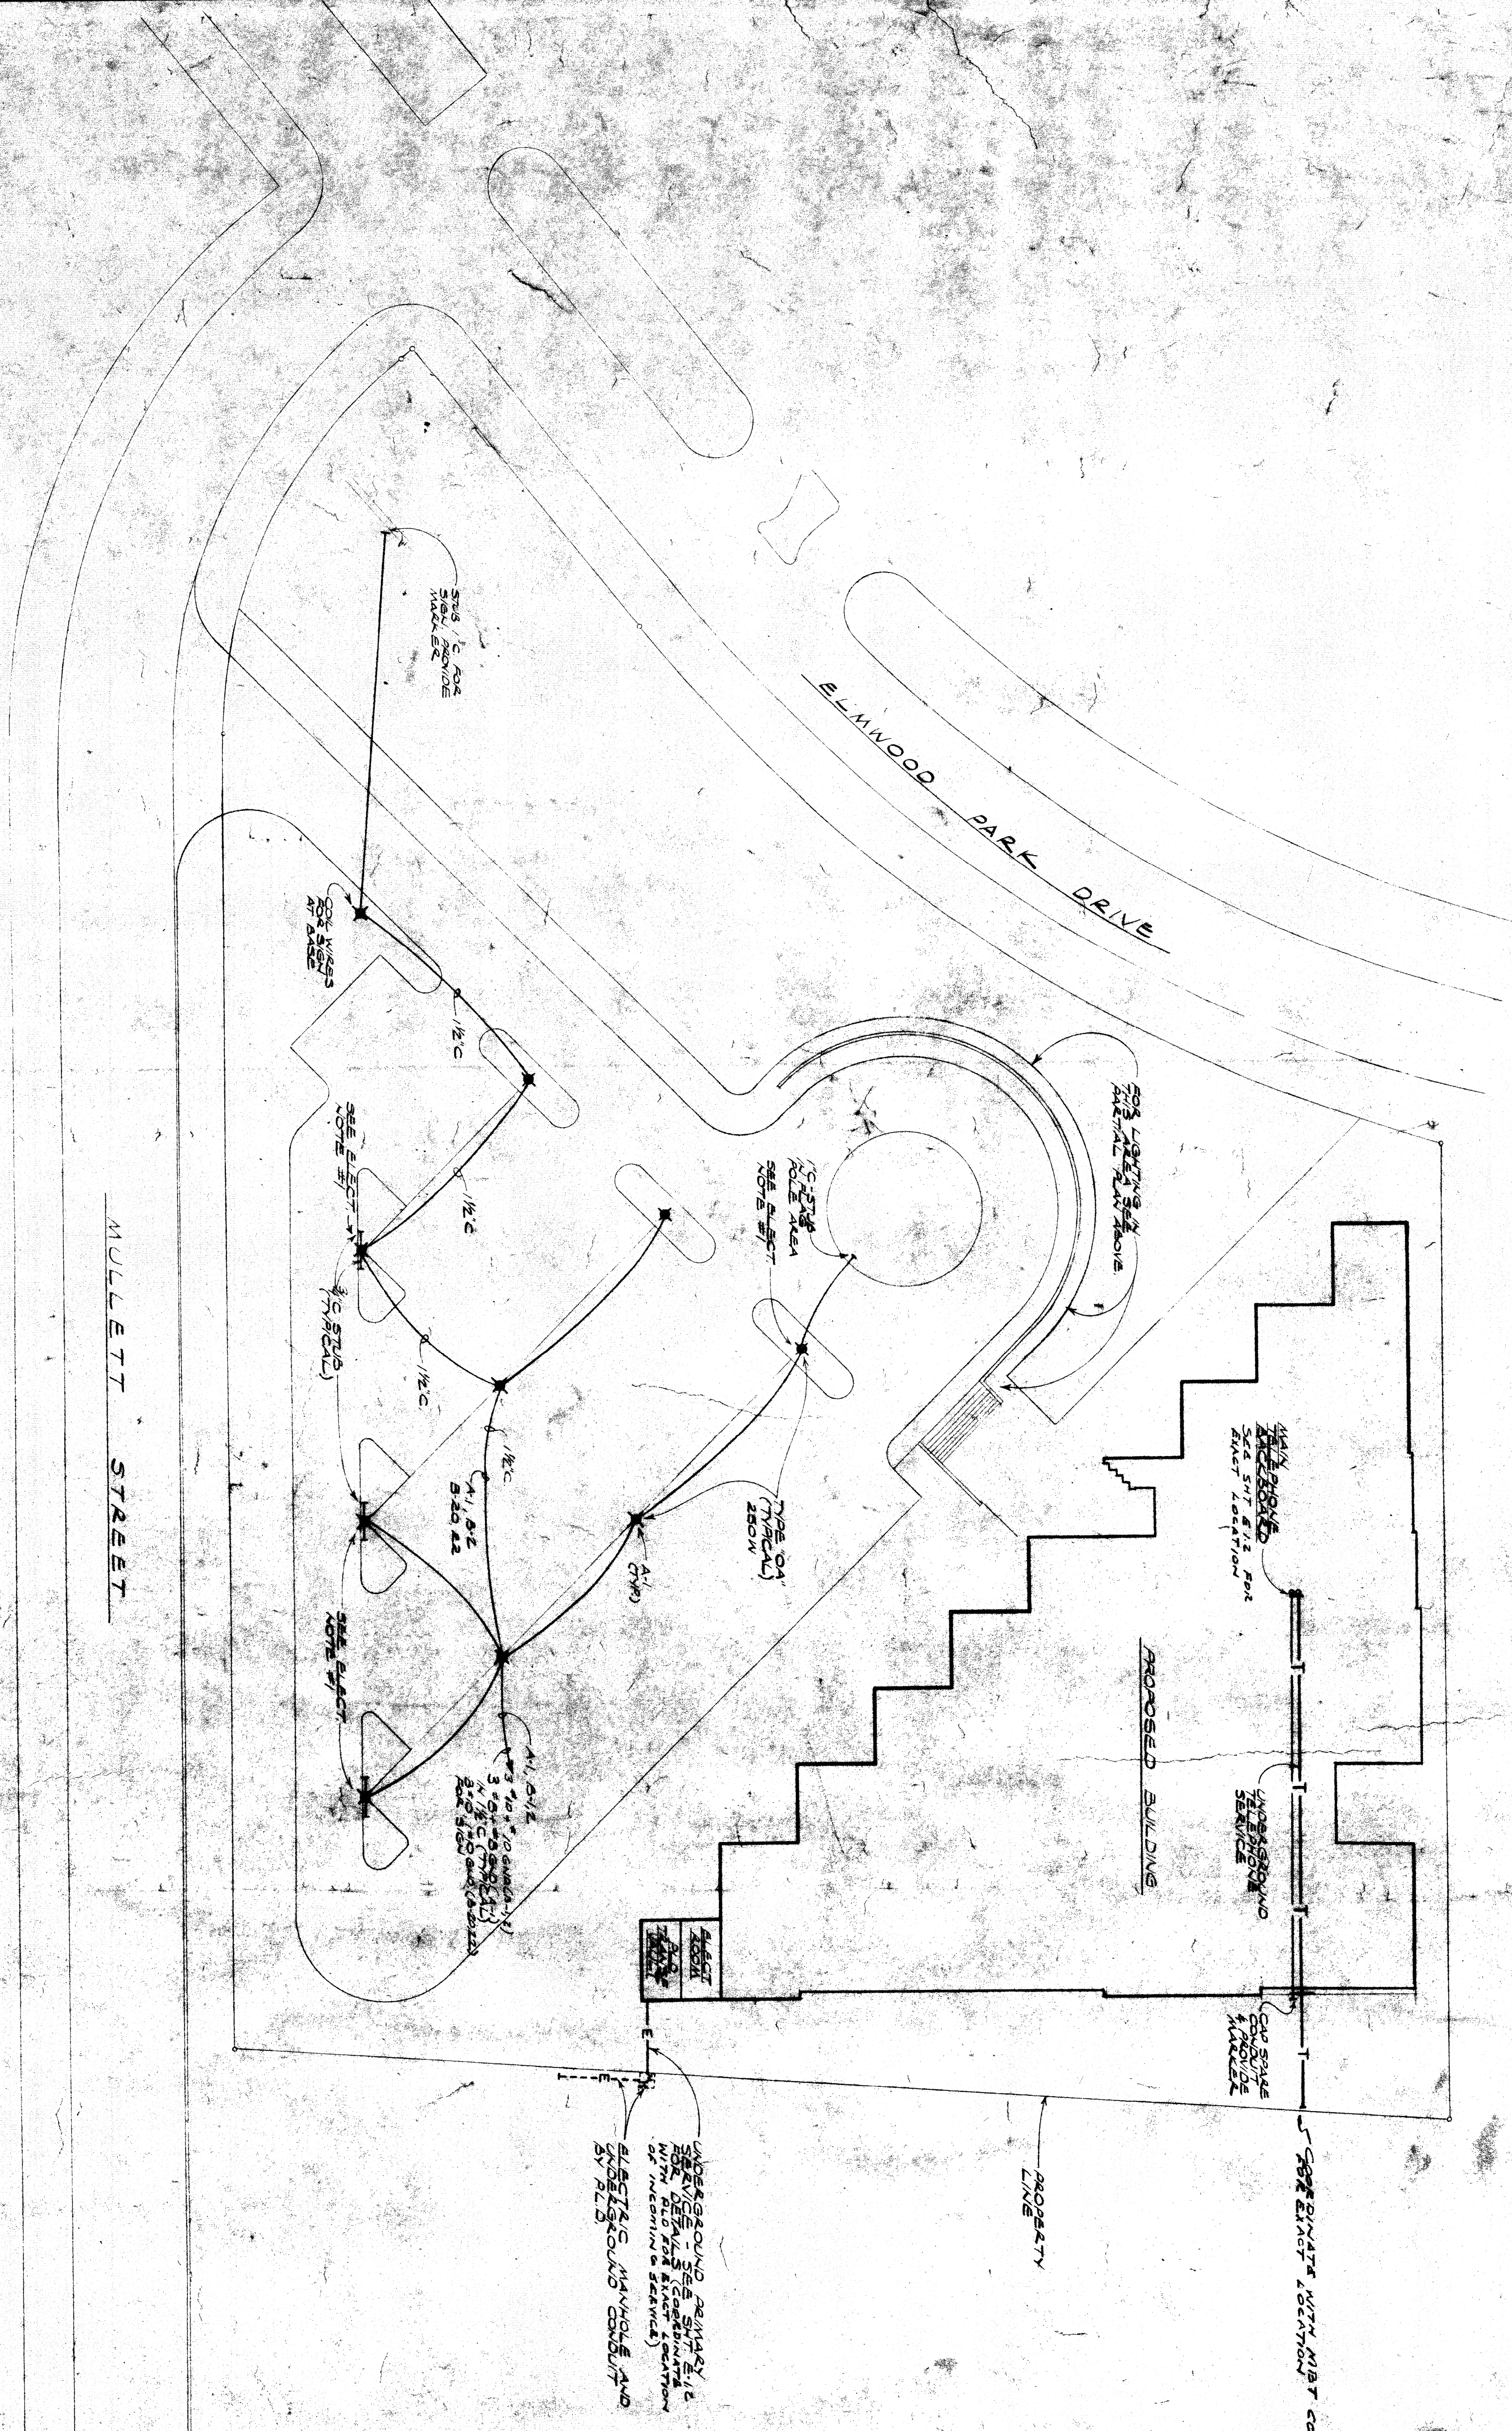

ELECTRICAL SITE PLAN

SCALE: 1" = 30'-0"

[illegible][illegible]