


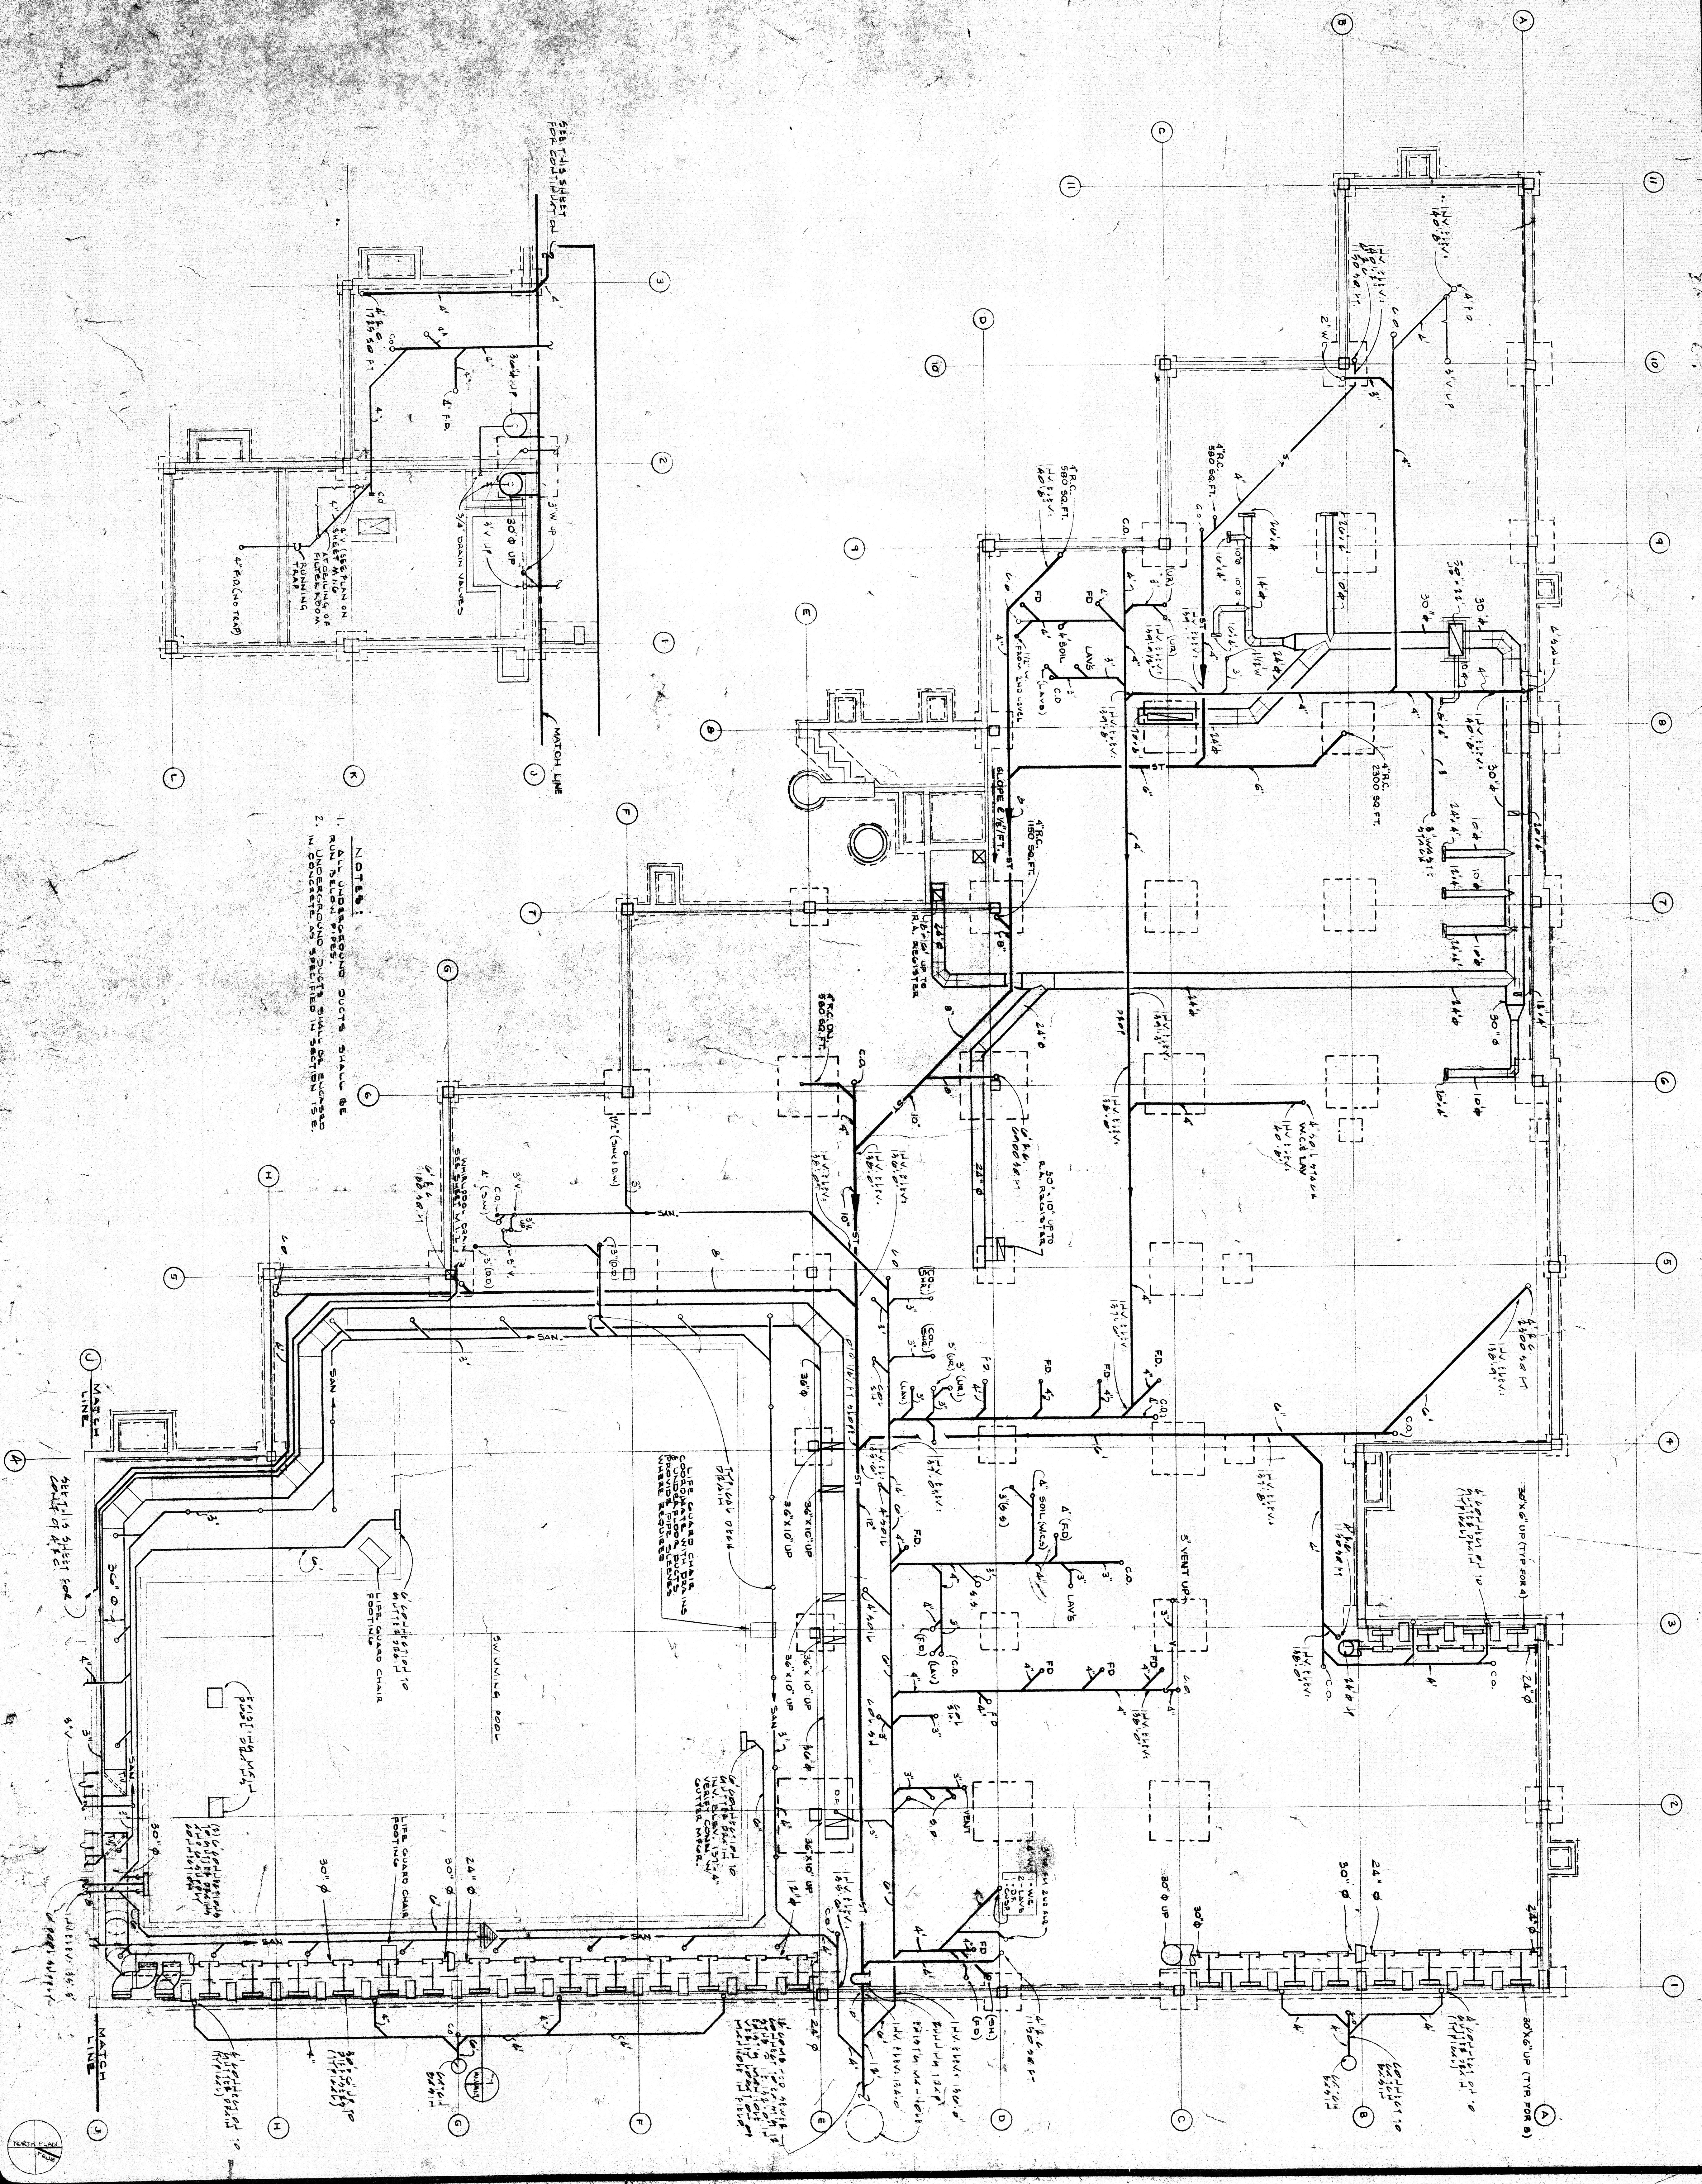

NOTES:
 1. ALL UNDERGROUND DUCTS SHALL BE
 2. UNDESGROUNDED DUCTS SHALL BE
 3. CONCRETE AS SPECIFIED IN SECTION 15.0.

M1.1

FOUNDATION PLAN MECHANICAL
 1/8" = 1'-0"

ELMWOOD PARK
 COMMUNITY CENTER
 DETROIT COMMUNITY AND ECONOMIC
 DEVELOPMENT DEPARTMENT DETROIT, MICHIGAN

date 7-26-77	drawn J.V.	checked P.A.C.	revisions
preliminary			
construction			
final record			

WILLIAM KESSLER
 AND ASSOCIATES INC ARCHITECTS
 733 ST ANTOINE ST
 DETROIT
 MICHIGAN 48226
 313-9635906

HOYEM-BASSO
 ASSOCIATES
 INCORPORATED
 Consulting Engineers
 and Surveyors
 25
 West 42nd St
 Bloomfield Hills
 Michigan